





1  
1/8" = 1'-0"  
LIGHTING PLAN  
1ST FLOOR

FOR CONTINUATION SEE DWG. E10

2  
LIGHTING CONTROL SCHEMATIC DIAGRAMS  
NO SCALE

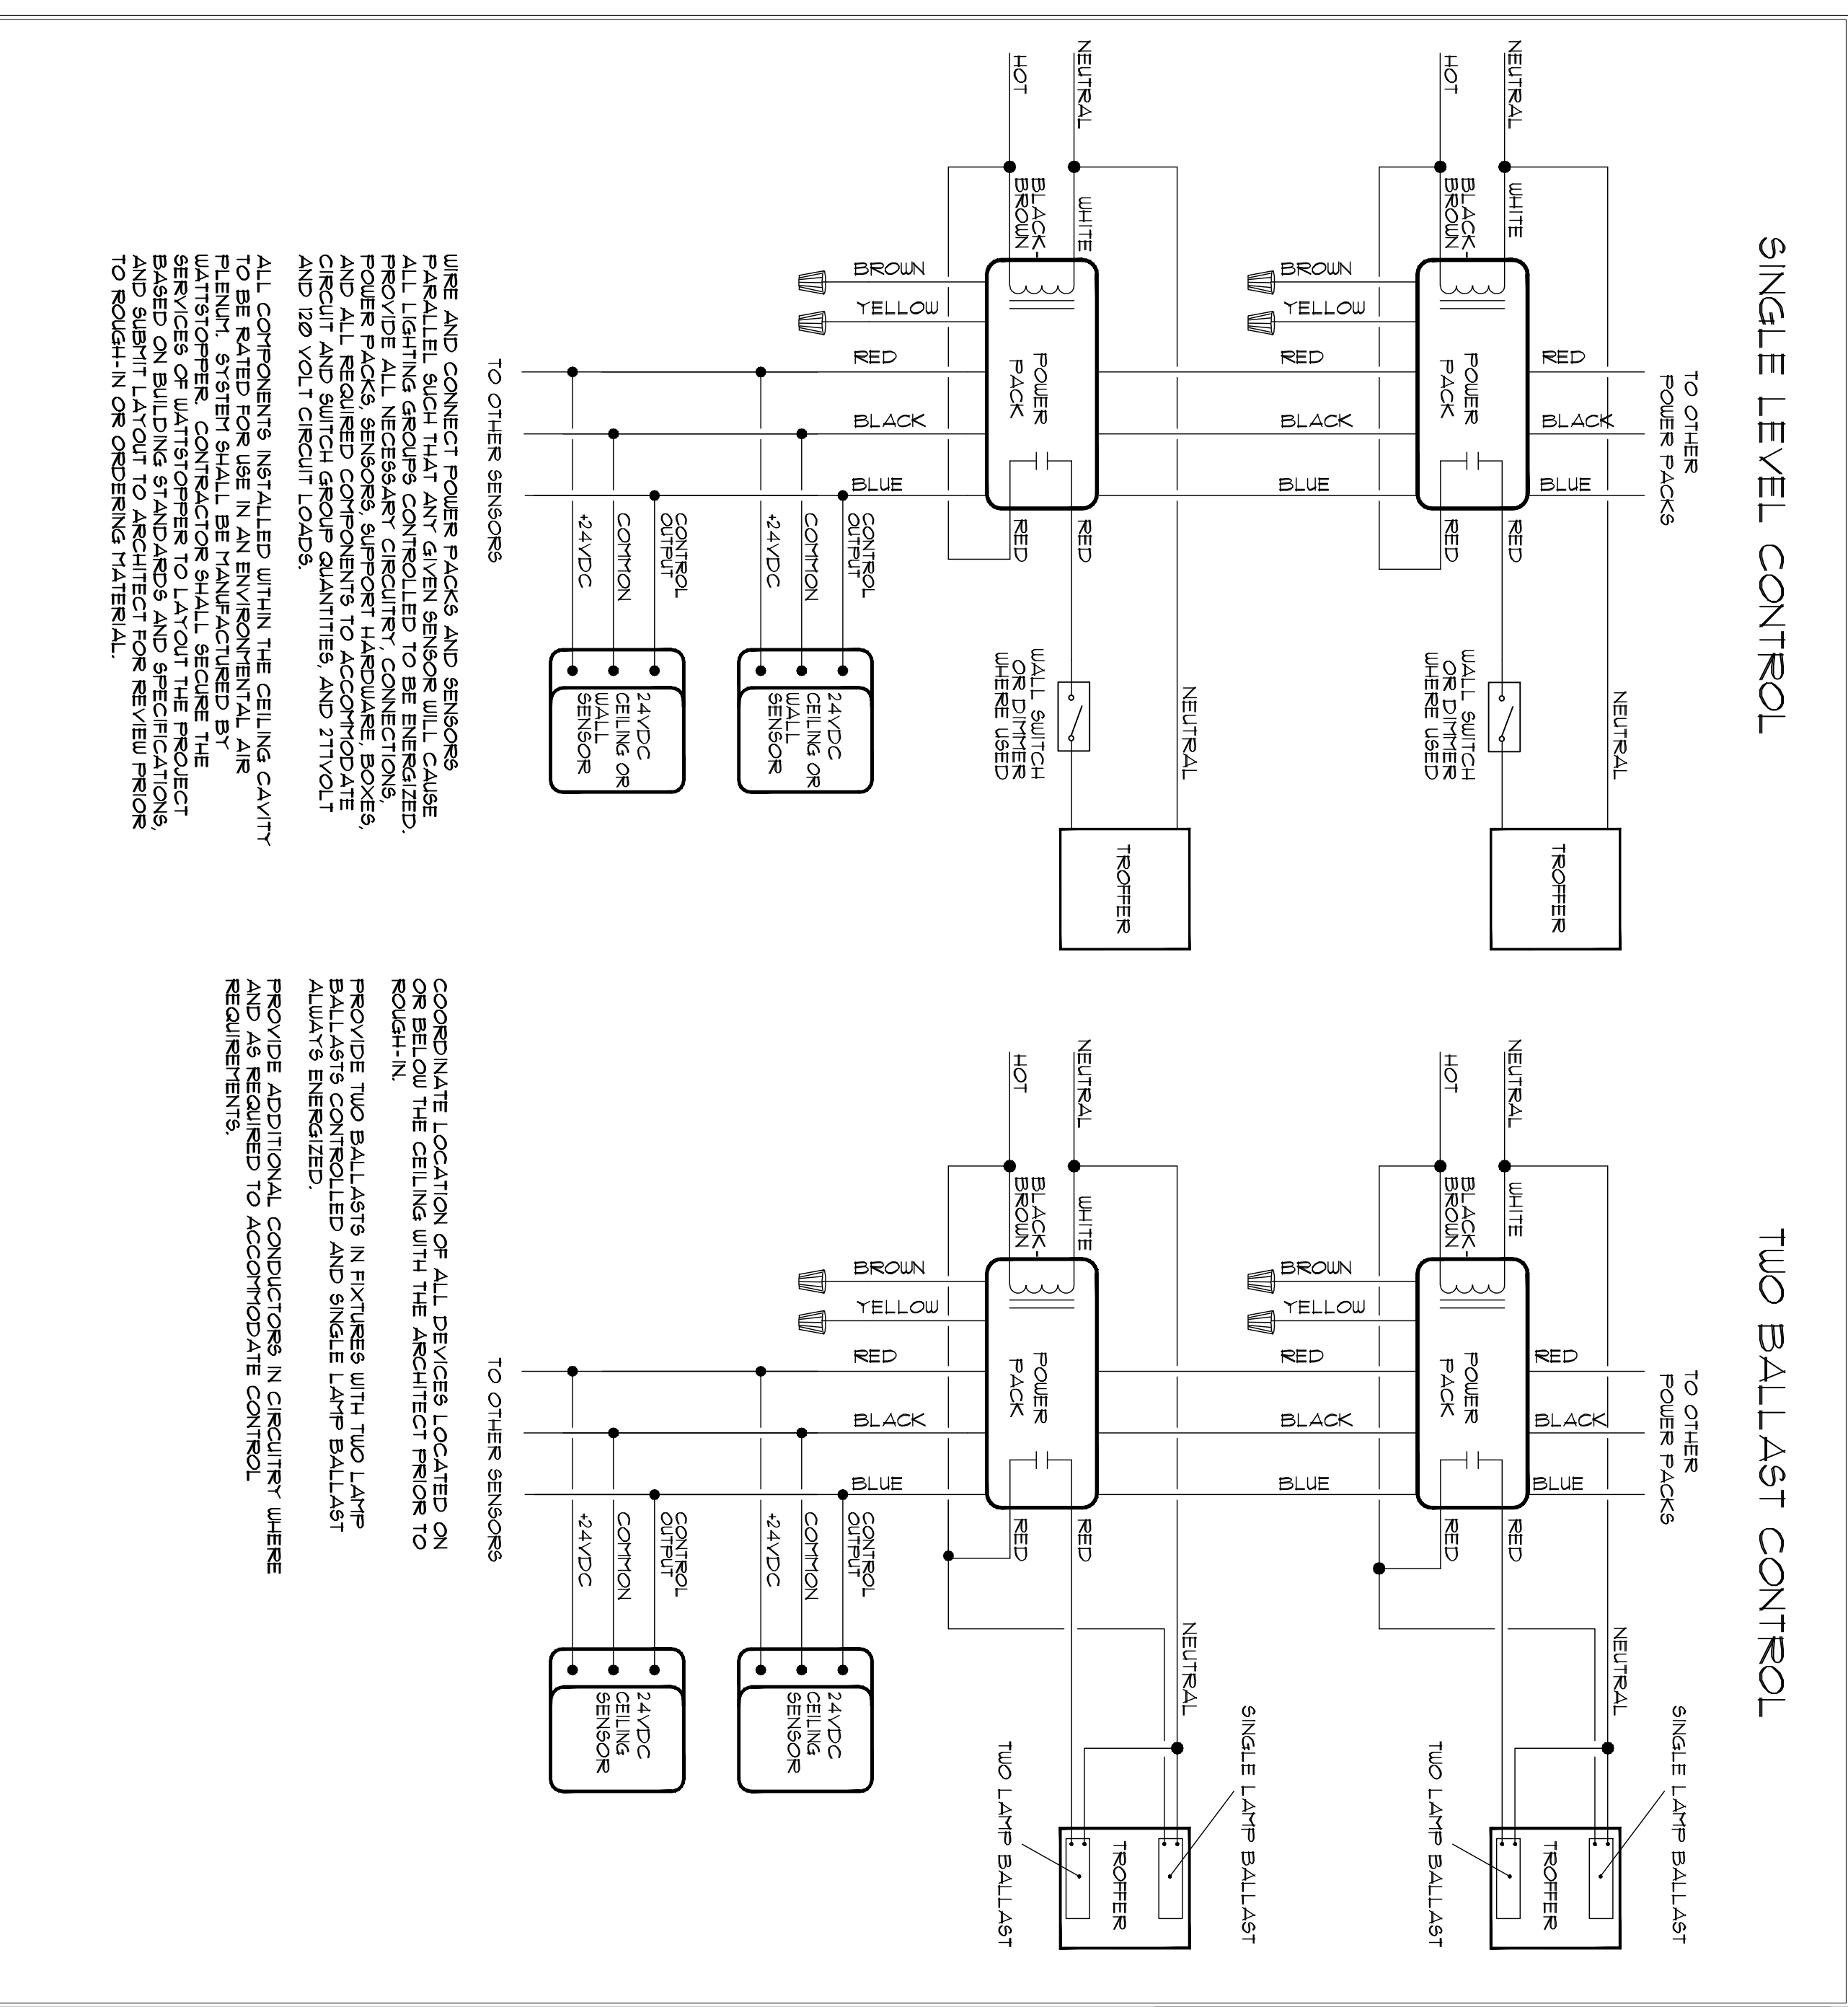

3  
POLE MOUNTING DETAIL  
NO SCALE

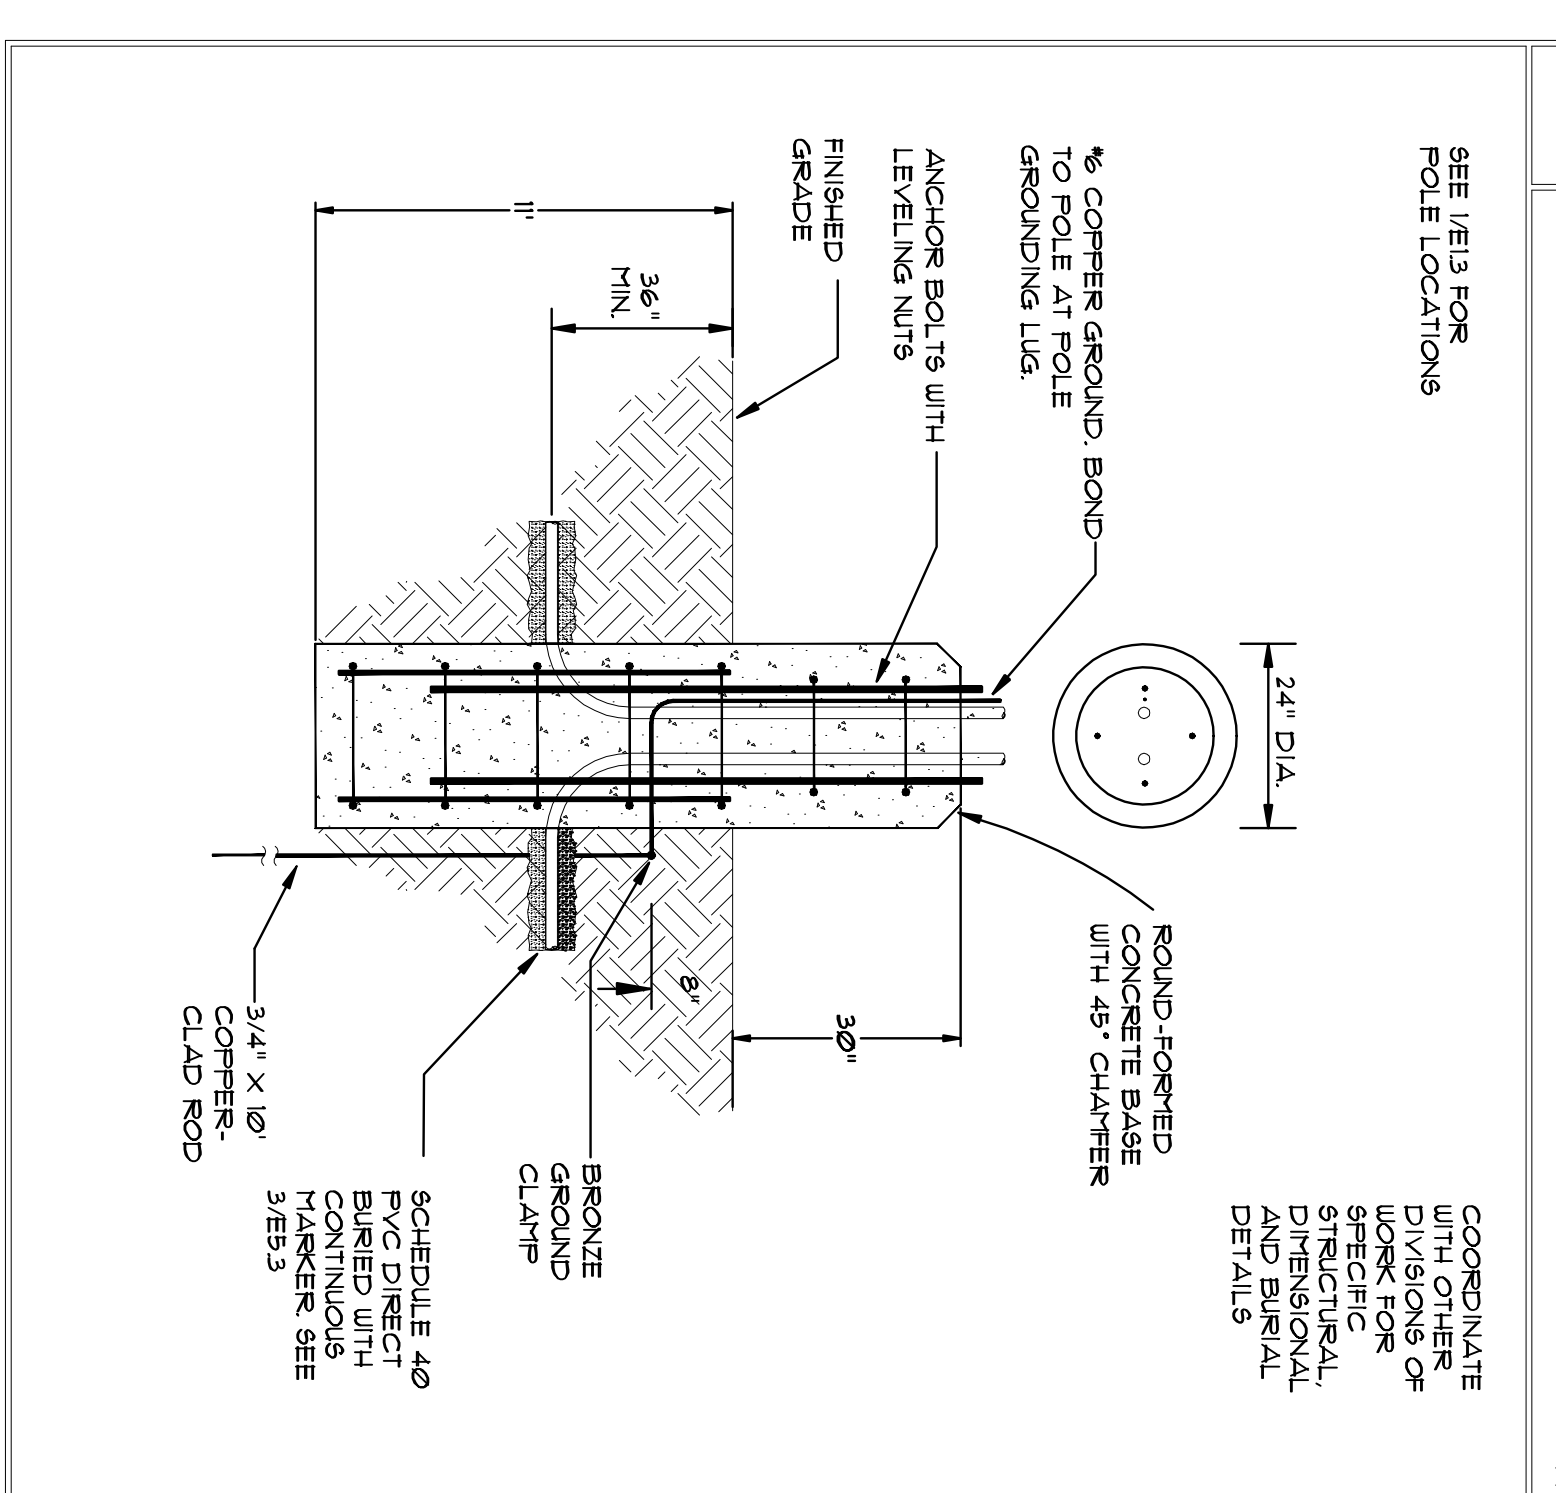

3350 Independence Drive Suite 150 Metairie, Louisiana 70002  
504.836.3889 • 504.836.3887 (fax/email) • [info@engdesignassoc.com](mailto:info@engdesignassoc.com)  
Copyright © 2007  
E1.1

**RCL**  
CONSULTANTS  
REGISTERED ARCHITECTS  
REGISTERED PROFESSIONAL ENGINEERS  
REGISTERED PROFESSIONAL ELECTRICAL ENGINEERS  
REGISTERED PROFESSIONAL MECHANICAL ENGINEERS  
REGISTERED PROFESSIONAL CIVIL ENGINEERS  
REGISTERED PROFESSIONAL SURVEYORS  
REGISTERED PROFESSIONAL LAND SURVEYORS  
REGISTERED PROFESSIONAL PLANNING ENGINEERS  
REGISTERED PROFESSIONAL ENVIRONMENTAL ENGINEERS  
REGISTERED PROFESSIONAL CHEMICAL ENGINEERS  
REGISTERED PROFESSIONAL METALLURGICAL ENGINEERS  
REGISTERED PROFESSIONAL INDUSTRIAL ENGINEERS  
REGISTERED PROFESSIONAL AERONAUTICAL ENGINEERS  
REGISTERED PROFESSIONAL AGRICULTURAL ENGINEERS  
REGISTERED PROFESSIONAL BIOMEDICAL ENGINEERS  
REGISTERED PROFESSIONAL BIOMEDICAL SCIENTISTS  
REGISTERED PROFESSIONAL BIOMEDICAL TECHNOLOGISTS  
REGISTERED PROFESSIONAL BIOMEDICAL ENGINEERS  
REGISTERED PROFESSIONAL BIOMEDICAL SCIENTISTS  
REGISTERED PROFESSIONAL BIOMEDICAL TECHNOLOGISTS

**RICHARD C. LAMBERT**  
CONSULTANT  
521 N. Country Club  
Metairie, Louisiana 70002  
Phone: 504.836.3889  
Fax: 504.836.3887  
E-Mail: [rlc@engdesignassoc.com](mailto:rlc@engdesignassoc.com)  
The content and design of this document are the property of RCL and are not to be reproduced or transmitted in any form or by any means, electronic, mechanical, photocopying, recording, or by any information storage and retrieval system, without the prior written permission of RCL.

RCLC  
Project Number: 0887  
Date Issued: 09/15/07  
Drawn By: EDA  
Checked By: EDA  
Revisions:

**ST. TAMMANY PARISH SHERIFF'S OFFICE**  
BROWNSWITCH ROAD  
SLIDELL, LOUISIANA

CONSTRUCTION DOCUMENTS

LIGHTING PLAN  
1ST FLOOR  
Sheet Number: E1.1