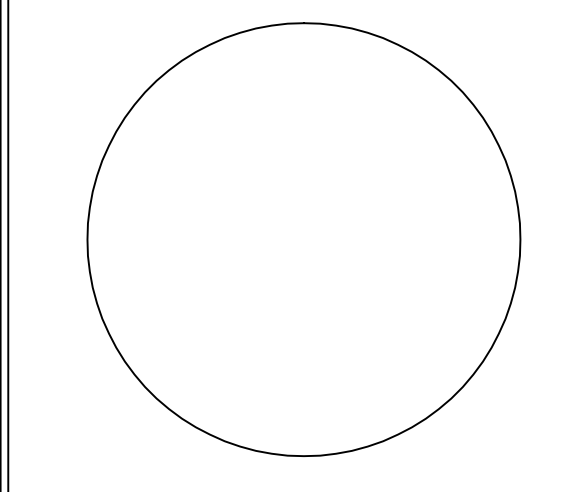


Revisions:

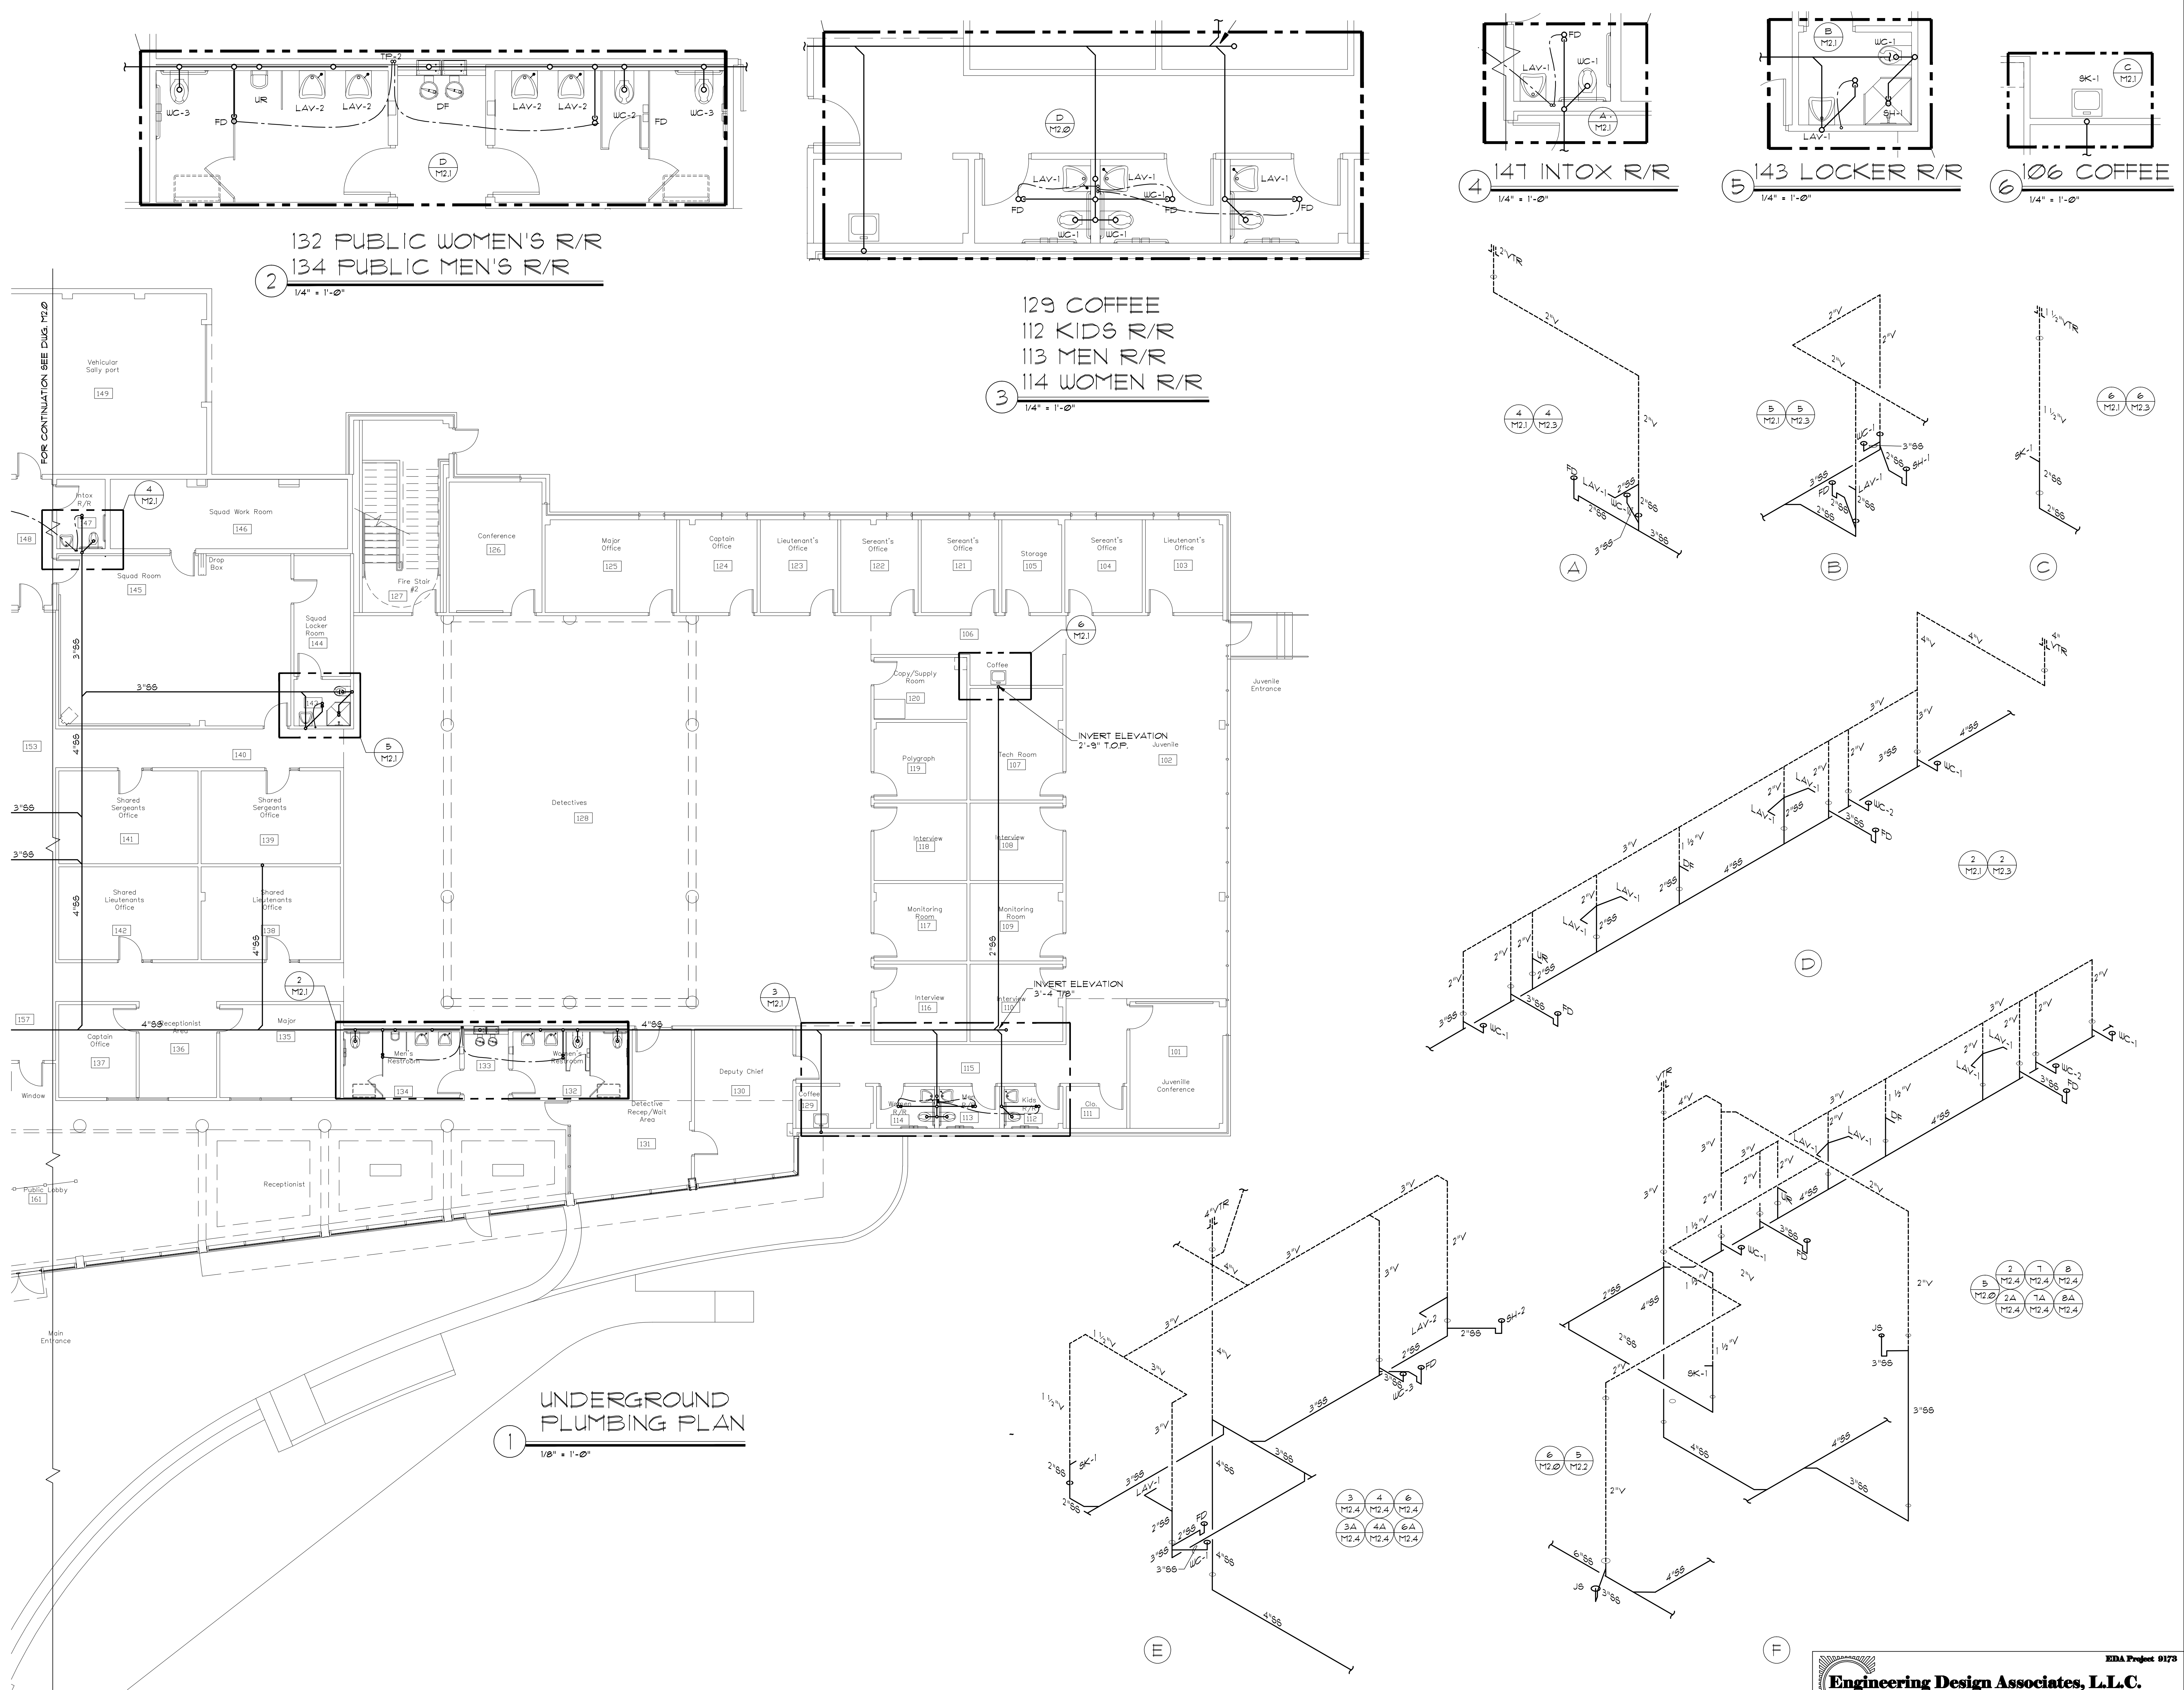

**ST. TAMMANY PARISH SHERIFF'S OFFICE**  
BROWNSWITCH ROAD  
SLIDELL, LOUISIANA

CONSTRUCTION DOCUMENTS



PLUMBING  
DETAILS  
UNDERGROUND

Sheet Number:  
**M2.1**



**1**  
UNDERGROUND  
PLUMBING PLAN  
1/8" = 1'-0"

**3**  
129 COFFEE  
112 KIDS R/R  
113 MEN R/R  
114 WOMEN R/R  
1/4" = 1'-0"

**4**  
141 INTOX R/R  
1/4" = 1'-0"

**5**  
143 LOCKER R/R  
1/4" = 1'-0"

**6**  
106 COFFEE  
1/4" = 1'-0"

**1**  
1/8" = 1'-0"

**E**

**F**