



RICHARD C. LAMBERT
CONSULTING, LLC

521 N. Gateway Blvd.
Metairie, LA 70002
Phone: 504-885-7247
Fax: 504-885-7247
#10000000
New Orleans, LA 70002
Phone: 504-577-7247
Fax: 504-577-7247

RCLC
Project Number: 0887
Date Issued: 05/15/07
Drawn By: EDA
Checked By: EDA
Revisors:

ST. TAMMANY PARISH SHERIFF'S OFFICE
BROWNSWITCH ROAD
SLIDELL, LOUISIANA






CONSTRUCTION DOCUMENTS

PLUMBING PLAN
1ST FLOOR
Sheet Number: M2.2

PLUMBING PLAN
1ST FLOOR
Sheet Number: M2.2

3250 Tulalaha Blvd., Suite 100 Metairie, Louisiana 70002
504.835.9387 - 504.835.9387 (toll-free) - info@engdesignassoc.com

Engineering Design Associates, L.L.C.
Consulting Engineers
Copyright © 2007
EIDA Project 8173

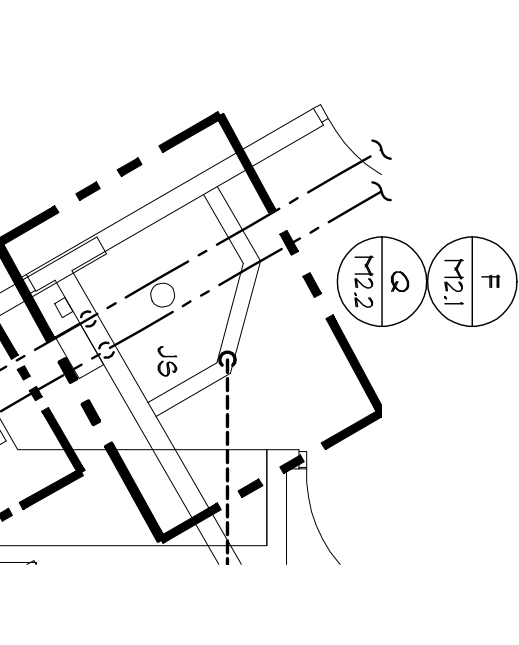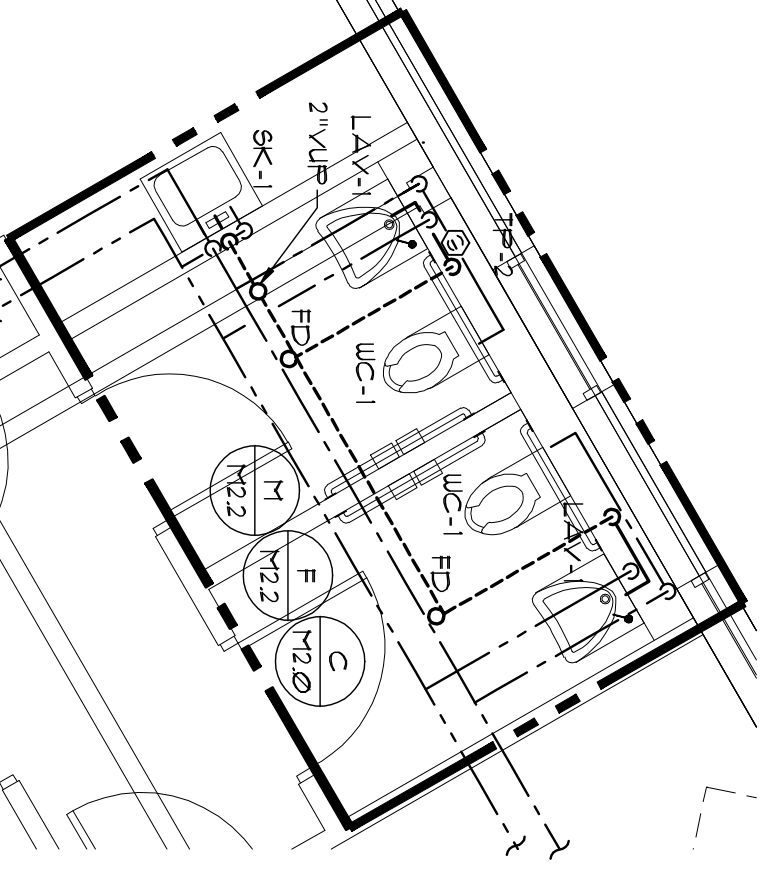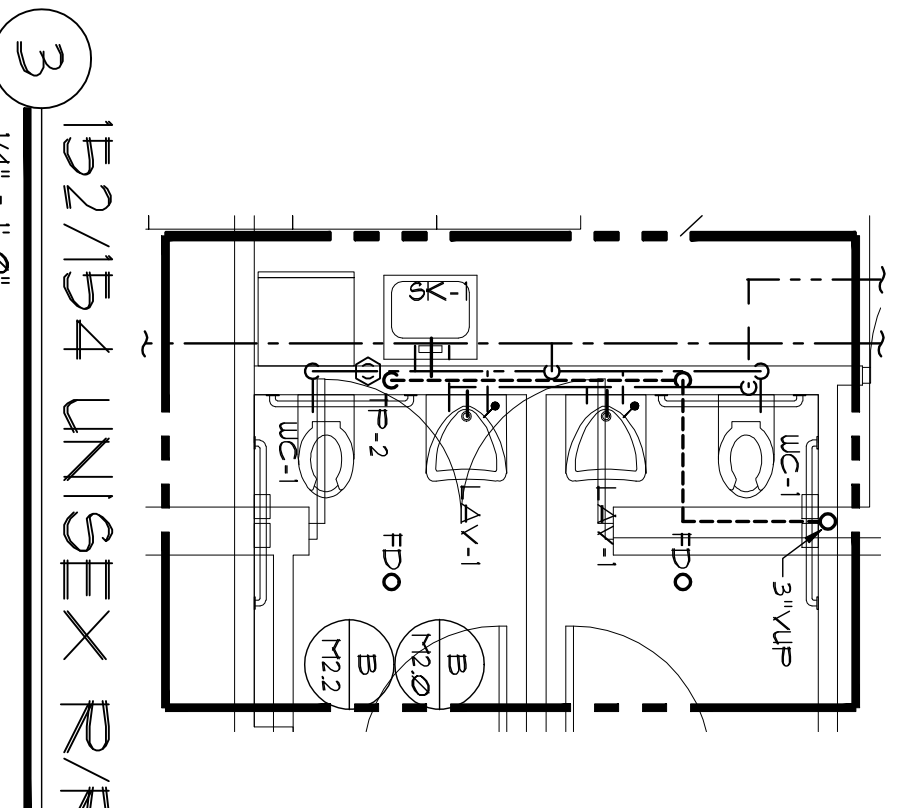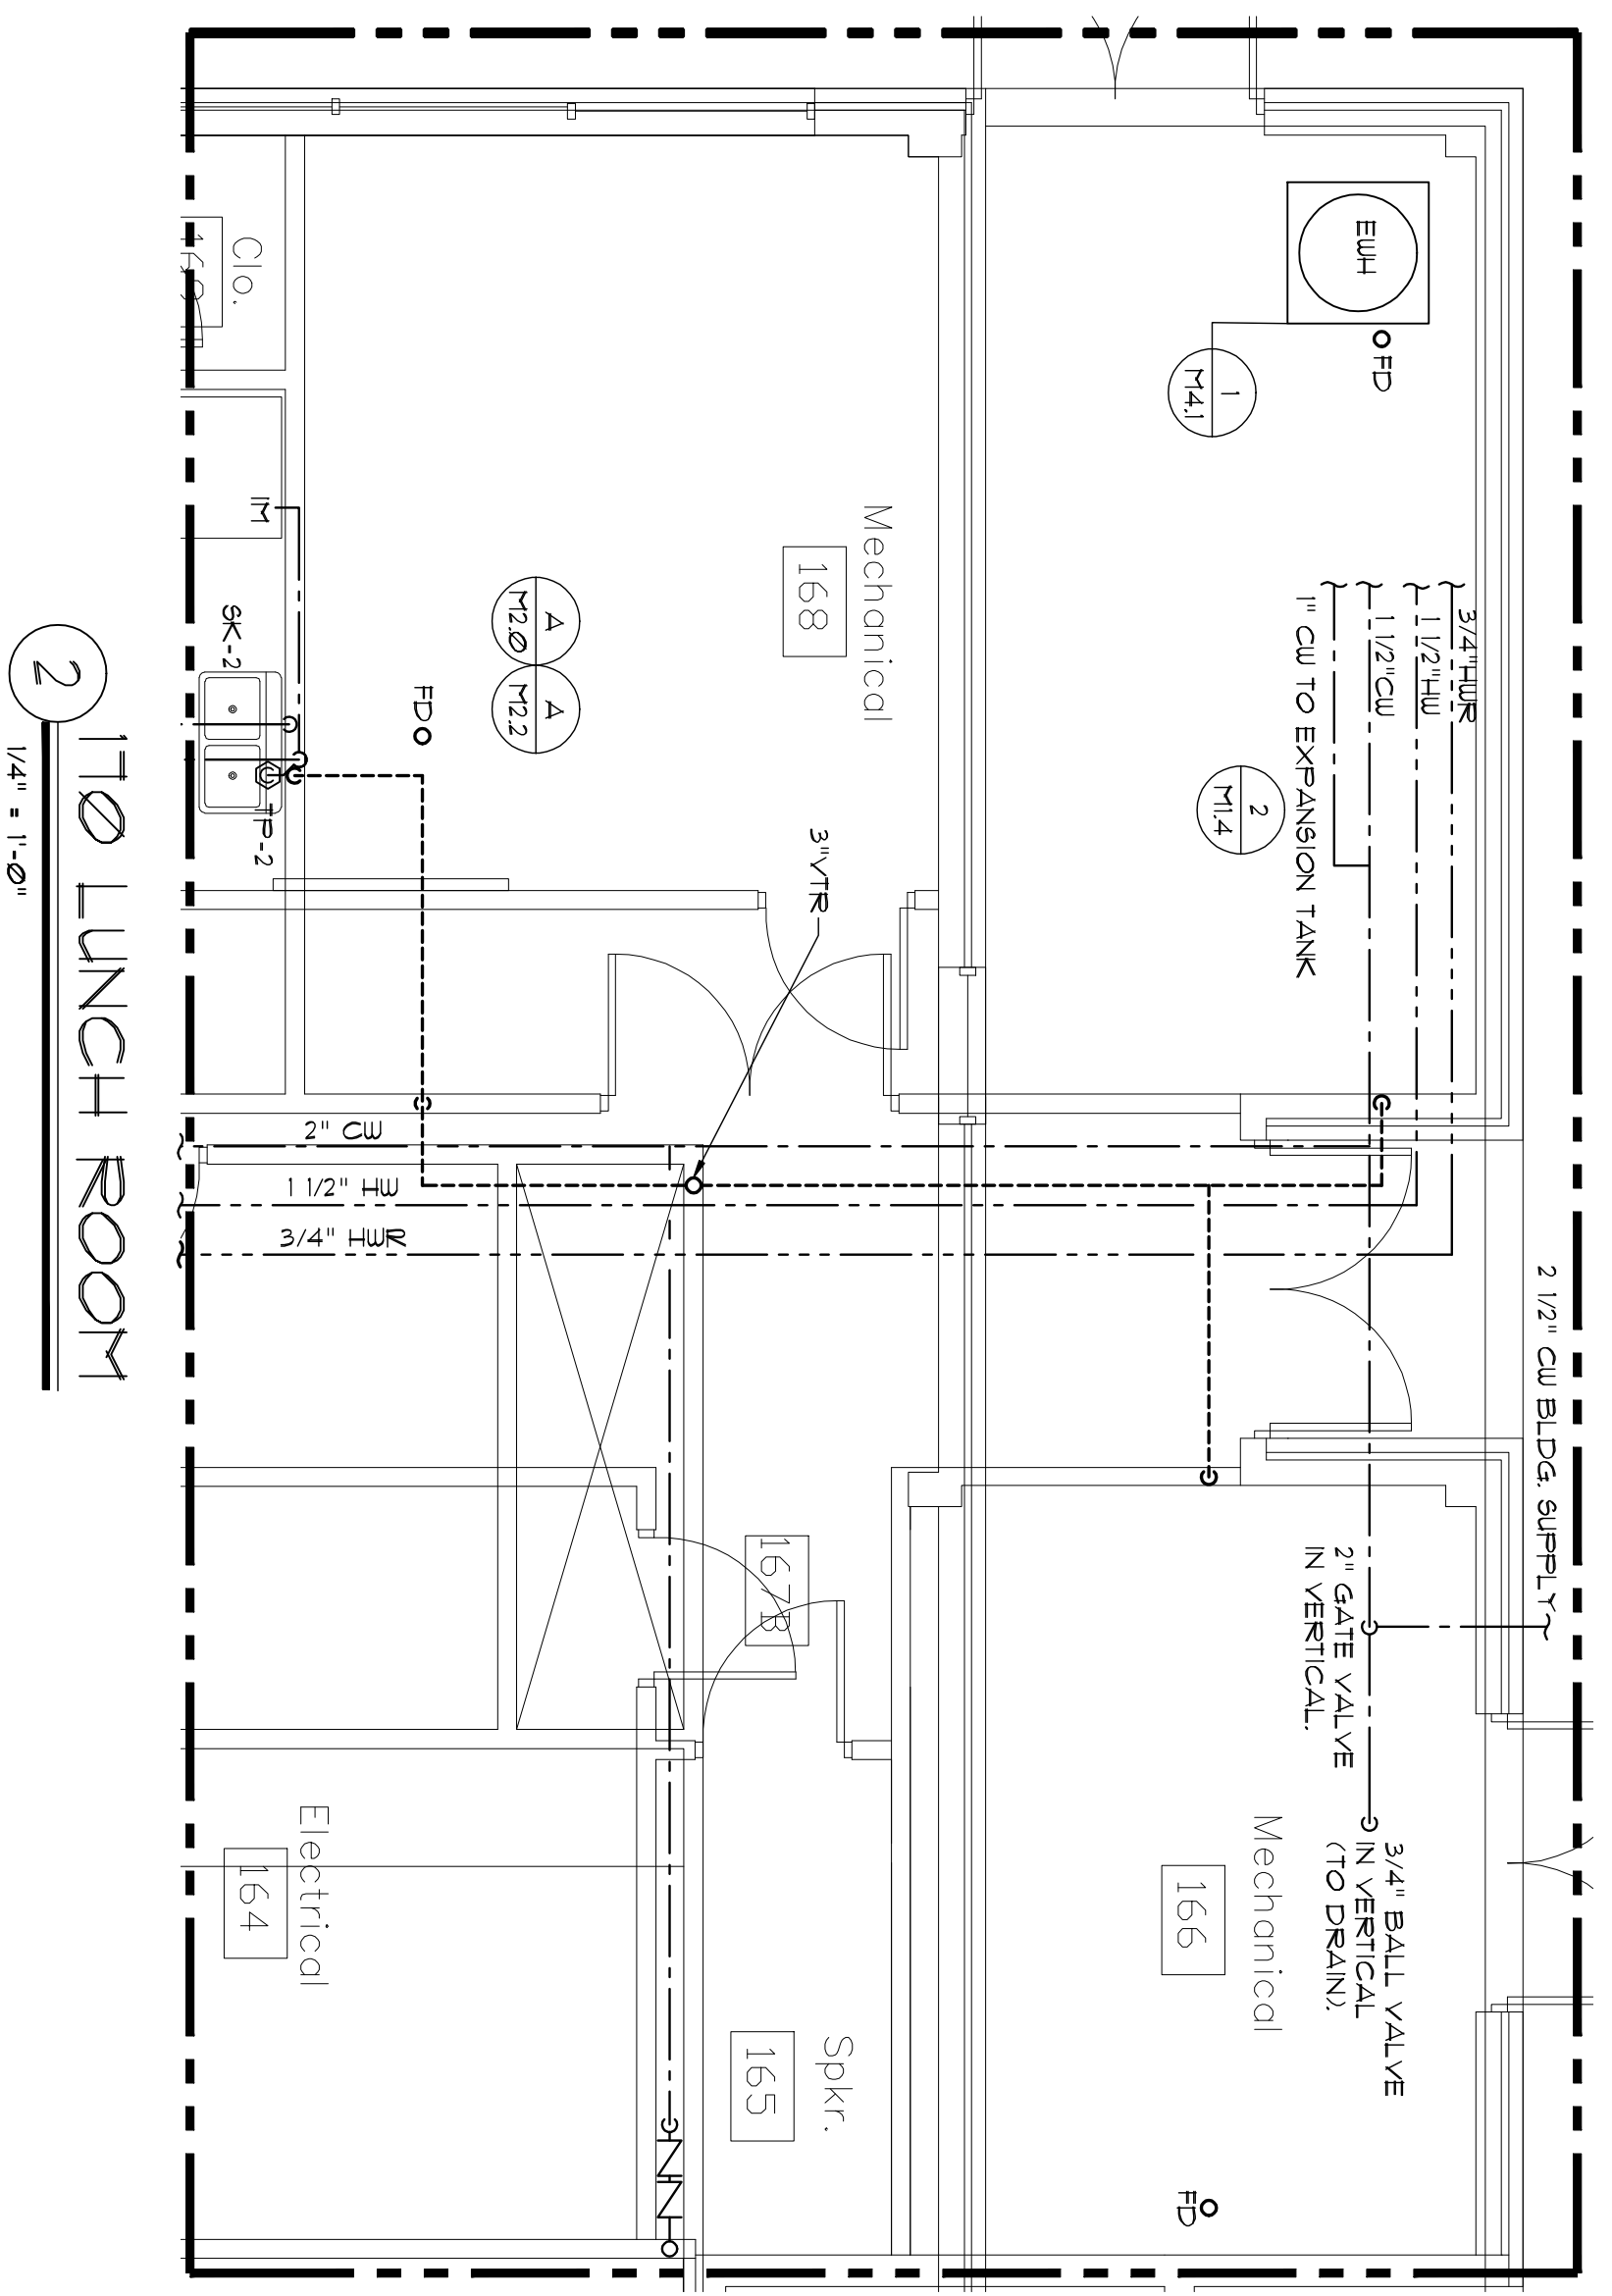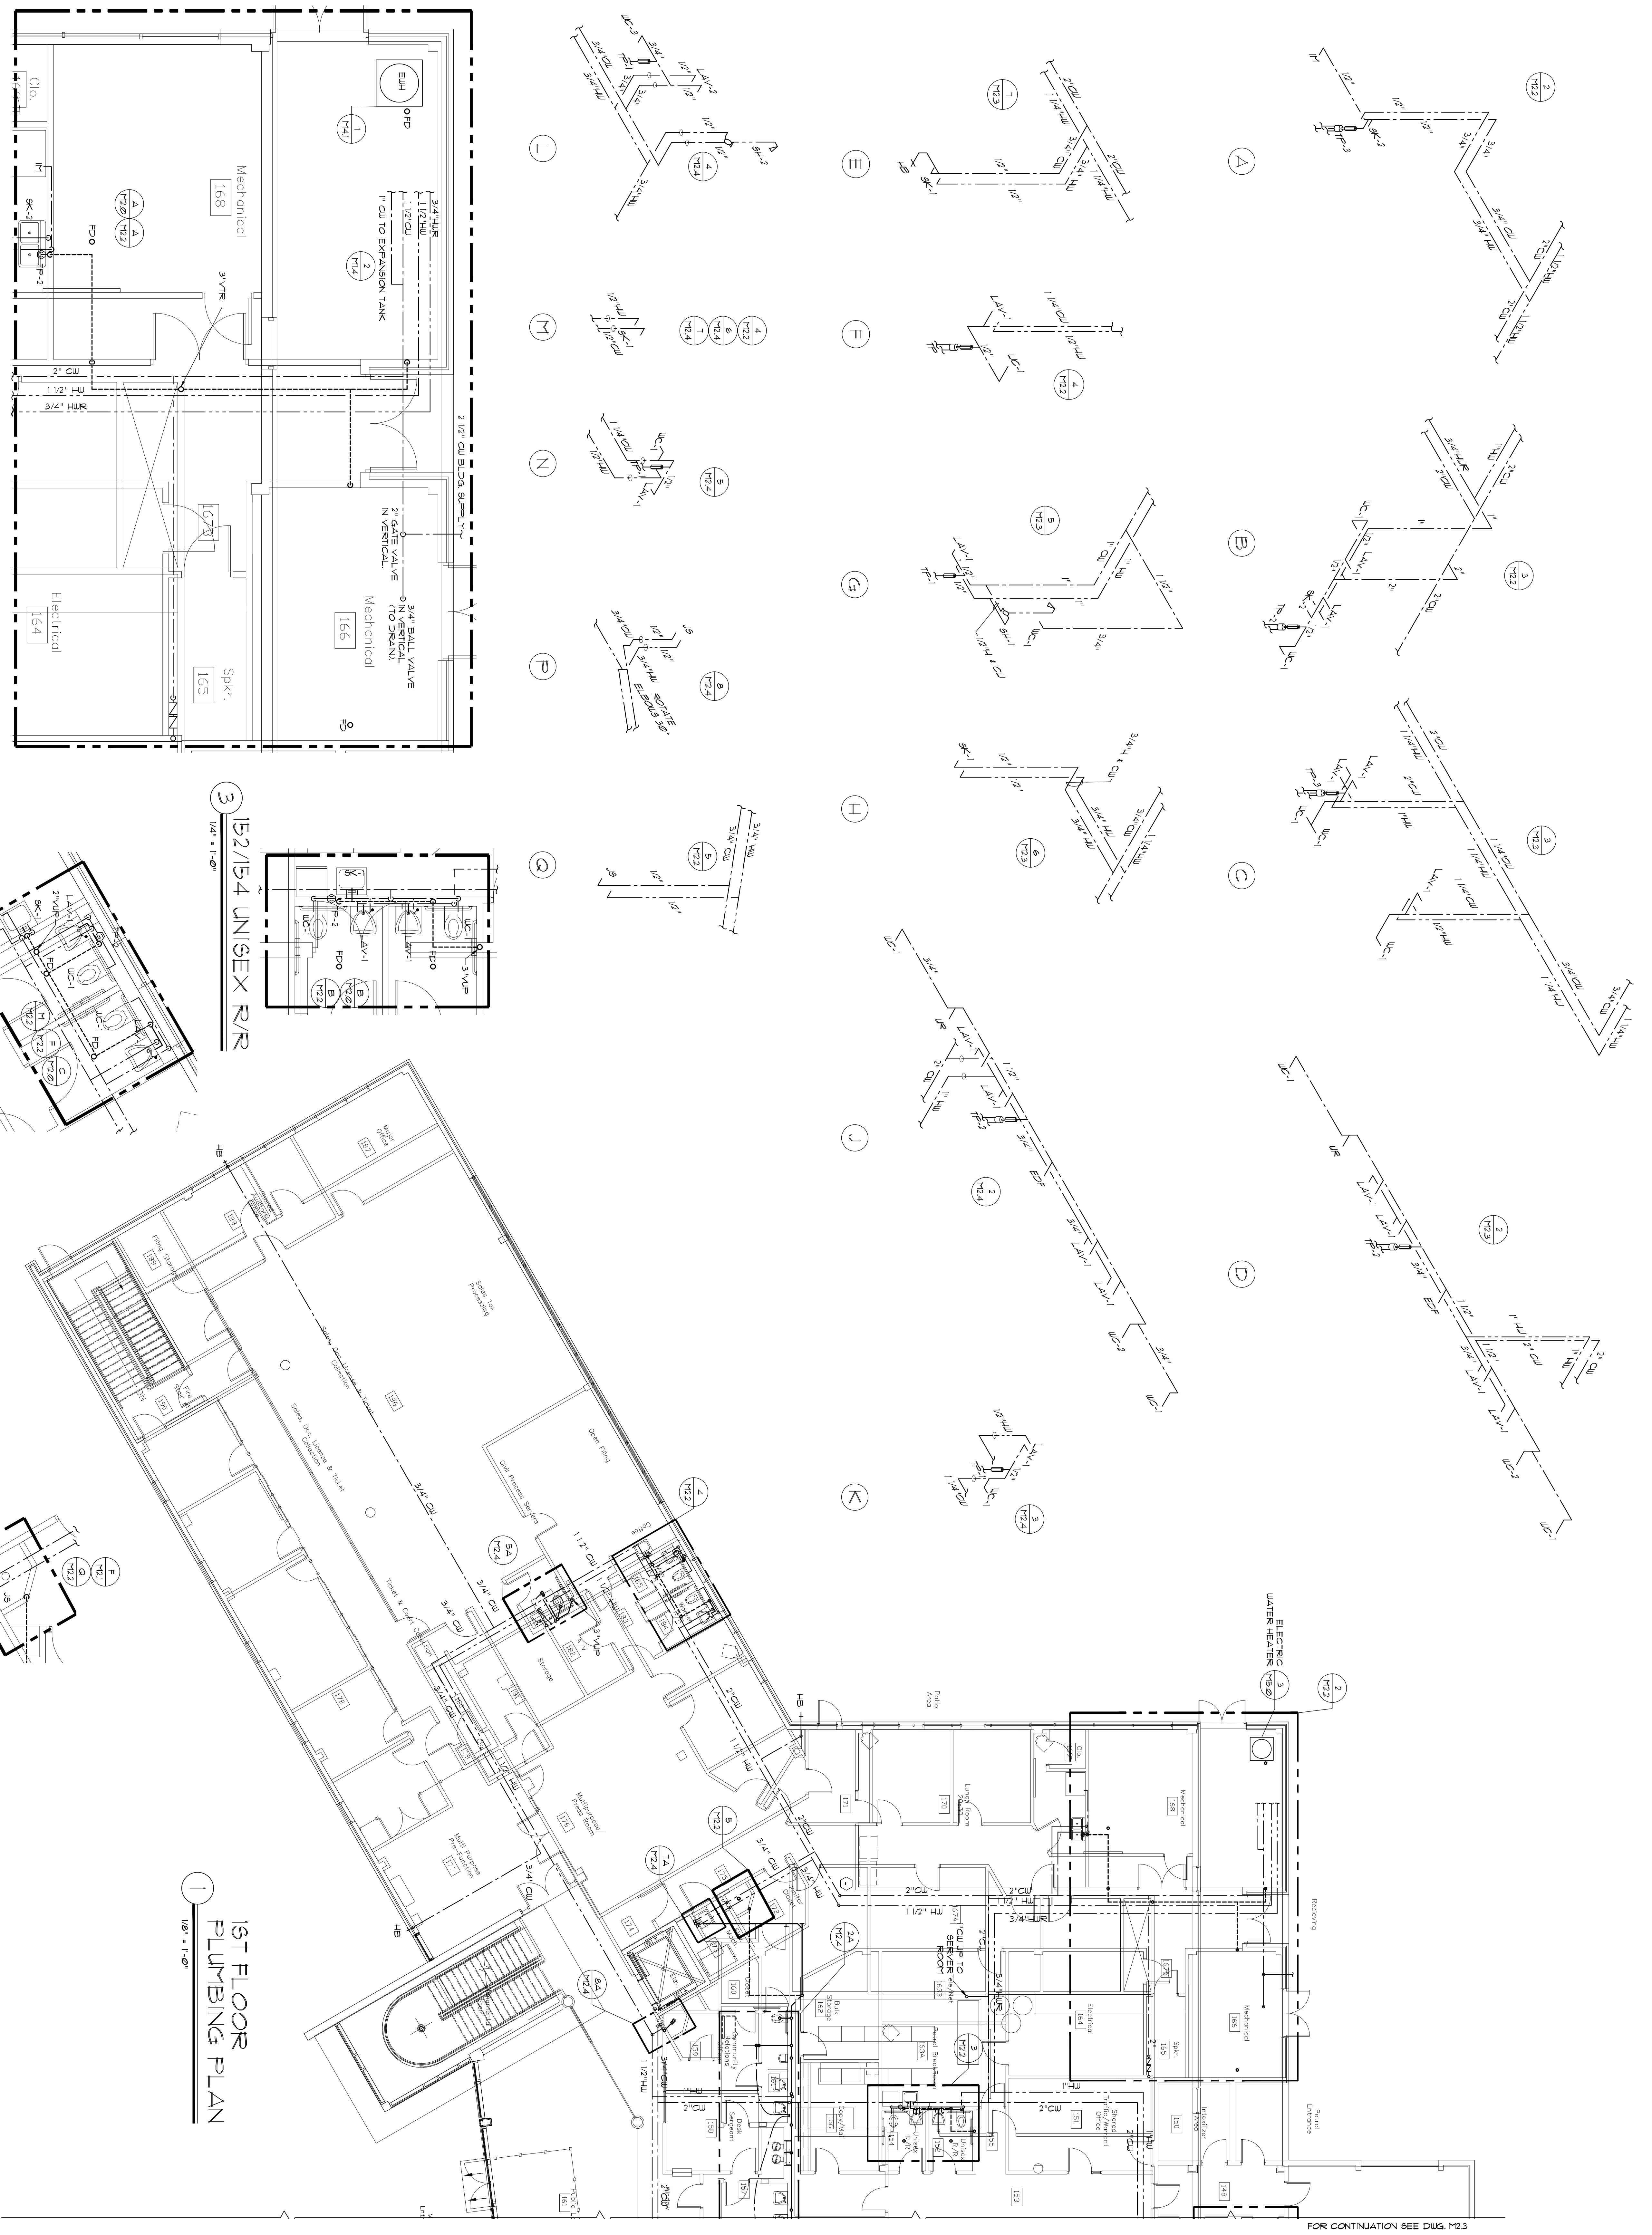

1 1ST FLOOR PLUMBING PLAN
1/8" = 1'-0"

3 152/154 UNISEX RR
1/4" = 1'-0"

4 184 WOMEN RR
185 MEN RR
1/4" = 1'-0"

5 172 JANITOR'S CLOSET
1/4" = 1'-0"

2 170 LUNCH ROOM
1/4" = 1'-0"