




1 1ST FLOOR PLUMBING PLAN  
1/8" = 1'-0"

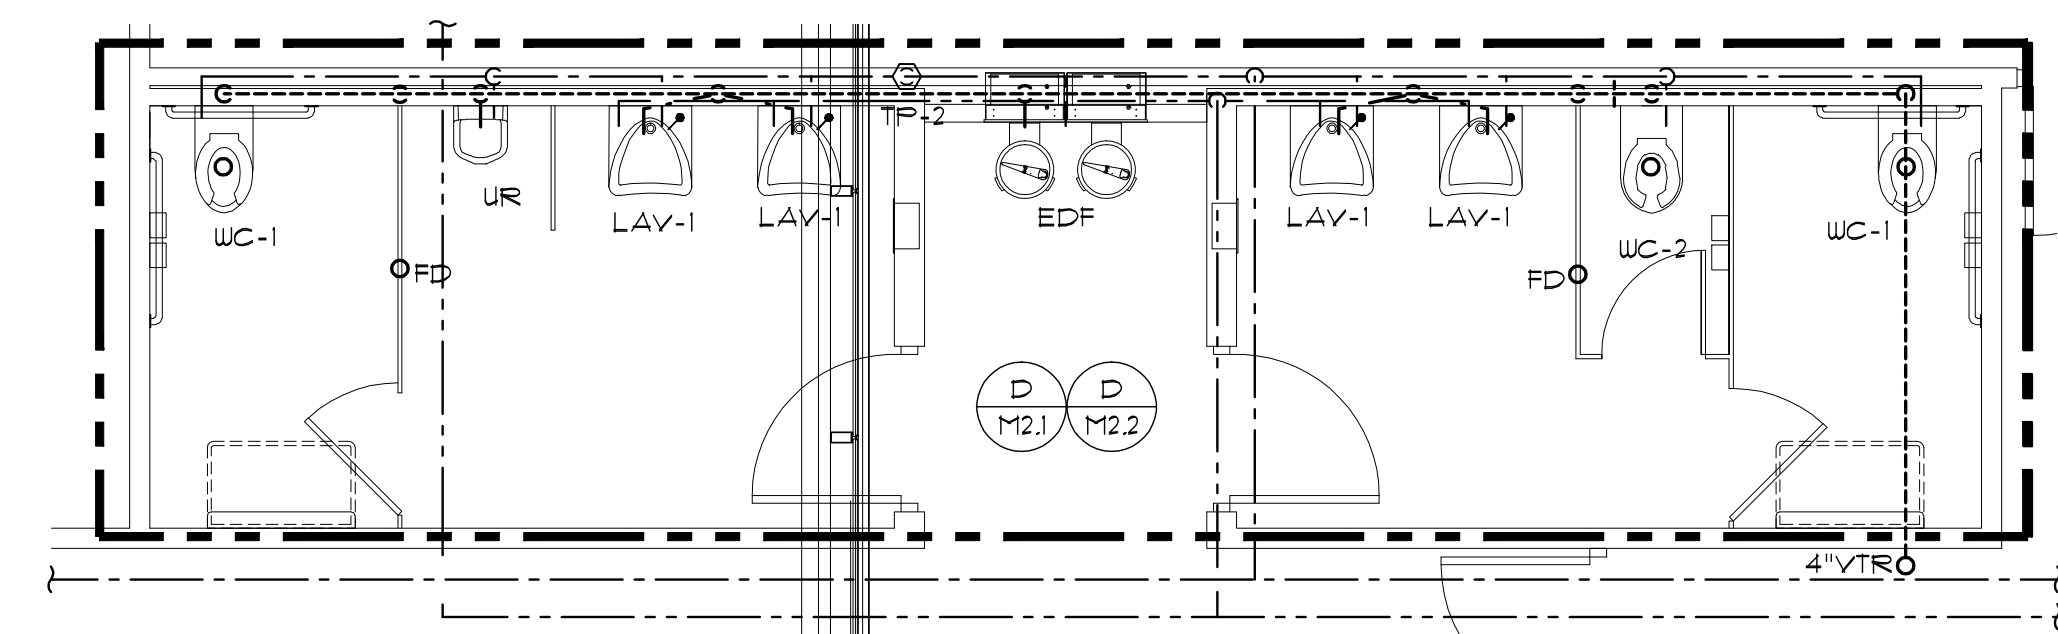


2 132 PUBLIC WOMEN'S R/R  
134 PUBLIC MEN'S R/R  
1/4" = 1'-0"

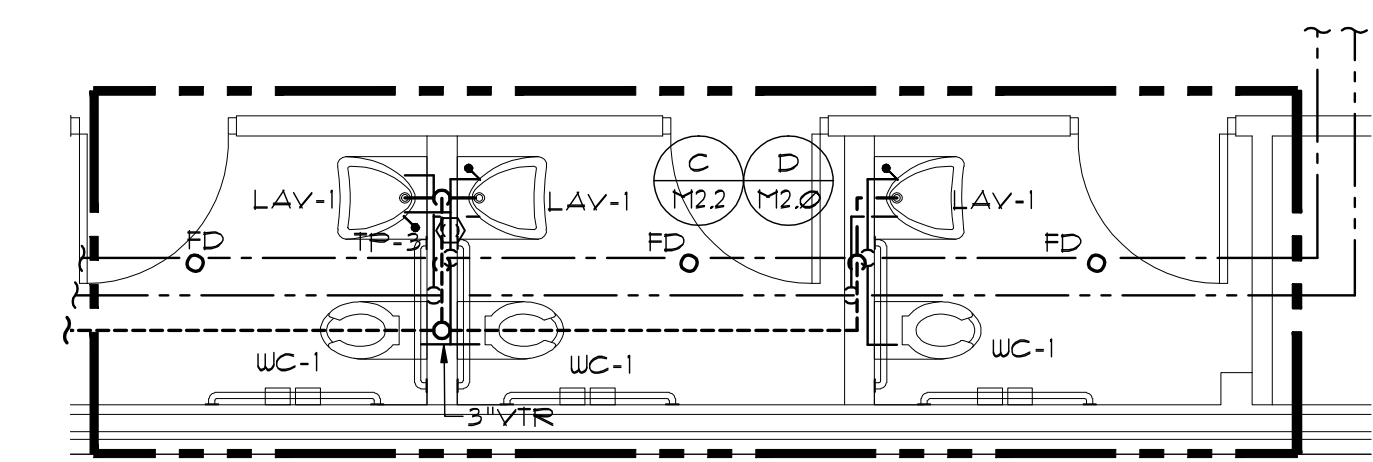


3 112 KIDS R/R  
113 MEN R/R  
114 WOMEN R/R  
1/4" = 1'-0"

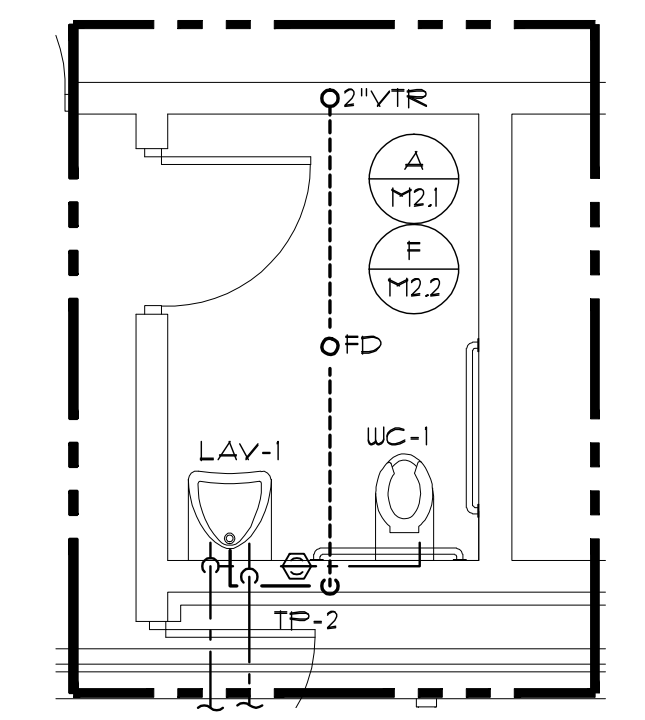


4 147 INTOX R/R  
1/4" = 1'-0"

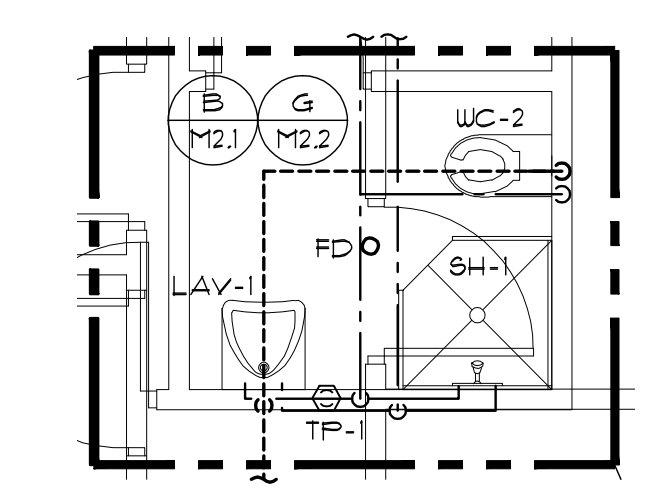

5 143 LOCKER R/R  
1/4" = 1'-0"

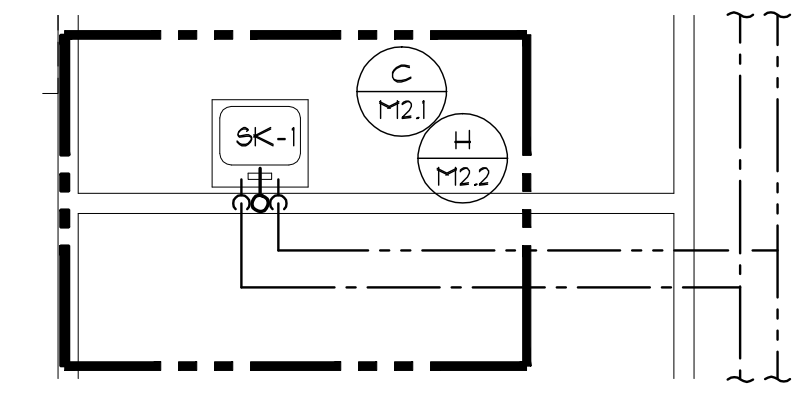

6 106 COFFEE  
1/4" = 1'-0"

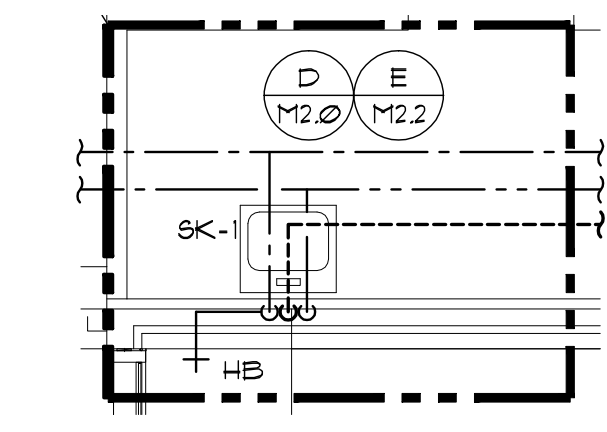

7 129 COFFEE  
1/4" = 1'-0"

PLUMBING FIXTURE AND CONNECTION SCHEDULE

TAG	FIXTURE	MANUFACTURER	MODEL *	TYPE	MATERIAL	STYLE	FAUCET/VALVE				DRAIN		PIPE SIZES			SUPPLIES/STOPS	REMARKS		
							MANUFACTURER	MODEL *	SPOUT	HANDLE	CENTERS	TYPE	SIZE	P-TRAP	WASTE			COLD WATER	HOT WATER
SK-1	SINGLE COMPARTMENT SINK	ELKAY	DLR2B1910	LAY IN	STAINLESS STEEL	1 BOWL	SYMMONS	6-23	8 1/2" SWING	SINGLE	8"	STRAINER	3 1/2"	2"	2"	1/2"	1/2"	1/2"x3/8" LAV.	
SK-2	DOUBLE COMPARTMENT SINK	ELKAY	CR3321	LAY IN	STAINLESS STEEL	2 BOWL	SYMMONS	6-23	8 1/2" SWING	SINGLE	8"	STRAINER	3 1/2"	2"	2"	1/2"	1/2"	1/2"x3/8" LAV.	
LAV-1	LAV-HANDICAP	CRANE	142V	WALL MOUNT	VITREOUS CHINA	1 BOWL	SYMMONS	8-20-0	STANDARD	SINGLE	4"	GRID		1 1/2"	2"	1/2"	1/2"	1/2"x3/8" LAV.	
LAV-2	LAVATORY	KOHLER	K-3049-8	ONE PIECE SURFACE	CAST IRON	INTEGRATED	KOHLER	K-394-4	6-3/8"	DOUBLE LEVER	8"	POP-UP	1 3/4"	K-2018	1 1/4"	1/2"	1/2"	1/2"x3/8" LAV.	SHERIFF'S PERSONAL BATHROOM
WC-1	WATER CLOSET-HANDICAP	CRANE	31092 HYMONT	FLOOR MOUNT	VITREOUS CHINA	ELONGATED	-	-	-	-	-	-	-	3"	1/2"	-	1/2"x3/8" CLOSET		
WC-2	WATER CLOSET	CRANE	3192 GALAXY	FLOOR MOUNT	VITREOUS CHINA	ELONGATED	-	-	-	-	-	-	-	4"	1/2"	-	1/2"x3/8" CLOSET		
WC-3	WATER CLOSET	KOHLER	K-3503	FLOOR MOUNT	VITREOUS CHINA	ELONGATED	-	-	-	-	-	-	-	2 1/8"	1/2"	-	1/2"x3/8" CLOSET	SHERIFF'S PERSONAL BATHROOM	
UR	URINAL	CRANE	7121 BEDFORD	WALL MOUNT	VITREOUS CHINA	1 BOWL	SLOAN	ROYAL 186-1	-	-	-	-	-	2"	3/4"	-	-		
SH-1	SHOWER	AMERICAN STANDARD	3838	SHOWER FLOOR	ACRYLIC	NEO-ANGLE	SYMMONS	BP-56-1-X	SHOWER ARM	SINGLE	5 1/2"	STRAINER	2"	2"	2"	1/2"	1/2"	INTEGRAL	PROVIDE NEO-ANGLE DOOR SHOWER ENCLOSURE 3838-NEO2
SH-2	SHOWER	KOHLER	K-9495	SHOWER FLOOR	FIBERGLASS (FRP)	NEO-ANGLE	KOHLER	K-1326-4	SHOWER ARM	SINGLE	5 1/2"	STRAINER	2"	2"	2"	1/2"	1/2"	-	PROVIDE DEVONSHIRE NEO-ANGLE SHOWER ENCLOSURE K-104516-B1
JS	JANITOR SINK	FIAT	T85C 6000	FLOOR MOUNT	FRECAST TERRAZZO	ONE PIECE	CHICAGO FAUCETS	182-VB-311	8" FIXED	-	8"	DOME	2"	2"	2"	1/2"	1/2"	-	
HB	HOSE BIBB	WATTS	HY-430	WALL HYDRANT	BRONZE	KEYED	-	-	-	-	-	-	-	-	-	3/4"	-	-	
IMB	ICE MAKER BOX	OATEY	-	RECESSED	BRASS	-	-	-	-	-	-	-	-	-	-	1/2"	-	-	
EDF	ELECTRIC DRINKING FOUNTAIN	ELKAY	ERFBM28K	WALL MOUNT	STAINLESS STEEL	2 BOWL	-	-	-	-	-	-	1 1/4"	2"	1 1/4"	3/8"	-	1/2"x3/8" LAV.	

NOTES:  
VERIFY ALL FIXTURES AND LOCATIONS WITH ARCHITECT PRIOR TO COMMENCING WORK OR ORDERING MATERIAL.



RICHARD C. LAMBERT  
CONSULTANTS, L.L.C.  
521 N. Canby Blvd.  
Metairie, LA 70002  
882-727-4460  
Fax: 882-724-4467  
#1 Poydras St., Ste. 1400 #10  
New Orleans, LA 70130  
504-587-7346


This drawing and design is the exclusive property of Richard C. Lambert Consultants, LLC and may not be reproduced or used without authorization and written permission. © 2007

RCLC  
Project Number: 0687  
Date Issued: 05/15/07  
Drawn By: EDA  
Checked By: EDA

Revisions:  
\_\_\_\_\_  
\_\_\_\_\_  
\_\_\_\_\_

ST. TAMMANY PARISH SHERIFF'S OFFICE  
BROWNSWITCH ROAD  
SLIDELL, LOUISIANA

CONSTRUCTION DOCUMENTS

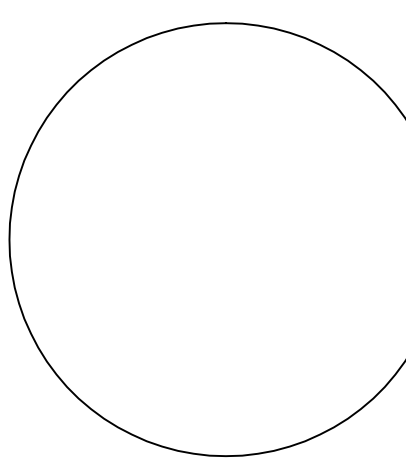

PLUMBING PLAN  
1ST FLOOR

Sheet Number:  
M2.3

Engineering Design Associates, L.L.C.  
Consulting Engineers  
3350 Ridgeland Drive Suite 190 Metairie, Louisiana 70002  
504 836 3889 - 504 836 3887 (fax) - eda@engineeringdesignassoc.com  
Copyright © 2007