




LACHIN OUBRE & Associates
 ARCHITECTS PLANNERS
 PROJECT MANAGERS
 A PROFESSIONAL CORPORATION
 5190 Canal Blvd., Suite 201, New Orleans, La. 70124
 Ph: 504-835-8013

NO.	DATE	REVISION	DESCRIPTION


STATION 36
CITY OF NEW ORLEANS FIRE STATION
 5403 READ BLVD
 NEW ORLEANS, LOUISIANA

DRAWING TITLE:	WALL SECTIONS
PROJECT NO:	1506
CHECK BY:	MG
DRAWN BY:	MG
DATE:	11/30/16
SHEET No.:	


A603
 OF -- SHEET

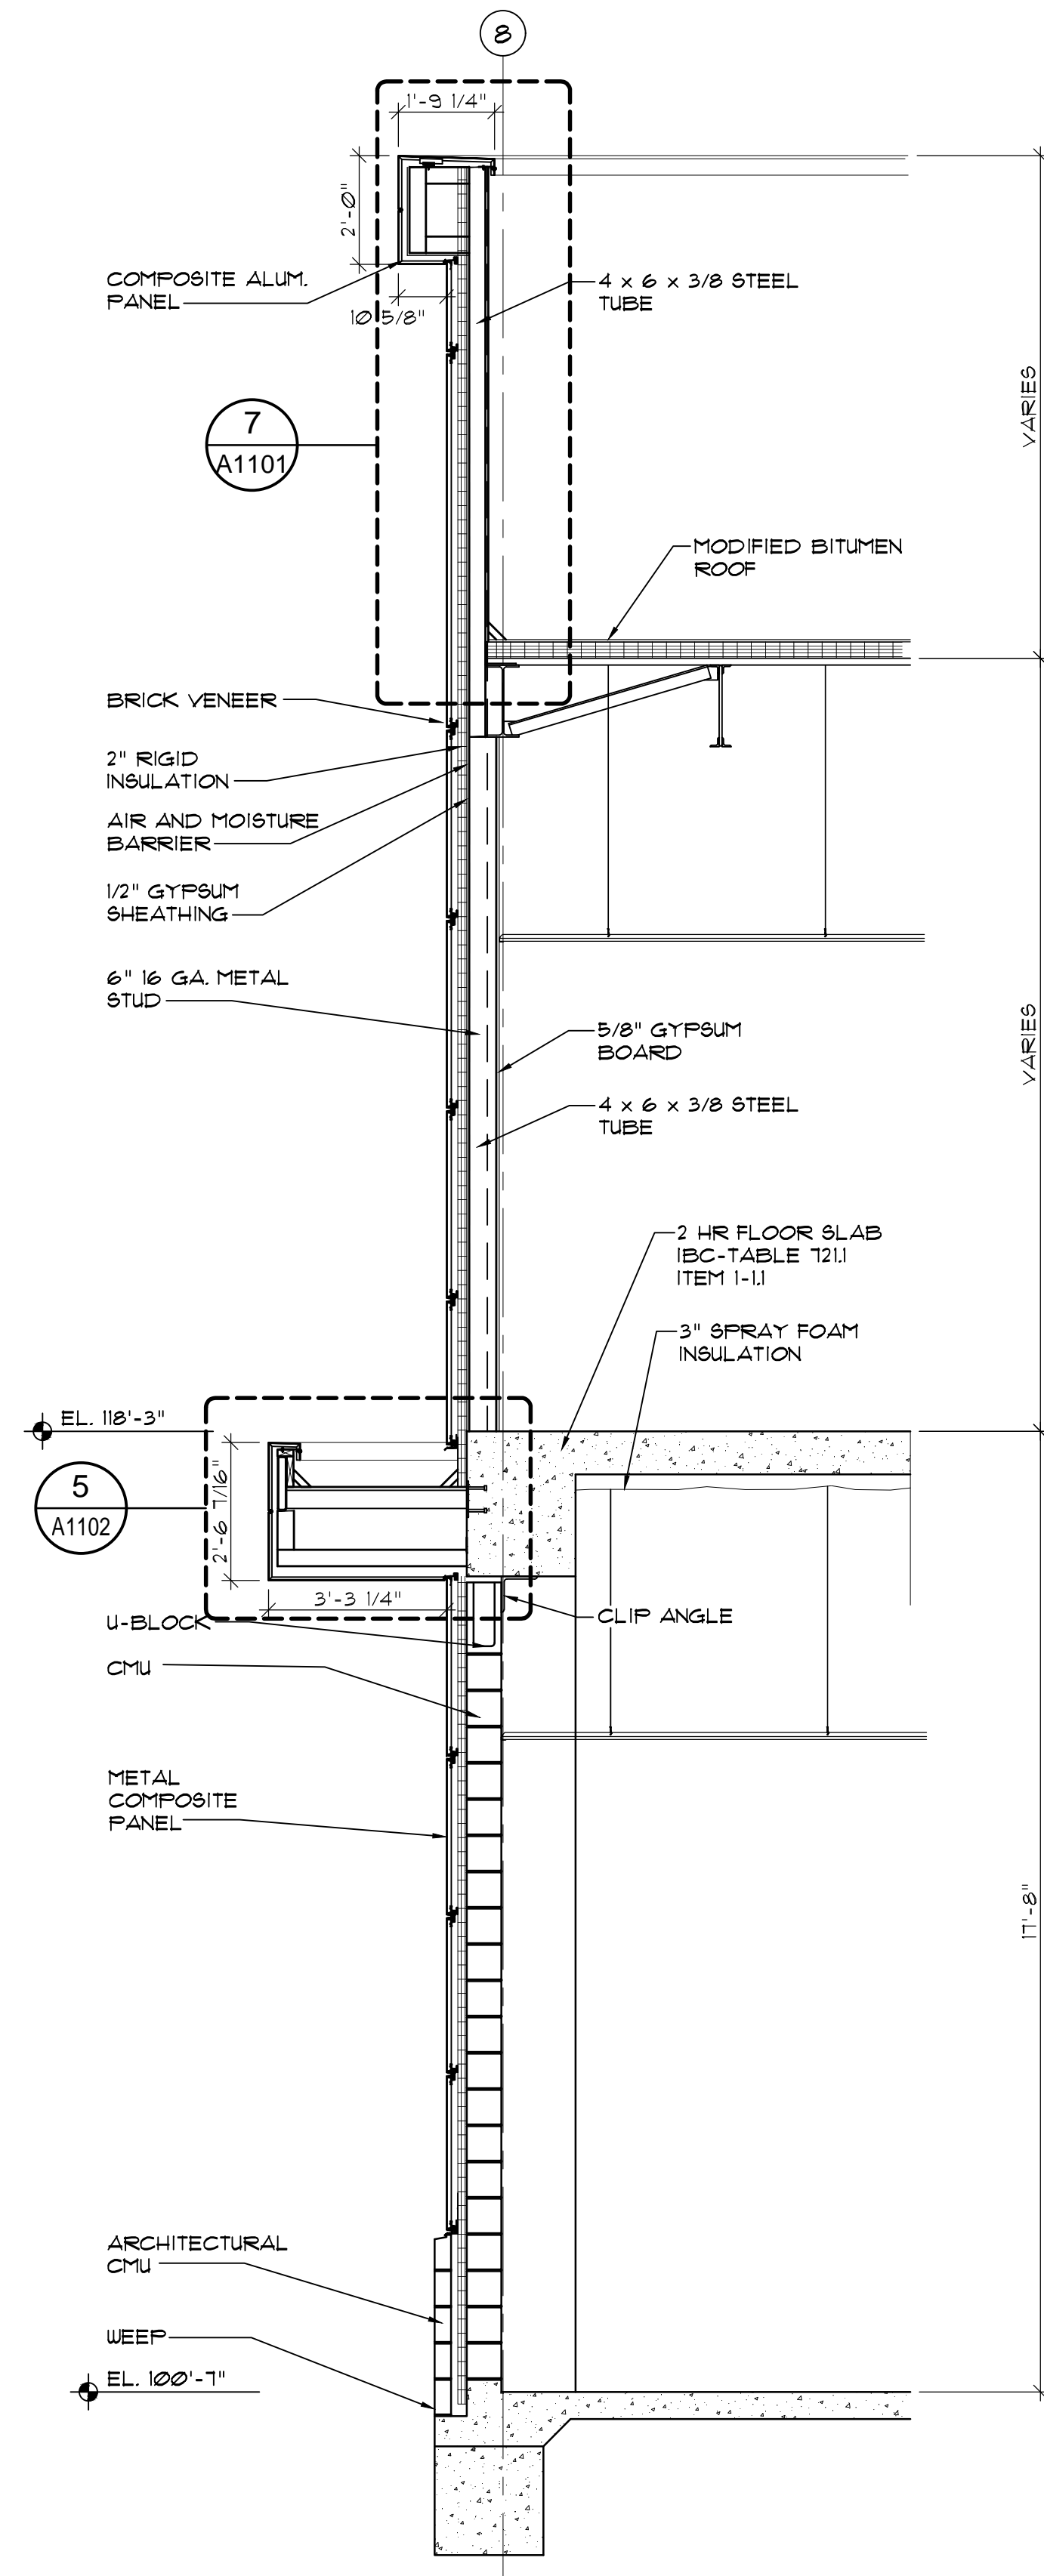

3 WALL SECTION
 A603 SCALE: 3/4" = 1'-0"

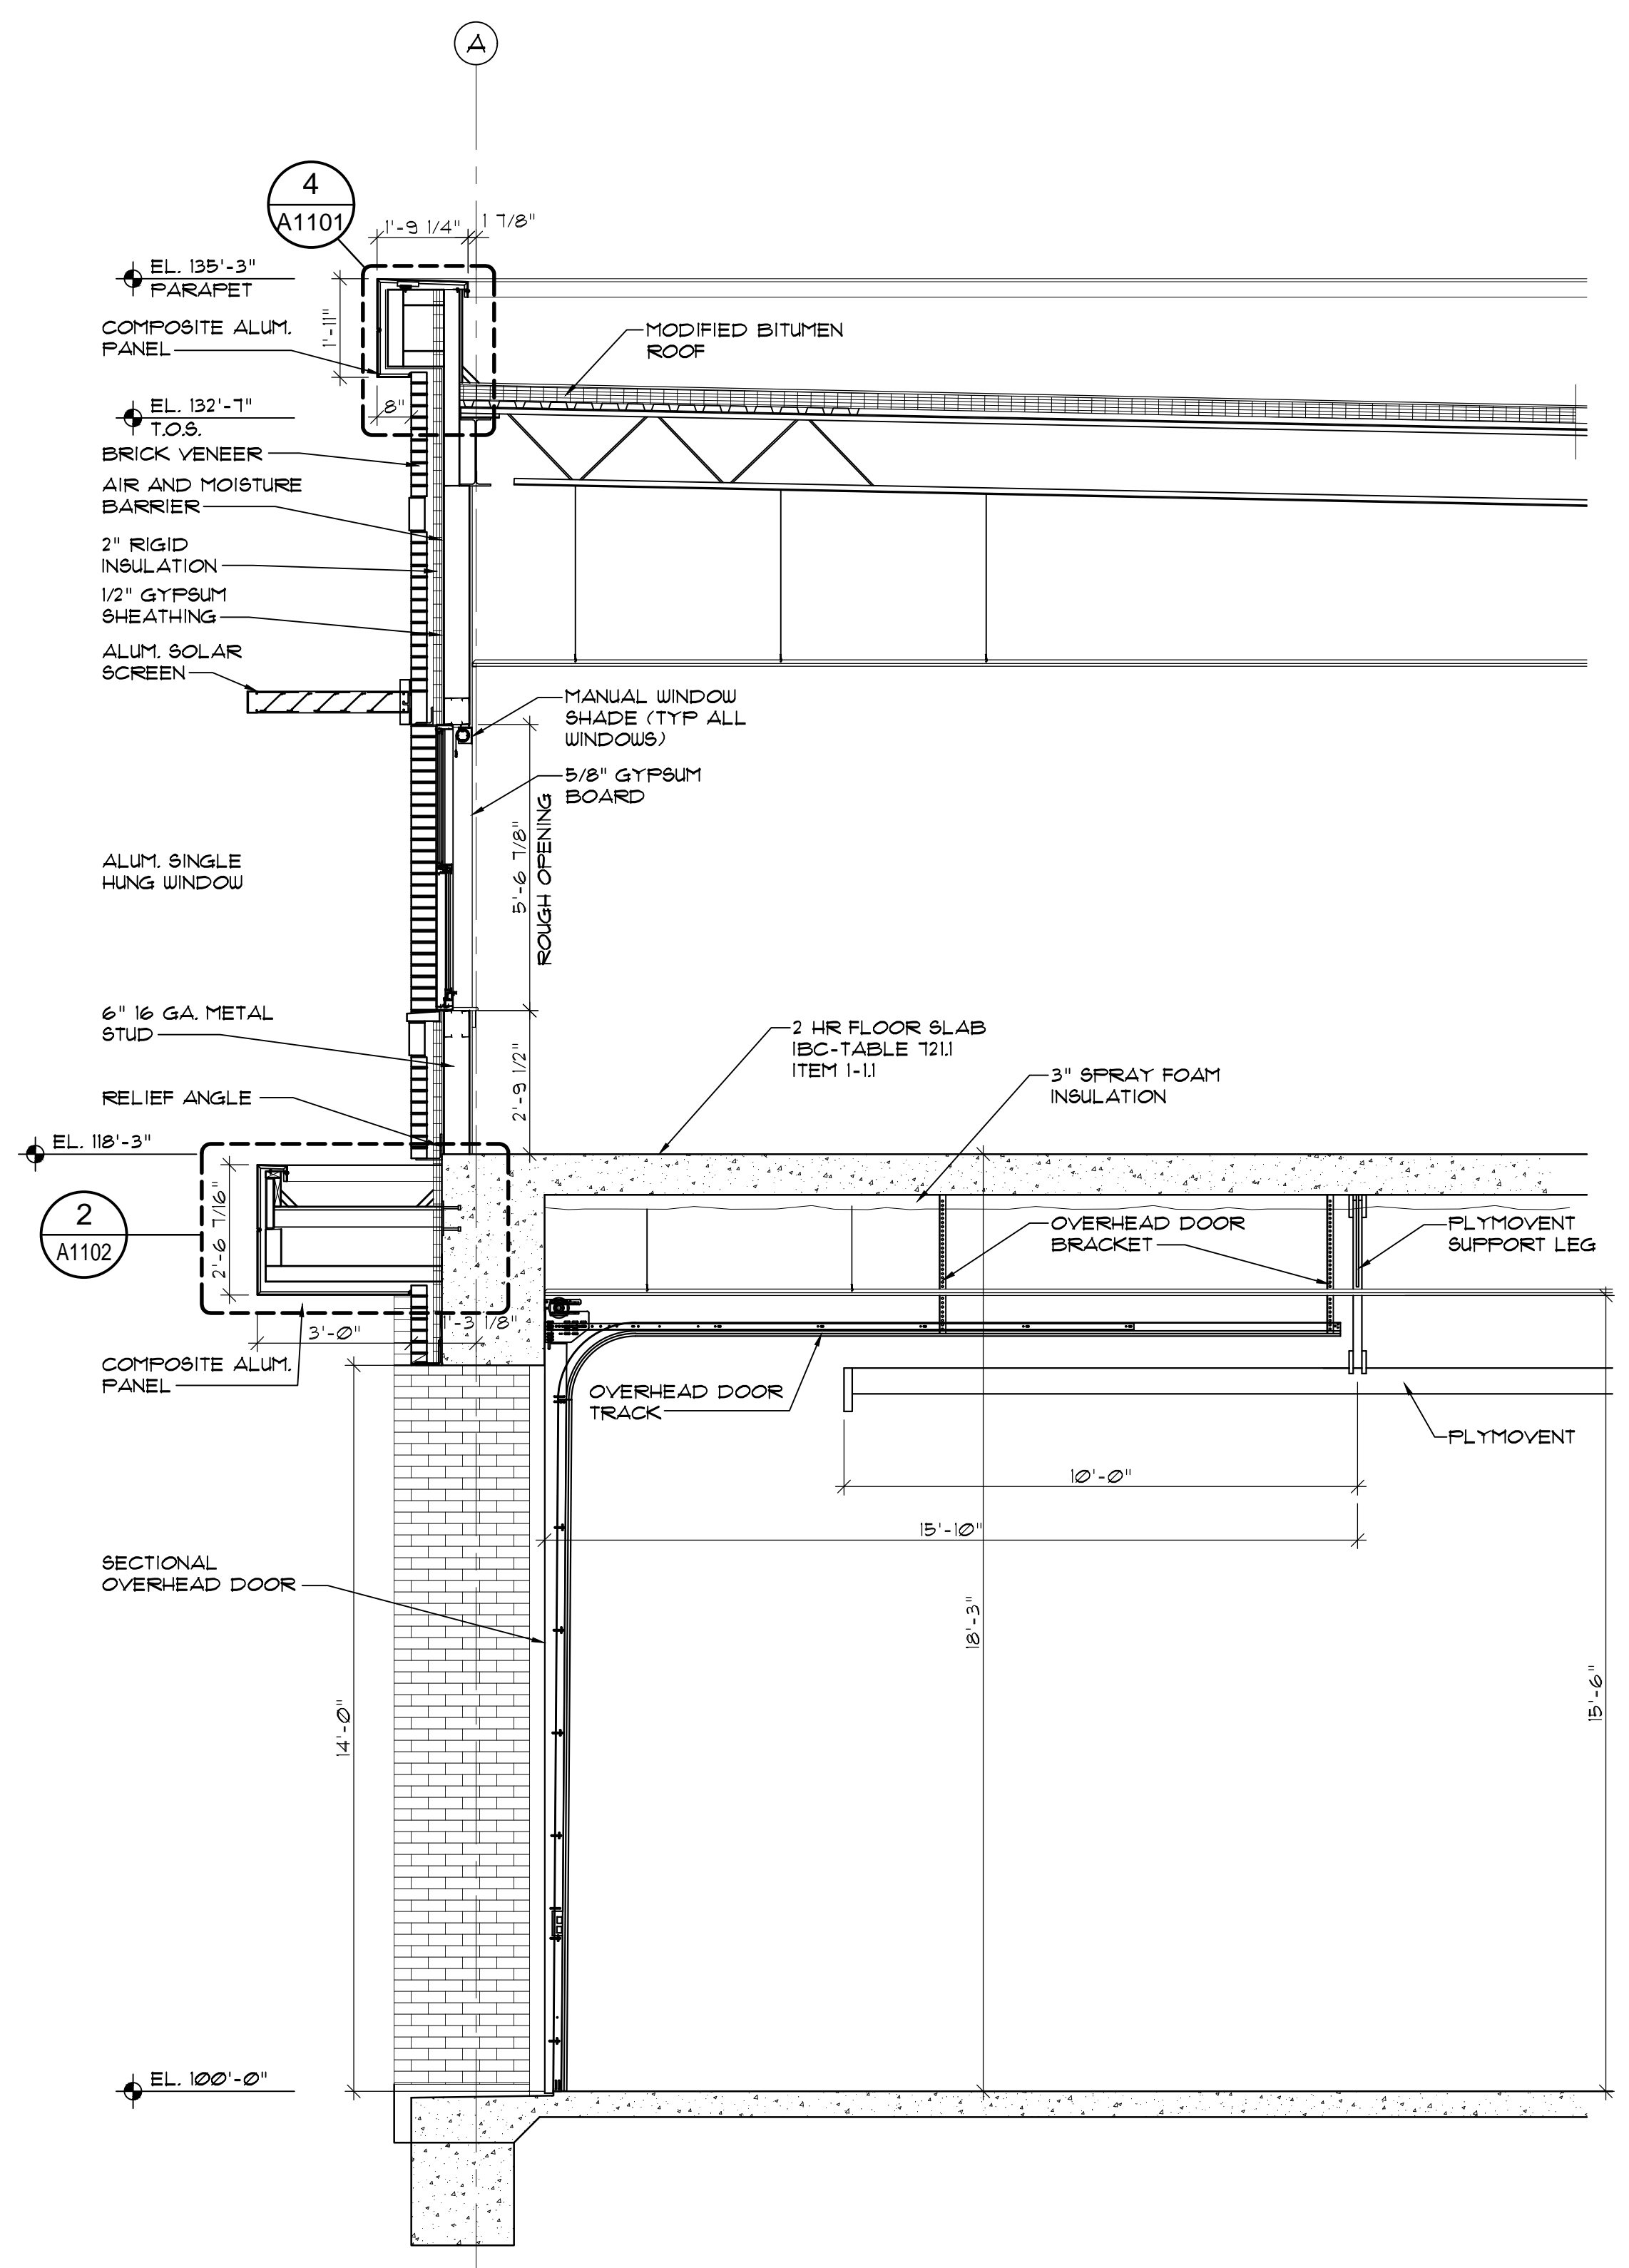

2 WALL SECTION
 A603 SCALE: 3/4" = 1'-0"

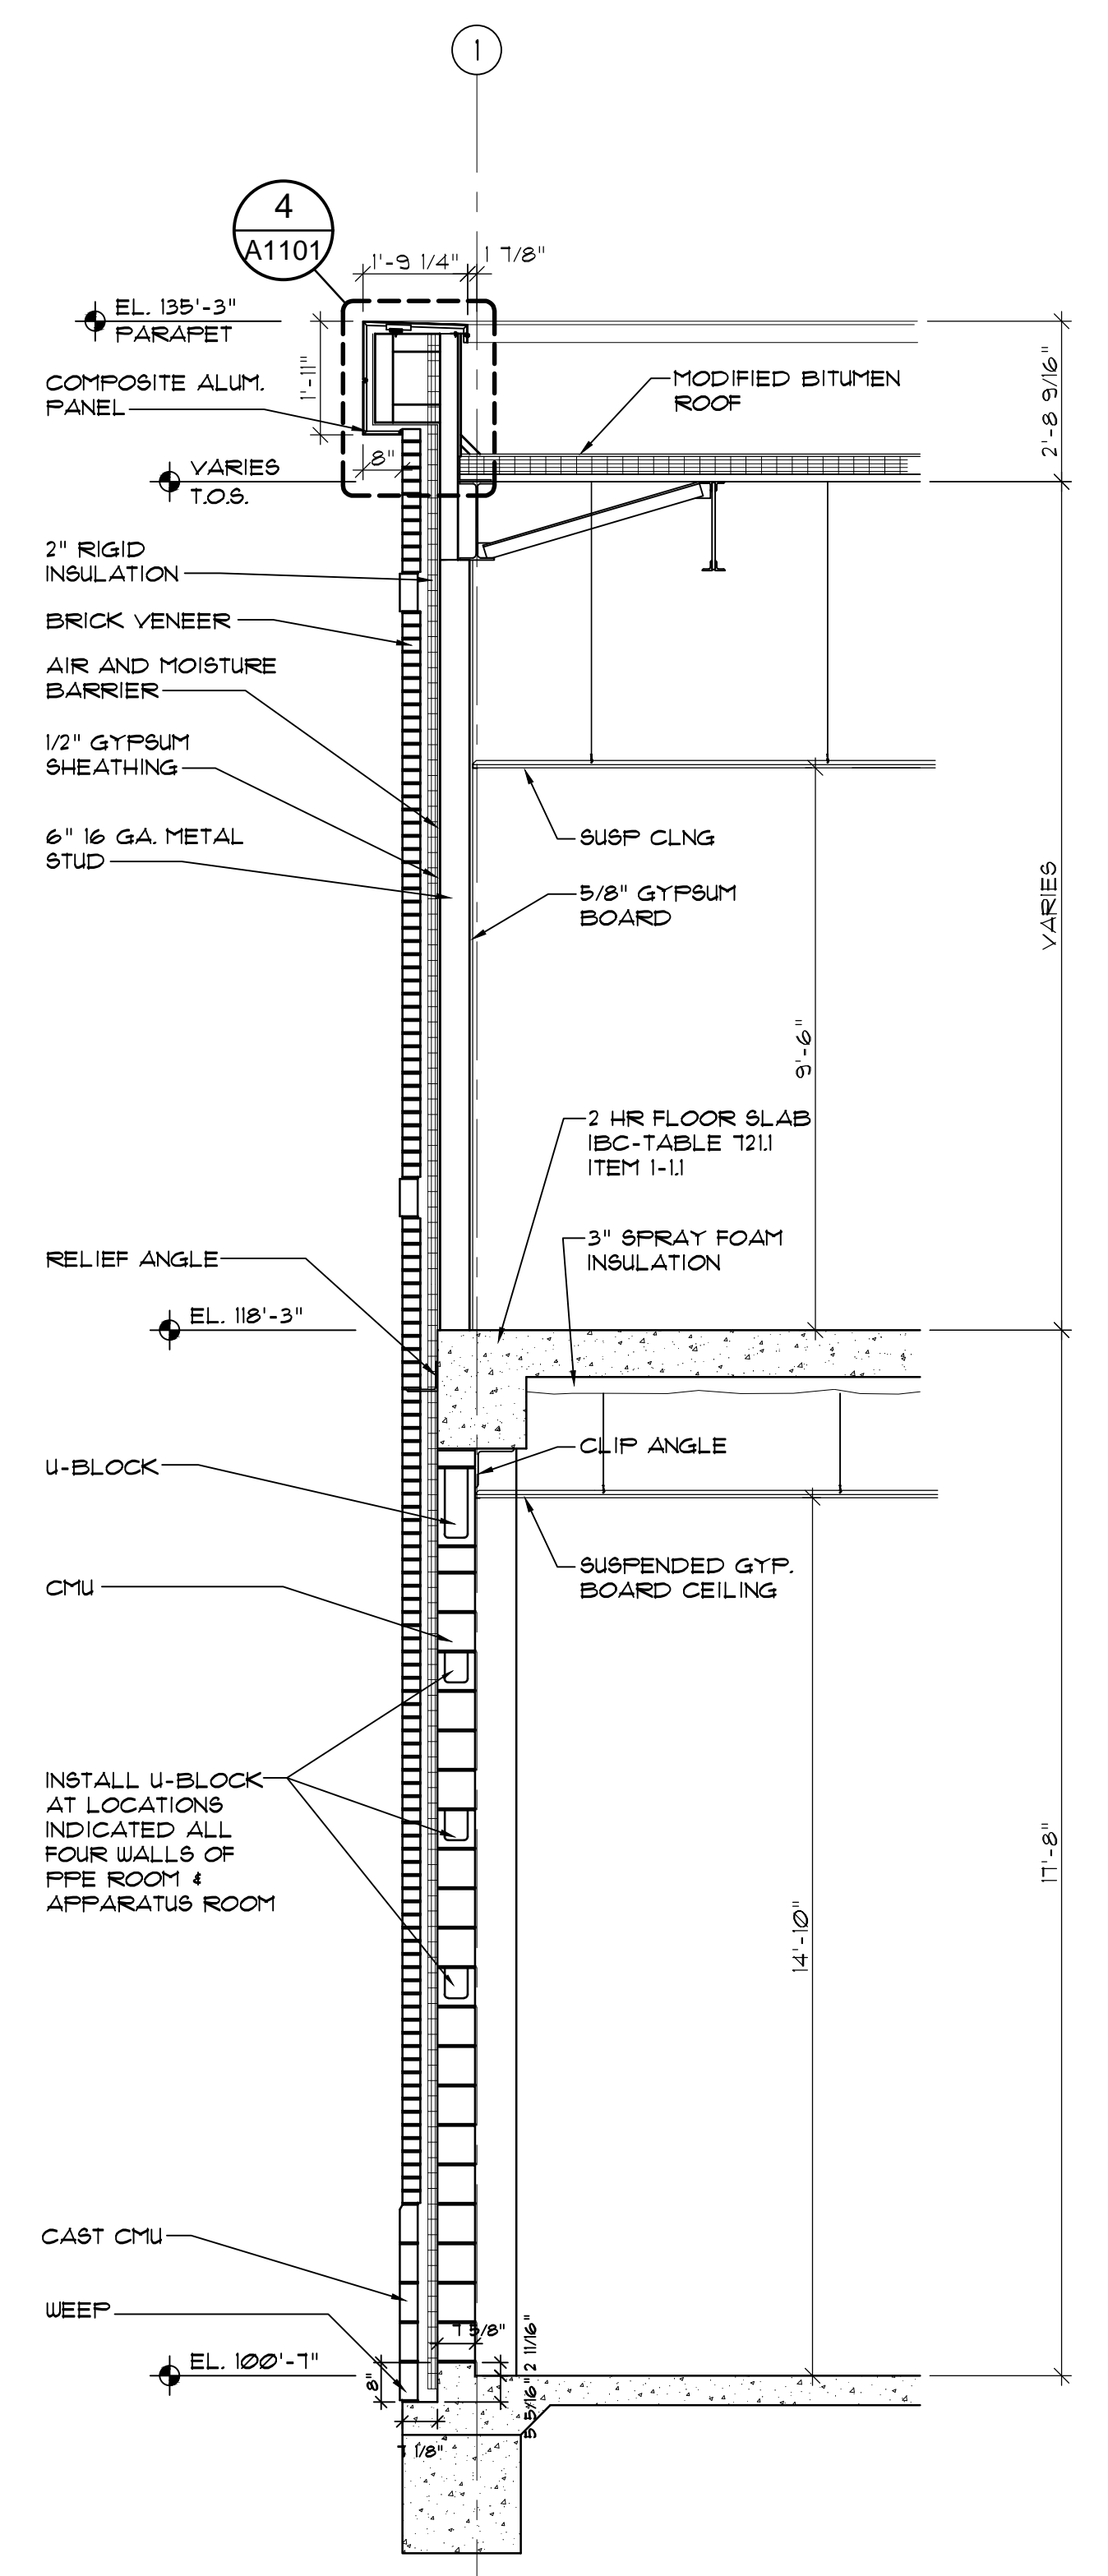

1 WALL SECTION
 A603 SCALE: 3/4" = 1'-0"