




ST. TAMMANY PARISH
ADMINISTRATION COMPLEX RENOVATIONS

520 OLD SPANISH TRAIL
SLIDELL, LOUISIANA

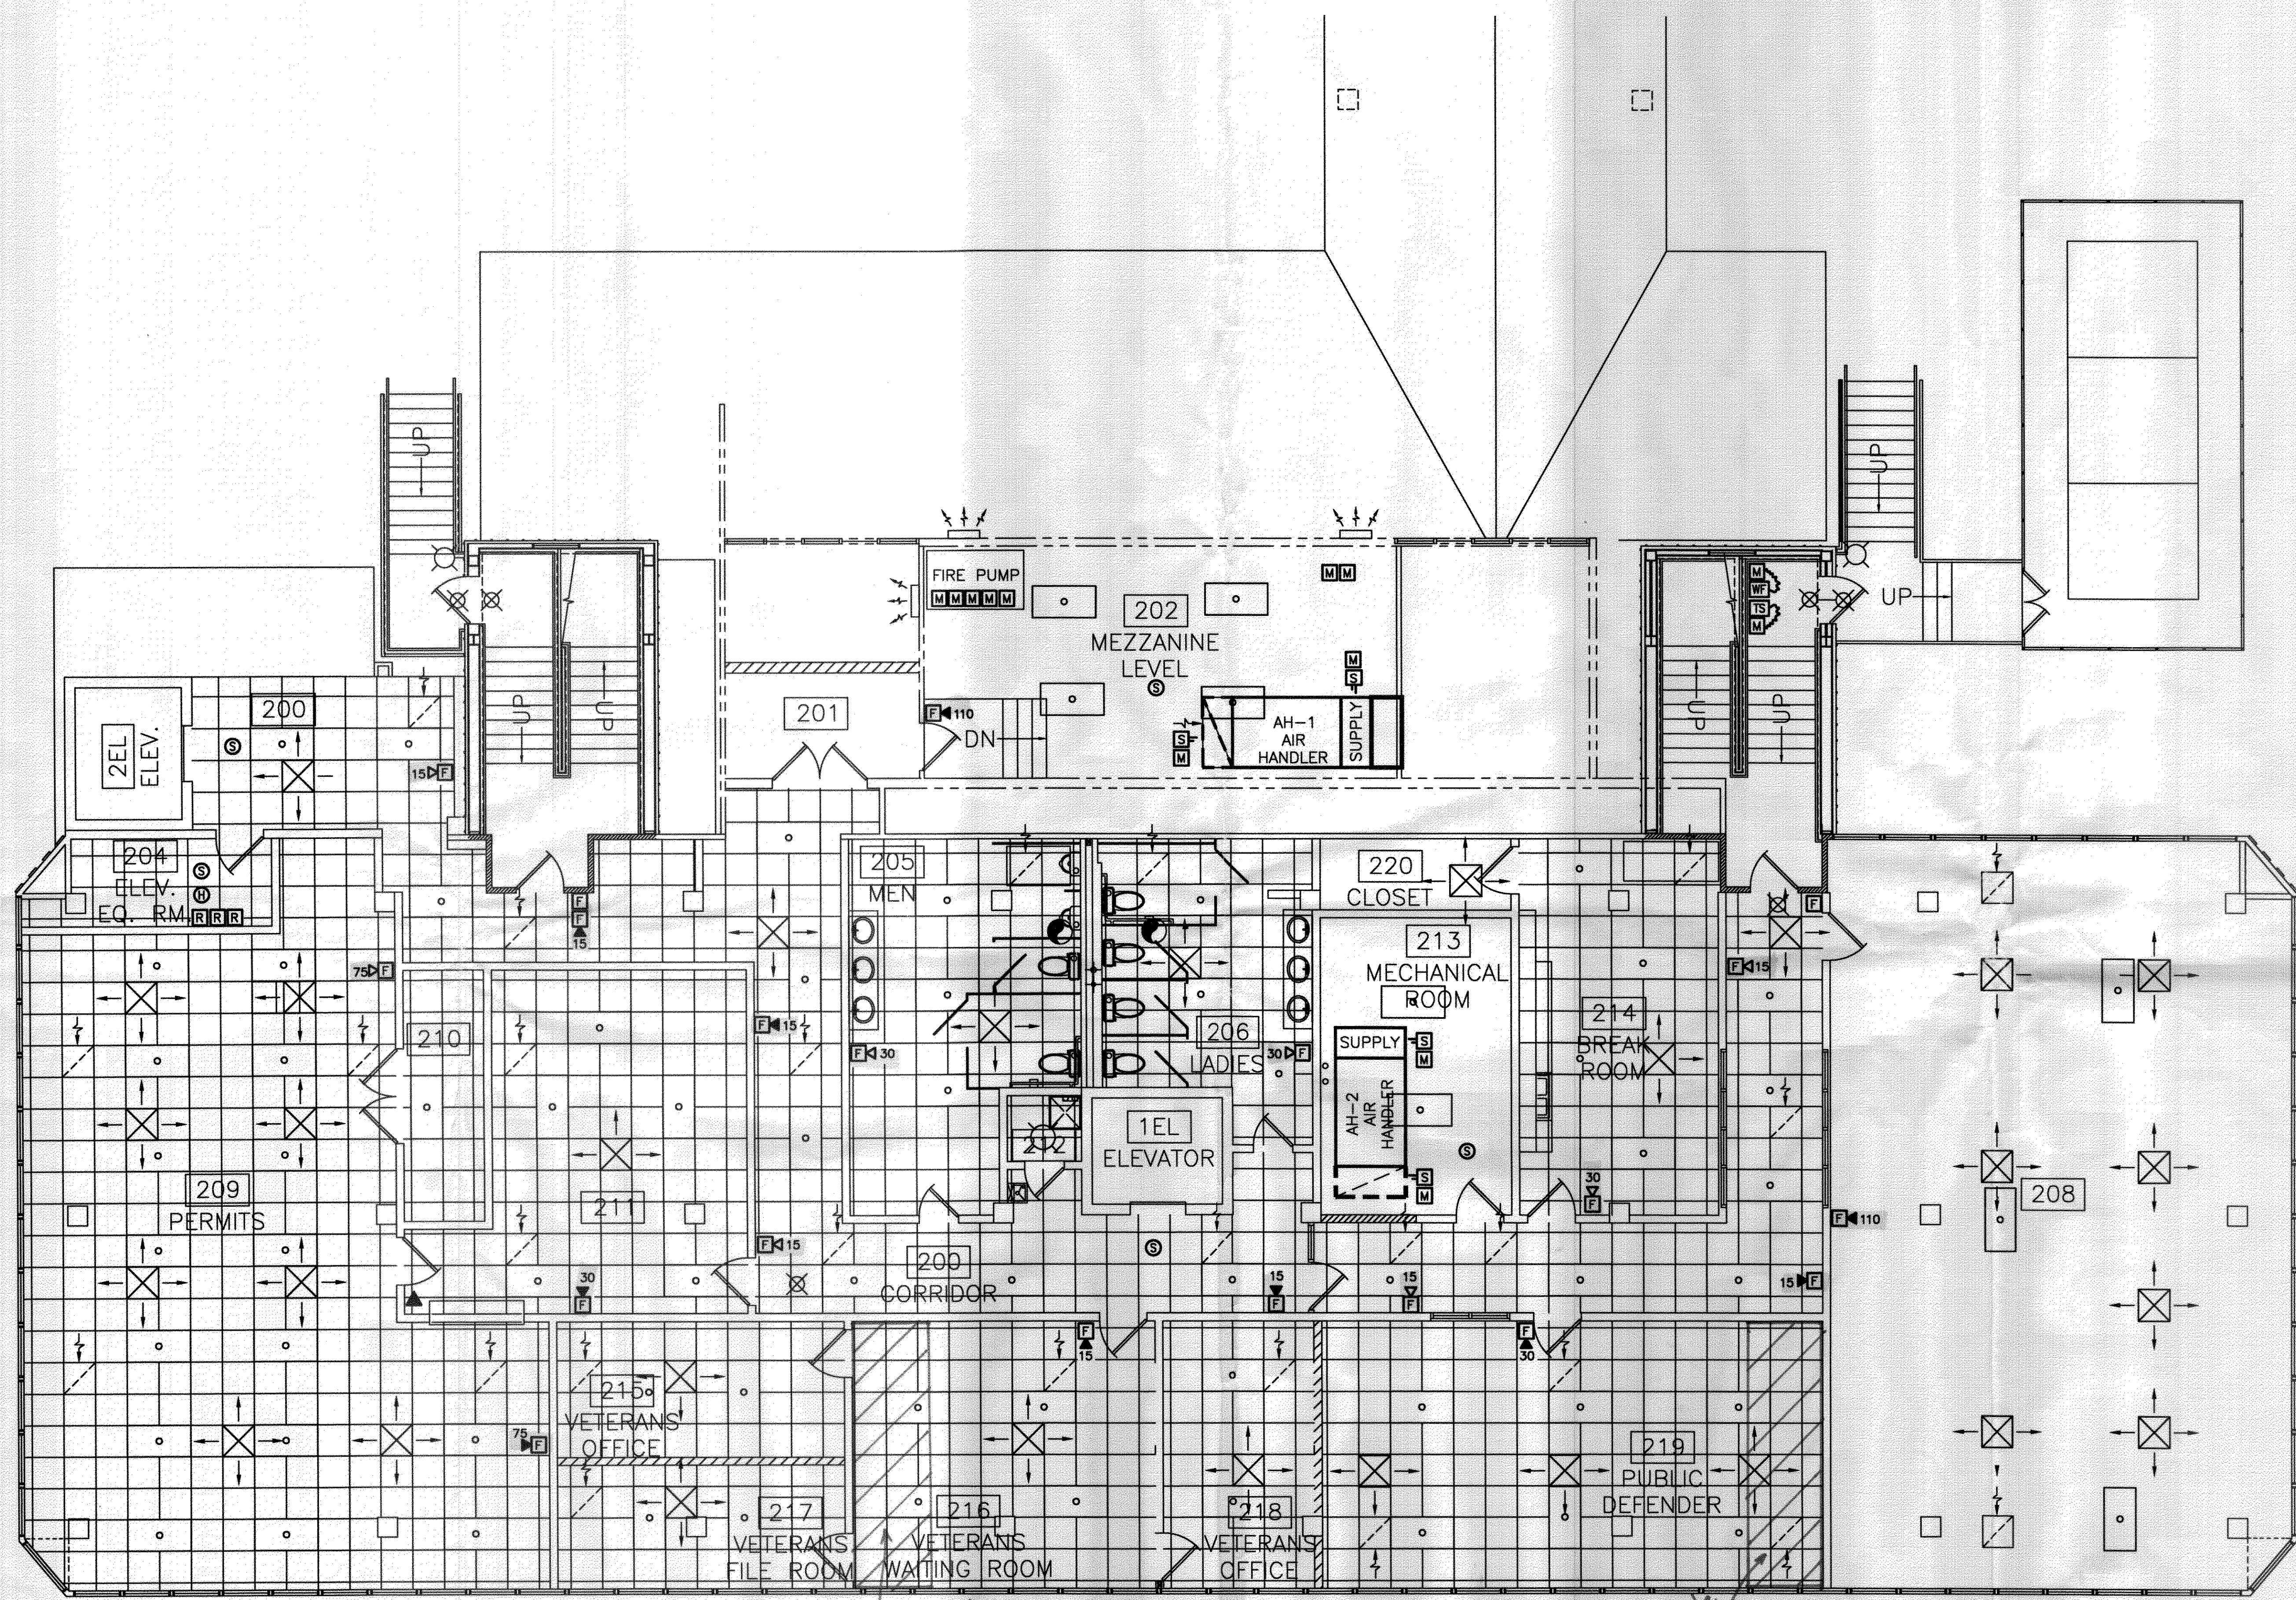

SECOND FLOOR PLAN - FIRE DETECTION AND ALARM SYSTEM
SCALE 3/16" = 1'-0"

NOTE:
FIRE ALARM SYSTEM SMOKE DETECTORS SHALL NOT BE INSTALLED WITHIN 3'-0" FROM AN A.H.U. AIR SUPPLY DIFFUSER OR WITHIN 1'-0" OF A LIGHT FIXTURE.

357110
REVIEWED FOR STATE FIRE MARSHAL AS PER REVIEW LETTER BY: WILLIAM D. JONES, ARCHITECT, CDR
William D. Jones

DESIGNED BY:	FRED FATH
DATE:	OCTOBER 2008
PROJ. NO.:	
SCALE:	3/16"=1'-0"