

DESIGNATOR	ITEM NAME/TYPE	SIZE	LOCATION COORDINATES	
			NORTH ±	EAST ±
	SEPTIC TANK	1,000 GAL	N250.472	E248.686
	C.O. NO. 1	6"	N250.474	E248.682
	C.O. 2A		N252.990	E248.860
	C.O. 2B		N251.784	E248.896
	C.O. 2C		N251.748	E249.100
	C.O. 2D		N251.700	E249.040
	C.O. 2E		N251.640	E249.004
	C.O. 2F		N251.628	E248.776
	C.O. 2G		N251.692	E248.776
	MH-A14	MANHOLE	N252.844	E248.860
	MH-A15	MANHOLE	N252.508	E248.860
	MH-A16	MANHOLE	N252.160	E248.860
	MH-A17	MANHOLE	N251.692	E248.860

LEGEND

C.P.S. - CATHODIC PROTECTION SERVICE

--- DRAWING INTERFACE

--- DRAWING NUMBER

M.H. - MANHOLE


P.I. - POINT OF INTERSECTION

COPIED CEF
DATE: 1-30-05
"VERIFY THAT THIS IS THE CORRECT VERSION BEFORE USE"

REV	DATE	DESCRIPTION
09	11/10/03	ADMIN CHANGE TO RELOCATE SEWERAGE LIFT STATION NO. 65
10	12/2/04	ADMIN CHANGE TO MAKE FORMAT COMPATIBLE WITH WINDCHILL T.L.M. 12/2/04
11	3/27/03	IN CORP SWR-90ABT1500 DWG CI. SEE HISTORY FOR PREVIOUS REVISION.

SYMBOL	DESCRIPTION	DATE	APPROVED
△	MANHOLE	3/27/03	AL. CLARKE
□	POINT OF INTERSECTION	3/27/03	AL. CLARKE

REV	DATE	DESCRIPTION
31	3/27/03	ISSUED/DEF
32	3/27/03	ISSUED/DEF
33	3/27/03	ISSUED/DEF
34	3/27/03	ISSUED/DEF
35	3/27/03	ISSUED/DEF
36	3/27/03	ISSUED/DEF

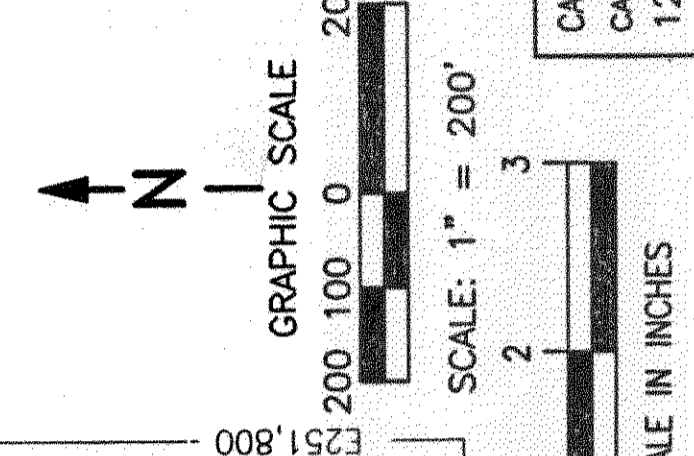

REV	DATE	DESCRIPTION
11B	3-11-06	ISSUED/DEF

ISSUED/DEF 4-2-09 2 REF: M/F-8232

MSS
Mississippi Space Services

SITE PLAN
SANITARY SEWAGE SYSTEM
REF. NO. 2

REV	DATE	DESCRIPTION
1	3-11-06	ISSUED/DEF
2	3-11-06	ISSUED/DEF
3	3-11-06	ISSUED/DEF
4	3-11-06	ISSUED/DEF
5	3-11-06	ISSUED/DEF
6	3-11-06	ISSUED/DEF
7	3-11-06	ISSUED/DEF
8	3-11-06	ISSUED/DEF
9	3-11-06	ISSUED/DEF
10	3-11-06	ISSUED/DEF
11	3-11-06	ISSUED/DEF
12	3-11-06	ISSUED/DEF
13	3-11-06	ISSUED/DEF
14	3-11-06	ISSUED/DEF
15	3-11-06	ISSUED/DEF
16	3-11-06	ISSUED/DEF
17	3-11-06	ISSUED/DEF
18	3-11-06	ISSUED/DEF
19	3-11-06	ISSUED/DEF
20	3-11-06	ISSUED/DEF
21	3-11-06	ISSUED/DEF
22	3-11-06	ISSUED/DEF
23	3-11-06	ISSUED/DEF
24	3-11-06	ISSUED/DEF
25	3-11-06	ISSUED/DEF
26	3-11-06	ISSUED/DEF
27	3-11-06	ISSUED/DEF
28	3-11-06	ISSUED/DEF
29	3-11-06	ISSUED/DEF
30	3-11-06	ISSUED/DEF

APPROVED
R.G. SMITH
12/20/001

CADD P/N:
12F00-R002SH111B

SCALE: 1" = 200'

GRAPHIC SCALE IN INCHES

GRAPHIC SCALE

GRAPHIC SCALE IN INCHES

GRAPHIC SCALE

GRAPHIC SCALE IN INCHES

GRAPHIC SCALE

GRAPHIC SCALE IN INCHES

GRAPHIC SCALE

GRAPHIC SCALE IN INCHES

GRAPHIC SCALE