

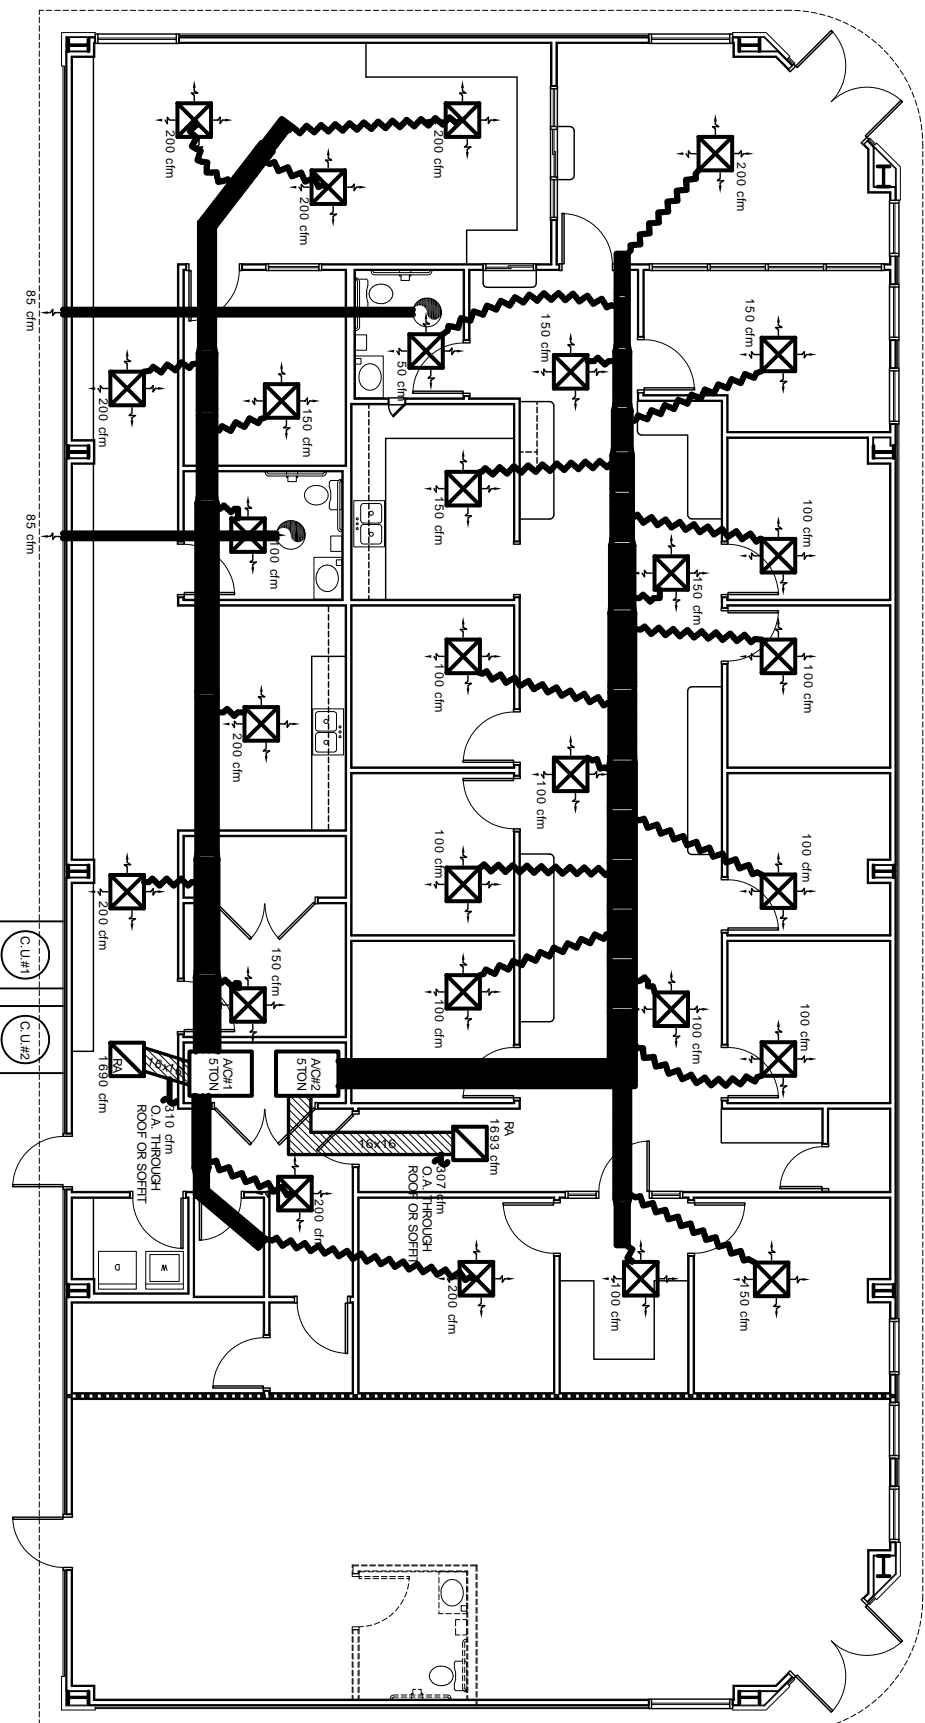



NOT FOR CONSTRUCTION

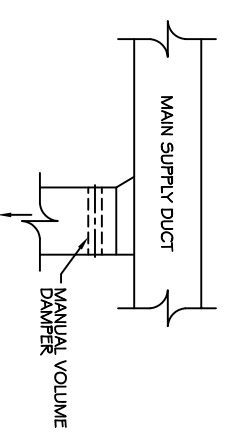


MECHANICAL PLAN
SCALE 3/16" = 1'

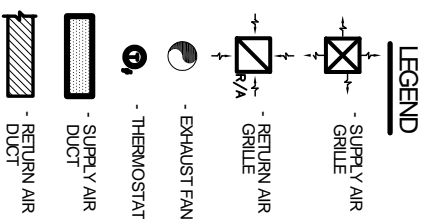


SUPPLY DUCT TAKE-OFF DETAIL
N.T.S.

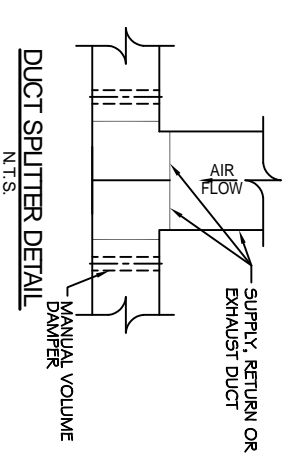


DUCT SPLITTER DETAIL
N.T.S.

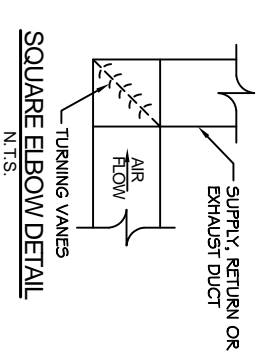


SQUARE ELBOW DETAIL
N.T.S.

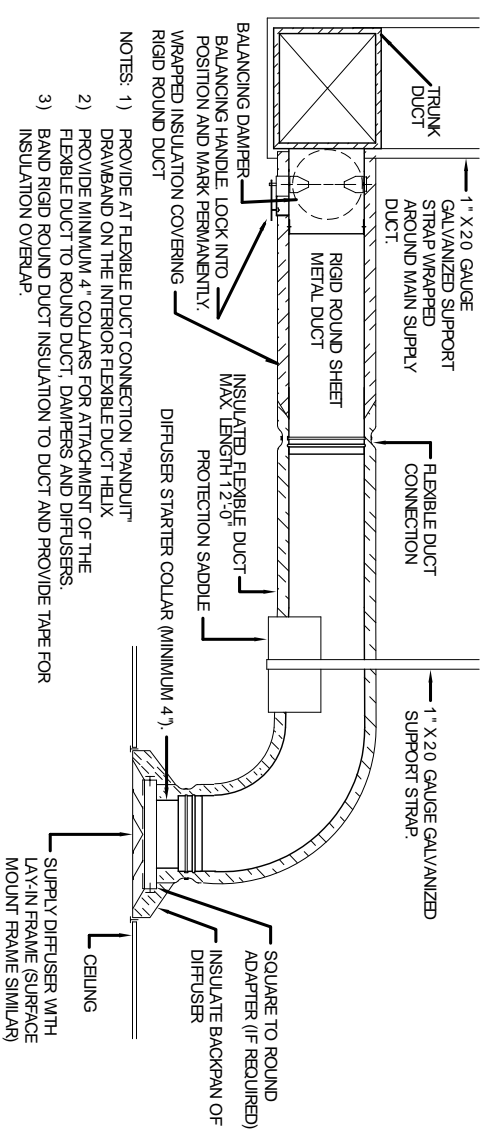


DIFFUSER CONNECTION DETAIL-FLEX DUCT
N.T.S.

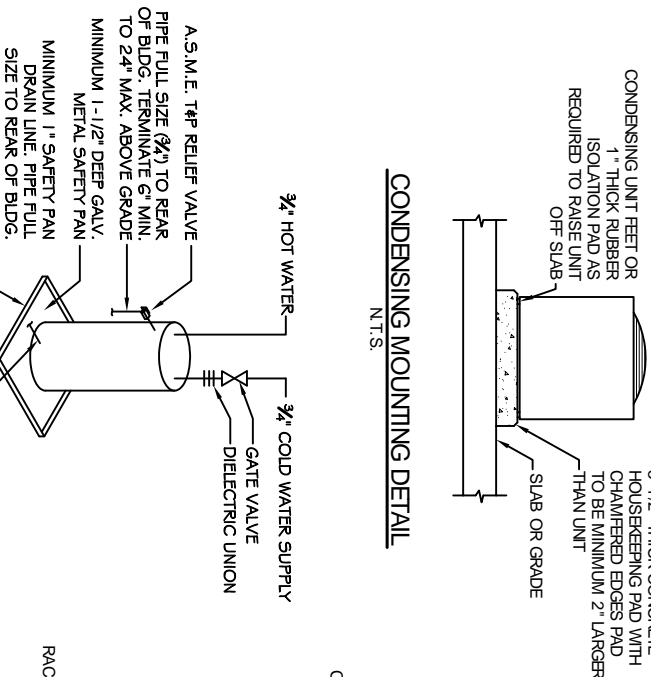


CONDENSING MOUNTING DETAIL
N.T.S.

 

TYPICAL WATER HEATER
N.T.S.

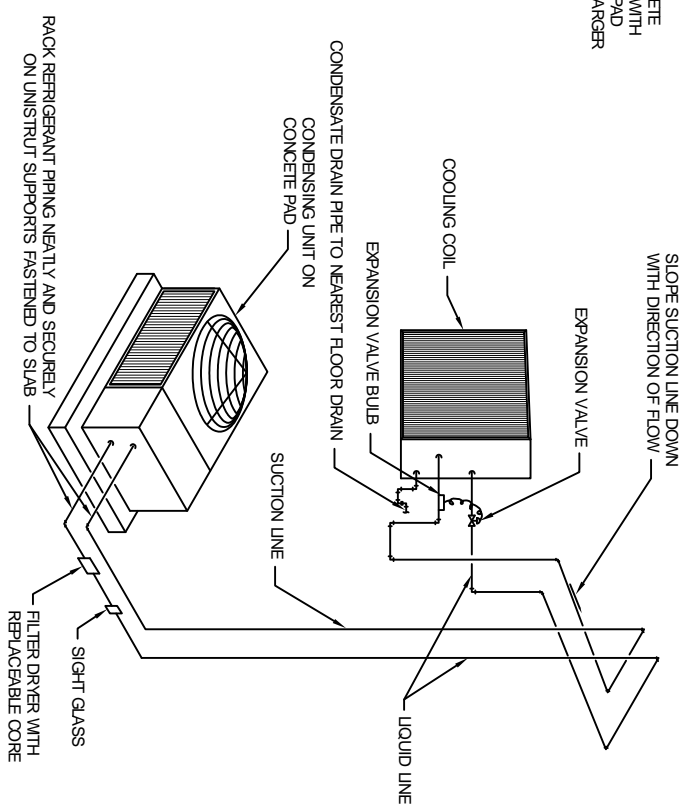

REFRIGERANT PIPING DIAGRAM
N.T.S.

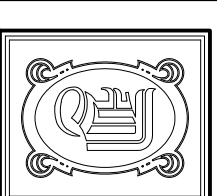

DAMMON ENGINEERING, INC.

CHIEF ENGINEER
EMMETT DAMMON, P.E.
CHIEF ARCHITECT
ROBERT WILTSE

1095 FLORIDA AVENUE
SUDELL, LA. 70456
OFFICE: 985-649-5832
FAX: 985-641-5950

WEBSITE: WWW.DAMMONENGINEERING.COM
EMAIL: DAMMONENG@BELLSouth.NET

ARCHITECTURE
ENGINEERING
STUDIES
PLANNING
INVESTIGATION
EXPERT WITNESSES

DR. EDUARDO
HERNANDEZ
HAMMOND
LOUISIANA

CHILDRENS
INTERNATIONAL
MEDICAL
GROUP
CIMG

MECHANICAL
PLAN

REV:	
SCALE:	AS NOTED
JOB#:	2042
DATE:	10-29-09
SHEET:	