 

 


FIELD VERIFY EXISTING A/C  
CONDENSING UNITS & AHUS  
(SIZES) THAT SUPPLY THE NEWLY  
RENOVATED AREA (DENTAL  
OFFICE)

EXISTING  
3 TON

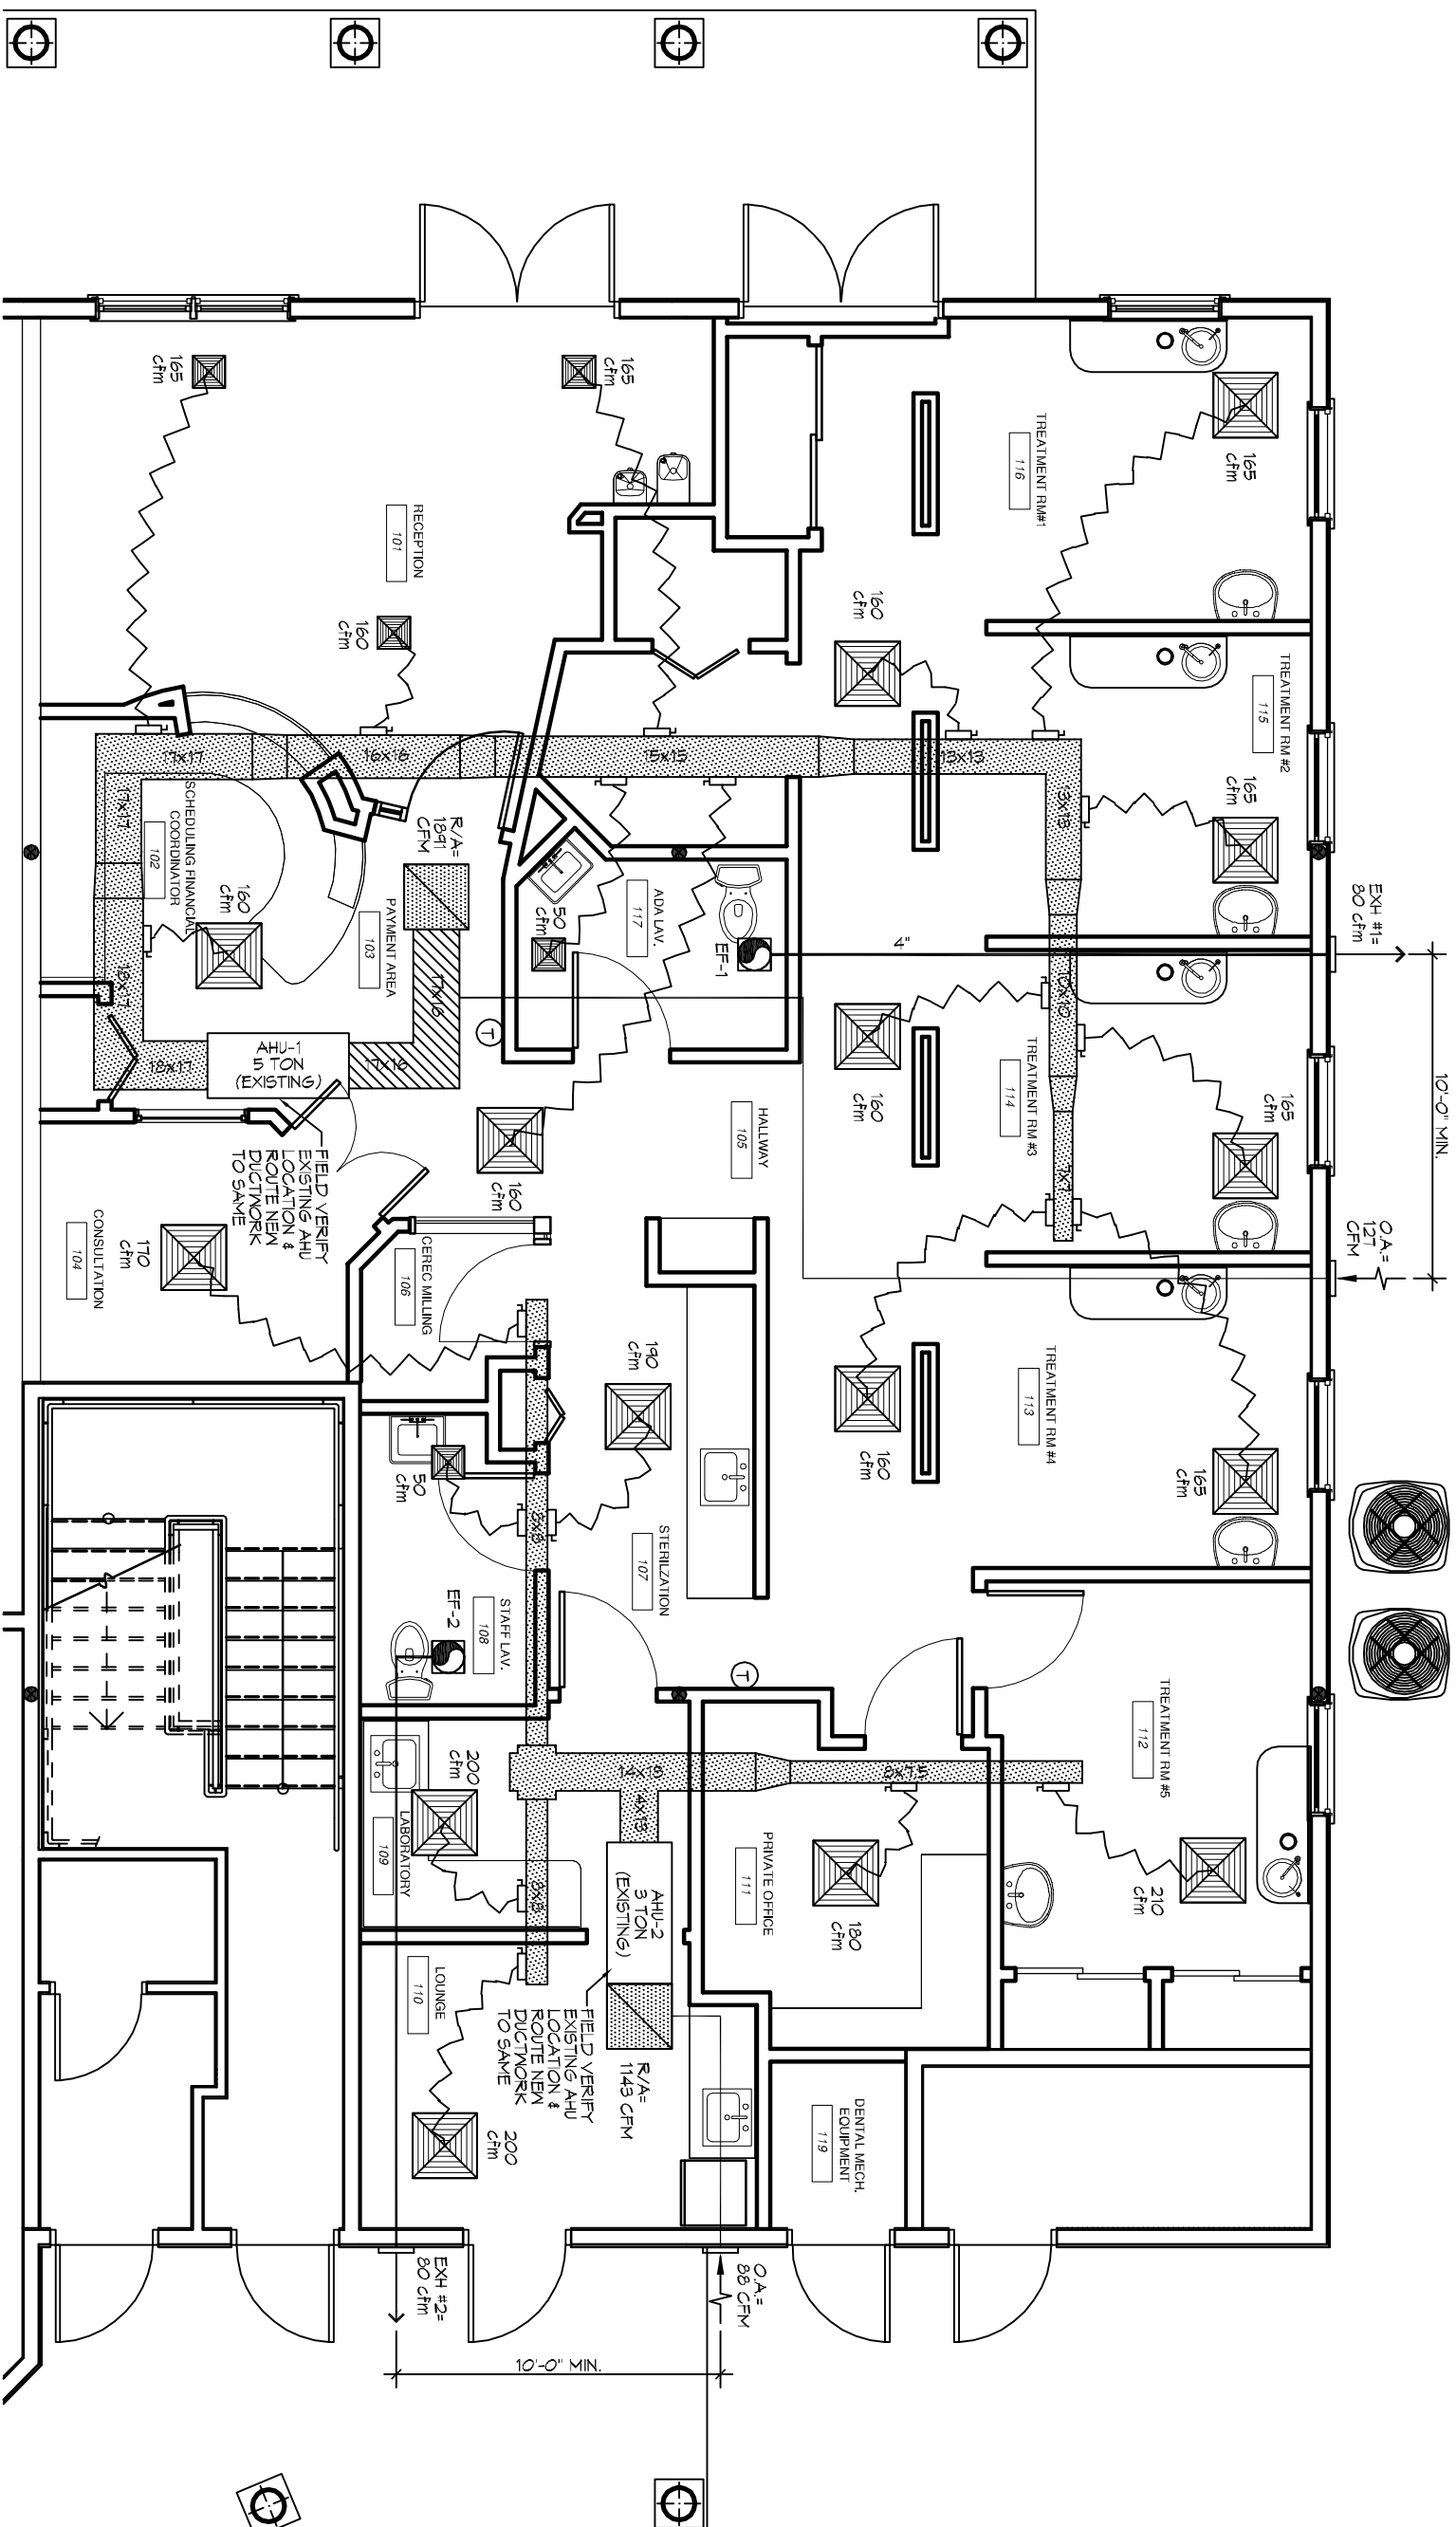

EXISTING  
5 TON



**MECHANICAL PLAN**

SCALE: 1/4" = 1'-0"