



REFLECTED CEILING PLAN
SCALE: 3/16" = 1'-0"

PROGRESS SET


R.C.P. LEGEND	
	CEILING MOUNTED AIR SUPPLY DIFFUSER
	CEILING MOUNTED EXHAUST FAN
	CEILING MOUNTED "J" BOX
	SURFACE MOUNTED FIXTURE
	RECESSED FIXTURE
	VAPOR PROOF RECESSED CAN LIGHT
	FLUORESCENT LIGHT
	WALL MOUNTED FIXTURE
	CEILING MOUNTED 1 x 4 FLUORESCENT LIGHT
	RECESSED 2 x 4 & 2 x 2 FLUORESCENT LIGHT
	CEILING MOUNTED FIRE SPRINKLER
	WALL MOUNTED FIRE SPRINKLER
	2 x 2 SUSPENDED ACOUSTIC CEILING TILE AND GRID
	G.W.B. FINISH
	EXIT SIGN WITH BATTERY PACK
	EMERGENCY LIGHTS WITH BATTERY PACK

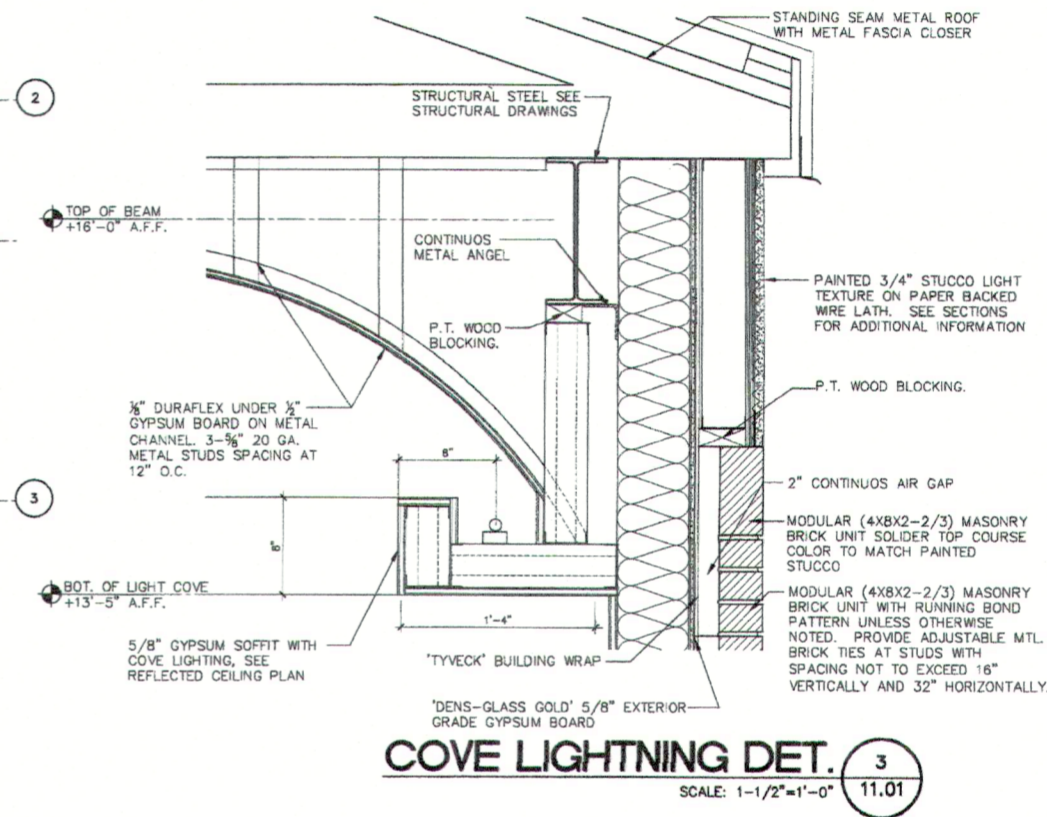

COVE LIGHTING DET. 3
SCALE: 1-1/2" = 1'-0"

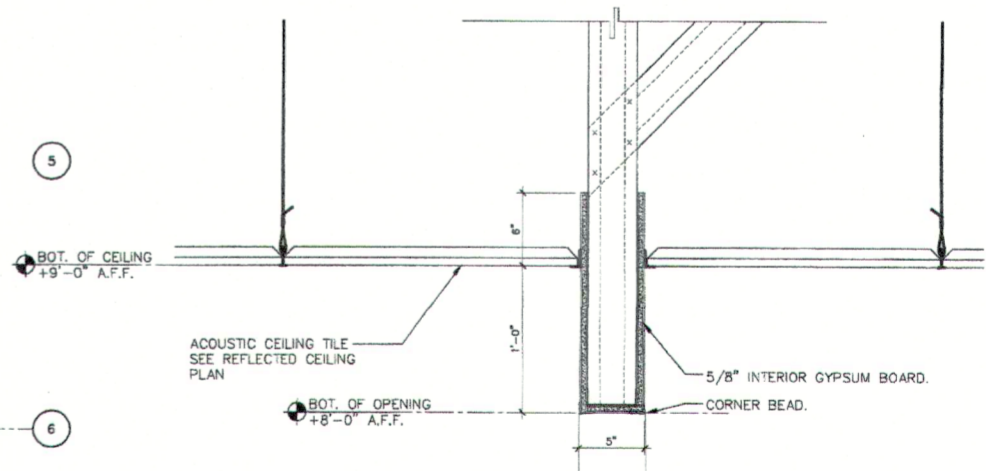

BULKHEAD DETAIL 2
SCALE: 1-1/2" = 1'-0"

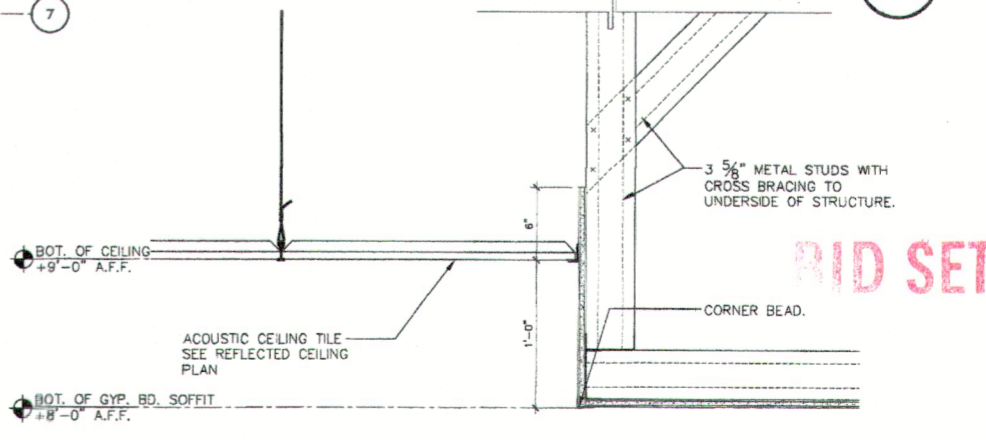

TRANSITION DETAIL 1
SCALE: 1-1/2" = 1'-0"

PROJECT NO. 111 SHEET NO. 111 DATE 11/11/01	
PROJECT FOR SATNOH, LLC 130 W. RUELE MANDEVILLE, LA 70471	
STATE REG. # 5780 GARCIA BRENNER STROMBERG ARCHITECTS 751 Park of Commerce Drive, Suite 118 Metairie, Louisiana 70002 (504) 885-8888 www.gb-st.com	
REFLECTED CEILING PLAN TULANE / HONTAS MEDICAL CENTER	
PROJECT NO.	111
SHEET NO.	A-11.01
DATE	11/11/01