



NOTE:
ALL EXTERIOR LIGHTS SHALL
HAVE A 90 MINUTE BACK-UP

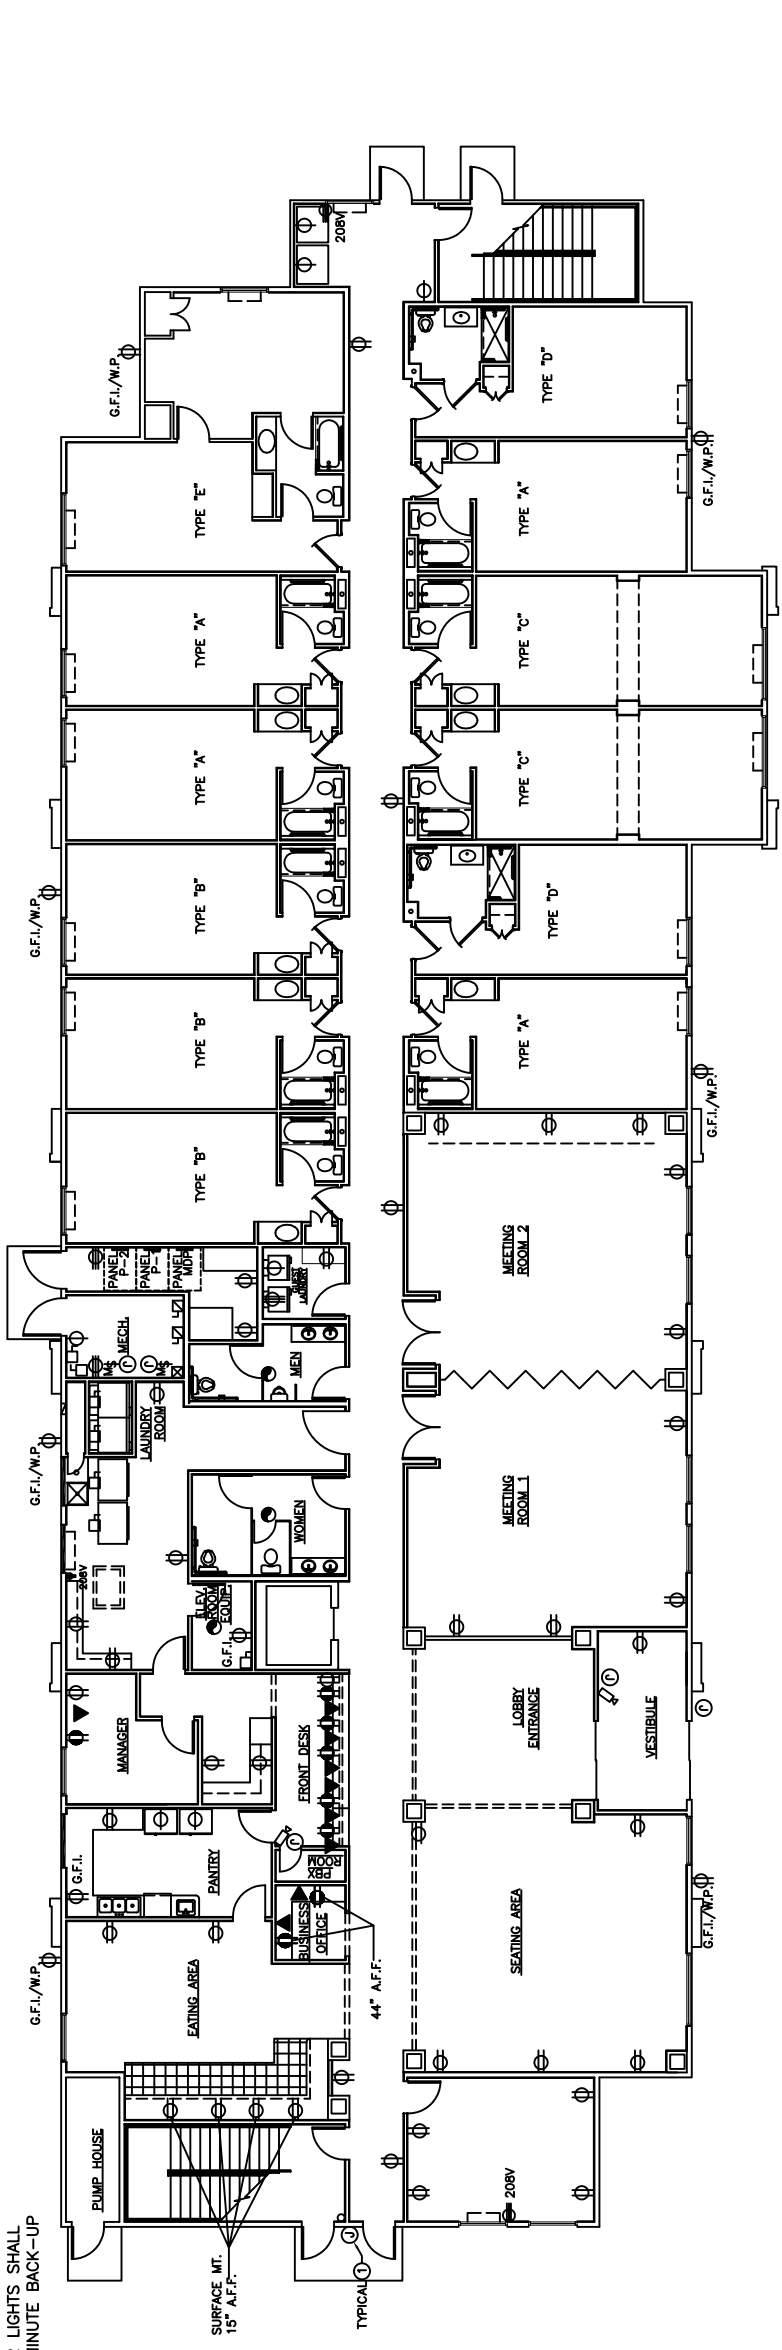

FIRST FLOOR POWER PLAN
SCALE: 1/8"=1'-0"

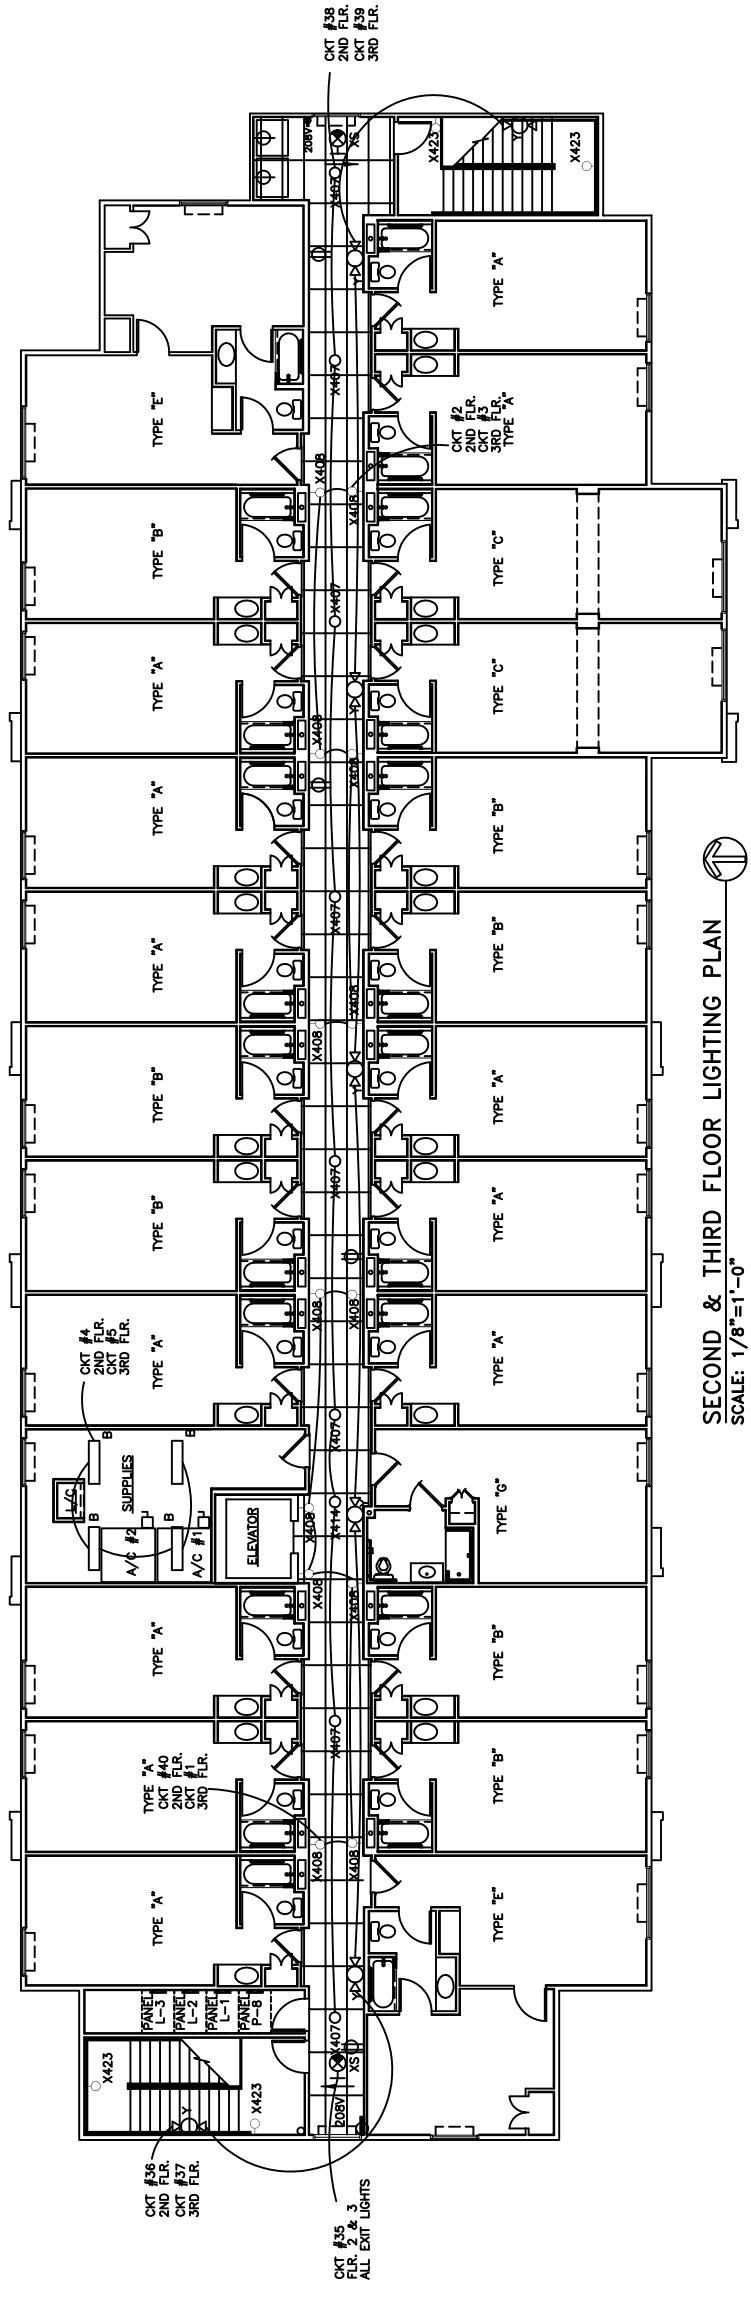

SECOND & THIRD FLOOR LIGHTING PLAN
SCALE: 1/8"=1'-0"

FIRST FLR PWR/SECD-THRD FLR ELECT

LA QUINTA INN & SUITES #12
HOLIDAY BOULEVARD
SLIDELL, LOUISIANA

LA QUINTA INN & SUITES #12
DAMMON ENGINEERING, INC.
1095 FLORIDA AVENUE 985-649-8832 SLIDELL, LA. 70458
DAMMONENGINEERING.COM

SCALE: AS NOTED
FILE:
JOB NO. 1828
DATE: 2-15-07
SHEET 29
E-2
OF 33