


2 GROUND MOUNTED BUILDING LIGHT

NOT TO SCALE

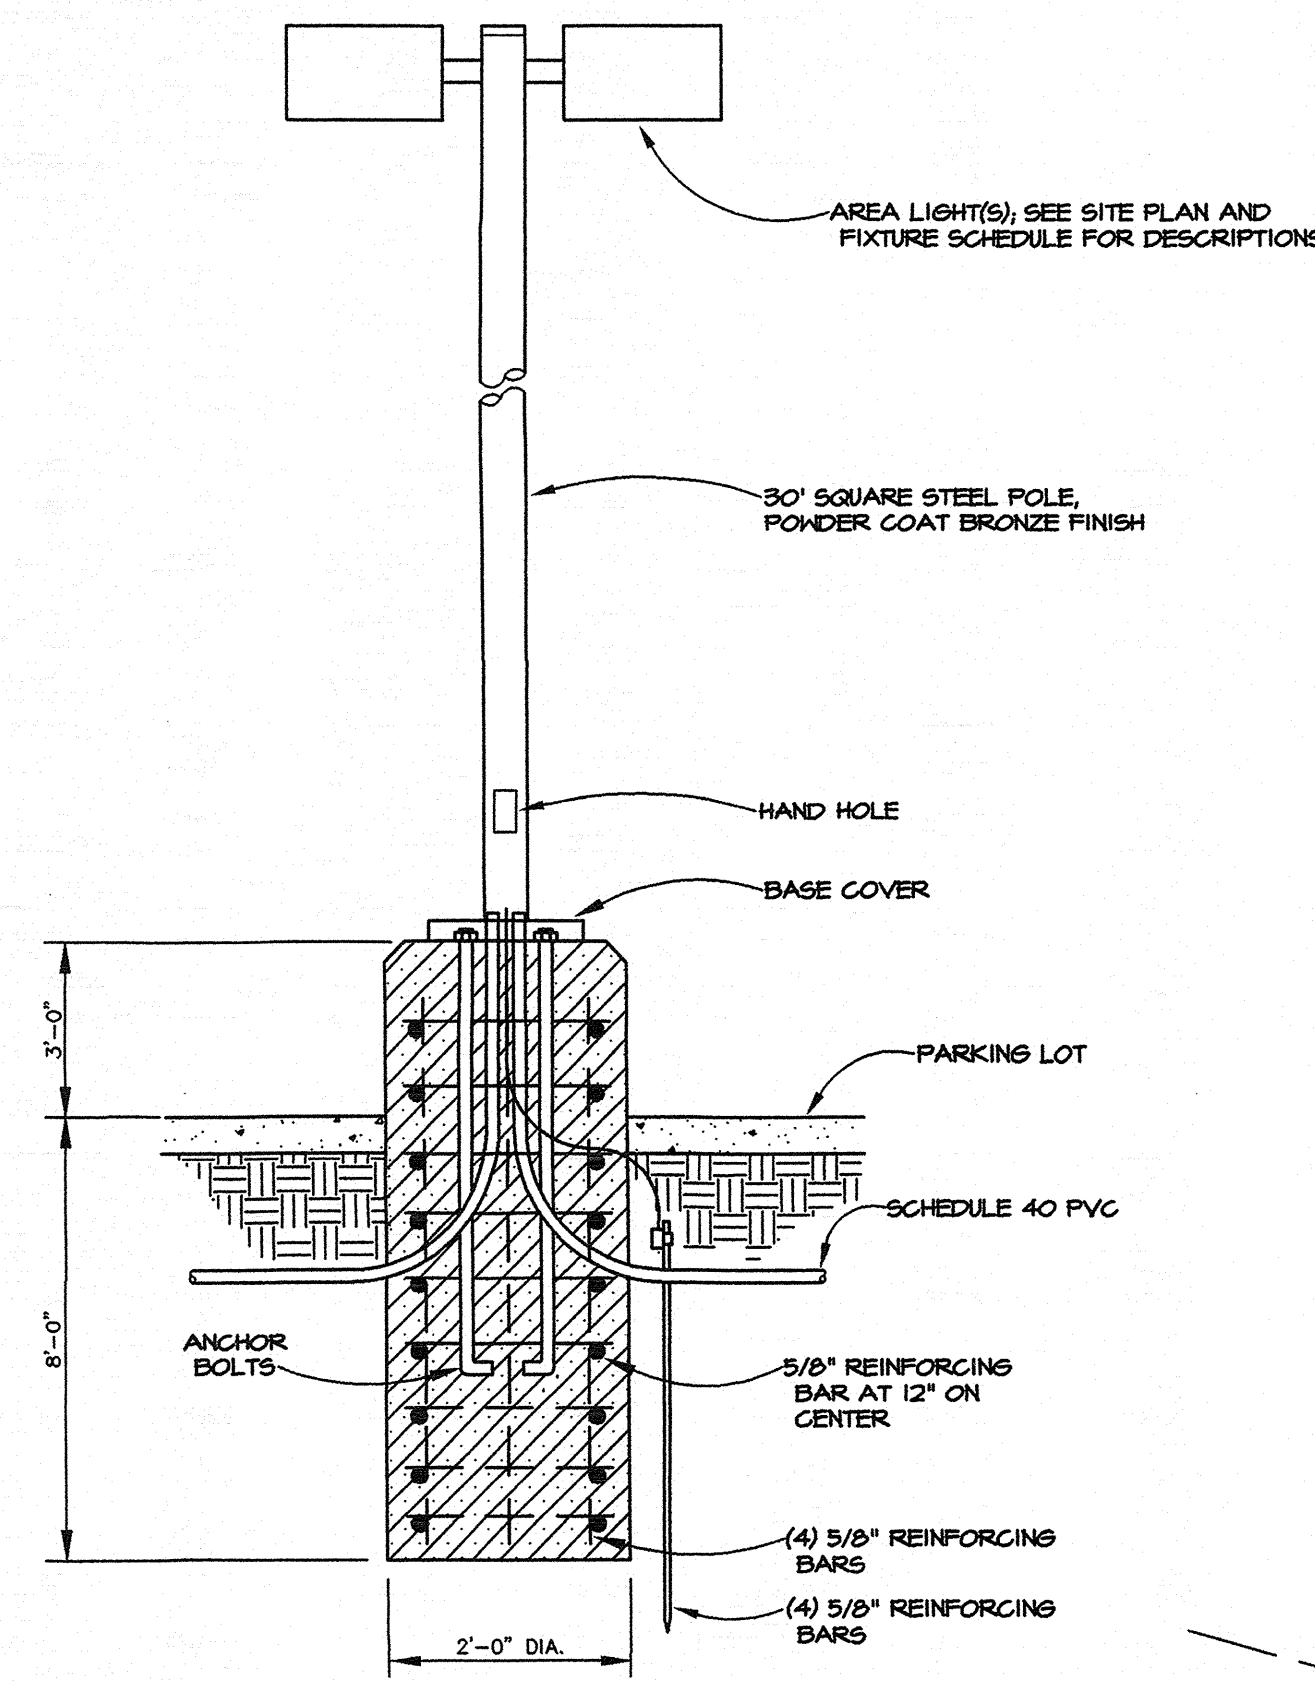

3 PARKING LIGHT DETAIL


SCALE: 1" = 20'-0"

EXTERIOR FIXTURE SCHEDULE

- EA 16-1/2" DIAMETER POST-TOP AGORN GLOBE WITH ONE (1) 175 WATT METAL HALIDE LAMP, CLEAR INJECTION-MOLDED ACRYLIC GLOBE, HFF BALLAST, CAST ALUMINUM HOLDER & FITTER, BLACK FINISH, FURNISH TEMON FOR MOUNTING ON FENCE TOP, NET LOCATION LISTED, 120 VOLT, HADECO #RS4-D-B-1-A-F-N-D-TSH-E; STERNBERG #A653-TSM-120-RS-165-FINAL
- EB 8" SQUARE X 42" HIGH BOLLARD WITH ONE (1) 100 WATT METAL HALIDE LAMP, EXTRUDED ALUMINUM HOUSING, TYPE V DISTRIBUTION, HIGH POWER FACTOR BALLAST, DARK BRONZE FINISH, NET LOCATION LISTED, FURNISH 24" X 24" X 12" CONCRETE BASE, 120 VOLT, LITHONIA # K88-100M-RS-120, ENCO #858-C-100M-BRZ-120
- EC GROUND MOUNTED FLOODLIGHT WITH ONE (1) 250 WATT METAL HALIDE LAMP, EXTRUDED ALUMINUM HOUSING, HIGH POWER FACTOR BALLAST, DARK BRONZE FINISH, NET LOCATION LISTED, STANCHION MOUNT, FURNISH 24" X 24" X 12" CONCRETE BASE, 120 VOLT, LITHONIA #KFL3-250M-SF-120-5THK; GARDCO #DF1-SF-250M-HFP-120-5T
- ED NOT USED
- EE 6" SQUARE, 30' LONG STRAIGHT STEEL POLE WITH ONE (1) TYPE V DISTRIBUTION AREA LIGHT FIXTURE, POLE FINISHED WITH BOLT COVER, EACH FIXTURE WITH ONE (1) 400 WATT METAL HALIDE LAMP, HORIZONTAL LAMP, EACH HFF BALLAST, PHOTOELECTRIC CELL, TEMPERED GLASS LENS, DARK BRONZE FINISH-POLE AND FIXTURE, 120 VOLT, ENCO # EA182-4H-400M-BRZ-PCT (fixture), K9A POLLS #SP30-6-D-1-82-DN180-BG (pole), HI-TEK # KAD-400M-R420SPD4-PEI (fixture), HI-TEK # 515306-4FDK28-008 (pole)
- EF 6" SQUARE, 30' LONG STRAIGHT STEEL POLE WITH TWO (2) TYPE V DISTRIBUTION AREA LIGHT FIXTURES, POLE FINISHED WITH BOLT COVER, EACH FIXTURE WITH ONE (1) 400 WATT METAL HALIDE LAMP, HORIZONTAL LAMP, EACH HFF BALLAST, PHOTOELECTRIC CELL, TEMPERED GLASS LENS, DARK BRONZE FINISH-POLE AND FIXTURE, 120 VOLT, TWO (2) ENCO # EA182-4H-400M-BRZ-PCT (fixture), K9A POLLS #SP30-6-D-1-82-DN180-BG (pole), HI-TEK # KAD-400M-R420SPD4-PEI (fixture), HI-TEK # 515306-4FDK28-008 (pole)

1 ELECTRICAL SITE PLAN

SCALE: 1" = 20'-0"

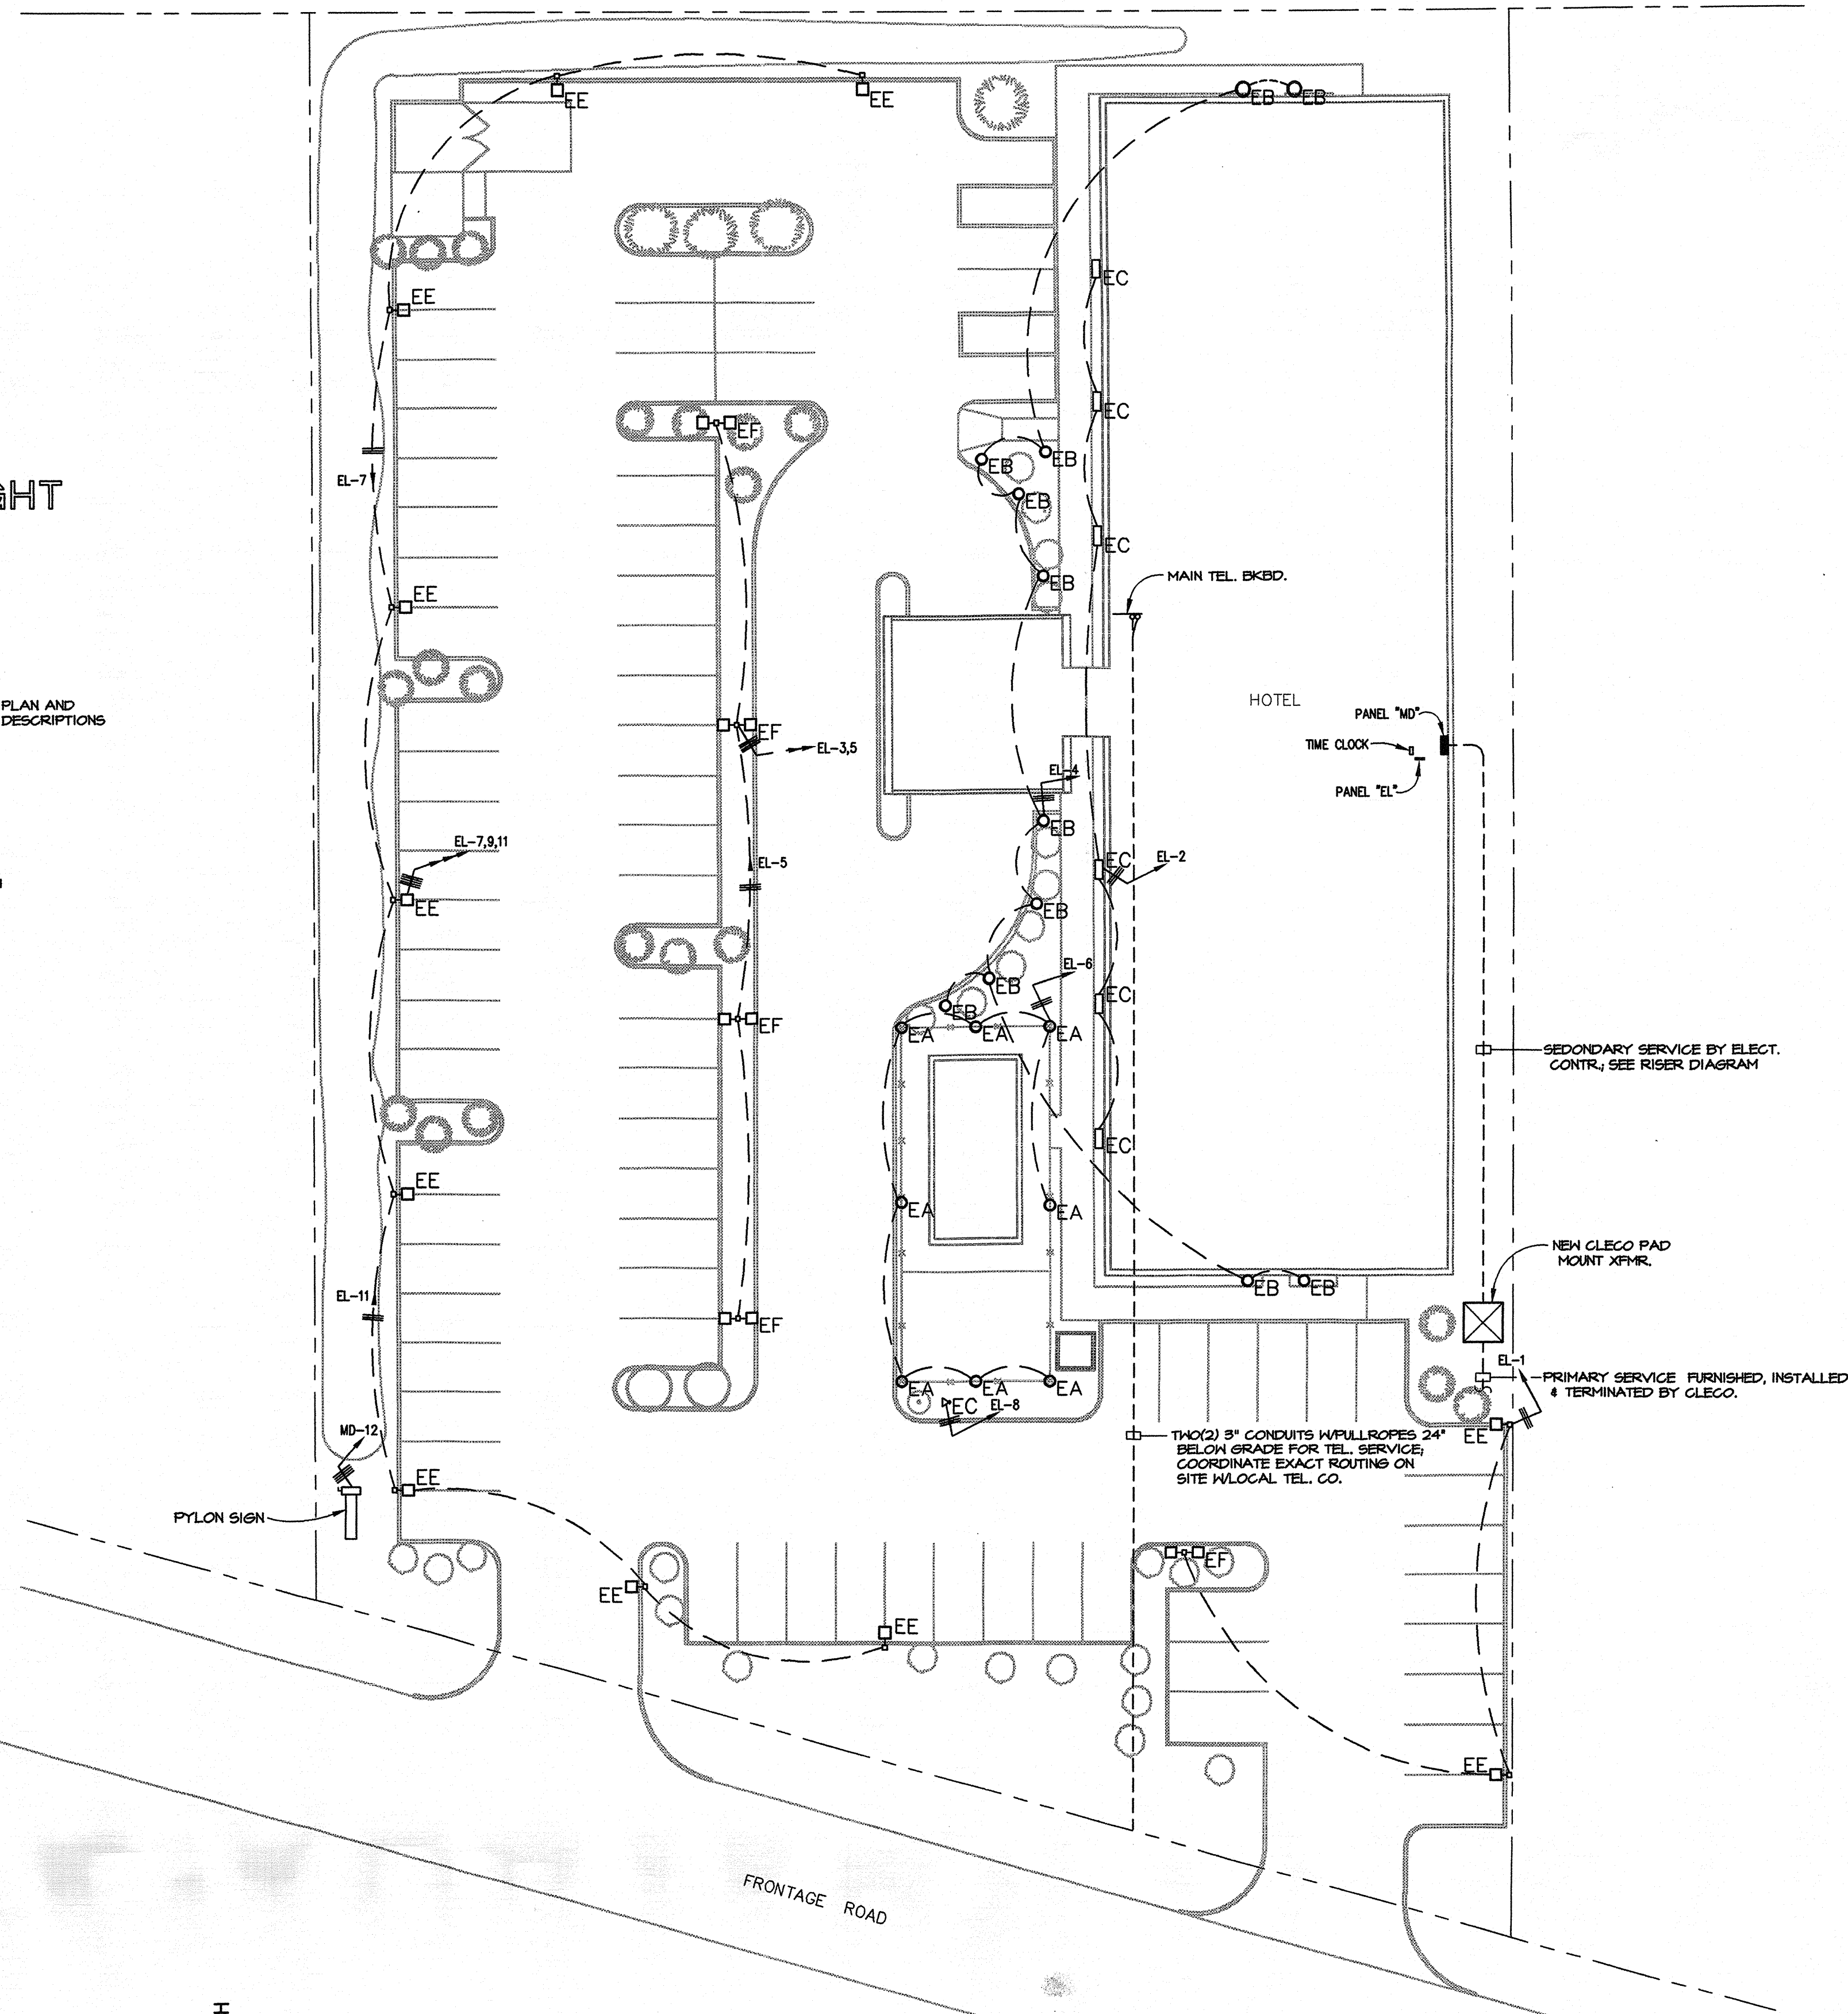

SYMBOL SCHEDULE	
FLUORESCENT FIXTURE; "A" DENOTES TYPE	
INCANDESCENT OR H.L.D. FIXTURE; "B" DENOTES TYPE	
EXIT LIGHT	
EMERGENCY LIGHTING UNIT	
DUPLEX RECEPTACLE	
GROUND FAULT INTERRUPTER DUPLEX RECEPTACLE	
QUADRAPLEX RECEPTACLE	
CLOCK HANGER OUTLET	
SPECIAL RECEPTACLE	
WEATHERPROOF	
SINGLE POLE TOGGLE SWITCH	
3-WAY TOGGLE SWITCH	
LINEAR SLIDE DIMMER SWITCH	
CONDUIT IN WALL OR CEILING	
HOMERUN; DASHES DENOTE NO. OF WIRES	
POWER PANEL	
FUSED SAFETY DISCONNECT SWITCH	
MOTOR	
VOICE/DATA OUTLET	
CABLE TV OUTLET	
JUNCTION BOX	
PHOTOELECTRIC CELL	
ABOVE FINISHED FLOOR	
KEYNOTE	
PUBLIC ADDRESS SYSTEM SPEAKER	
TRUMPET SPEAKER	
FIRE ALARM SYSTEM PULL STATION	
FIRE ALARM SYSTEM CHIME/STROBE	
FIRE ALARM SYSTEM HORN/STROBE	
FIRE ALARM SYSTEM STROBE	
FIRE ALARM SYSTEM SMOKE DETECTOR	
FIRE ALARM SYSTEM THERMAL DETECTOR	
DUCT DETECTOR	
FLOW SWITCH	
TEMPER SWITCH	
SPRINKLER ZONE VALVE	

INTERIOR FIXTURE SCHEDULE

- A 2' x 4' LAY-IN TROFFER FOR GRID CEILING WITH TWO (2) F32T8/SP41 LAMPS, ELECTRONIC BALLAST, WHITE TRIM, ACRYLIC LENS, 120 VOLT, DAY-BRITE #216232-01-120-1/2EB, LITHONIA #26T-232-A12-120-6EB
- B 2' x 4' LAY-IN TROFFER FOR GRID CEILING WITH FOUR (4) F32T8/SP41 LAMPS, TWO (2) ELECTRONIC BALLASTS, WHITE TRIM, ACRYLIC LENS, 120 VOLT, DAY-BRITE #216482-01-120-1/4EB, LITHONIA #26T-482-A12-120-6EB
- BI 2' x 4' LAY-IN RECESSED TROFFER FOR GYPSUM BOARD CEILING WITH FOUR (4) F32T8/SP41 LAMPS, TWO (2) 10% DIMMABLE ELECTRONIC BALLASTS, WHITE TRIM, ACRYLIC LENS, 120 VOLT, DAY-BRITE #217482-01-120-1/2EB, LITHONIA #26F-F-4-32-A12-120-ADEZ
- C SURFACE MOUNT W/RAPAROUND FLUORESCENT WITH TWO (2) F32T8/SP41 LAMPS, ELECTRONIC BALLAST, ACRYLIC LENS, 120 VOLT, DAY-BRITE #04K482-120-1/2EB, LITHONIA #LB232-120-6EB
- D SURFACE MOUNT W/RAPAROUND FLUORESCENT WITH FOUR (4) F32T8/SP41 LAMPS, TWO (2) ELECTRONIC BALLASTS, ACRYLIC LENS, 120 VOLT, DAY-BRITE #04K482-120-2/2EB, LITHONIA #LB482-120-6EB
- ES 3' STRIP WITH TWO (2) F32T8/SP41 LAMPS, ELECTRONIC BALLAST, MOUNTED IN COVE, 120 VOLT, DAY-BRITE #1225-120-1/2EB, LITHONIA #C225-120-6EB
- E4 4' STRIP WITH TWO (2) F32T8/SP41 LAMPS, ELECTRONIC BALLAST, MOUNTED IN COVE, 120 VOLT, DAY-BRITE #1232-120-1/2EB, LITHONIA #C232-120-6EB
- F 4' STRIP WITH TWO (2) F32T8/SP41 LAMPS, ELECTRONIC BALLAST, 120 VOLT, DAY-BRITE #1232-120-1/2EB, LITHONIA #C232-120-6EB
- G 2' LONG HALL MOUNT FLUORESCENT WITH UP AND DOWN LIGHT PATTERN, TWO (2) F40S/02X/SPX41 LAMPS, ELECTRONIC BALLAST, ACRYLIC LENS, WHITE FINISH, 120 VOLT, DAY-BRITE #C82C40-120-1/2EB, PRUDENTIAL #1652-24-C40-FRA-120
- H 1" DIAMETER RECESSED DOWNLIGHT WITH TWO (2) F10T8/SPX41/4P LAMPS, WHITE TRIM, ELECTRONIC BALLAST, SILVER (CLEAR) ALZAK REFLECTOR, 120 VOLT, LITHONIA #AF-218-DTT-10AR-120-6EB-TR4, DAY-BRITE #C8-F232S1-H85
- K 1" DIAMETER RECESSED DOWNLIGHT WITH TWO (2) F10T8/SPX41/4P LAMPS, WHITE TRIM, ELECTRONIC BALLAST, SILVER (CLEAR) ALZAK REFLECTOR, 120 VOLT, LITHONIA #AF2/32-TR1-10AR-120-6EB-TR4, DAY-BRITE #C8-F232S1-H85
- L 16" WIDE X 8" HIGH HALL MOUNT QUARTER SPHERE WITH TWO (2) F10T8/SPX41/4P LAMPS, OPAL ACRYLIC LENS, WHITE TRIM, ELECTRONIC BALLAST, 120 VOLT, MOORE LAMBERT #271-26-X2-BAL/LITHONIA #1469-MH
- M 4' LONG HALL MOUNT FLUORESCENT WITH UP AND DOWN PATTERN, TWO (2) F32T8/SP41 LAMPS, ELECTRONIC BALLAST, ACRYLIC LENS, WHITE FINISH, 120 VOLT, DAY-BRITE #C8232-120-1/2EB, LITHONIA #F-232-120-6EB
- N HALL MOUNT 'JELLY JAR' WITH ONE (1) 50 WATT METAL HALIDE LAMP/HIGH POWER FACTOR BALLAST, CLEAR PRISMATIC LENS, NET LOCATION LISTED, 120 VOLT, HF HARRIS #1000CP-HB-50M-HFF-21-LP
- O 10" DIAMETER RECESSED DOWNLIGHT WITH ONE (1) 100 WATT METAL HALIDE LAMP, SMOOTH WHITE BAFFLE WITH REGRESSED FRESNEL LENS, HFF BALLAST, DAMP LOCATION LISTED, 120 VOLT, DAY-BRITE #461-T068, LITHONIA #L6H-100M-89H-FLL-120
- P 10" DIAMETER RECESSED DOWNLIGHT WITH ONE (1) 175 WATT METAL HALIDE LAMP, SMOOTH WHITE BAFFLE WITH REGRESSED FRESNEL LENS, HFF BALLAST, DAMP LOCATION LISTED, 120 VOLT, LITHONIA #L6H-TSM-89H-FLL-120, DAY-BRITE #462-T068
- Q HALL MOUNT VAPOR TIGHT INCANDESCENT WITH 100 WATT A19 LAMP, CAST ALUMINUM BODY, GLASS GLOBE, CAST GUARD, 120 VOLT, STONCO #VH16G, G.E. #H100F30DD, PRES-COLITE #420M5-100M-FE-142, DAY-BRITE #11H-150-G, HALO #G41H16H1, SPERO #2100-C88G
- R 18" DIAMETER SURFACE MOUNT WITH ONE (1) F32D/035/4P LAMP, OPAL WHITE ACRYLIC LENS, ELECTRONIC BALLAST, DAMP LOCATION LISTED, 120 VOLT, HF HARRIS # 50M-D-28D-120-EB
- S 18" DIAMETER SURFACE MOUNT WITH ONE (1) F32D/035/4P LAMP, OPAL WHITE ACRYLIC LENS, ELECTRONIC BALLAST, DAMP LOCATION LISTED, 120 VOLT, HF HARRIS # 50M-D-32D-120-EB
- T 4" DIAMETER RECESSED DOWNLIGHT WITH ONE (1) 50 WATT PAR-20 LAMP, CLEAR (ALZAK) REFLECTOR, WHITE TRIM, 120 VOLT, CAFRU #A20X-102, LITHONIA #L3/301A
- U 8" DIAMETER RECESSED DOWNLIGHT WITH ONE (1) 60 WATT A19 LAMP, WHITE TRIM, BLACK HILL GROVE BAFFLE WITH REGRESSED FRESNEL GLASS LENS, DAMP LOCATION LISTED, THERMALLY PROTECTED, 120V, CAFRU #R4P-R10
- X EXIT LIGHT WITH RED LED LAMPS, THERMOPLASTIC HOUSING, BUILT-IN BATTERY, 120/277 VOLT, LITHONIA #L6G5HBR20/27TEL, ENERGI-LITE #ECLXMR, DAY-BRITE #CXL5R4EM
- EM SELF-CONTAINED EMERGENCY LIGHTING UNIT WITH TWO (2) SEALED BEAM PAR-36 LAMPS, MAINTENANCE FREE 6-VOLT BATTERY, THERMOPLASTIC HOUSING, 120 VOLT, ENERGI-LITE #PR0-2, LITHONIA #EM 2, DAY-BRITE #CA-6

ROY HENDRICK AIA ARCHITECT
5647 GALERIA DRIVE, SUITE 110
BATON ROUGE, LOUISIANA 70816
(225)-293-6363



Hampton Inn
SIX G'S SUBDIVISION
COVINGTON, LOUISIANA

REVISIONS
3-9-01
5-14-01
DATE
11-17-00
DRAWN BY
SHEET

Daniel T. Calongne
ASSOCIATES
7911 Wrenwood Blvd., Suite D
Baton Rouge, Louisiana 70806
voice (225) 922-9223 fax (225) 922-9414

E1.0