

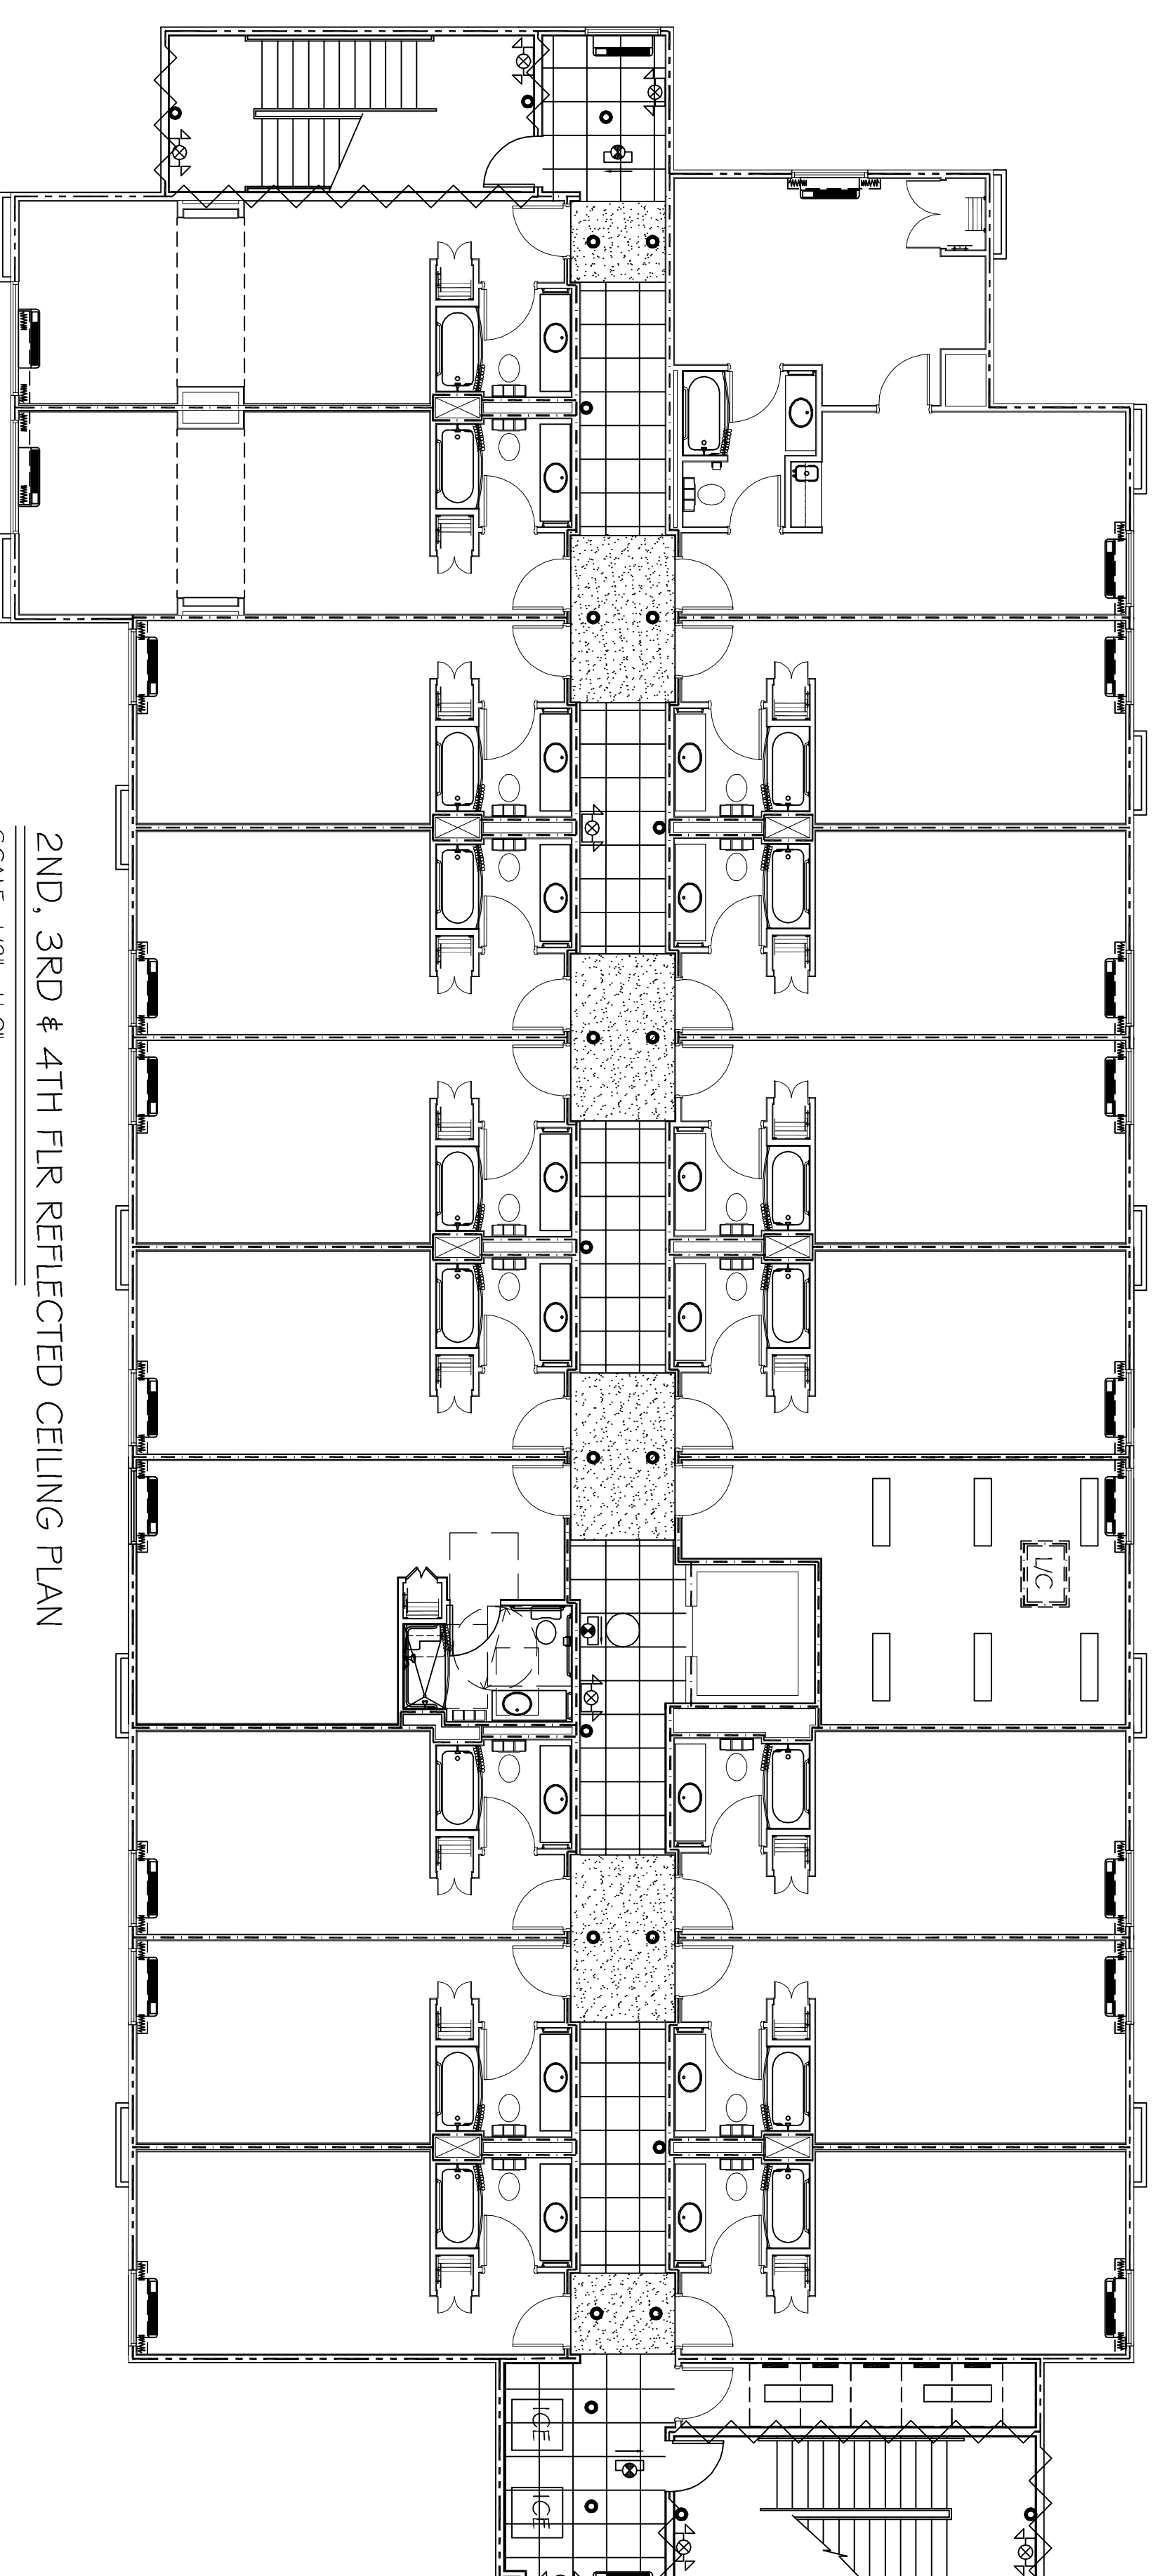


GROUND FLR REFLECTED CEILING PLAN  
SCALE: 1/8"=1'-0"

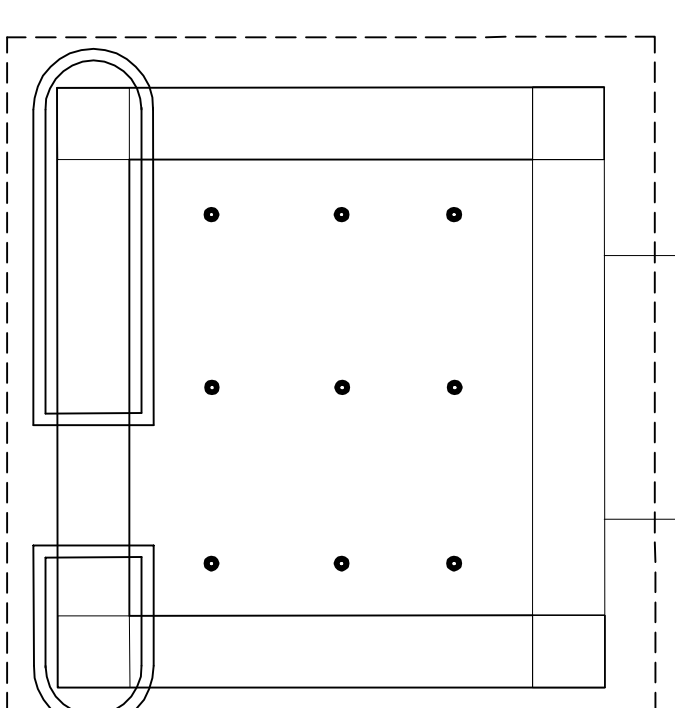

2ND, 3RD & 4TH FLR REFLECTED CEILING PLAN  
SCALE: 1/8"=1'-0"

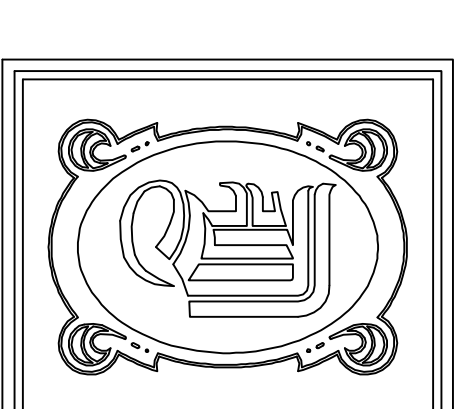

**DAMMON**  
ENGINEERING, INC.

CHIEF ENGINEER  
EMMETT  
DAMMON, P.E.  
CHIEF ARCHITECT  
ROBERT  
WILTSE

554 OLD SPANISH TRAIL  
SUITE L, LA, 70456  
OFFICE: 985-649-5632  
FAX: 985-641-5950

WEBSITE:  
WWW.DAMMONENGINEERING.COM  
EMAIL:  
DAMMONENG@BELL.SOUTH.NET

ARCHITECTURE  
ENGINEERING  
STUDIES  
PLANNING  
INVESTIGATION  
EXPERT WITNESS

LA QUINTA  
INN & SUITES

SPORTSMAN PARK  
LOT 14  
CABLEAS PARKWAY  
GONZALES  
LOUISIANA

REFLECTED  
CEILING PLAN

REV:  
SCALE: AS NOTED  
JOB#: 2141  
DATE: 07-03-12  
SHEET 15

A-10

OF 36