




1 DIMENSIONAL CONTROL PLAN
SCALE: 1/4" = 1'-0"

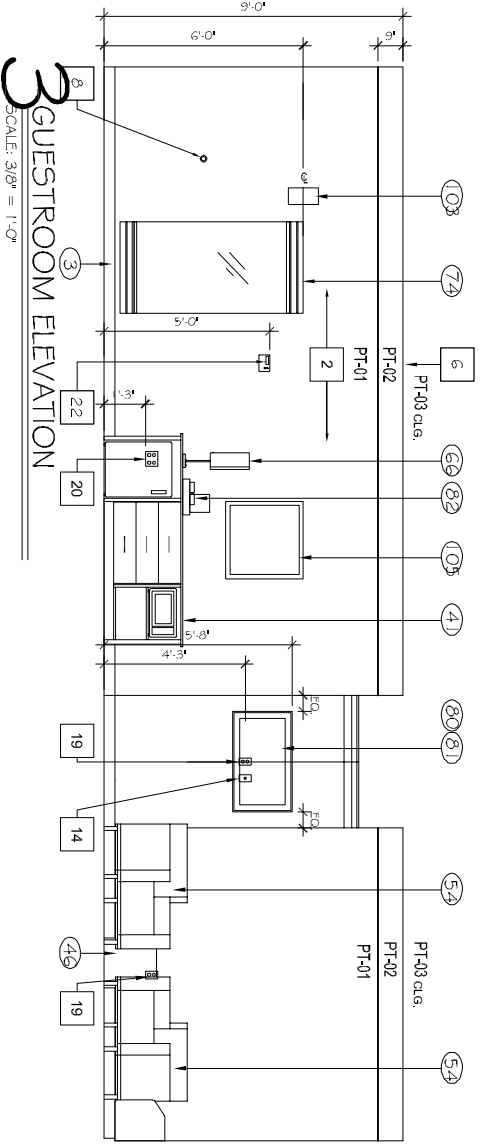


3 GUESTROOM ELEVATION
SCALE: 3/8" = 1'-0"

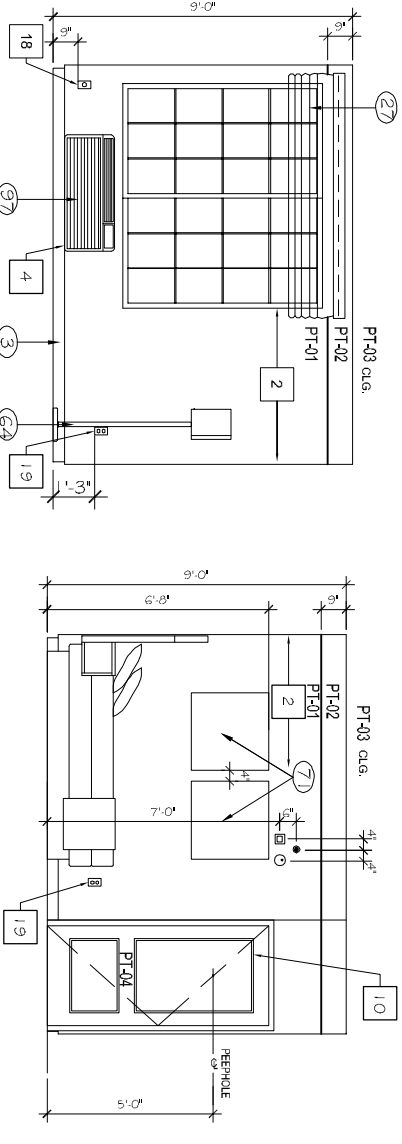


4 GUESTROOM ELEVATION
SCALE: 3/8" = 1'-0"

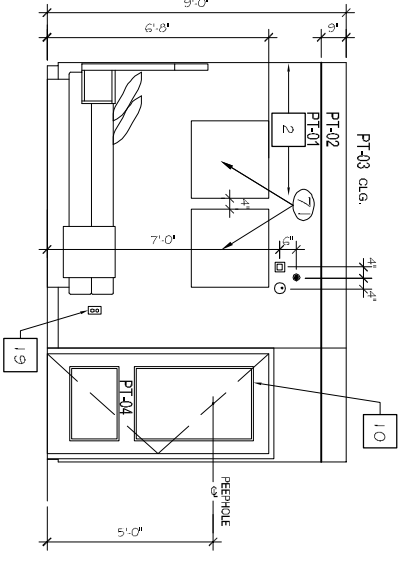


6 GUESTROOM ELEVATION
SCALE: 3/8" = 1'-0"

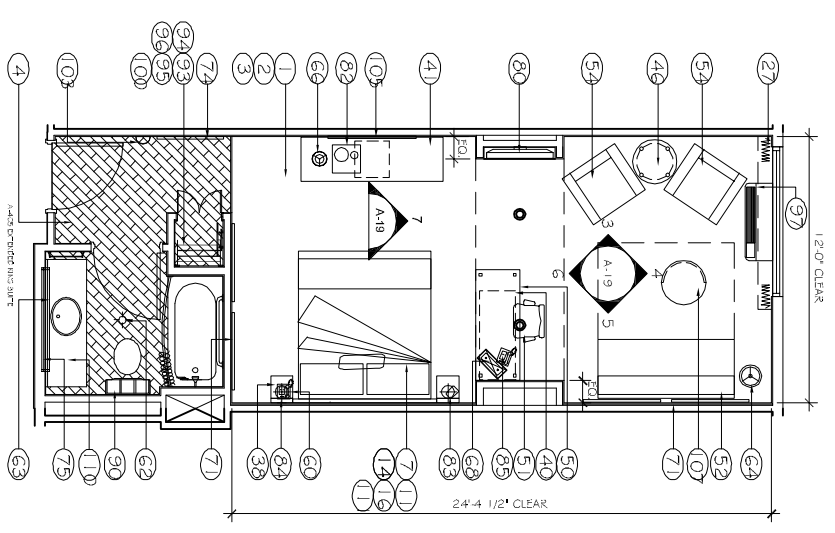

2 FURNITURE PLAN
SCALE: 1/4" = 1'-0"

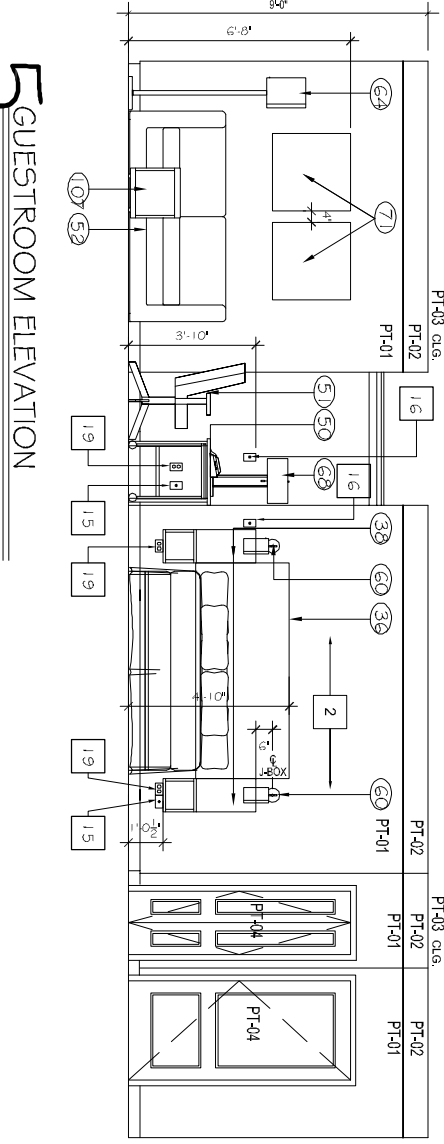

5 GUESTROOM ELEVATION
SCALE: 3/8" = 1'-0"

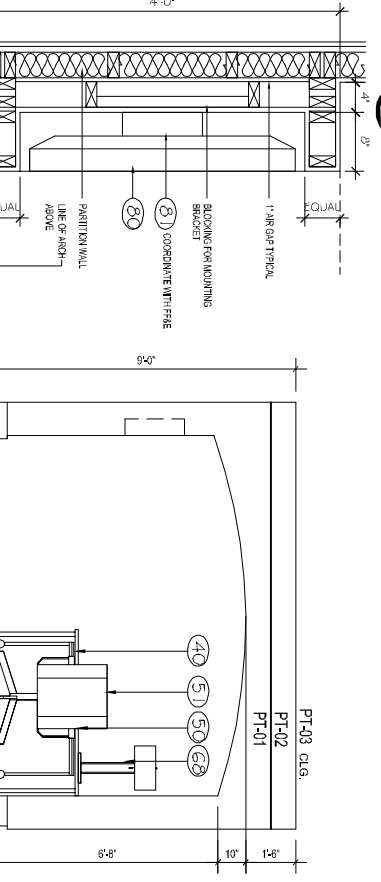

8 DETAIL "A" (RECESS FOR TV)
SCALE: 1" = 1'-0"

7 GUESTROOM ELEVATION
SCALE: 3/8" = 1'-0"

FF&E SCHEDULE	
1	GUESTROOM CARPET
2	GUESTROOM CARPET PAD
3	GUESTROOM CARPET BASE
4	GUESTROOM BATH RESILIENT TILE
BEDDING / DRAPERY (100)	
5	COVERLET FABRICATION - DD
6	COVERLET FABRICATION - QUEEN
7	COVERLET FABRICATION - KING
8	COVERLET FABRIC
9	BED THROW FABRICATION DOUBLE
10	BED THROW FABRICATION QUEEN
11	BED THROW FABRICATION KING
12	BESHSKIRT FABRICATION DOUBLE
13	BESHSKIRT FABRICATION QUEEN
14	BESHSKIRT FABRICATION KING
15	BESHSKIRT FABRIC
16	MATTRESS AND BOXSPRING KING
17	MATTRESS AND BOXSPRING DOUBLE
18	MATTRESS AND BOXSPRING QUEEN
19	MATTRESS AND BOXSPRING KING-AVA
20	MATTRESS AND BOXSPRING KING-AVA
21	MATTRESS AND BOXSPRING KING-AVA
22	MATTRESS AND BOXSPRING KING-AVA
23	BED BASE - DOUBLE ADA
24	BED BASE - QUEEN
25	MATTRESS AND BOXSPRING QUEEN-AVA
26	MATTRESS AND BOXSPRING QUEEN-AVA
27	MATTRESS AND BOXSPRING QUEEN-AVA
100	MATTRESS AND BOXSPRING QUEEN-AVA

FF&E SCHEDULE (CONTINUED)	
101	MATTRESS AND BOXSPRING QUEEN-AVA
102	MATTRESS AND BOXSPRING QUEEN-AVA
103	MATTRESS AND BOXSPRING QUEEN-AVA
200	MATTRESS AND BOXSPRING QUEEN-AVA

LAQUINTA INNS & SUITES
HATTIESBURG, MISSISSIPPI

2158
JTL

12-05-2012

CHIEF ENGINEER: EMMETT DAMMON, P.E.
554 OLD SPANISH TRAIL
SLIDE, LA 70458

dammoneengineering.com
dammoneg@bellsouth.net
PHONE: 985-649-5832
FAX: 985-641-5950

KEY SCHEDULE

- 1 CARPET PAD & BASE
- 2 TEXTURE DRYWALL - REFER TO FINISH SCHEDULE
- 3 THRU-WALL AIR-CONDITIONING UNIT ROUGH OPENING 7'-8" X 11'-4" MIN.
- 4 REINFORCING BLOCKING IN WALL
- 5 TEXTURED CEILING - REFER TO FINISH SCHEDULE
- 6 DOOR MOUNTED DOOR STOP
- 7 WALL MOUNTED DOOR STOP
- 8 DECORATIVE WOOD MOLDING
- 9 2-PANEL METAL DOOR AND FRAME - PAINTED REFER TO DOOR SCHEDULE TESTA LOCK HARDWARE
- 10 GYPSUM BOARD RETURN AT HEAD, JAMB & SILL
- 11 TELEPHONE/DATA DUPLEX HOUSING
- 12 PHONE/COIL CONDUNIT PULL OUT 10" IN A SINGLE BOX, REFER TO ELECTRICAL SCHEDULE FOR DIMENSIONS AND LOCATION
- 13 TELEPHONE OUTLET REFER TO ELECTRICAL SCHEDULE FOR DIMENSIONS AND LOCATION
- 14 LIGHT SWITCH REFER TO ELECTRICAL SCHEDULE FOR DIMENSIONS AND LOCATION
- 15 CONNECTING DOORS: SEE BUILDING PLAN FOR LOCATION AND BATHROOM
- 16 220V. OUTLET REFER TO ELECTRICAL SCHEDULE FOR VOLTAGE INFORMATION, ALWAYS LOCATE TO 2FT OF FLOOR
- 17 DUPLEX OUTLET INSTALL HORIZONTALLY AT NIGHTSTANDS
- 18 QUID OUTLET
- 19 MOUNTING HEIGHT OF HEADBOARD, NIGHTSTAND AND WALL LAMPS BASED ON LOW PROFILE BOXSPRINGS. T-SHIRT HEIGHTS 48" IN HANDICAPPED ACCESSIBLE ROOMS AND 87" IN TYPICAL ROOMS.

DRAWING NOTES

1. VANTY FLOORING, CARPETING TO BE INSTALLED AT 45° FROM THE ROOM ANGLE. DETERMINE STARTING POINT FOR EACH ROW SO AS TO MAINTAIN A MINIMUM 12" LONG PIECE AT EDGES.

GENERAL NOTES

1. ELECTRICAL OUTLETS IN ADJACENT ROOMS OF THE SAME TYPE SHALL BE OFFSET A MAXIMUM OF 8" SEP. BY STUD.
2. REFER TO BUILDING PLANS FOR LOCATION OF GUEST ROOM TYPES.
3. ALL DIMENSIONS ARE TO FACE UNLESS NOTED OTHERWISE.
4. REF. A-1, 2, 3 FOR PARTITION FINISHES.

REFERENCE FINISH SELECTION BOOK FOR XX
PAINT AND MATERIAL LEGEND
FOR FINISH SELECTION BOOK FOR XX
DESIGN SIGNATURE

REFER A-401 FOR PARTITION TYPES

EXTENDED KING SUITE DETAILS

SHEET NO: **A18**