

STIPULATION FOR REUSE  
THIS DRAWING IS PREPARED FOR  
USE ON A SPECIFIC SITE AT  
A SPECIFIC LOCATION AND IS NOT  
CONSIDERED A GENERAL DRAWING.  
IT IS NOT TO BE REUSED FOR ANY OTHER  
PROJECT, SITE OR A LATER TIME  
WITHOUT THE WRITTEN CONSENT OF  
HARRISON FRENCH & ASSOCIATES, LTD.  
OR ANY OTHER PROJECTS AND ENGINEERS.  
REUSE ON ANOTHER PROJECT IS NOT  
PERMITTED AND MAY BE CONTRARY TO  
THE LAW.



STORE NUMBER: 860  
I-59, EXIT 1  
NICHOLSON, MS 39466

TIER 1 180

ISSUE BLOCK

NO.	DATE	DESCRIPTION

CHECKED BY: JKR

DRAWN BY: PRC

DOCUMENT DATE: 2/7/2023

PROTO: TIER 1 180


PROTO CYCLE: Q4 - 2022



2023.02.07 13:31:13-06'00"

HVAC  
TEMPERATURE  
CONTROL  
DIAGRAMS

SHEET:  
M102

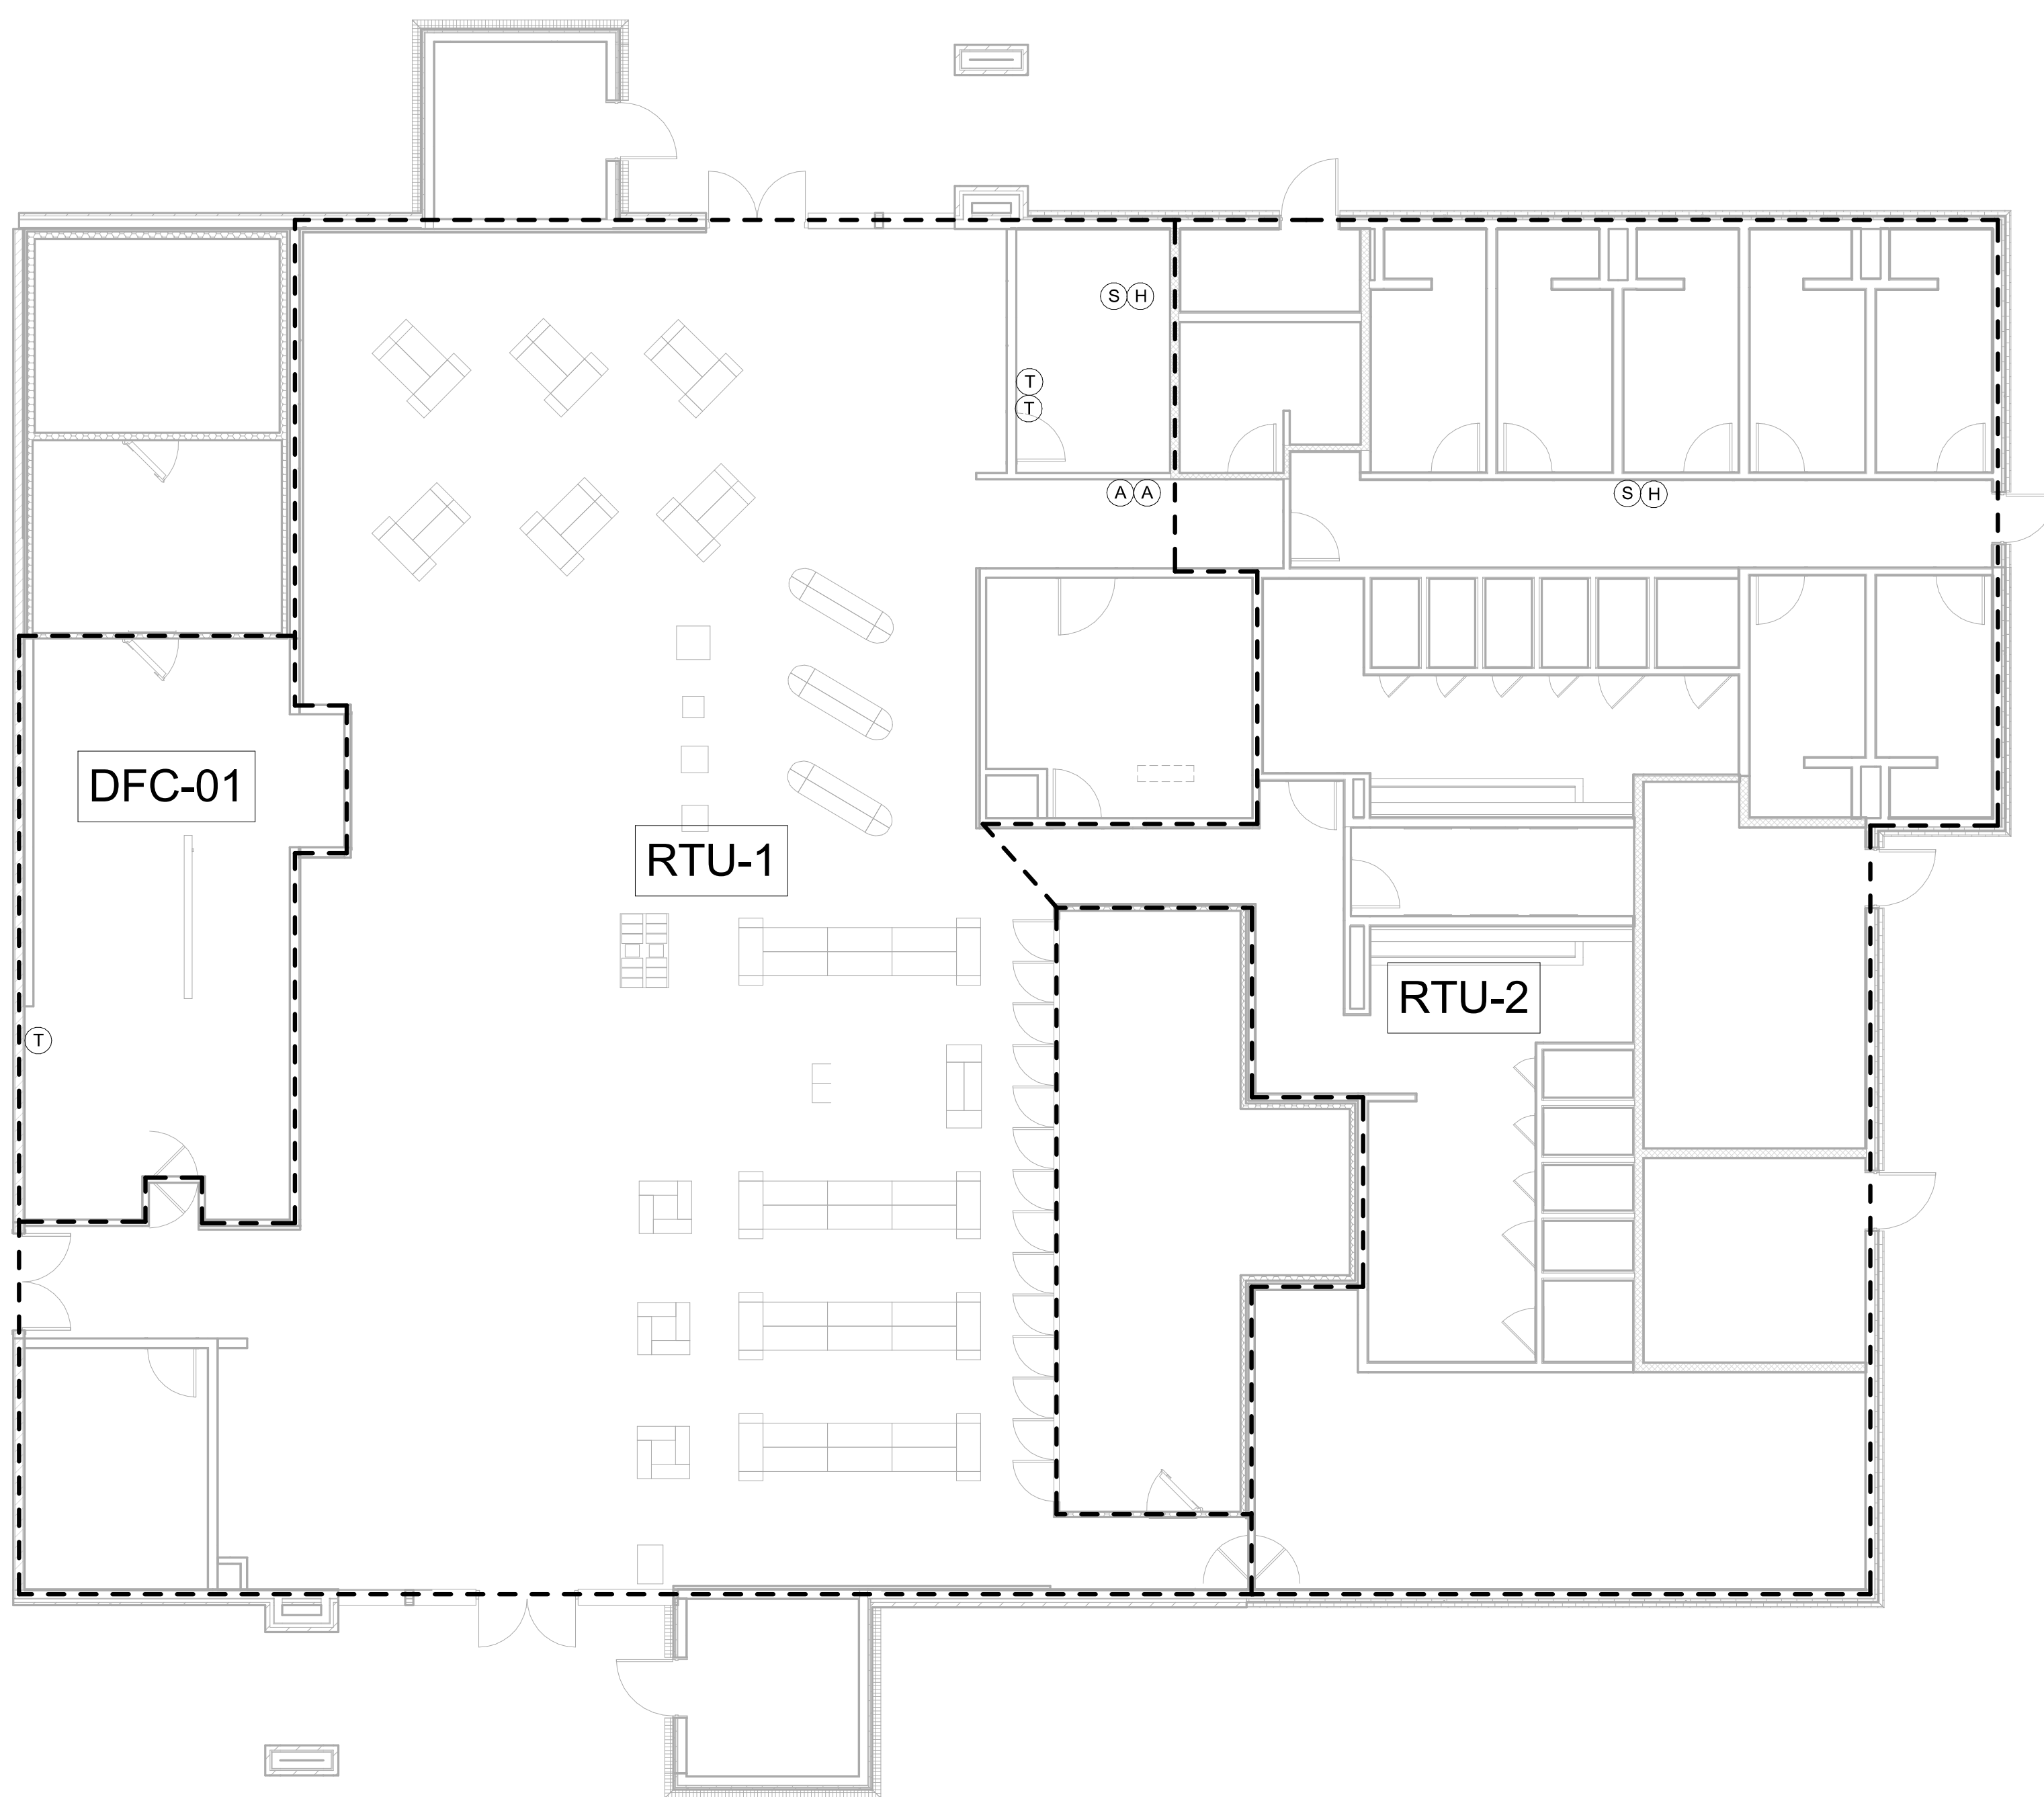

1 HVAC TEMPERATURE CONTROL DIAGRAMS  
1/8" = 1'-0"

C:\Users\jkr\OneDrive\Documents\2023\Revit\Projects\Love's\_Nicholson\_MS\_MEP\_T2\_180\_CTL\_HFA\_Planet\_Chicago\NYT  
400-M102-HVAC TEMPERATURE CONTROL DIAGRAMS