


2 CURB BOX DETAIL
NTS

KEYNOTES	
22.012	POST HYDRANT YH-1, BRANCH LINES TO BE 1/2". REFER TO GENERAL NOTES 12 & 13.
22.013	LOCATE AIR HOSE AT DIESEL ISLANDS AT BACK (TOP) EDGE OF BUMPERS, BRANCH LINES TO BE 1/2" REFER TO CIVIL SITE SHEETS.
22.014	G.C. TO PROVIDE 3"PVC CANOPY DOWNSPOUT EXTENSIONS TO EACH ISLAND; REFER TO CIVIL SITE SHEETS AND ARCHITECTURAL FUEL ISLAND SHEETS.
22.015	PROVIDE AIR AND WATER ARCH PATTERN CURB BOXES: McDONALD 5601L, MODEL 1600 WATER VALVE, AND MODEL 3061 AIR VALVE AT EACH SERVICE ISLAND (REQUIRED) FOR ACCESS TO ISOLATION VALVES BY G.C. (SIZE AND DEPTH T.B.D. IN THE FIELD).
22.016	DIESEL CATCH BASIN WITH SILT TRAP; REFER TO ARCHITECTURAL (TYPICAL).

- GENERAL NOTES**
- THE "GENERAL CONDITIONS OF THE CONTRACT" CURRENT EDITION PUBLISHED IN STANDARD FORM BY THE AMERICAN INSTITUTE OF ARCHITECTS SHALL BE PART OF THIS CONTRACT.
 - THE CONTRACTOR SHALL FURNISH AND INSTALL ALL ITEMS WHICH ARE OBVIOUSLY AND REASONABLY NECESSARY TO COMPLETE THE INSTALLATION.
 - ALL WORK AND MATERIALS SHALL BE IN FULL ACCORDANCE WITH THE CURRENT STATE AND LOCAL CODES THAT APPLY.
 - THE CONTRACTOR SHALL TAKE OUT PERMITS, PROCURE CERTIFICATES, AND PAY FEES CONNECTED THEREWITH.
 - BIDDERS SHALL VISIT THE SITE AND BECOME FAMILIAR WITH EXISTING CONDITIONS SURROUNDING THE PROJECT PRIOR TO BIDDING.
 - THE CONTRACTOR IS REFERRED TO ARCHITECTURAL, STRUCTURAL, ELECTRICAL PLANS AND SPECIFICATIONS, SUCH PLANS AND SPECIFICATIONS ARE CONTRACT DOCUMENTS.
 - DRAWINGS ARE DIAGRAMMATIC AND INTENDED TO SHOW APPROXIMATE LOCATIONS.
 - ALL UNDERGROUND COMPRESSED AIR PIPING SHALL BE PE100 ASAHI/AMERICA AIR-PRO PIPING.
 - UNDERGROUND SANITARY WASTE SHALL BE PVC.
 - PROVIDE 4" EMPTY PVC SLEEVE UNDER ALL DRIVES 30" COVER MINIMUM. TAPE ENDS FOR OWNER'S FUTURE USE.
 - REFER TO SHEET P401 PLUMBING FIXTURE SCHEDULE.
 - TURN POST HYDRANTS AT DIESEL ISLANDS TO FACE EXIT SIDE OF ISLAND LOCATE AT THE EDGE OF BUMPER. WRAP ALL POST YARD HYDRANTS BELOW GRADE WITH 1/2" EXPANSION JOINT MATERIAL. (DO NOT COVER WEEP HOLES OF YARD HYDRANTS).
 - UNDERGROUND WATER SHALL BE "ENDOPOLY" (ASTM D3350) SERVICE PIPE.

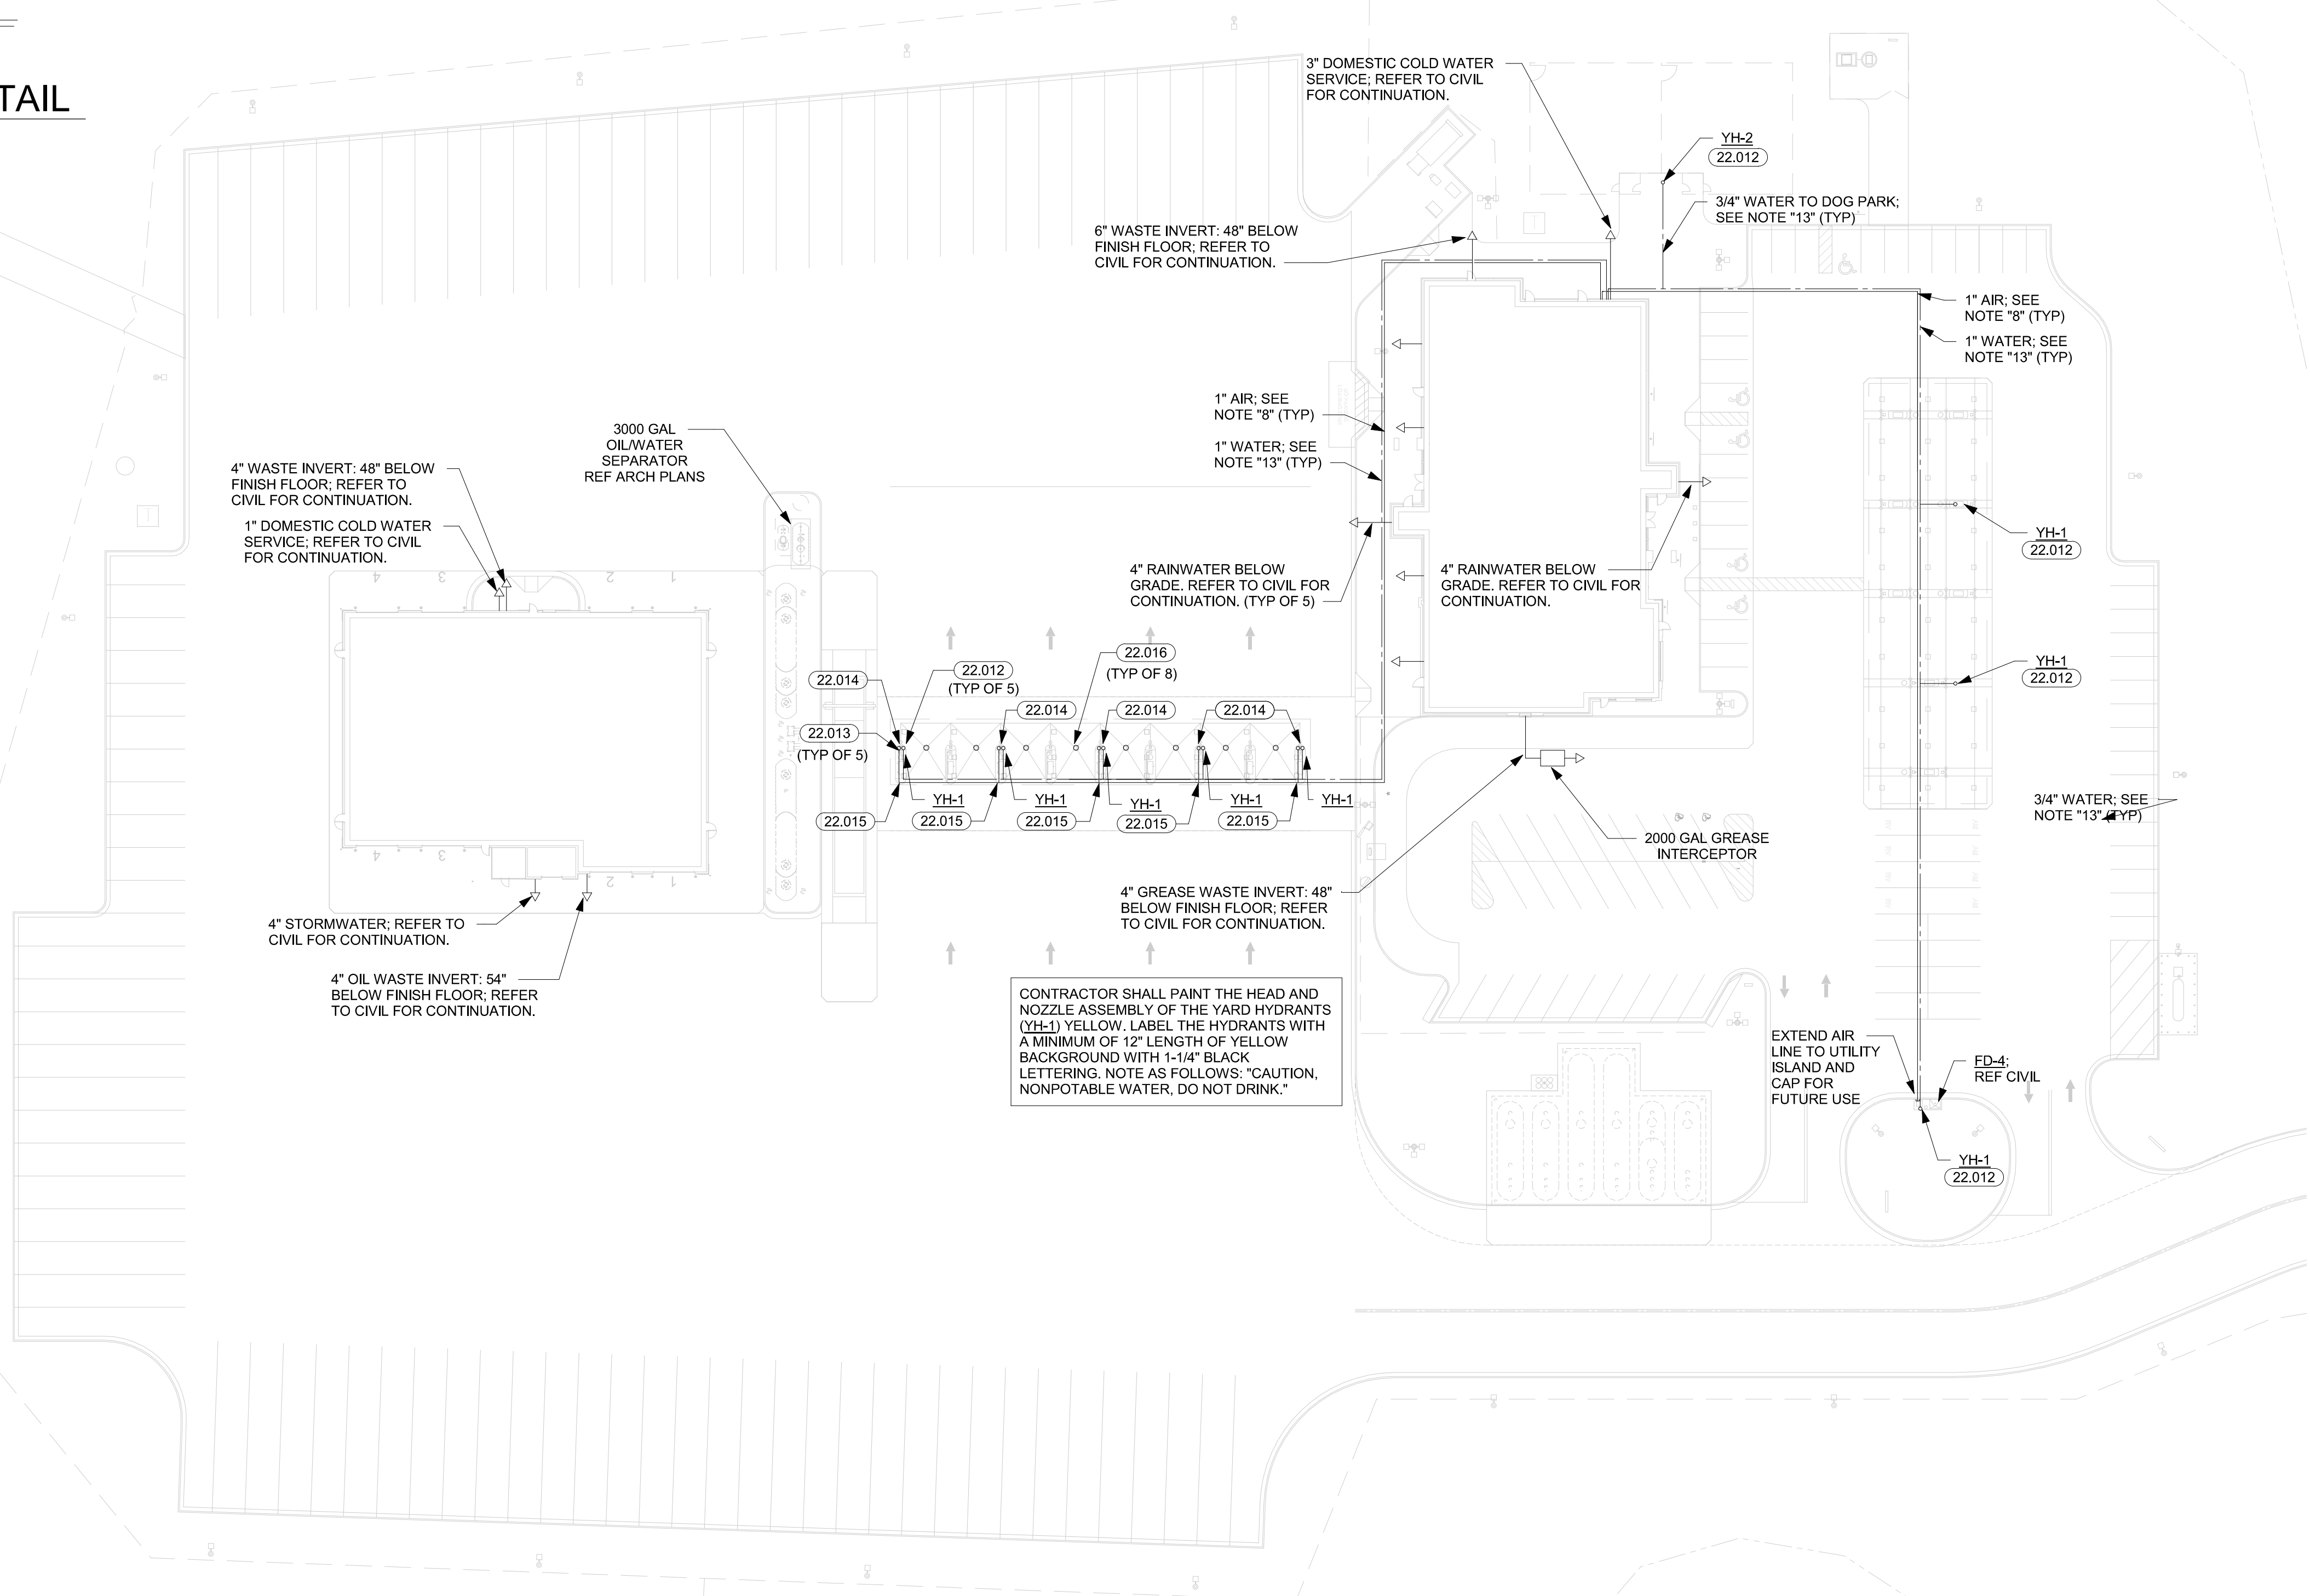

CONTRACTOR SHALL PAINT THE HEAD AND NOZZLE ASSEMBLY OF THE YARD HYDRANTS (YH-1) YELLOW. LABEL THE HYDRANTS WITH A MINIMUM OF 12" LENGTH OF YELLOW BACKGROUND WITH 1-1/4" BLACK LETTERING. NOTE AS FOLLOWS: "CAUTION, NONPOTABLE WATER, DO NOT DRINK."

HFA
HARRISON FRENCH & ASSOCIATES, LTD.
479.273.7780
1705 S. Walton Blvd., Suite 3
Bentonville, Arkansas 72712
www.hfa-ac.com

STIPULATION FOR REUSE
THIS DRAWING IS PREPARED FOR USE ON A SPECIFIC SITE AT THE LOCATION AND DATE INDICATED. IT IS NOT TO BE REUSED FOR ANY OTHER PROJECT WITHOUT THE WRITTEN CONSENT OF HARRISON FRENCH & ASSOCIATES, LTD. ANY REUSE OF THIS DRAWING FOR ANY OTHER PROJECT WITHOUT THE WRITTEN CONSENT OF HARRISON FRENCH & ASSOCIATES, LTD. IS PROHIBITED.

Loves
STORE NUMBER: 860
I-59, EXIT 1
NICHOLSON, MS 39466
JOB NUMBER: 03-23-30009
TIER 1 180

ISSUE BLOCK

NO.	DATE	DESCRIPTION

CHECKED BY: JKR
DRAWN BY: PRC
DOCUMENT DATE: 2/7/2023
PROTO: TIER 1 180
PROTO CYCLE: Q4 - 2022



2023.02.07 13:31:52-06'00"

PLUMBING SITE PLAN

SHEET: **P101**

2/7/2023 13:31:52-06'00"
 C:\Users\jkr\OneDrive\Documents\2023\New\Projects\Level_Nicholson_MS_MEP_T2_180_C21_HFA_Plumb_Site_Plan.dwg
 4/26/2023 10:41 AM LAMING SITE PLAN