


# TEXTRON NAVSEA SSC OFFICE RENOVATION

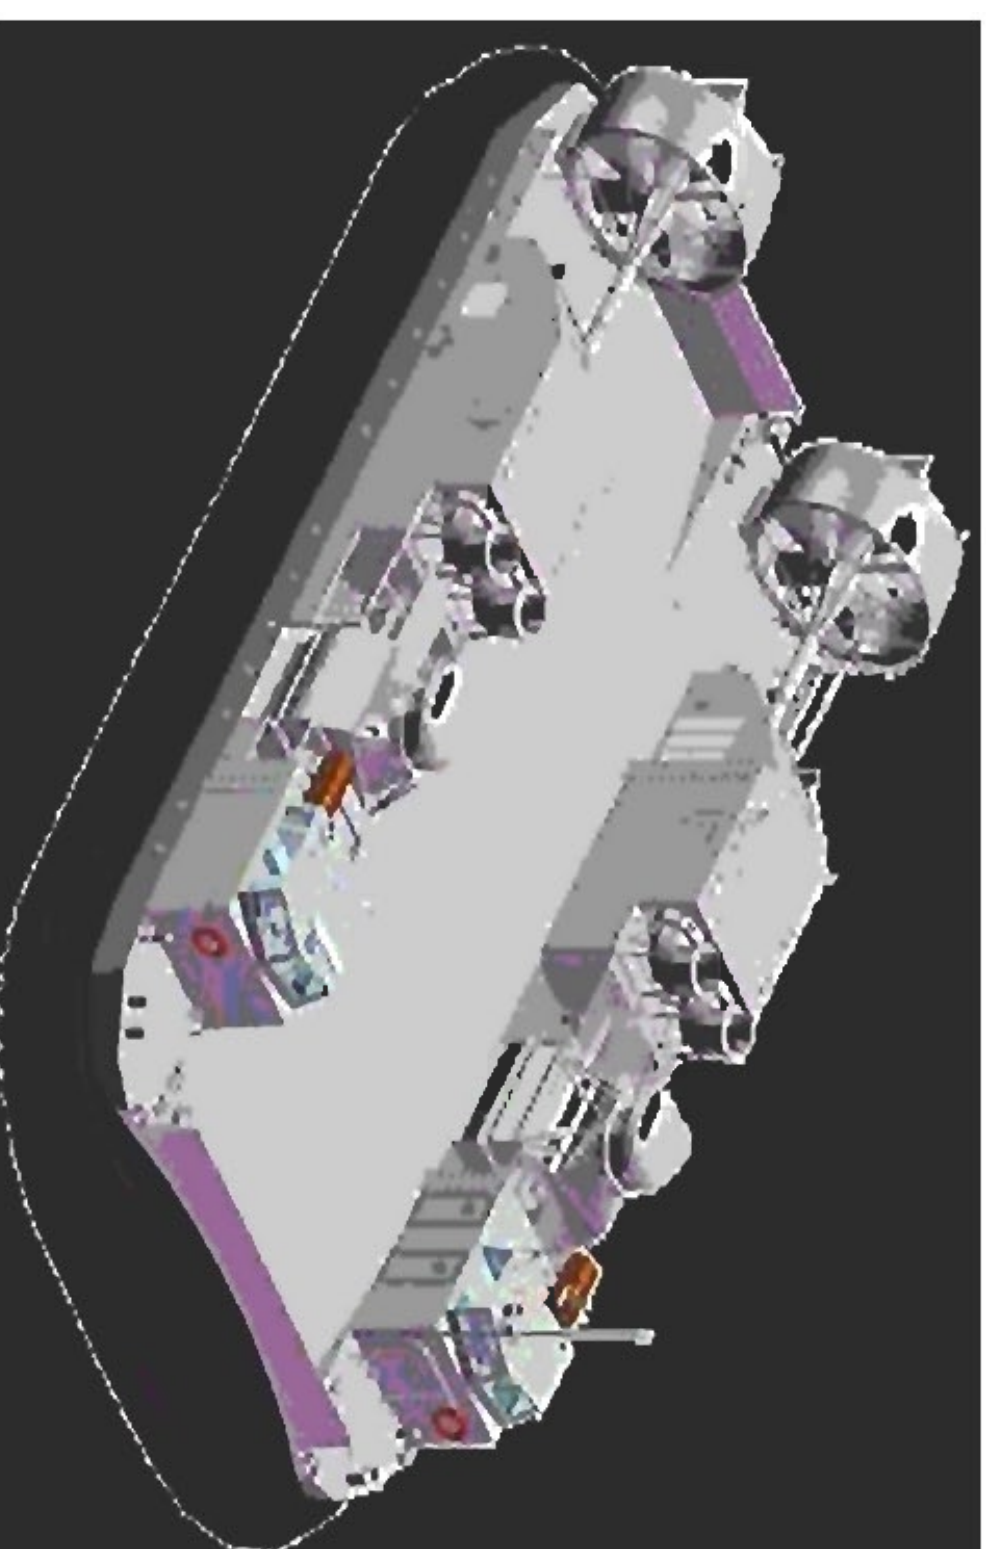


- STATEMENT OF WORK:**
- 1) DEMO ALL EXISTING CEILING TILES, LIGHTS AND CEILING GRID. PROVIDE AND INSTALL NEW CEILING TILES, LIGHTS AND CEILING GRID.
  - 2) REMOVE AND REPLACE EXISTING AHUS AND DUCT HEATER WITH NEW AND INSTALL NEW VENTS. PROVIDE AND INSTALL ADDITIONAL EXHAUST FAN AS NOTED IN PLANS.
  - 3) DEMO EXISTING RESTROOM PARTITIONS AND REPLACE WITH NEW.
  - 4) DEMO EXISTING FLOORING AND BASE BOARD. PROVIDE AND INSTALL WITH NEW FLOORING AND BASEBOARD.
  - 5) DEMO AND RELOCATE EXISTING WALLS AND ADD NEW WALLS.
  - 6) PAINT ALL NEW WALLS.
  - 7) DEMO ELECTRICAL AS NOTED AND INSTALL NEW.



VICINITY MAP  
N.T.S.

DWG#	DRAWING NAME
-	COVER SHEET
D-1	DEMO PLAN
A-1	FLOOR PLAN
A-2	OFFICE LAYOUT
A-3	REFLECTED CEILING PLAN
M-1	MECHANICAL PLAN
E-1	ELECTRICAL POWER PLAN
E-2	ELECTRICAL LIGHTING PLAN

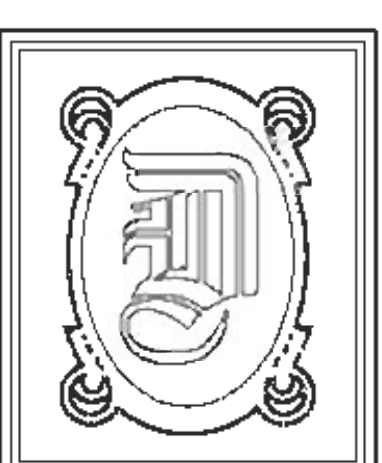

**DAMMON ENGINEERING, INC.**  
 554 OLD SPANISH TRAIL OFFICE: (985) 649-5832  
 SLIDELL, LA 70458 FAX: (985) 641-5950  
 WEBSITE: WWW.DAMMONENGINEERING.COM  
 EMAIL: DAMMONENG@BELLSOUTH.NET

DATE: 9/19/2011  
 JOB NO. 2120

NAVSEA SSC  
 OFFICE AREA,  
 19401 CHEF MENTUER HWY  
 NEW ORLEAN, LA 70129