



ENLARGED FLOOR PLANS
STORE NUMBER 2274
FREMAUX TOWN CENTER
SLIDELL, LOUISIANA

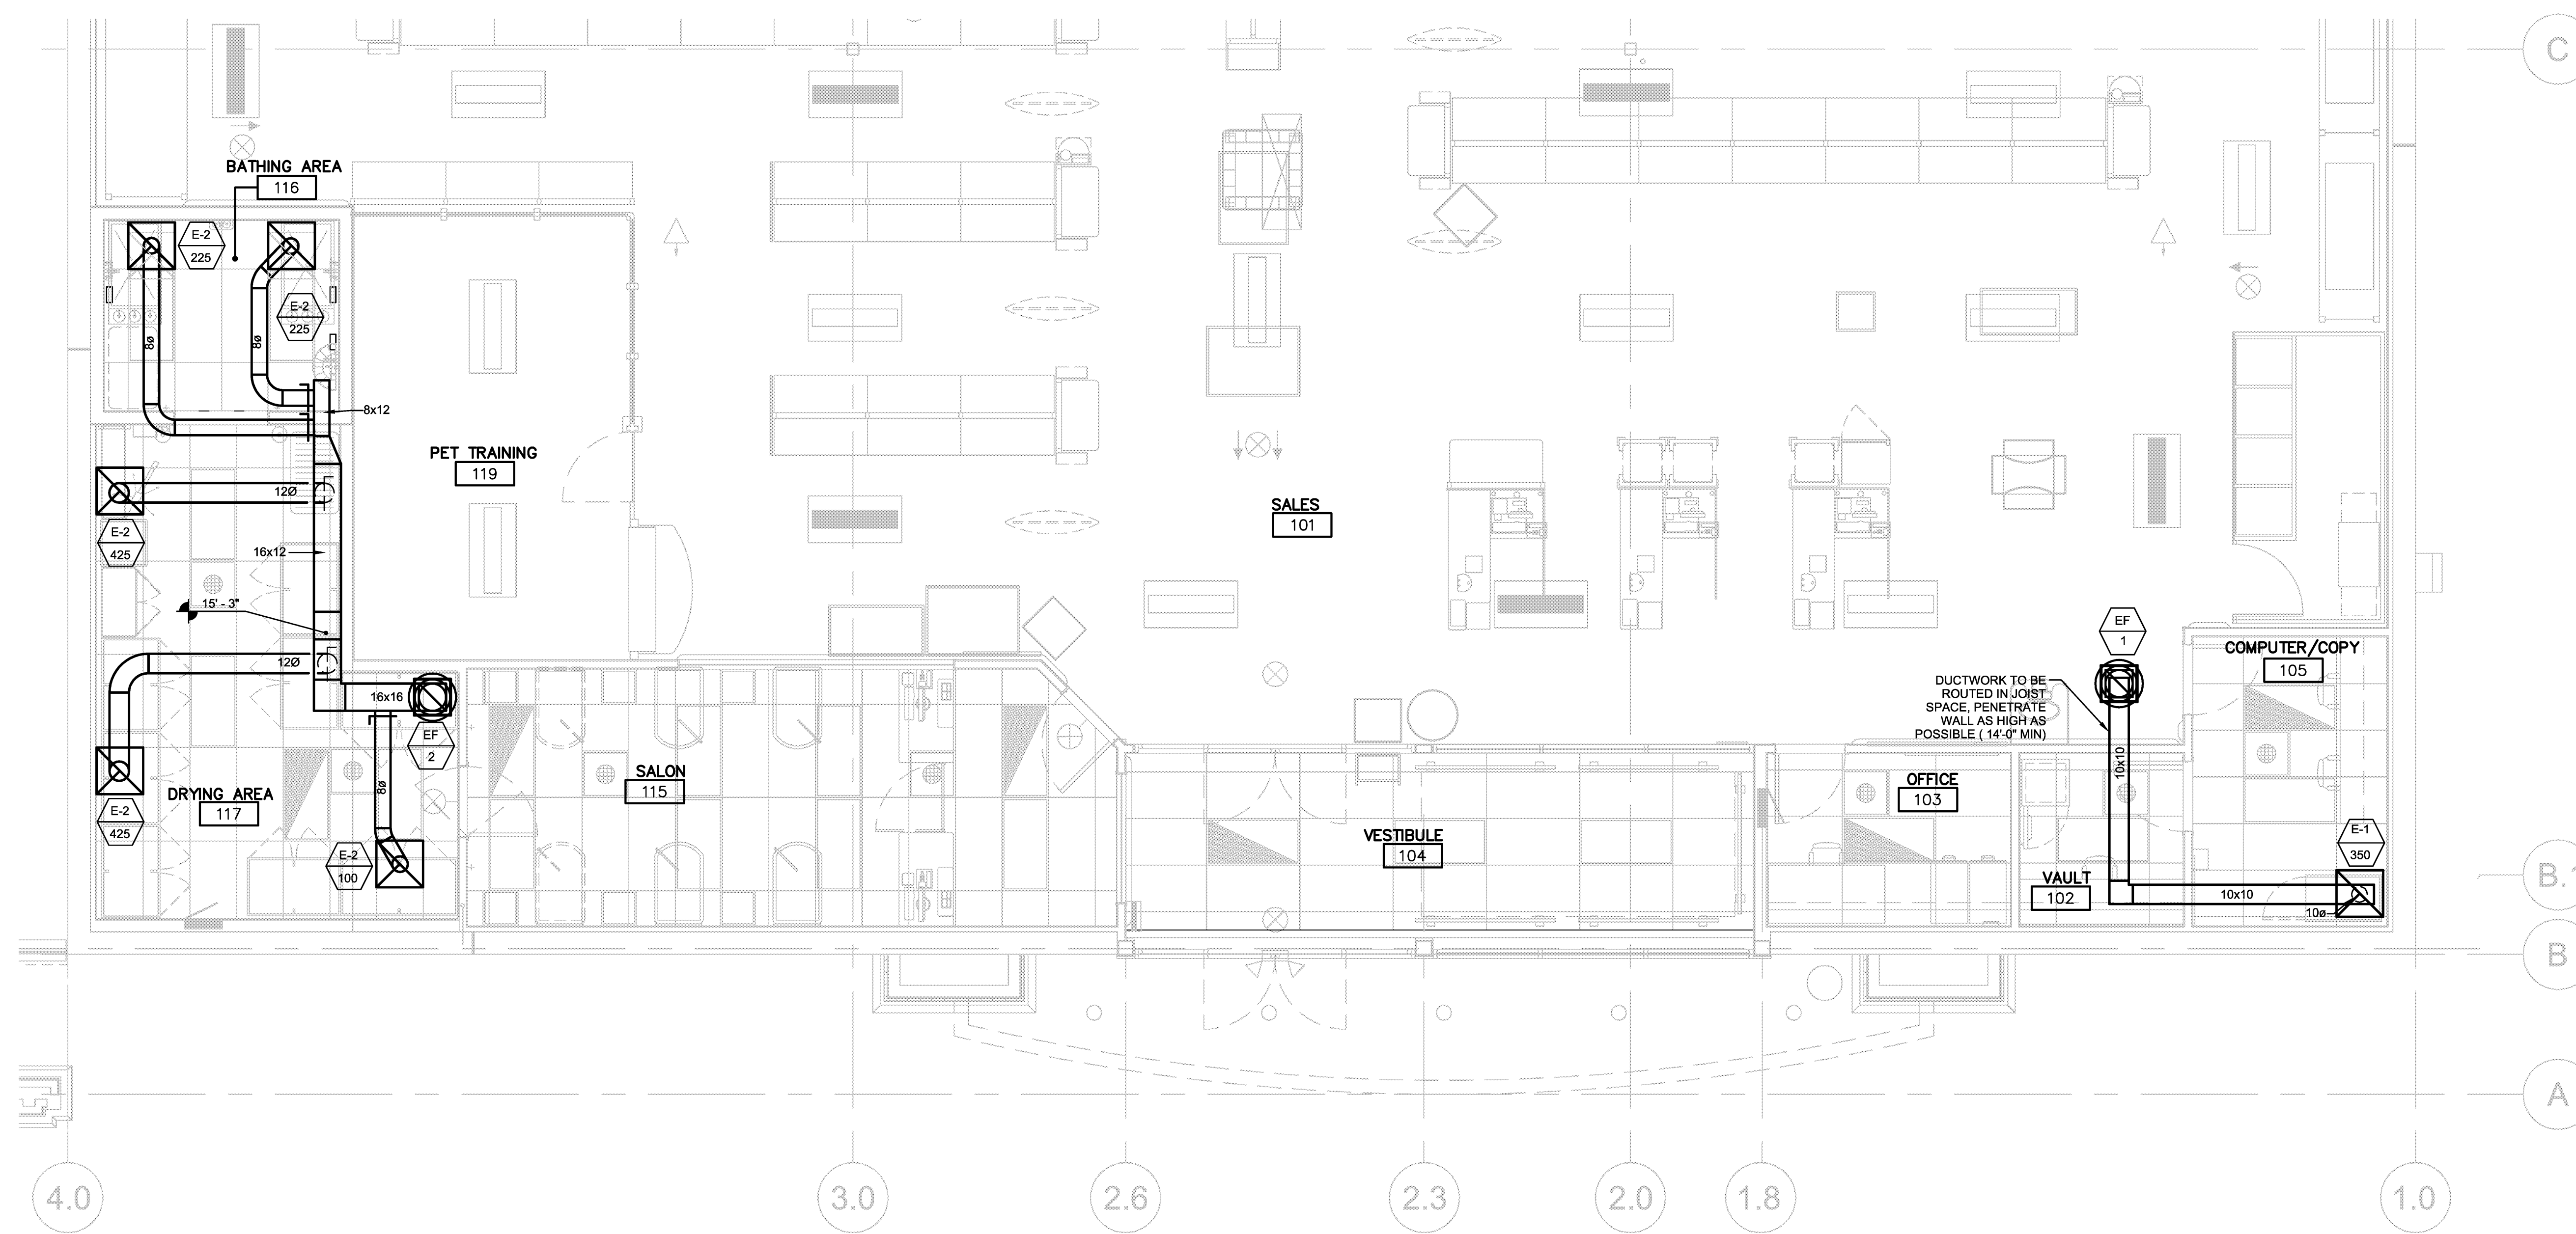

2 ENLARGED MECHANICAL SALON / OFFICE EXHAUST PLAN
 M1.1 SCALE: 1/4" = 1'-0" NORTH

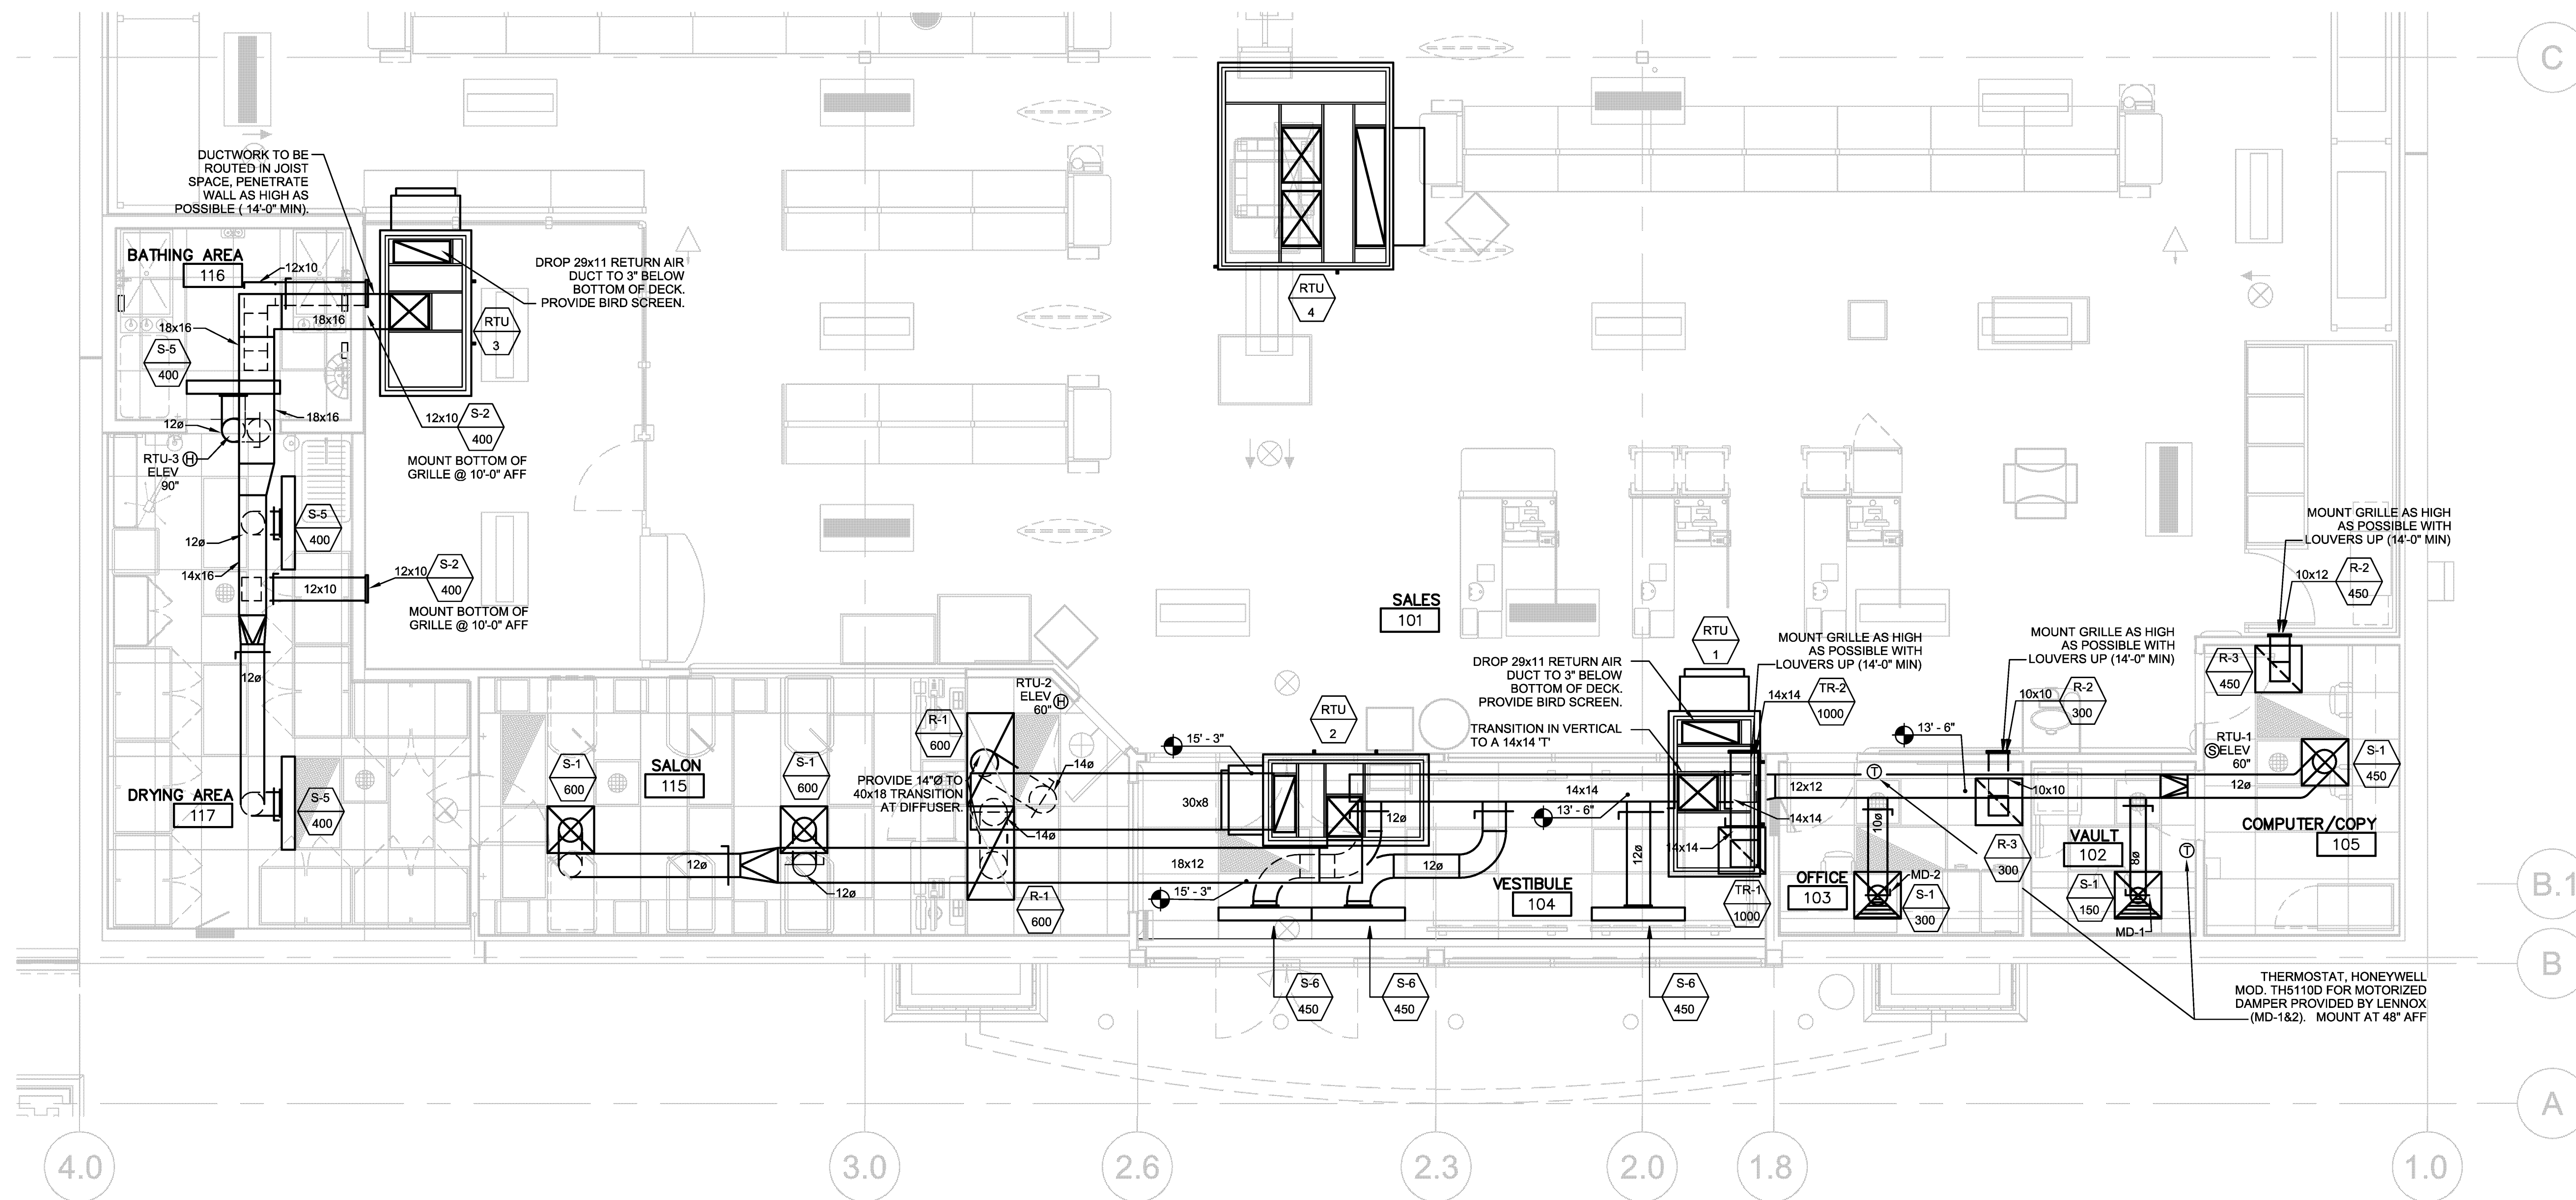

1 ENLARGED MECHANICAL SALON / OFFICE HVAC PLAN
 M1.1 SCALE: 1/4" = 1'-0" NORTH

NO:	ISSUE:	DATE:
	ISSUE FOR PERMIT	APRIL 15, 2013

ROBERT M. LUCIUS, ARCHITECT
 1200 Marshall St.
 NE Minneapolis, MN 55413
 612.677.7100
 612.677.7499
 www.rmlarch.com

DUNHAM
 Dunham Associates, Inc.
 50 South River Street, Suite 1100
 Minneapolis, Minnesota 55402-1945
 phone 612.682.3500 fax 612.682.7001
 www.dunhamcorp.com
 mechanical • electrical consulting engineering

Job No:
0413995-081

Scale: 1/4"=1'-0"
 Drawn: -
 Checked: -
M1.1