



ENLARGED FLOOR PLANS
STORE NUMBER 2274
FREMAUX TOWN CENTER
SLIDELL, LOUISIANA

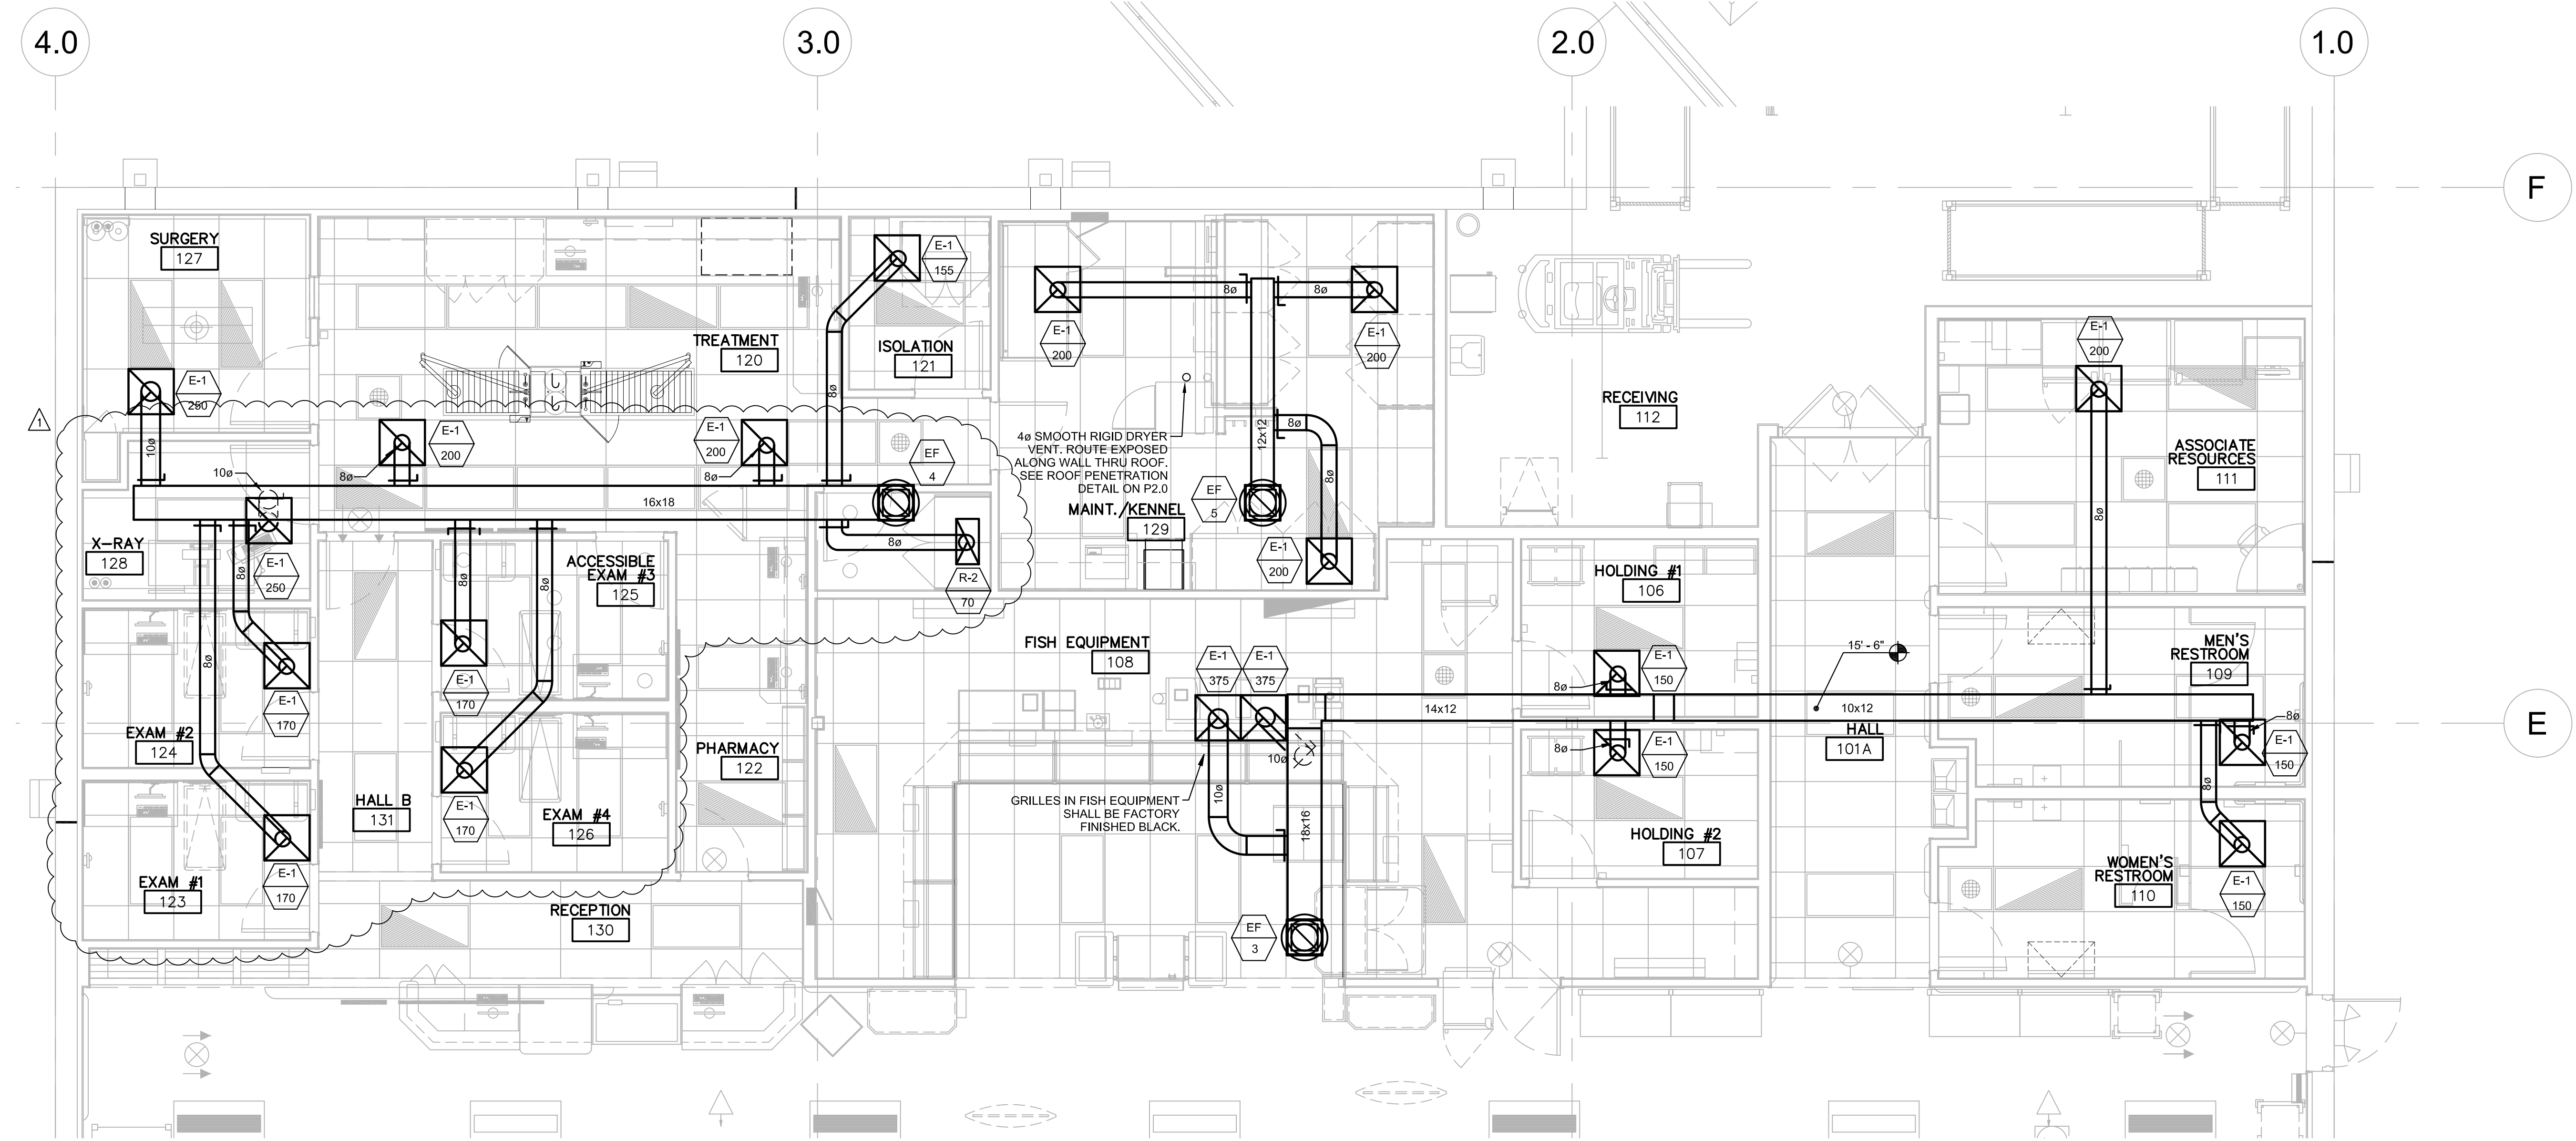

2 ENLARGED RESTROOM / FISH AREA EXHAUST PLAN
 M1.2 SCALE: 1/4" = 1'-0" NORTH

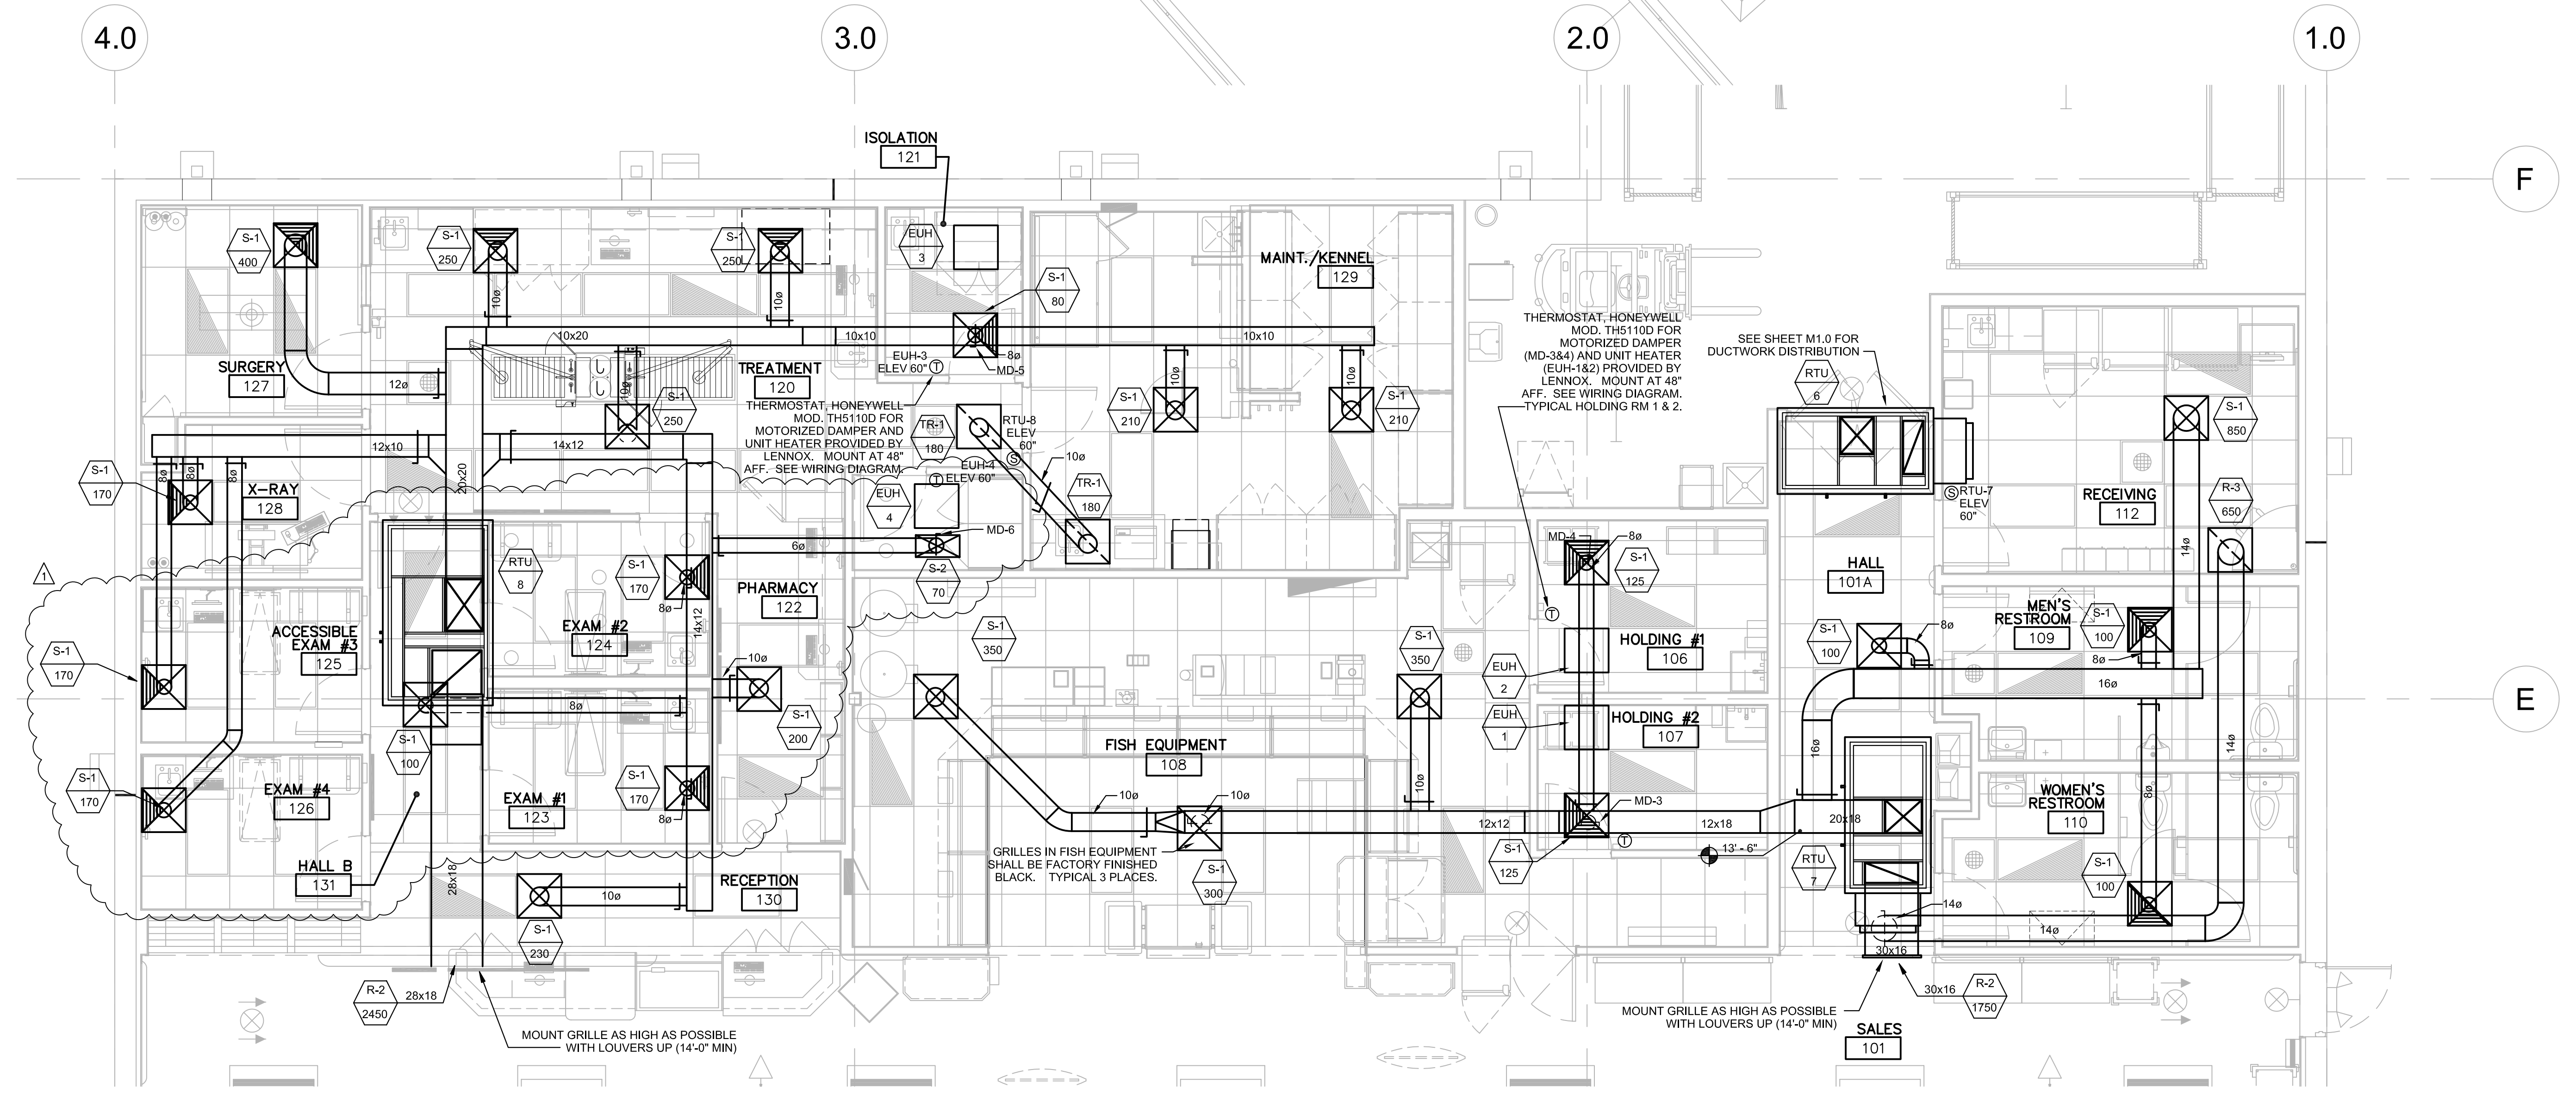

1 ENLARGED RESTROOM / FISH AREA HVAC PLAN
 M1.2 SCALE: 1/4" = 1'-0" NORTH

DATE:	APRIL 15, 2013
ISSUE:	ISSUE FOR PERMIT
NO.:	CONSTRUCTION CHANGE DIRECTIVE #1 09/06/13

ROBERT M. LUCIUS, ARCHITECT
 1200 Marshall St.
 NE Minneapolis, MN 55413
 612.677.7100
 612.677.7499
 www.rmla.com

DUNHAM
 Dunham Associates, Inc.
 95 South River Street, Suite 100
 Minneapolis, Minnesota 55402-1640
 phone 612.485.7500 fax 612.485.7911
 www.dunhamcorp.com
 mechanical • electrical consulting engineering

Job No: **0413995-081**
 Sheet No: **M1.2**
 Scale: As Indicated
 Drawn: -
 Checked: -