



DAMMON
ENGINEERING, INC.
EMMETT
DAMMON

ARCHITECT
ROBERT
SOLBERGER

1095 FLORIDA AVENUE
SLIDELL, LA. 70458
985-649-5832

WEBSITE:
WWW.DAMMONENGINEERING.COM
EMAIL:
DAMMONENG@BELLSOUTH.NET

ARCHITECTURE
ENGINEERING
STUDIES
PLANNING
INVESTIGATION
EXPERT WITNESS

**NEW OFFICE
BUILDING**

PLATFORM CRANE
POWELL DRIVE
SLIDELL, LA

**ELECTRICAL
PLAN
SUITE C**

REV:

SCALE: AS NOTED


JOB#: 1898

DATE: 10-8-07

SHEET 21

E-3

OF 25

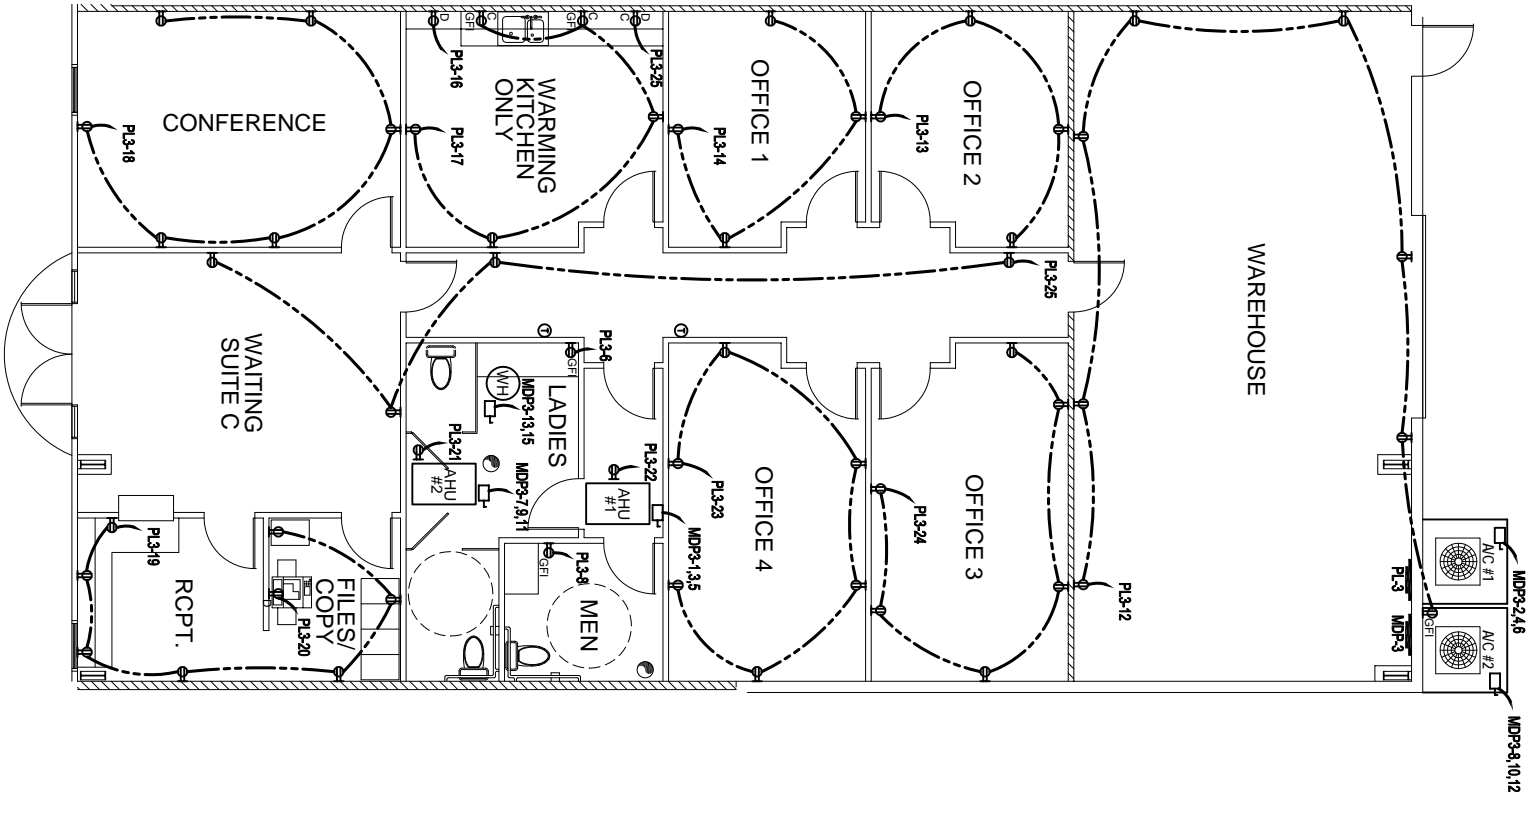

POWER PLAN SUITE C
SCALE: 3/16"=1'-0"

- LEGEND**
- 2x4 RECESSED FLUORESCENT LAMP, STEEL HOUSING
 - ⚡ EMERGENCY LIGHT WITH 90 MIN. BATTERY BACKUP
 - ⊕ 120V, 20A DUPLEX RECEPTACLE
 - ⊕ 120V, 20A DUPLEX RECEPTACLE
 - ⊕ 120V, GFI RECEPTACLE
 - ⊕ 120V, GFI RECEPTACLE AT COUNTER HEIGHT
 - ⊕ DISCONNECT
 - ⊕ POWER PANEL
 - ⊕ SWITCH
 - ⊕ 3-WAY SWITCH
 - ⊕ EXIT LIGHT, 90 MINUTE BATTERY BACK-UP
 - ⊕ THERMOSTAT
 - ⊕ HIGH BAY LIGHT
 - ⊕ TELEPHONE / COMPUTER
 - ⊕ EXHAUST FAN
 - ⊕ 20 GAL WATER HEATER
 - ⊕ PULL STRING LIGHT
 - ⊕ EXTERIOR WATERPROOF WALL MOUNTED LIGHT W/ 90 MIN. BATTERY BACKUP

FOR ELECTRICAL
NOTES SEE E-5

PANEL SCHEDULE


LOCATION: SUITE C
FEDERATION: MDP-3

NO.	TYPE	DESCRIPTION	AMP	VOLTS	PHASE	TERMINALS	REMARKS
1	MDP-3-1.1	MDP-3-1.1	100	120	3	40	MDP-3-1.1
2	MDP-3-1.2	MDP-3-1.2	100	120	3	40	MDP-3-1.2
3	MDP-3-1.3	MDP-3-1.3	100	120	3	40	MDP-3-1.3
4	MDP-3-1.4	MDP-3-1.4	100	120	3	40	MDP-3-1.4
5	MDP-3-1.5	MDP-3-1.5	100	120	3	40	MDP-3-1.5
6	MDP-3-1.6	MDP-3-1.6	100	120	3	40	MDP-3-1.6
7	MDP-3-1.7	MDP-3-1.7	100	120	3	40	MDP-3-1.7
8	MDP-3-1.8	MDP-3-1.8	100	120	3	40	MDP-3-1.8
9	MDP-3-1.9	MDP-3-1.9	100	120	3	40	MDP-3-1.9
10	MDP-3-1.10	MDP-3-1.10	100	120	3	40	MDP-3-1.10
11	MDP-3-1.11	MDP-3-1.11	100	120	3	40	MDP-3-1.11
12	MDP-3-1.12	MDP-3-1.12	100	120	3	40	MDP-3-1.12
13	MDP-3-1.13	MDP-3-1.13	100	120	3	40	MDP-3-1.13
14	MDP-3-1.14	MDP-3-1.14	100	120	3	40	MDP-3-1.14
15	MDP-3-1.15	MDP-3-1.15	100	120	3	40	MDP-3-1.15
16	MDP-3-1.16	MDP-3-1.16	100	120	3	40	MDP-3-1.16
17	MDP-3-1.17	MDP-3-1.17	100	120	3	40	MDP-3-1.17
18	MDP-3-1.18	MDP-3-1.18	100	120	3	40	MDP-3-1.18
19	MDP-3-1.19	MDP-3-1.19	100	120	3	40	MDP-3-1.19
20	MDP-3-1.20	MDP-3-1.20	100	120	3	40	MDP-3-1.20
21	MDP-3-1.21	MDP-3-1.21	100	120	3	40	MDP-3-1.21
22	MDP-3-1.22	MDP-3-1.22	100	120	3	40	MDP-3-1.22
23	MDP-3-1.23	MDP-3-1.23	100	120	3	40	MDP-3-1.23
24	MDP-3-1.24	MDP-3-1.24	100	120	3	40	MDP-3-1.24
25	MDP-3-1.25	MDP-3-1.25	100	120	3	40	MDP-3-1.25
26	MDP-3-1.26	MDP-3-1.26	100	120	3	40	MDP-3-1.26
27	MDP-3-1.27	MDP-3-1.27	100	120	3	40	MDP-3-1.27
28	MDP-3-1.28	MDP-3-1.28	100	120	3	40	MDP-3-1.28
29	MDP-3-1.29	MDP-3-1.29	100	120	3	40	MDP-3-1.29
30	MDP-3-1.30	MDP-3-1.30	100	120	3	40	MDP-3-1.30
31	MDP-3-1.31	MDP-3-1.31	100	120	3	40	MDP-3-1.31
32	MDP-3-1.32	MDP-3-1.32	100	120	3	40	MDP-3-1.32
33	MDP-3-1.33	MDP-3-1.33	100	120	3	40	MDP-3-1.33
34	MDP-3-1.34	MDP-3-1.34	100	120	3	40	MDP-3-1.34
35	MDP-3-1.35	MDP-3-1.35	100	120	3	40	MDP-3-1.35
36	MDP-3-1.36	MDP-3-1.36	100	120	3	40	MDP-3-1.36
37	MDP-3-1.37	MDP-3-1.37	100	120	3	40	MDP-3-1.37
38	MDP-3-1.38	MDP-3-1.38	100	120	3	40	MDP-3-1.38
39	MDP-3-1.39	MDP-3-1.39	100	120	3	40	MDP-3-1.39
40	MDP-3-1.40	MDP-3-1.40	100	120	3	40	MDP-3-1.40
41	MDP-3-1.41	MDP-3-1.41	100	120	3	40	MDP-3-1.41
42	MDP-3-1.42	MDP-3-1.42	100	120	3	40	MDP-3-1.42
43	MDP-3-1.43	MDP-3-1.43	100	120	3	40	MDP-3-1.43
44	MDP-3-1.44	MDP-3-1.44	100	120	3	40	MDP-3-1.44

PANEL SCHEDULE

LOCATION: SUITE C
FEDERATION: MDP-3

NO.	TYPE	DESCRIPTION	AMP	VOLTS	PHASE	TERMINALS	REMARKS
1	MDP-3-1.1	MDP-3-1.1	100	120	3	40	MDP-3-1.1
2	MDP-3-1.2	MDP-3-1.2	100	120	3	40	MDP-3-1.2
3	MDP-3-1.3	MDP-3-1.3	100	120	3	40	MDP-3-1.3
4	MDP-3-1.4	MDP-3-1.4	100	120	3	40	MDP-3-1.4
5	MDP-3-1.5	MDP-3-1.5	100	120	3	40	MDP-3-1.5
6	MDP-3-1.6	MDP-3-1.6	100	120	3	40	MDP-3-1.6
7	MDP-3-1.7	MDP-3-1.7	100	120	3	40	MDP-3-1.7
8	MDP-3-1.8	MDP-3-1.8	100	120	3	40	MDP-3-1.8
9	MDP-3-1.9	MDP-3-1.9	100	120	3	40	MDP-3-1.9
10	MDP-3-1.10	MDP-3-1.10	100	120	3	40	MDP-3-1.10
11	MDP-3-1.11	MDP-3-1.11	100	120	3	40	MDP-3-1.11
12	MDP-3-1.12	MDP-3-1.12	100	120	3	40	MDP-3-1.12
13	MDP-3-1.13	MDP-3-1.13	100	120	3	40	MDP-3-1.13
14	MDP-3-1.14	MDP-3-1.14	100	120	3	40	MDP-3-1.14
15	MDP-3-1.15	MDP-3-1.15	100	120	3	40	MDP-3-1.15
16	MDP-3-1.16	MDP-3-1.16	100	120	3	40	MDP-3-1.16
17	MDP-3-1.17	MDP-3-1.17	100	120	3	40	MDP-3-1.17
18	MDP-3-1.18	MDP-3-1.18	100	120	3	40	MDP-3-1.18
19	MDP-3-1.19	MDP-3-1.19	100	120	3	40	MDP-3-1.19
20	MDP-3-1.20	MDP-3-1.20	100	120	3	40	MDP-3-1.20
21	MDP-3-1.21	MDP-3-1.21	100	120	3	40	MDP-3-1.21
22	MDP-3-1.22	MDP-3-1.22	100	120	3	40	MDP-3-1.22
23	MDP-3-1.23	MDP-3-1.23	100	120	3	40	MDP-3-1.23
24	MDP-3-1.24	MDP-3-1.24	100	120	3	40	MDP-3-1.24
25	MDP-3-1.25	MDP-3-1.25	100	120	3	40	MDP-3-1.25
26	MDP-3-1.26	MDP-3-1.26	100	120	3	40	MDP-3-1.26
27	MDP-3-1.27	MDP-3-1.27	100	120	3	40	MDP-3-1.27
28	MDP-3-1.28	MDP-3-1.28	100	120	3	40	MDP-3-1.28
29	MDP-3-1.29	MDP-3-1.29	100	120	3	40	MDP-3-1.29
30	MDP-3-1.30	MDP-3-1.30	100	120	3	40	MDP-3-1.30
31	MDP-3-1.31	MDP-3-1.31	100	120	3	40	MDP-3-1.31
32	MDP-3-1.32	MDP-3-1.32	100	120	3	40	MDP-3-1.32
33	MDP-3-1.33	MDP-3-1.33	100	120	3	40	MDP-3-1.33
34	MDP-3-1.34	MDP-3-1.34	100	120	3	40	MDP-3-1.34
35	MDP-3-1.35	MDP-3-1.35	100	120	3	40	MDP-3-1.35
36	MDP-3-1.36	MDP-3-1.36	100	120	3	40	MDP-3-1.36
37	MDP-3-1.37	MDP-3-1.37	100	120	3	40	MDP-3-1.37
38	MDP-3-1.38	MDP-3-1.38	100	120	3	40	MDP-3-1.38
39	MDP-3-1.39	MDP-3-1.39	100	120	3	40	MDP-3-1.39
40	MDP-3-1.40	MDP-3-1.40	100	120	3	40	MDP-3-1.40
41	MDP-3-1.41	MDP-3-1.41	100	120	3	40	MDP-3-1.41
42	MDP-3-1.42	MDP-3-1.42	100	120	3	40	MDP-3-1.42
43	MDP-3-1.43	MDP-3-1.43	100	120	3	40	MDP-3-1.43
44	MDP-3-1.44	MDP-3-1.44	100	120	3	40	MDP-3-1.44

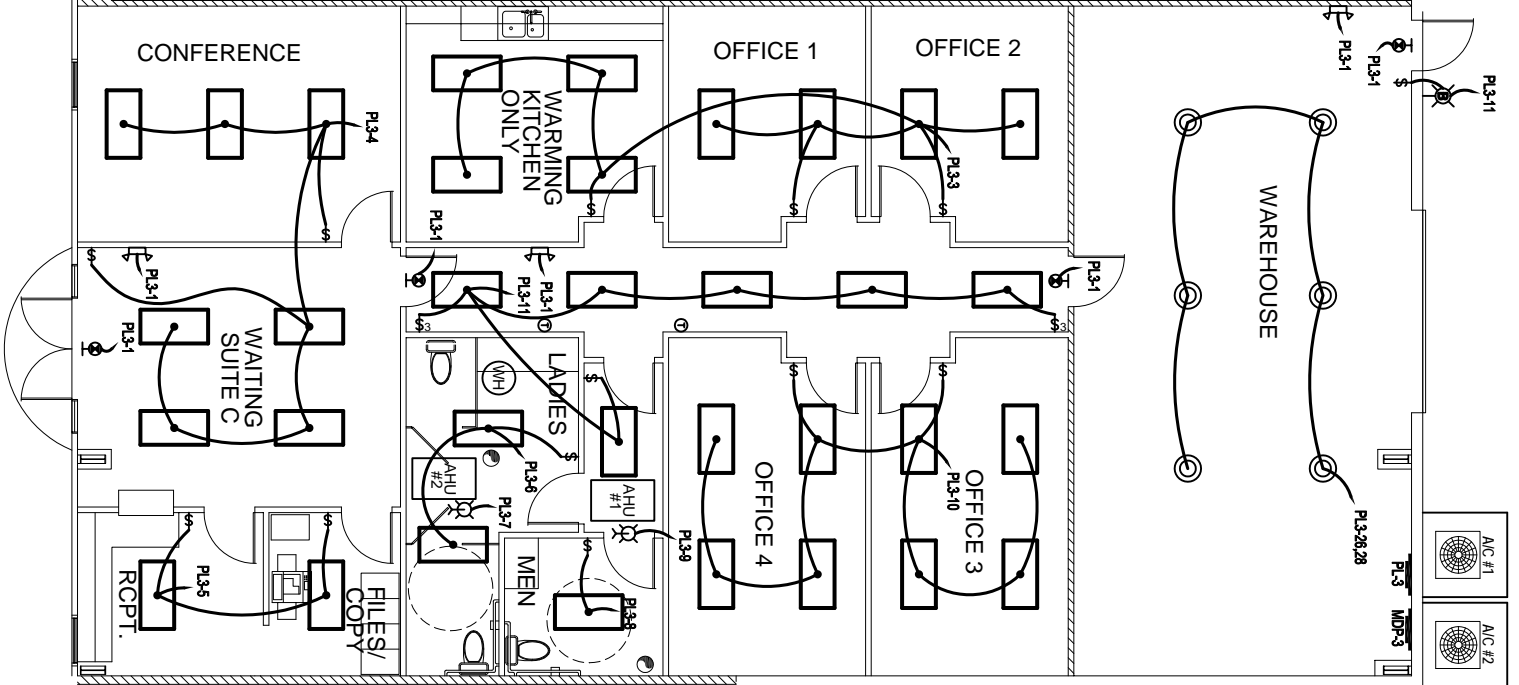

LIGHTING PLAN SUITE C
SCALE: 3/16"=1'-0"