

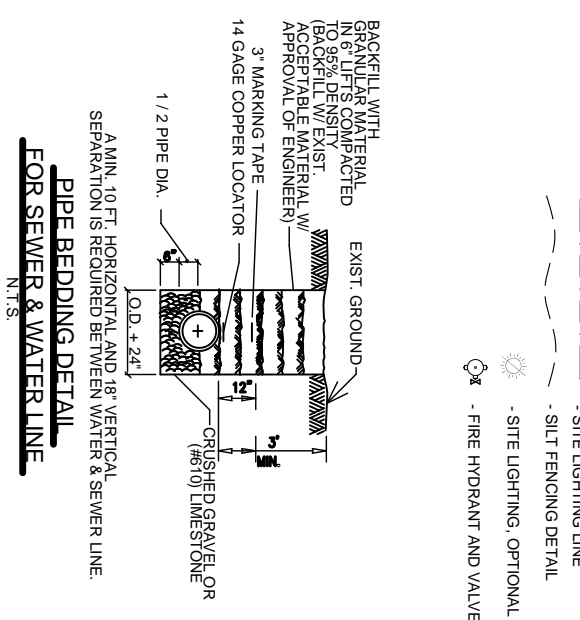


BM - "ALL" on FIRE HYDRANT
ELEVATION = 20.09' (NAVD88 GEOD03)

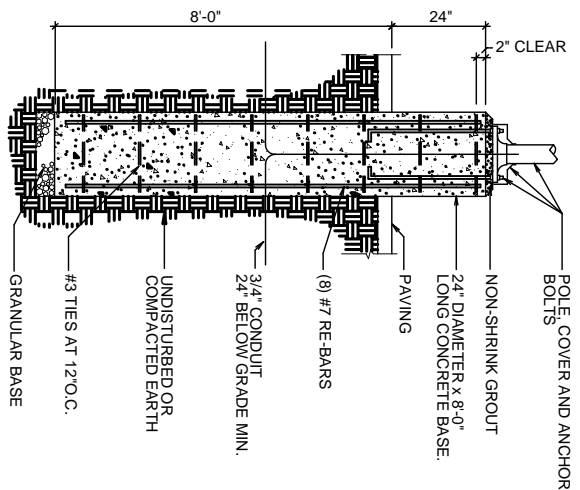

APPROXIMATE LOCATION OF
THE FLOOD ZONE LINE


FLOOD ZONE
FLOOD ZONE C

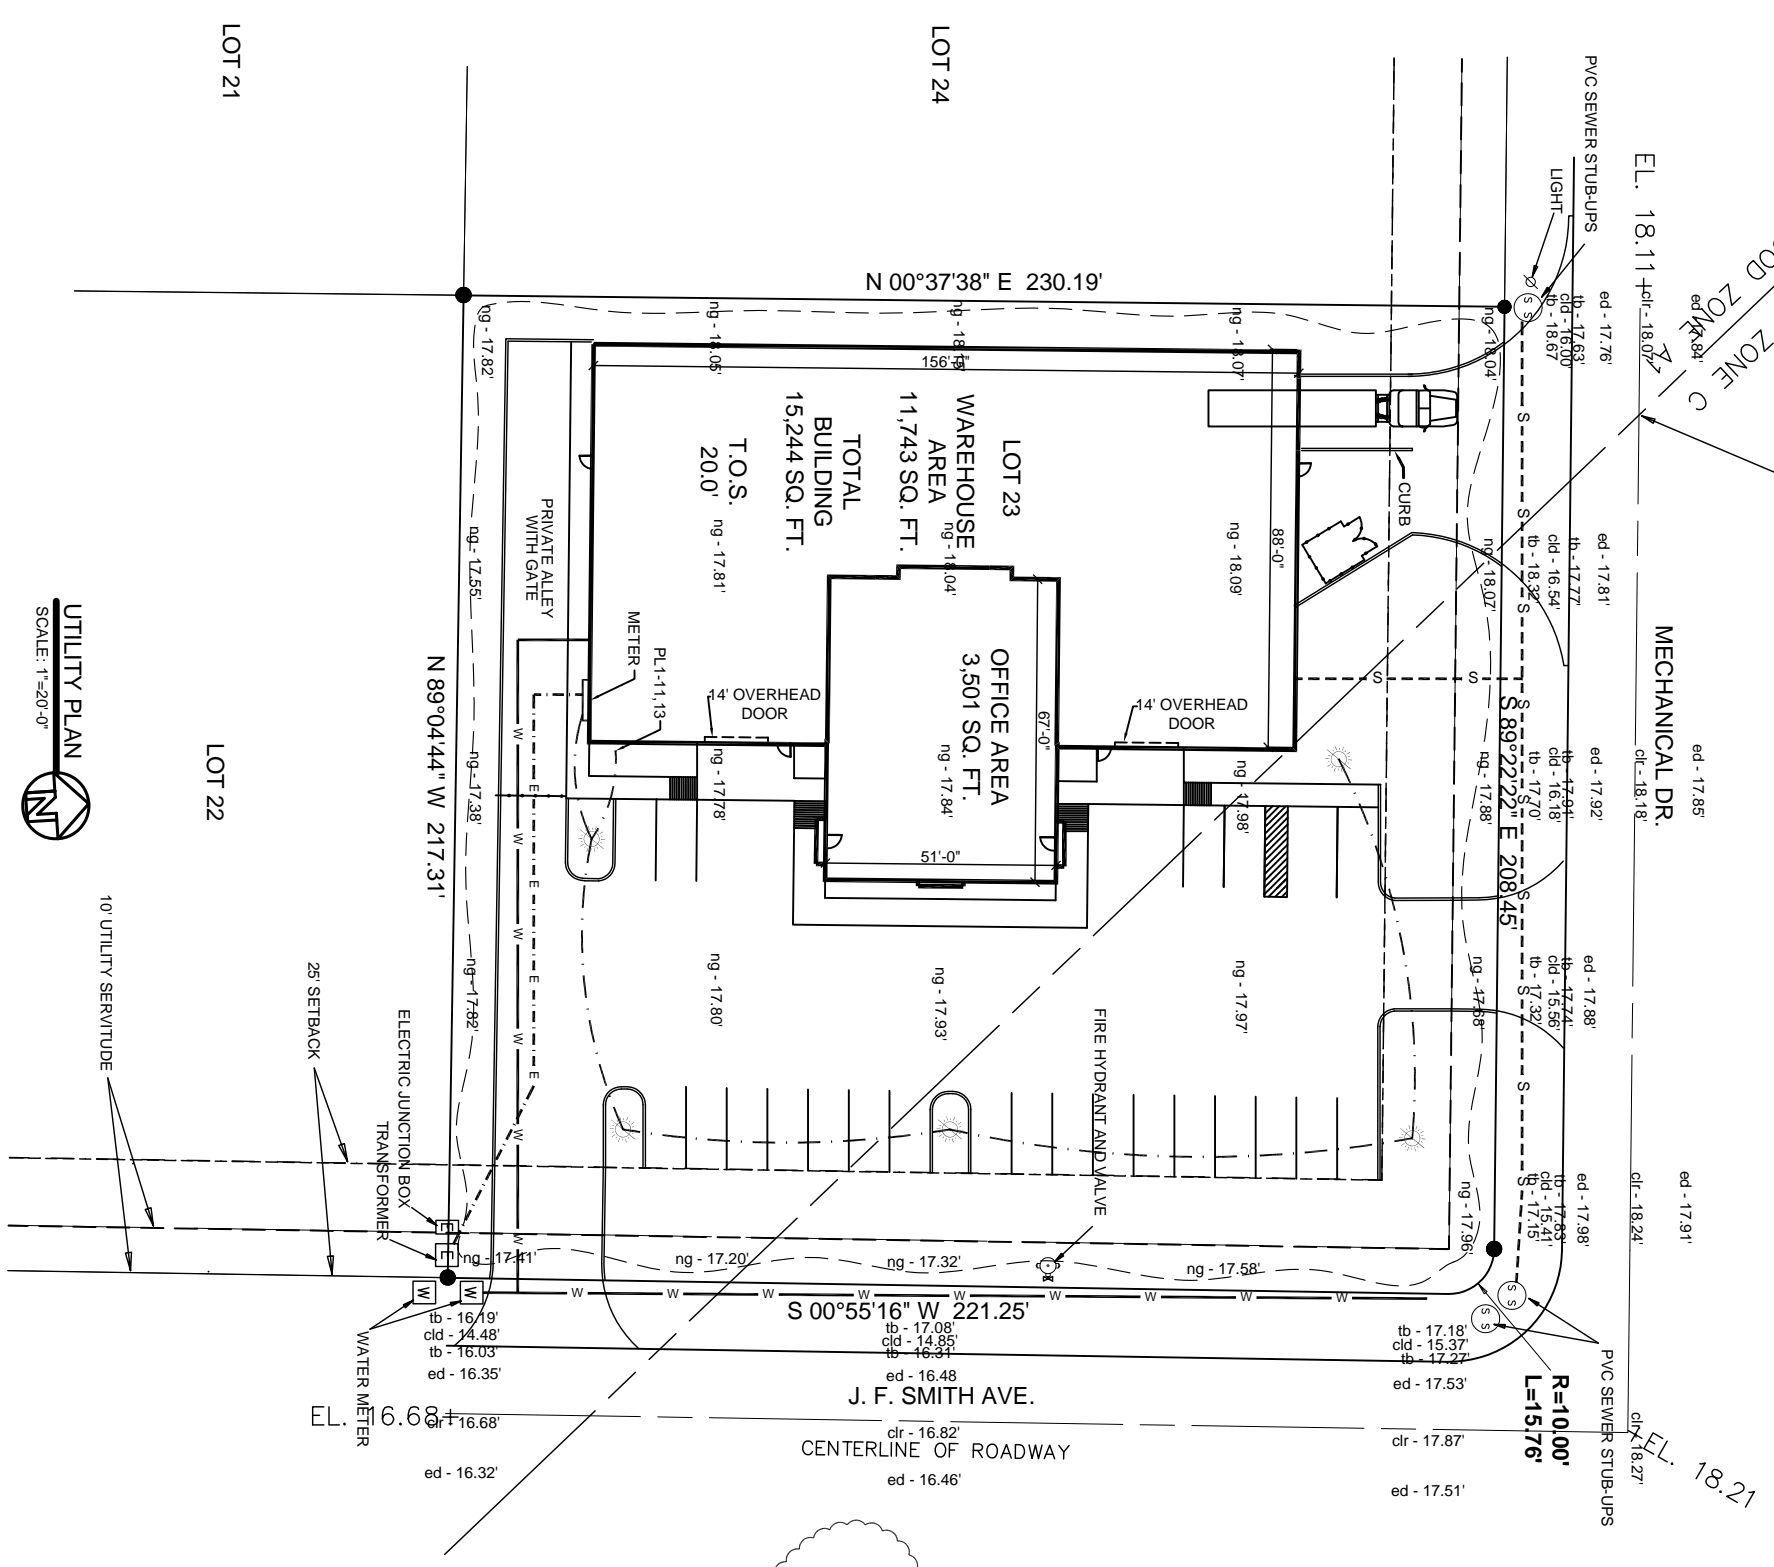

LEGEND

- - - - - PROPERTY LINE
- - - - - SETBACK
- - - - - NEW BUILDING OUTLINE
- - - - - SERVITUDE / EASEMENT
- - - - - NEW WATER LINE
- - - - - NEW SEWER LINE
- - - - - NEW POWER LINE
- - - - - SITE LIGHTING LINE
- - - - - SILT FENCING DETAIL
- - - - - SITE LIGHTING, OPTIONAL
- - - - - FIRE HYDRANT AND VALVE

VICK,
PLEASE SEE PARKING LOT LIGHTING
ON THIS SHEET. 7-3-08

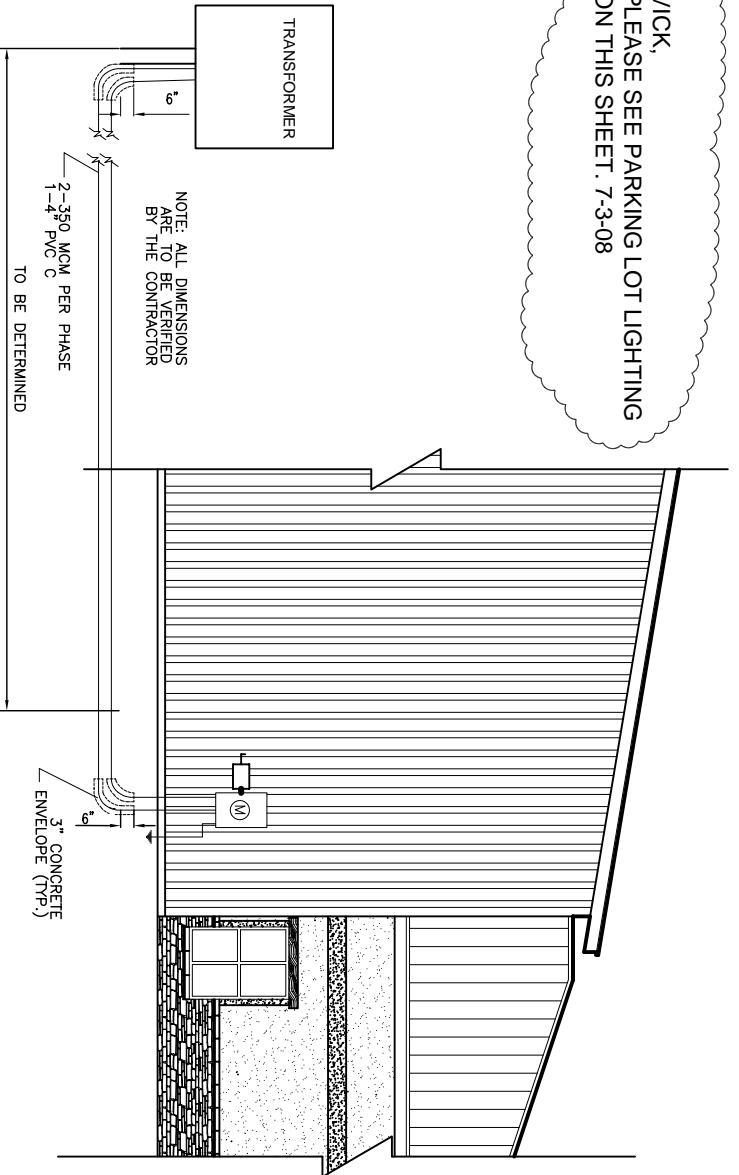

DAMMON
ENGINEERING, INC.
EMMETT
DAMMON

ARCHITECT
ROBERT
WILTSE

1095 FLORIDA AVENUE
SLIDELL, LA. 70458
985-649-5832

WEBSITE:
WWW.DAMMONENGINEERING.COM
EMAIL:
DAMMONENG@BELLSOUTH.NET

ARCHITECTURE
ENGINEERING
STUDIES
PLANNING
INVESTIGATION
EXPERT WITNESS

NEW OFFICE/
WAREHOUSE

O'BRIEN / NORTH
SHORE FLOORING
DISTRIBUTORS
J.F. SMITH AVE.
SLIDELL, LA

UTILITY
PLAN

REV: 1-17-08

SCALE: AS NOTED

JOB#:

DATE: 1-4-08

SHEET

C-4

OF

UTILITY PLAN
SCALE: 1"=20'-0"

