

DAMMON ENGINEERING, INC.

CHIEF ENGINEER
EMMETT
DAMMON, P.E.
CHIEF ARCHITECT
ROBERT
WILTSE


1095 FLORIDA AVENUE
SUDELL, LA. 70458
OFFICE: 985-649-5332
FAX: 985-641-5950

WEBSITE:
WWW.DAMMONENGINEERING.COM
EMAIL:
DAMMONENG@BELLSOUTH.NET


ARCHITECTURE
ENGINEERING
STUDIES
PLANNING
INVESTIGATION
EXPERT WITNESS

WINDWARD, INC.
37362
BROWNSVILLE RD.
SUDELL, LA. 70460

ELECTRICAL
LIGHTING
PLAN

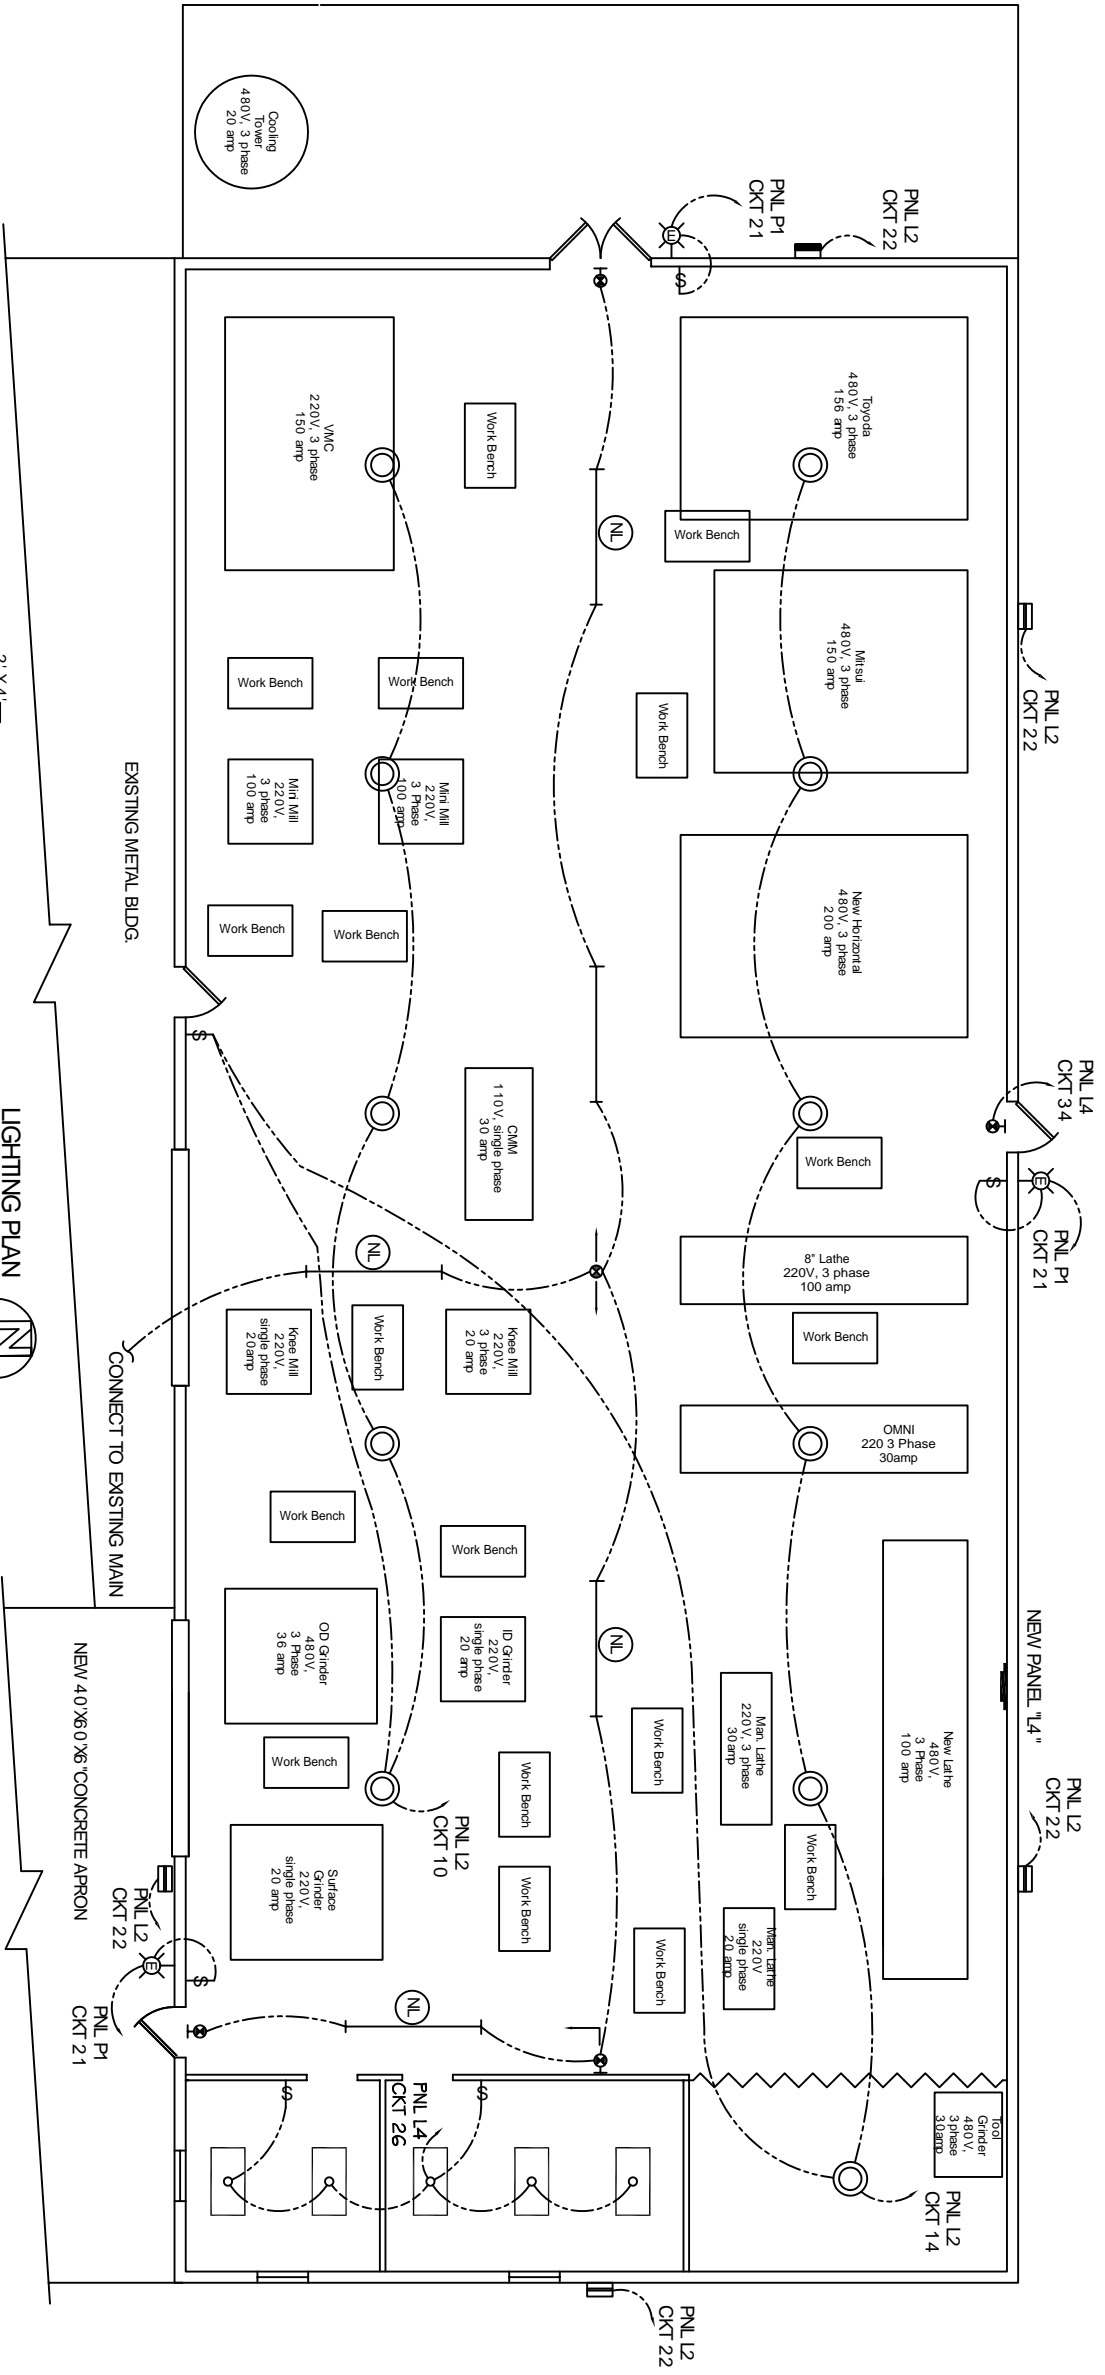

LIGHTING PLAN
SCALE 3/16" = 1'-0"

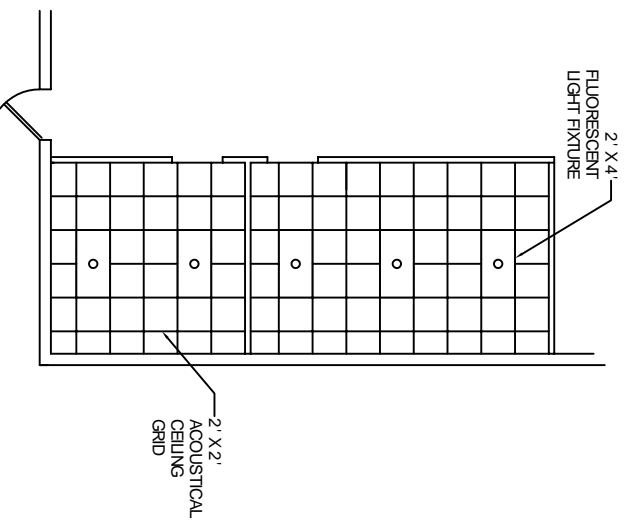

LEGEND

- ⚡ - EXTERNAL EMERGENCY LIGHT, W/90 MINUTE BATTERY BACK-UP
- ⌘ - EXTERIOR WALL MOUNTED LIGHT, WITH 90 MINUTE BACKUP
- ▬ - 250 WATT WALL PACK LIGHT
- ▬ - 400 WATT WALL PACK LIGHT
- ▬ - 8' FLUORESCENT STRIP WITH REFLECTORS
- ▬ - 4'-4FT T8 32 WATT LAMPS
- ▬ - 8' FLUORESCENT STRIP WITH REFLECTORS AS NIGHT LIGHT
- ▬ - 4'-4FT T8 32 WATT LAMPS W/BATTERY BACK UP
- ▬ - PANEL
- ⌘ - LIGHT SWITCH
- - 2' x 4' 4 LAMP LAMIN FLUORESCENT WITH ACRYLIC LENS
- - 250V HPS HIGH BAY LIGHT

OFFICE AREA REFLECTED CEILING PLAN
SCALE 3/16" = 1'-0"

SHEET 9

DATE: 07-18-08

JOB#: 1934A

SCALE: AS NOTED

REV:

OF 11

E-2