



LEGEND

- ⊕ - EXIT/EMERGENCY LIGHT, W/90 MINUTE BATTERY BACK-UP
- ⊕ - EXTERIOR WALL MOUNTED LIGHT, WITH 90 MINUTE BACKUP
- ☐ - 250 WATT WALL PACK LIGHT
- ☐ - 400 WATT WALL PACK LIGHT
- ☐ - 8' FLUORESCENT STRIP WITH REFLECTORS
- ☐ - 4- FT T8 32 WATT LAMPS
- ☐ - 8' FLUORESCENT STRIP WITH REFLECTORS AS NIGHT LIGHT
- ☐ - 4- FT T8 32 WATT LAMPS W/BATTERY BACK UP
- ☐ - PANEL
- ⊕ - LIGHT SWITCH

THIS AREA IS EXISTING AND TO REMAIN AS IS

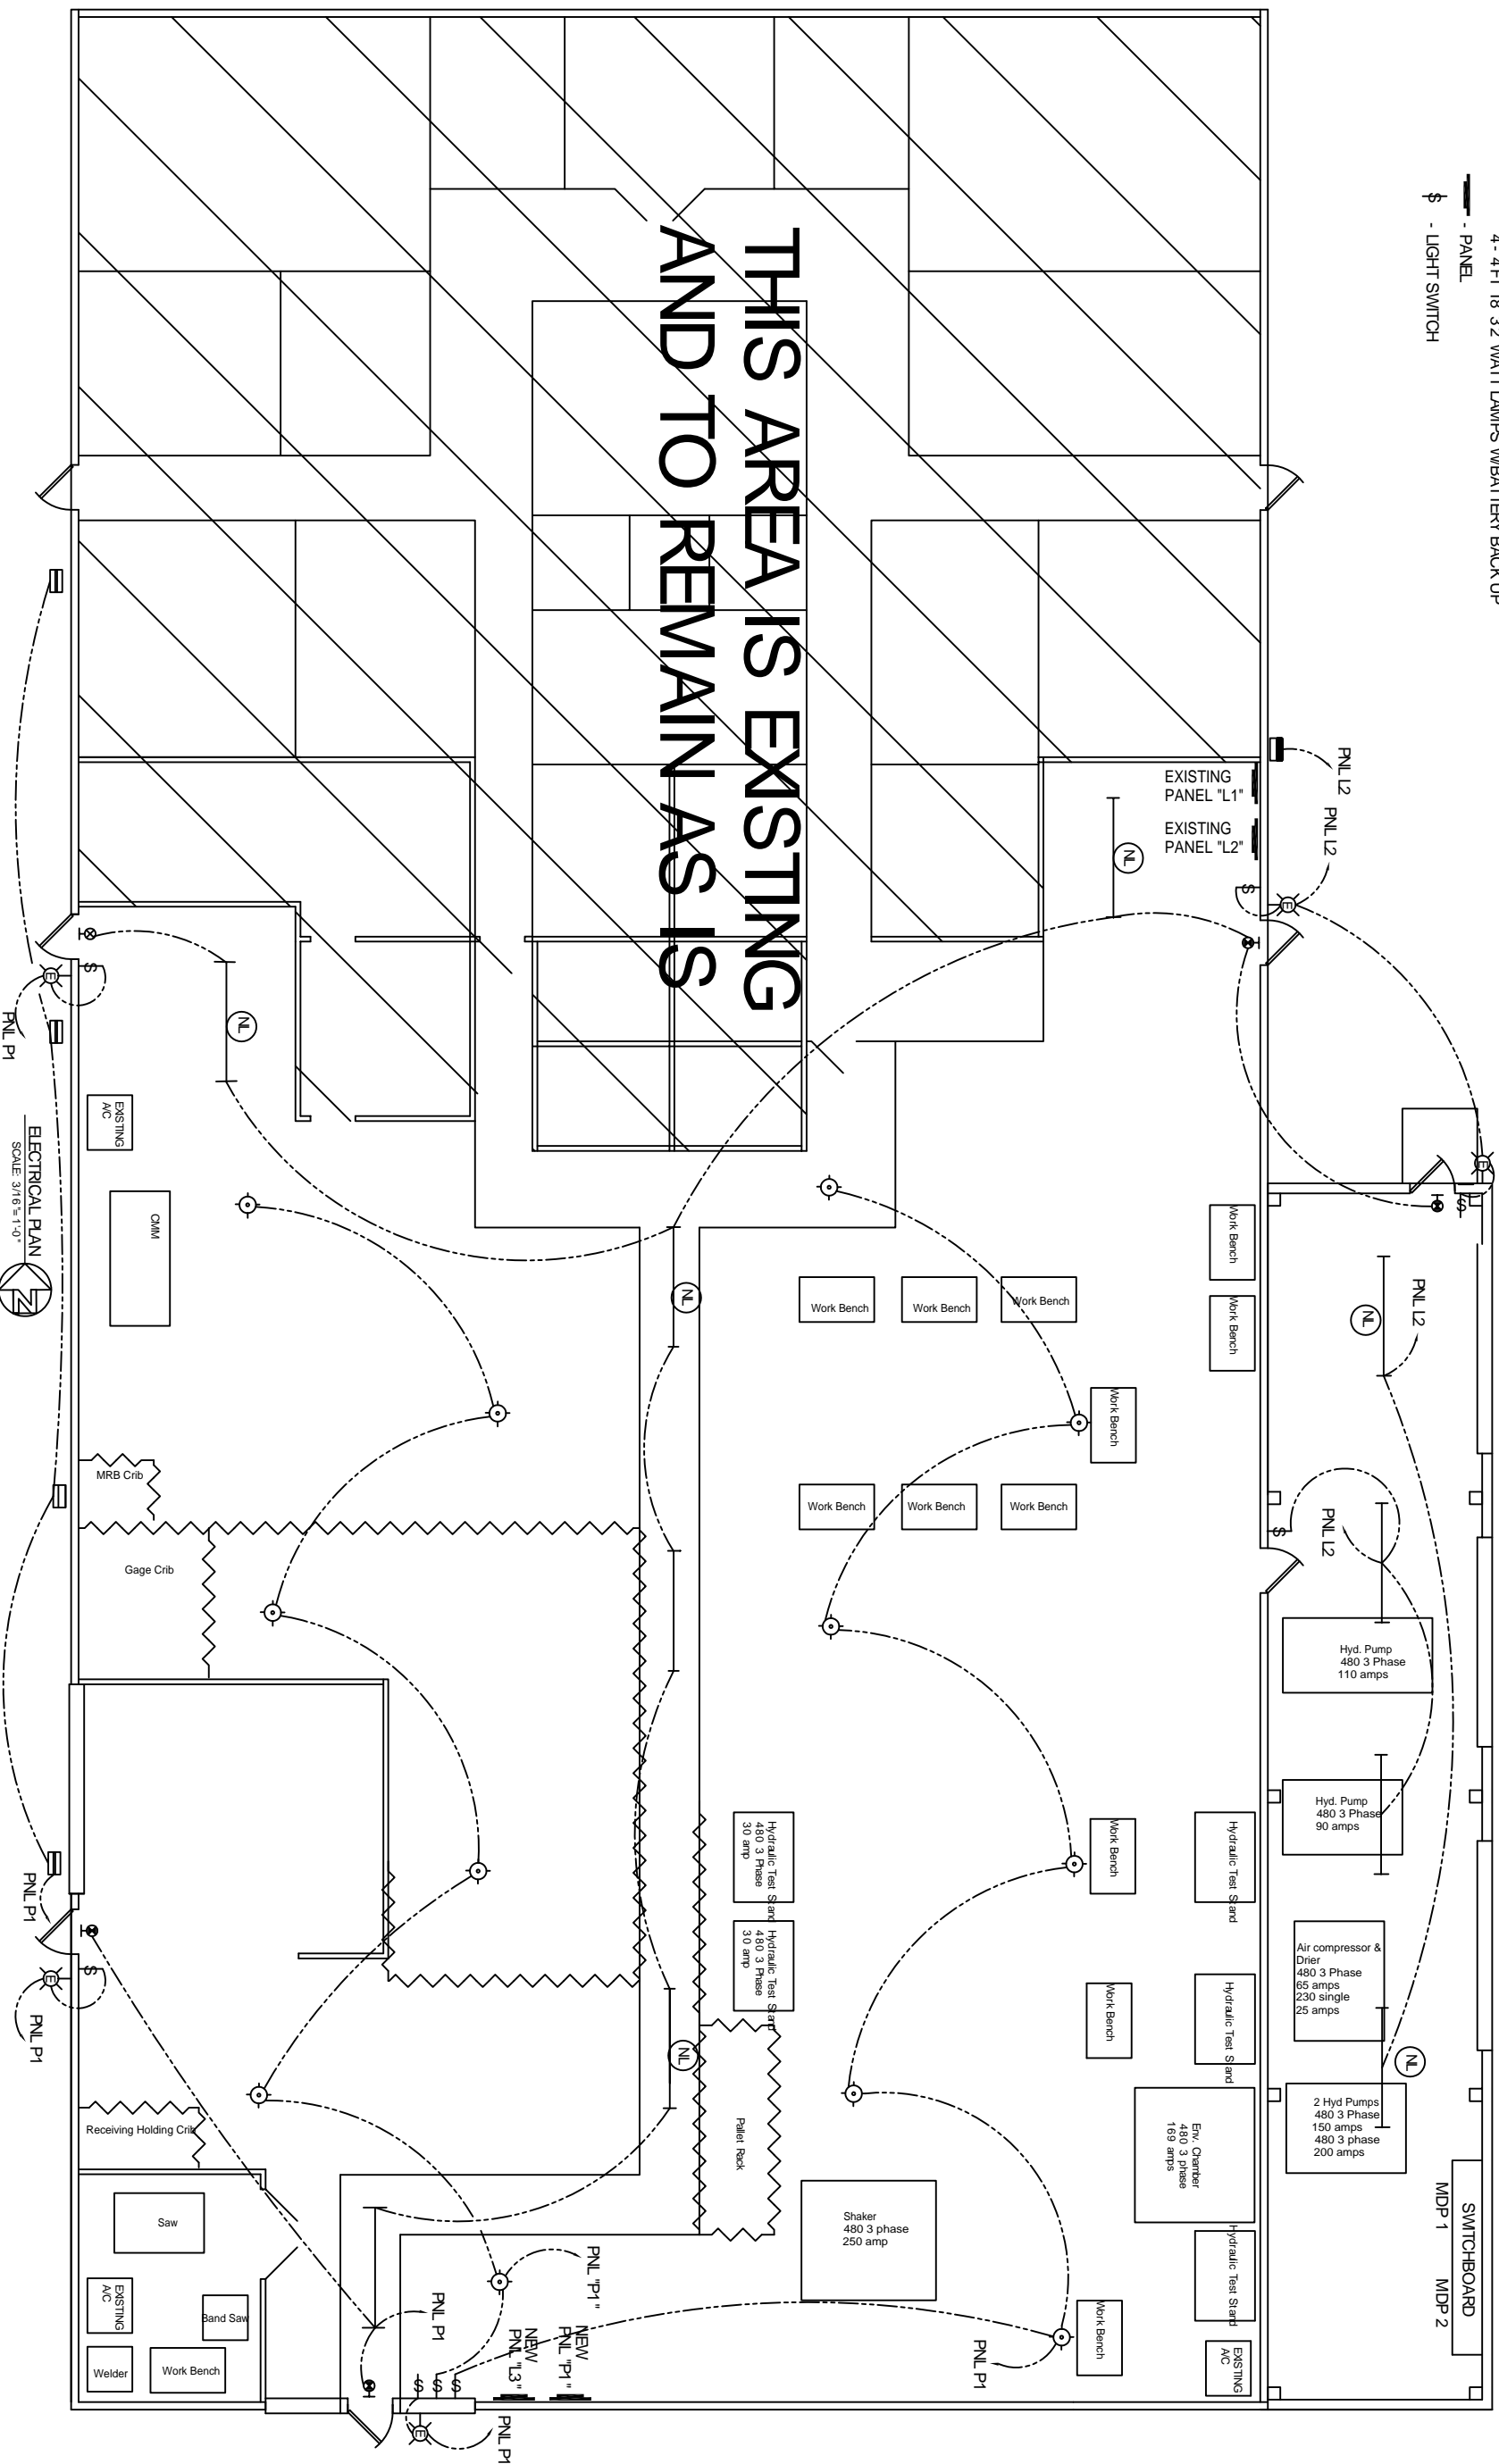

ELECTRICAL PLAN
SCALE: 3/16"=1'-0"

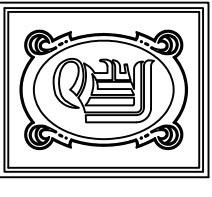

DAMMON
ENGINEERING, INC.

CHIEF ENGINEER
EMMETT
DAMMON, P. E.
CHIEF ARCHITECT
ROBERT
WILTSE

1095 FLORIDA AVENUE
SLIDELL, LA. 70459
OFFICE: 985-649-5832
FAX: 985-641-5950

WWW.DAMMONENGINEERING.COM
EMAIL: DAMMONING@DILLSOUTH.NET

ARCHITECTURE
ENGINEERING
STUDIES
PLANNING
INVESTIGATION
EXPERT WITNESS

WINDWARD, INC.
37362
BROWNSVILLE RD
SUDELL, LA. 70460

ELECTRICAL
LIGHTING
PLAN

REV:

SCALE: AS NOTED

JOB#: 1934

DATE: 04-04-08

SHEET 7

E-2

OF 8