

**DAMMON**  
ENGINEERING, INC.

CHIEF ENGINEER  
EMMETT  
DAMMON, P.E.  
CHIEF ARCHITECT  
ROBERT  
WILTSE

1095 FLORIDA AVENUE  
SLIDELL, LA. 70458  
OFFICE: 985-649-5832  
FAX: 985-641-5950

WEBSITE:  
WWW.DAMMONENGINEERING.COM  
EMAIL:  
DAMMONENG@BELLOUTH.NET

ARCHITECTURE  
ENGINEERING  
STUDIES  
PLANNING  
INVESTIGATION  
EXPERT WITNESS

NEW OFFICE/  
WAREHOUSE

GUASTELLA CONSTRUCTION  
LOT #10 TAOS STREET  
SLIDELL, LA 70458

MECHANICAL  
PLAN

REV:


SCALE AS NOTED

JOB#: 1572

DATE: 6-20-08

SHEET 15

M-1

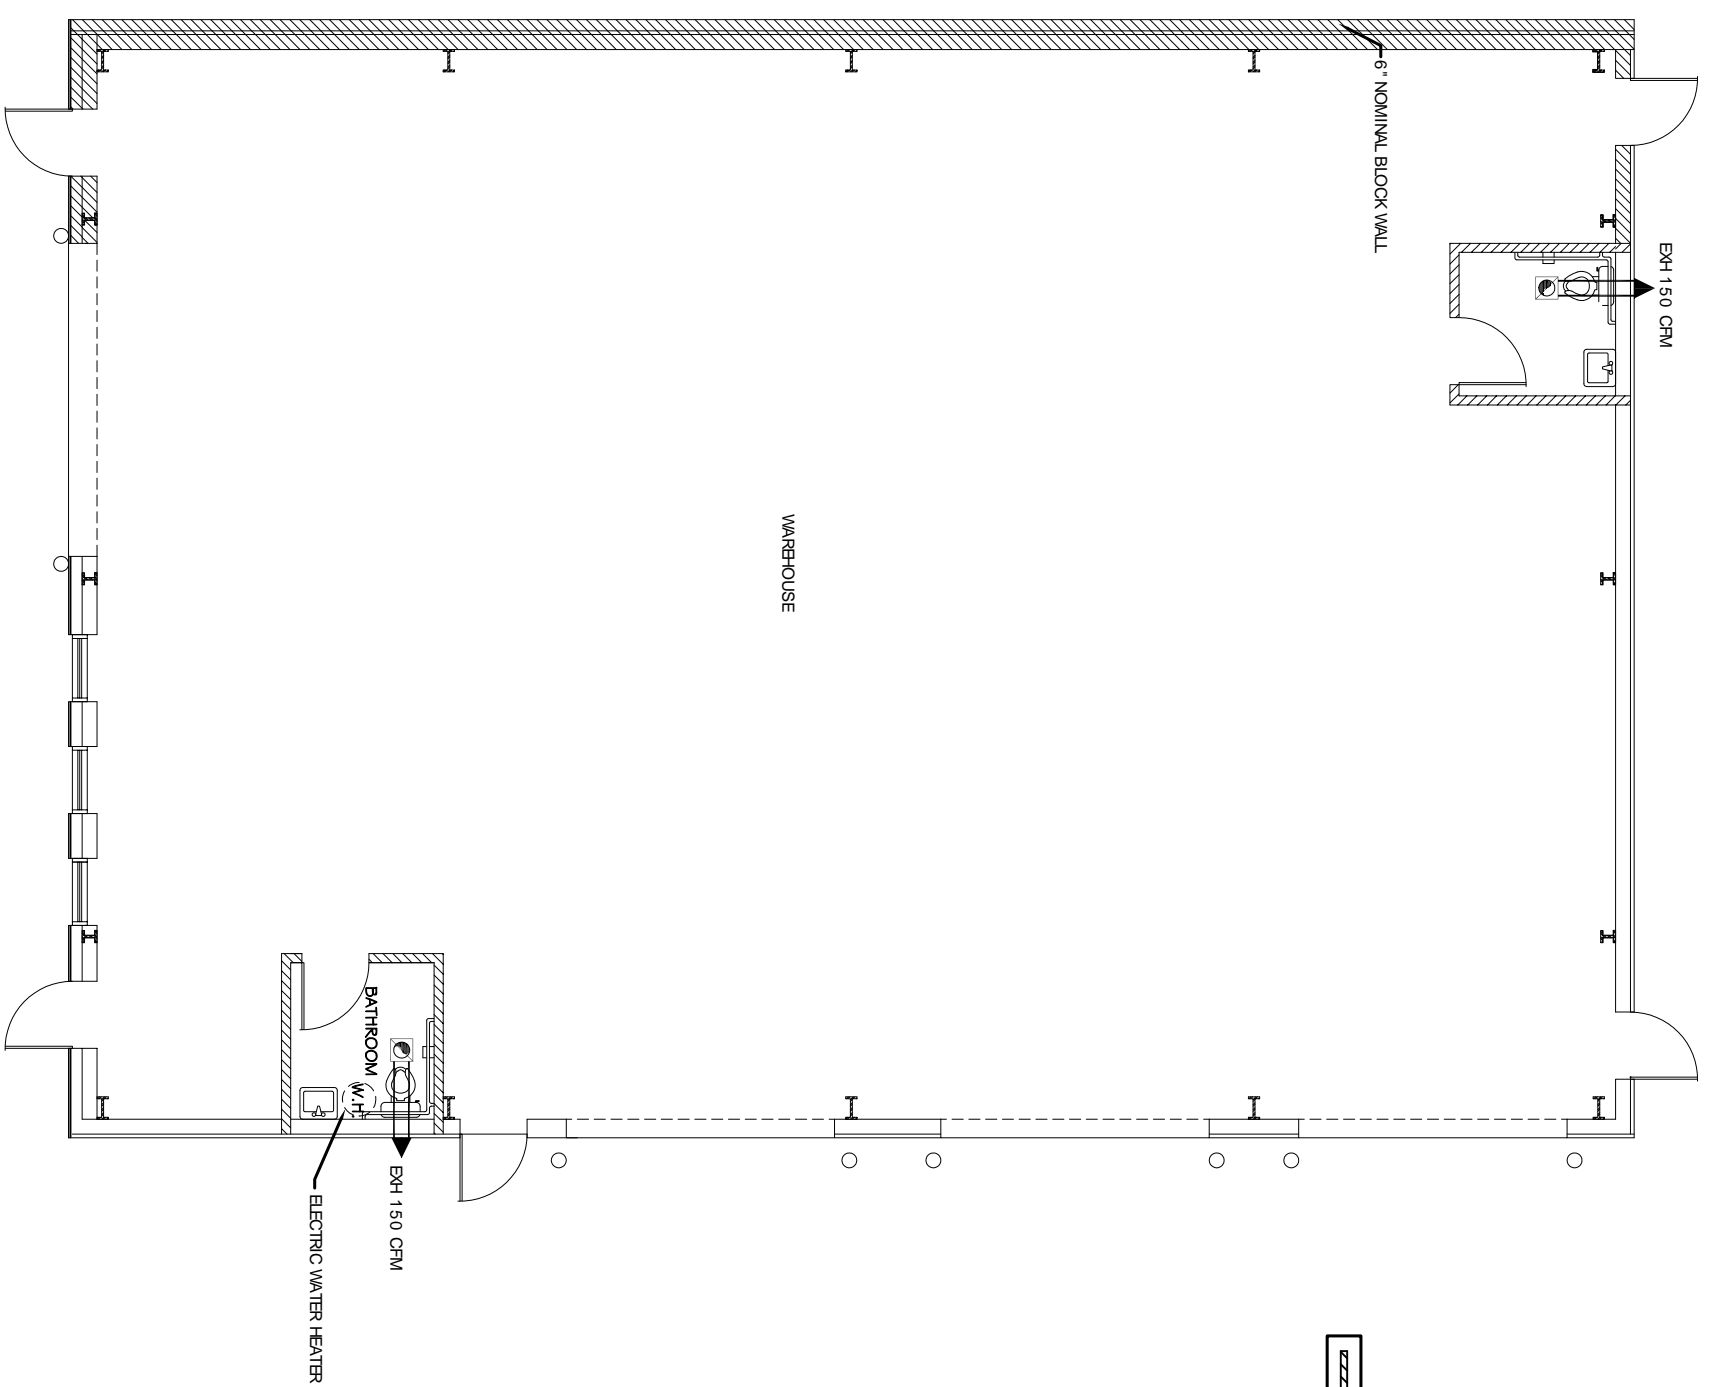

EXHAUST FAN SCHEDULE				
LOC.	CFM	VOLTAGE	TYPE	MANF.
TOILETS/SEE DWG	120		VENTILIGHT	-

MECHANICAL PLAN  
SCALE: 1/4" = 1'-0"