

© Copyright by Waring Architects
2002. All rights reserved. Except
as permitted under the Copyright
Act of 1976, this drawing may
not be reproduced in whole or
in part in any manner.

SEAL:

This drawing is the property of
Waring Architects, and is not to
be reproduced or copied in
whole or in part. It is only to
be used for the project and site
specifically identified herein.



Scales as stated herein are
void on the original drawing only.
These plans were prepared in
this office or under our personal
supervision, and to the best of
our knowledge comply with state
and local codes.

PROJECT
NO:
200343

DATE:
11/05/03


REVISIONS:

E101
OF

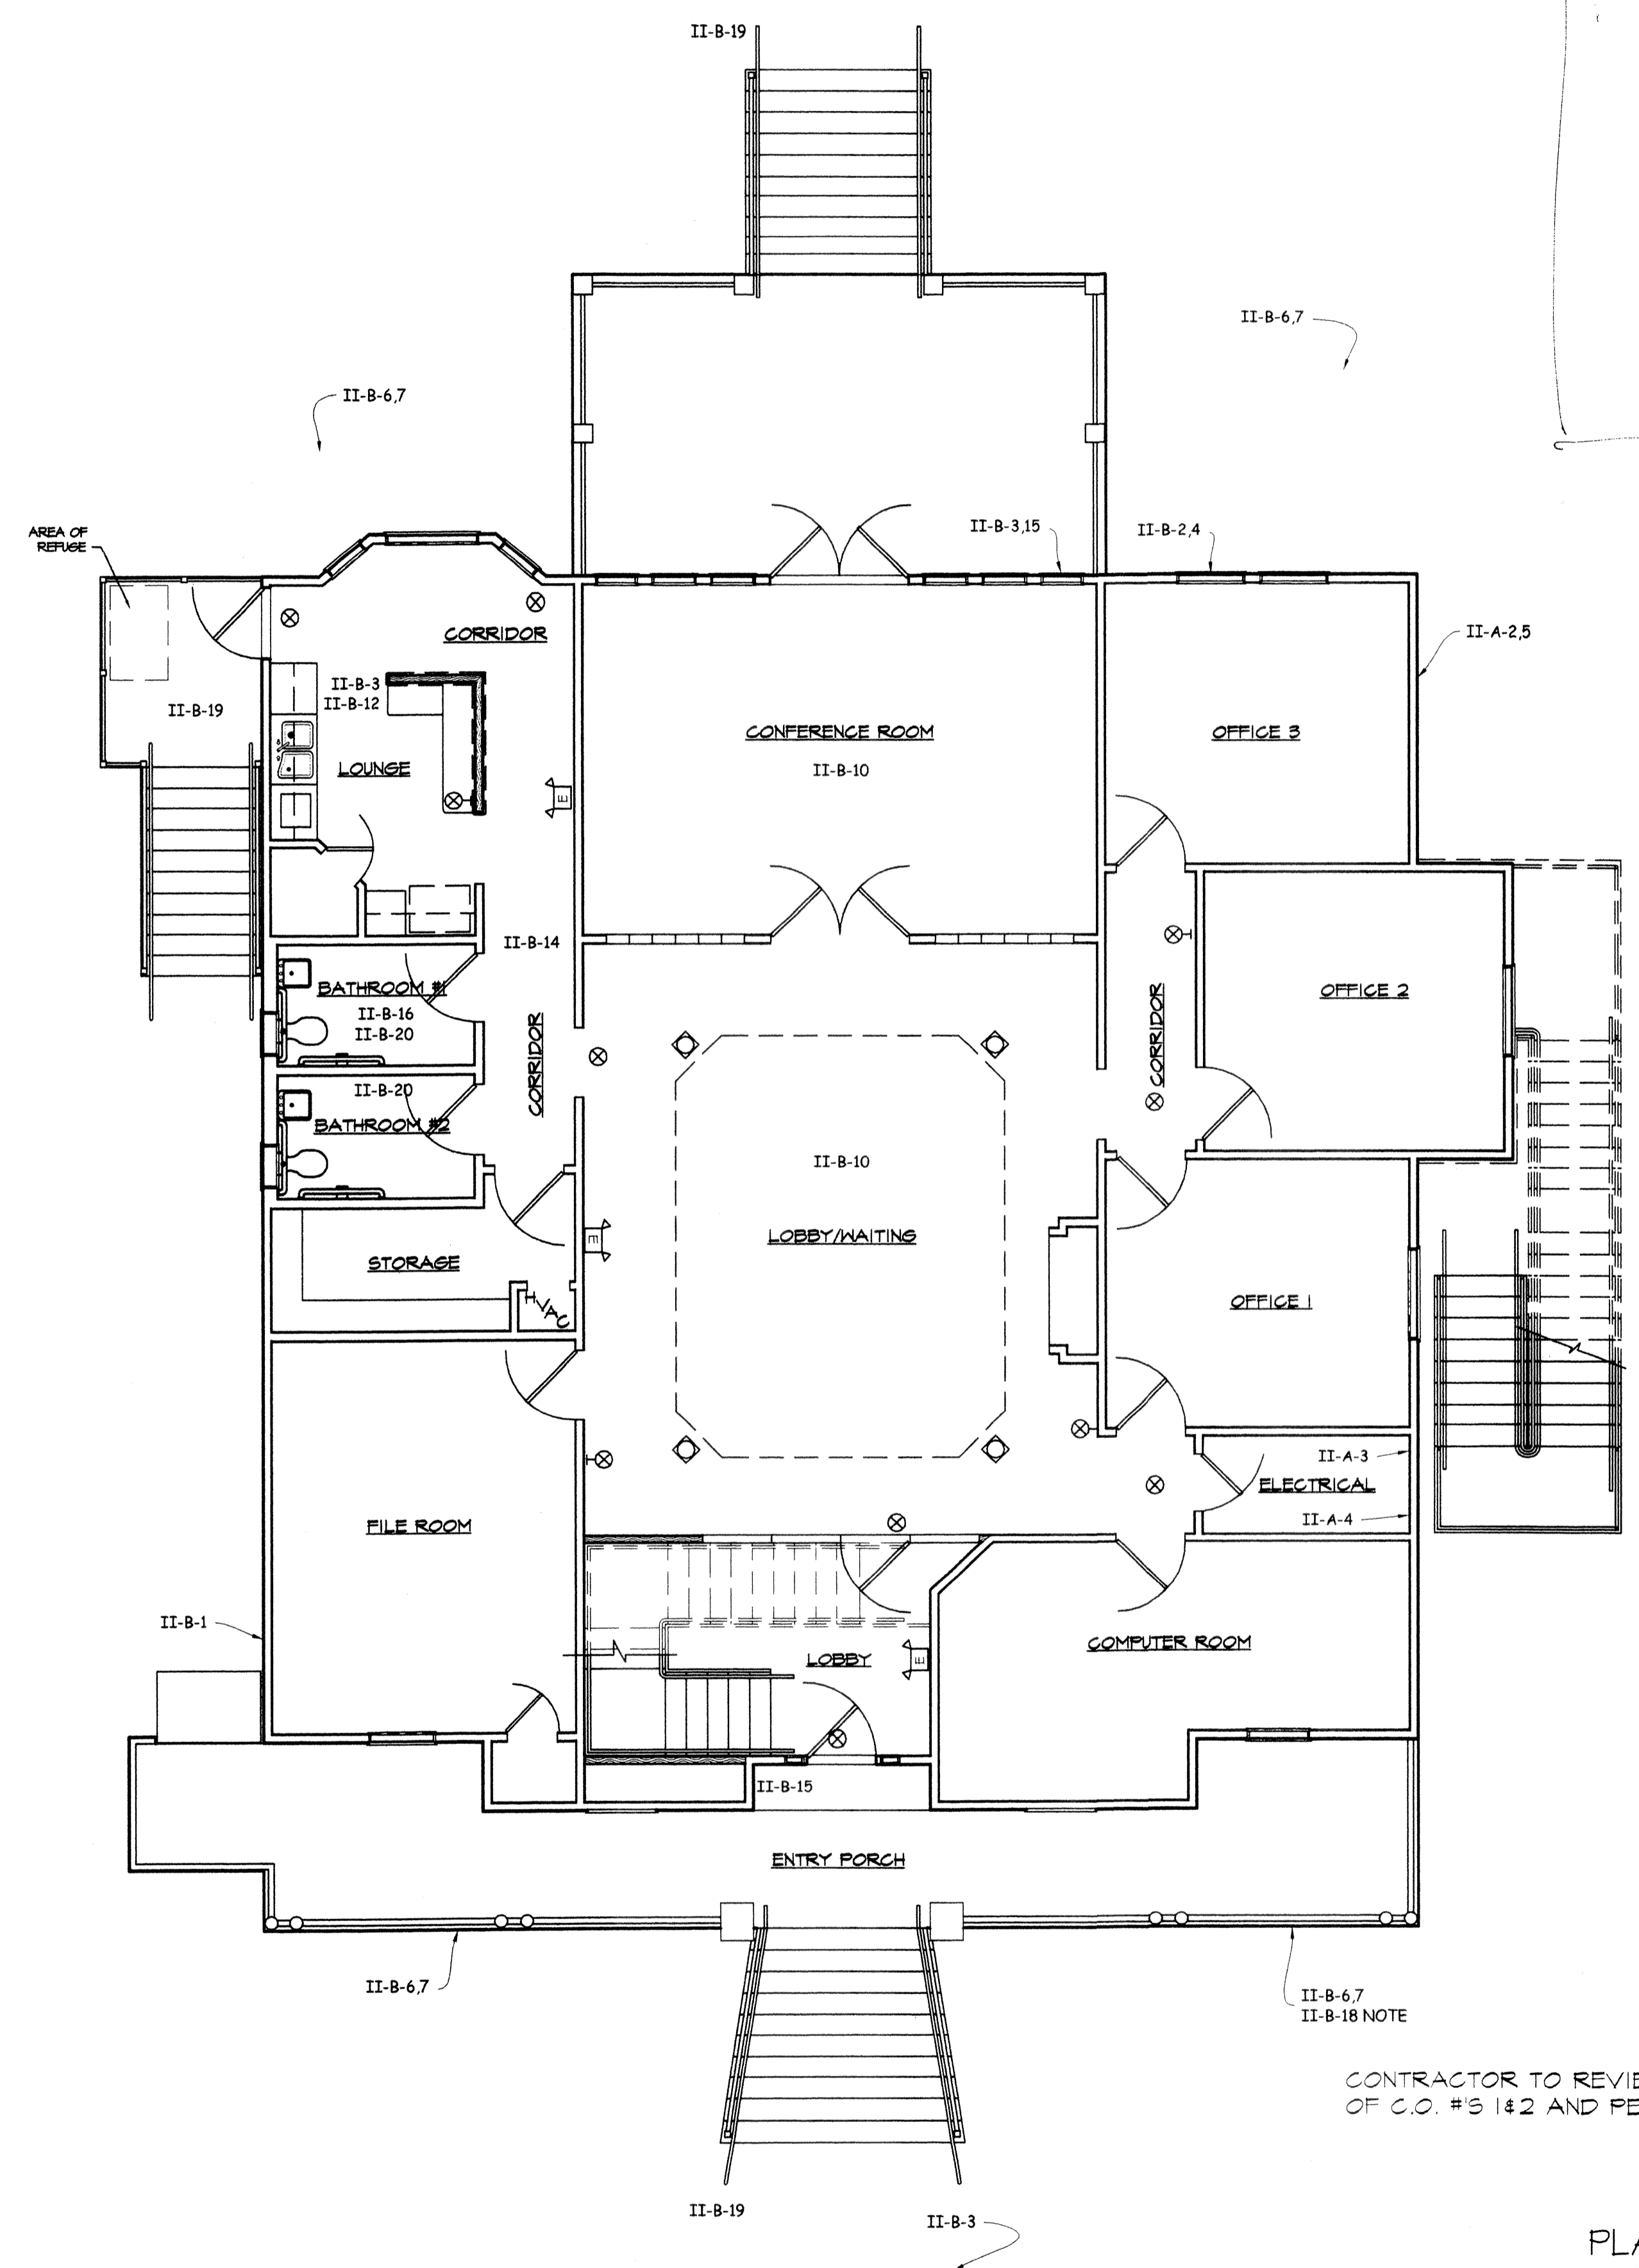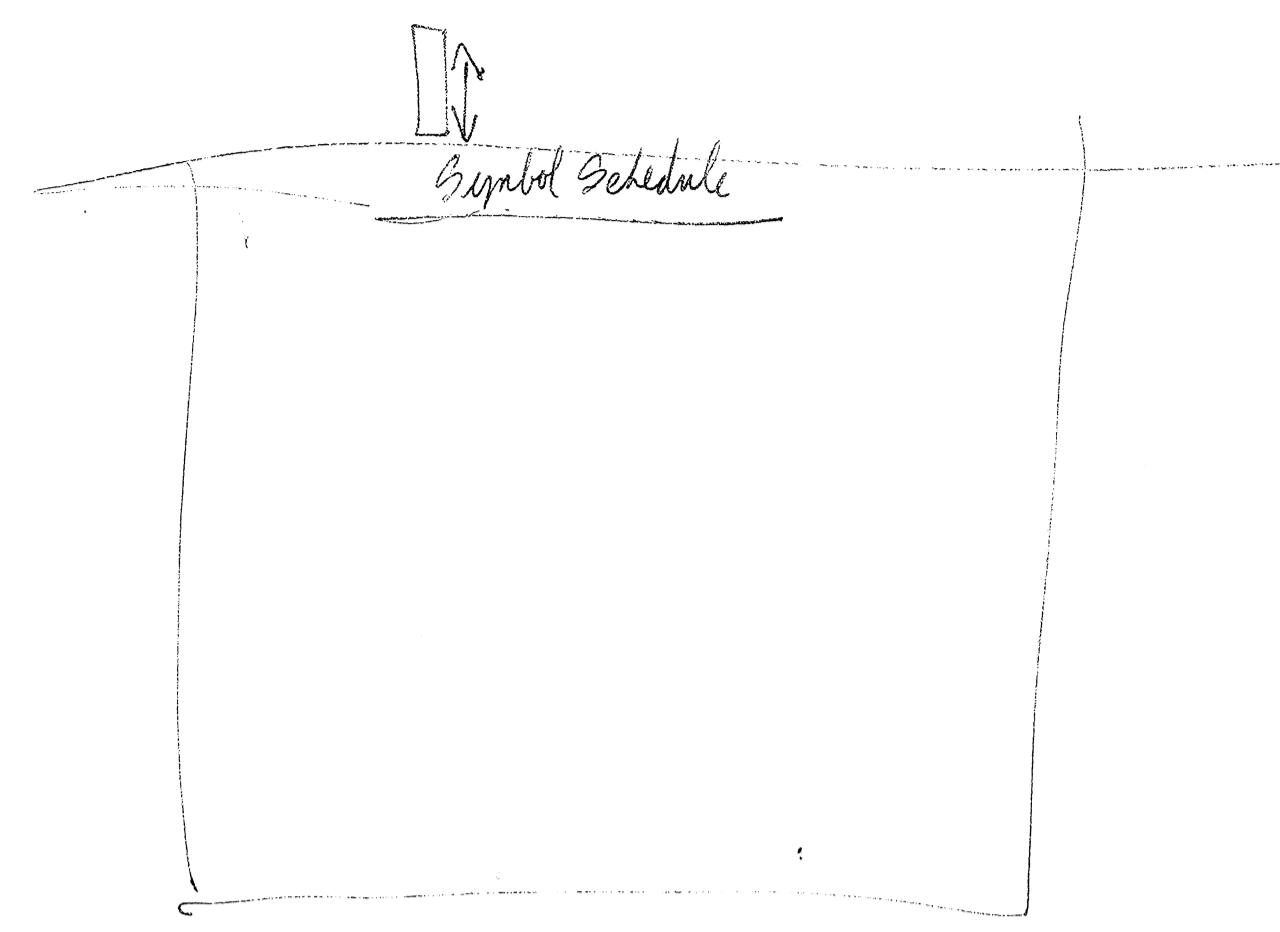

1 FIRST FLOOR ELECTRICAL PLAN
E101 SCALE: 3/16" = 1'-0"

CONTRACTOR TO REVIEW CLOSELY ALL SECTIONS AND NOTES
OF C.O. #'S 1&2 AND PERFORM ALL WORK PROPERLY & DILIGENTLY.

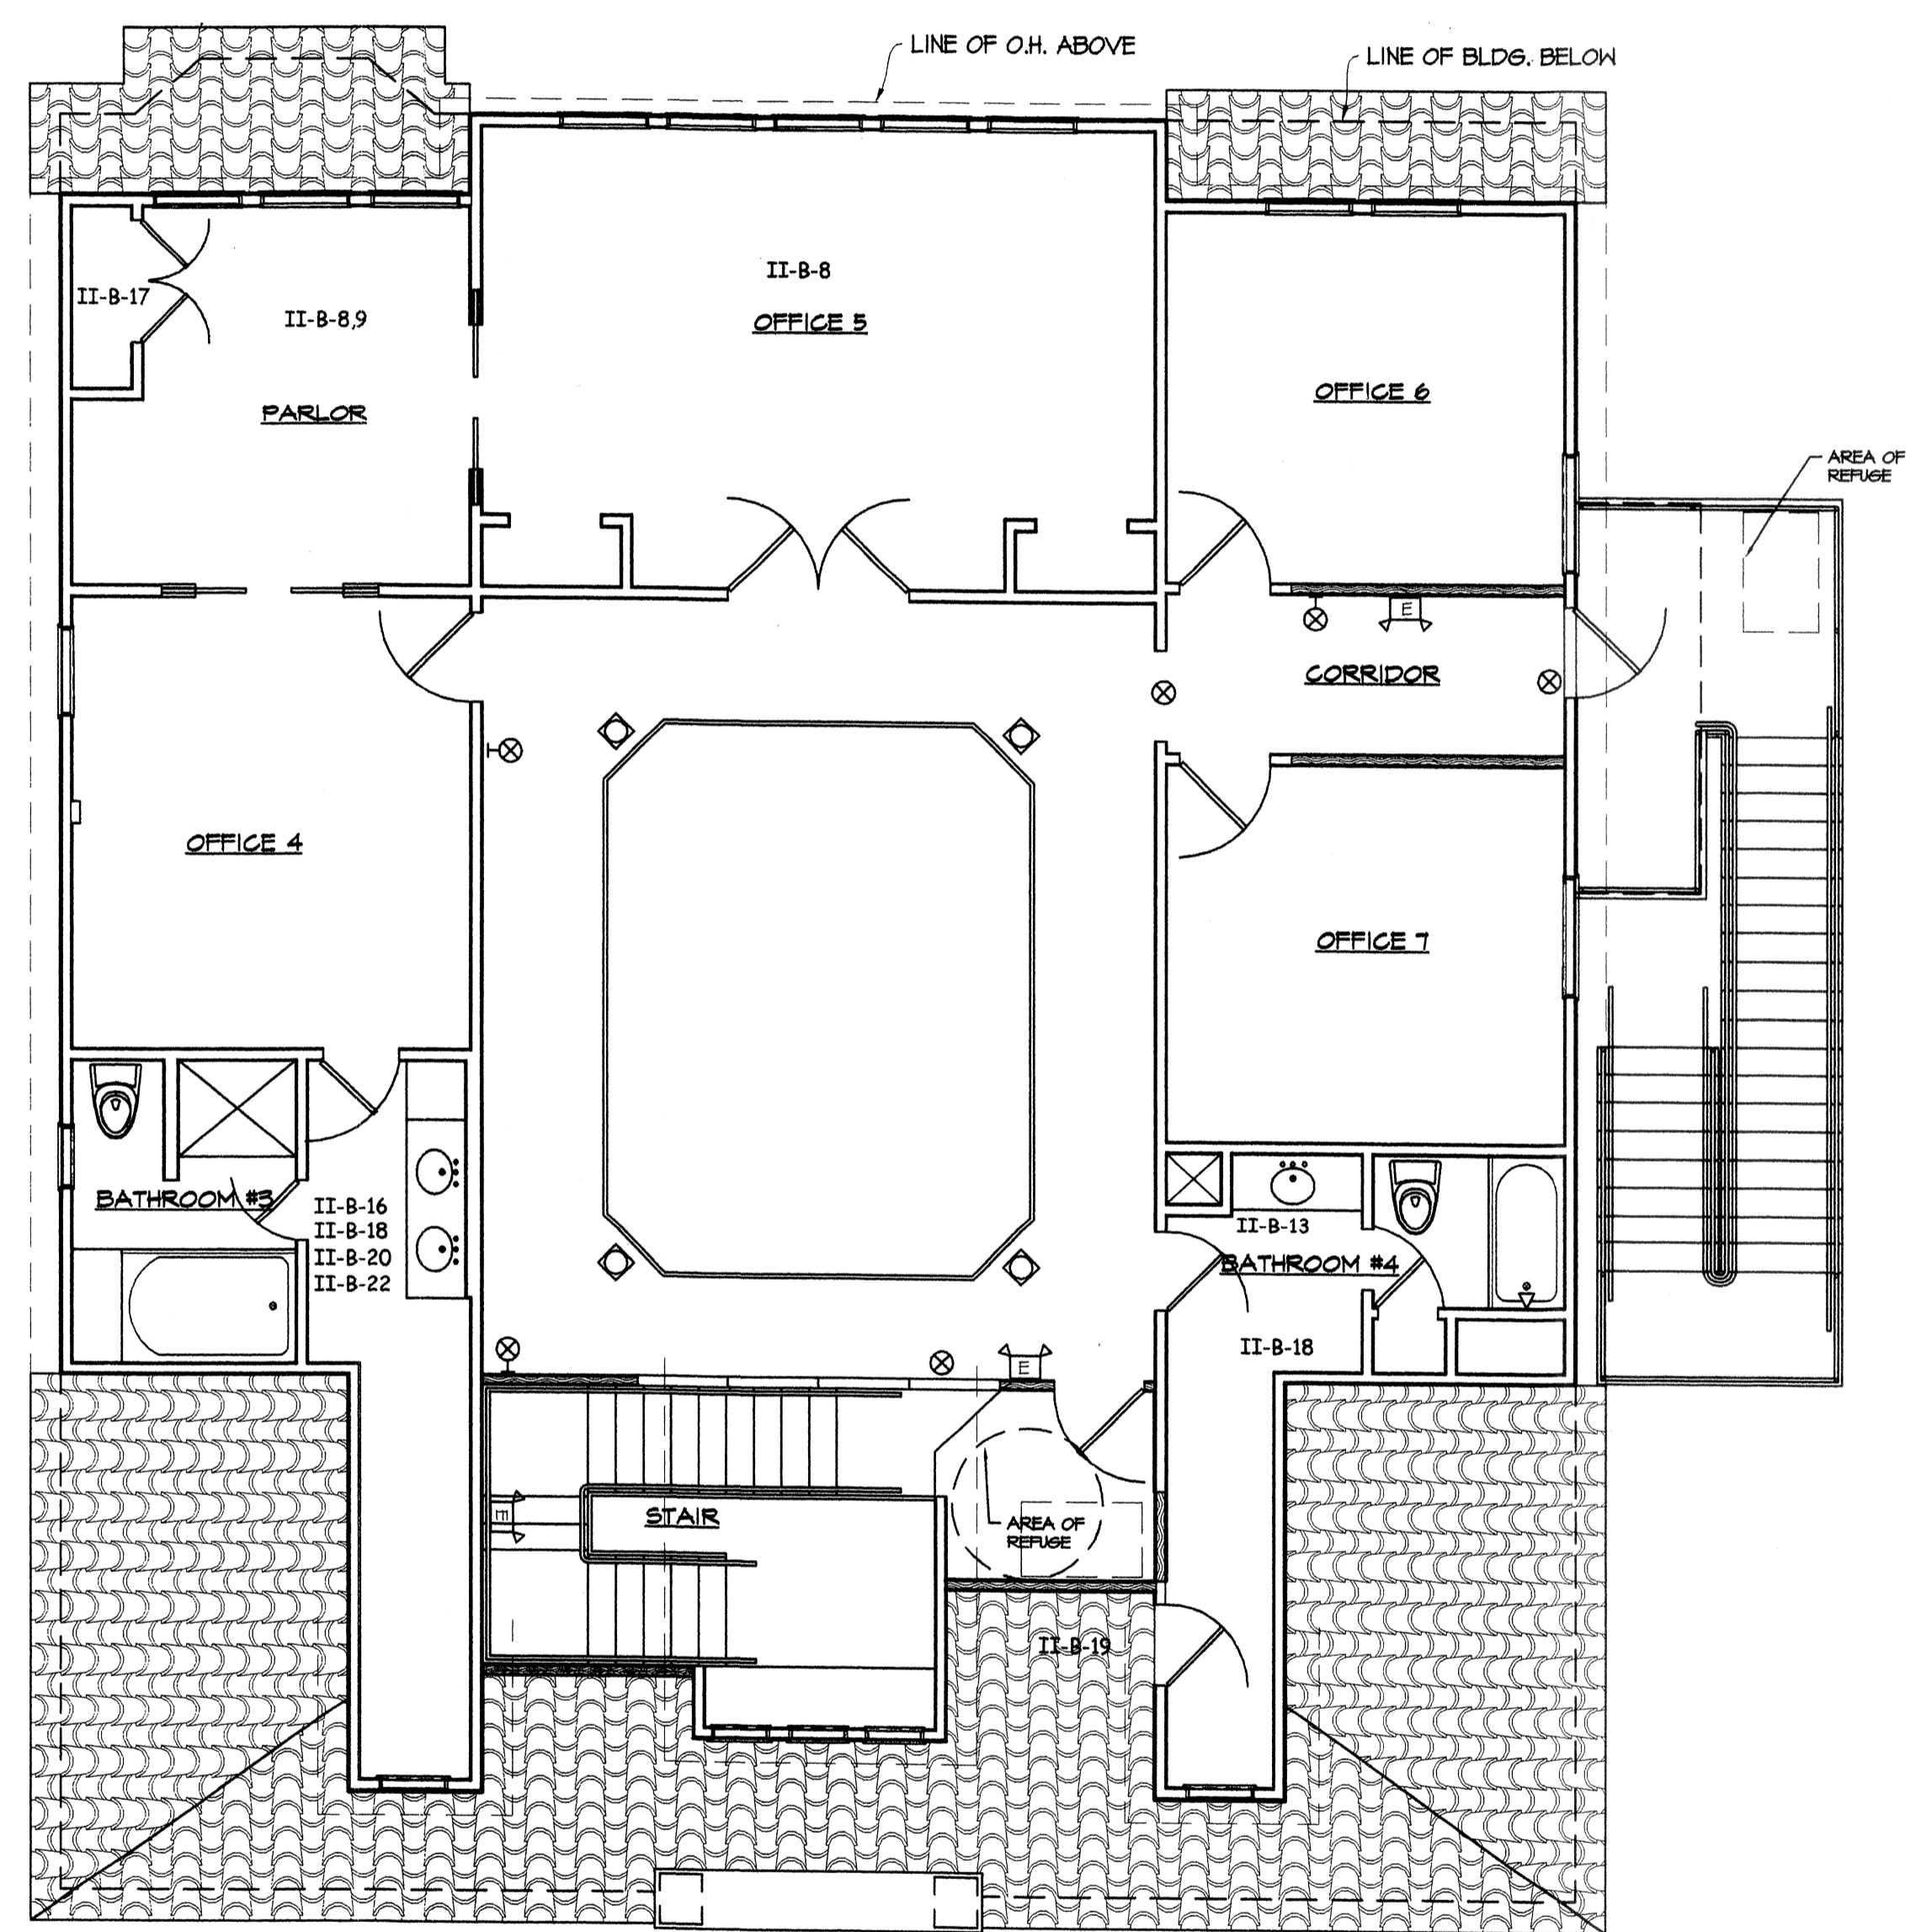

2 SECOND FLOOR ELECTRICAL PLAN
E101 SCALE: 3/16" = 1'-0"