
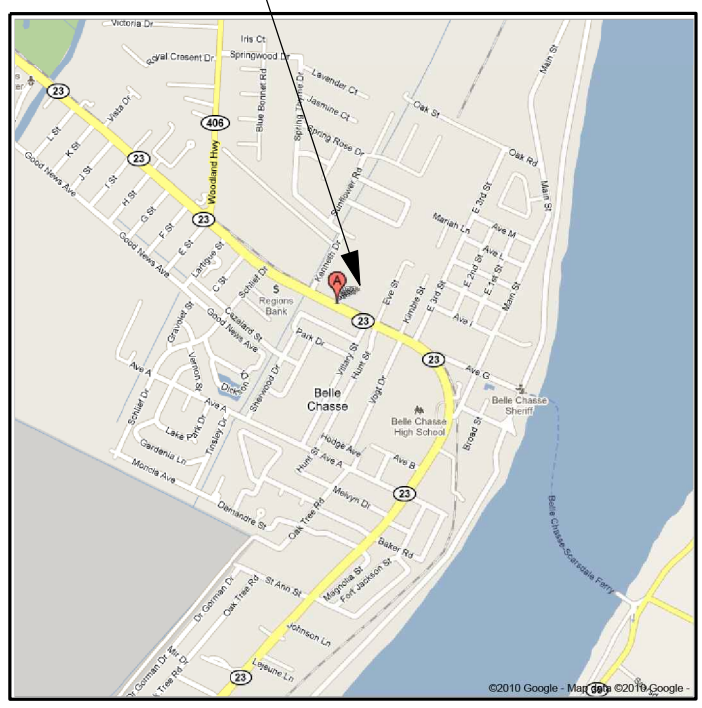


YMCA - BELLE CHASSE OUTDOOR POOL CONSTRUCTION BELLE CHASSE, LOUISIANA JANUARY 2011

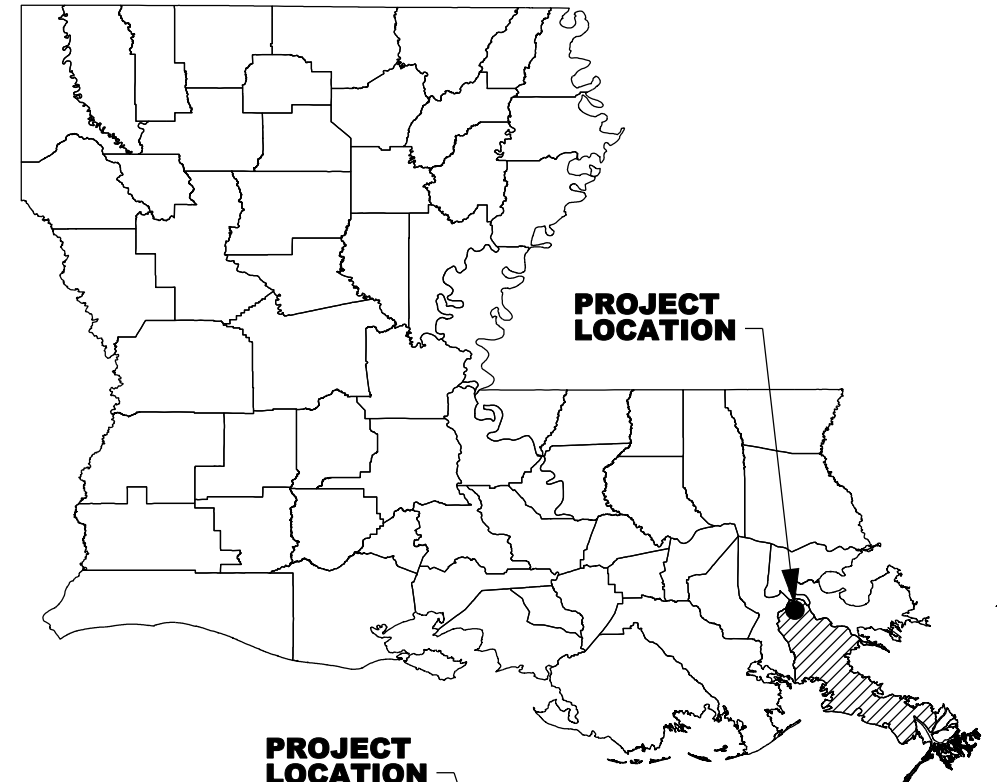

PROJECT:
YMCA BELLE CHASSE
8101 HIGHWAY 23
BELLE CHASSE, LOUISIANA 70037

OWNER:
YMCA OF GREATER NEW ORLEANS
6691 RIVERSIDE DRIVE
METAIRIE, LOUISIANA 70003
CONTACT: DAVID OZMORE
PHONE: (504) 237-2479
EMAIL: DAVIDO@YMCANEWORLEANS.ORG

AQUATICS CONSULTANT:
RAMAKER & ASSOCIATES, INC.
1120 DALLAS STREET
SAUK CITY, WI 53583
CONTACT: DARYL MATZKE, P.E.
PHONE: (608) 643-4100
FAX: (608) 643-7999
EMAIL: DMATZKE@RAMAKER.COM

ARCHITECT:
MSH ARCHITECTS, LLC
229 NORTH COLUMBIA STREET
COVINGTON, LOUISIANA 70433
CONTACT: MICHAL SAVOIE HUNLEY
PHONE: (985) 898-0303
FAX: (985) 898-0304
EMAIL: MICHAEL@MSH-ARCHITECTS.COM

POOL CONTRACTOR:
ROTOLO CONSULTANTS, INC.
894 ROBERT BOULEVARD
SLIDELL, LOUISIANA, 70458
CONTACT: DAVID RIMMER
PHONE: (985) 643-2427
FAX: (985) 643-2691
EMAIL: DRIMMER@ROTOLOCONSULTANTS.COM

LEGEND:

AQ0.01	TITLE SHEET
AQ0.02	GENERAL NOTES
AQ0.03	SITE PLAN
AQ1.00	SWIMMING POOL FLOOR PLAN
AQ1.01	SWIMMING POOL PIPING PLAN
AQ1.02	SWIMMING POOL SECTIONS
AQ1.03	SWIMMING POOL SECTIONS
AQ1.04	SWIMMING POOL PIPING SCHEMATIC & EQUIPMENT LIST
AQ10.00	EQUIPMENT ROOM AND MEP NOTES
AQ20.00	STANDARD POOL DETAILS
AQ20.01	STANDARD POOL DETAILS
AQ20.02	STANDARD POOL DETAILS
AQ20.03	STANDARD POOL DETAILS
AQ30.00	DIMENSIONAL PLAN

POOL INFORMATION:
 POOL AREA: 6438 SQ FT
 POOL PERIMETER: 664 LF
 POOL VOLUME: 137,150 GAL
 POOL CAPACITY: 460 BATHERS
 POOL DEPTH: 0'-0" TO 4'-6"; AVERAGE: 2'-3"
 OVERALL DIMENSIONS: 95' X 100'
 RECIRCULATION RATE: 425 GPM AT 323 MIN
 MAIN DRAINS: LAWSON FI-SG-1836-WT, VGBA COMPLIANT
 AND MLD-FGD-1818-WT, VGBA COMPLIANT
 RECIRC PUMP: 10 H.P, 425 GPM AT 75 TDH
 SANITATION EQUIPMENT: SALINE CHLORINATION SYSTEM & ACID
 FILTER AREA: 30.6 SQ FT, BACKWASH RATE: 230 GPM
 * FOR MORE DETAIL SEE SHEET AQ1.04 *

TO OBTAIN LOCATION OF PARTICIPANTS' UNDERGROUND FACILITIES BEFORE YOU DIG IN LOUISIANA

LOUISIANA ONE CALL
1-800-272-3020

LOUISIANA UNDERGROUND UTILITIES AND FACILITIES DAMAGE PREVENTION LAW PART VII OF CHAPTER 8 OF TITLE 40 SECTION 1749.13 REQUIRES MIN. 2 WORKING DAYS NOTICE BEFORE YOU EXCAVATE.

ISSUED FOR: STATE SUBMITTAL 01/26/2011

Engineer Stamp

I hereby certify that this plan set was prepared by me or under my direct supervision and that I am a duly Licensed Professional Engineer under the laws of the State of Louisiana.

Signature: *James R. Skowronski*

Date: 01/26/2011

RAMAKER & ASSOCIATES, INC.
 1120 Dallas Street, Sauk City, Wisconsin 53583
 Voice: 608-643-4100 Fax: 608-643-7999
 www.ramaker.com

RCI
 LANDSCAPE - MAINTENANCE - CONSTRUCTION

YMCA - BELLE CHASSE
 BELLE CHASSE, LOUISIANA

SHEET TITLE


TITLE SHEET

SCALE: NONE

PROJECT NUMBER: 18655

SHEET NUMBER: AQ0.01

NOTE: THIS SITE PLAN WAS DEVELOPED FROM DRAWINGS PROVIDED BY ALL SOUTH CONSULTING ENGINEERS, INC. ON MAY 19, 2010. RAMAKER AND ASSOCIATES MAKES NO WARRANTY AS TO THE ACCURACY OF THIS INFORMATION. ANY CHANGES OR REVISIONS TO THIS PLAN MUST BE IMMEDIATELY REPORTED TO RAMAKER AND ASSOCIATES.

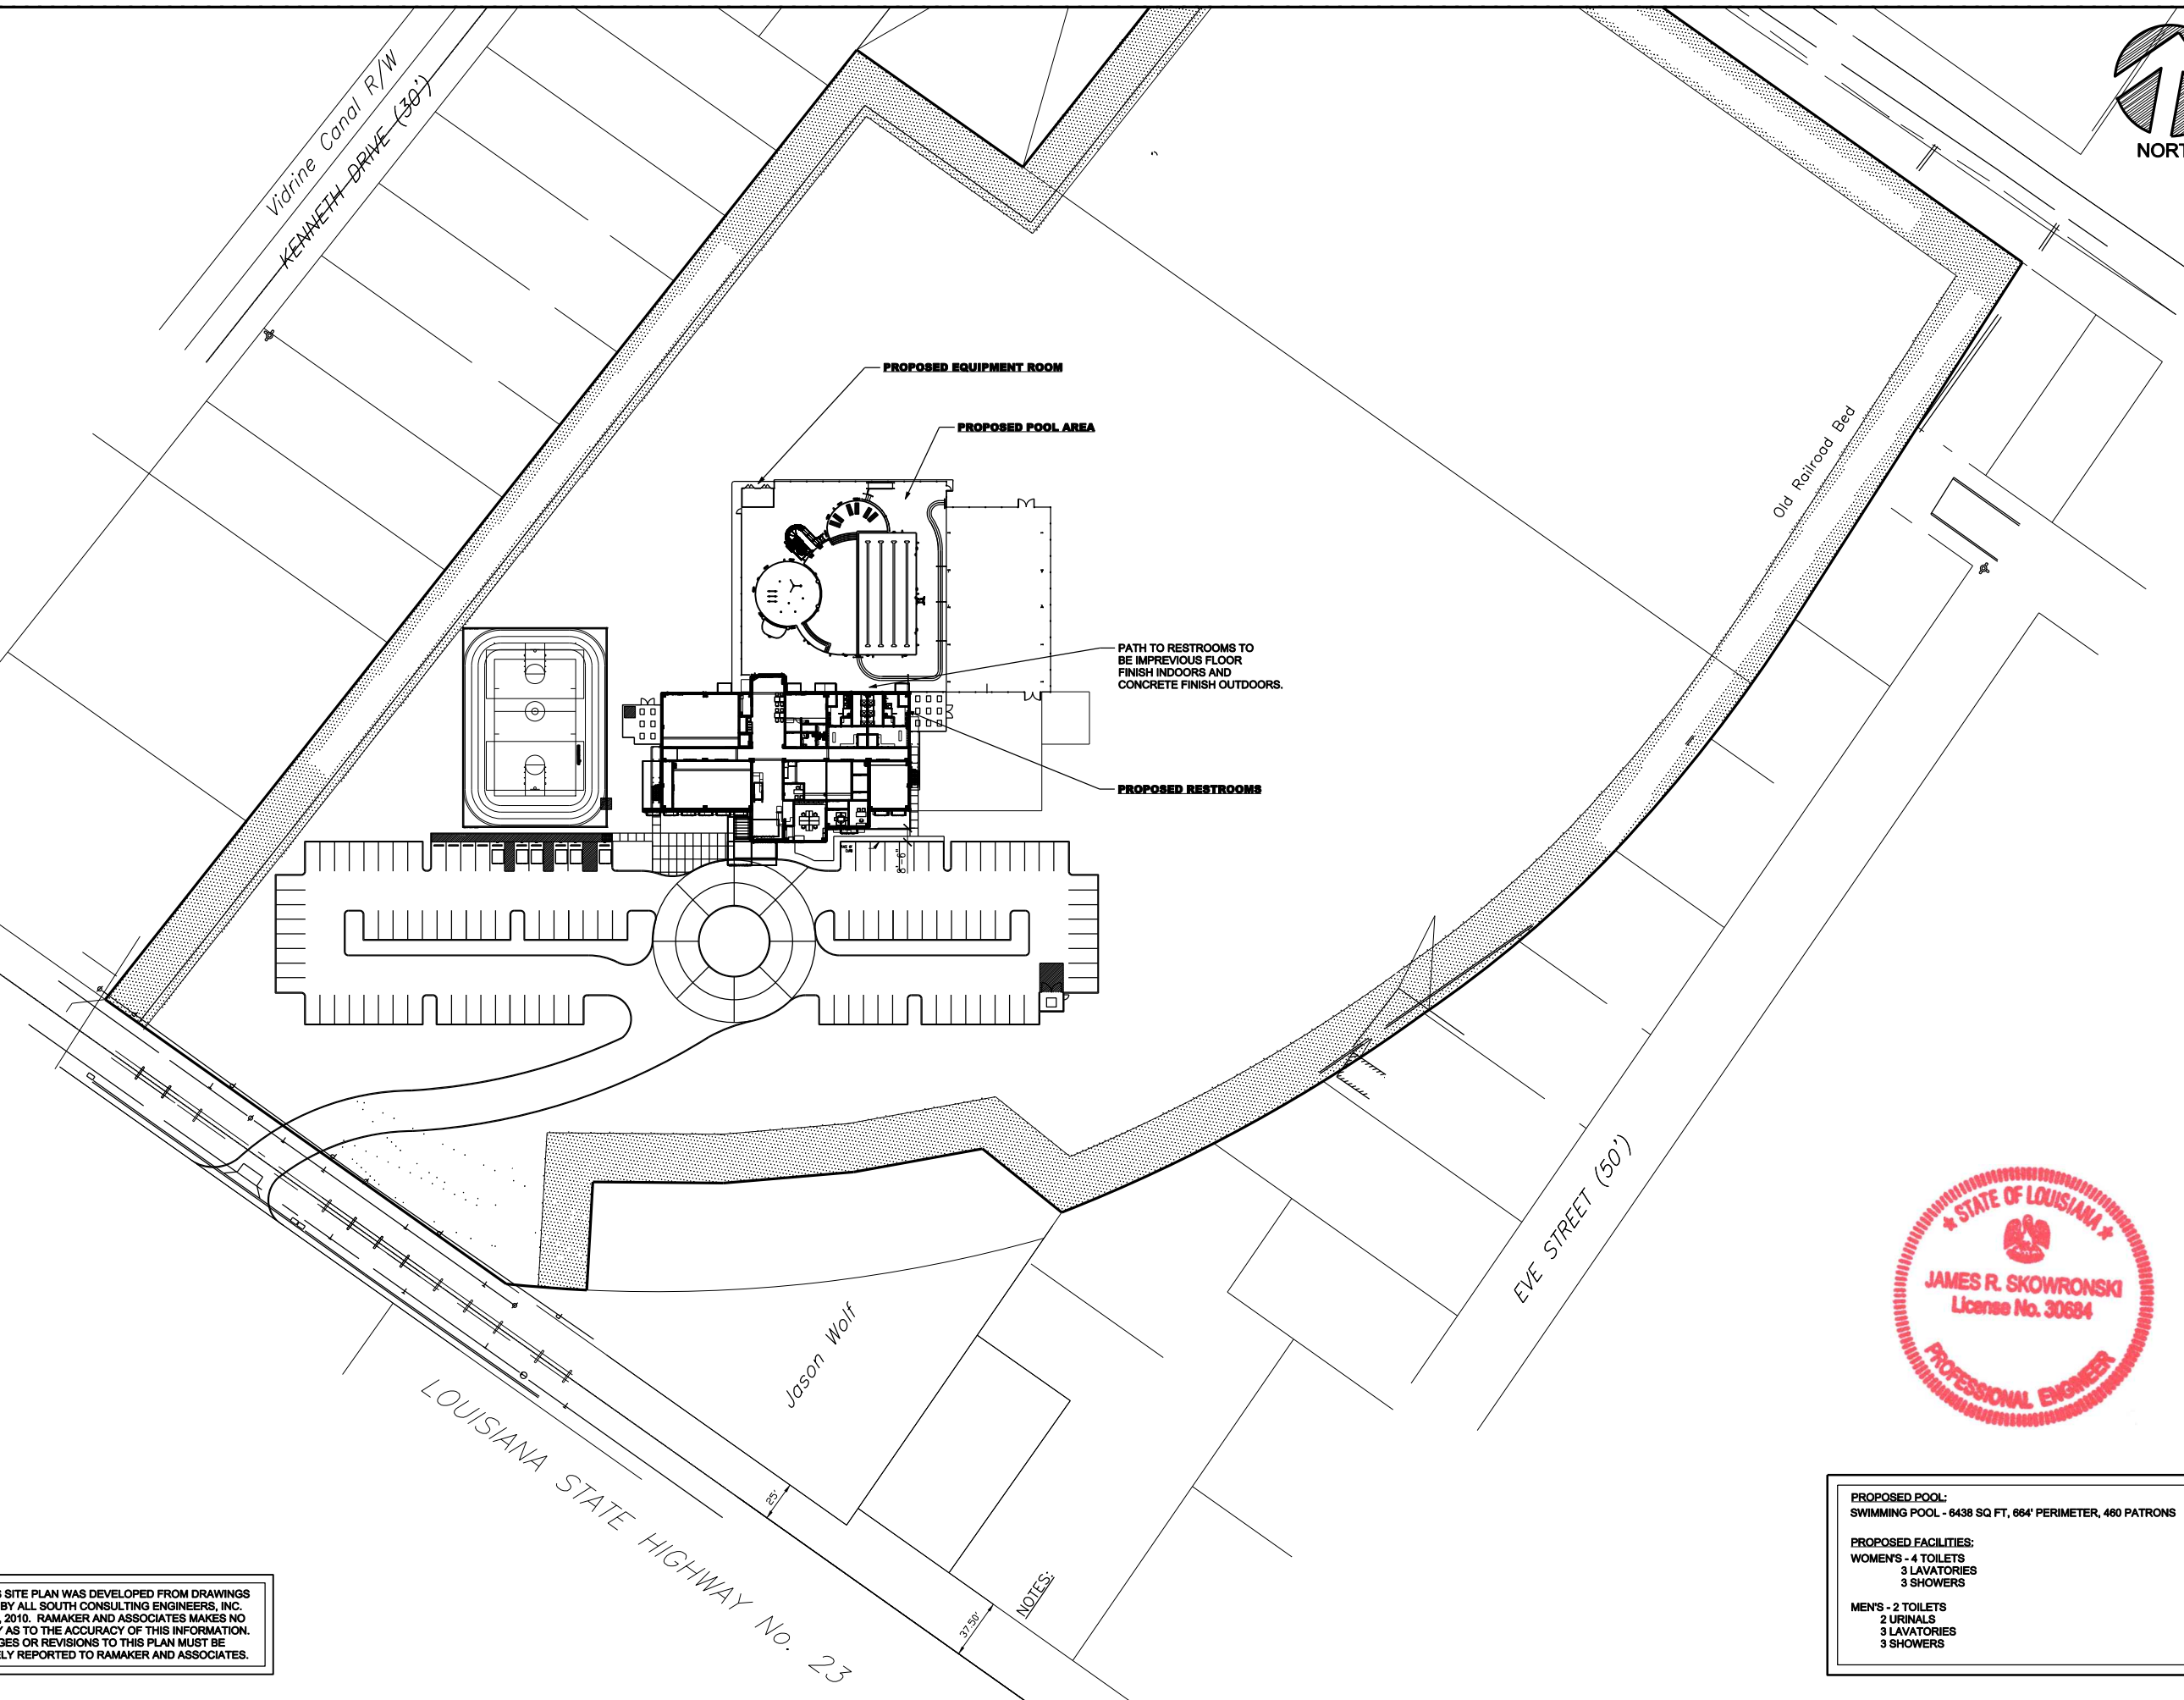

PROPOSED POOL:
SWIMMING POOL - 6438 SQ FT, 664' PERIMETER, 460 PATRONS

PROPOSED FACILITIES:
WOMEN'S - 4 TOILETS
3 LAVATORIES
3 SHOWERS

MEN'S - 2 TOILETS
2 URINALS
3 LAVATORIES
3 SHOWERS

YMCA - BELLE CHASSE
BELLE CHASSE, LOUISIANA
SHEET TITLE
SITE PLAN


SCALE
0 25' 50' 100'

11" x 17" - 1" = 100'
22" x 34" - 1" = 50'


PROJECT NUMBER
18655

SHEET NUMBER
AQ0.03

RAMAKER & ASSOCIATES, INC.
1120 Dallas Street, Sauk City, Wisconsin 53583
Voice: 608-643-4100 Fax: 608-643-7999
www.ramaker.com

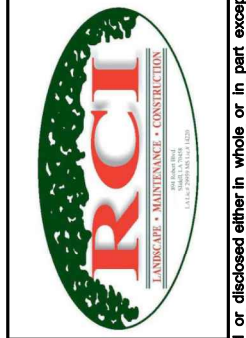

This document contains confidential or proprietary information of Ramaker & Associates, Inc. Neither this document nor the information herein is to be reproduced, distributed, used or disclosed either in whole or in part except as authorized by Ramaker and Associates, Inc.

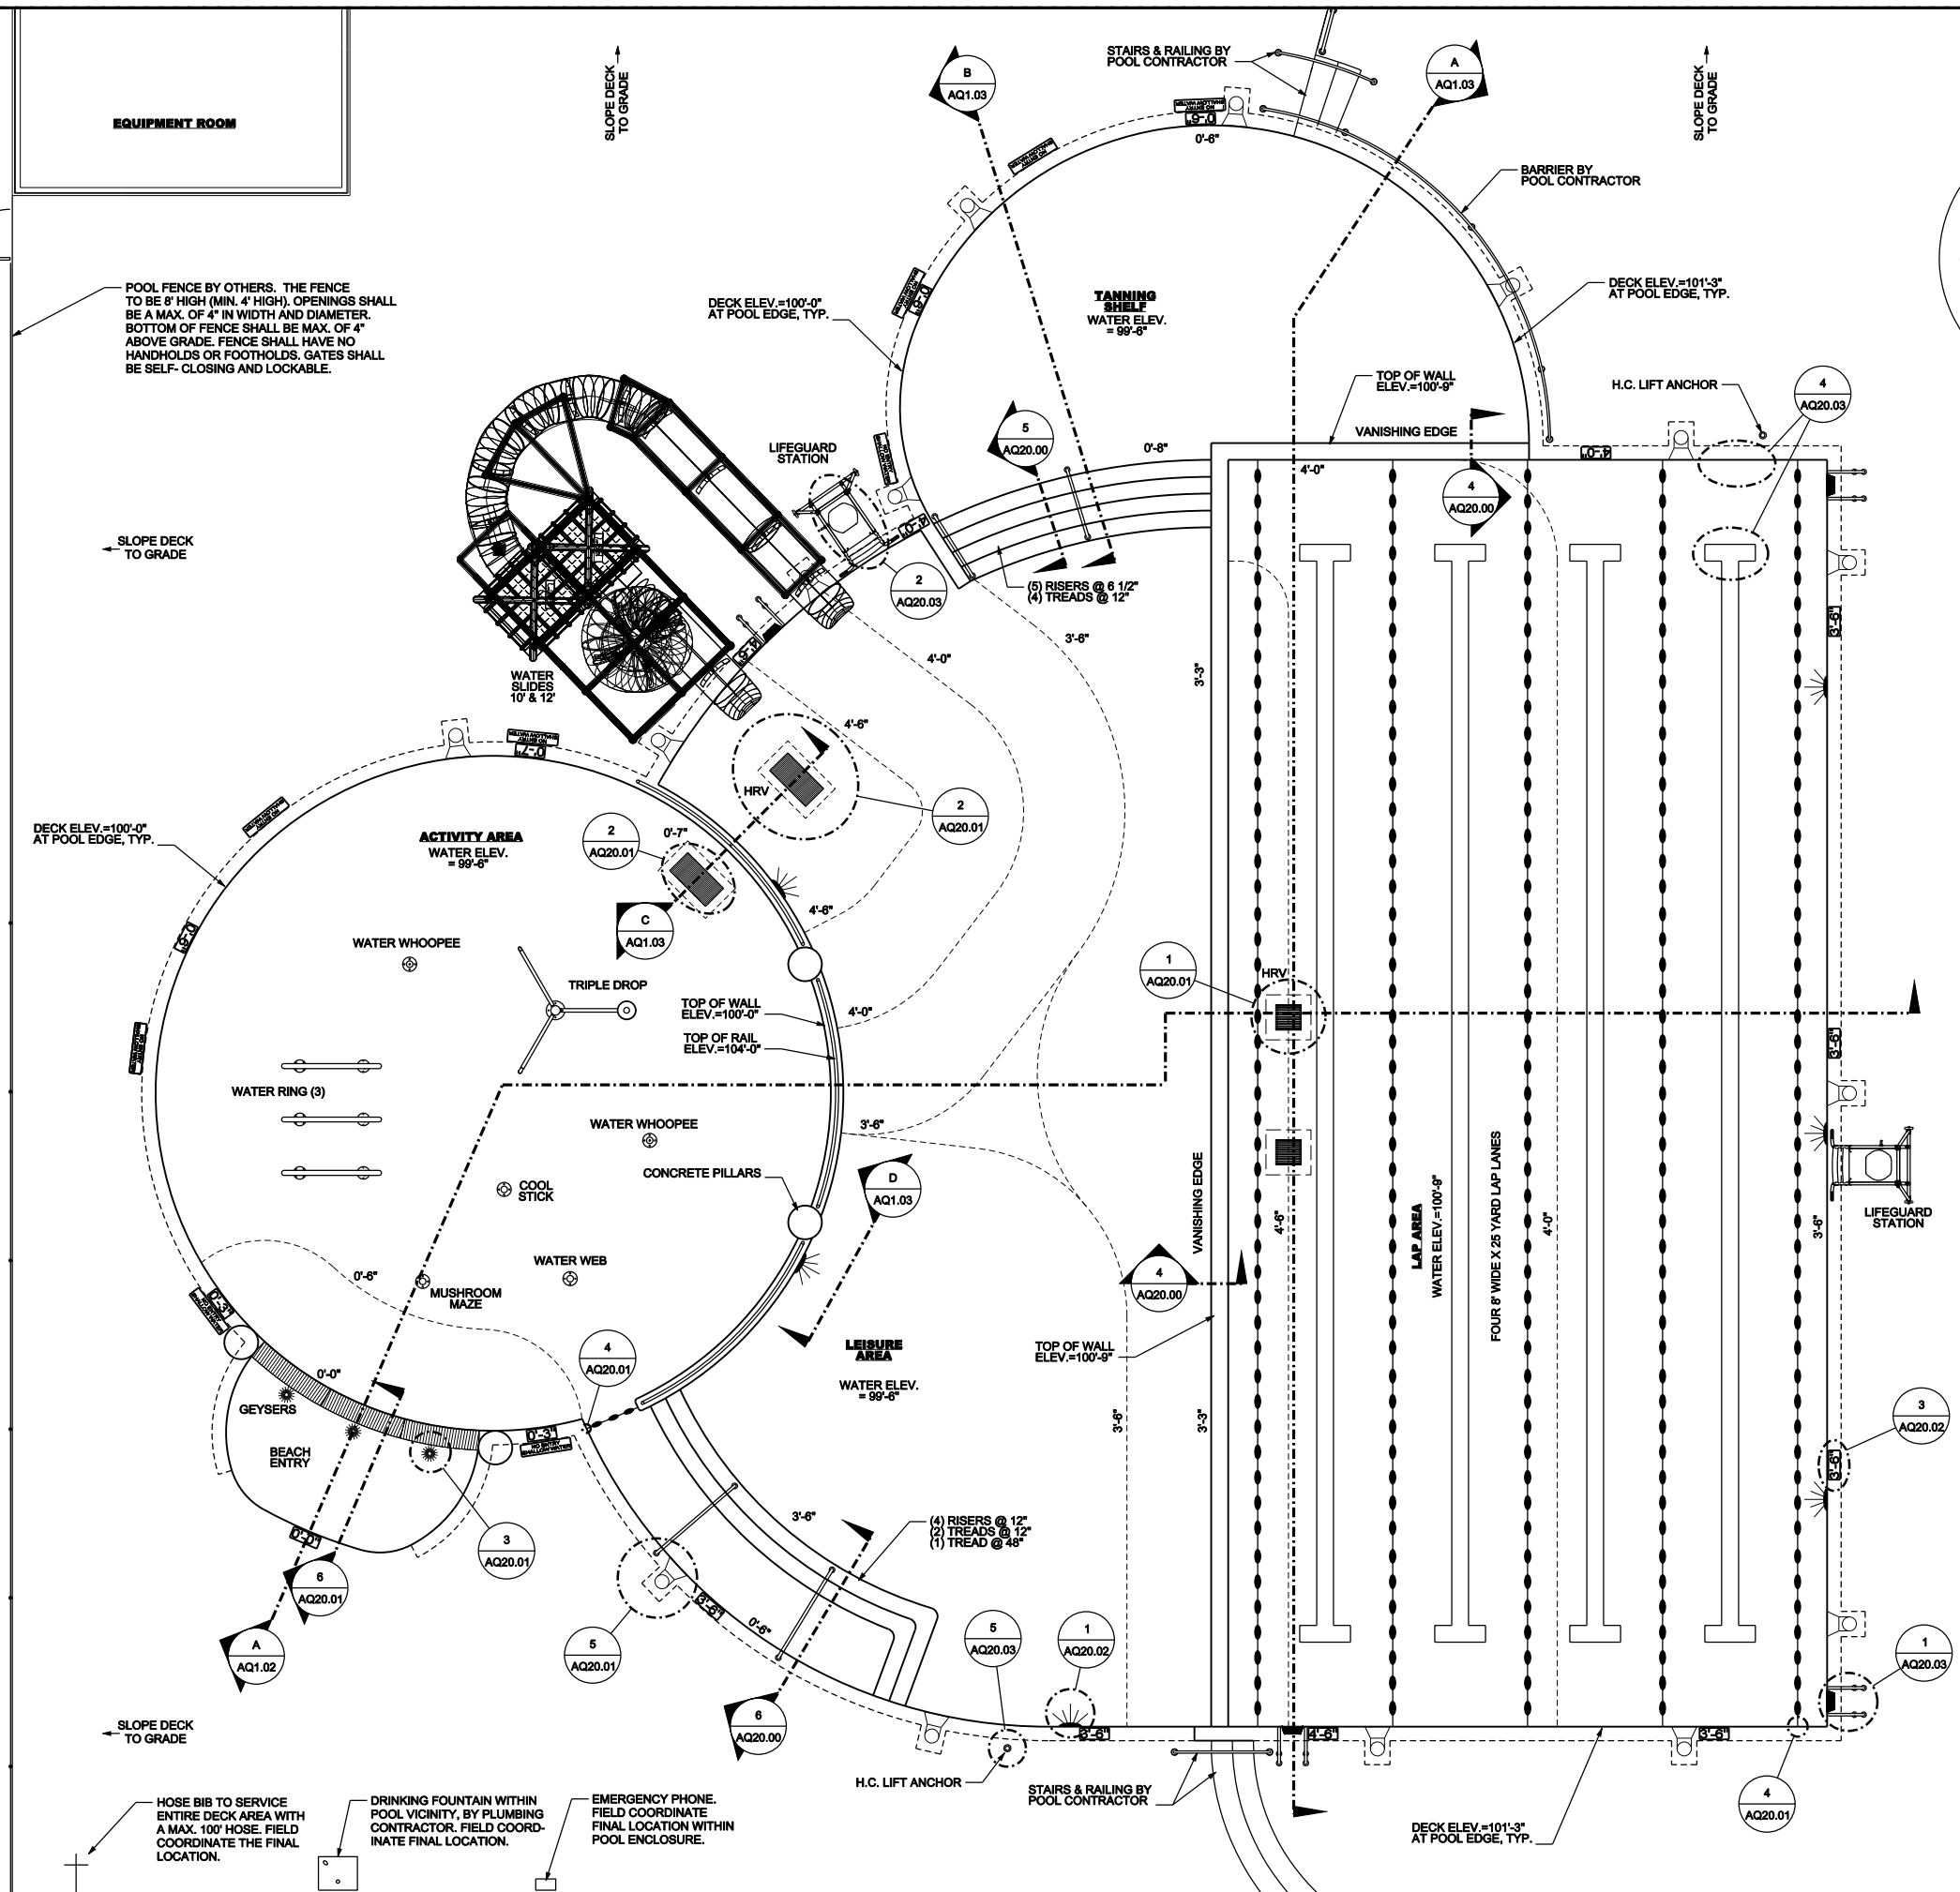

EQUIPMENT ROOM

POOL FENCE BY OTHERS. THE FENCE TO BE 8' HIGH (MIN. 4' HIGH). OPENINGS SHALL BE A MAX. OF 4" IN WIDTH AND DIAMETER. BOTTOM OF FENCE SHALL BE MAX. OF 4" ABOVE GRADE. FENCE SHALL HAVE NO HANDHOLDS OR FOOTHOLDS. GATES SHALL BE SELF-CLOSING AND LOCKABLE.



- FACILITY NOTES:**
- POOL DECK:
 - ELEVATION AT POOL EDGES = 100'-0" AND 101'-3"
 - SHALL SLOPE AT 1/8" TO 1/2" PER FOOT TO GRADE.
 - TO BE POURED BY GENERAL CONTRACTOR.
 - COORDINATE WITH DRAIN INSTALLER FOR DECK DRAINS REGARDING DRAIN HEIGHTS AND REQUIRED FINISH.
 - RESTROOMS SHALL NOT DRAIN TO THE POOL DECK.
 - DECK AND BARRIERS BY GENERAL CONTRACTOR.
 - SURFACE TO HAVE NON-SLIP FINISH.
 - PROVIDE EMERGENCY PHONE IN IMMEDIATE POOL AREA BY OWNER.
 - HOSE BIBS WITH VACUUM BREAK BY PLUMBING CONTRACTOR. HOSE BIBS TO BE SPACED TO SERVICE COMPLETE DECK AREA WITH A MAXIMUM 100 FT. HOSE.
 - DRINKING FOUNTAINS BY PLUMBING CONTRACTOR. DRINKING FOUNTAINS TO BE LOCATED IN VICINITY OF POOL.
 - ALL POOL PATRON ENTRANCE DOORS AND GATES TO BE SELF CLOSING AND LOCKABLE, TYP. - BY GENERAL CONTRACTOR.
 - ALL THEMING TO BE DEVELOPED AND INSTALLED BY OWNER AND/OR OWNER'S THEMING CONTRACTOR.
 - POOL AREA ELECTRICAL BY ELECTRICAL CONTRACTOR:
 - ALL WIRING SHALL CONFORM TO ALL APPLICABLE NATIONAL, STATE, AND LOCAL ELECTRICAL CODES.
 - LOCATION OF ELECTRICAL DEVICES SHOWN IS APPROXIMATE. CONSULT WITH POOL CONTRACTOR FOR ACTUAL INSTALLATION LOCATION. ALL ELECTRICAL SWITCHES SHALL BE LOCATED A MINIMUM OF 5'-0" HORIZONTALLY FROM THE POOL EDGE.
 - POOL CONTRACTOR TO COORDINATE W/ELECTRICIAN FOR POOL LIGHTS AND JUNCTION BOX LOCATION.
 - ELECTRICAL CONTRACTOR RESPONSIBLE FOR ELECTRICAL BONDING AND GROUNDING OF POOL VESSELS AND ACCESSORIES TO CONFORM TO NEC REQUIREMENTS.
 - THE POOL AND ADJACENT AREAS THAT ARE INTENDED TO BE USED AFTER DAYLIGHT HOURS MUST BE PROVIDED WITH AREA LIGHTING THAT IS IN COMPLIANCE WITH THE STATE OF LOUISIANA ADMINISTRATIVE CODE. THIS LIGHTING TO BE PROVIDED BY THE OWNER OR OWNER'S LIGHTING CONTRACTOR.

- POOL NOTES:**
- MAIN DRAINS MARKED "HRV" REQUIRE A HYDROSTATIC RELIEF VALVE.
 - DEPTH MARKERS SHALL BE PLACED AT MAXIMUM 25' INTERVALS AROUND THE POOL PERIMETER.

DATA:

POOL AREA = 6438 SQ. FT. 480 PATRONS
 DECK AREA = 9132 SQ. FT.
 BEACH AREA = 121 SQ. FT.




YMCA - BELLE CHASSE
 BELLE CHASSE, LOUISIANA
 SHEET TITLE
SWIMMING POOL FLOOR PLAN

SCALE
 0 2.5' 5' 10'
 11" x 17" - 3/32" = 1"
 22" x 34" - 3/16" = 1"
 PROJECT NUMBER
18655
 SHEET NUMBER
AQ1.00

RAMAKER & ASSOCIATES, INC.
 1120 Dallas Street, Sauk City, Wisconsin 53583
 Voice: 608-643-4100 Fax: 608-643-7999
 www.ramaker.com



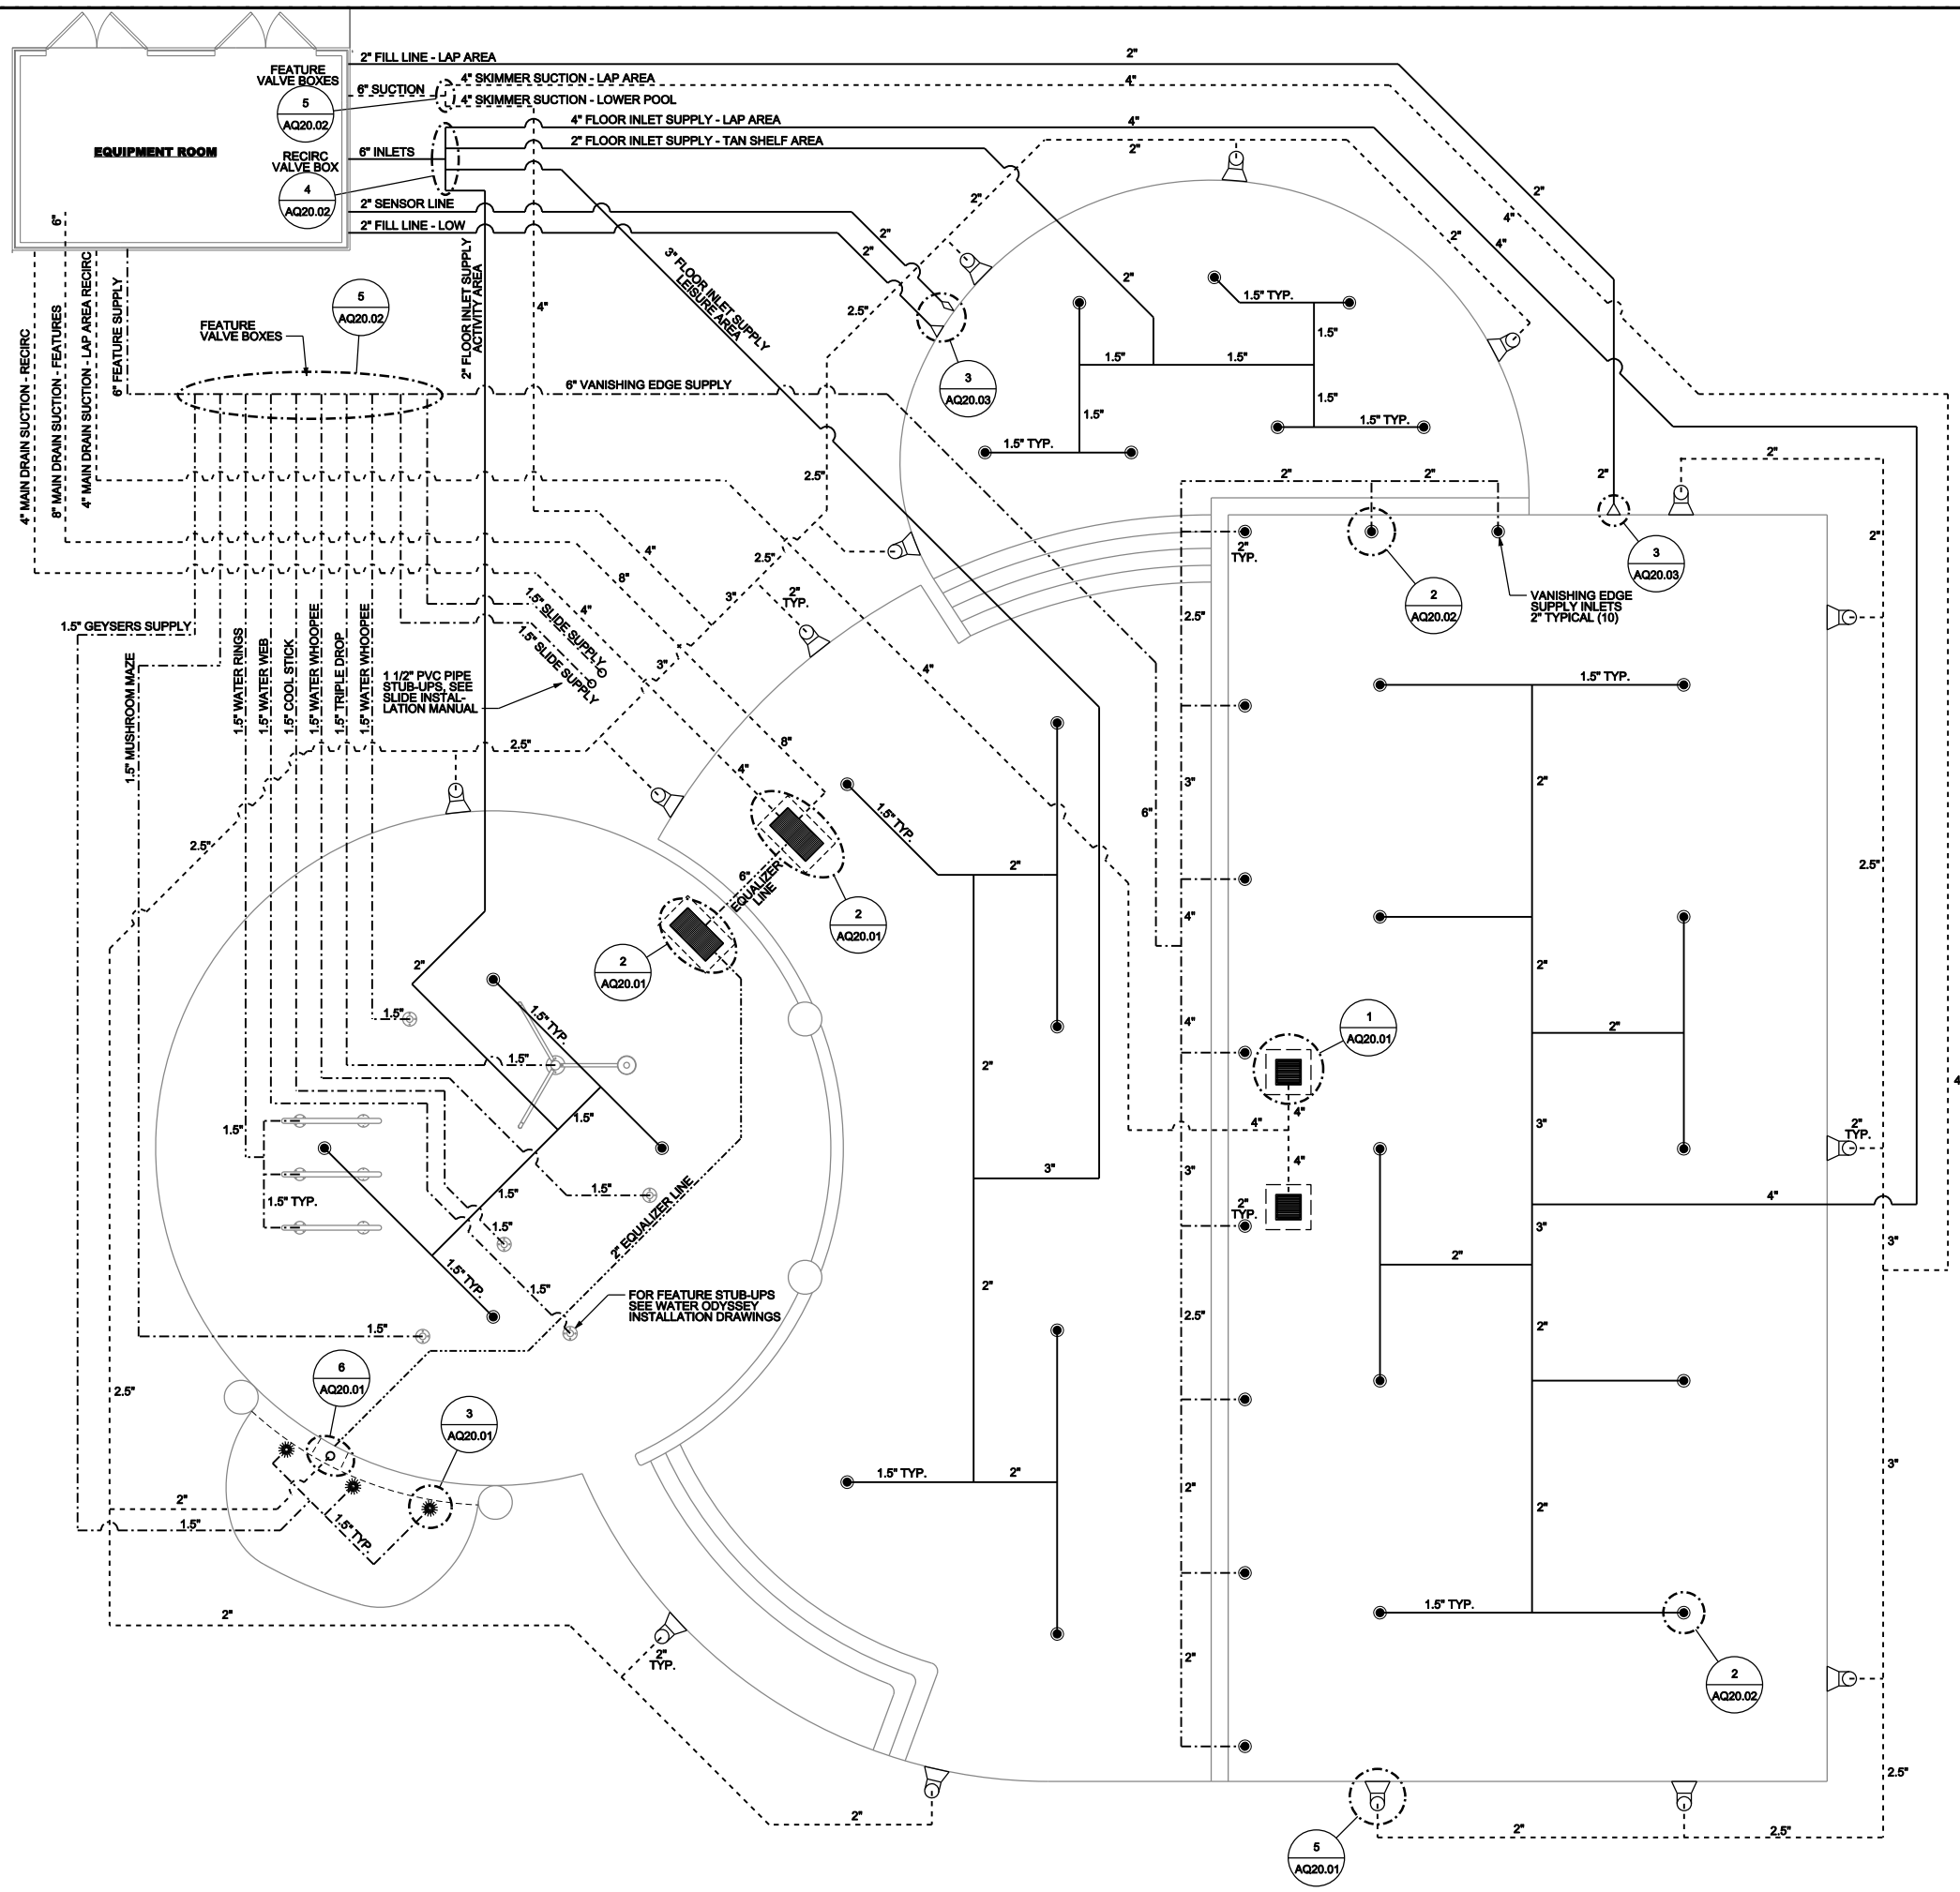

SYMBOL KEY	
	POOL FILL
	FILL SENSOR
	SKIMMER
	FLOOR INLET
	PIPE STUB-UP
	WALL INLET
	HYDRO JET INLET
	MAIN DRAIN
	AIR BREATHER
	SKIMMER EQUALIZER FITTING

PIPING KEY	
	RECIRC SUPPLY LINE
	GRAVITY LINE
	FEATURE SUPPLY LINE
	SUCTION LINE

- NOTES:**
- VELOCITY OF SUPPLY PIPING SHALL BE LESS THAN 10 FT/SEC.
 - VELOCITY OF SUCTION PIPING SHALL BE LESS THAN 6 FT/SEC.
 - POOL PIPING RUNS ARE SHOWN FOR SCHEMATIC PURPOSES ONLY. THEY ARE NOT INTENDED TO REFLECT ACTUAL PIPE LOCATION. (CONTRACTOR SHALL FIELD LOCATE POOL PIPING).
 - MAIN DRAIN SUCTION VELOCITY SHALL BE LESS THAN 1.5 FT/SEC THROUGH GRATE AT DESIGN FLOW.
 - ALL POOL PIPING SHALL BE RIGID PVC SCHEDULE 40 UNLESS OTHERWISE NOTED.
 - GRAVITY LINES TO HAVE A MINIMUM SLOPE OF 1/8" PER FOOT.



YMCA - BELLE CHASSE
 BELLE CHASSE, LOUISIANA
SWIMMING POOL PIPING PLAN

SCALE
 0 2.5' 5' 10'
 11" x 17" - 3/32" = 1"
 22" x 34" - 3/16" = 1"


PROJECT NUMBER
18655

SHEET NUMBER
AQ1.01

RAMAKER & ASSOCIATES, INC.
 1120 Dallas Street, Saut City, Wisconsin 53583
 Voice: 800-643-4100 Fax: 800-643-7999
 www.ramaker.com



This document contains confidential or proprietary information of Ramaker & Associates, Inc. Neither this document nor the information herein is to be reproduced, distributed, used or disclosed either in whole or in part except as authorized by Ramaker and Associates, Inc.

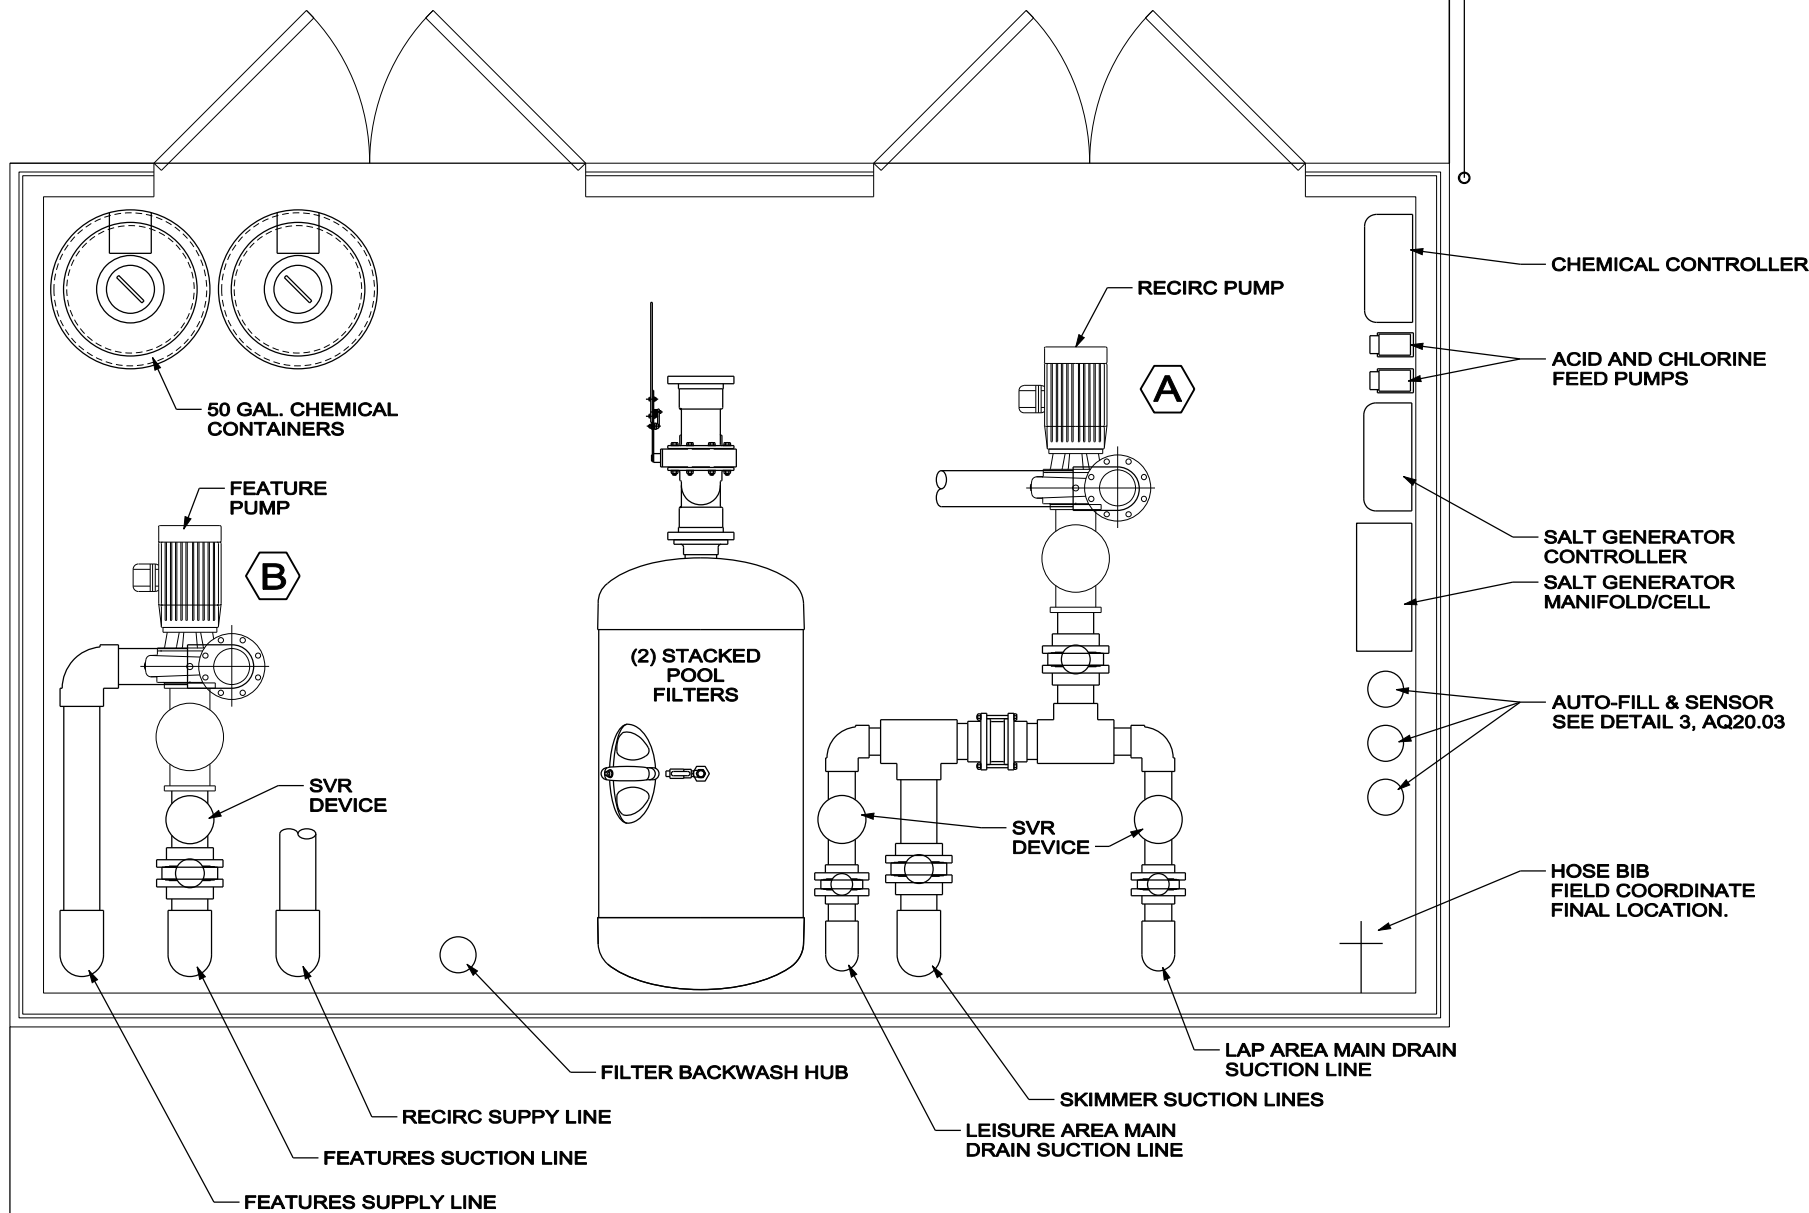

REQUIRED ELECTRICAL SERVICE FOR POOL EQUIPMENT ROOM			
QTY.	ITEM	VOLT/PH	COMMENTS
1	CHEMICAL FEED CONTROLLERS	110/1	ELEC. SERVICE
2	CHEMICAL FEED PUMPS	110/1	ELEC. SERVICE THRU CONTROLLER
1	SALT GENERATOR	220/1	

PUMP SCHEDULE FOR POOL EQUIPMENT ROOM						
MARK	QTY.	FLOW & HEAD REQUIREMENTS	HP	VOLT/ PHASE	HAIR & LINT TRAP	COMMENTS
A	1	425 GPM @ 75' TDH	10.0	230/1	Y	RECIRCULATION PUMP
B	1	525 GPM @ 30' TDH	10.0	230/1	Y	FEATURES PUMP

PLUMBING NOTES:

POOL AREA:

- HOSE BIBS - PROVIDE HOSE BIBS IN THE POOL AREA TO CONVENIENTLY SERVE THE POOL AREA WITH A MAXIMUM 100' HOSE.
- DRINKING FOUNTAIN - PROVIDE DRINKING FOUNTAIN(S) IN THE POOL VICINITY AS REQUIRED BY CODE.
- DECK DRAIN PIPING - PROVIDE DECK DRAIN PIPING THAT DISCHARGES TO THE GRADE THROUGH AN AIR GAP AS NEEDED.
- POOL FILL WATER - PROVIDE A 3/4" WATER SUPPLY IN AN EQUIPMENT SPACE AT POOL LEVEL.

EQUIPMENT ROOM:

- PROVIDE A HOSE BIB.
- PROVIDE FLOOR DRAINS.
- PROVIDE A HUB DRAIN FOR FILTER BACKWASH. HUB DRAIN SHALL DISCHARGE TO SANITARY SEWER (MAX. 230 GPM FLOW).

BATHROOMS:

- FLOOR DRAINS ARE RECOMMENDED.
- PROVIDE HOSE BIBS IN THE BATHROOMS, OR ENSURE THAT THE POOL AREA HOSE BIBS ARE LOCATED TO BE ABLE TO SERVE THE BATHROOMS WITH A MAXIMUM 100' HOSE.

GENERAL NOTES:

- POOL CONTRACTOR SHALL SET PUMPS. ELECTRICAL CONTRACTOR SHALL PROVIDE STARTERS AND ELECTRICAL SERVICE TO THE PUMPS.
- EQUIPMENT AND PIPING SHOWN FOR SCHEMATIC PURPOSES ONLY. POOL CONTRACTOR SHALL LOCATE EQUIPMENT AND PIPING IN FIELD.
- POOL CONTRACTOR TO CONNECT AUTOMATIC WATER FILL SYSTEM AND FILL SPOUT COLD WATER LINES FROM WATER SOURCE IN EQUIPMENT ROOM.


ELECTRICAL CONTRACTOR NOTES:

ELECTRICAL CONTRACTOR SHALL BE RESPONSIBLE FOR THE FOLLOWING:

- FURNISH AND INSTALL JUNCTION BOXES, CONDUITS AND SWITCHES FOR POOL LIGHTING.
- INSTALL POOL LIGHT FIXTURES (FIXTURES TO BE PROVIDED BY POOL CONTRACTOR, LIGHT NICHE TO BE FURNISHED AND INSTALLED BY POOL CONTRACTOR).
- FURNISH AND INSTALL EMERGENCY SHUT OFF SWITCHES FOR FEATURE PUMPS. ALL EMERGENCY SHUT OFF SWITCHES SHALL HAVE A PROTECTIVE PLASTIC COVER.
- ELECTRICAL WIRING TO SOLENOID VALVES, POOL WATER SENSORS, AND POOL FILLS.
- POOL CONTRACTOR TO SUPPLY SOLENOID VALVES FOR POOL FILLS.
- ELECTRICAL WIRING TO PUMPS, INCLUDING STARTERS AND BREAKERS.
- ELECTRICAL WIRING TO CHEMICAL CONTROLLERS AND FEED PUMPS.
- ELECTRICAL GROUNDING AND BONDING OF ALL STEEL IN THE POOL VESSEL AND ACCESSORIES SHALL CONFORM TO NEC, STATE, AND LOCAL CODES. BY ELECTRICAL CONTRACTOR.




RAMAKER & ASSOCIATES, INC.
 1120 Dallas Street, Sauk City, Wisconsin 53583
 Voice: 608-643-4100 Fax: 608-643-7999
 www.ramaker.com

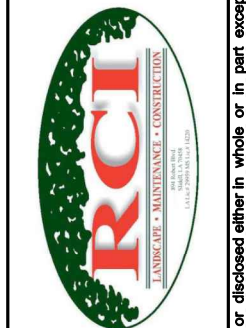


YMCA - BELLE CHASSE
 BELLE CHASSE, LOUISIANA
EQUIPMENT ROOM AND MEP NOTES

SCALE
 0 7.5" 1'-3" 2'-6"
 11" x 17" - 3/8" = 1'
 22" x 34" - 3/4" = 1'
 PROJECT NUMBER
18655
 SHEET NUMBER
AQ10.00


This document contains confidential or proprietary information of Ramaker & Associates, Inc. Neither this document nor the information herein is to be reproduced, distributed, used or disclosed either in whole or in part except as authorized by Ramaker and Associates, Inc.

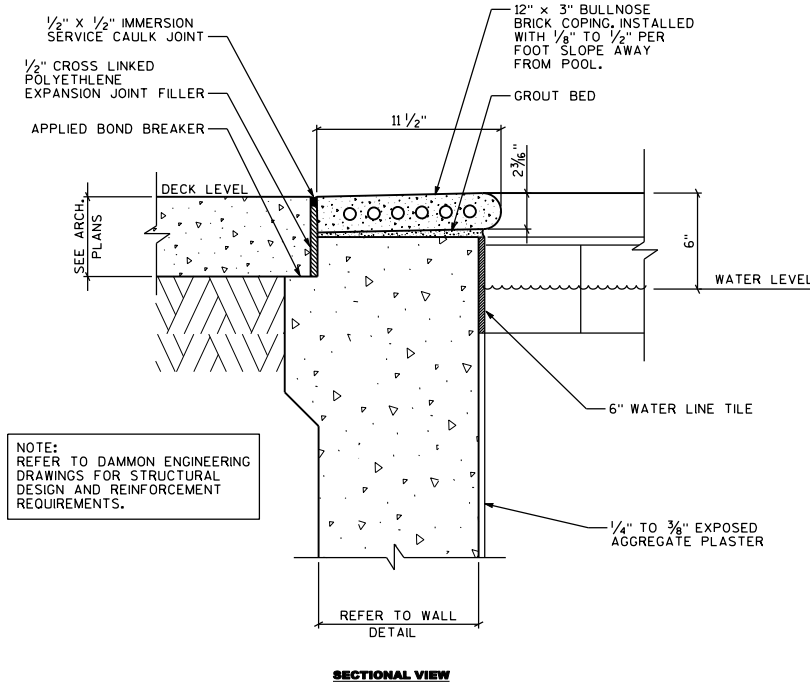


BRICK COPING DETAIL 1
SCALE: NONE

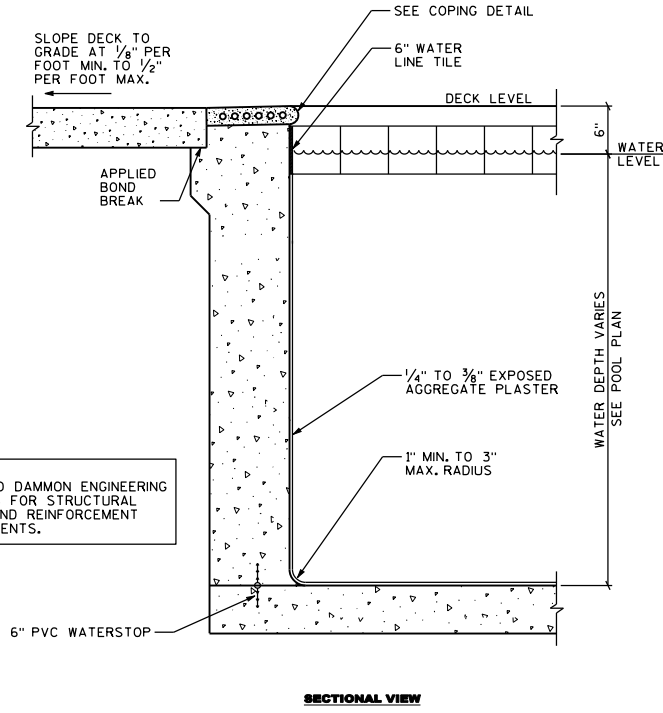


TYPICAL POOL WALL DETAIL 2
SCALE: 1" = 1'

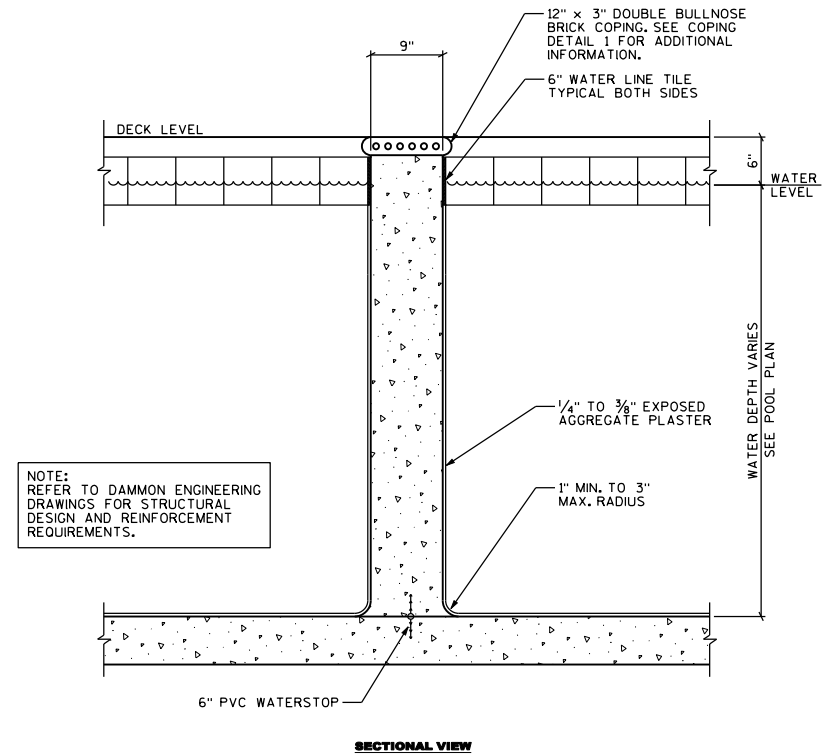


TYPICAL COMMON WALL DETAIL 3
SCALE: 1" = 1'

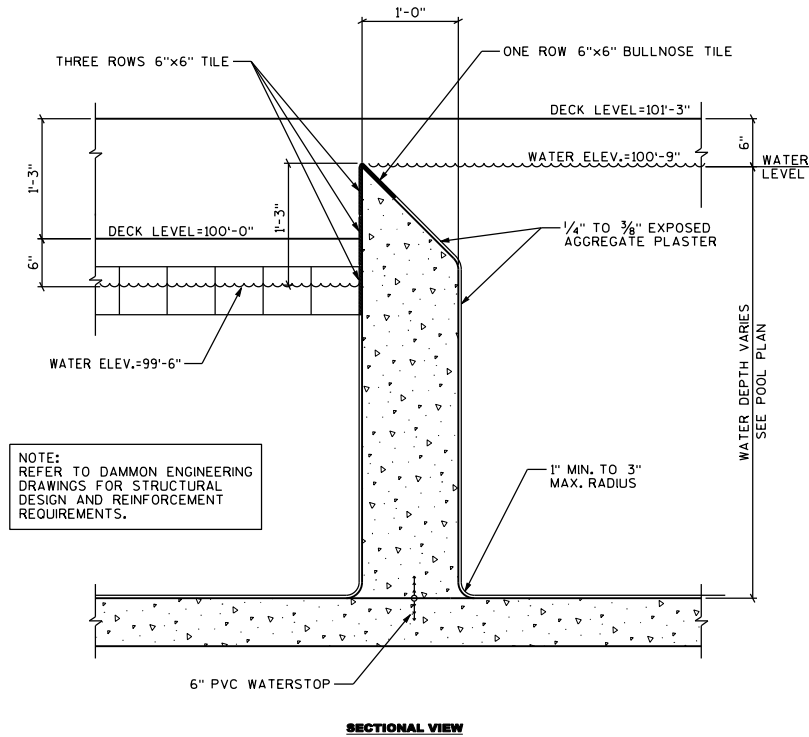



VANISHING EDGE WALL DETAIL 4
SCALE: 1" = 1'

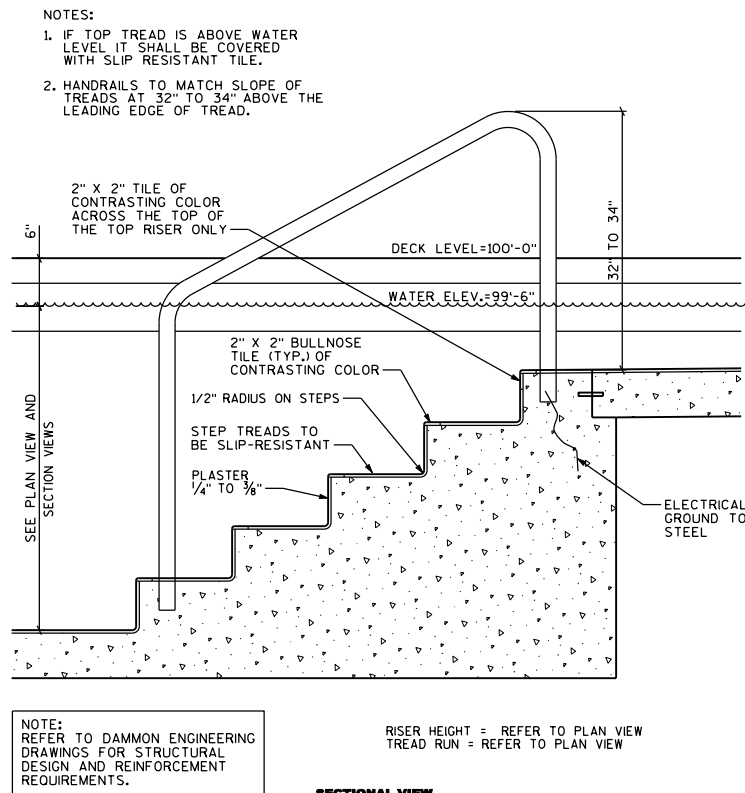


FOUR TREAD STAIR DETAIL 5
SCALE: NONE

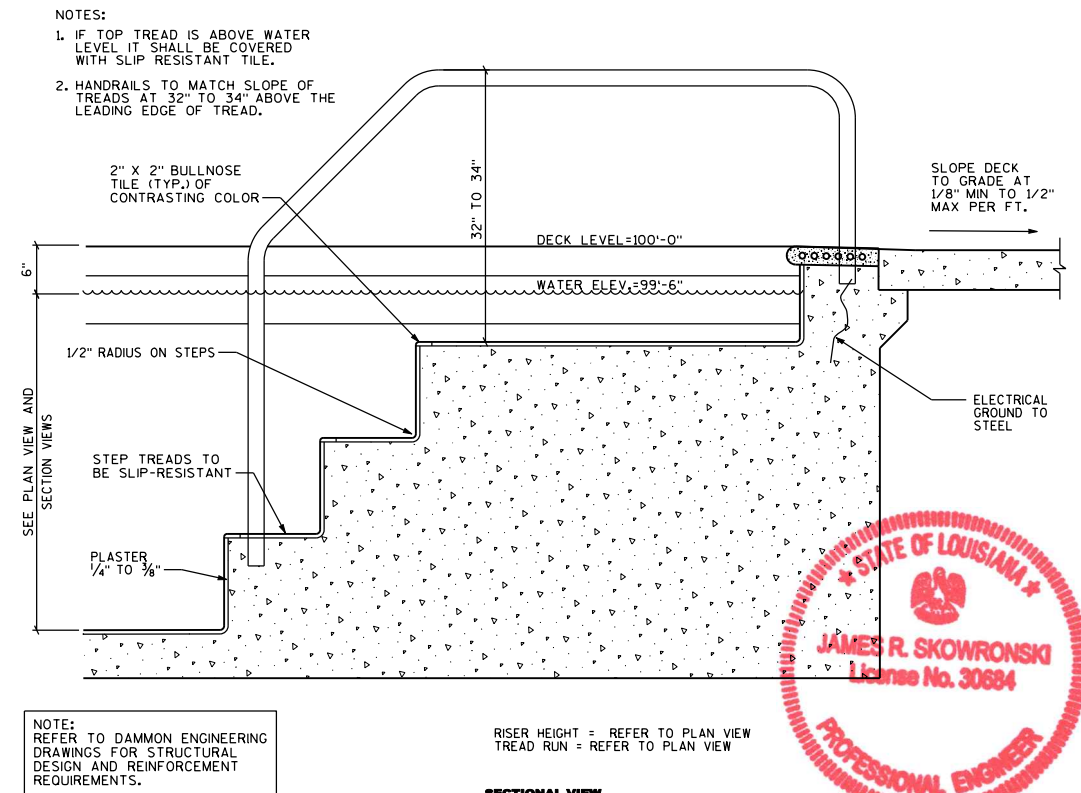


THREE TREAD STAIR DETAIL 6
SCALE: NONE

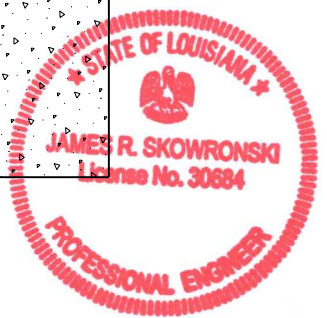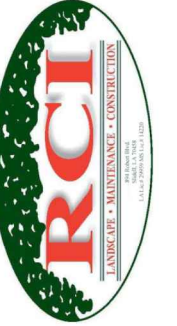

- NOTES:
- OPENINGS IN GRATES SHALL BE 1/2" OR LESS IN WIDTH OR DIAMETER
 - GRATES SHALL NOT BE REMOVABLE EXCEPT WITH TOOLS.
 - SEE EQUIPMENT SCHEMATIC FOR PIPE DIAMETERS.

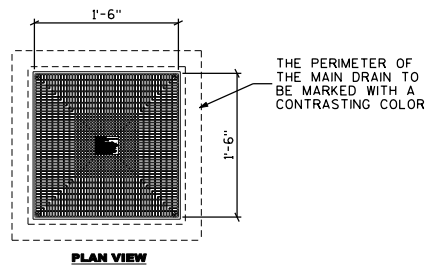


THE PERIMETER OF THE MAIN DRAIN TO BE MARKED WITH A CONTRASTING COLOR

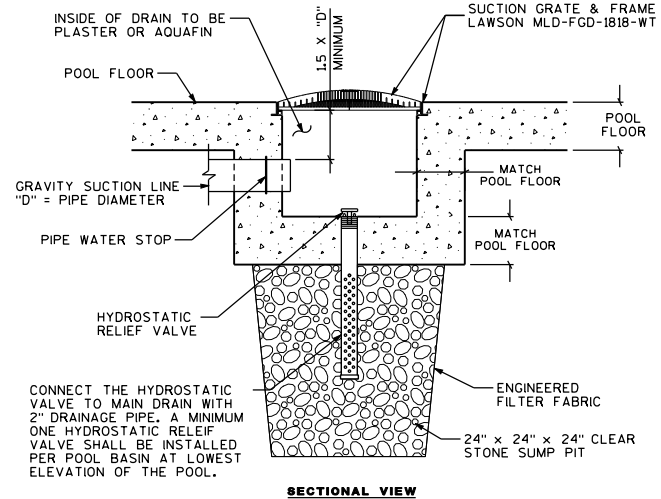


CONNECT THE HYDROSTATIC VALVE TO MAIN DRAIN WITH 2" DRAINAGE PIPE. A MINIMUM ONE HYDROSTATIC RELIEF VALVE SHALL BE INSTALLED PER POOL BASIN AT LOWEST ELEVATION OF THE POOL.

MAIN DRAIN DETAIL 18" X 18" 1
SCALE: 1" = 1'

- NOTES:
- OPENINGS IN GRATES SHALL BE 1/2" OR LESS IN WIDTH OR DIAMETER
 - GRATES SHALL NOT BE REMOVABLE EXCEPT WITH TOOLS.
 - SEE EQUIPMENT SCHEMATIC FOR PIPE DIAMETERS.

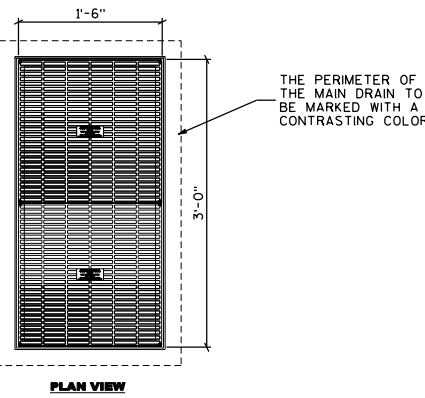


THE PERIMETER OF THE MAIN DRAIN TO BE MARKED WITH A CONTRASTING COLOR

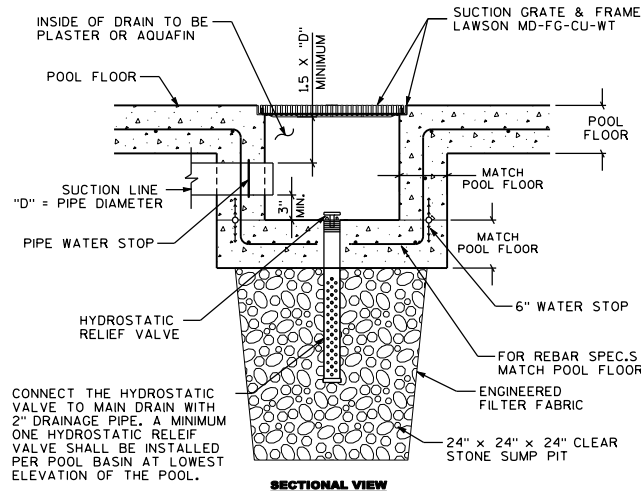


CONNECT THE HYDROSTATIC VALVE TO MAIN DRAIN WITH 2" DRAINAGE PIPE. A MINIMUM ONE HYDROSTATIC RELIEF VALVE SHALL BE INSTALLED PER POOL BASIN AT LOWEST ELEVATION OF THE POOL.

MAIN DRAIN DETAIL 18" X 36" 2
SCALE: 1" = 1'

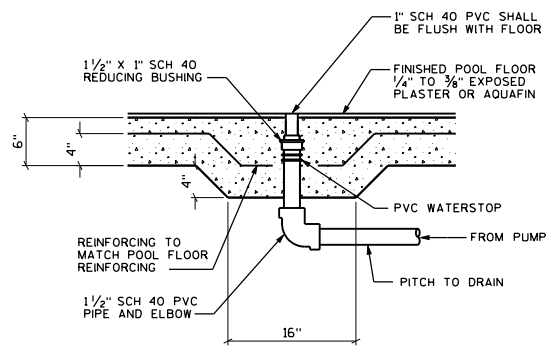


GEYSER DETAIL 3
SCALE: NONE

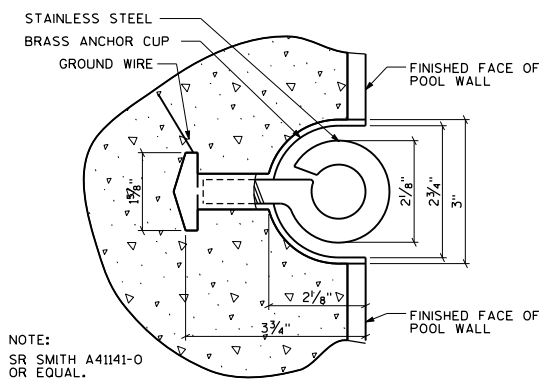


NOTE: SR SMITH A41141-0 OR EQUAL.


ROPE ANCHOR DETAIL 4
SCALE: NONE

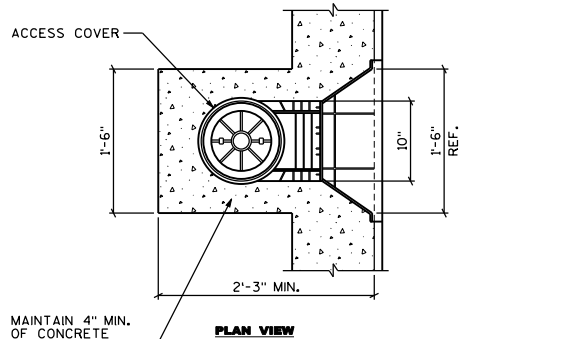


MAINTAIN 4" MIN. OF CONCRETE AROUND SKIMMER

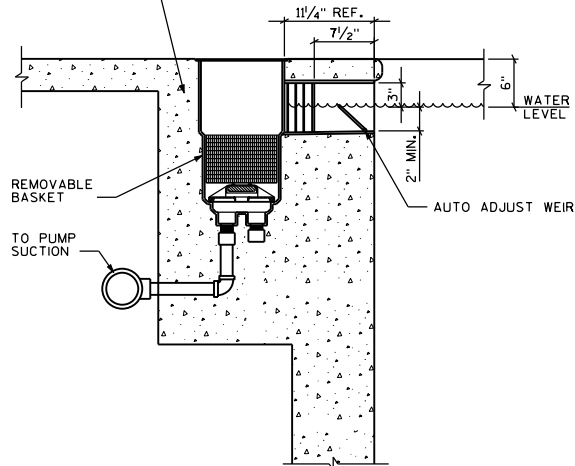


SKIMMER DETAIL 5
SCALE: 1" = 1'

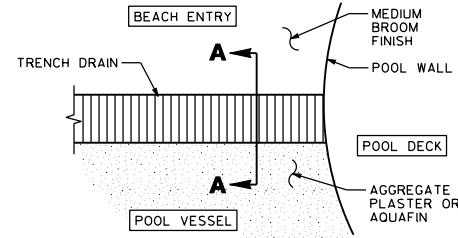

FINISH DETAILS

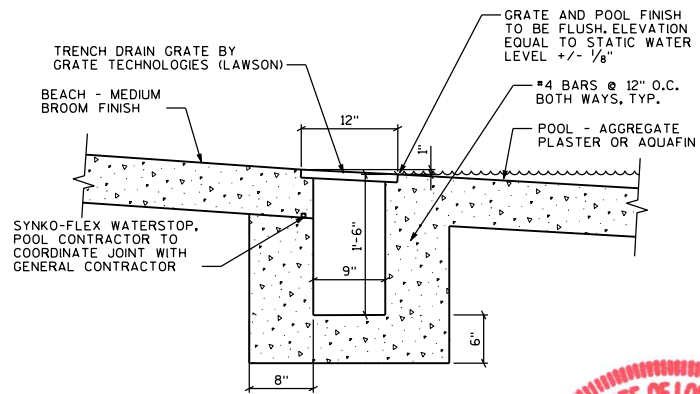

TRENCH SECTION A-A

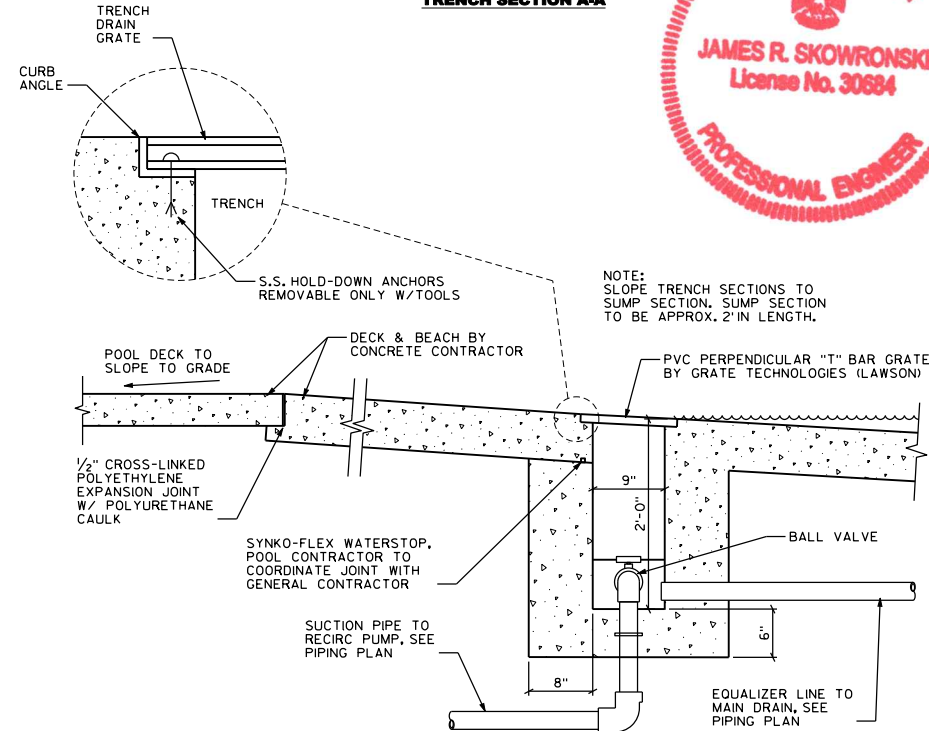

TRENCH DRAIN & SUMP DETAIL 6
SCALE: NONE




YMCA - BELLE CHASSE
BELLE CHASSE, LOUISIANA
STANDARD POOL DETAILS


SCALE: AS NOTED
PROJECT NUMBER: 18655
SHEET NUMBER: AQ20.01

RAMAKER & ASSOCIATES, INC.
1120 Dallas Street, Sauk City, Wisconsin 53683
Voice: 608-643-4100 Fax: 608-643-7999
www.ramaker.com





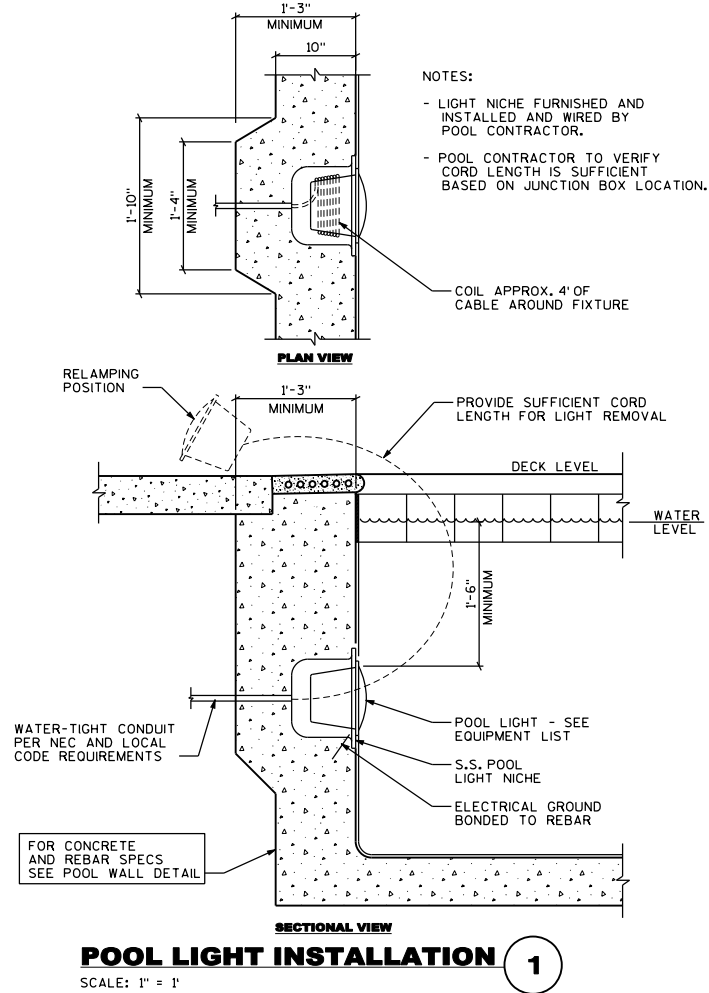


NOTE:
REFER TO DATA AND EQUIPMENT LIST FOR NUMBER OF TURNS OPEN. ADDITIONAL ADJUSTMENT OF FLOW BY CONTRACTOR MAY BE NECESSARY TO BALANCE THE FLOW.

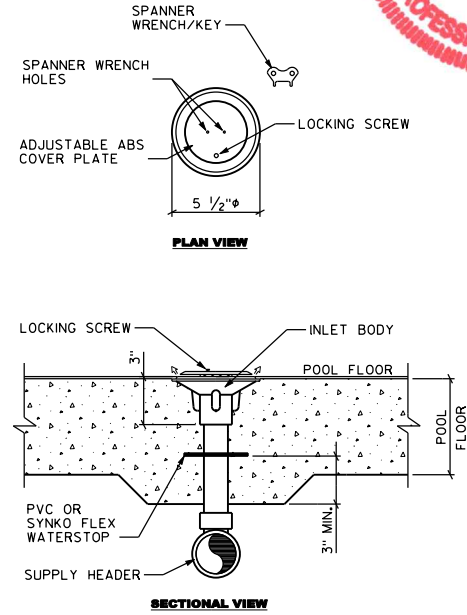

MARKER REQUIREMENTS:
SWIMMING POOLS, ACTIVITY POOLS, WAVE POOLS, PLUNGE POOLS, RIVERS:
1. DEPTH MARKERS
2. "NO DIVING" MARKER WITH EACH DEPTH MARKER
3. "NO RUNNING" MARKER AT 50' MAX. INTERVALS ON DECK ONLY

- NOTES:**
- UNLESS OTHERWISE NOTED, DEPTH MARKERS SHALL BE PLACED ON BOTH THE DECK AND WALL SURFACES.
 - ALL DECK TILES TO BE WITHIN 18" OF POOL WATER SURFACE.
 - ALL DECK TILES TO BE POSITIONED TO BE READ WHILE STANDING ON THE DECK FACING THE WATER.
 - DEPTH MARKERS TO BE IN ENGLISH.
 - DEPTH MARKERS AT MAXIMUM AND MINIMUM POINTS, POINTS OF CHANGE IN SLOPE, AND AT A MAXIMUM SPACING OF 25' CENTER TO CENTER.
 - "NO ENTRY" TILES TO BE IN ALL AREAS UNTIL AT LEAST 3 FOOT WATER DEPTH IS REACHED (EXCEPT BEACH ENTRY) AND AT A MAXIMUM SPACING OF 15' CENTER TO CENTER.
 - ALL DECK TILES SHALL BE NON-SLIP TYPE.
 - LETTERS/NUMERAL COLOR SHALL CONTRAST WITH THE BACKGROUND.

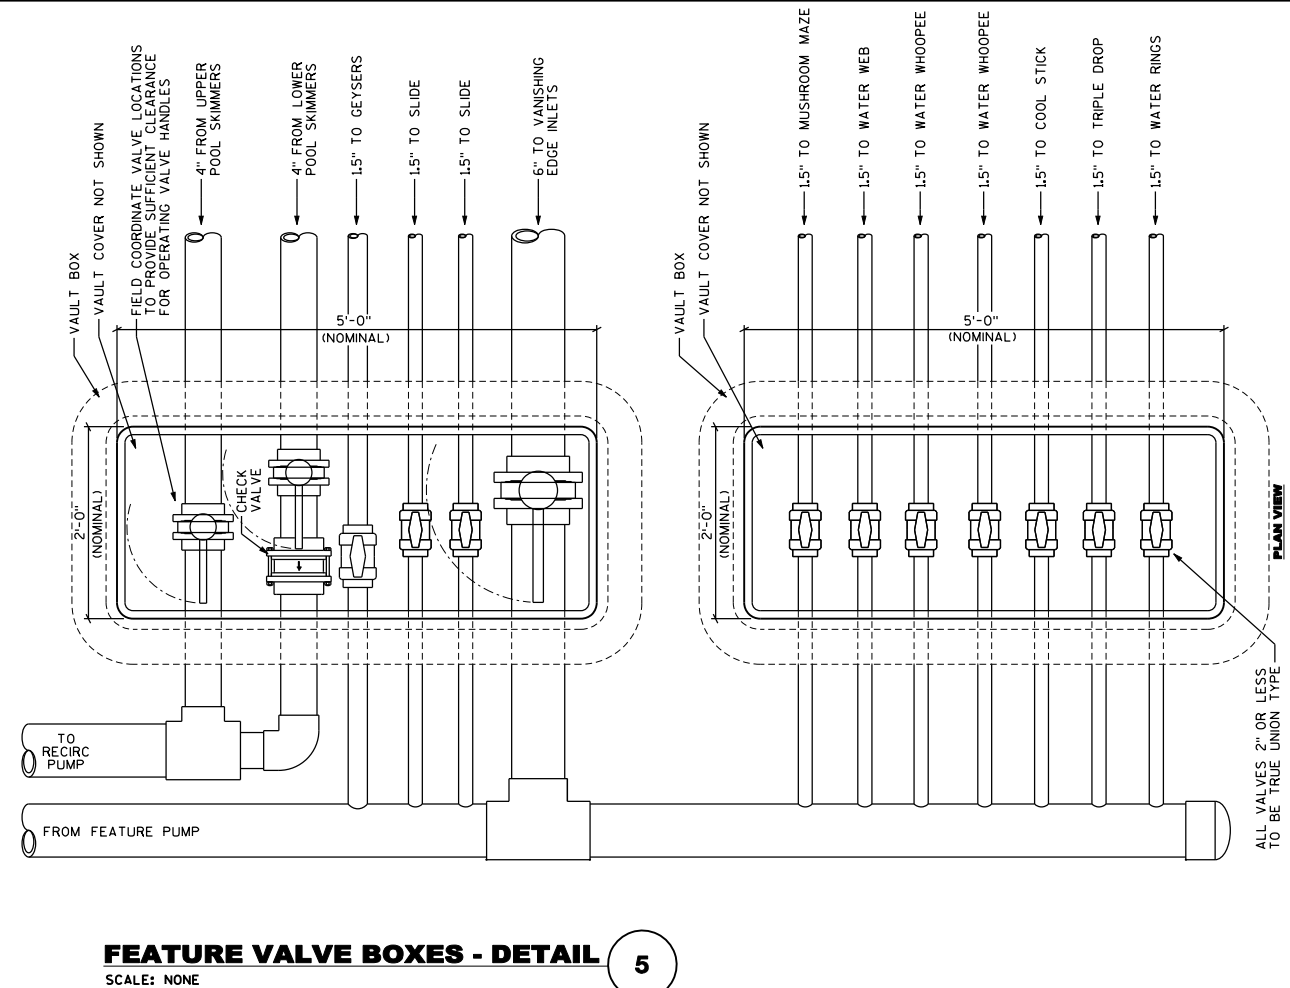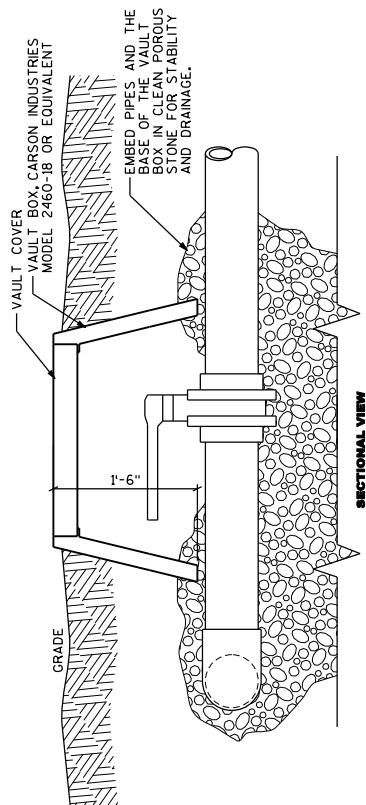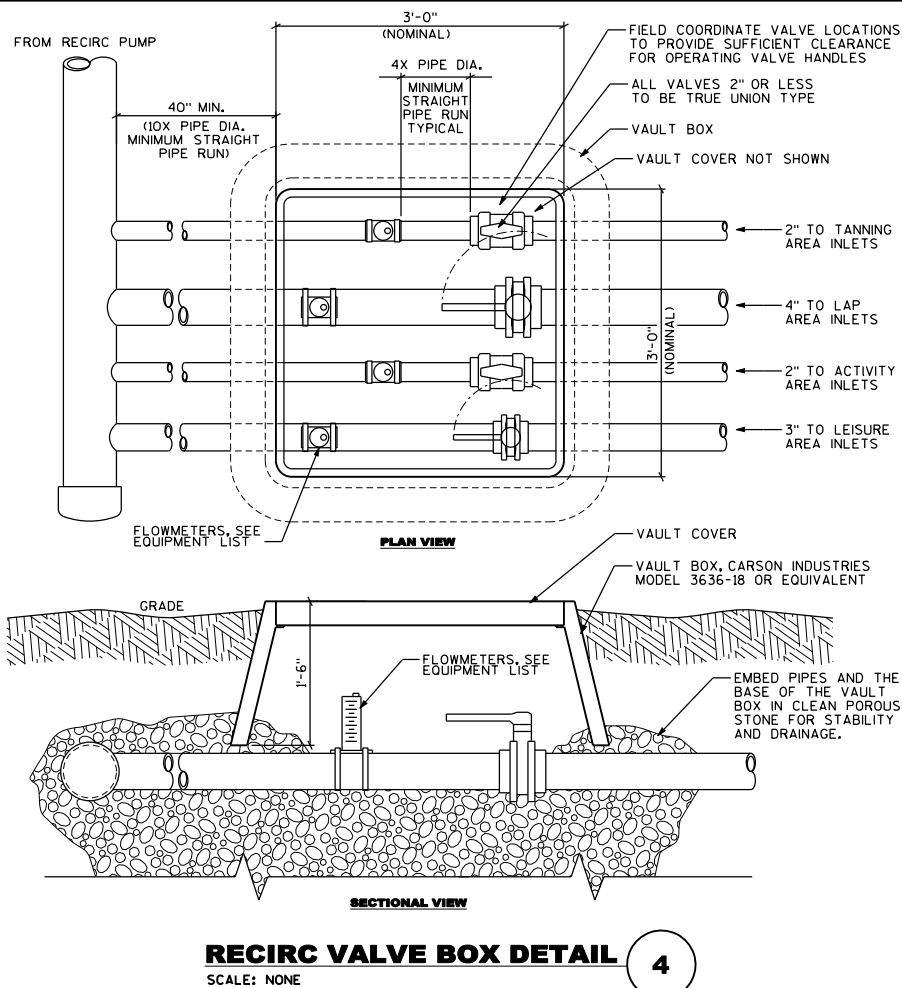


YMCA - BELLE CHASSE
BELLE CHASSE, LOUISIANA
SHEET TITLE
STANDARD POOL DETAILS

SCALE
AS NOTED

PROJECT NUMBER
18655

SHEET NUMBER
AQ20.02

RAMAKER & ASSOCIATES, INC.
1120 Dallas Street, Sauk City, Wisconsin 53683
Voice: 608-643-4100 Fax: 608-643-7999
www.ramaker.com

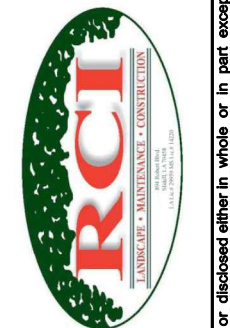

This document contains confidential or proprietary information of Ramaker & Associates, Inc. Neither this document nor the information herein is to be reproduced, distributed, used or disclosed either in whole or in part except as authorized by Ramaker and Associates, Inc.



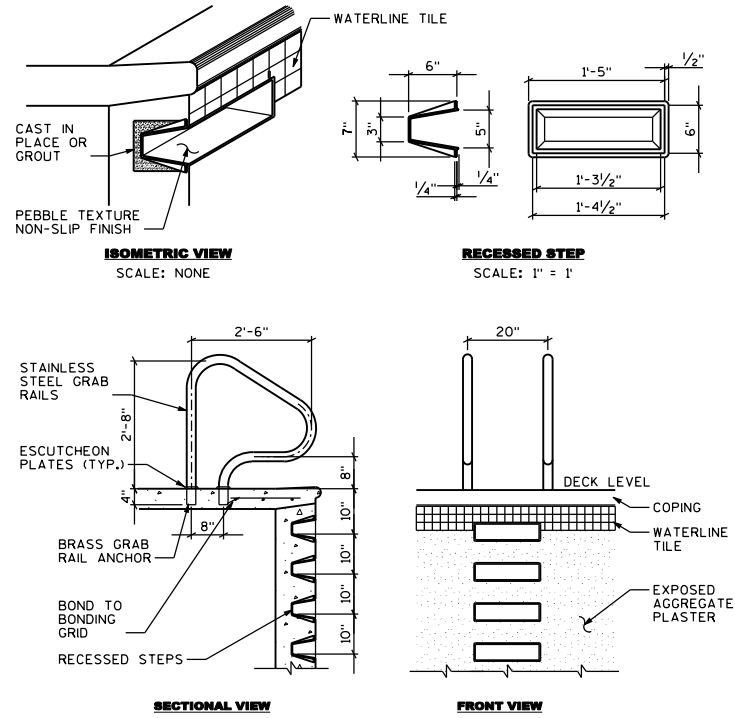



FIGURE FOUR LADDER DETAIL 1
SCALE: NONE

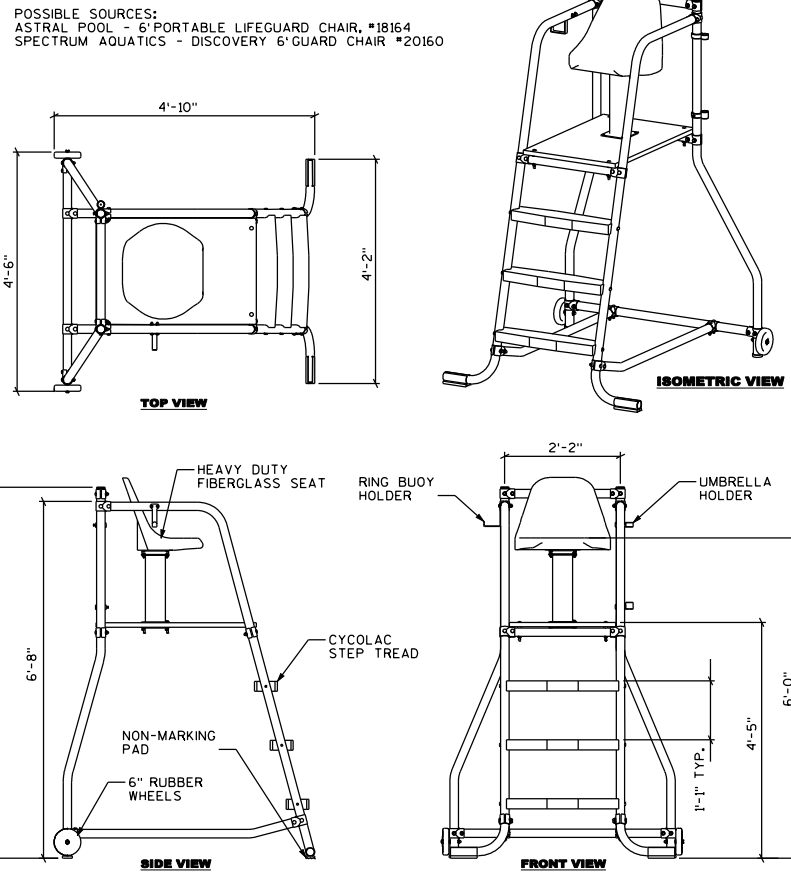

LIFEGUARD STAND DETAIL 2
SCALE: NONE

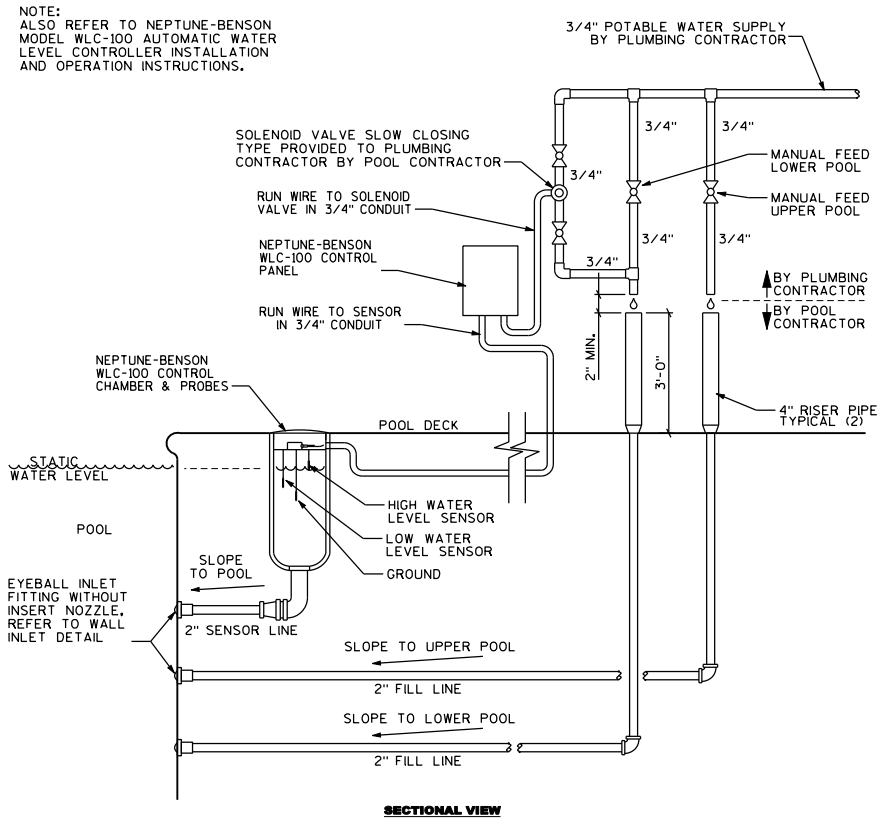


AUTO-FILL AND SENSOR DETAIL 3
SCALE: NONE

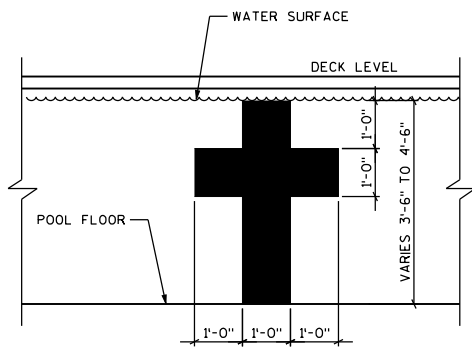


NOTE: TARGET SHALL BE OF A CONTRASTING COLOR & FINISHED FLUSH WITH POOL BASIN.

WALL AND FLOOR LANE MARKERS 4
SCALE: 1/2" = 1'

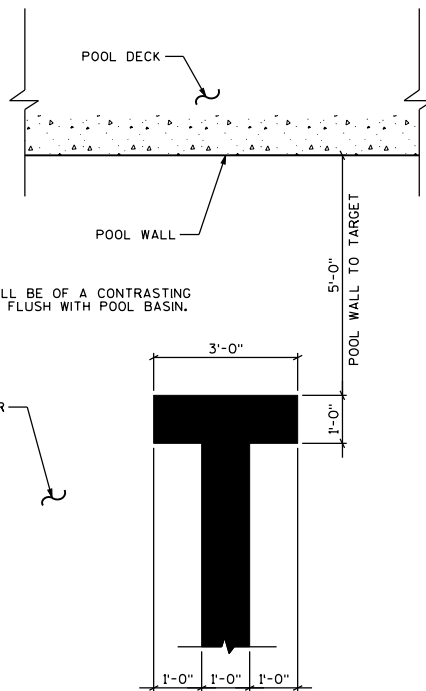

NOTE: MARKER SHALL BE OF A CONTRASTING COLOR & FINISHED FLUSH WITH POOL BASIN.

SCALE: 1/2" = 1'

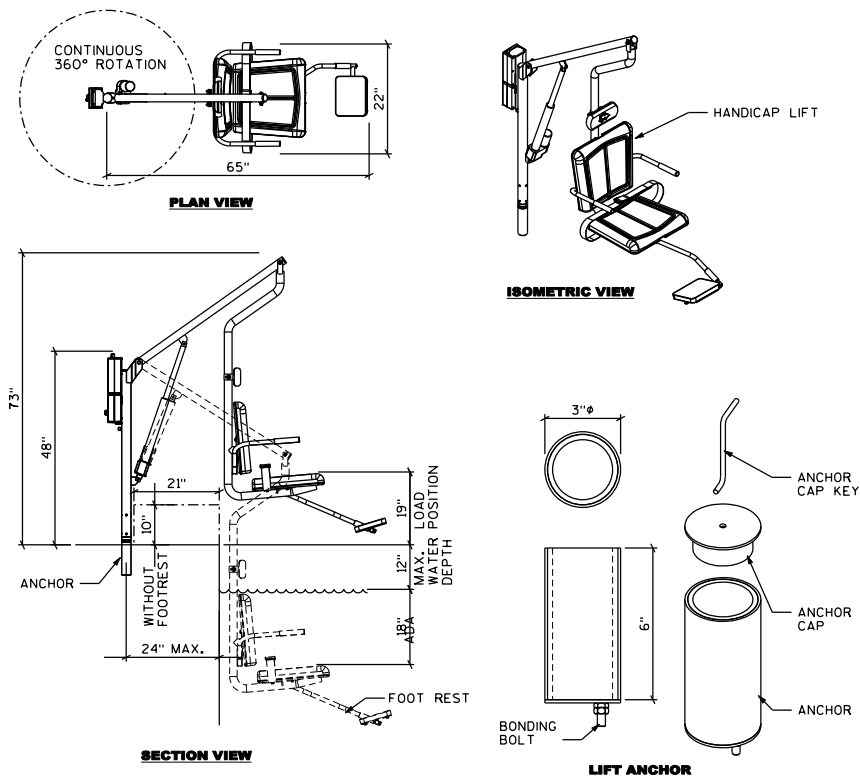

SUPPLIER:
HANDICAP LIFT - SPECTRUM MODEL: ASPEN BP350 - BY OWNER.
LIFT ANCHOR - SPECTRUM MODEL: ELKHORN 28510 - BY POOL CONTRACTOR.

HANDICAP LIFT / ANCHOR DETAIL 5
SCALE: NONE


RAMAKER & ASSOCIATES, INC.
1120 Dallas Street, Sauk City, Wisconsin 53683
Voice: 608-643-4100 Fax: 608-643-7999
www.ramaker.com



YMCA - BELLE CHASSE
BELLE CHASSE, LOUISIANA
STANDARD POOL DETAILS

SCALE	AS NOTED
PROJECT NUMBER	18655
SHEET NUMBER	AQ20.03

This document contains confidential or proprietary information of Ramaker & Associates, Inc. Neither this document nor the information herein is to be reproduced, distributed, used or disclosed either in whole or in part except as authorized by Ramaker and Associates, Inc.

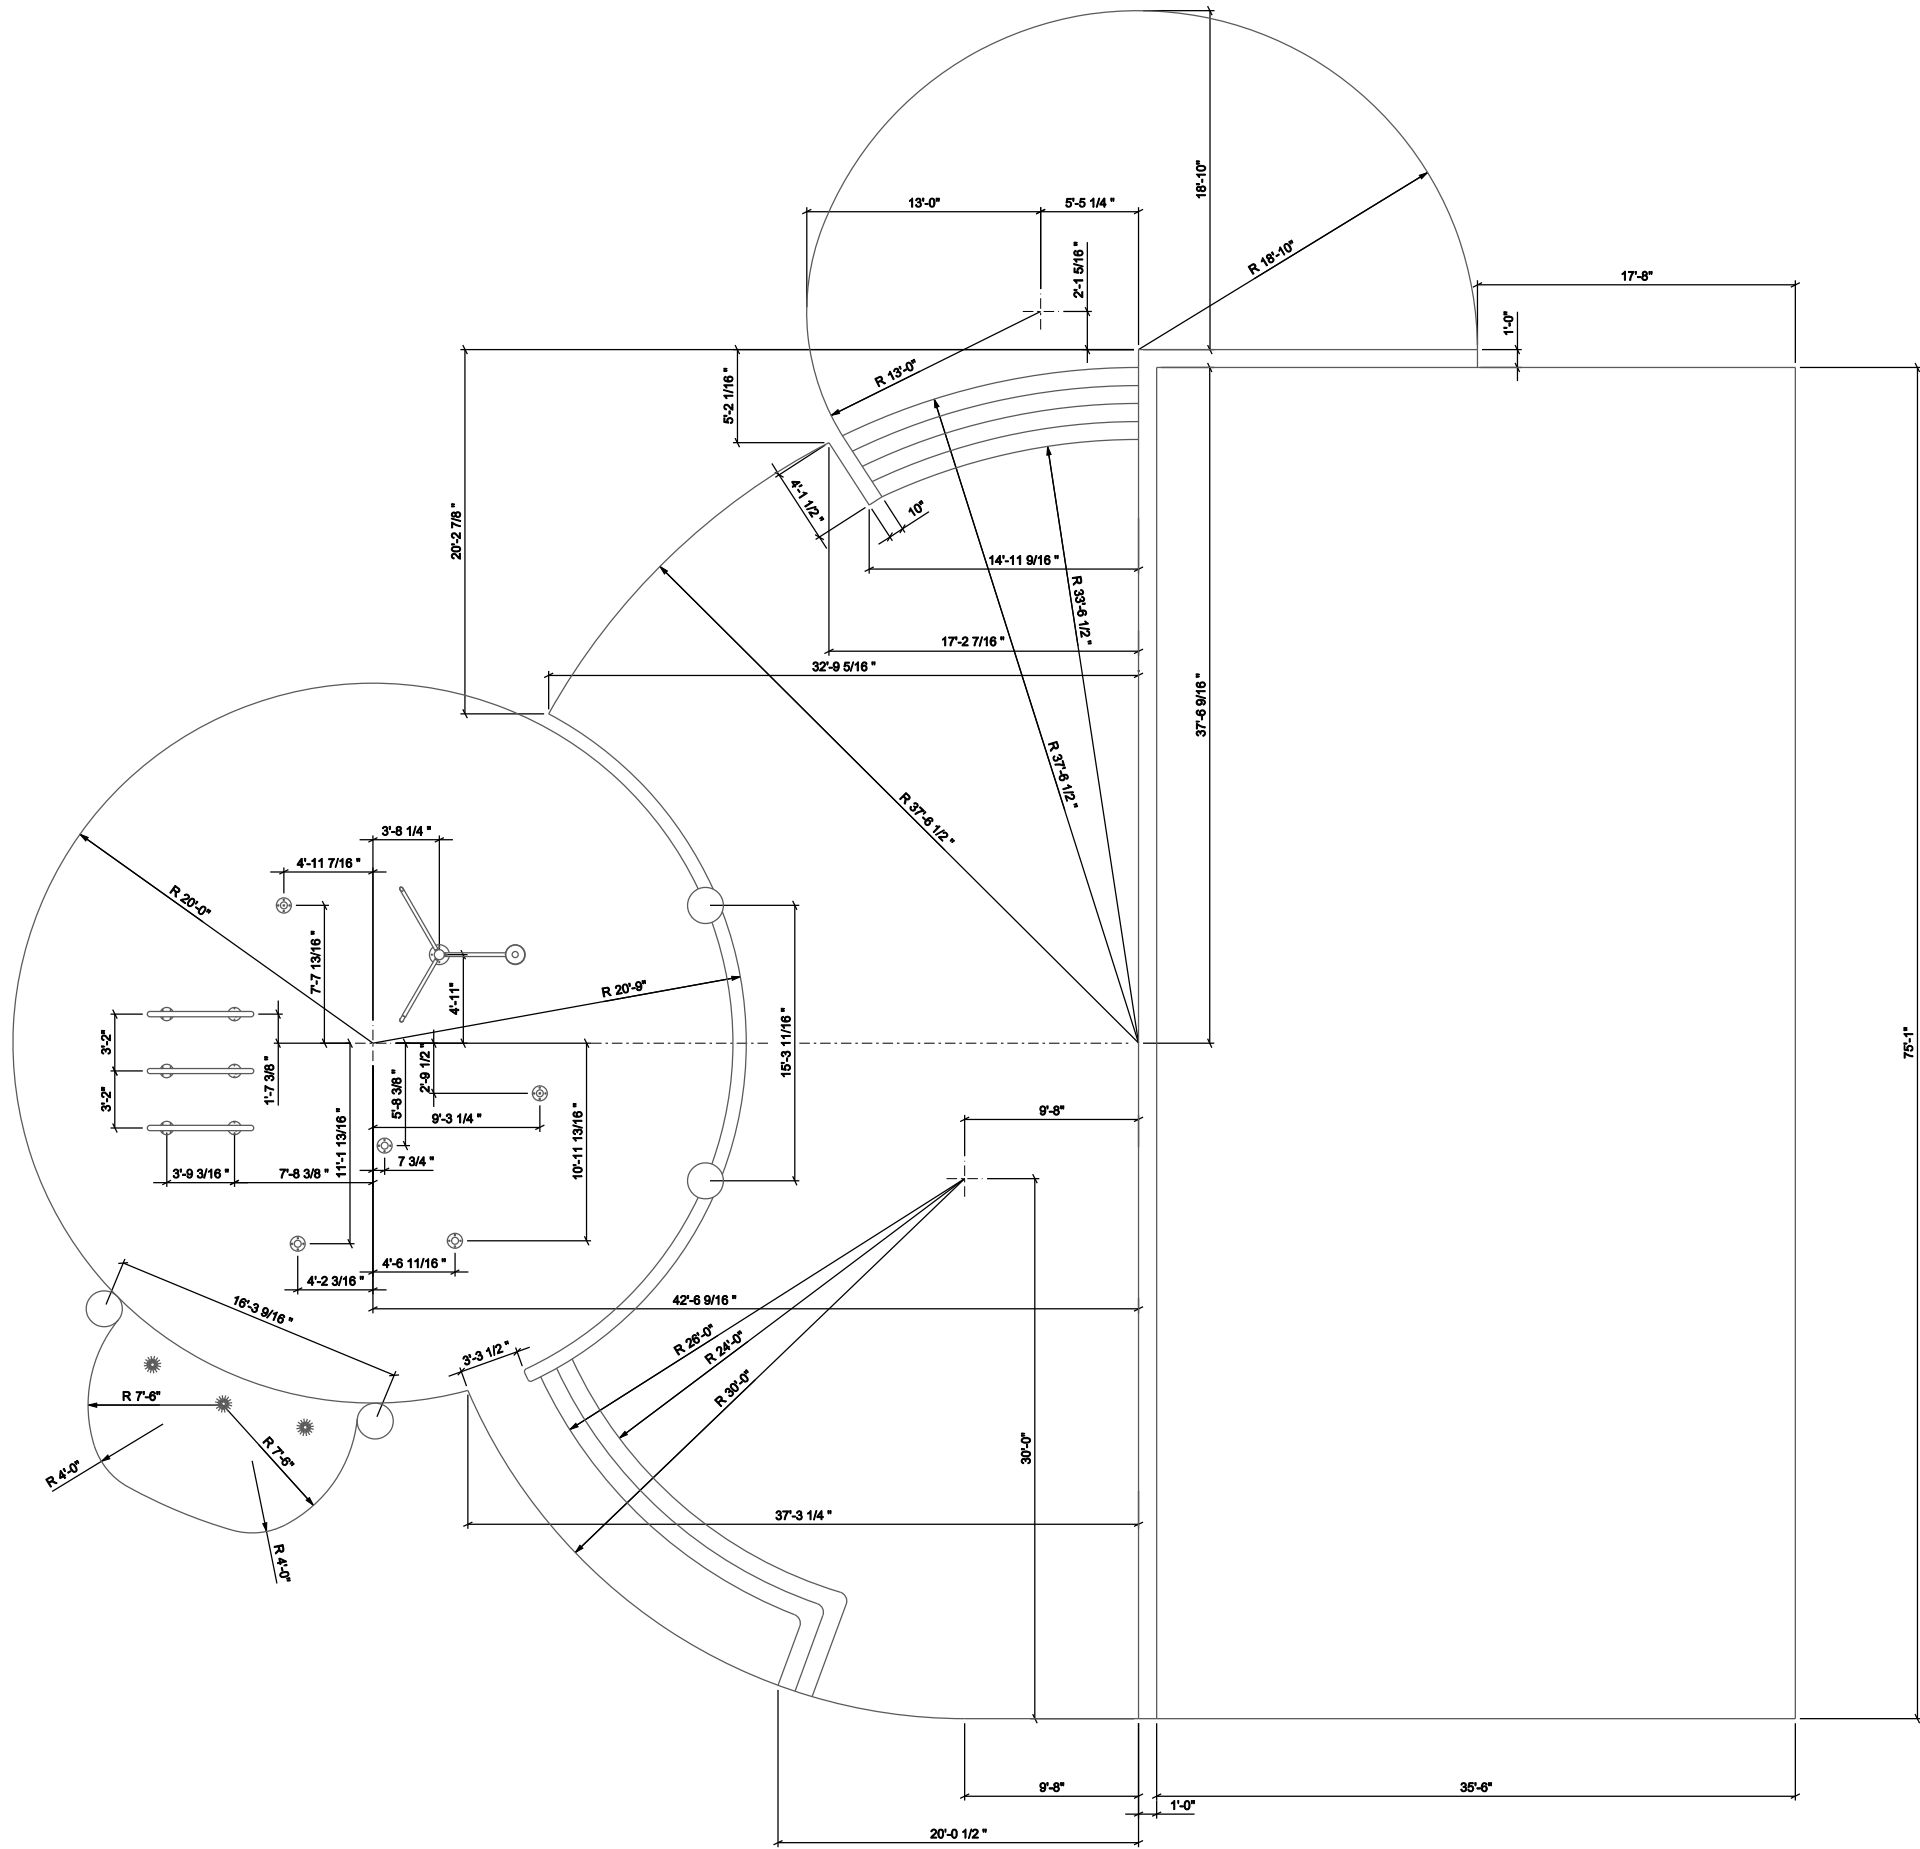

YMCA - BELLE CHASSE
 BELLE CHASSE, LOUISIANA
 DIMENSIONAL PLAN

SCALE
 0 2.5' 5' 10'
 11" x 17" - 3/32" = 1'
 22" x 34" - 3/16" = 1'

PROJECT NUMBER
18655

SHEET NUMBER
AQ30.00



RAMAKER & ASSOCIATES, INC.
 1120 Dallas Street, Sauk City, Wisconsin 53683
 Voice: 608-643-4100 Fax: 608-643-7999
 www.ramaker.com

This document contains confidential or proprietary information of Ramaker & Associates, Inc. Neither this document nor the information herein is to be reproduced, distributed, used or disclosed either in whole or in part except as authorized by Ramaker and Associates, Inc.