



FILE NAME: J:\A101 - RESIDENTIAL\101 - Sanders Residential - Bathroom add\Working.dwg DATE: 11/15/2021 11:35:50 AM

12ND FLOOR
SCALE: 1/4"=1'-0"

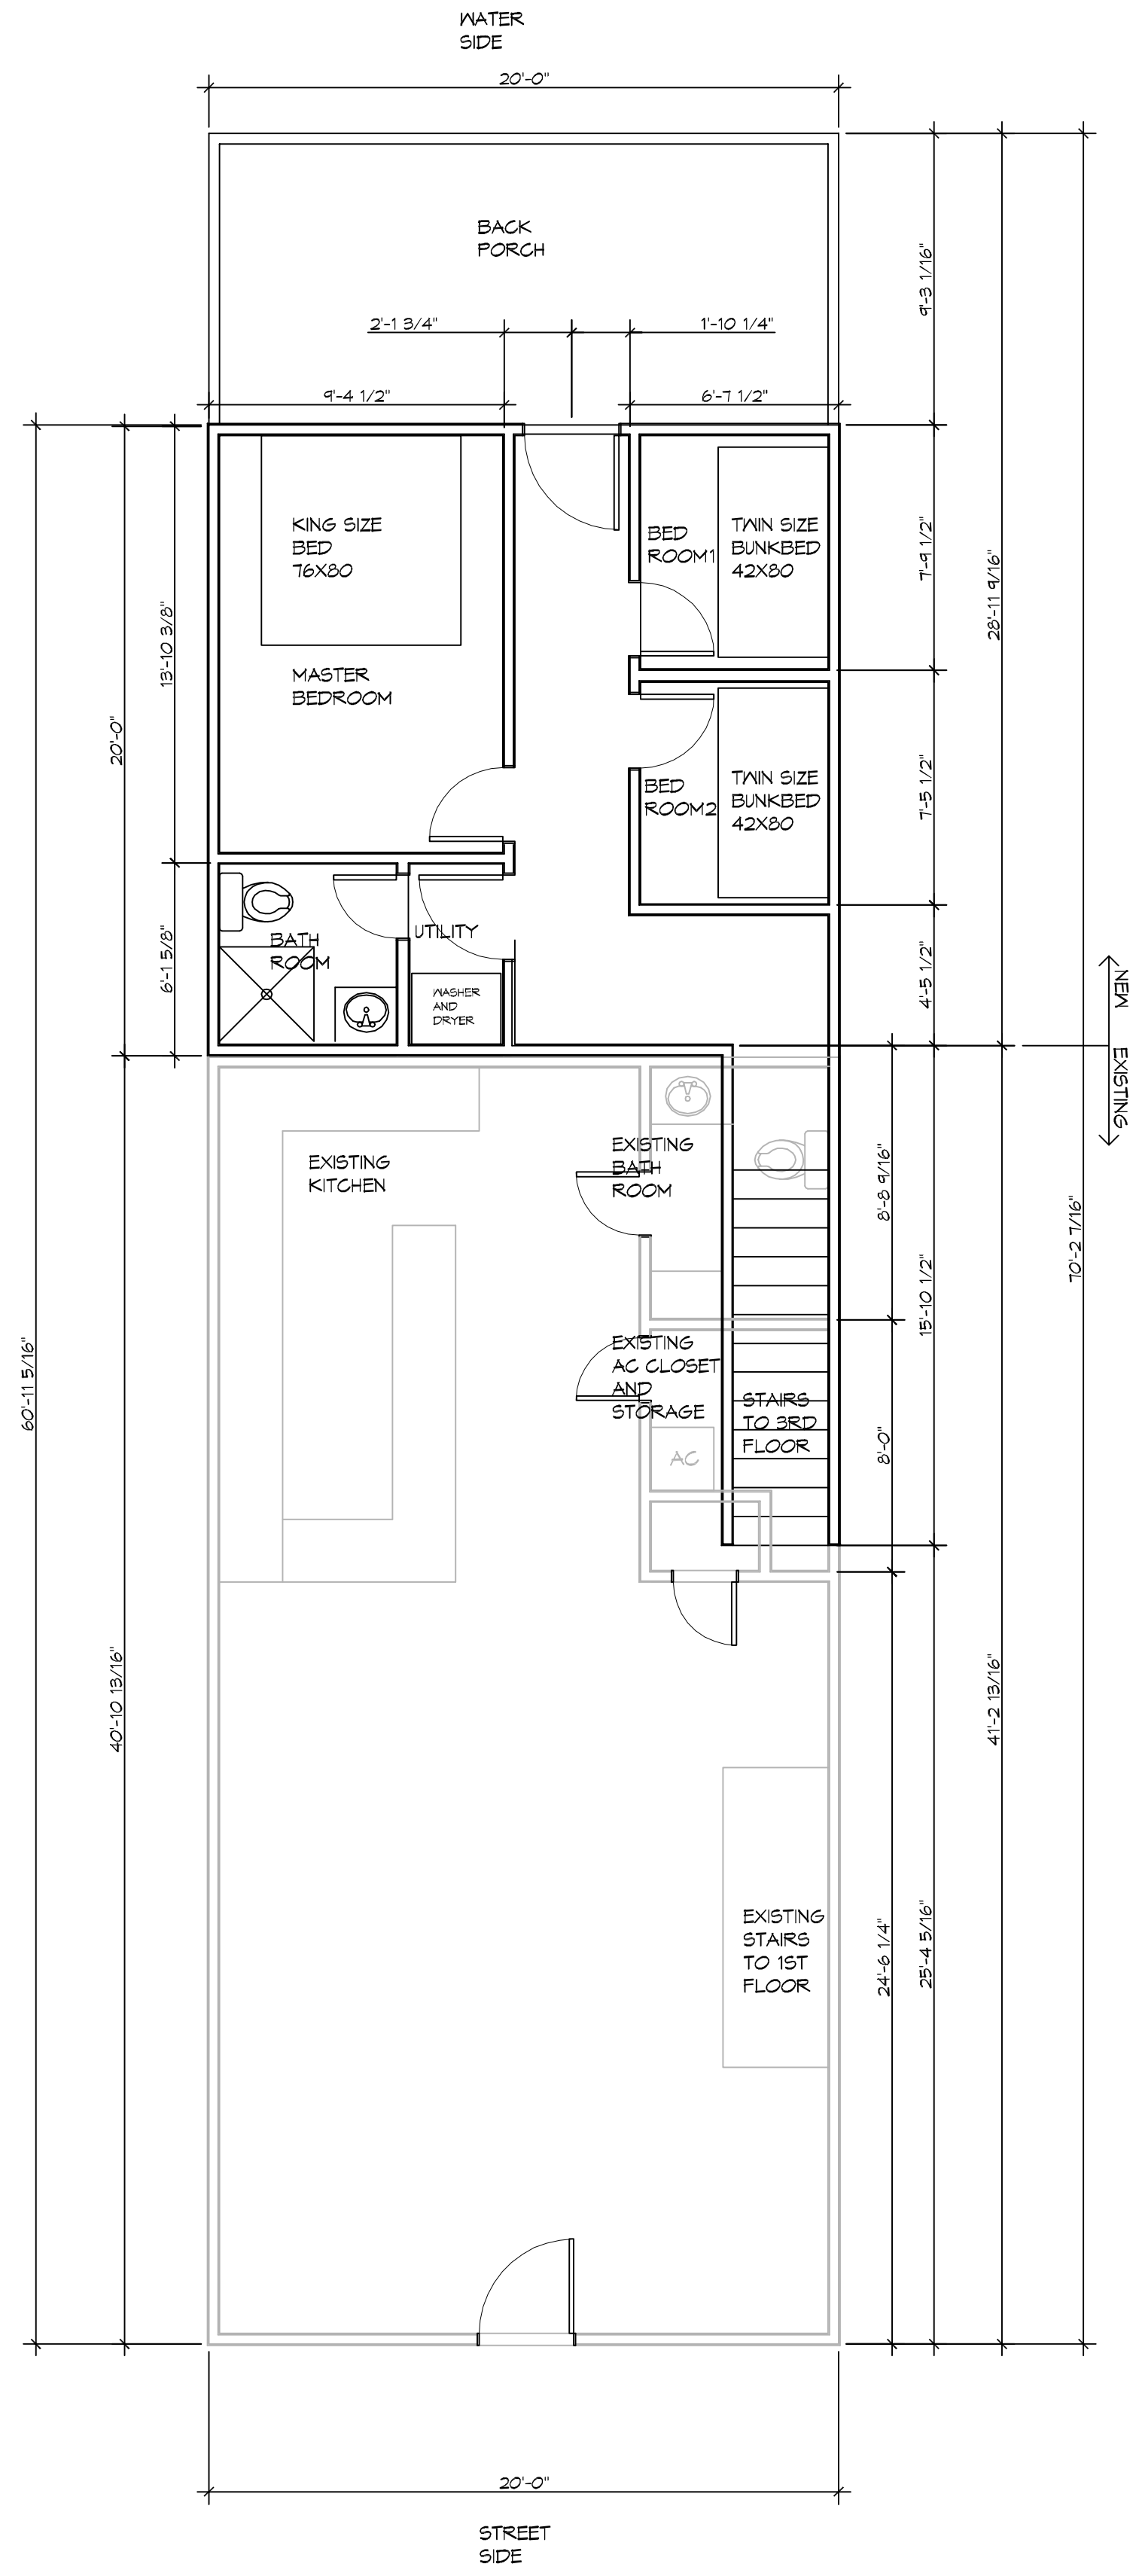

23RD FLOOR
SCALE: 1/4"=1'-0"

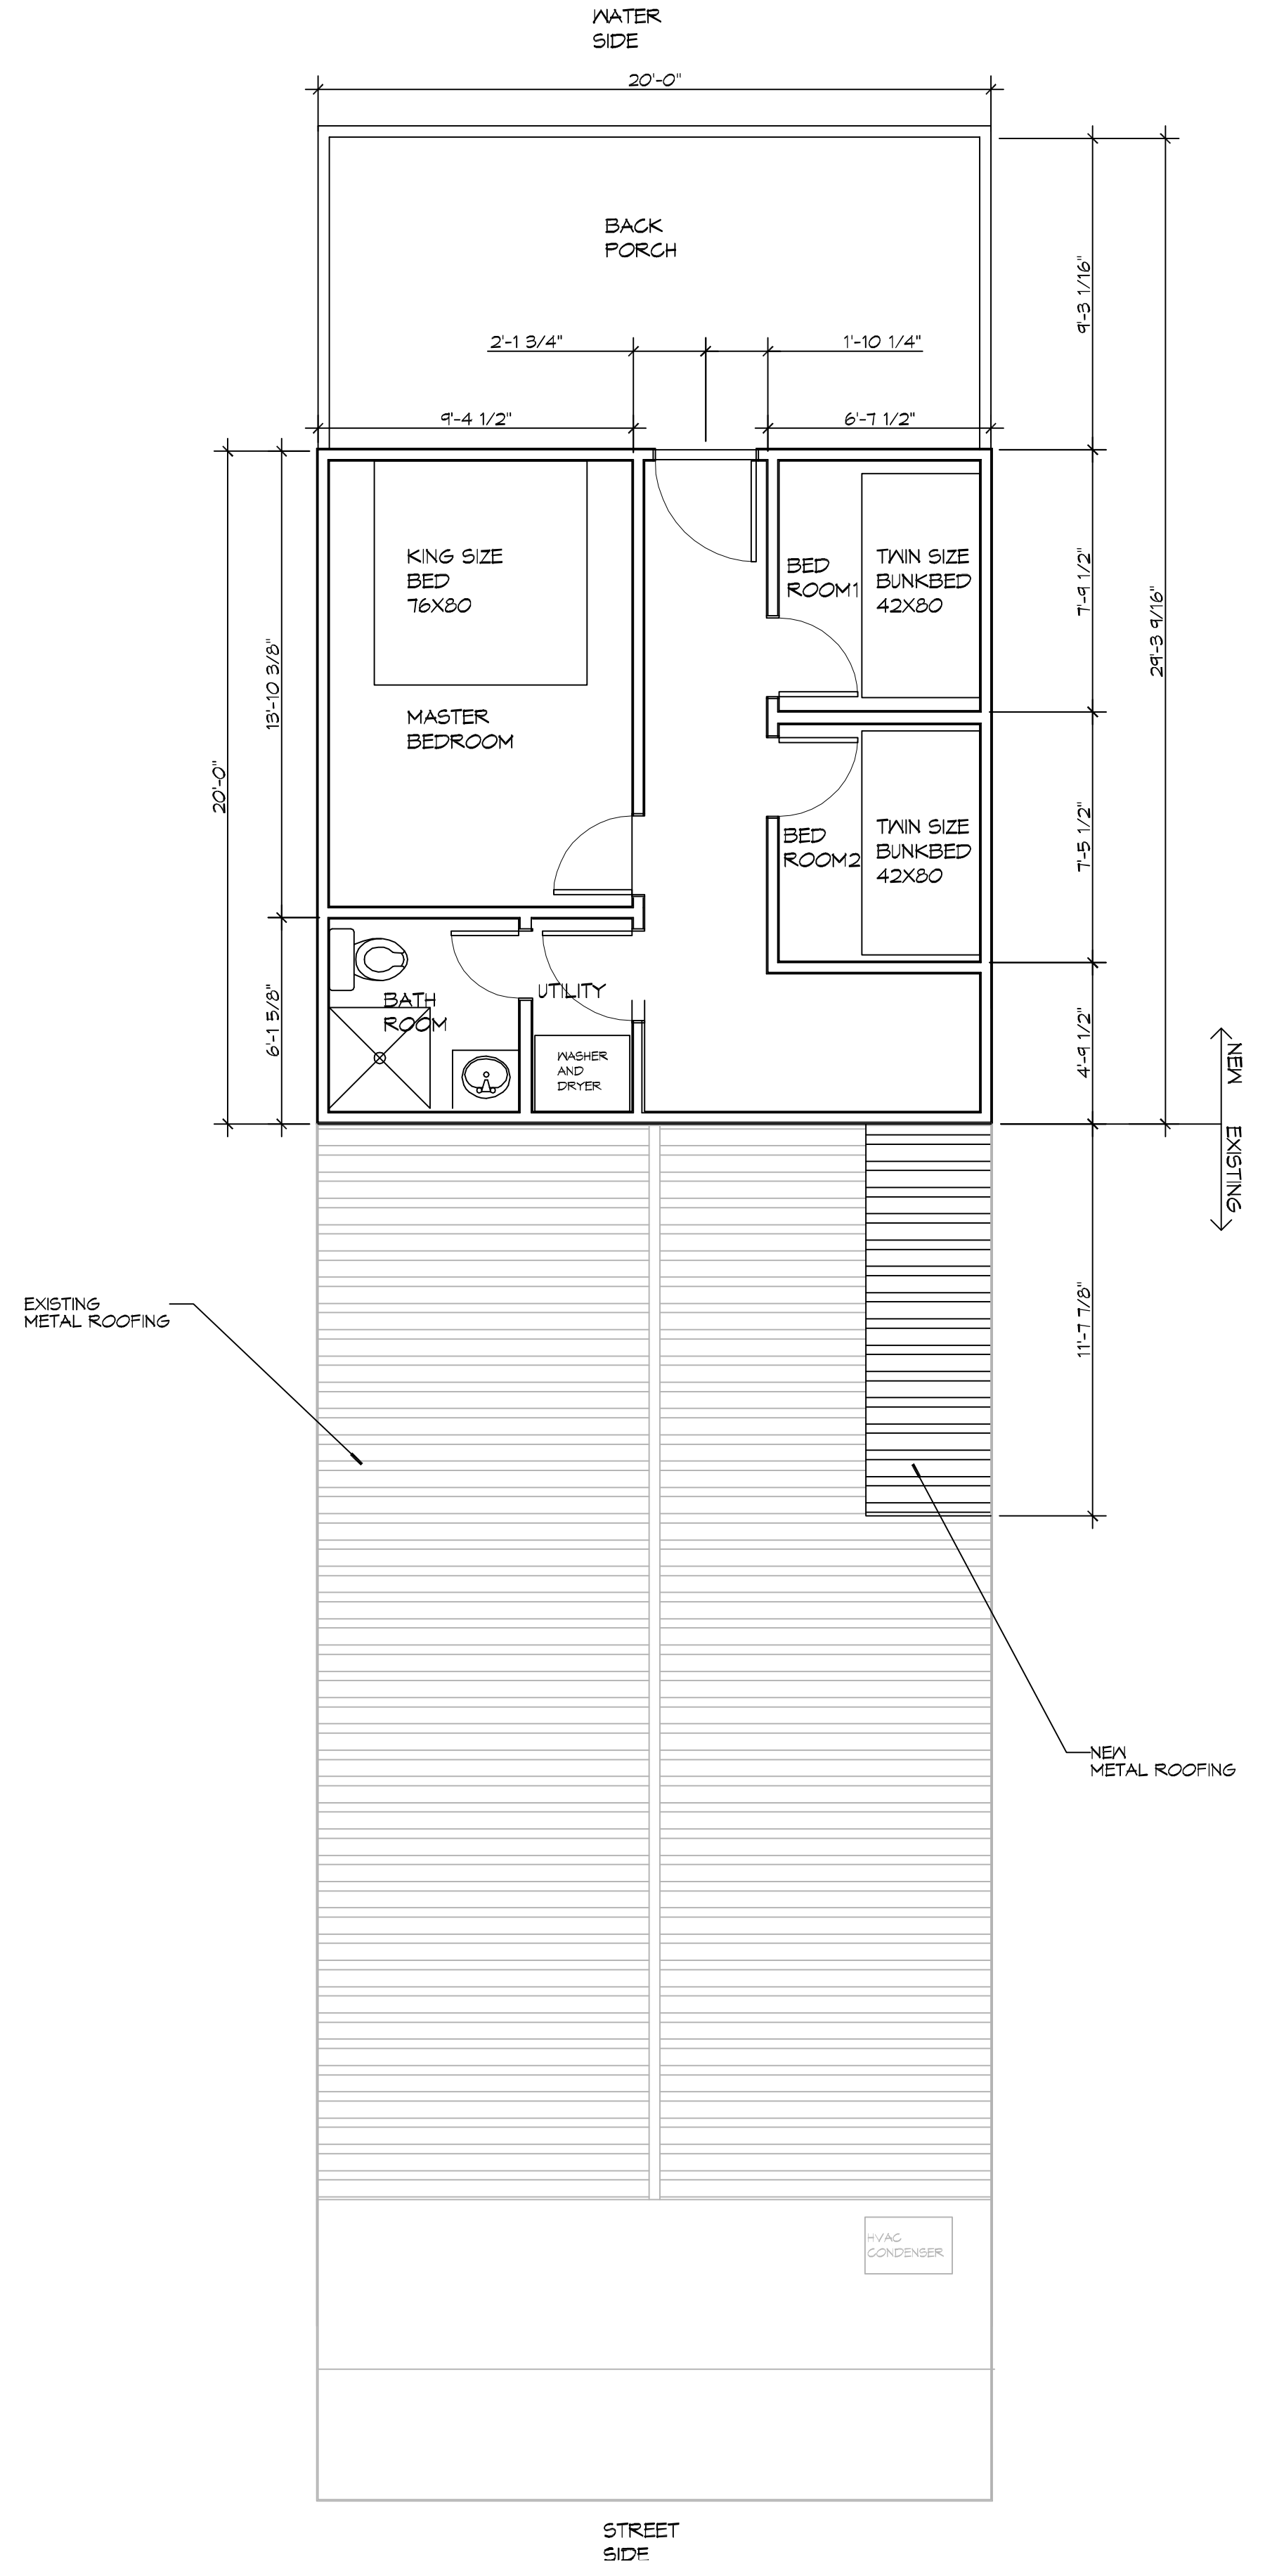

DAMMON ENGINEERING, INC.
LOUISIANA & MISSISSIPPI
www.dammonengineering.com
info@dammonengineering.com
Chief Engineer: Brian Mitchell, PE
554 Old Spanish Trail
Slidell, LA 70468
PH: 985.649.5832

#	DESCRIPTION	REVISIONS	DATE

SEAL:

DAN SANDERS
NEW RESIDENTIAL
7704 BREAKWATER DRIVE
NEW ORLEANS LA
JOB No: 2021 DATE: 03-16-2021
DRAWN BY: TYNMOTHY TAYLOR | CHECKED BY: CKD

SHEET TITLE:
FLOOR PLAN

DRAWING NUMBER:
A101

