




FILE NAME: \\s:\residential\new\hobby\hobby.dwg DATE: 11-24-2021 11:24:21 AM USER: bdammon

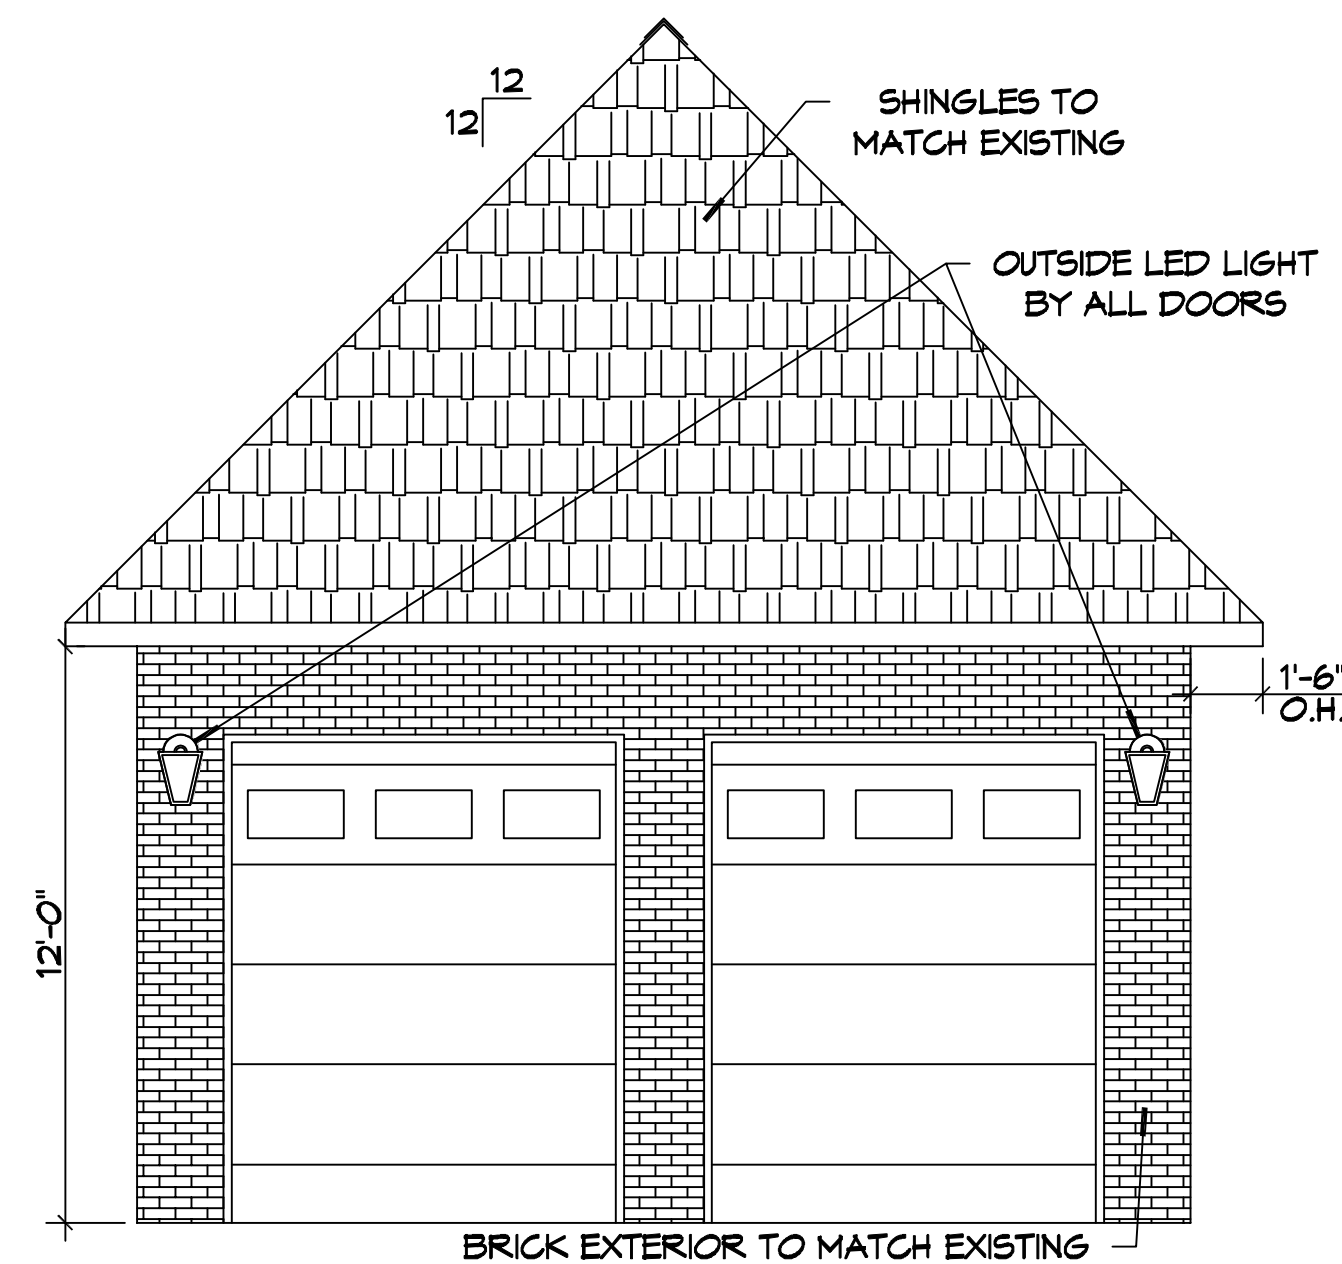


3 FRONT ELEVATION
SCALE: 1/4"=1'-0"

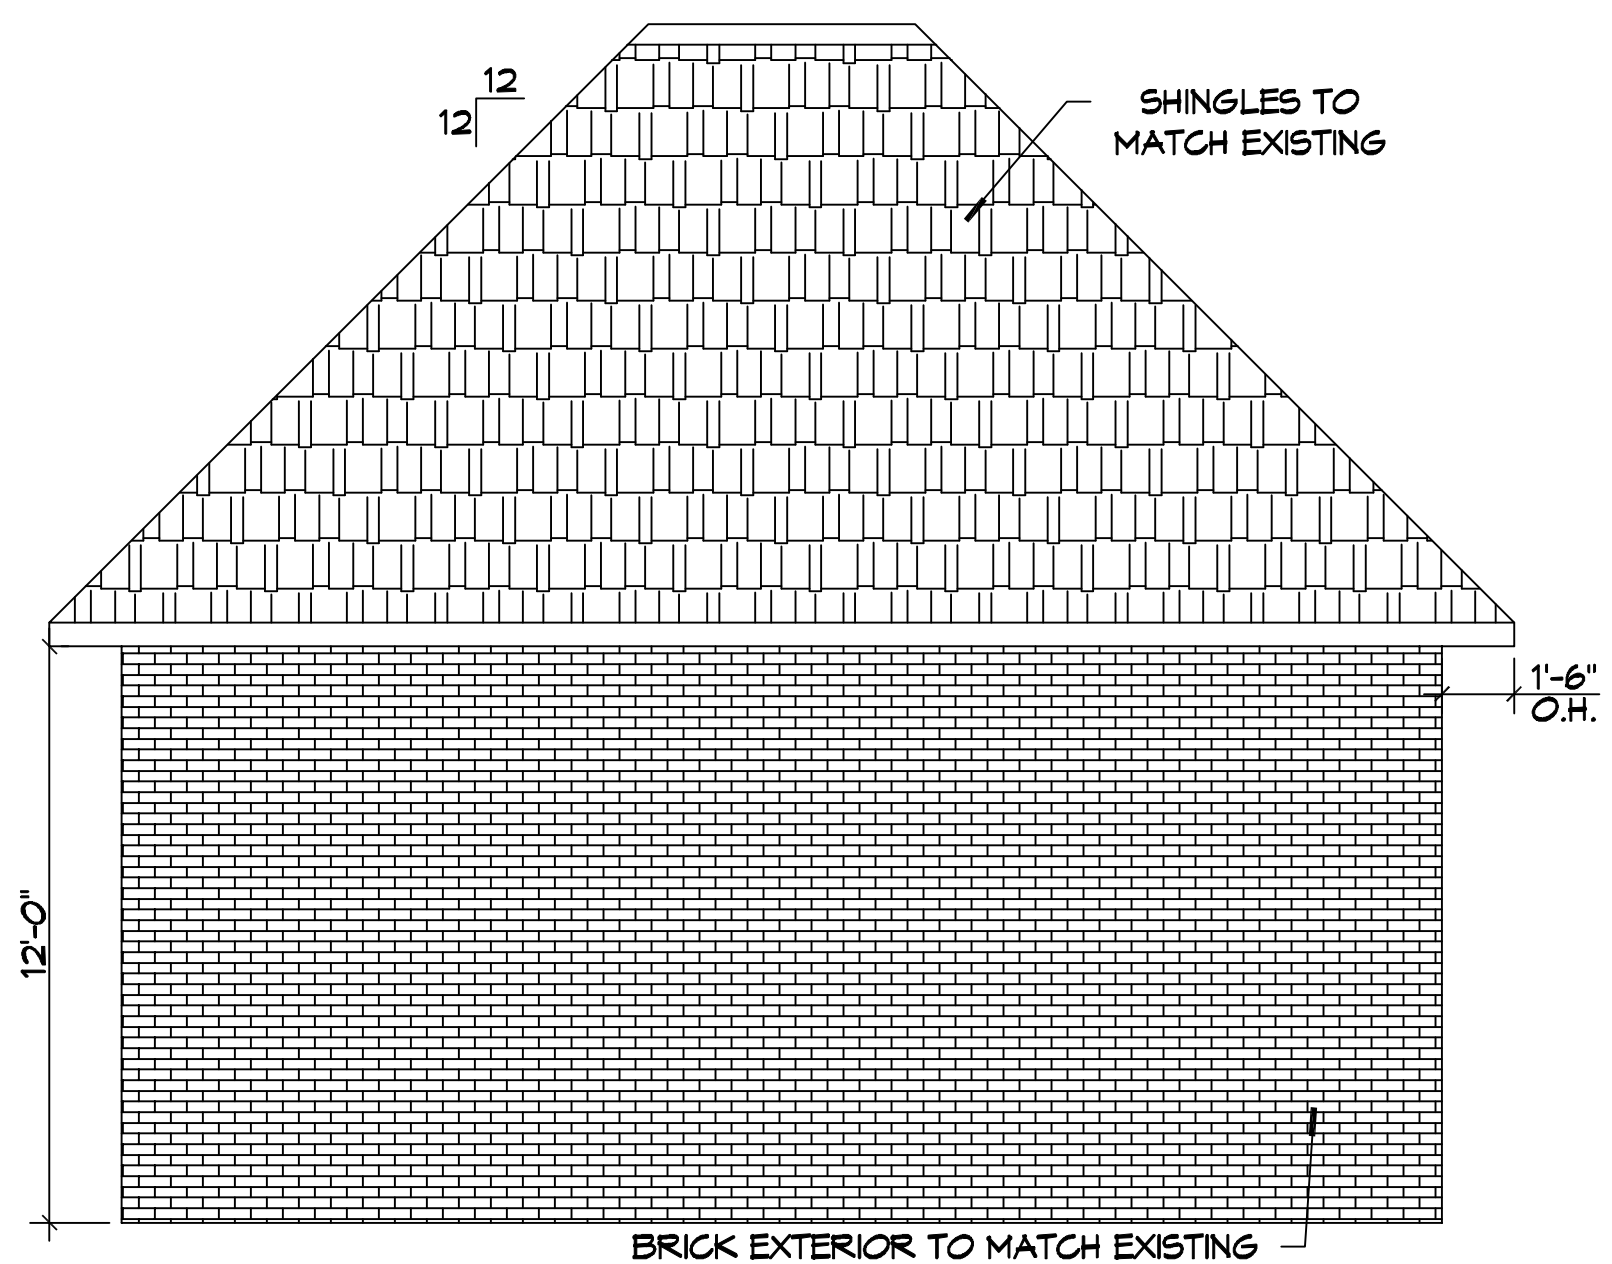


4 LEFT ELEVATION
SCALE: 1/4"=1'-0"

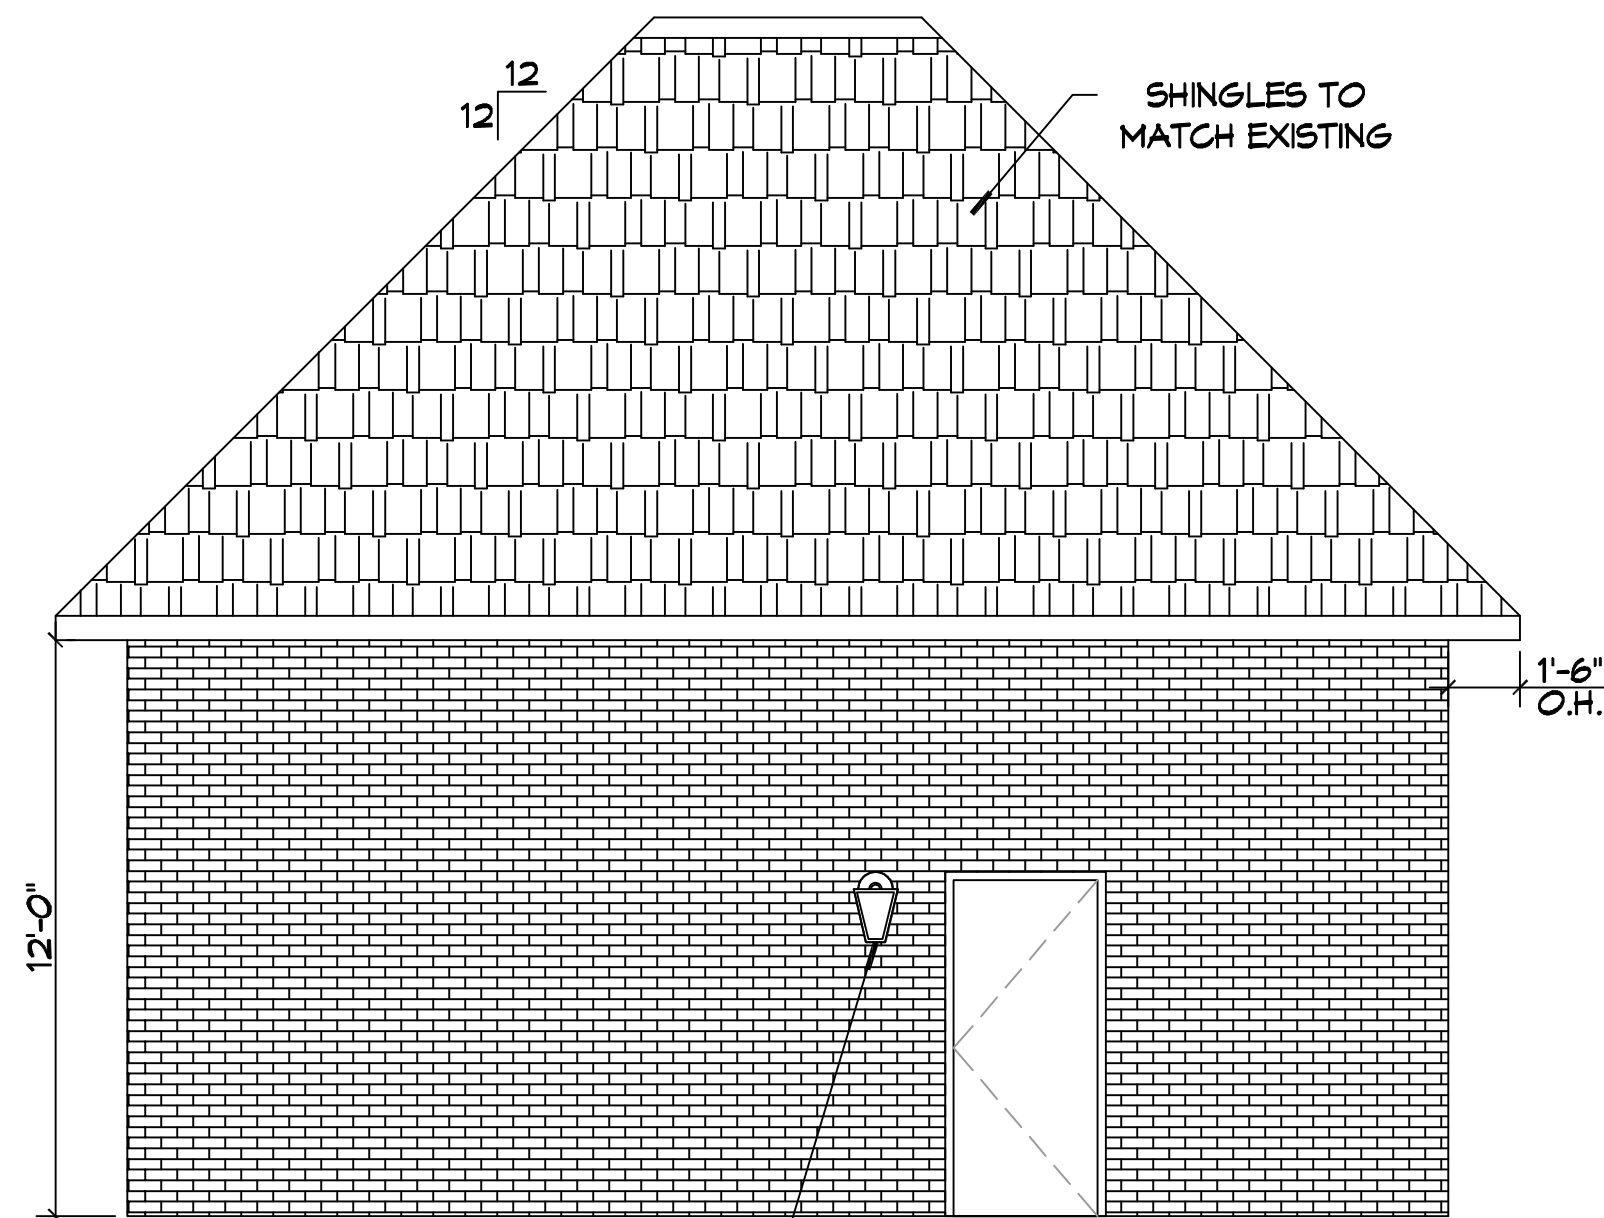

6 RIGHT ELEVATION
SCALE: 1/4"=1'-0"

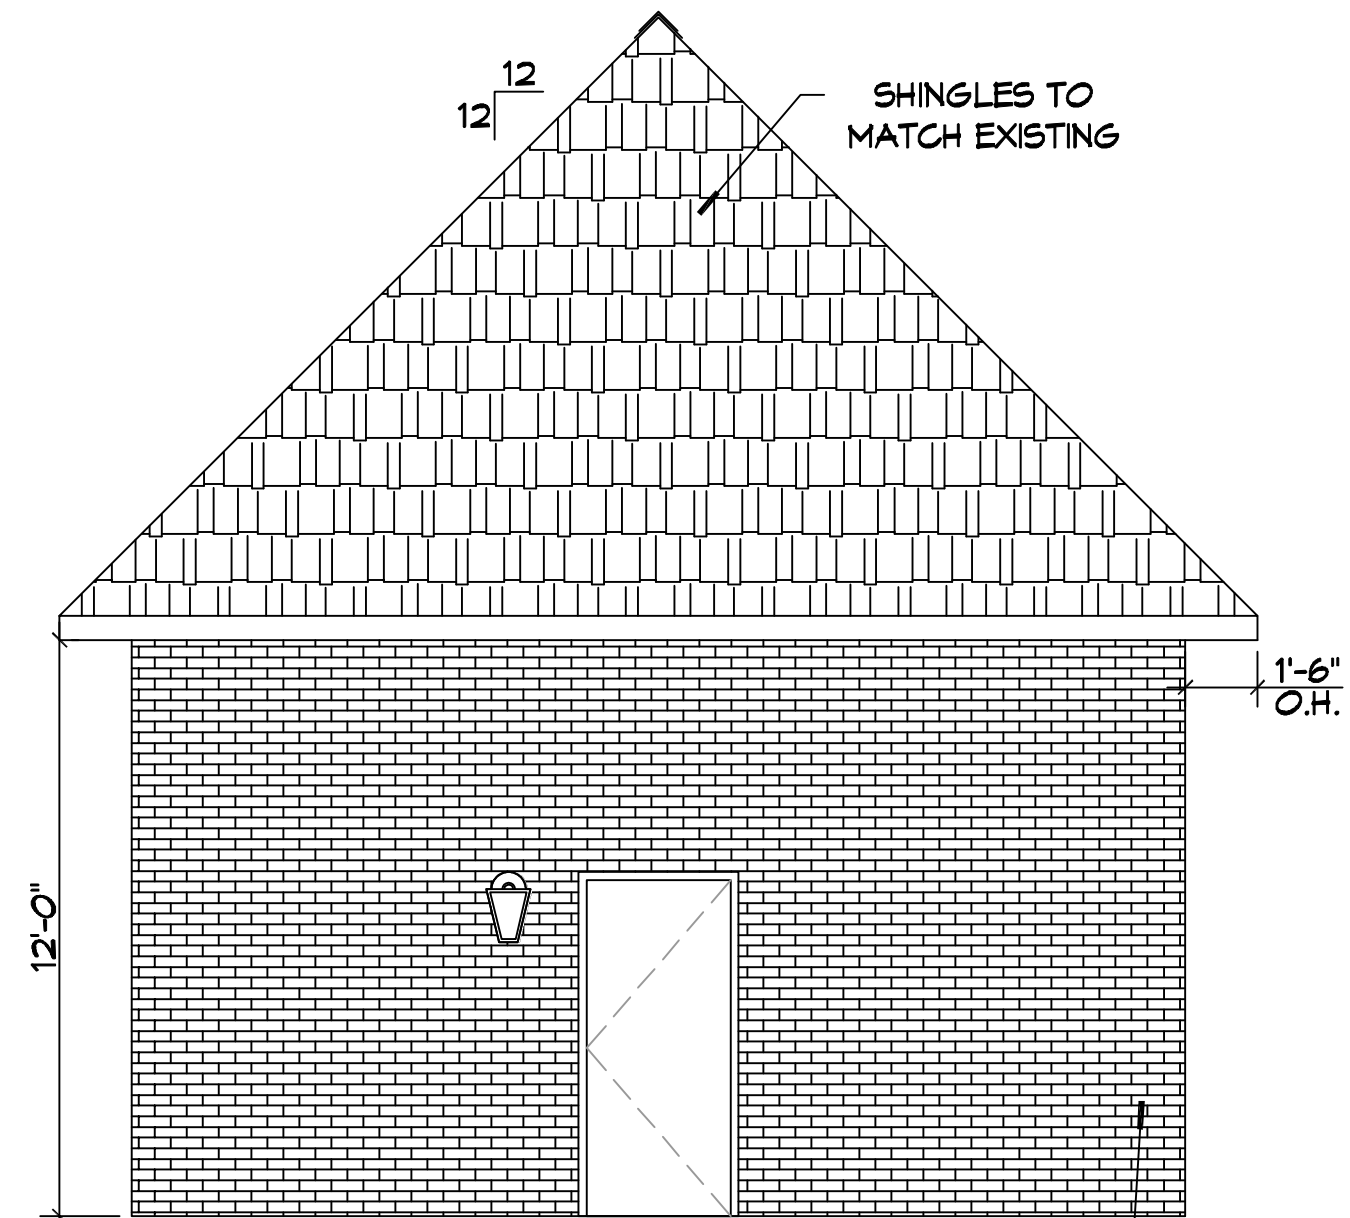

5 REAR ELEVATION
SCALE: 1/4"=1'-0"

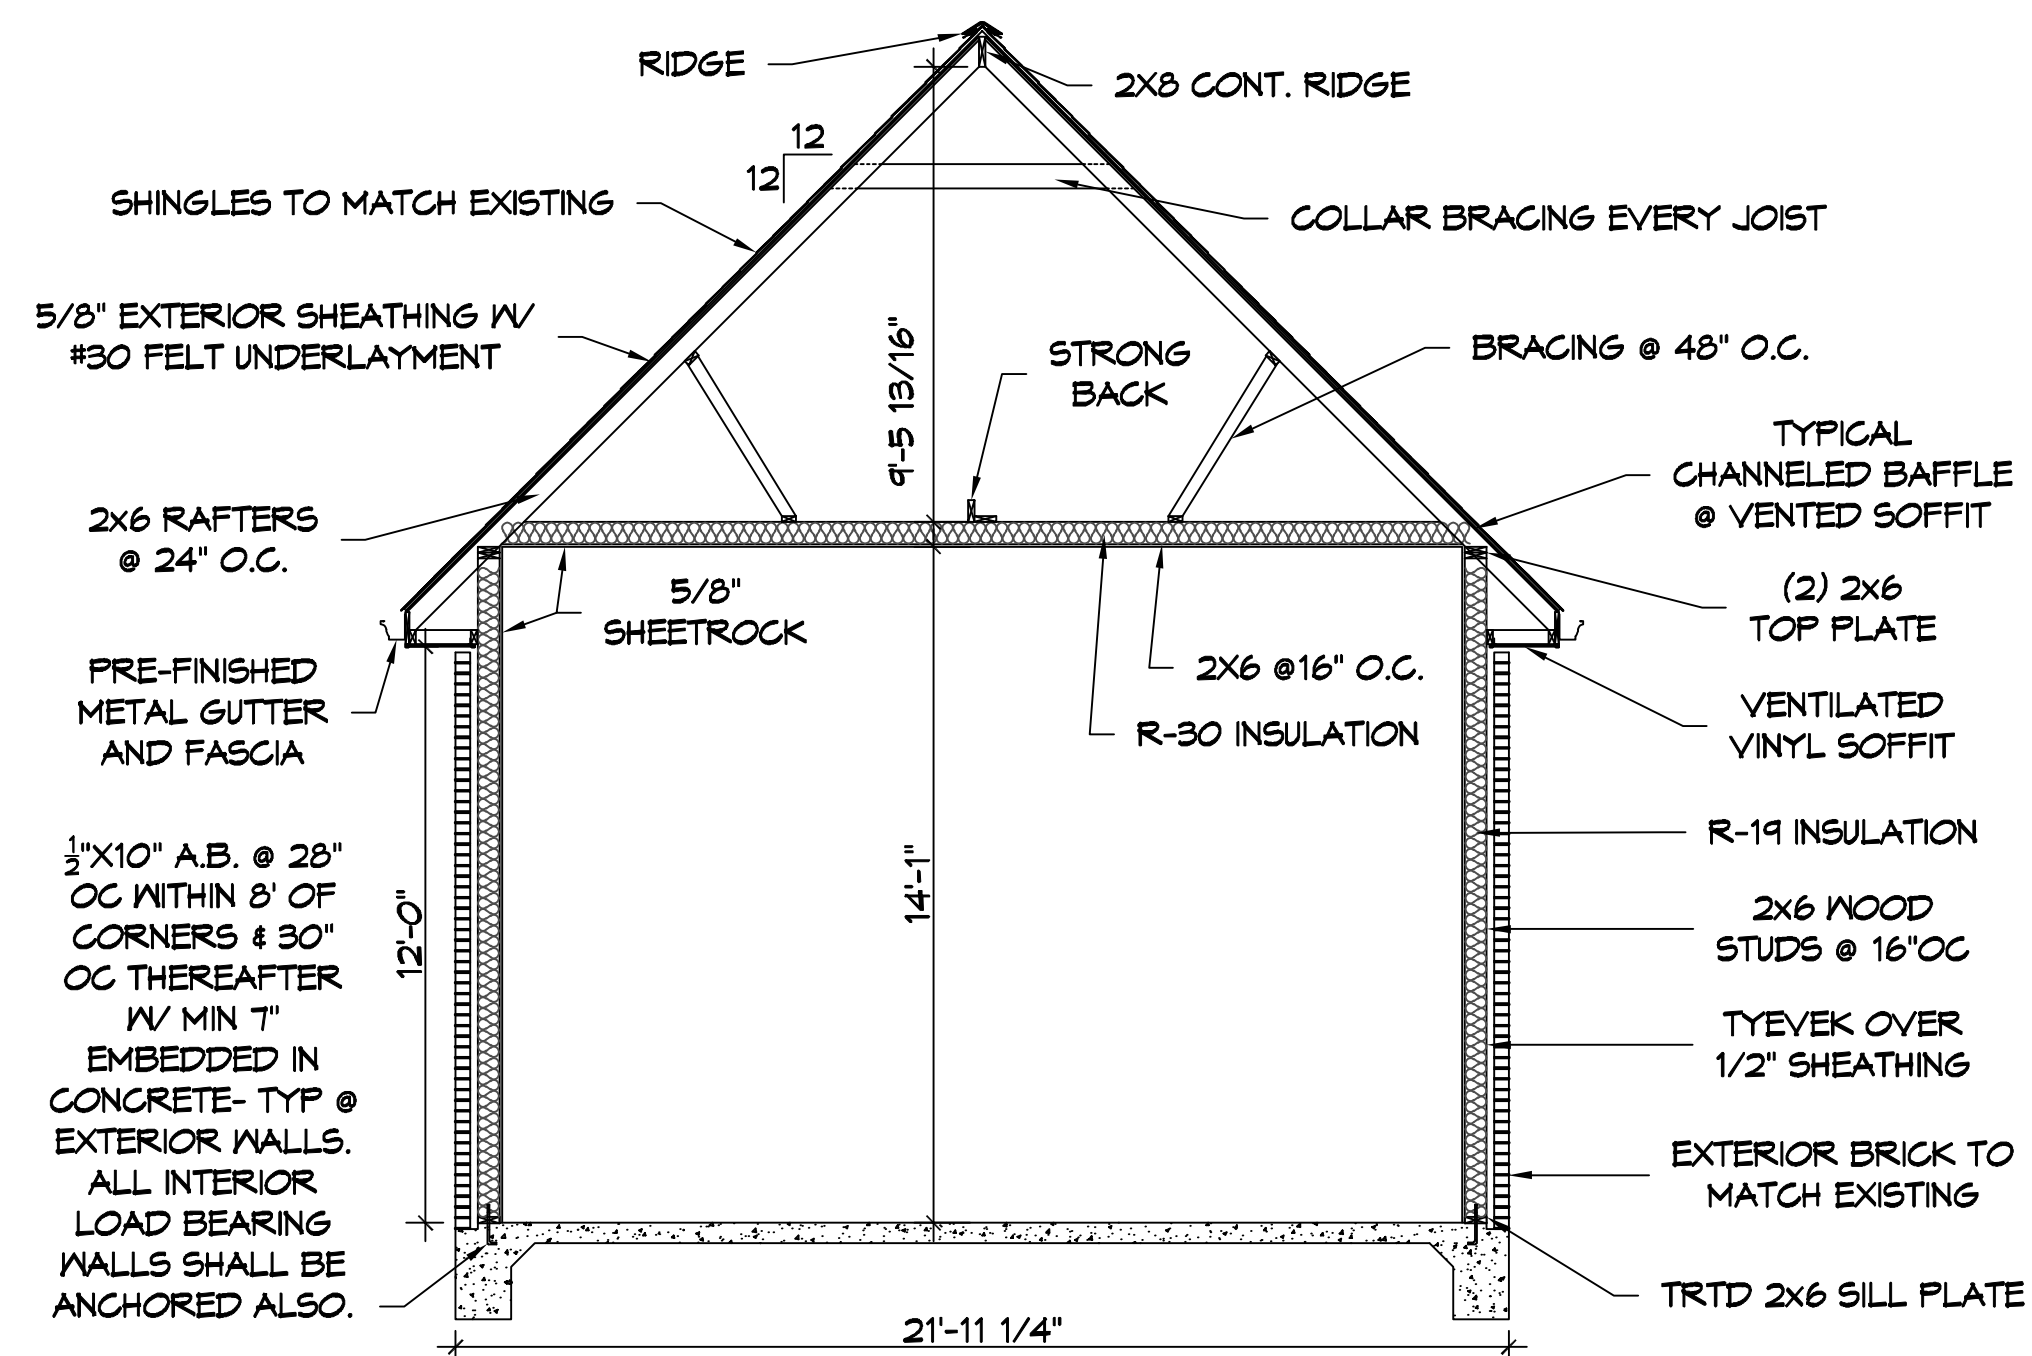


7 SECTION VIEW
SCALE: 1/4"=1'-0"

ELECTRICAL LEGEND

	LED LIGHT FIXTURE
	SINGLE POLE SWITCH
	STANDARD 120V DUPLEX RECEPTACLE, 18" AFF (UNLESS OTHERWISE NOTED)

DOOR SCHEDULE

MK	WIDTH	HEIGHT	NOTES
D01	8'-0"	10'-0"	GARAGE ROLL-UP DOOR
D02	3'-0"	7'-0"	SINGLE ACTION DOOR

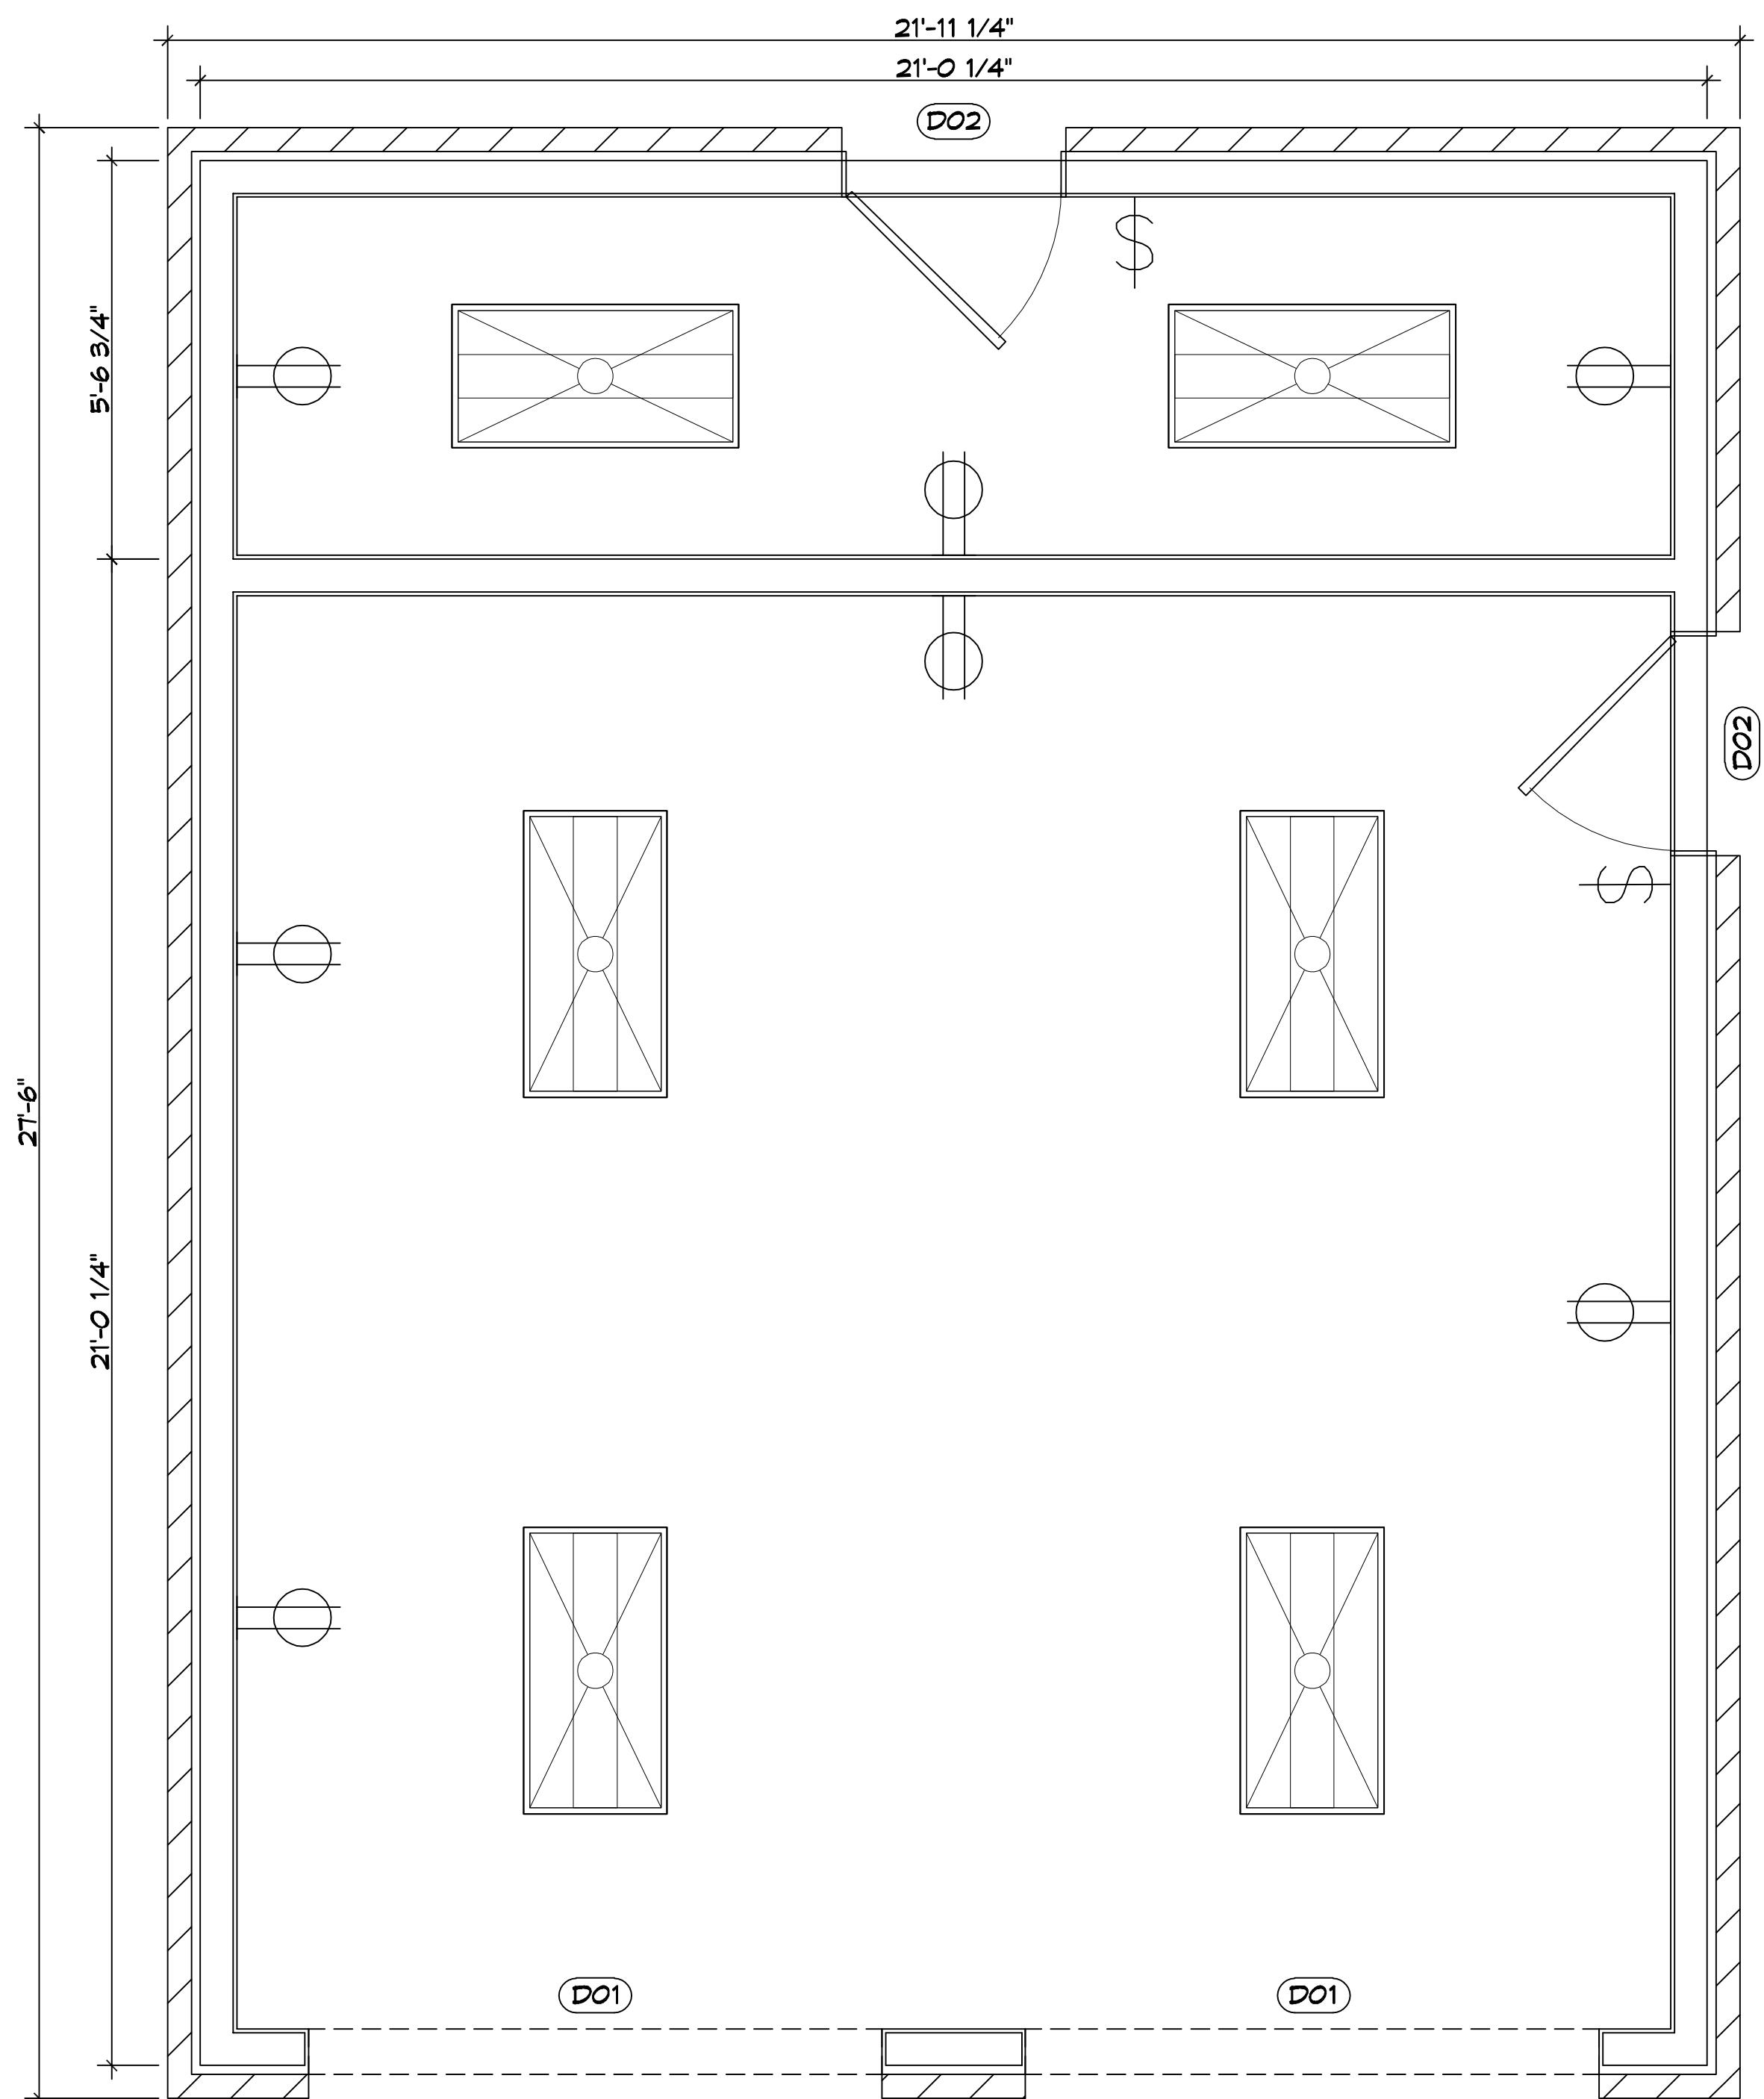

2 FLOOR PLAN
SCALE: 1/2"=1'-0"

DAMMON ENGINEERING, INC.
LOUISIANA & MISSISSIPPI
www.dammonengineering.com
info@dammonengineering.com
PH: 985-649-5832
Chief Engineer: Brian Misch, PE
554 Old Spanish Trail
Slidell, LA 70488

#	DESCRIPTION	DATE

SEAL: _____

ADDITION
A D A M M O N & W E N D Y
A B O W E N
582 SOUTH CALES COURT DR.
SLIDELL, LA 70461
JOB No: 11-24-2021
DRAWN BY: TIMOTHY TAYLOR
CHECKED BY: CKD
DATE: 11-24-2021

SHEET TITLE:
FLOOR, ELEVATION, AND SECTION PLANS

DRAWING NUMBER:

A101

