




1 LEVEL ONE LAYOUT ARCHITECTURAL SCALE: 1/4" = 1'-0"

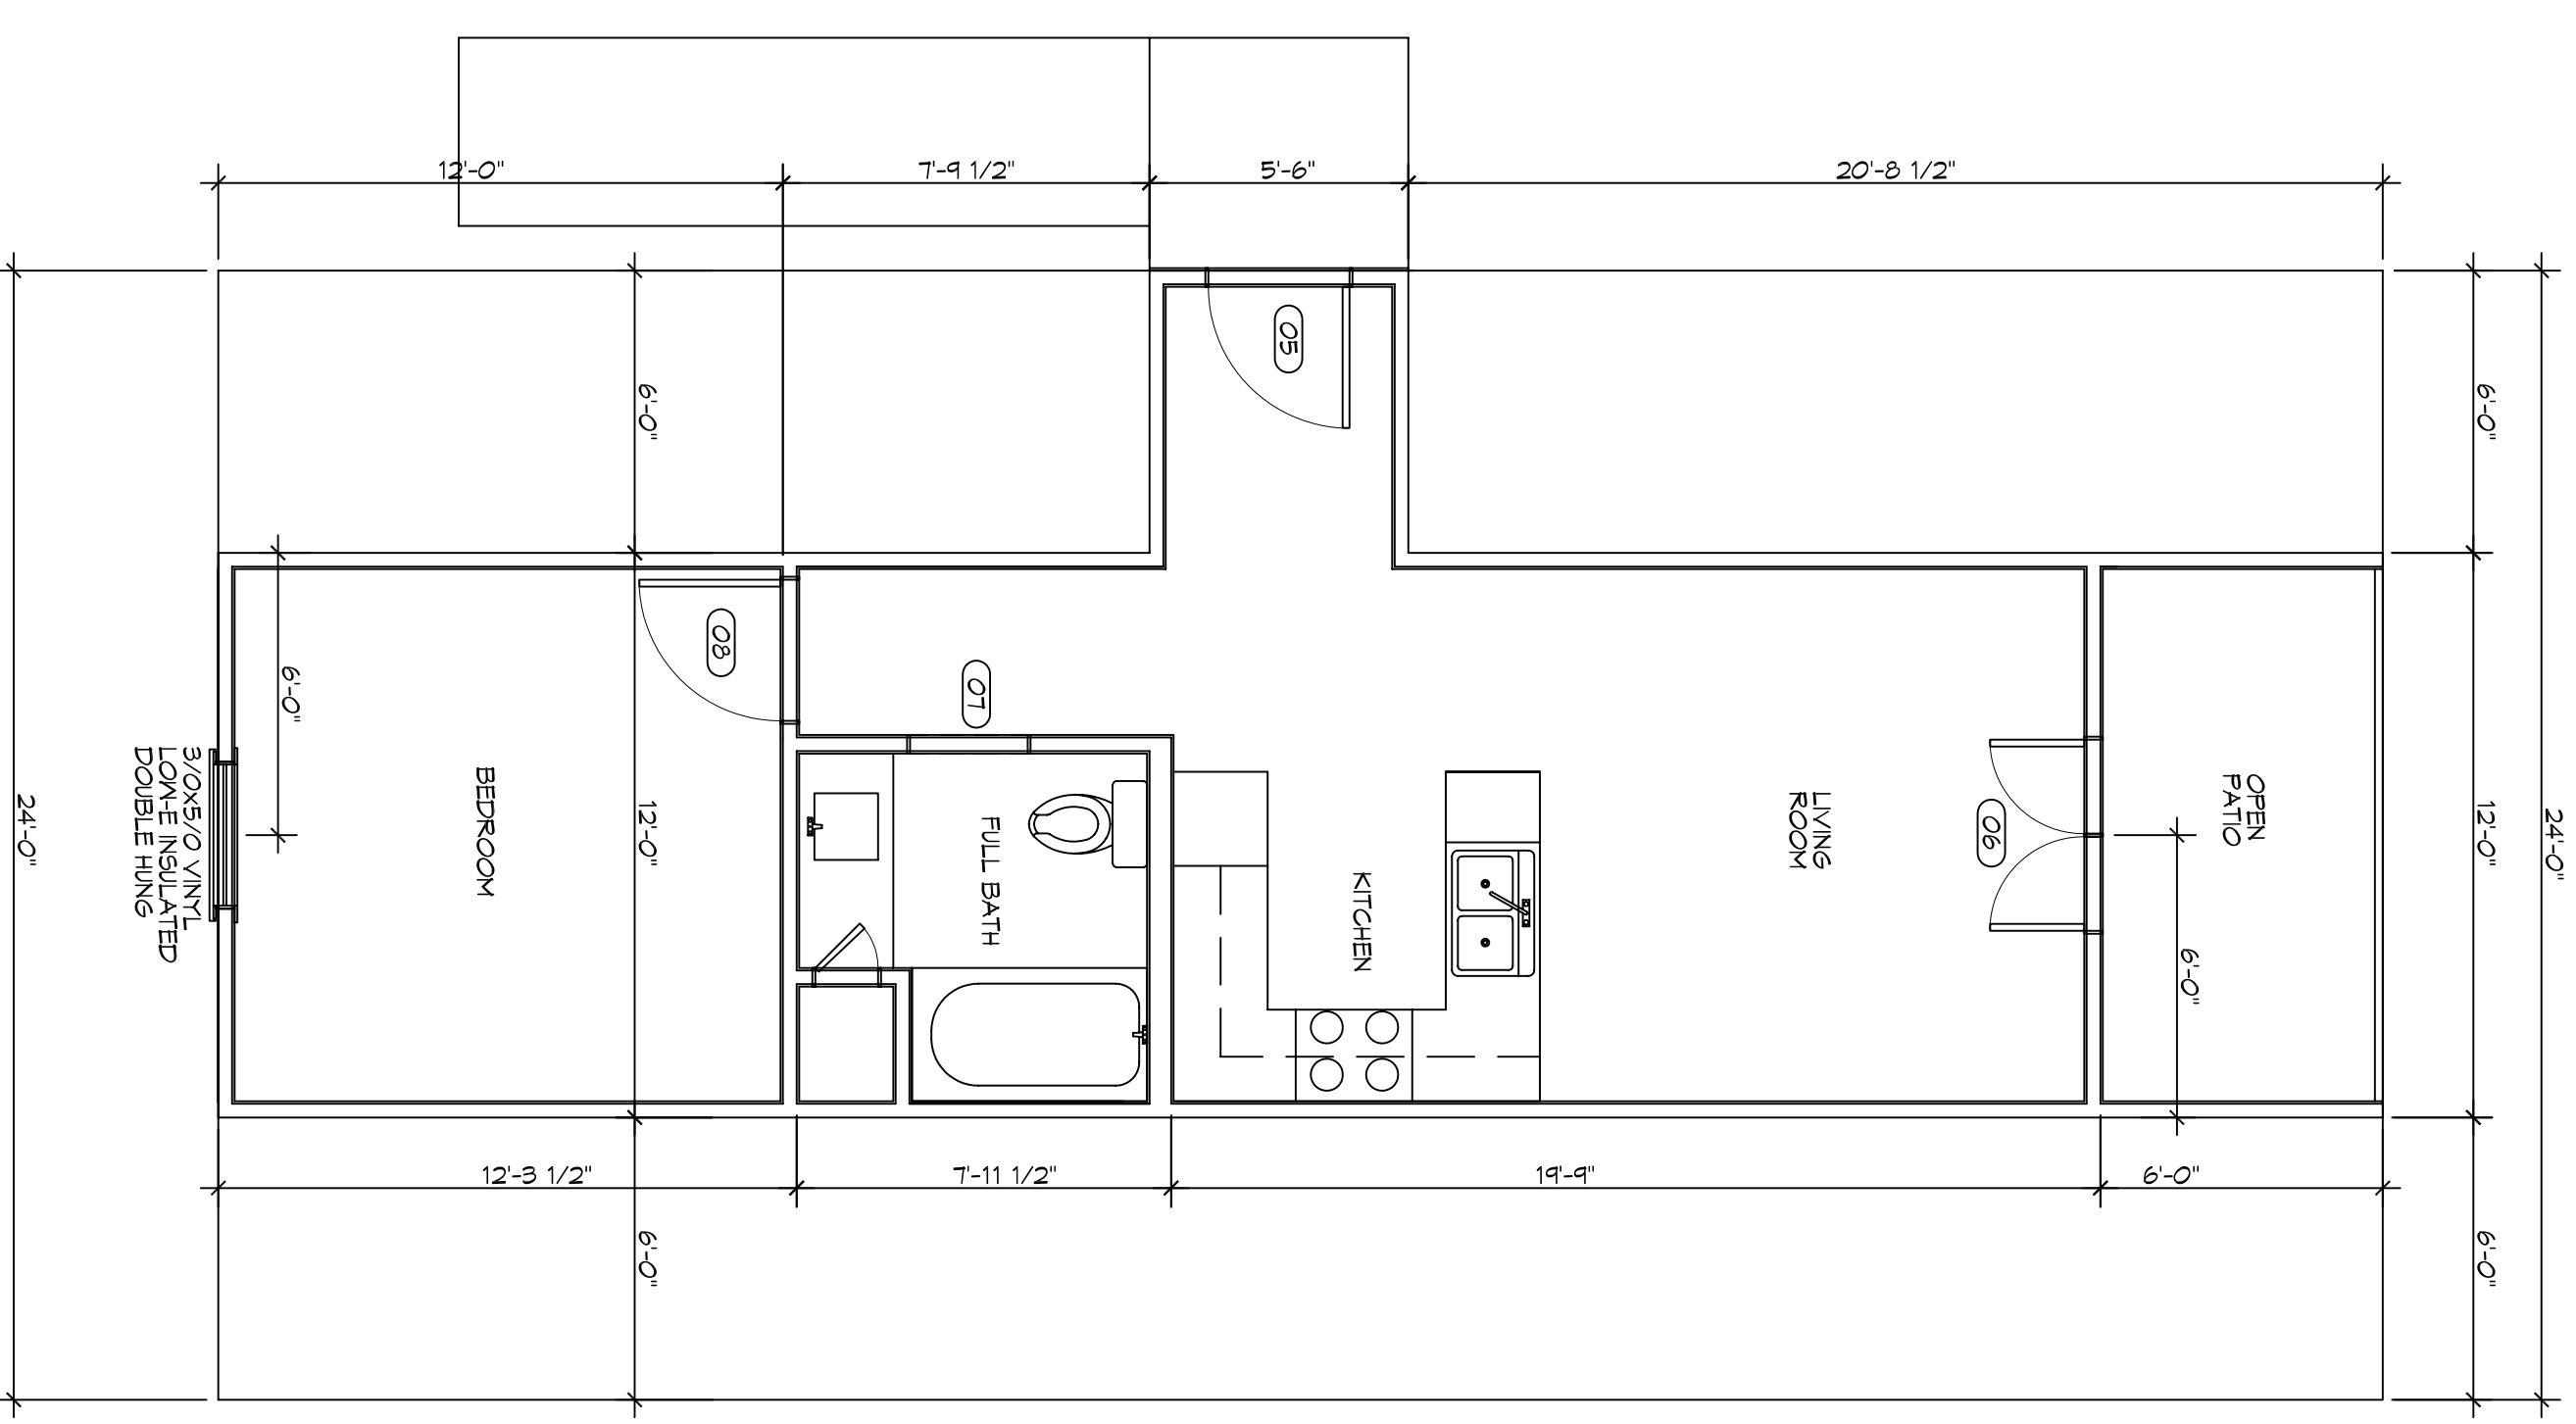

1 LEVEL TWO LAYOUT ARCHITECTURAL SCALE: 1/4" = 1'-0"

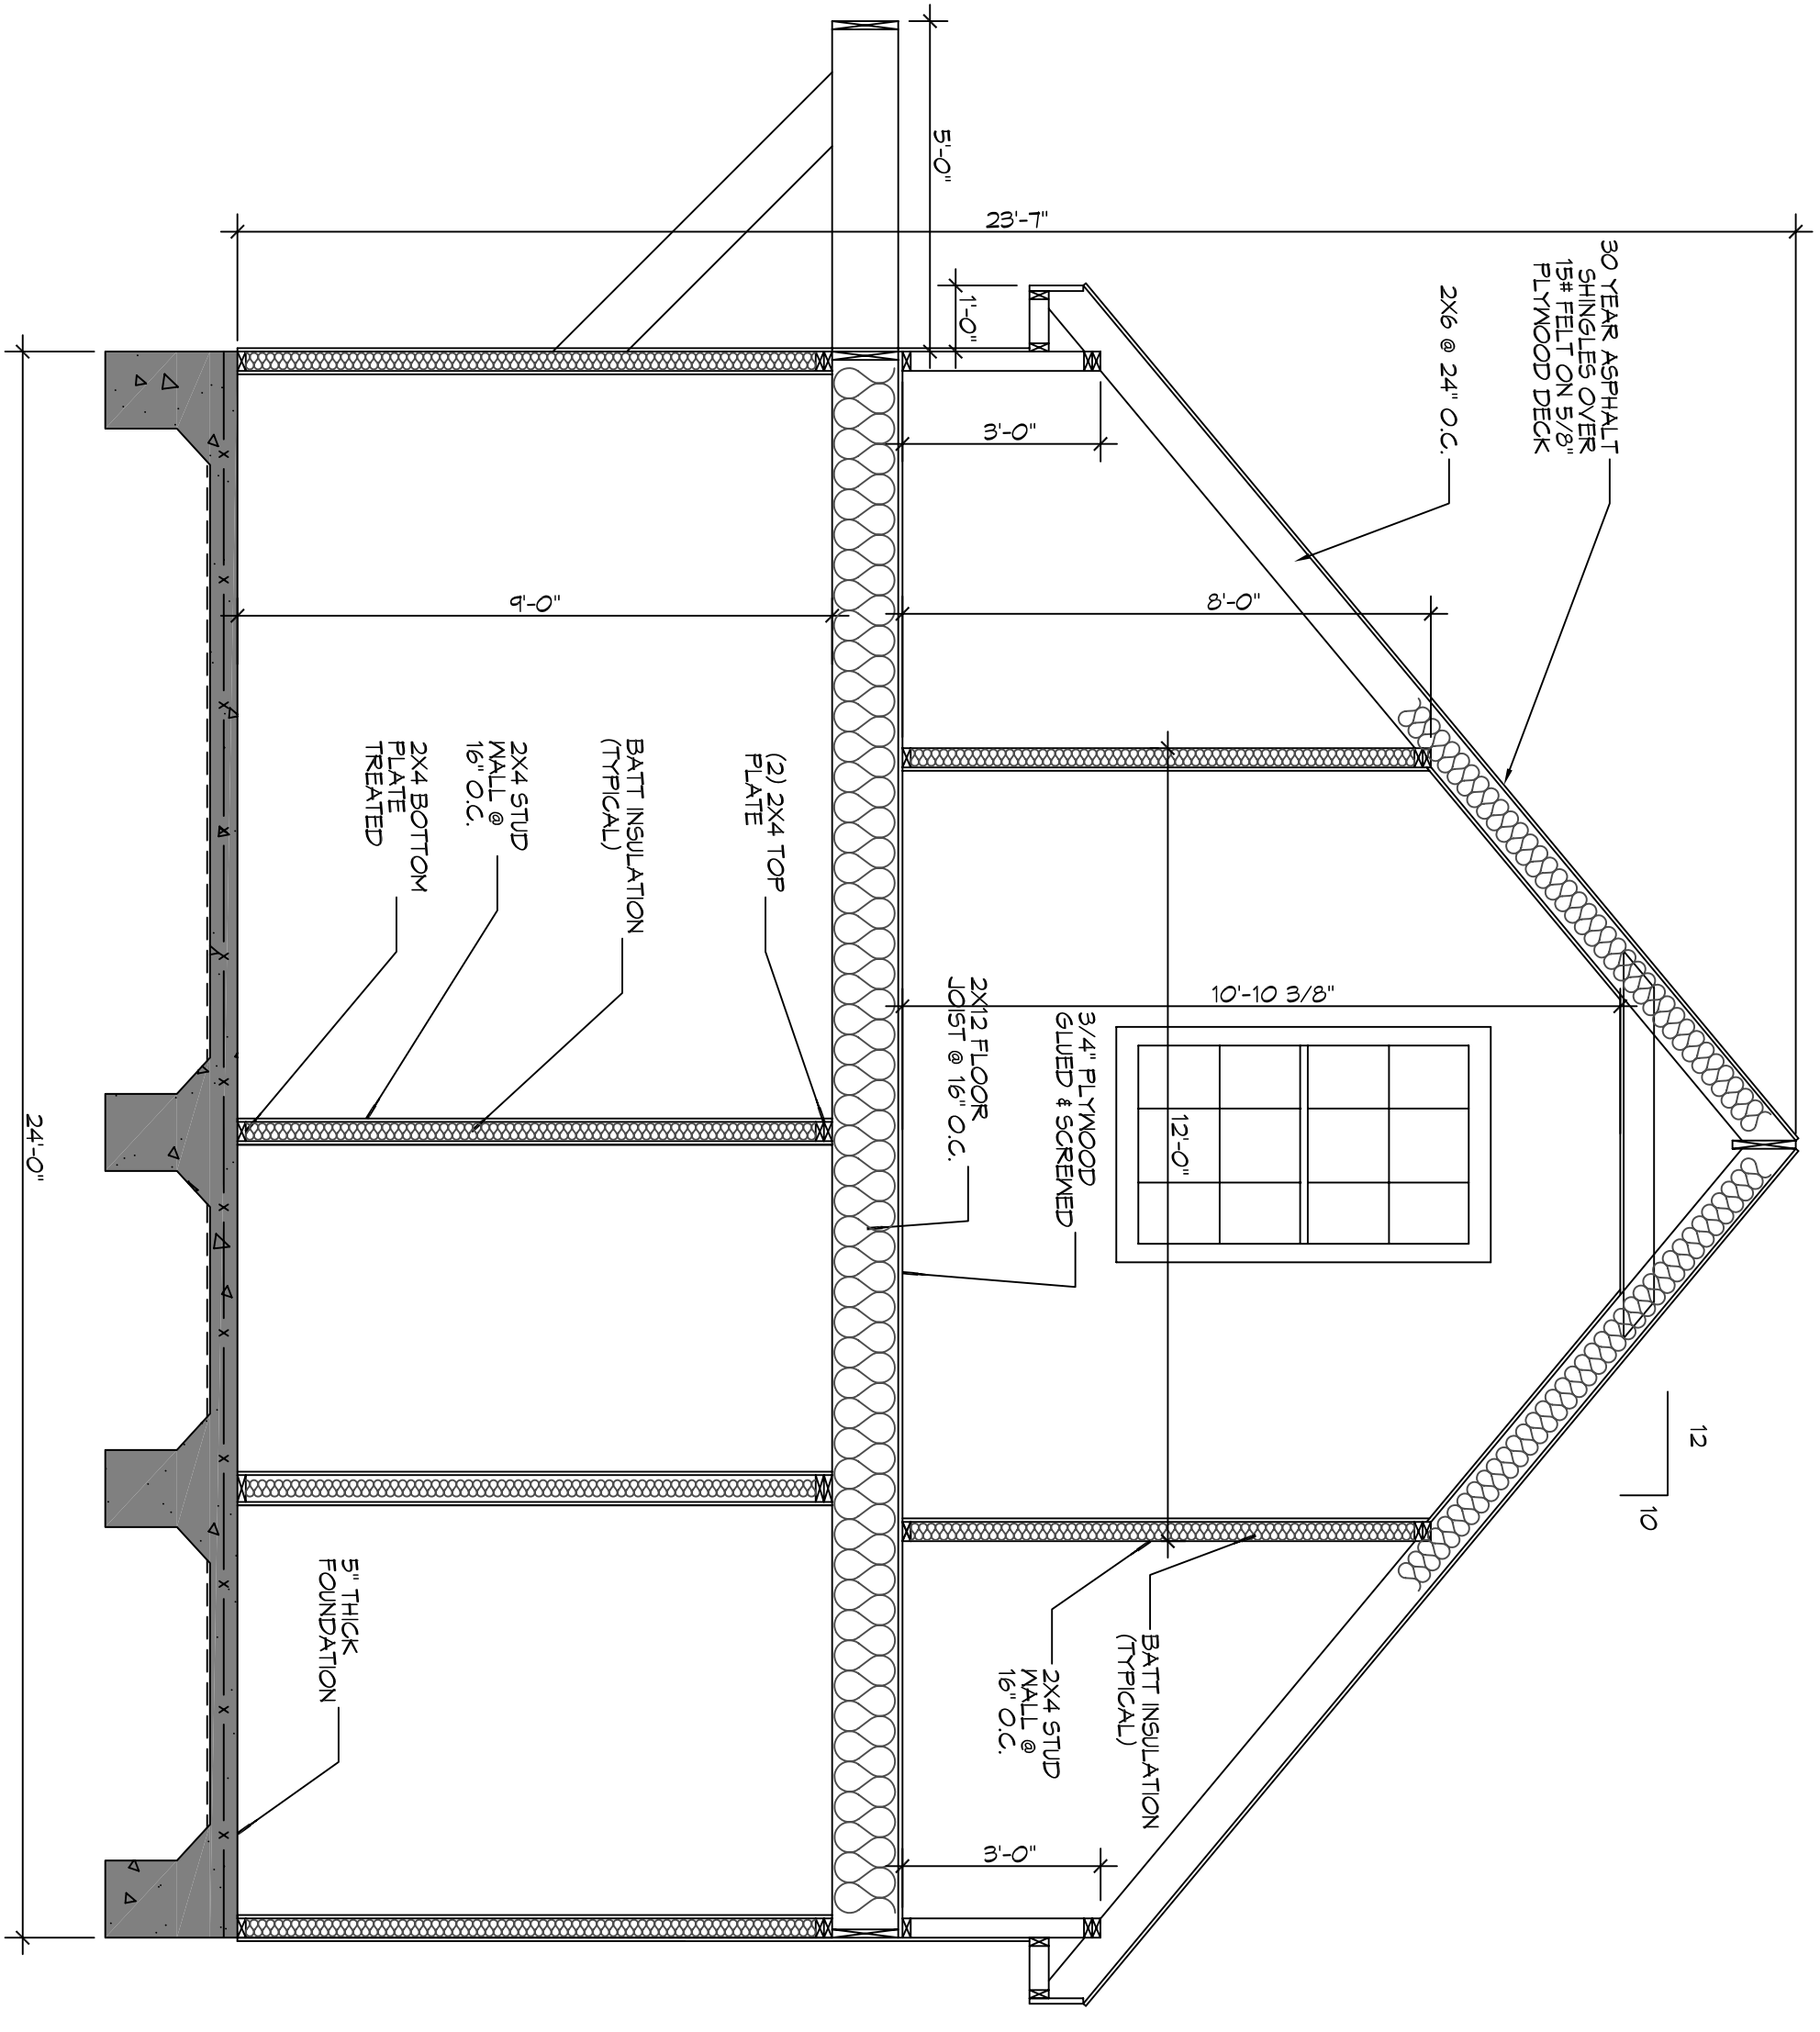

1 SECTION ARCHITECTURAL SCALE: 3/8" = 1'-0"

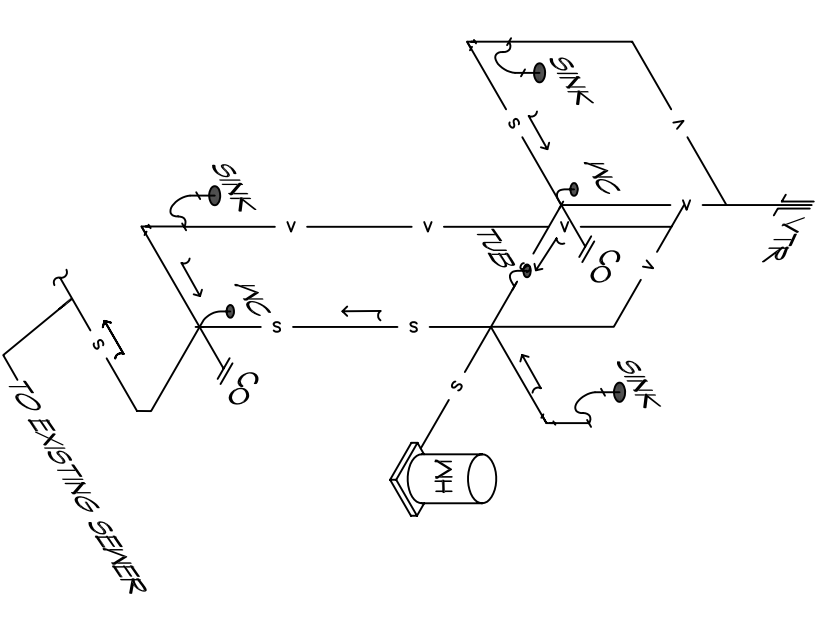

2 PLUMBING RISER ARCHITECTURAL SCALE: 1/8" = 1'-0"

DOOR SCHEDULE								
MK	WIDTH	HEIGHT	THK	DOOR MATERIAL	FRAME MATERIAL	TYPE	HWR	REMARKS
01	4'-0"	8'-0"	1-3/4"	WOOD	WOOD	-	-	(2) GARAGE DOOR
02	4'-0"	8'-0"	1-3/4"	WOOD	WOOD	-	-	(2) PASSAGE DOOR (ONE FIXED)
03	3'-0"	6'-8"	1-3/4"	WOOD	WOOD	-	-	BATHROOM DOOR
04	3'-0"	6'-8"	1-3/4"	WOOD	WOOD	-	-	(2) GARAGE DOOR
05	3'-0"	4'-3"	1-3/4"	WOOD	WOOD	-	-	EXT. DOOR WEATHER STRIP
06	2'-6"	6'-8"	1-3/4"	WOOD	WOOD	-	-	(2) EXT. DOOR WEATHER STRIP
07	2'-6"	6'-8"	1-3/4"	WOOD	WOOD	-	-	POCKET DOOR
08	3'-0"	6'-8"	1-3/4"	WOOD	WOOD	-	-	BEDROOM DOOR

NEW GARAGE FOR:
NICK V. BETZENE
 12169 INDIAN TRAIL
 ABITA SPRINGS, LOUISIANA
 JOB No: 2017 DATE: 04-03-2017
 DRAWN BY: CKD CHECKED BY: BAN

REVISIONS		
#	DESCRIPTION	DATE



554 Old Spanish Trail
 Slidell, LA 70458
 PH: 985.649.5832
 www.dammonengineering.com
 info@dammonengineering.com
 Fax: 985.641.5950

DRAWING NUMBER:
A101
 SHEET No: 4 OF 5