

Jake Cowden-Garofalo
 (504) 416-6871

301 Royal St.
 Existing First Floor Plan


Scale: 3/32" = 1'-0"

NOTES:

ALL STAR ELECTRIC
 PROJECT RECORD
 12/17

DATE:
 08/16/2017

Page 1

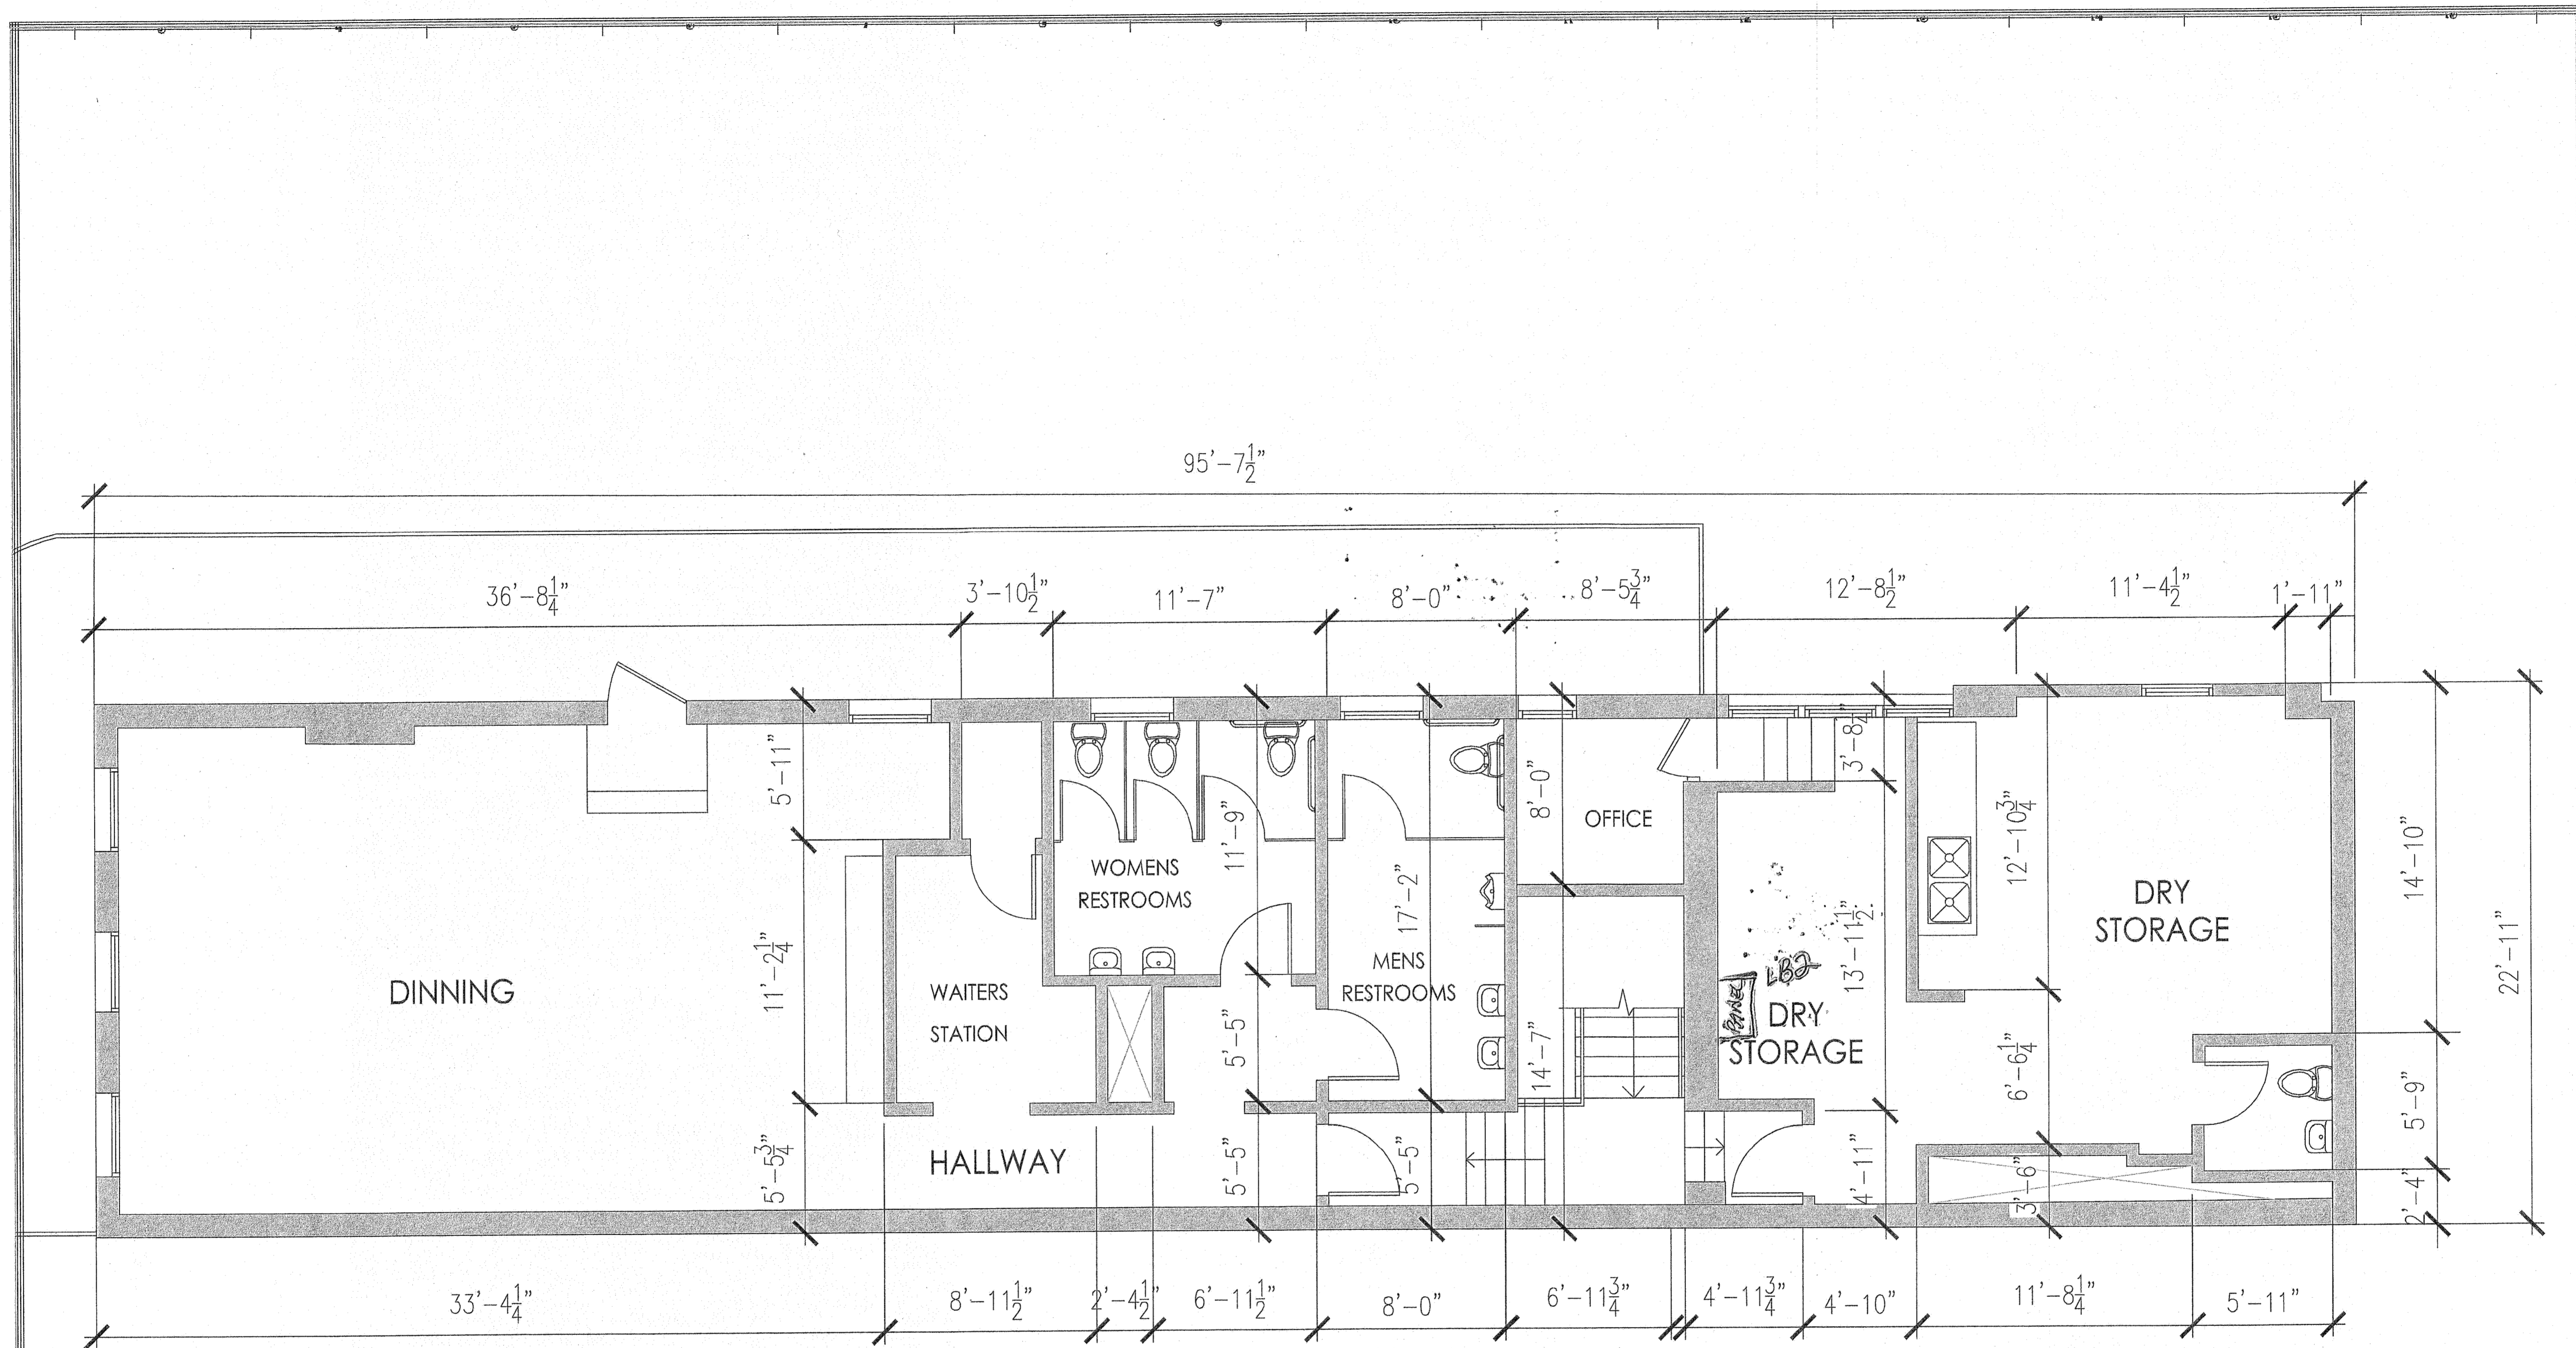

Jake Cowden-Garofalo
 (504) 416-6871


301 Royal St.
 Existing Second Floor Plan

Scale: 3/32" = 1'-0"


NOTES: ALL STAR ELECTRIC
 PROJECT RECORD
 12/17

DATE:
 08/16/2017

Page 2

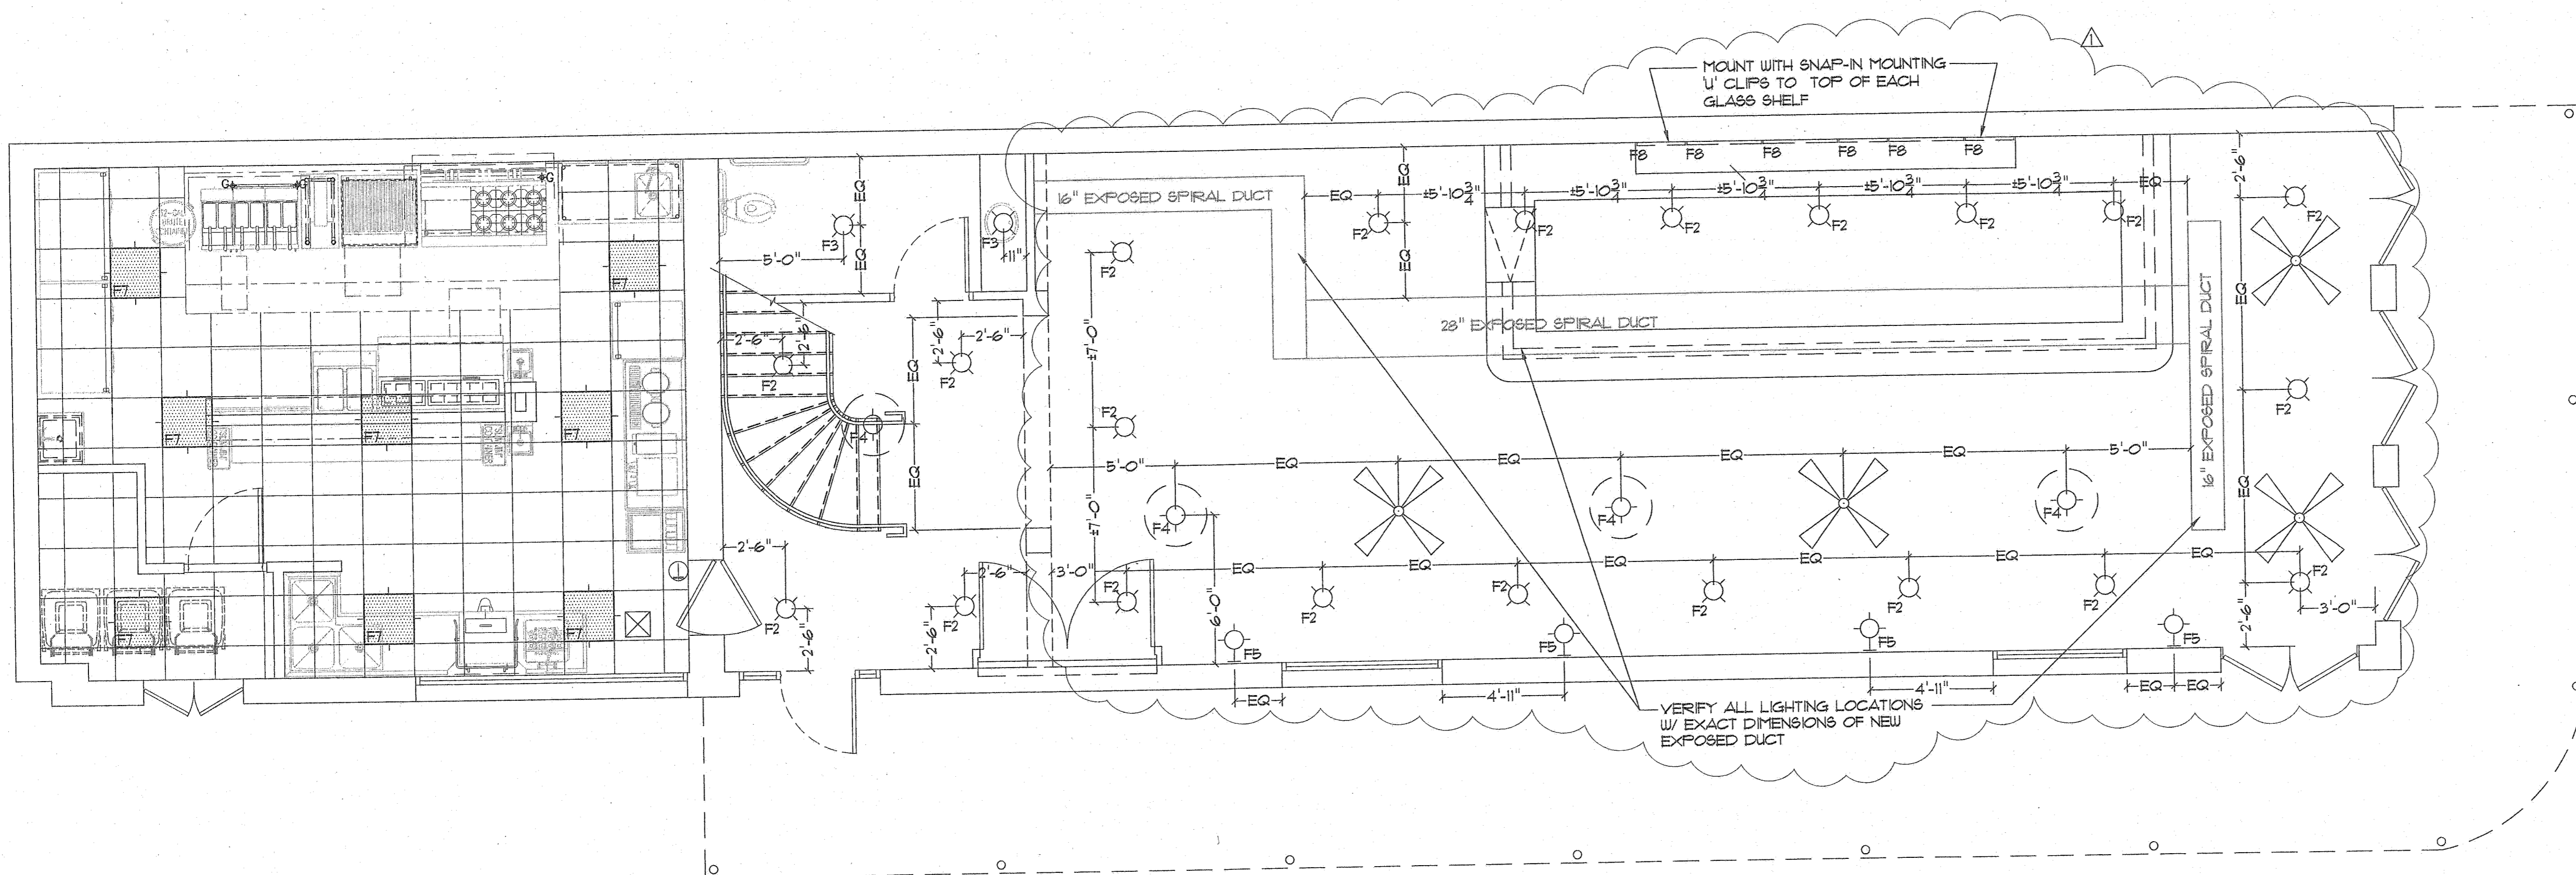

Lighting Plan
 1st Floor
 1/4" = 1'-0"

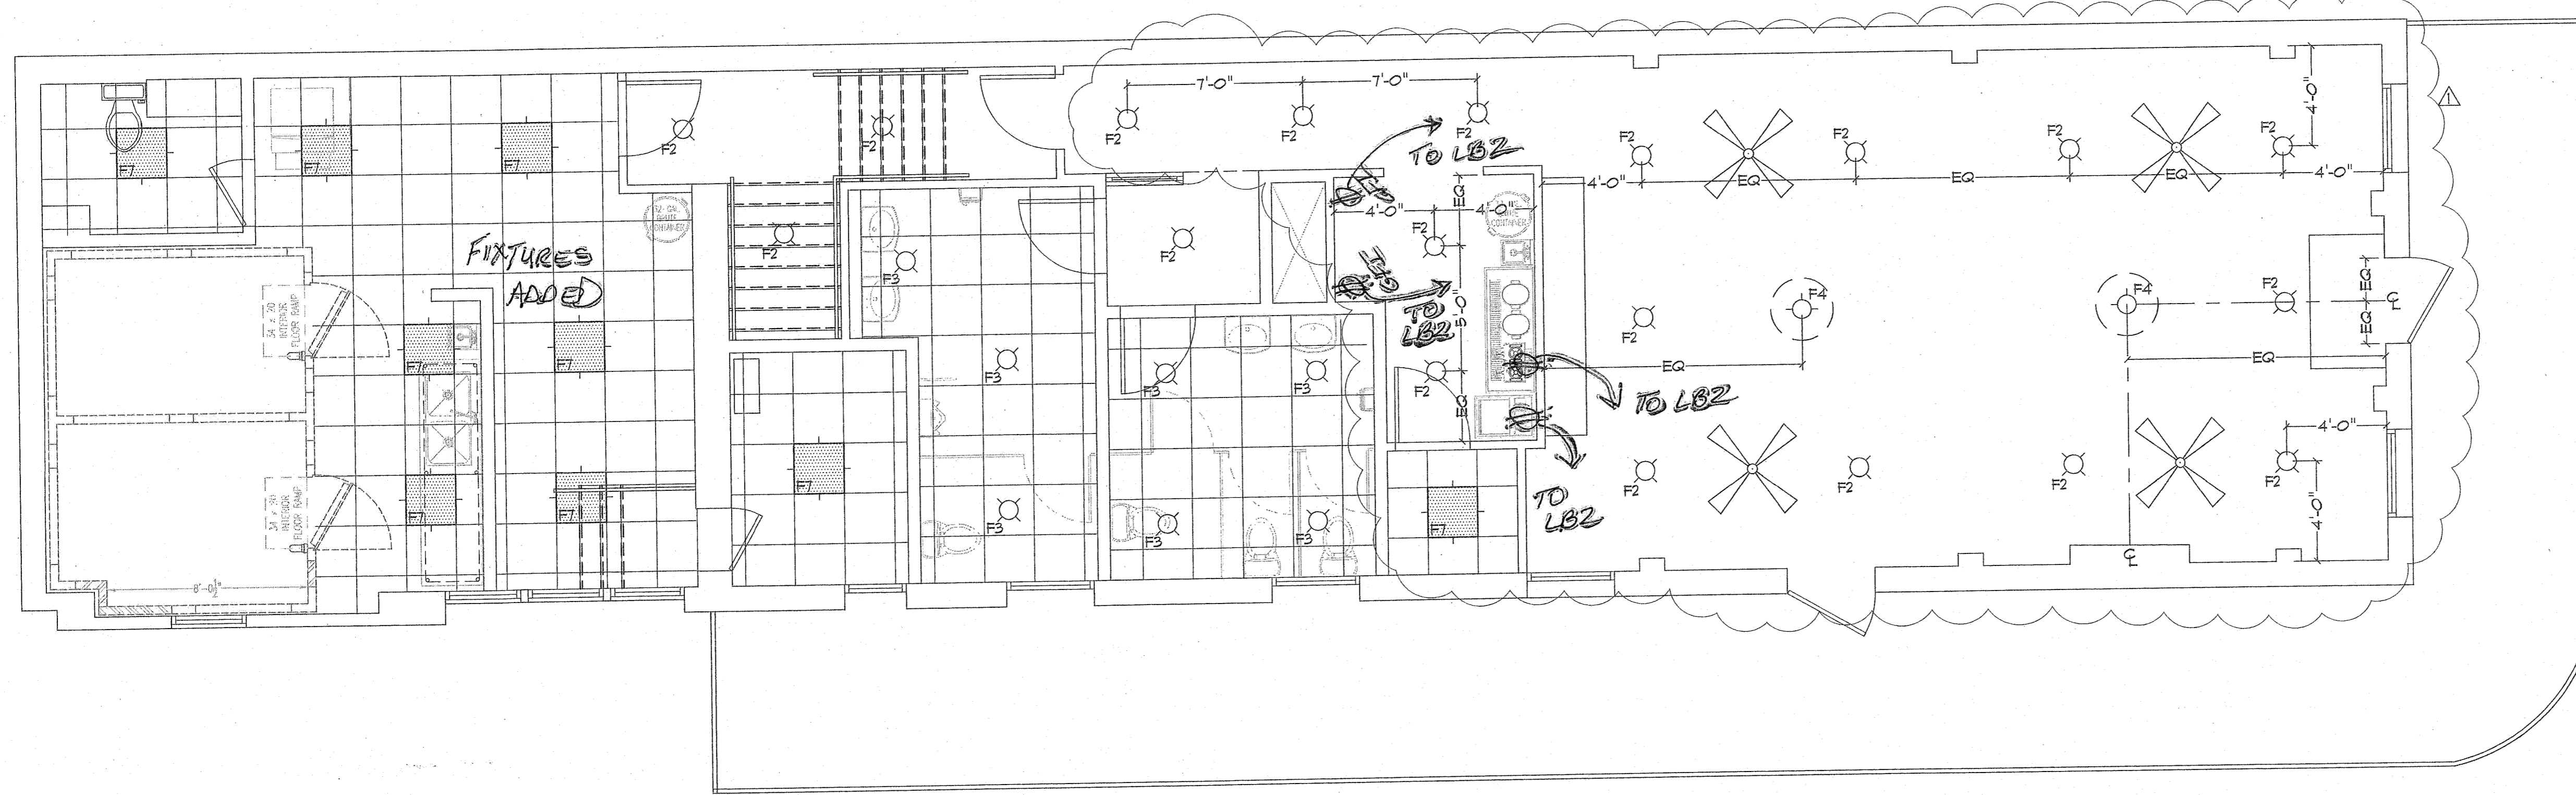

Lighting Plan
 2nd Floor
 1/4" = 1'-0"

LIGHTING LEGEND	
	ACOUSTICAL CEILING TILE AS SCHEDULED
	NOT USED
	PHILIPS LIGHTOLIER LYTEPROFILE 4" 2700K LED DIMMABLE DOWNLIGHT, 1600 LUMENS PHILIPS SUNRISE ELECTRONIC WALL DIMMER FRAME IN KIT: P-4-R-D-15-N-Z10-U-VB LIGHT ENGINE: P-4-R-D-8-21-VB REFLECTOR: P-4-R-D-CL ALTERNATE: DIMMABLE RECESSED INCANDESCENT DOWNLIGHT W/2700K LED BULB. OWNER TO APPROVE SAMPLE BULB & LUMEN OUTPUT PRIOR TO CONTRACTOR ORDERING.
	PHILIPS LIGHTOLIER LYTEPROFILE 4" 2700K LED DOWNLIGHT, 1000 LUMENS FRAME IN KIT: P-4-R-D-15-N-Z10-U-VB LIGHT ENGINE: P-4-R-D-8-21-VB REFLECTOR: P-4-R-D-CL ALTERNATE: RECESSED INCANDESCENT DOWNLIGHT W/2700K LED BULB. OWNER TO APPROVE SAMPLE BULB & LUMEN OUTPUT PRIOR TO CONTRACTOR ORDERING.
	TROY LIGHTING ANDROMEDA F4826 42"W x 37"H x 9" MAX HGT. OWNER SUPPLIED, CONTRACTOR INSTALLED.
	TROY LIGHTING ANDROMEDA INTERIOR SCONCE, B4822, 5 1/2"W x 13 1/4" x 6 1/2" PROJ. OWNER SUPPLIED, CONTRACTOR INSTALLED
	NOT USED
	METALUX ZEN LED 2'X2' TROFFER LED MODULE 3400 LUMENS, 3500K ZENLDI-34-UNV-LB35-CDHJ
	JESCO LIGHTING INFINA LED FLEXIBLE LINEAR DL-FLEX STATIC SERIES, DRIVERLESS, 2700K DL-AC-FLEX-27 MOUNTING: DL-AC-FLEX-MC. VERIFY MOUNTING W/ ETAGERE FABRICATOR ALAN TUDURY
	CALIFORNIA FAN COMPANY RAINDANCE TRADITIONAL 52" BLADE CEILING FAN, BLACK BLADES, ROTARY SPEED CONTROL, 24" DOWNROD OWNER SUPPLIED, CONTRACTOR INSTALLED

ALL STAR ELECTRIC
 PROJECT RECORD
 12/17

301 Royal Street
 New Orleans, Louisiana

Plans

ID-2
 OF


BY:	REV. DATE:
TM	3/26/15
TM	4/1/15
TM	6/19/15

CANZONERI & ASSOCIATES, L.L.C.
 3305 BIRCHMEYER AVE.
 METairie, La. 70002
 Drawn By: MR. Checked By: LM.
 Job Name: 301 ROYAL STREET


PROJECT:
 PROPOSED RENOVATIONS TO 301 ROYAL ST.
 CREOLE CUISINE RESTAURANT CONCEPTS

Moynan Consulting, LLC
 Facility Design & Planning
 101 Kramer Ct, Metairie, Louisiana 70071
 Phone/FAX: (885) 674-5710
 Cell: (885) 284-6121
 www.moynanconsulting.com

DATE: 3/23/15
 SCALE: AS NOTED
 SHEET: **E2**

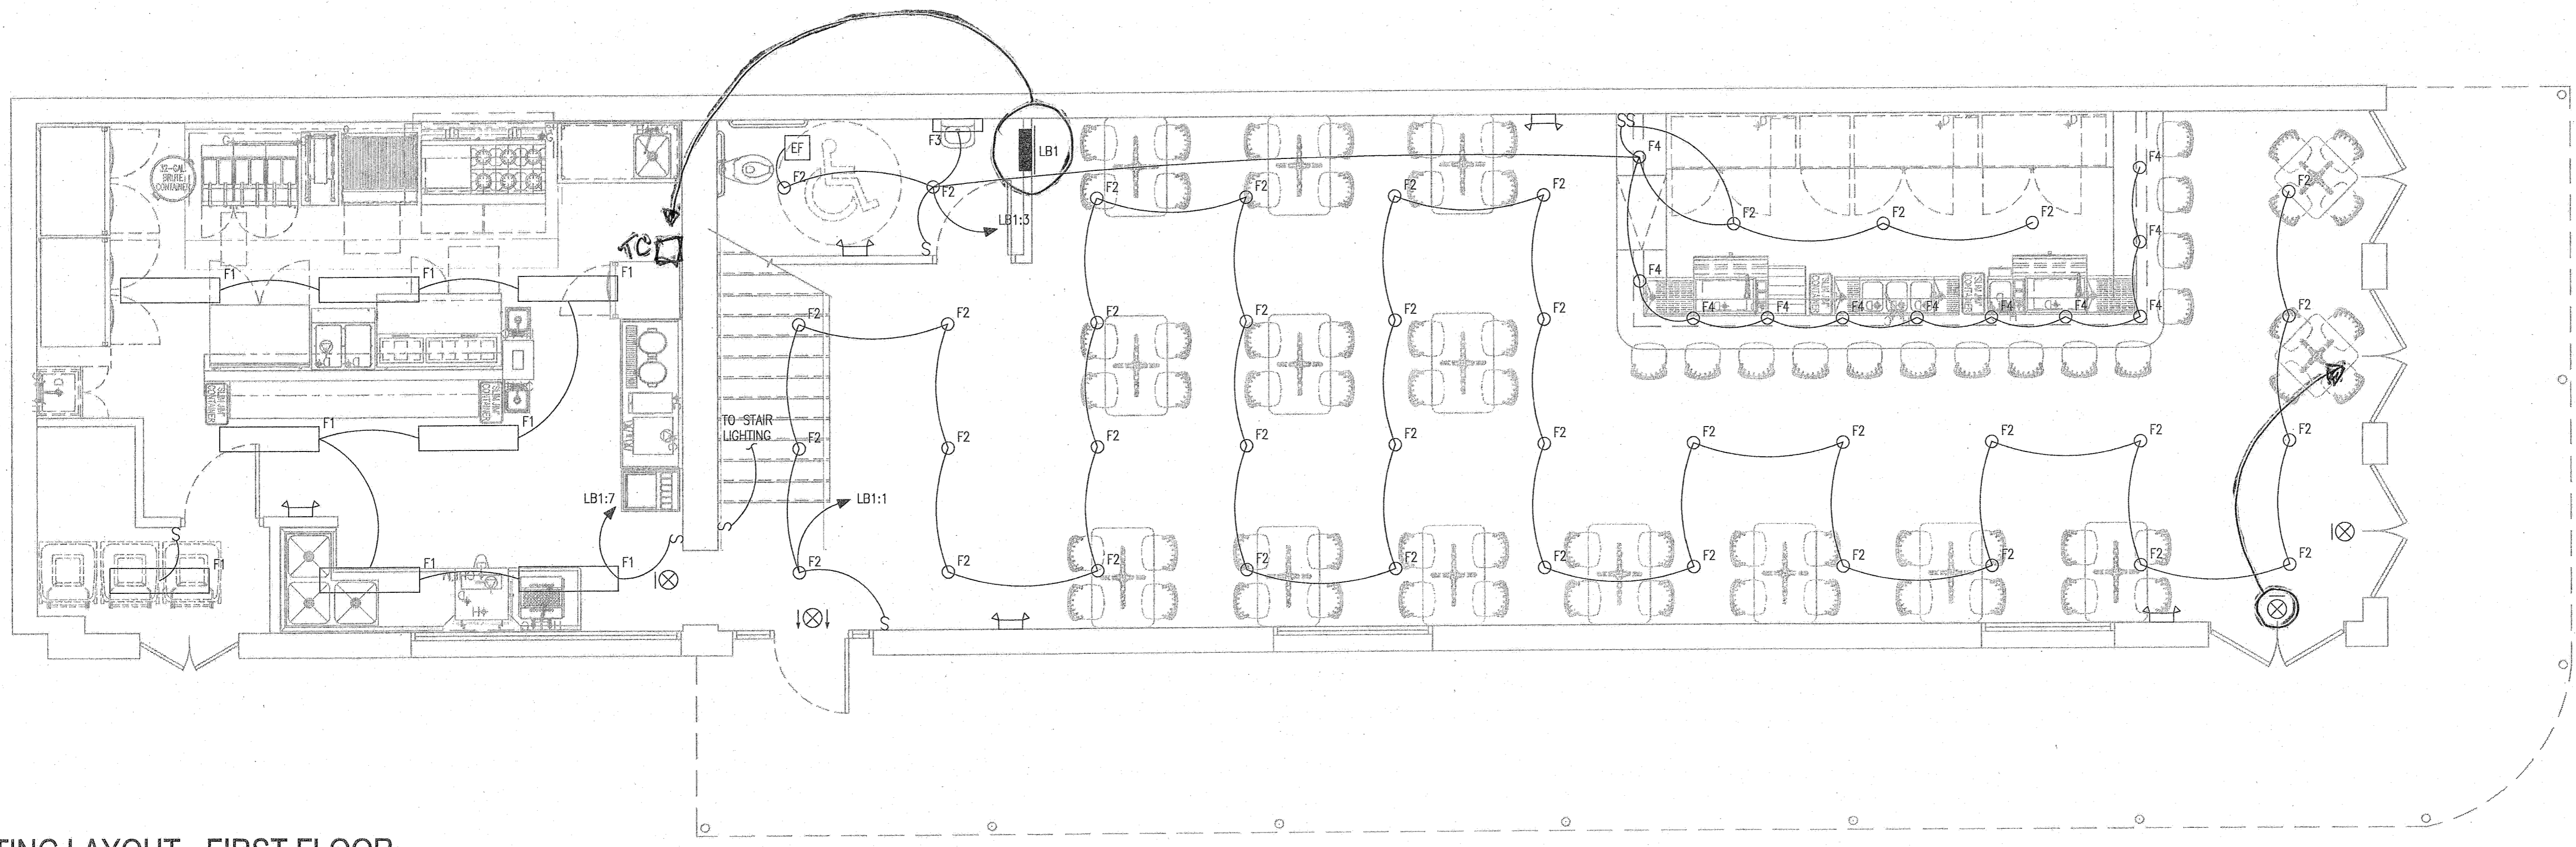


LIGHTING LAYOUT - FIRST FLOOR
 SCALE: 1/4" = 1'-0" SEE SHEET ID-2 FOR LIGHTING LAYOUT

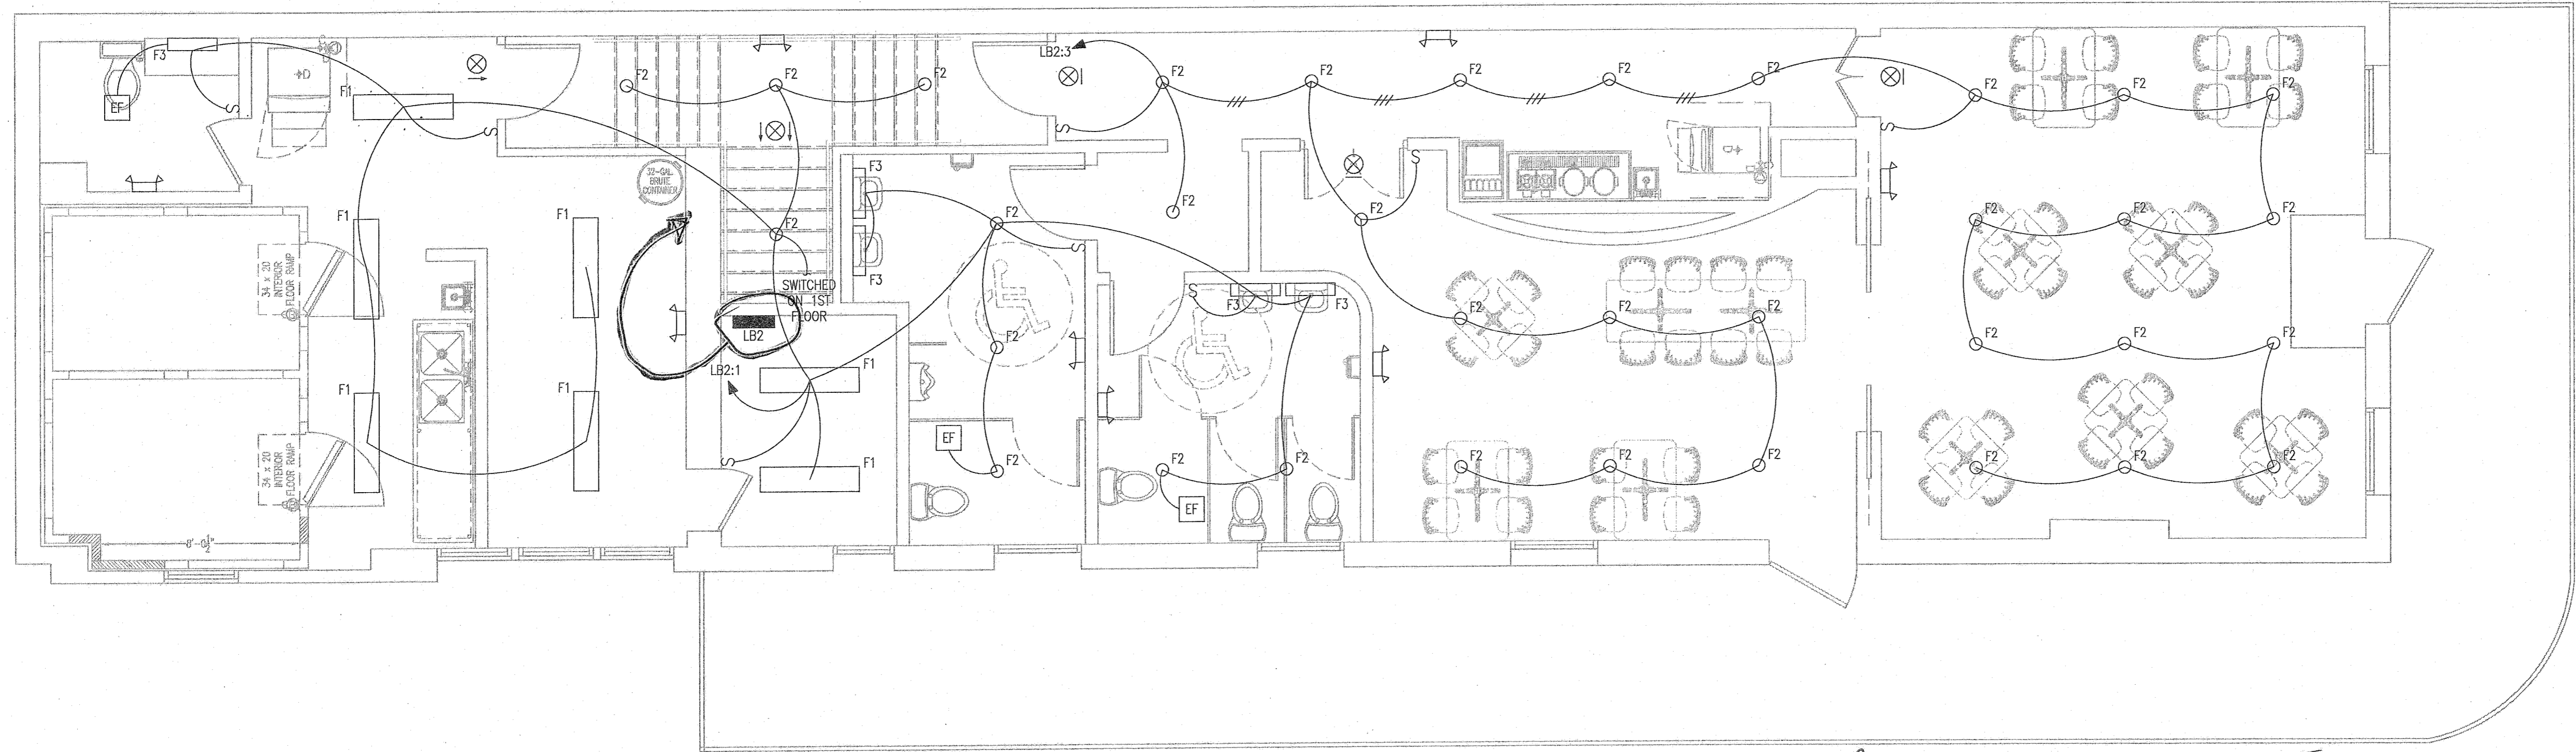

LIGHTING LAYOUT - SECOND FLOOR
 SCALE: 1/4" = 1'-0" SEE SHEET ID 2 FOR LIGHTING LAYOUT

ALL STAR ELECTRIC
 PROJECT RECORD
 12/17

BY:	REV. DATE:
TM	3/26/15
TM	4/1/15
TM	6/19/15

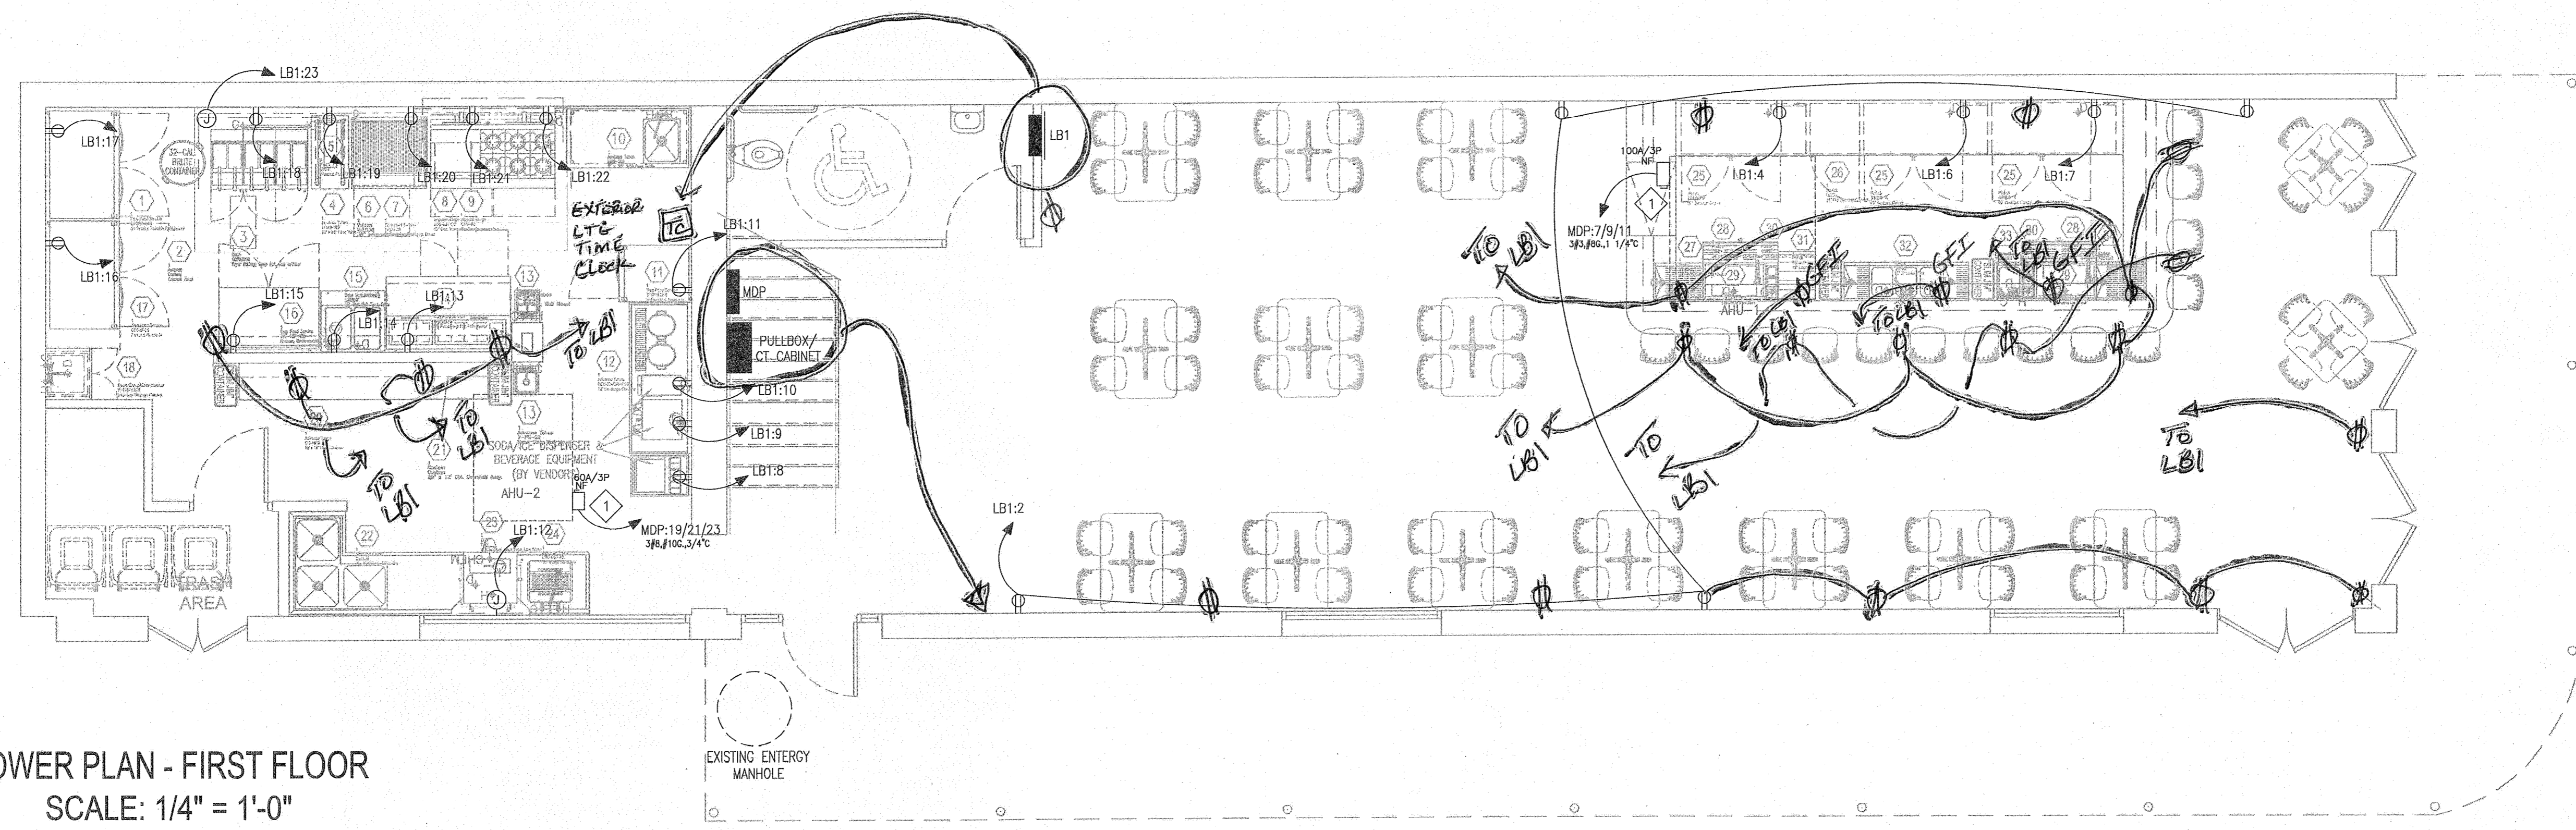


POWER PLAN - FIRST FLOOR
SCALE: 1/4" = 1'-0"

ELECTRICAL SCHEDULE (6/30/15)

Item No	Qty	Equipment Description	Manufacturer	Model Number	Ampe	KW	HP	Volts	Phase	Cycle	Hardwire Conn.	Conc/Plug	NEMA Plug No.	Electrical A.F.F. (in)	Elec Remarks
1	1	(2) Section Reach Refrigerator	True Food Service	STG2R-4HS	9.1	-	1/2	120	1	60	-	-	X	5-15P	80 (E1)
2	1	Exhaust Hood	Accurex	Exhaust Fan	10.6	-	3.0	208	3	60	X	-	-	-	ROOF (E2); See Shop Drawings
3	1	Fryer Battery, Deep Fat, Gas w/Filter	Dean	SCFD350G (Controls)	1.0	-	-	120	1	60	-	-	X	5-15P	12 (E3)
4	1	18" x 36" Filter Table	Advance Tabco	Filter System	8.0	-	-	120	1	60	X	-	X	5-15P	12 (E3.1)
5	1	Warmer, Food Overhead	Helica	GRFF	4.2	0.5	-	120	1	60	-	-	X	5-15P	48 (E5)
6	1	36" Infrared Charbroiler	Vulcan	VTEC36	-	-	-	-	-	-	-	-	-	-	-
7	1	36" Refrigerated Equip. Stand	True Food Service	TROB-36	5.7	-	1/8	120	1	60	-	-	X	5-15P	12 (E7)
8	1	60" Gas Restaurant Range	Imperial Range	IR-6-G24-CC (Left Convection Oven)	6.0	-	1/4	120	1	60	X	-	X	5-15P	12 (E8)
9	1	60" Gas Cheesemelter	Imperial Range	ICMA-60	-	-	-	-	-	-	-	-	-	-	-
10	1	5' x 30" S/S Prep Table	Advance Tabco	RMS-30S	-	-	-	-	-	-	-	-	-	-	-
11	1	Refrigerator, Reach-in	True Food Service	STG1R-2HS	4.8	-	1/3	120	1	60	-	-	X	5-15P	80 (E11)
12	1	72" Beverage Counter	Advance Tabco	BEV-30-72R-MOD	-	-	-	-	-	-	-	-	-	-	-
13	2	Hand Sink, Wall Mount	Advance Tabco	7-PS-22	-	-	-	-	-	-	-	-	-	-	-
14	1	60" Pizza/Prep Top Refrigerator	True Food Service	TPP-60D-2	7.9	-	1/3	120	1	60	-	-	X	5-15P	12 (E14)
15	1	(2)-Wall Hot Food Table	Duke Manufacturing	E302SW	12.5	1.5	-	120	1	60	-	-	X	5-15P	18 (E15)
16	1	Freezer, Undercounter, Compact	True Food Service	TWT-48F-ADA	5.0	-	1/8	120	1	60	-	-	X	5-15P	12 (E16)
17	1	Freezer, Reach-in	True Food Service	STG2F-2S	8.7	-	3/4	120	1	60	-	-	X	5-15P	80 (E17)
18	1	Mop Sink/Storage Cabinet	Eagle Group/Metal Masters	F1918-VSCS	-	-	-	-	-	-	-	-	-	-	-
19	1	Ice Maker/ Bin	Montwaco Ice	11-4908A / F-700	12.3	-	-	208	1	60	X	-	-	-	80 (E19)
20	1	10" x 18" Dish Cabinet	Advance Tabco	DC-1810	-	-	-	-	-	-	-	-	-	-	-
21	1	20" x 12" Dish, Overshelf Assy.	Custom	Custom	-	-	-	-	-	-	-	-	-	-	-
22	1	Pat Sink/Clean Dishable	Advance Tabco	Custom	-	-	-	-	-	-	-	-	-	-	-
23	1	Washer, Door Type, Low Temp	TBD	TBD	16.0	-	-	120	1	60	X	-	-	-	60 (E23)
24	1	36" Sliced Dishable	Advance Tabco	DTS-560-36L	-	-	-	-	-	-	-	-	-	-	-
25	3	60" Backbar Cooler	Perlick	BBS60**R	5.5	-	1/4	120	1	60	X	-	X	5-15P	12 (E25), (E25.1), (E25.2)
26	1	24" Dry Backbar Cabinet	Perlick	DB24	-	-	-	-	-	-	-	-	-	-	-
27	1	24" Right Corner Drainboard	Perlick	TS2ARC	-	-	-	-	-	-	-	-	-	-	-
28	2	36" Dish Underbar Speed Rail	Perlick	SR-3L36	-	-	-	-	-	-	-	-	-	-	-
29	2	Underbar Ice Chest	Perlick	TS30IC-EC10	-	-	-	-	-	-	-	-	-	-	-
30	2	6" Underbar Ice Chest Accessory	Perlick	TS6U2	-	-	-	-	-	-	-	-	-	-	-
31	1	18" Underbar Liquor Display	Perlick	TS18LS	-	-	-	-	-	-	-	-	-	-	-
32	1	60" Underbar Sink	Perlick	TS63C	-	-	-	-	-	-	-	-	-	-	-
33	1	12" Underbar Handsink	Perlick	TS12HSN	-	-	-	-	-	-	-	-	-	-	-
34	1	24" Left Corner Drainboard	Perlick	TS24LC	-	-	-	-	-	-	-	-	-	-	-

SPECIFIC NOTES:
1 A 125VAC, 15- OR 20 AMPERE RATED RECEPTACLE TO BE LOCATED WITHIN 25' OF HVAC EQUIPMENT AT SAME LEVEL FOR MAINTENANCE PURPOSED AS PER NEC 2011.

ALL STAR ELECTRIC
PROJECT RECORD
12/17

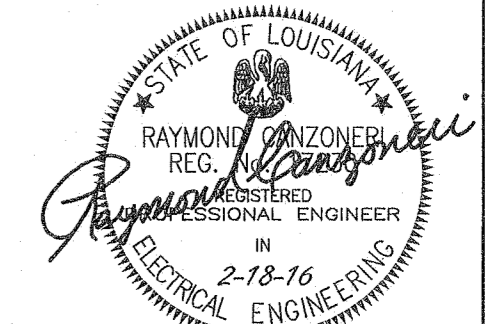

PROJECT:


PROPOSED RENOVATIONS TO 301 ROYAL ST.
CREOLE CUISINE RESTAURANT CONCEPTS

Moynan Consulting, LLC
Foodservice Facility Design & Planning
101 Kramer Ct. Mandeville, Louisiana 70471
Phone/FAX: (985) 674-5710
Cell: (985) 264-6121
www.moynanconsulting.com

DATE: 3/23/15
SCALE: AS NOTED
SHEET: E3

BY:	REV. DATE:
TM	3/26/15
TM	4/1/15
TM	6/19/15

CANZONERI & ASSOCIATES, L.L.C.
 ELECTRICAL ENGINEERING
 5001 BIRCHWOOD DRIVE
 SUITE 100
 METairie, LA 70002
 Phone: (504) 888-0074
 Fax: (504) 888-0074
 Down By: MR. ...
 Checked By: LM
 Job Name: ... 301 ROYAL STREET

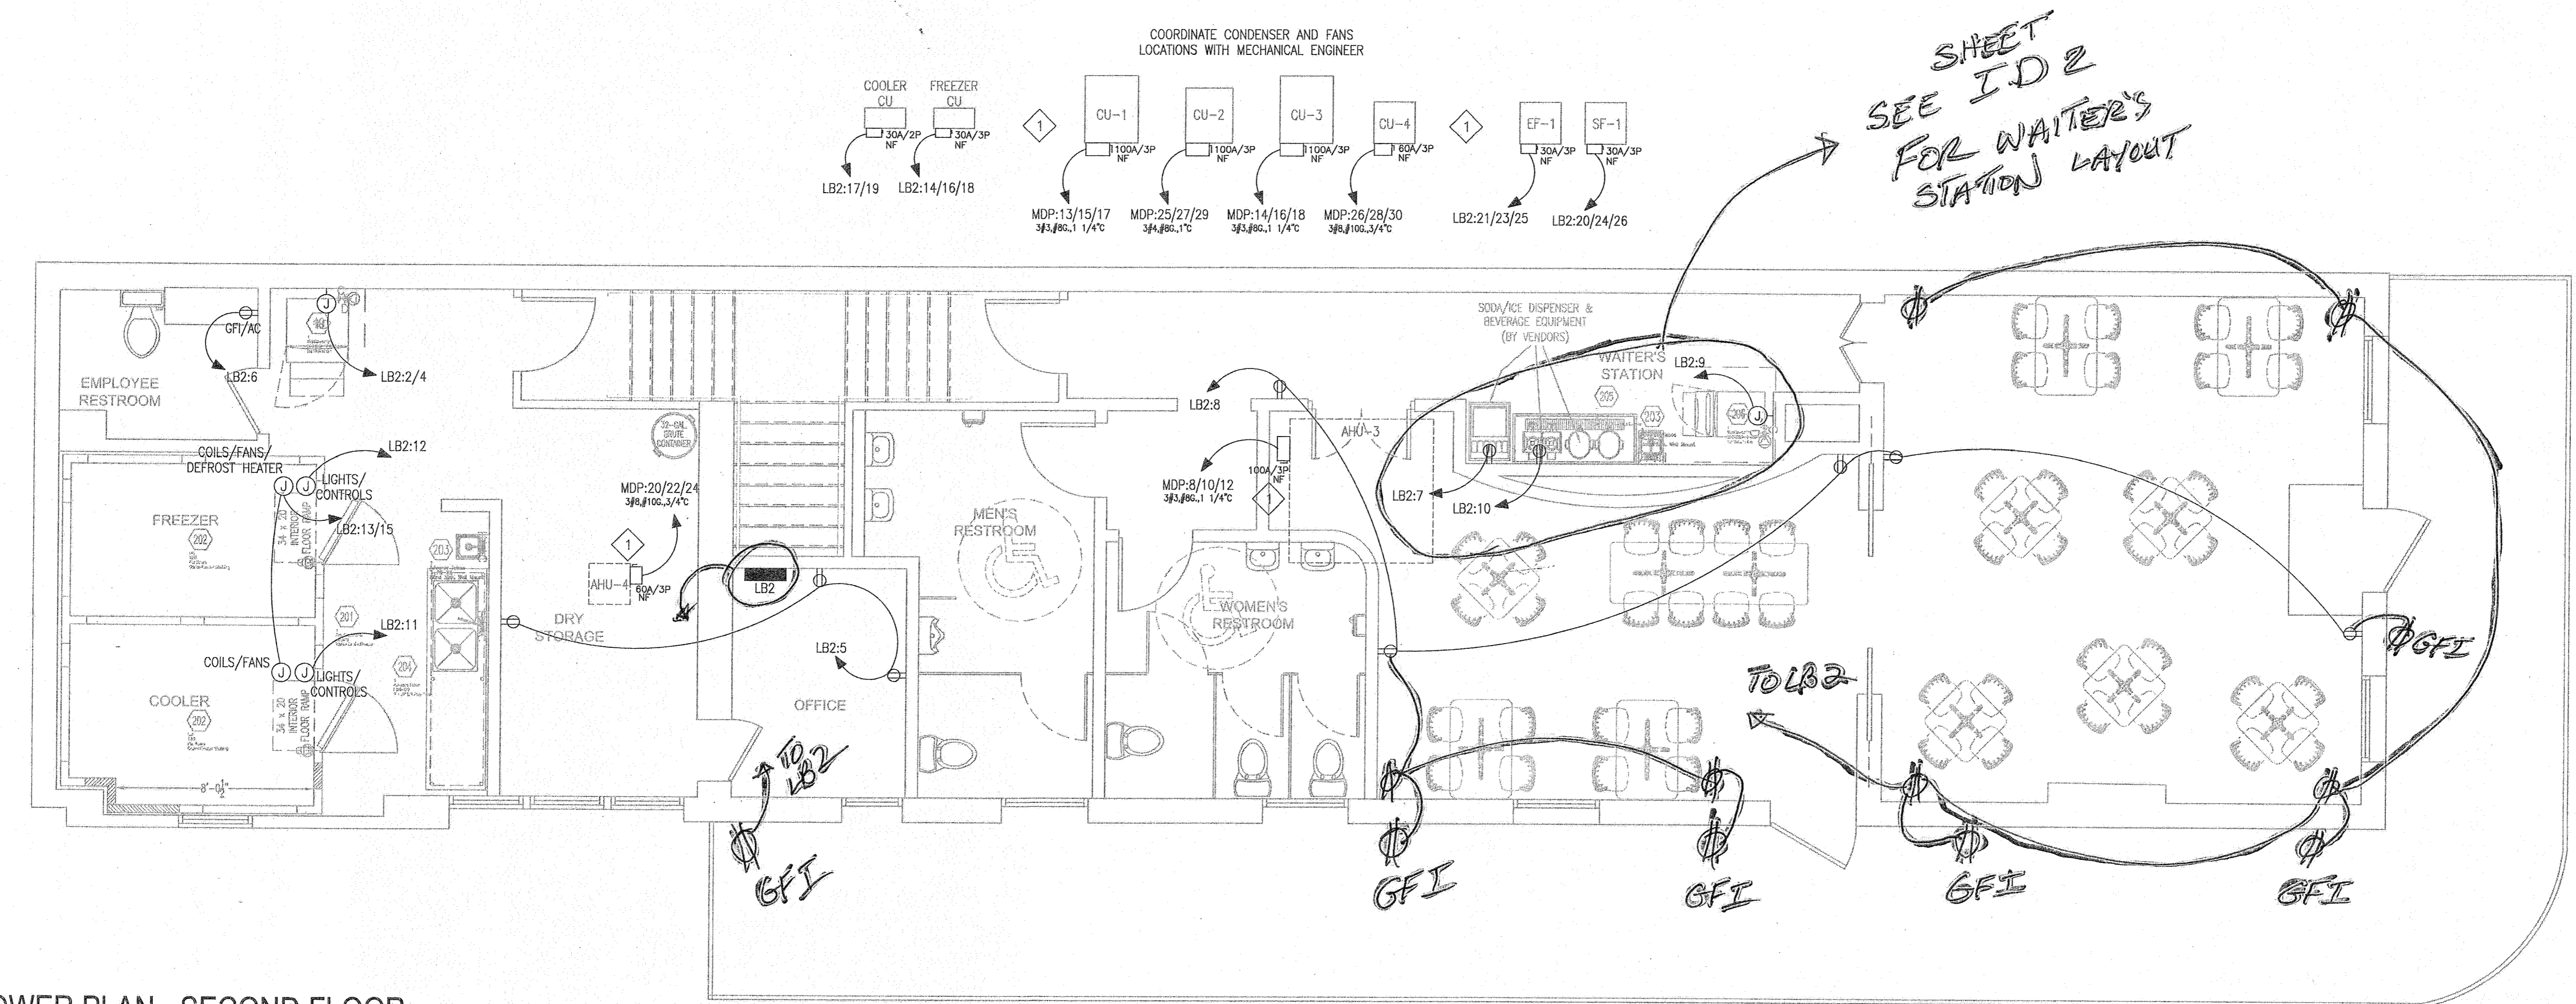


POWER PLAN - SECOND FLOOR
 SCALE: 1/4" = 1'-0"

Item No.	Qty	Equipment Description	Manufacturer	Model Number	Amps	KW	HP	Volts	Phase	Cycle	Harmonics Conn. Coords/Plug	NECA Plug No.	Electrical A.C.F. (in)	File Remarks
201	1	Walkin Cooler/Freezer	American Panel	Cooler Condensing Unit	12.7	1.0	208	1	60	X	-	-	-	ROOF (E201); See Shop Drawings
-	-	-	-	Cooler Coils/Fans	0.9	-	208	1	60	X	-	-	-	DFA (E201); See Shop Drawings
-	-	-	-	Cooler Lights/Controls	10.0	-	120	1	60	X	-	-	-	DFA (E201); See Shop Drawings
-	-	-	-	Freezer Condensing Unit	11.8	2.0	208	3	60	X	-	-	-	ROOF (E201); See Shop Drawings
-	-	-	-	Freezer Coils/Fans/Defrost Heaters	8.7	-	208	1	60	X	-	-	-	DFA (E201); See Shop Drawings
-	-	-	-	Freezer Lights/Controls	10.0	-	120	1	60	X	-	-	-	DFA (E201); See Shop Drawings
202	Lot	Cooler/Freezer Shelving	TBD	Per Space	-	-	-	-	-	-	-	-	-	-
203	2	Hand Sink, Wall Mount	Advance Tabco	7-PS-22	-	-	-	-	-	-	-	-	-	-
204	1	9' x 30" S/S Prep Table	Advance Tabco	KMS-309	-	-	-	-	-	-	-	-	-	-
205	1	24" x 60" Beverage Counter	Custom	Custom	-	-	-	-	-	-	-	-	-	-
206	1	Ice Maker / Bin	Monitowoc	ID-0322A / B-420	11.8	-	120	1	60	X	-	-	60	(E206)

SPECIFIC NOTES:
 1 A 125VAC, 15- OR 20 AMPERE RATED RECEPTACLE TO BE LOCATED WITHIN 25' OF HVAC EQUIPMENT AT SAME LEVEL FOR MAINTENANCE PURPOSES AS PER NEC 2011.

ALL STAR ELECTRIC
 PROJECT RECORD
 12/17

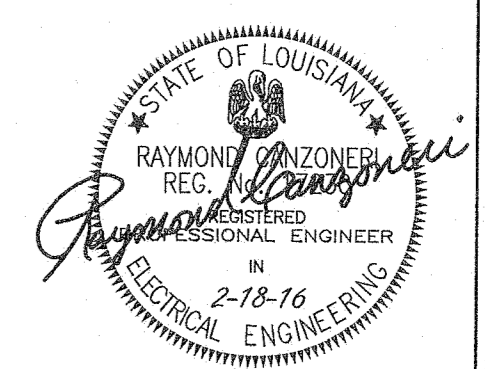


PROJECT:

PROPOSED RENOVATIONS TO 301 ROYAL ST.
 CREOLE CUISINE RESTAURANT CONCEPTS

Moynan Consulting, LLC
 Foodservice Facility Design & Planning
 101 Kramer Ct. Mandeville, Louisiana 70471
 Phone/FAX: (985) 674-5710
 Cell: (985) 264-6121
 www.moynanconsulting.com

DATE: 3/23/15
 SCALE: AS NOTED
 SHEET: E4

301 Royal

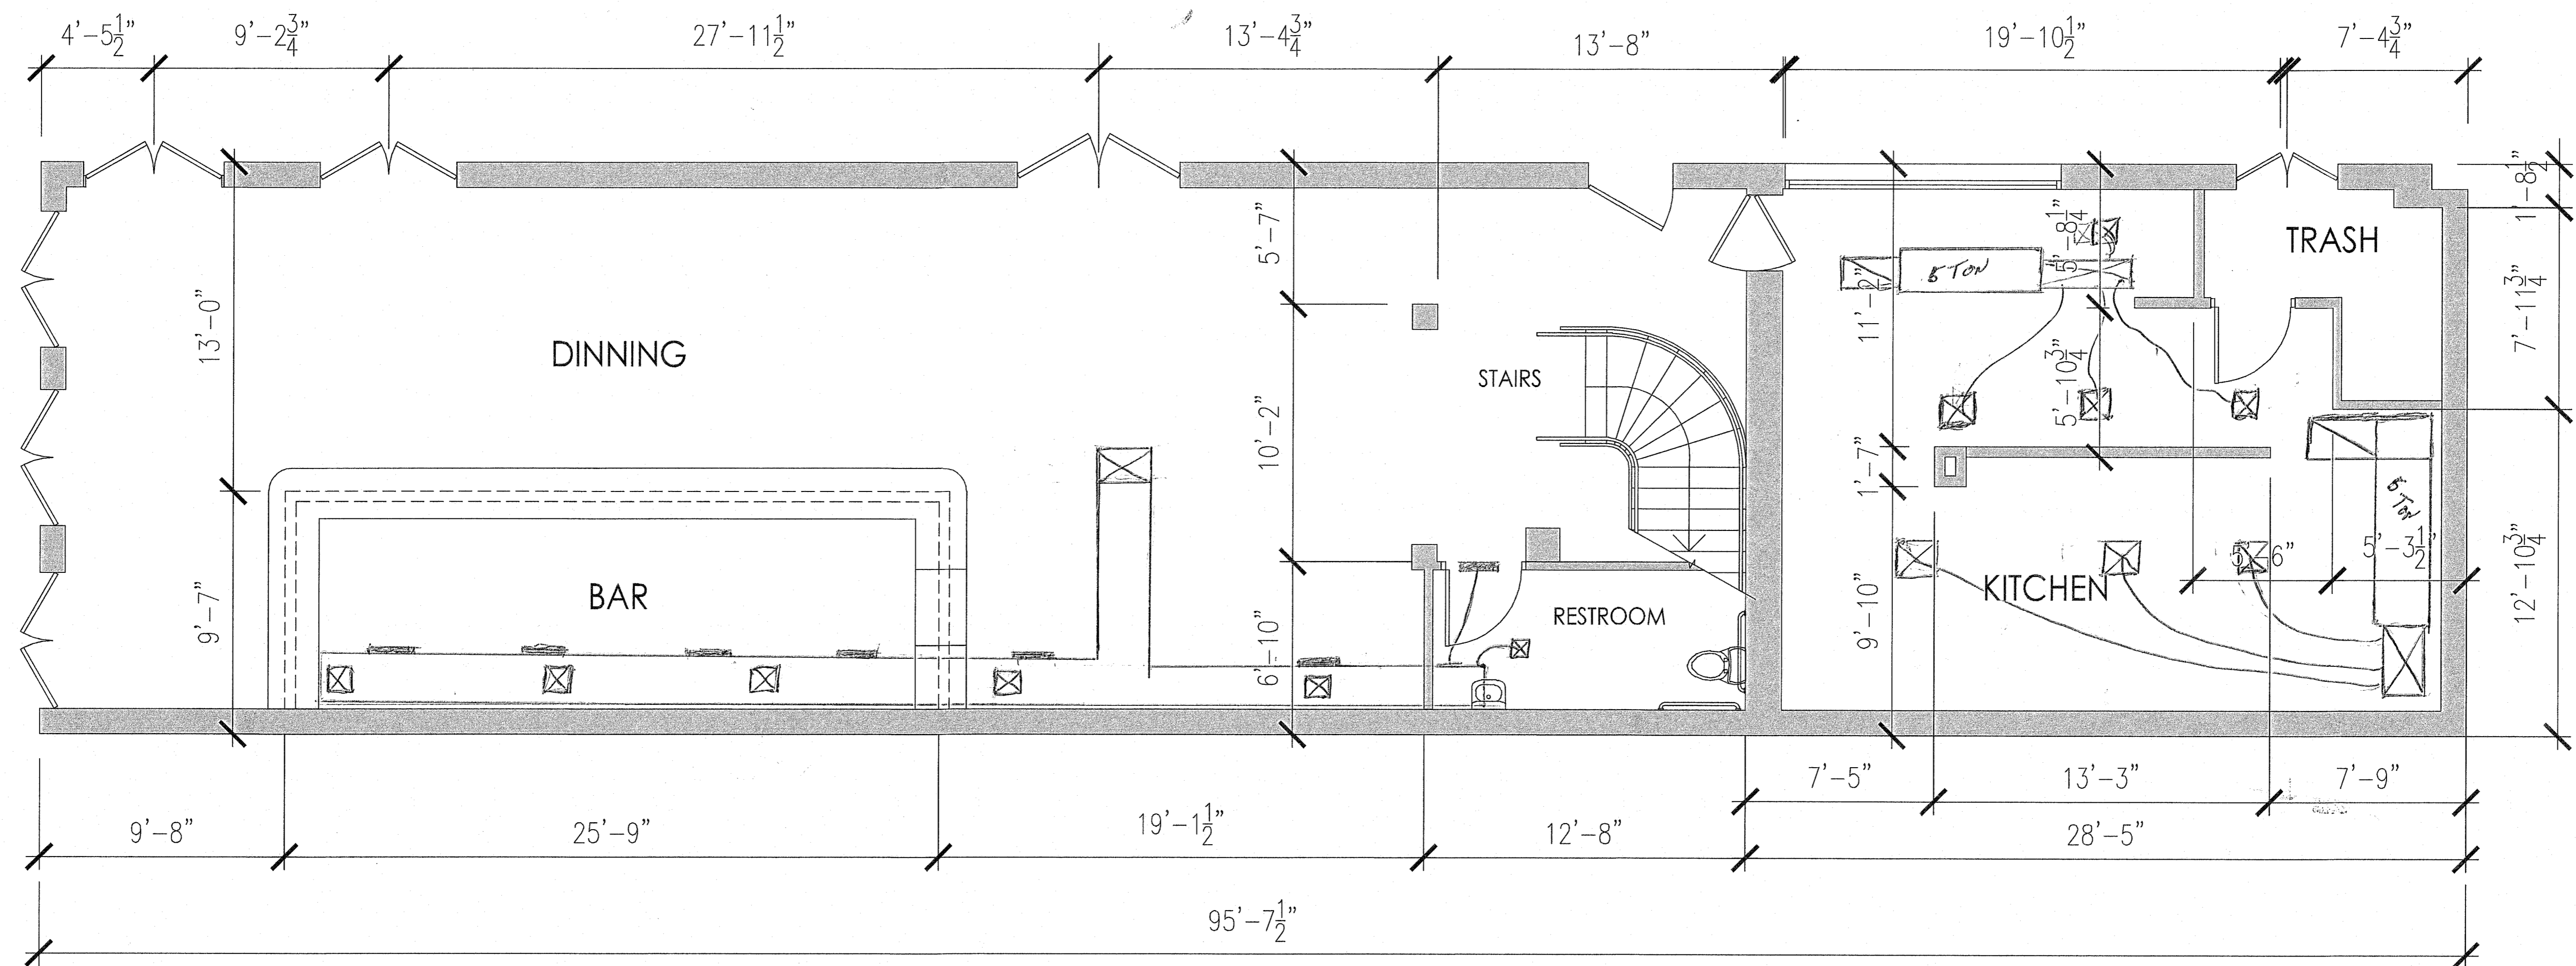

Jake Cowden-Garofalo
(504) 416-6871


301 Royal St.
Existing First Floor Plan

Scale: 3/32" = 1'-0"

NOTES: Lewis AC
Project Record

DATE:
08/16/2017

Page 1

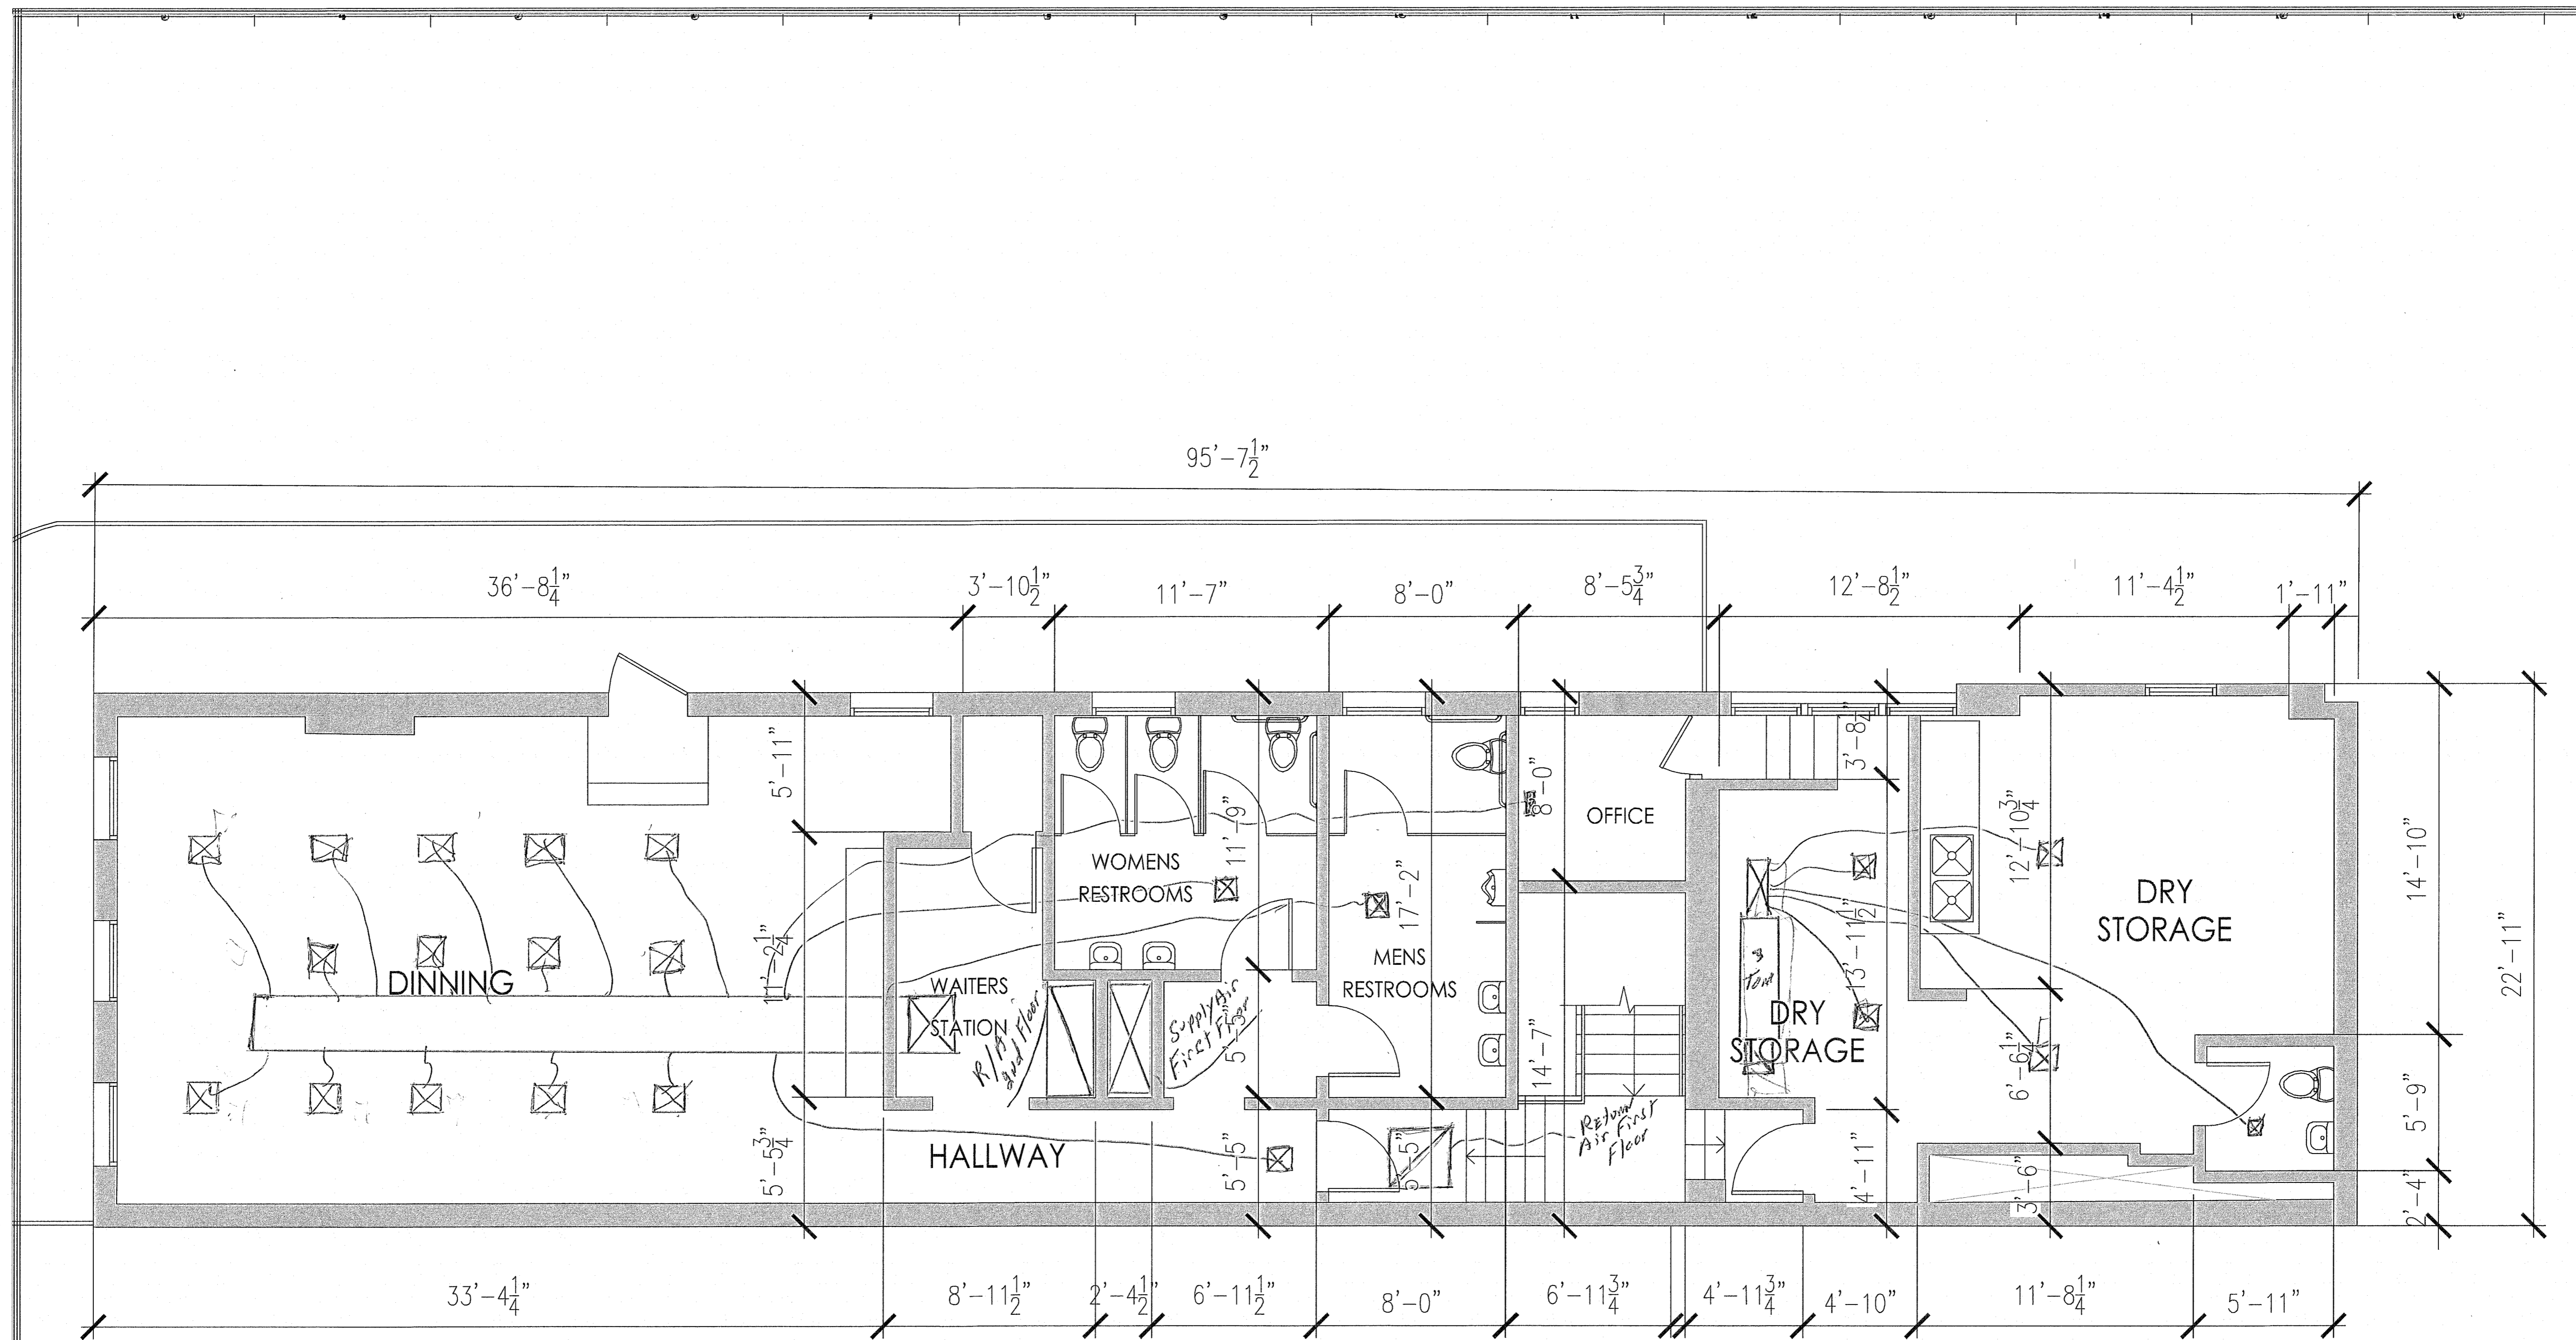

Jake Cowden-Garofalo
 (504) 416-6871

301 Royal St.
 Existing Second Floor Plan

Scale: 3/32" = 1'-0"

NOTES: *Lewis AC*
Project Record

DATE:
 08/16/2017

Page 2