


BY:	REV. DATE:
TM	3/26/15
TM	4/1/15
TM	6/19/15

CANZONERI & ASSOCIATES, L.L.C.
 3305 BIRCHMEYER AVE.
 Metairie, La. 70002
 Drawn By: MR. _____
 Checked By: LM
 Job Name: 301 ROYAL STREET


PROJECT:
 PROPOSED RENOVATIONS TO 301 ROYAL ST.
 CREOLE CUISINE RESTAURANT CONCEPTS

Moynan Consulting, LLC
 Facility Design & Planning
 101 Kramer Ct, Metairie, Louisiana 70071
 Phone/FAX: (885) 674-5710
 Cell: (885) 284-6121
 www.moynanconsulting.com

DATE: 3/23/15
 SCALE: AS NOTED
 SHEET: **E2**

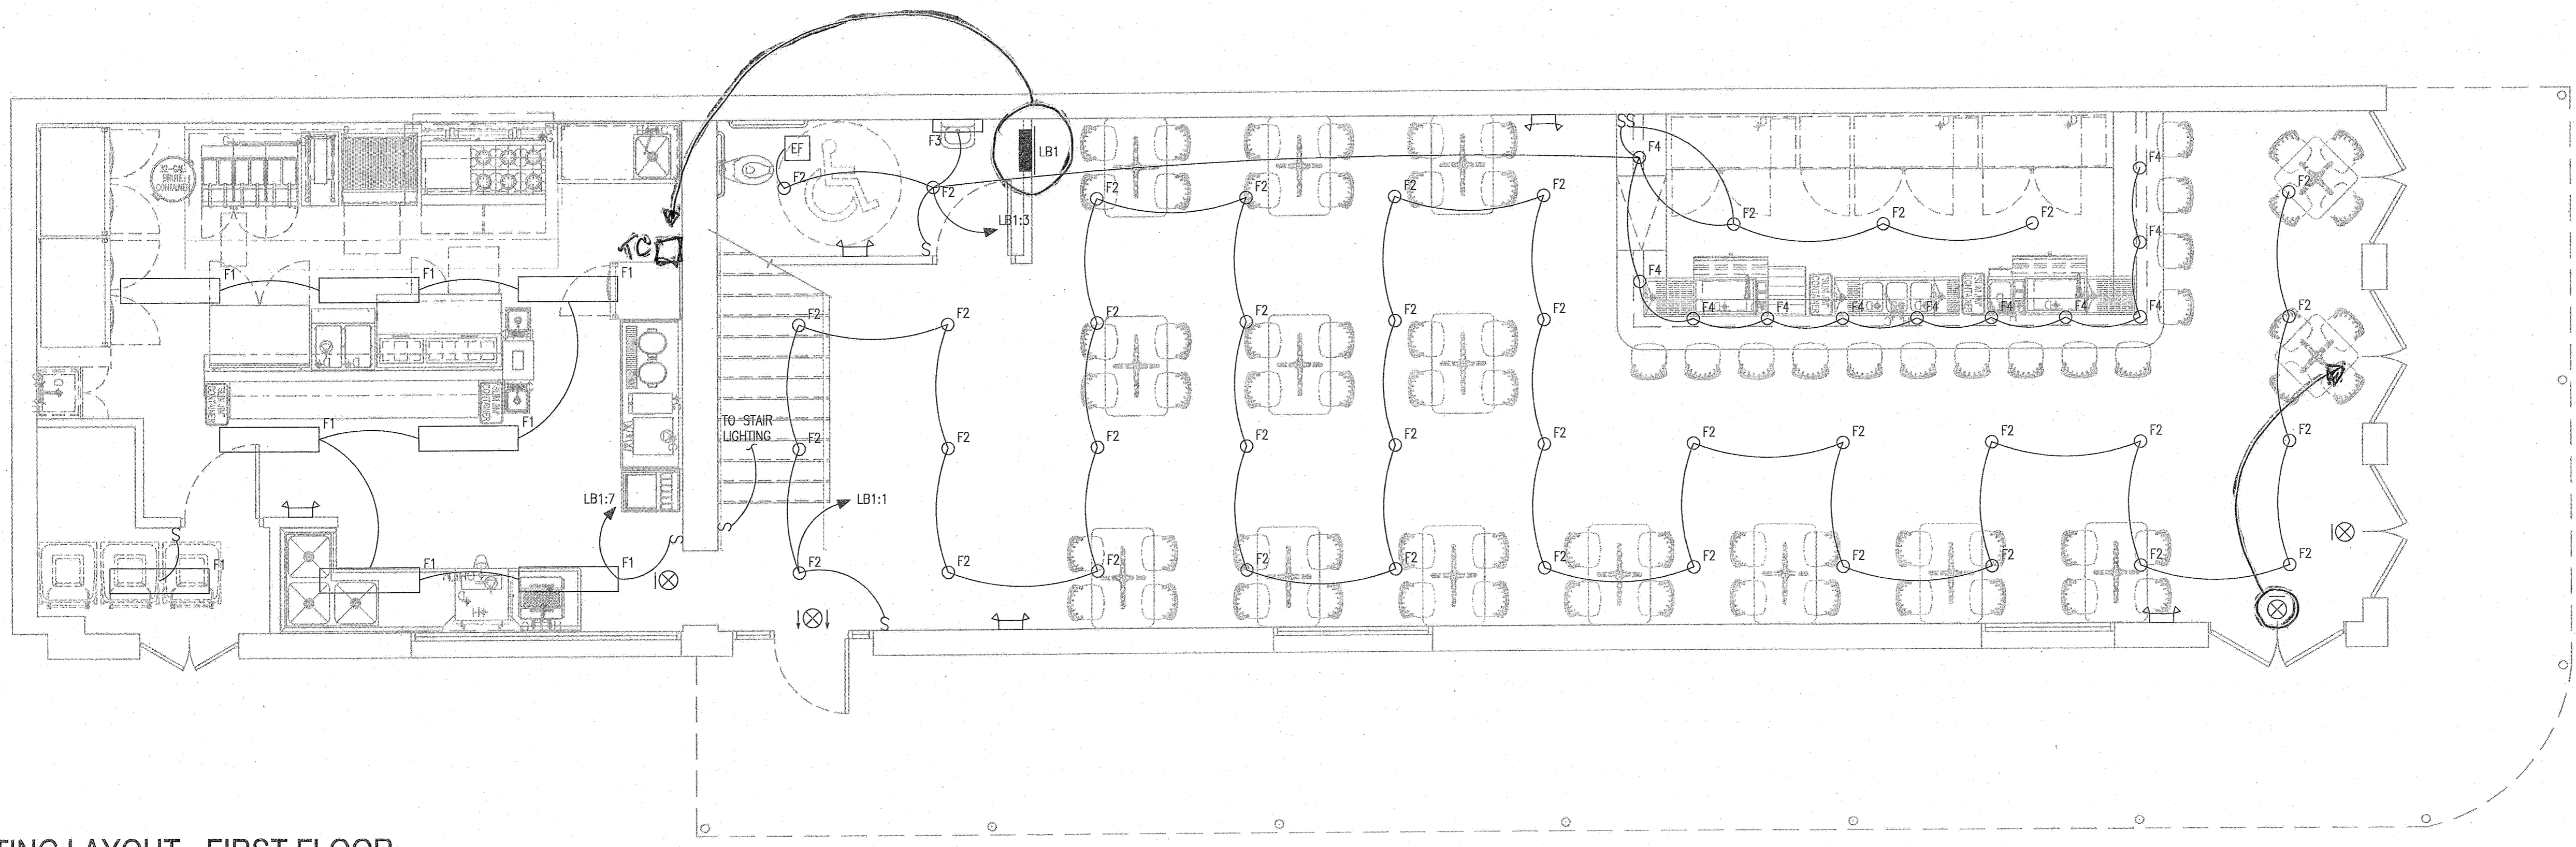

LIGHTING LAYOUT - FIRST FLOOR
 SCALE: 1/4" = 1'-0" SEE SHEET ID-2 FOR LIGHTING LAYOUT

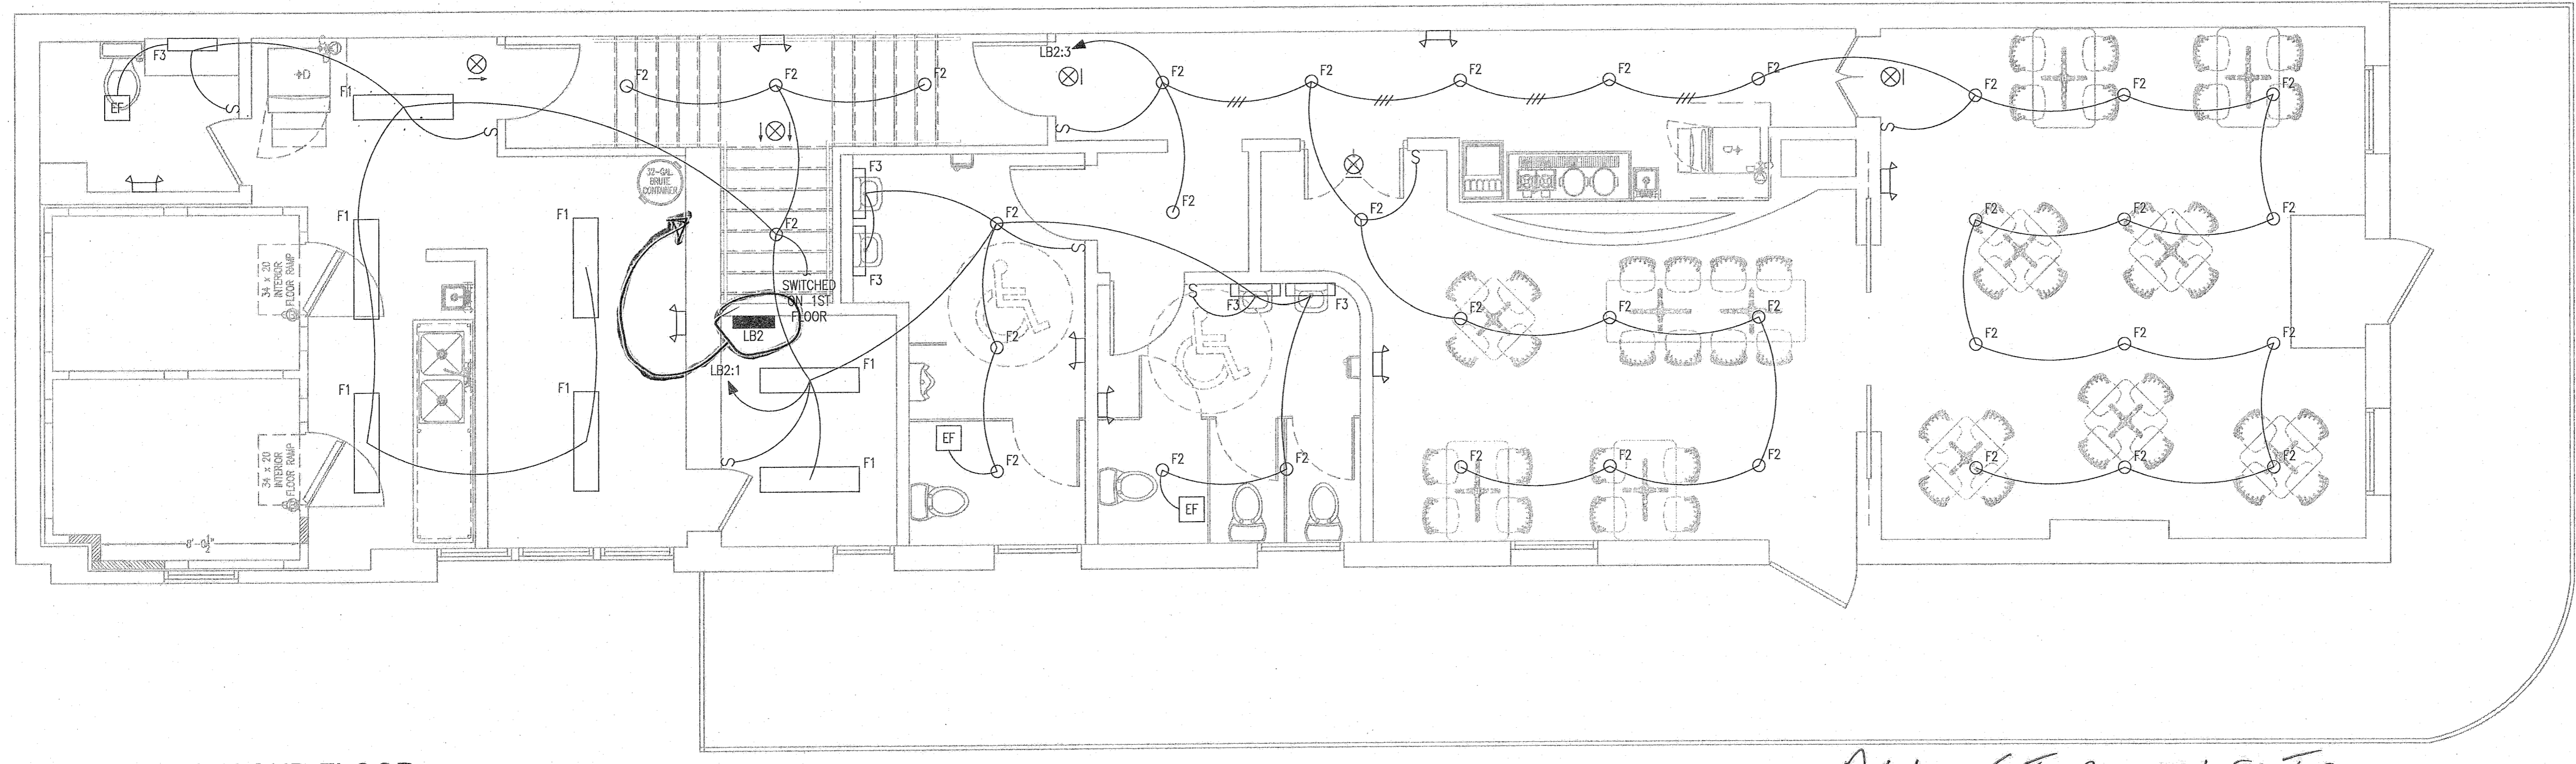

LIGHTING LAYOUT - SECOND FLOOR
 SCALE: 1/4" = 1'-0" SEE SHEET ID 2 FOR LIGHTING LAYOUT

ALL STAR ELECTRIC
 PROJECT RECORD
 12/17