


BY:	REV. DATE:
TM	3/26/15
TM	4/1/15
TM	6/19/15

CANZONERI & ASSOCIATES, L.L.C.
CONSULTING ELECTRICAL ENGINEERS
3005 HESSBUR AVENUE
SUITE 200
METairie, LA 70002
Drawn By: [Signature] Checked By: LM
Job Name: 301 ROYAL STREET

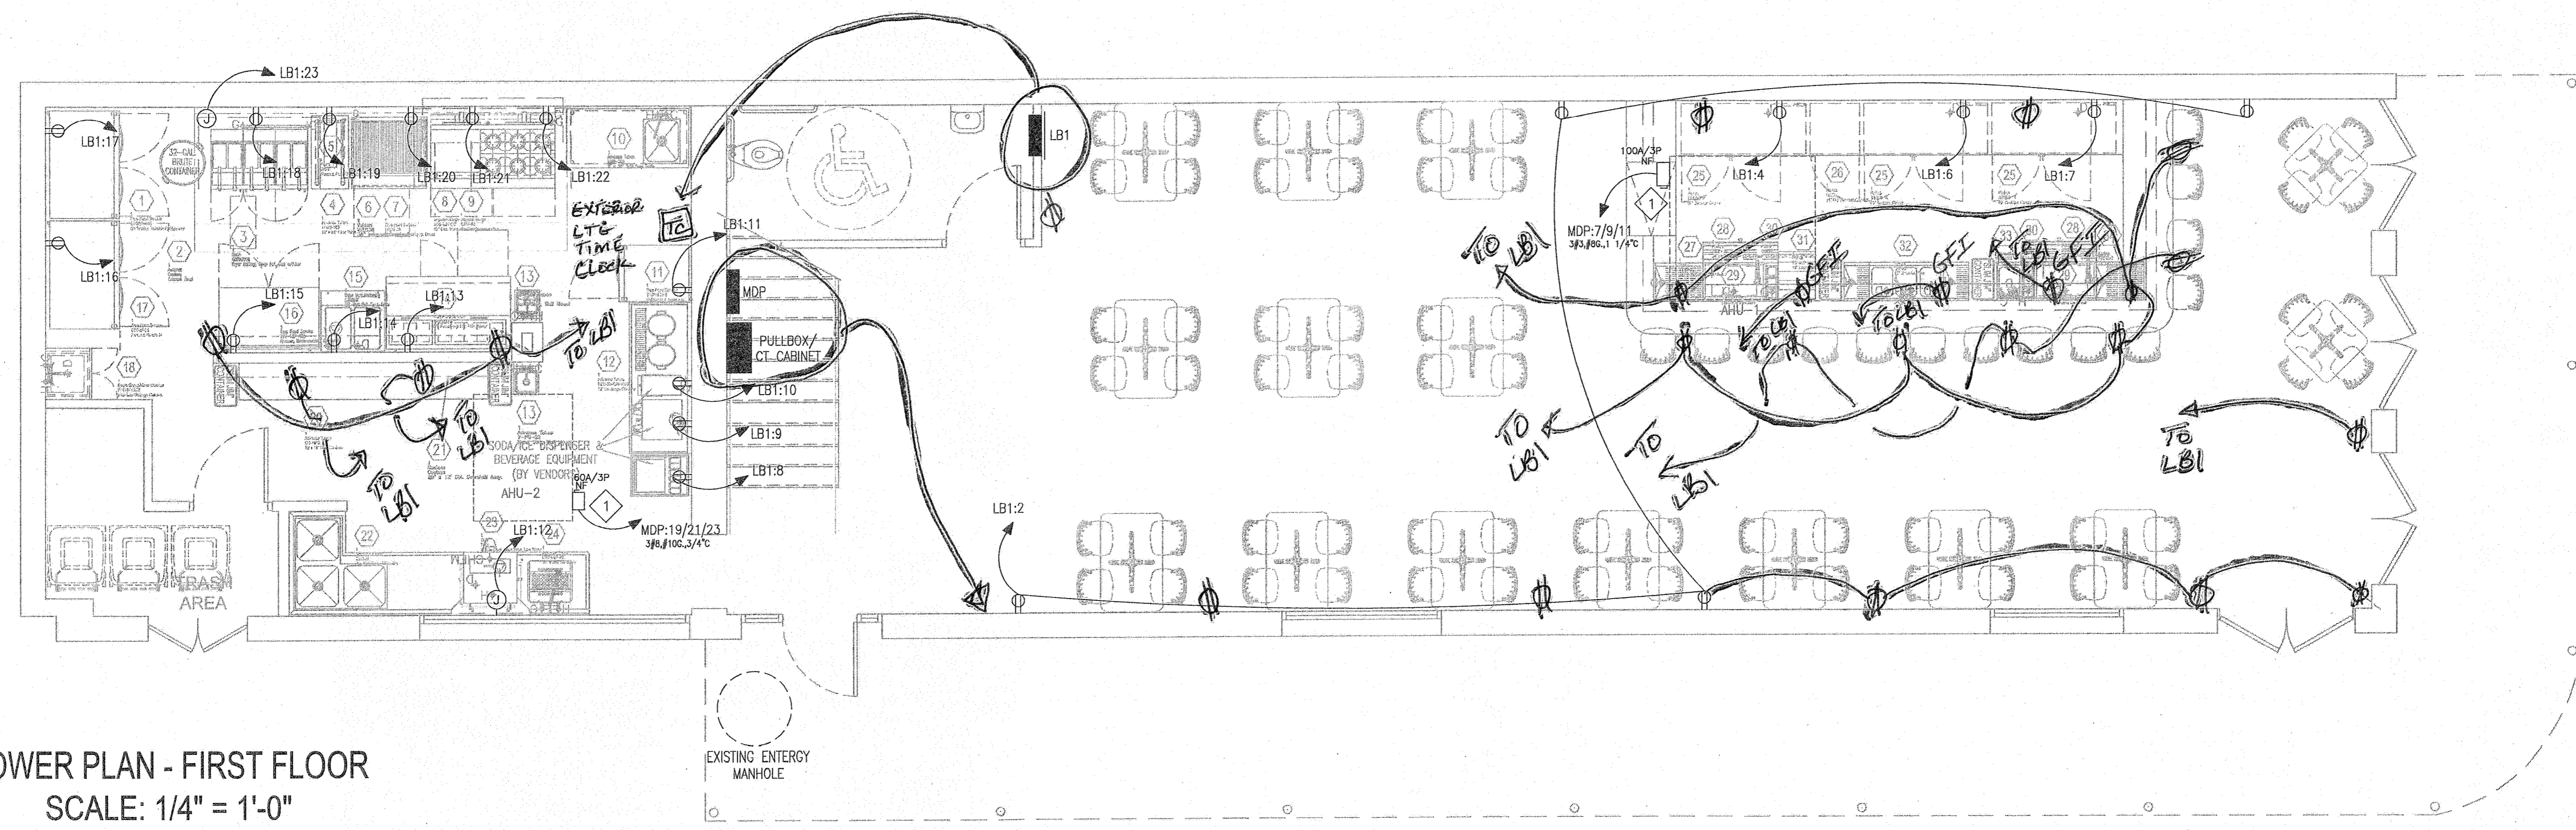


POWER PLAN - FIRST FLOOR
SCALE: 1/4" = 1'-0"

ELECTRICAL SCHEDULE (6/30/15)

Item No	Qty	Equipment Description	Manufacturer	Model Number	Ampe	KW	HP	Volts	Phase	Cycle	Hardwire Conn.	Conc/Plug	NEMA Plug No.	Electrical A.F.F. (in)	Elec Remarks
1	1	(2) Section Reach Refrigerator	True Food Service	STG2R-4HS	9.1	-	1/2	120	1	60	-	-	X	5-15P	80 (E1)
2	1	Exhaust Hood	Accurex	Exhaust Fan	10.6	-	3.0	208	3	60	X	-	-	-	ROOF (E2); See Shop Drawings
3	1	Fryer Battery, Deep Fat, Gas w/Filter	Dean	SCFD350G (Controls)	1.0	-	-	120	1	60	-	-	X	5-15P	12 (E3)
4	1	18" x 36" Filter Table	Advance Tabco	Filter System	8.0	-	-	120	1	60	X	-	X	5-15P	12 (E3.1)
5	1	Warmer, Food Overhead	Helica	GRFF	4.2	0.5	-	120	1	60	-	-	X	5-15P	48 (E5)
6	1	36" Infrared Charbroiler	Vulcan	VTEC36	-	-	-	-	-	-	-	-	-	-	-
7	1	36" Refrigerated Equip. Stand	True Food Service	TROB-36	5.7	-	1/8	120	1	60	-	-	X	5-15P	12 (E7)
8	1	60" Gas Restaurant Range	Imperial Range	IR-6-G24-CC (Left Convection Oven)	6.0	-	1/4	120	1	60	X	-	X	5-15P	12 (E8)
9	1	60" Gas Cheesemelter	Imperial Range	ICMA-60	-	-	-	-	-	-	-	-	-	-	-
10	1	5' x 30" S/S Prep Table	Advance Tabco	RMS-30S	-	-	-	-	-	-	-	-	-	-	-
11	1	Refrigerator, Reach-in	True Food Service	STG1R-2HS	4.8	-	1/3	120	1	60	-	-	X	5-15P	80 (E11)
12	1	72" Beverage Counter	Advance Tabco	BEV-30-72R-MOD	-	-	-	-	-	-	-	-	-	-	-
13	2	Hand Sink, Wall Mount	Advance Tabco	7-PS-22	-	-	-	-	-	-	-	-	-	-	-
14	1	60" Pizza/Prep Top Refrigerator	True Food Service	TPP-60D-2	7.9	-	1/3	120	1	60	-	-	X	5-15P	12 (E14)
15	1	(2)-Wall Hot Food Table	Duke Manufacturing	E302SW	12.5	1.5	-	120	1	60	-	-	X	5-15P	18 (E15)
16	1	Freezer, Undercounter, Compact	True Food Service	TWT-48F-ADA	5.0	-	1/8	120	1	60	-	-	X	5-15P	12 (E16)
17	1	Freezer, Reach-in	True Food Service	STG2F-2S	8.7	-	3/4	120	1	60	-	-	X	5-15P	80 (E17)
18	1	Mop Sink/Storage Cabinet	Eagle Group/Metal Masters	F1918-VSCS	-	-	-	-	-	-	-	-	-	-	-
19	1	Ice Maker/ Bin	Montwaco Ice	11-4908A / F-700	12.3	-	-	208	1	60	X	-	-	-	80 (E19)
20	1	10" x 18" Dish Cabinet	Advance Tabco	DC-1810	-	-	-	-	-	-	-	-	-	-	-
21	1	20" x 12" Dish Overshelf Assy.	Custom	Custom	-	-	-	-	-	-	-	-	-	-	-
22	1	Pat Sink/Clean Dishable	Advance Tabco	Custom	-	-	-	-	-	-	-	-	-	-	-
23	1	Washer, Door Type, Low Temp	TBD	TBD	16.0	-	-	120	1	60	X	-	-	-	60 (E23)
24	1	36" Sliced Dishable	Advance Tabco	DTS-560-36L	-	-	-	-	-	-	-	-	-	-	-
25	3	60" Backbar Cooler	Perlick	BBS60**R	5.5	-	1/4	120	1	60	X	-	X	5-15P	12 (E25), (E25.1), (E25.2)
26	1	24" Dry Backbar Cabinet	Perlick	DB24	-	-	-	-	-	-	-	-	-	-	-
27	1	24" Right Corner Drainboard	Perlick	TS2ARC	-	-	-	-	-	-	-	-	-	-	-
28	2	36" Dish Underbar Speed Rail	Perlick	SR-6L36	-	-	-	-	-	-	-	-	-	-	-
29	2	Underbar Ice Chest	Perlick	TS30IC-EC10	-	-	-	-	-	-	-	-	-	-	-
30	2	6" Underbar Ice Chest Accessory	Perlick	TS6U2	-	-	-	-	-	-	-	-	-	-	-
31	1	18" Underbar Liquor Display	Perlick	TS18LS	-	-	-	-	-	-	-	-	-	-	-
32	1	60" Underbar Sink	Perlick	TS63C	-	-	-	-	-	-	-	-	-	-	-
33	1	12" Underbar Handsink	Perlick	TS12HSN	-	-	-	-	-	-	-	-	-	-	-
34	1	24" Left Corner Drainboard	Perlick	TS24LC	-	-	-	-	-	-	-	-	-	-	-

SPECIFIC NOTES:
1 A 125VAC, 15- OR 20 AMPERE RATED RECEPTACLE TO BE LOCATED WITHIN 25' OF HVAC EQUIPMENT AT SAME LEVEL FOR MAINTENANCE PURPOSED AS PER NEC 2011.

ALL STAR ELECTRIC
PROJECT RECORD
12/17

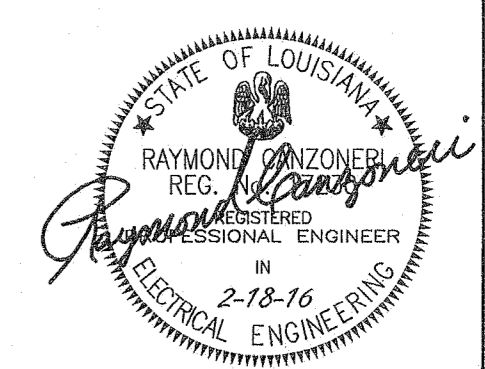

PROJECT:
PROPOSED RENOVATIONS TO 301 ROYAL ST.
CREOLE CUISINE RESTAURANT CONCEPTS

Moynan Consulting, LLC
Foodservice Facility Design & Planning
101 Kramer Ct. Mandeville, Louisiana 70471
Phone/FAX: (985) 674-5710
Cell: (985) 264-6121
www.moynanconsulting.com

DATE:
3/23/15
SCALE:
AS NOTED
SHEET:
E3