

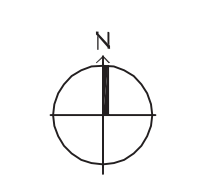



FILE NAME: J:\18231\18231.dwg - 18231.dwg  
 PROJECT: 18231 - 18231.dwg  
 DATE: 01-11-2021  
 TIME: 10:00:00 AM  
 USER: brian.mitchell  
 PLOT DATE: 01-11-2021  
 PLOT TIME: 10:00:00 AM  
 PLOT USER: brian.mitchell

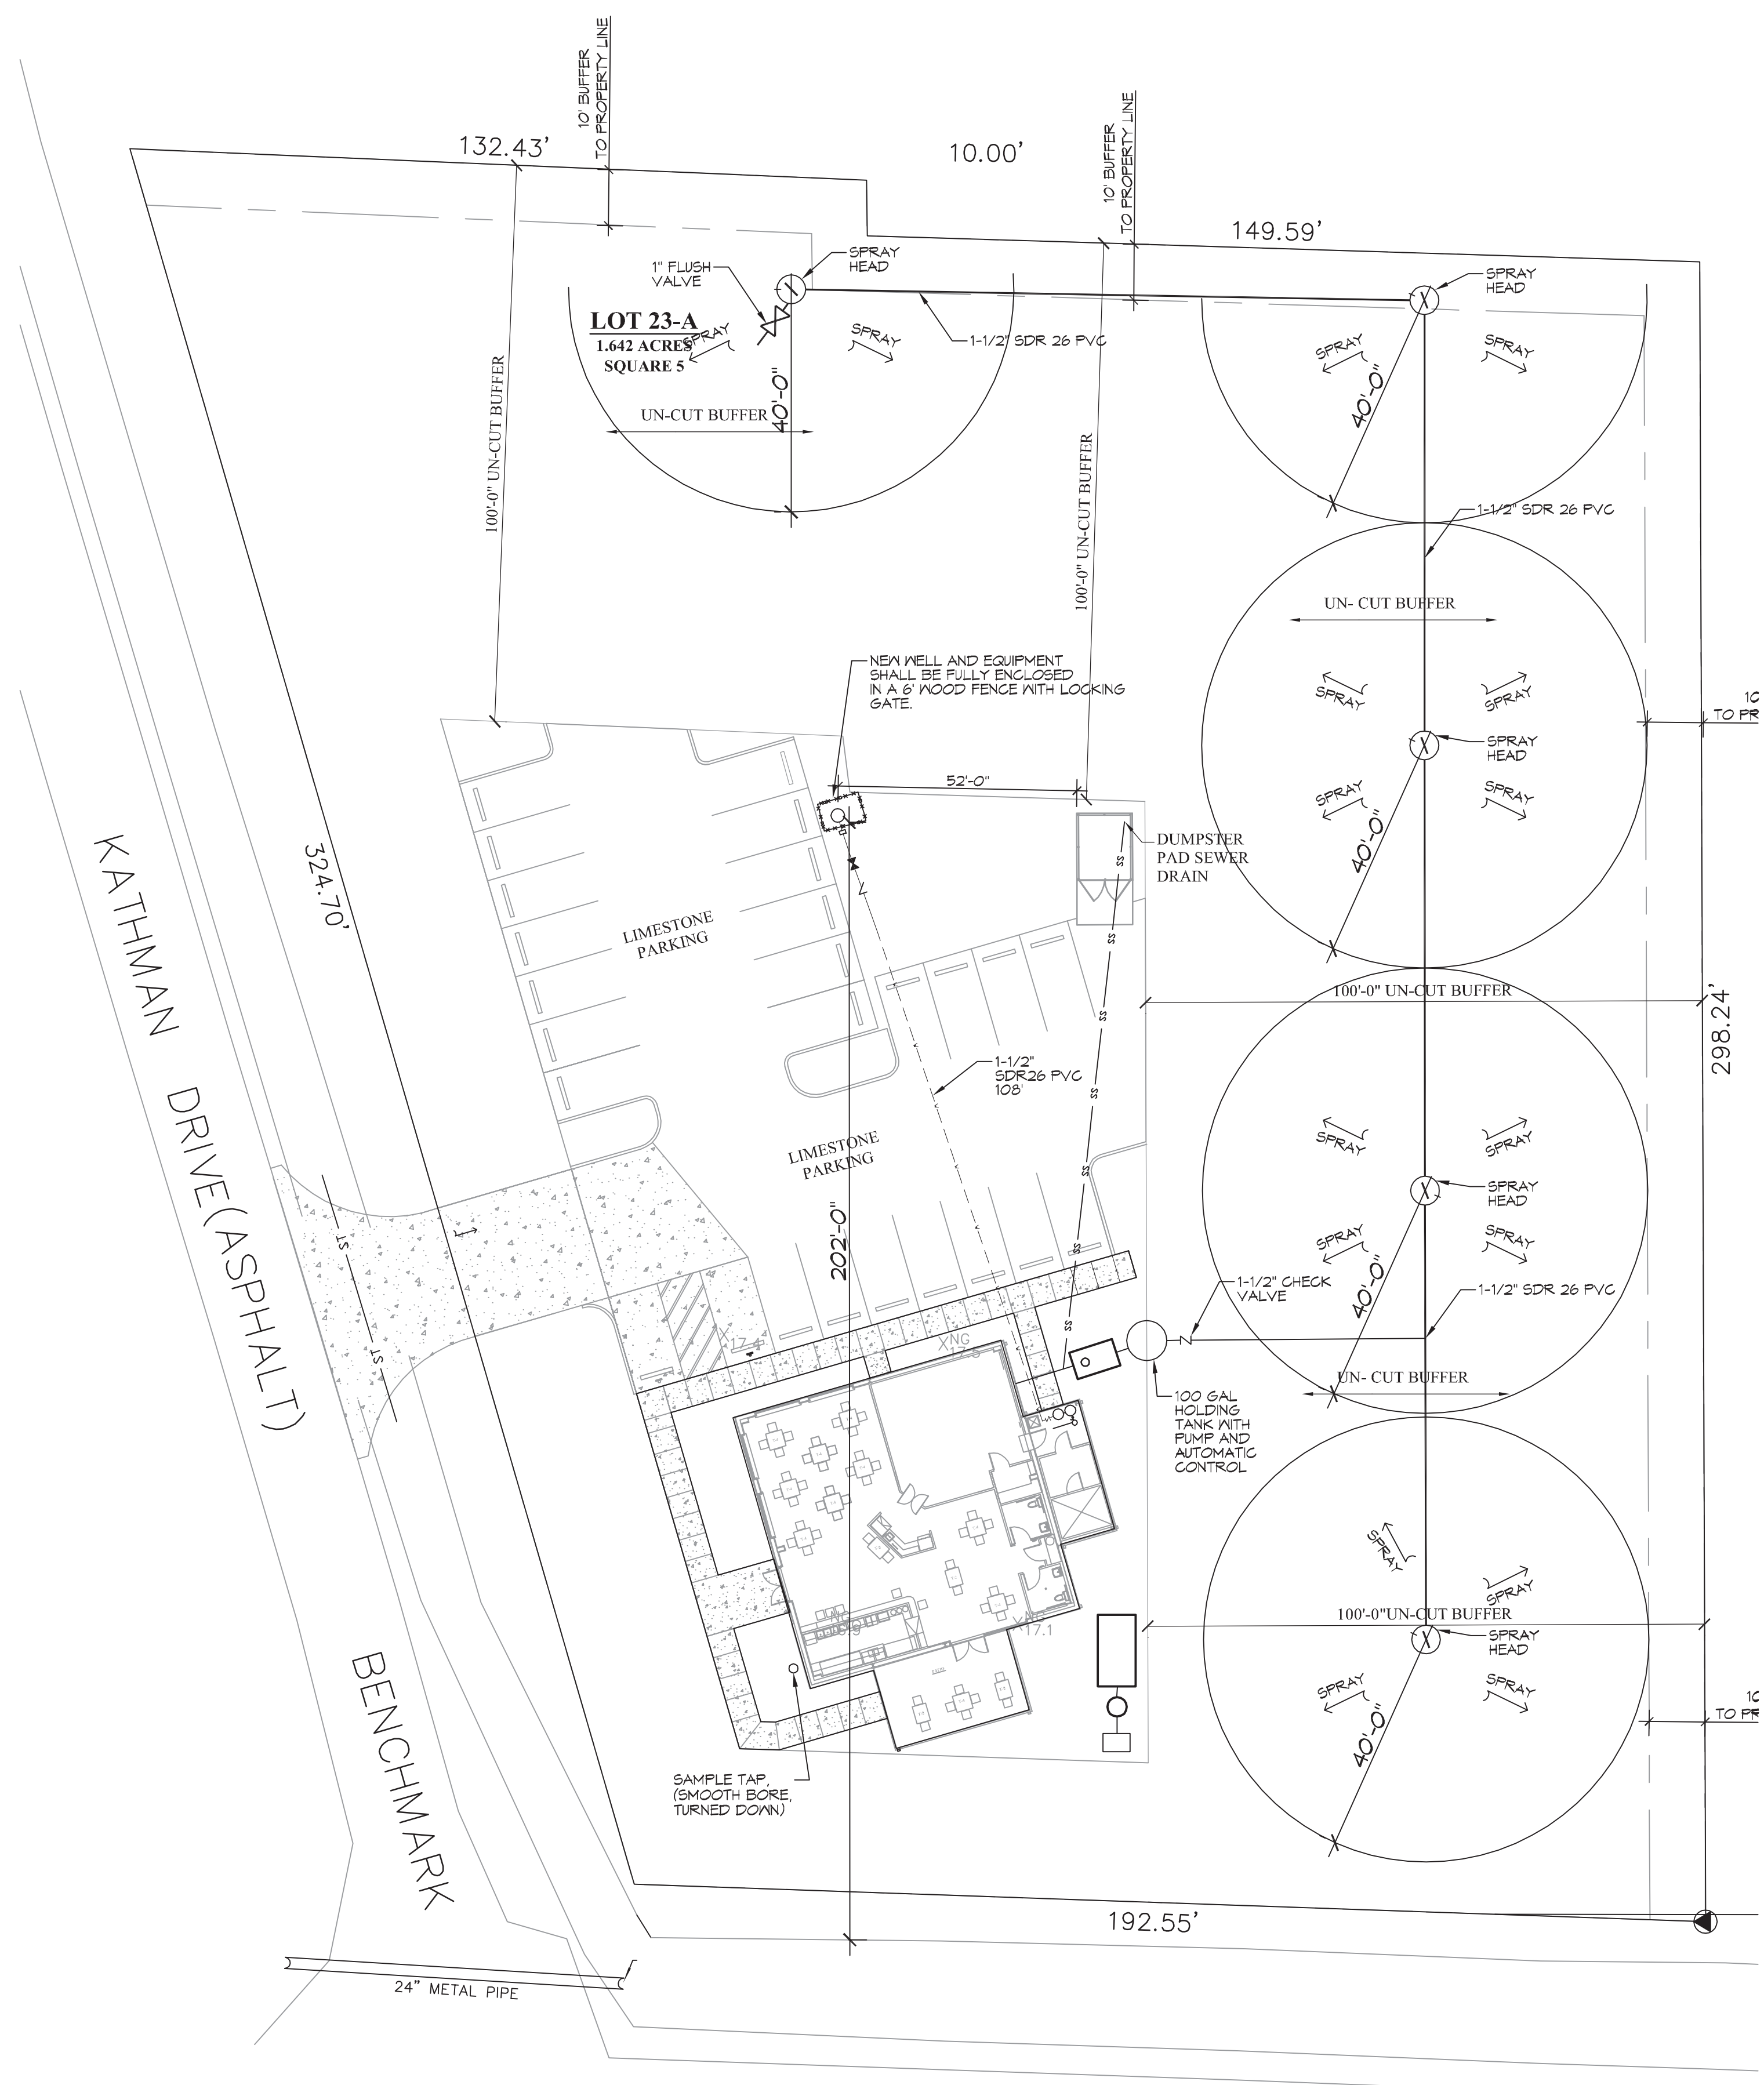


**SPRAY IRRIGATION FIELD (5 SPRAY HEADS) SITE PLAN**  
 SCALE: 1" = 20'-0"

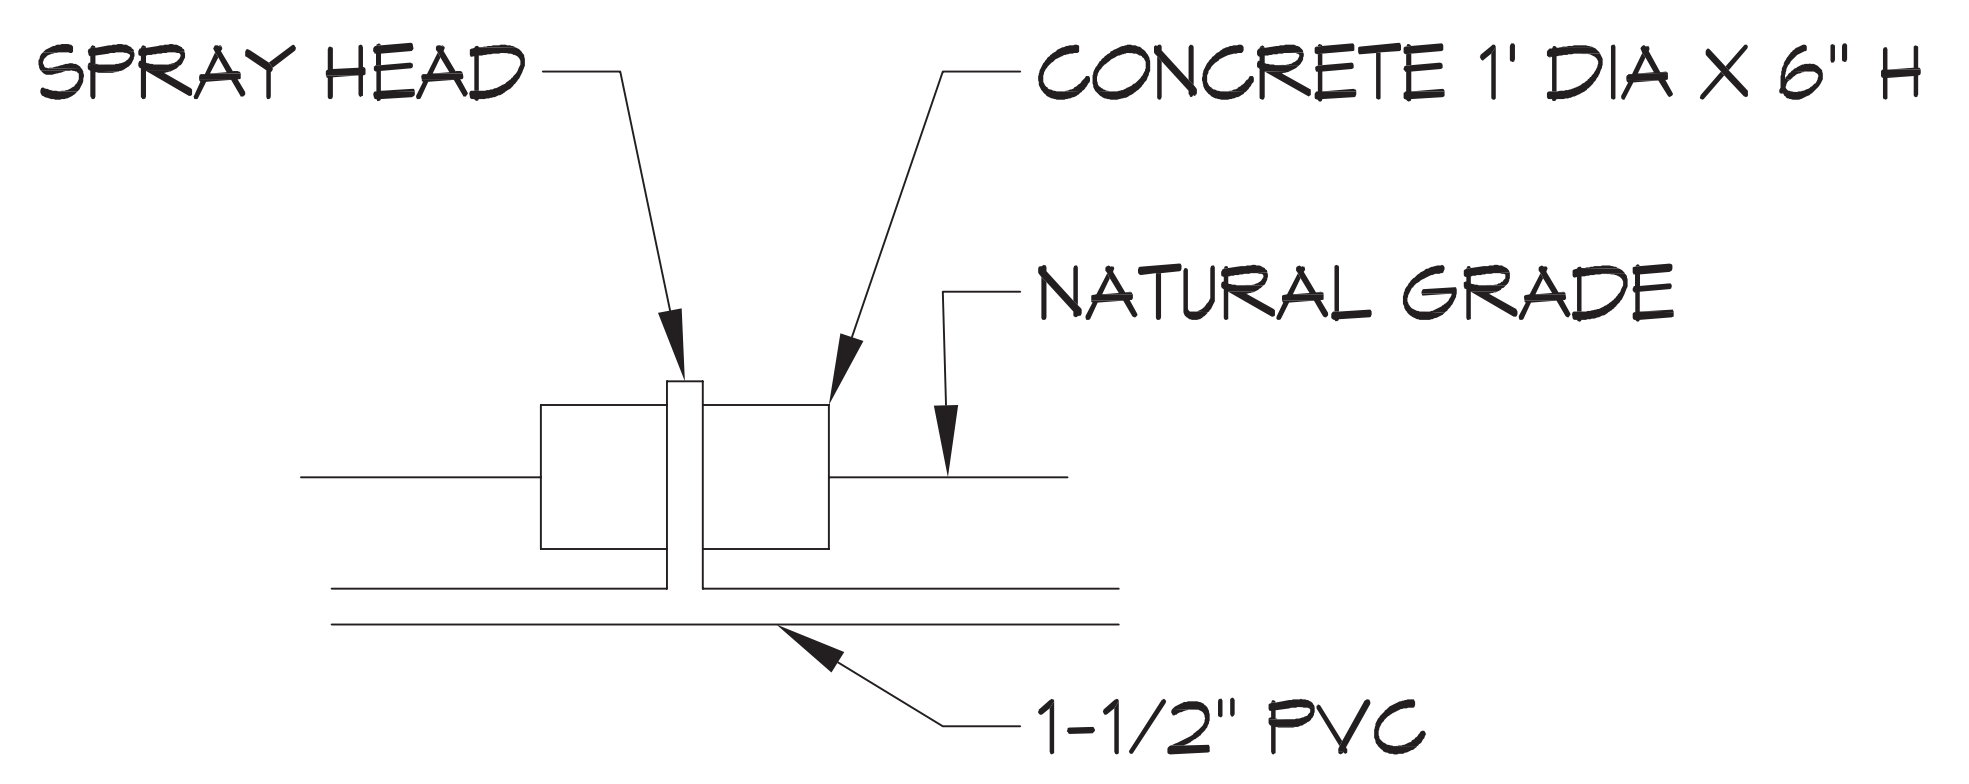

**SPRAY HEAD SUPPORT DETAIL**  
 SCALE: 1" = 20'-0"

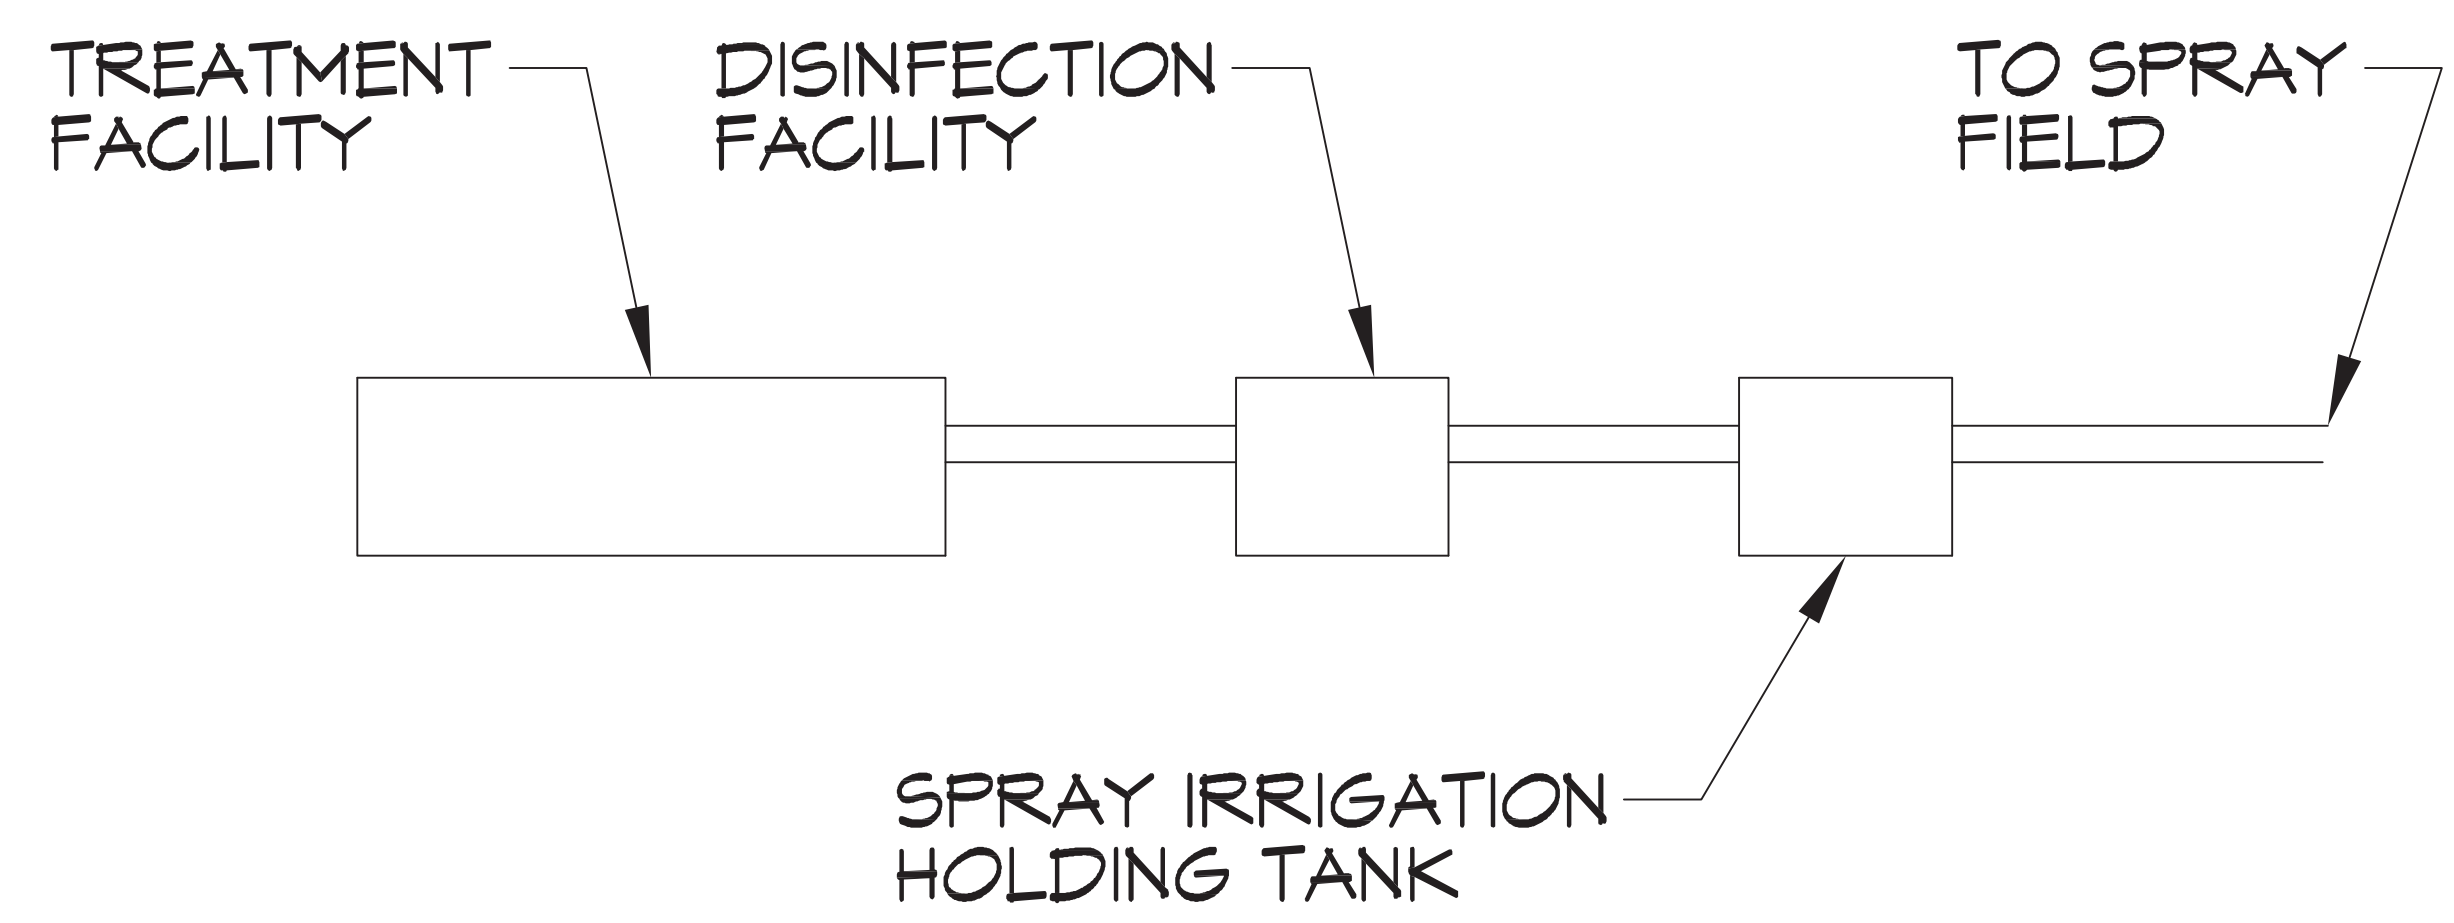

**SPRAY HEAD HOLDING FACILITY**  
 SCALE: 1" = 20'-0"

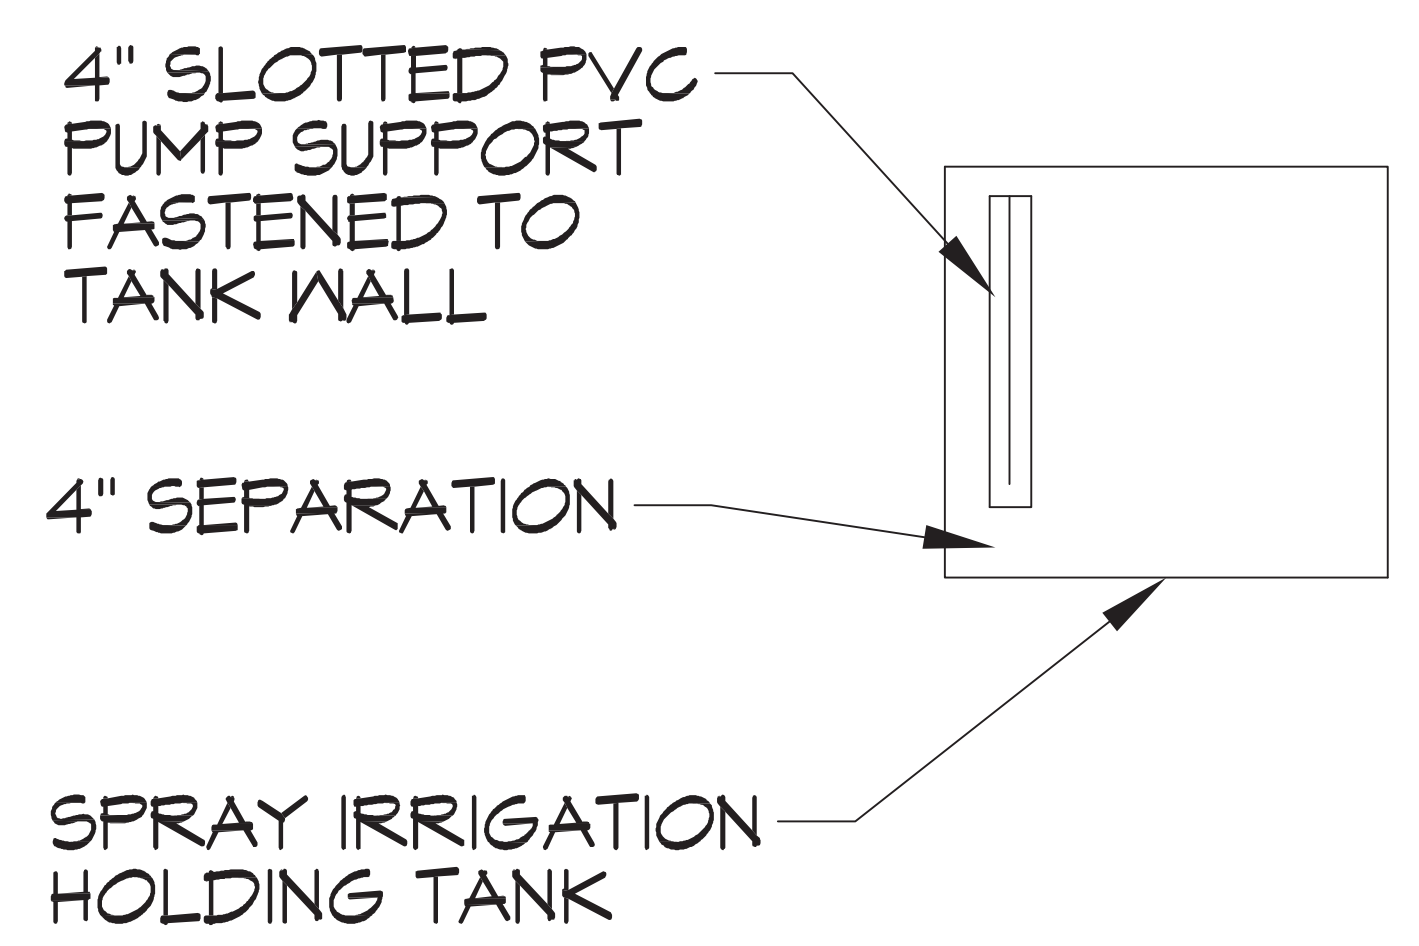

**SPRAY IRRIGATION HOLDING TANK PUMP SUPPORT**  
 SCALE: 1" = 20'-0"

**DAMMON ENGINEERING, INC.**  
 LOUISIANA & MISSISSIPPI  
 www.dammonengineering.com  
 info@dammonengineering.com  
 Chief Engineer: Brian Mitchell, PE  
 554 Old Spanish Trail  
 Shreveport, LA 71208  
 PH: 781.871.8282

#	DESCRIPTION	REVISIONS	DATE
1			



**NEW RESTAURANT**  
**ABACANTO**  
**RESTAURANT**  
 1936 LA HWY. 22 WEST  
 MADISONVILLE, LA 70447  
 JOB No: 2345 DATE: 01-11-2021  
 DRAWN BY: BMM CHECKED BY: BMM

SHEET TITLE:  
 SPRAY IRRIGATION FIELD  
 SITE PLAN  
 DRAWING NUMBER:  
**SF101**  
 SHEET No: 1 of 1