




SPRAY HEAD SUPPORT DETAIL  
SCALE: 1" = 20'-0"

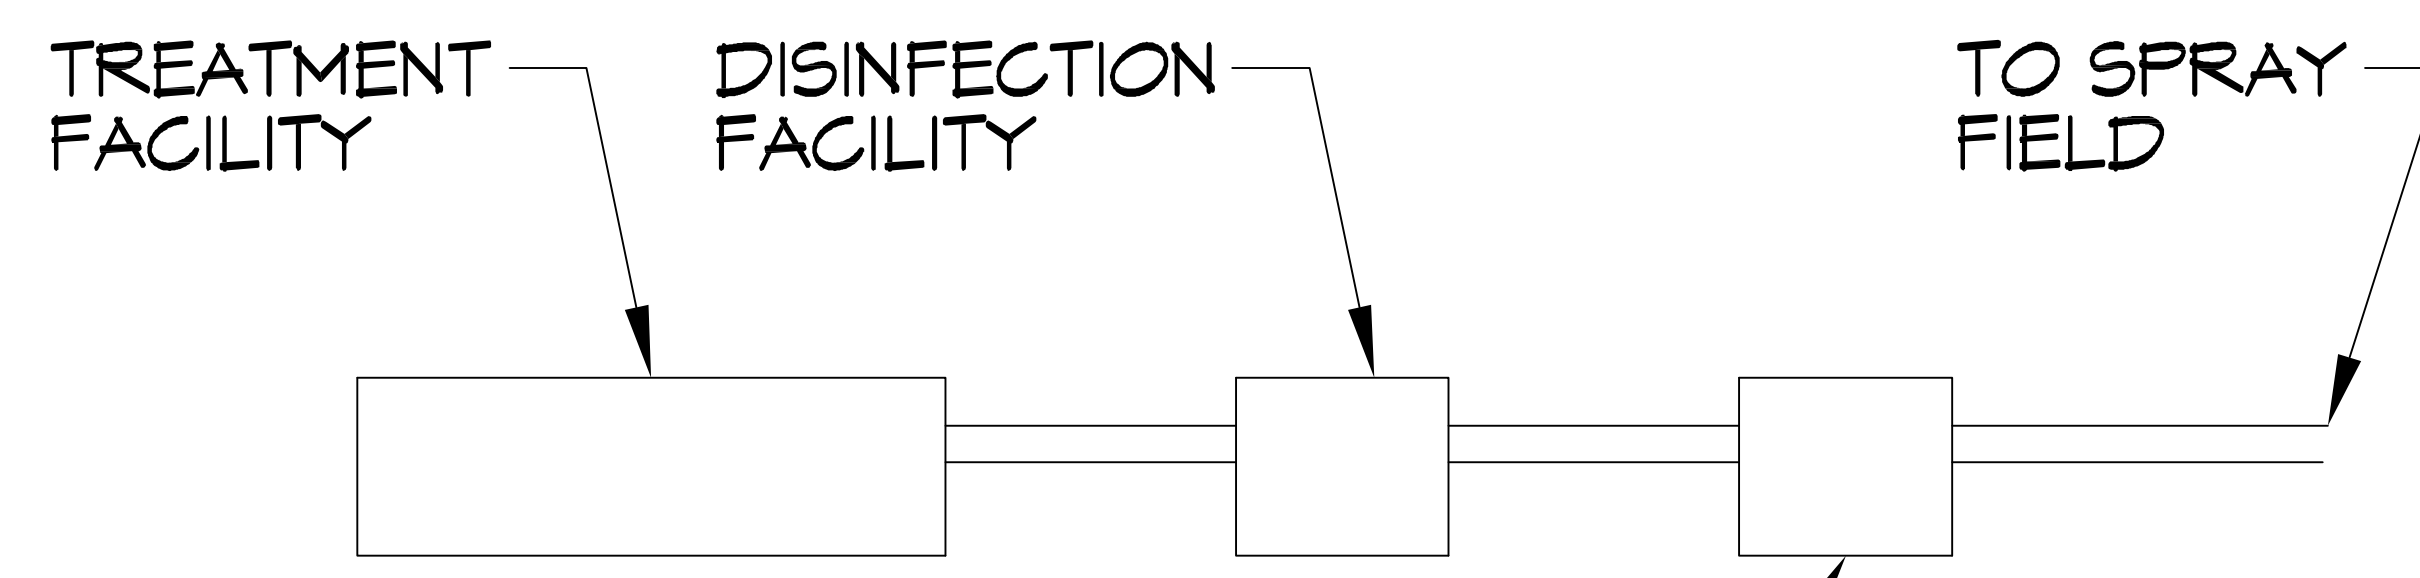

SPRAY HEAD HOLDING FACILITY  
SCALE: 1" = 20'-0"

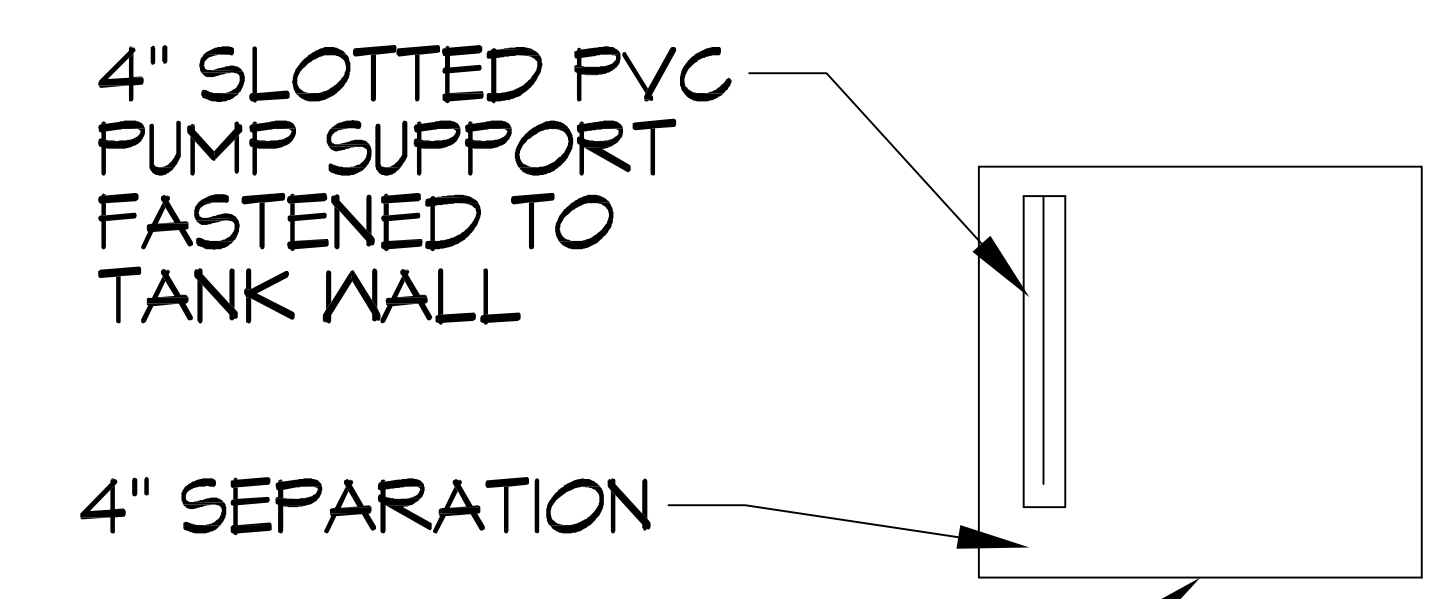

SPRAY IRRIGATION HOLDING TANK  
PUMP SUPPORT  
SCALE: 1" = 20'-0"

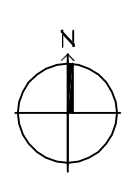

SPRAY IRRIGATION FIELD (5 SPRAY HEADS) SITE PLAN  
SCALE: 1" = 20'-0"

**DAMMON ENGINEERING, INC.**  
LOUISIANA & MISSISSIPPI  
www.dammonengineering.com  
info@dammonengineering.com  
Chief Engineer: Brian Mitchel, P.E.  
354 Old Spanish Trail  
Shreveport, LA 71208  
PH: 985.671.1828

#	DESCRIPTION	DATE
1		



NEW RESTAURANT  
**ABACAZANT**  
RESTAURANT  
1936 LA HWY. 22 WEST  
MADISONVILLE, LA 70447  
JOB No: 2345 DATE: 01-11-2021  
DRAWN BY: BMM CHECKED BY: CSD

SHEET TITLE:  
SPRAY IRRIGATION FIELD  
SITE PLAN

DRAWING NUMBER:

**SF101**