




1 SITE PLAN
SCALE: 1" = 20'-0"

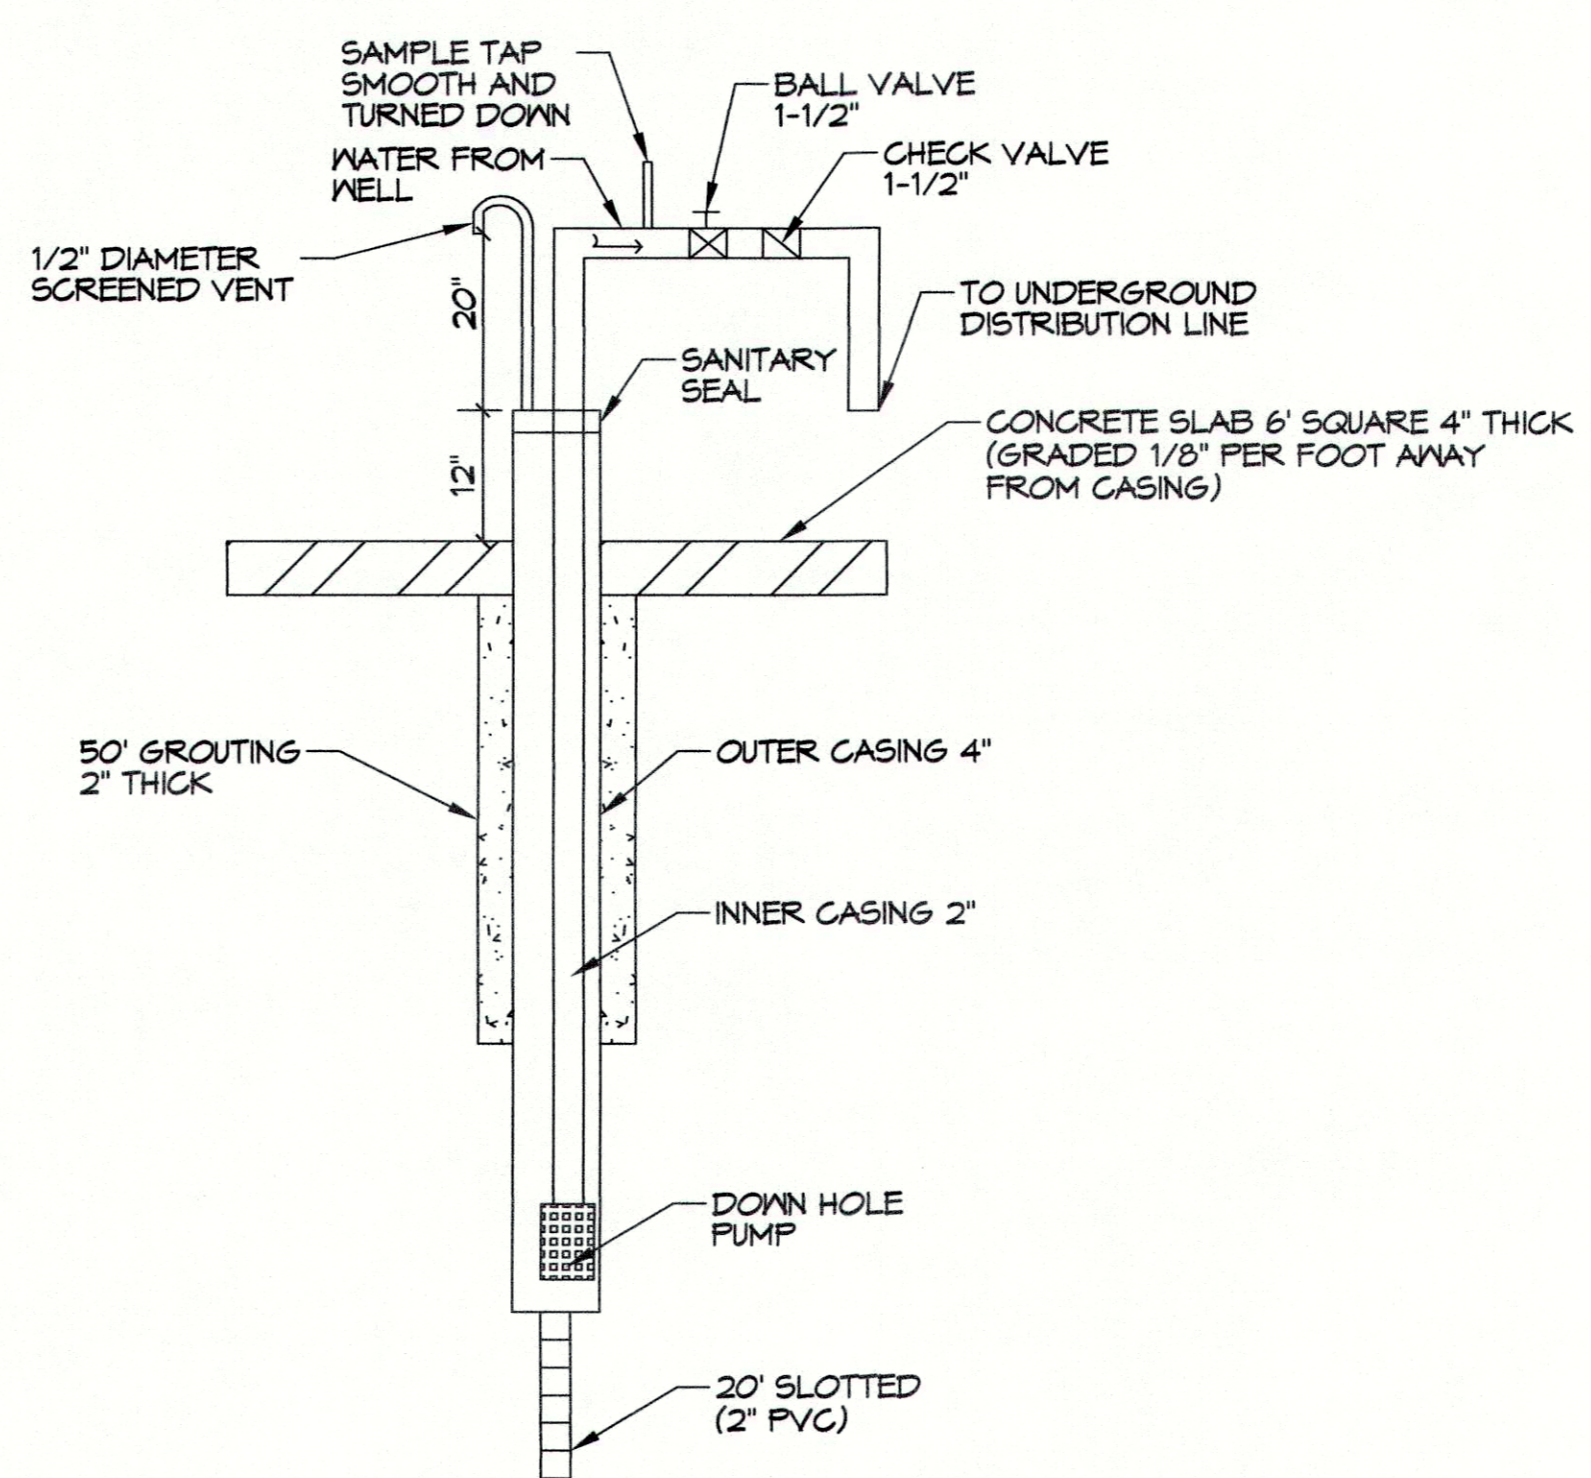

2 WELL HEAD
SCALE: N.T.S.

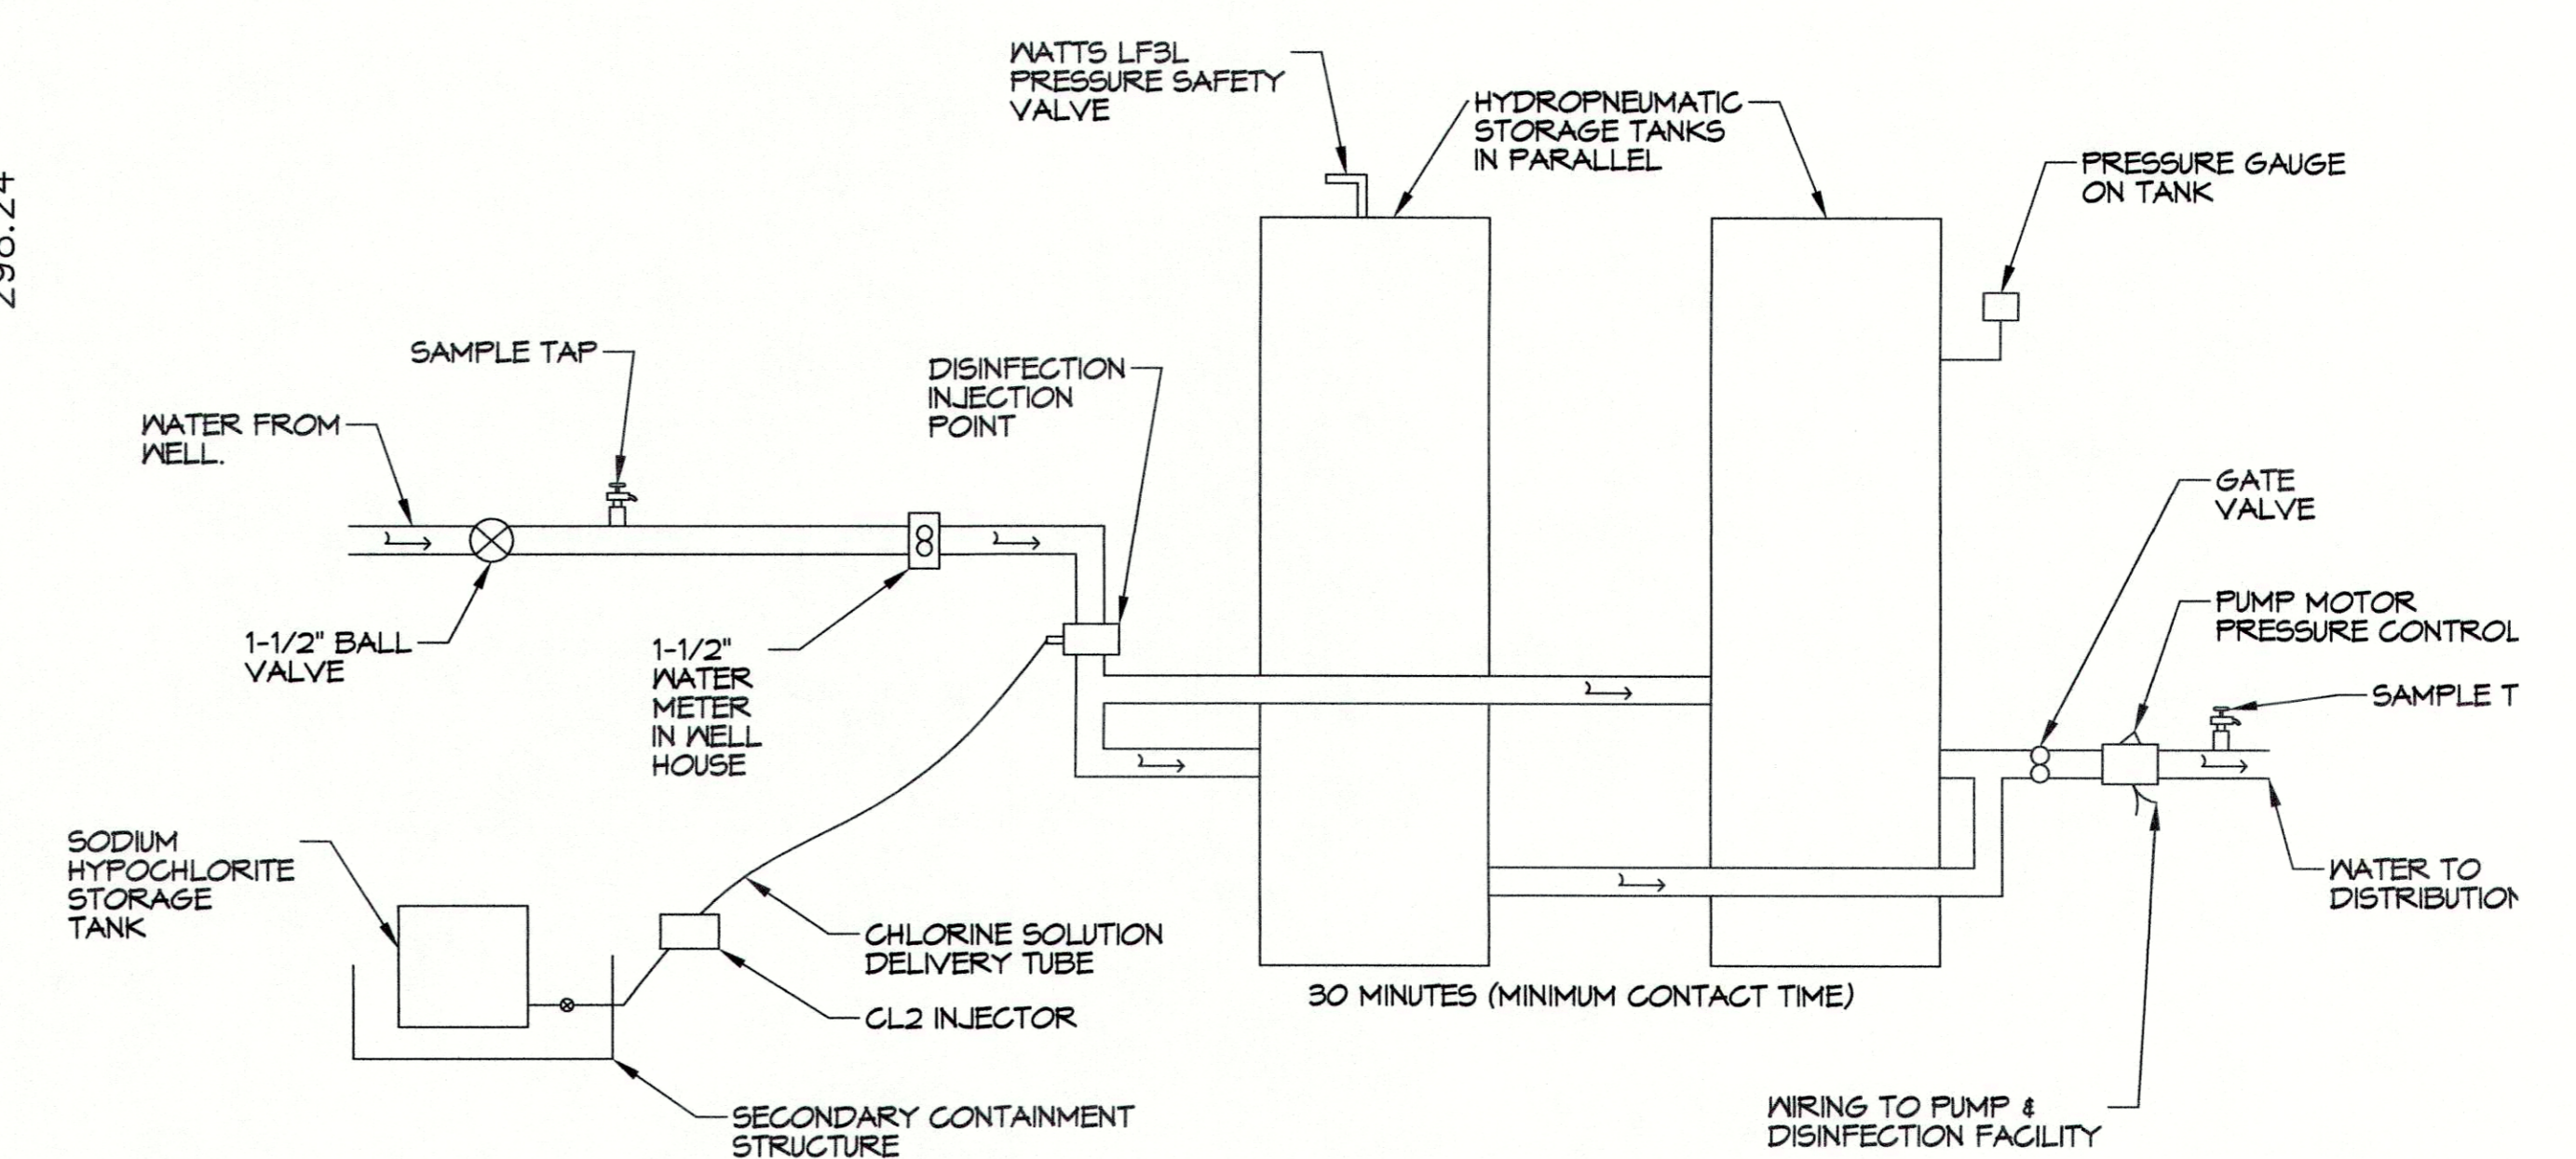

3 SMALL WATER SYSTEM CONFIGURATION
SCALE: N.T.S.

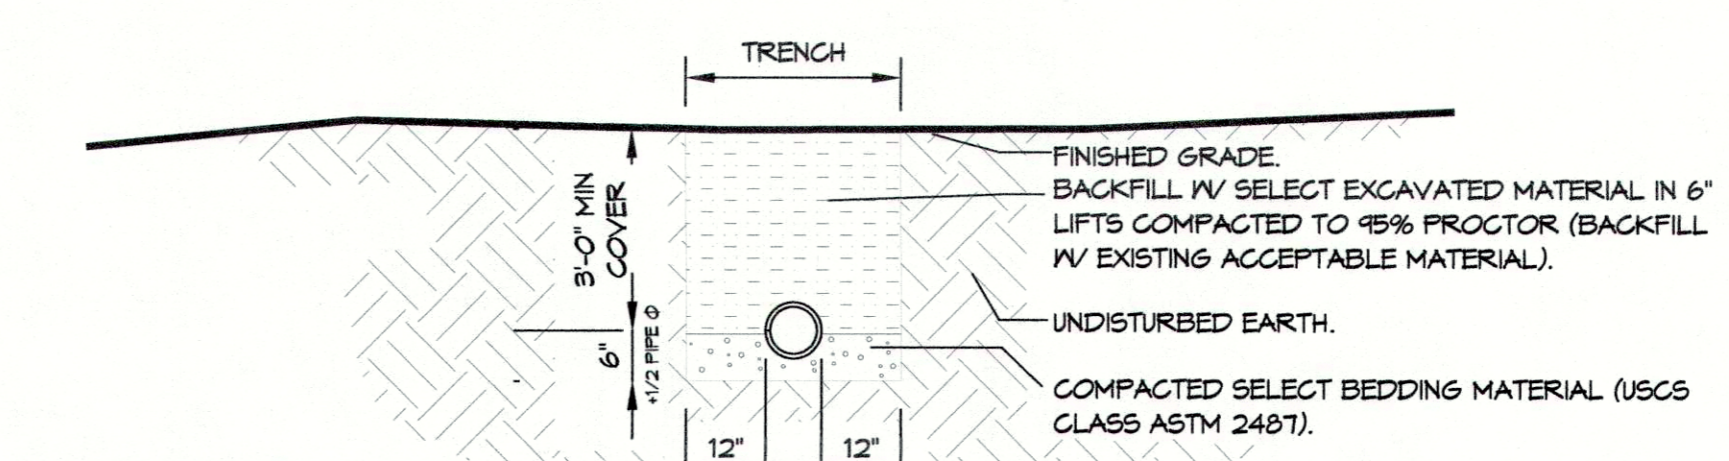

NOTE:
A MINIMUM SEPARATION OF 10' HORIZONTAL AND 18" VERTICAL IS REQUIRED BETWEEN WATER AND SEWER LINES

4 DETAIL
SCALE: N.T.S.

NOTES


- THE CONSTRUCTION AND OPERATION OF THE HABANERO'S WATER SUPPLY SHALL CONFORM TO ALL APPLICABLE PROVISIONS OF LAC TITLE 51, PART 12.
- WATER WELL SHALL BE CONSTRUCTED IN ACCORD WITH LAC TITLE 51, PART 12, PASSAGE #821, 1 THRU 12, 4 14 THRU 16.
- WATER WELL SHALL BE CONSTRUCTED IN ACCORD WITH LAC TITLE 51, PART 12, PASSAGE #824, A - D, 4, 5, 6, 4 F.
- THE DISTRIBUTION SYSTEM BE CONSTRUCTED IN ACCORD WITH LAC TITLE 51, PART 12, PASSAGE 889, A, B, 4 D.
- THE DISTRIBUTION SYSTEM SHALL BE CONSTRUCTED IN ACCORD WITH LAC TITLE 51, PART 12, PASSAGE 844 AND 851.
- DISINFECTION OF THE NEW WATER SUPPLY SHALL BE IN ACCORD WITH LAC TITLE 51, PART 12, PASSAGE 889, A, B, 4 C.
- MANDATORY DISINFECTION SHALL BE IN ACCORD WITH LAC TITLE 51, PART 12, PASSAGE 889 A 4 B.
- MINIMUM DISINFECTANT RESIDUALS SHALL BE IN ACCORD WITH LAC TITLE 51, PART 12, PASSAGE 881 A, AND 861 A.
- WATER SHALL BE PROVIDED IN ACCORD WITH LAC TITLE 51, PART 12, PASSAGE 864, A, B, D, 4 E.

PARTS LIST

CHLORINATOR	STENNER 45MHP2
WATER STORAGE	WATER SYSTEM FZ-220 (TWO)
PUMP	WATER HORSE 20WA1F4-24G20
WATER METER	DAE A8820U-180P
TABLET CHLORINATOR	NORWECO LF 1000
TREATMENT PLANT	EIBC 5.0

DAMMON ENGINEERING, INC.
LOUISIANA & MISSISSIPPI
www.dammonengineering.com
554 Old Spanish Trail
Sibley, LA 70458
PH: 985.649.5832

#	DESCRIPTION	DATE
1		

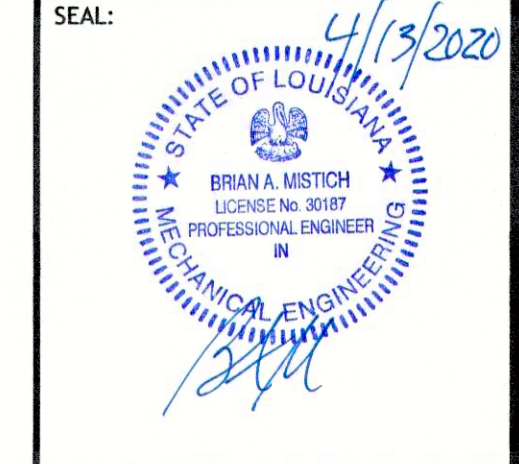

NEW RESTAURANT
HABANERO RESTAURANT
1989 LA HWY. 22 WEST
MADISONVILLE, LA 70447
JOB No: 2998 DATE: 08-16-2020
DRAWN BY: CKP CHECKED BY: BAW

SHEET TITLE:
WELL PLAN
DRAWING NUMBER:
W101
SHEET No: 2 of 2