



1 REFLECTED CEILING PLAN - FIRST FLOOR
SCALE: 1/4" = 1'-0"

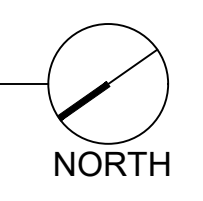


CEILING LEGEND

- F1 DECORATIVE PENDANT
- F2 MONOPOINT LUMINAIRE
- F3 DECORATIVE SCONCE
- F4 NOT USED
- F5 VANITY SCONCE
- F6 4" CAN LIGHT
- F7 6" CYLINDER
- F8 6" CAN LIGHT
- F9 2x4' TROFFER
- Supply Air Grille: RE: MECHANICAL
- Return Air Grille: RE: MECHANICAL
- Restroom Exhaust Fan: RE: MECHANICAL

NOTE: REFER TO ELECTRICAL DRAWINGS FOR LIGHTING FIXTURE SCHEDULE

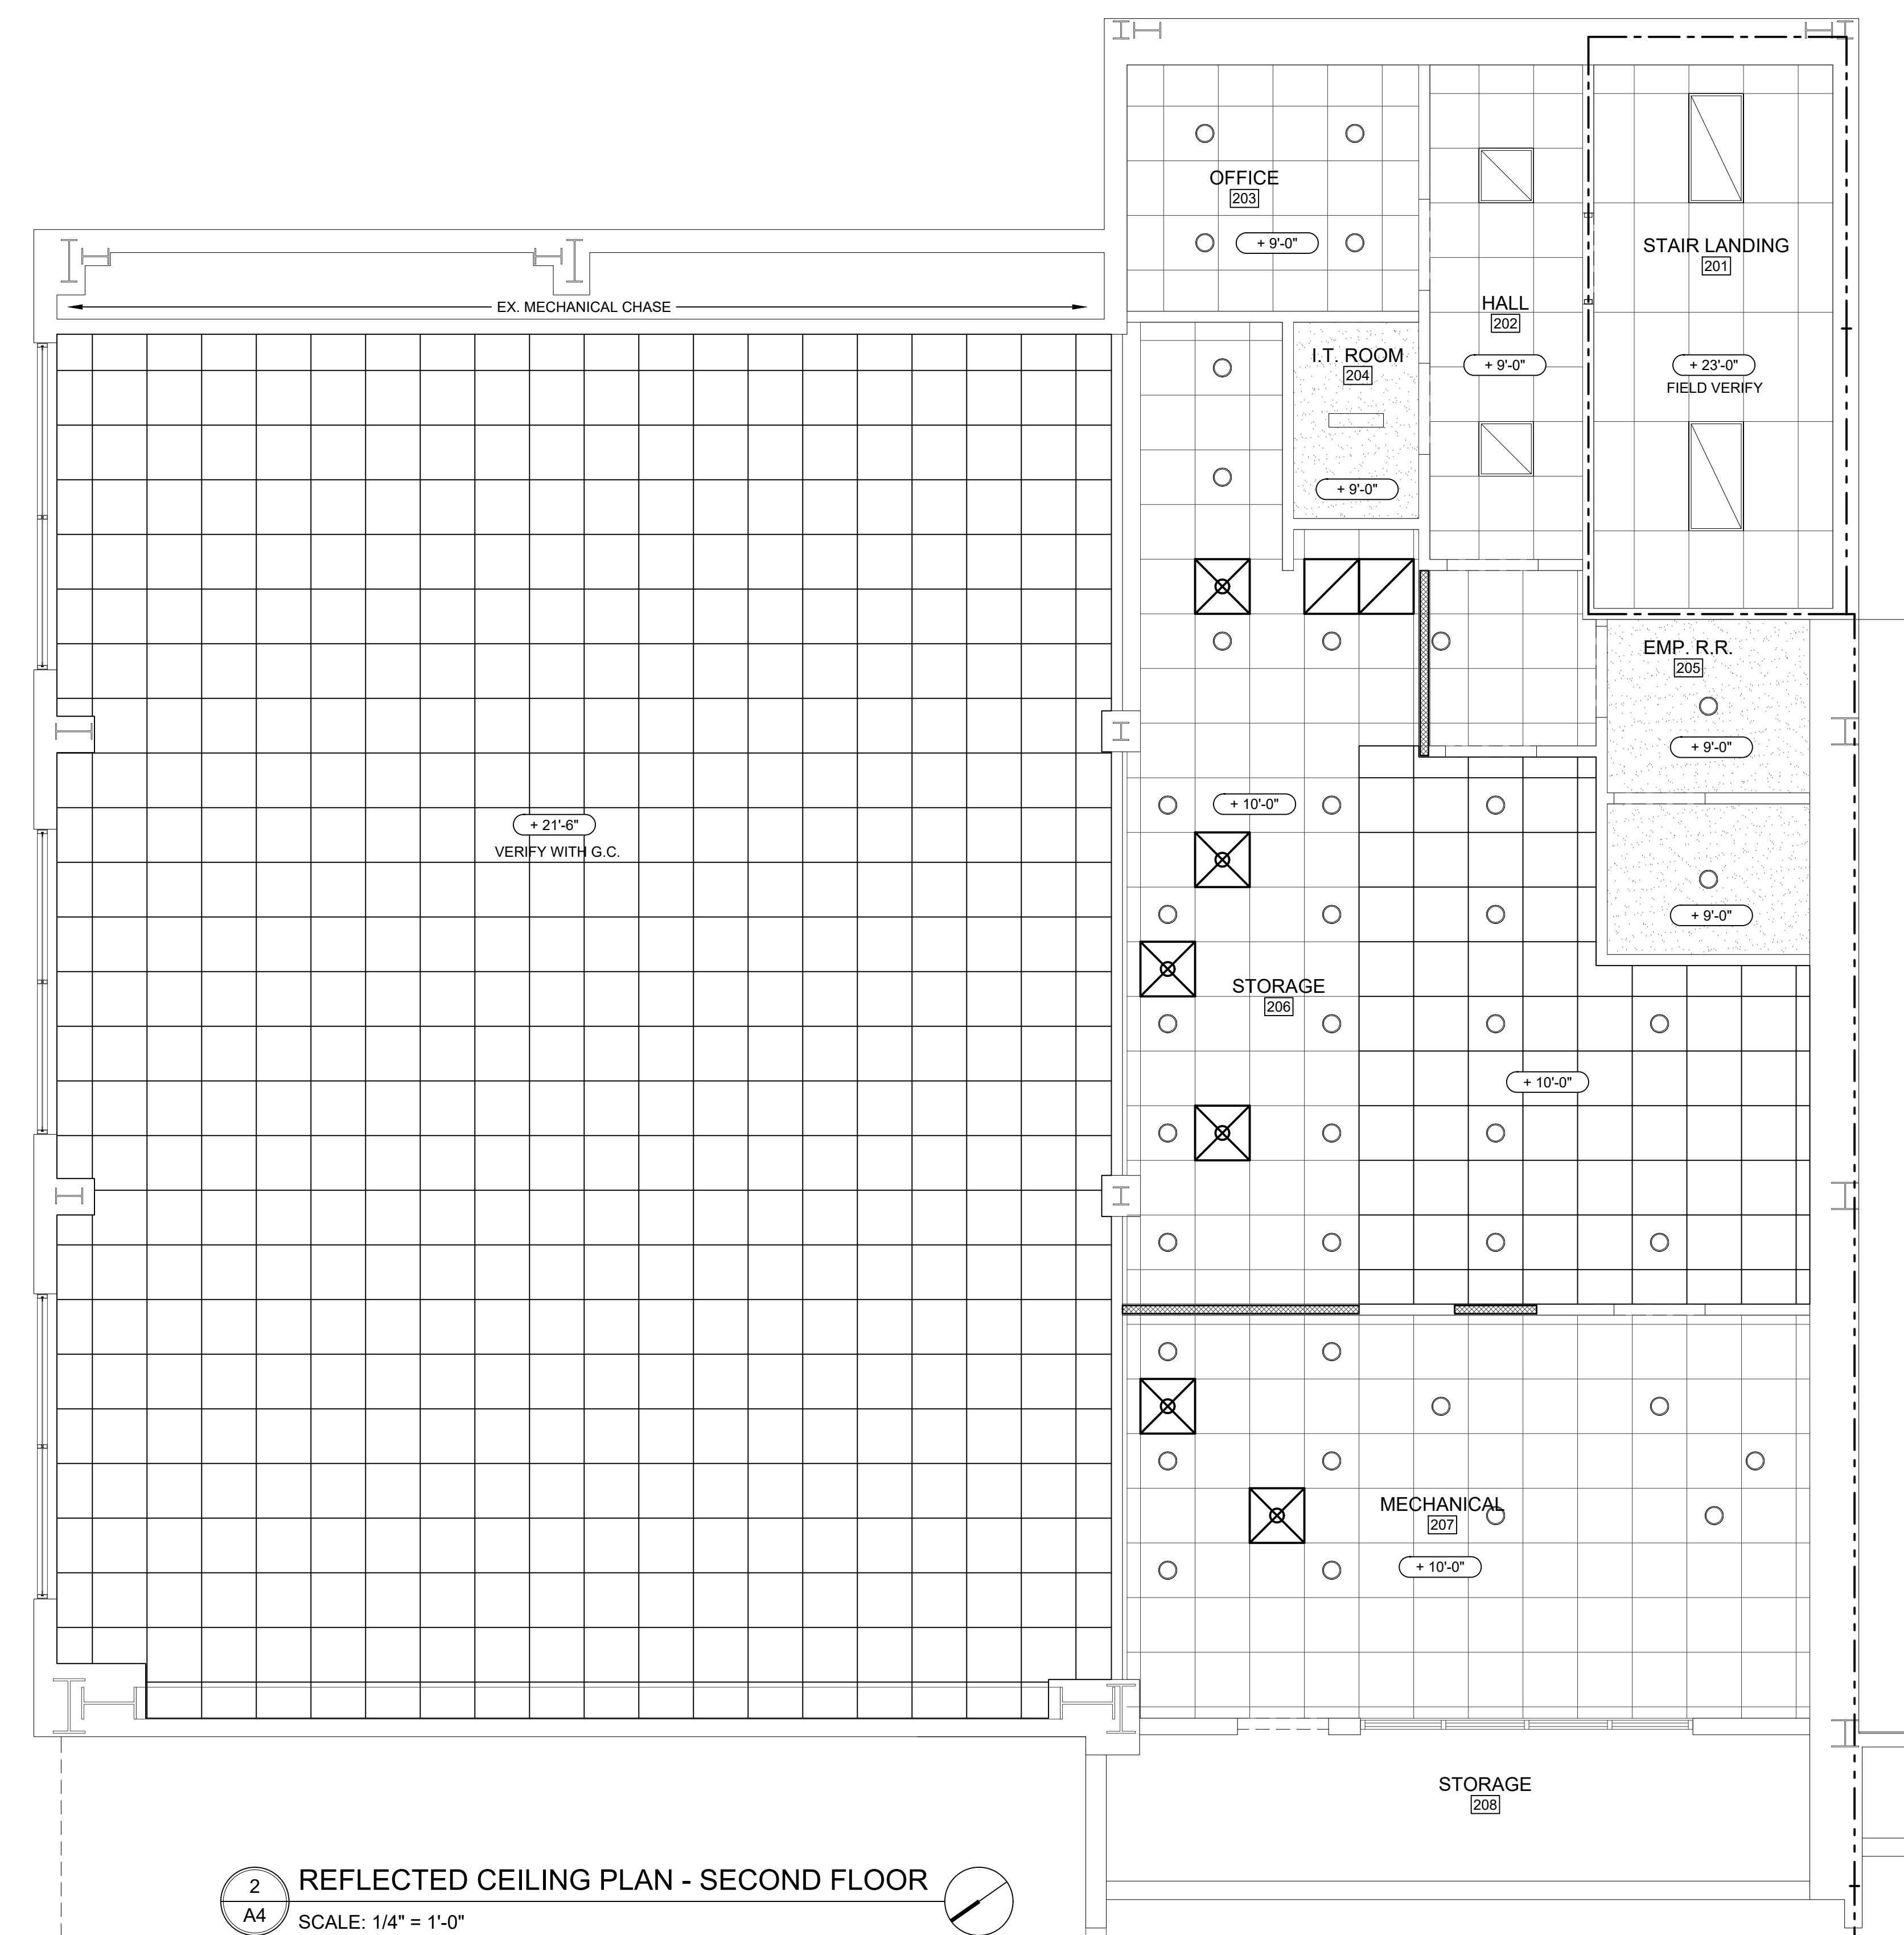

2 REFLECTED CEILING PLAN - SECOND FLOOR
SCALE: 1/4" = 1'-0"

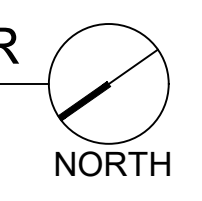

TENANT BUILDOUT DRAWINGS FOR
BOULEVARD BISTRO
70340 LA STATE HIGHWAY 21
COVINGTON, LOUISIANA 70340

ZITO • RUSSELL
ARCHITECTS, P.C.
820 S. UNIVERSITY BLVD., SUITE 202
MOBILE, AL 36609
PHONE (251) 343-9161
FAX (251) 343-5505

© COPYRIGHT 2021
ZITO - RUSSELL
ARCHITECTS, P.C.

REVISIONS

NOT FOR
PRELIMINARY
CONSTRUCTION

ZR JOB # 4124
DATE JUNE XX, 2021
SHEET

A4