


2 EXTERIOR LIGHTING DETAIL
NOT TO SCALE

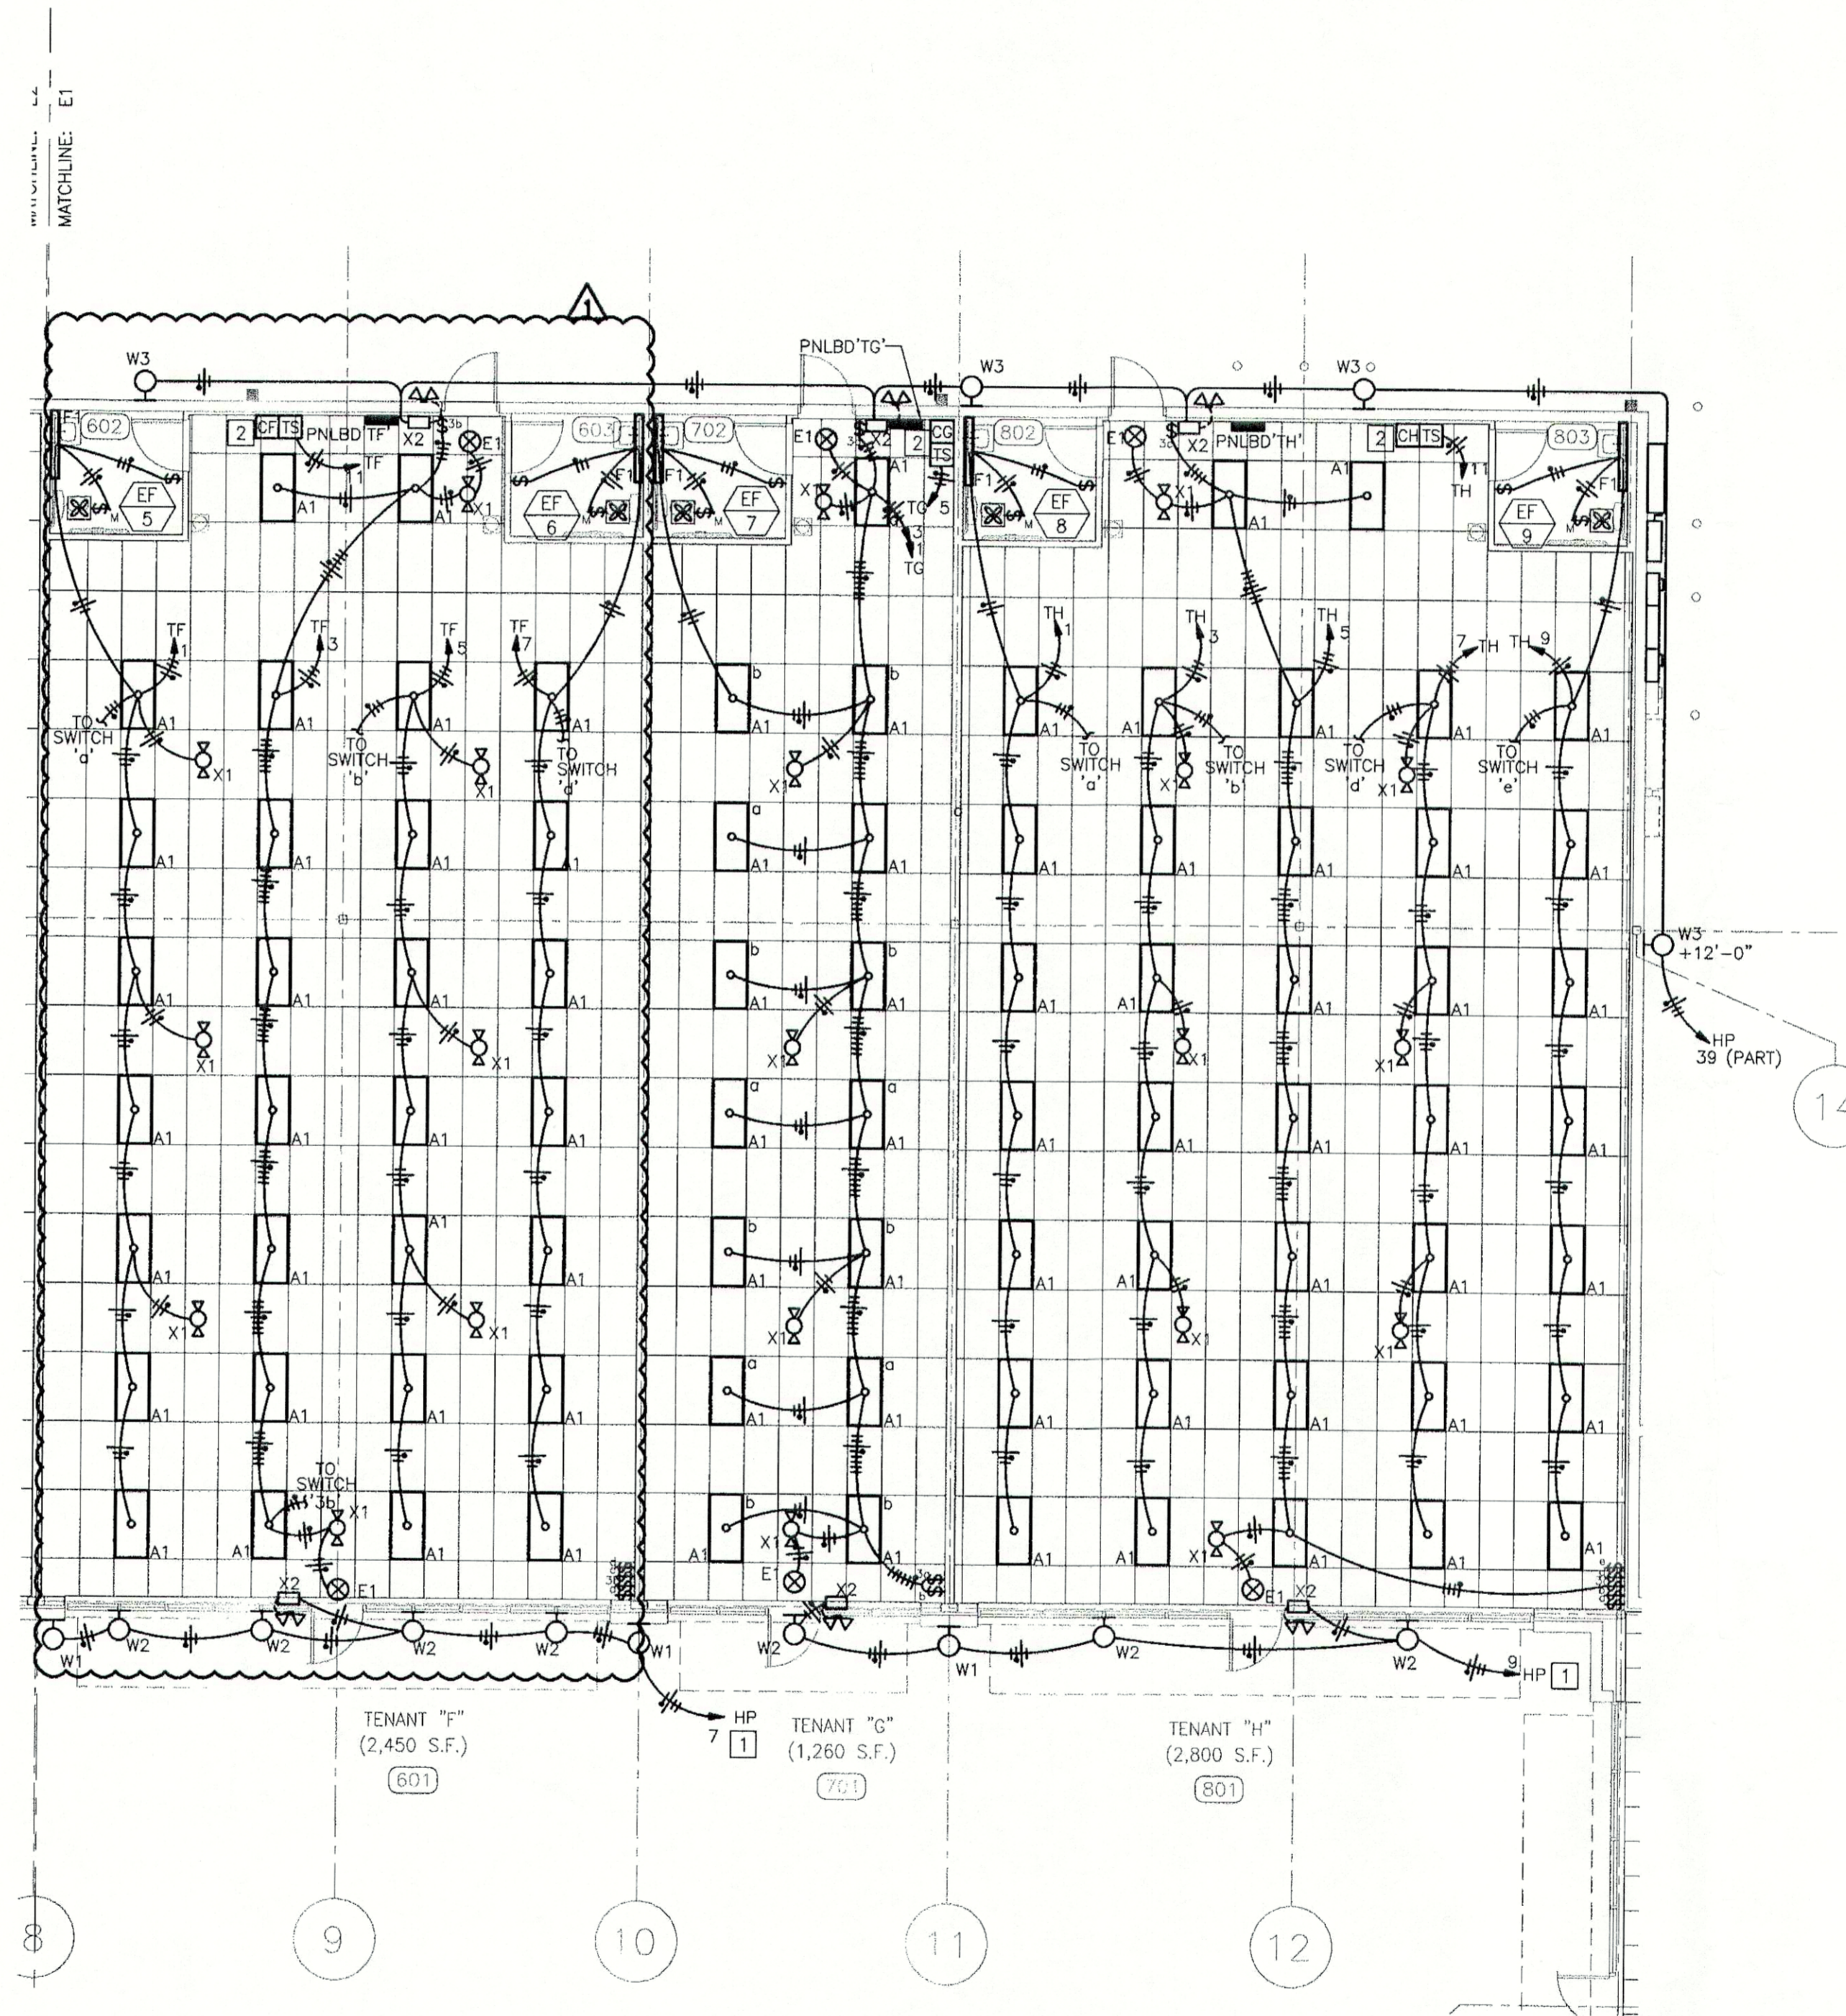

1 LIGHTING FLOOR PLAN
SCALE: 1/8"=1'-0"

GENERAL ELECTRICAL NOTES:

1. PROVIDE UNSWITCHED CONDUCTOR FOR EMERGENCY FIXTURES AND EXIT SIGNS.
2. INSTALL ALL EMERGENCY EXIT LIGHTS AND EXIT SIGNS AT 9'-0" OR JUST BELOW CEILING IN CASES WHERE CEILING IS LOWER THAN 9'-0".
3. INTERCONNECT RESTROOM FAN WITH RESTROOM LIGHT AND SWITCH.
4. PROVIDE MINIMUM OF (2)#12, (1)#12 GND. FOR ALL CIRCUITS.

ELECTRICAL PLAN NOTES:

- 1 HOMERUN CIRCUIT(S) THRU CONTACTOR CONTROLLED BY PHOTOCELL AND/OR TIME SWITCH. REFER TO CONTACTOR SCHEDULE ON SHEET ES FOR CONTROL SEQUENCE.
- 2 TIMESWITCH AND CONTACTORS FOR OVERRIDE CONTROL OF LIGHTS. REFER TO CONTACTOR SCHEDULE ON SHEET E7 AND SPECIFICATIONS FOR ADDITIONAL INFORMATION.

REVISION #1	DATE	DESCRIPTION	BY

DDG DUPLANTIS DESIGN GROUP, PC
Respect. Integrity. Client Satisfaction. Excellence.
 THIBODAUX MANDEVILLE HOUSTON
 Civil Engineering • Site Development • Land Planning • Public Works • Architecture
 314 East • 985-447-7000
 Thibodaux, Louisiana 70301

SIGNATURE: _____ DATE: _____

STAMP:

PROPOSED RETAIL DEVELOPMENT
 CITY OF BOULTE
 ST. CHARLES PARISH, LOUISIANA
 FOR THE SPECTRA GROUP, INC.
 MEMPHIS, TENNESSEE

DRAWN	FLS
CHECKED	DWL
DATE	8/13/07
SCALE	AS NOTED ON DWG
PROJECT NO.	075000106
FILE	075000106E2.DWG
SHEET	E2

HENDERSON ENGINEERS
 8525 LEXA DRIVE
 IRVING, TX 75014
 TEL 913.742.5000 FAX 913.742.5001
 www.hel-eng.com
 075000106