

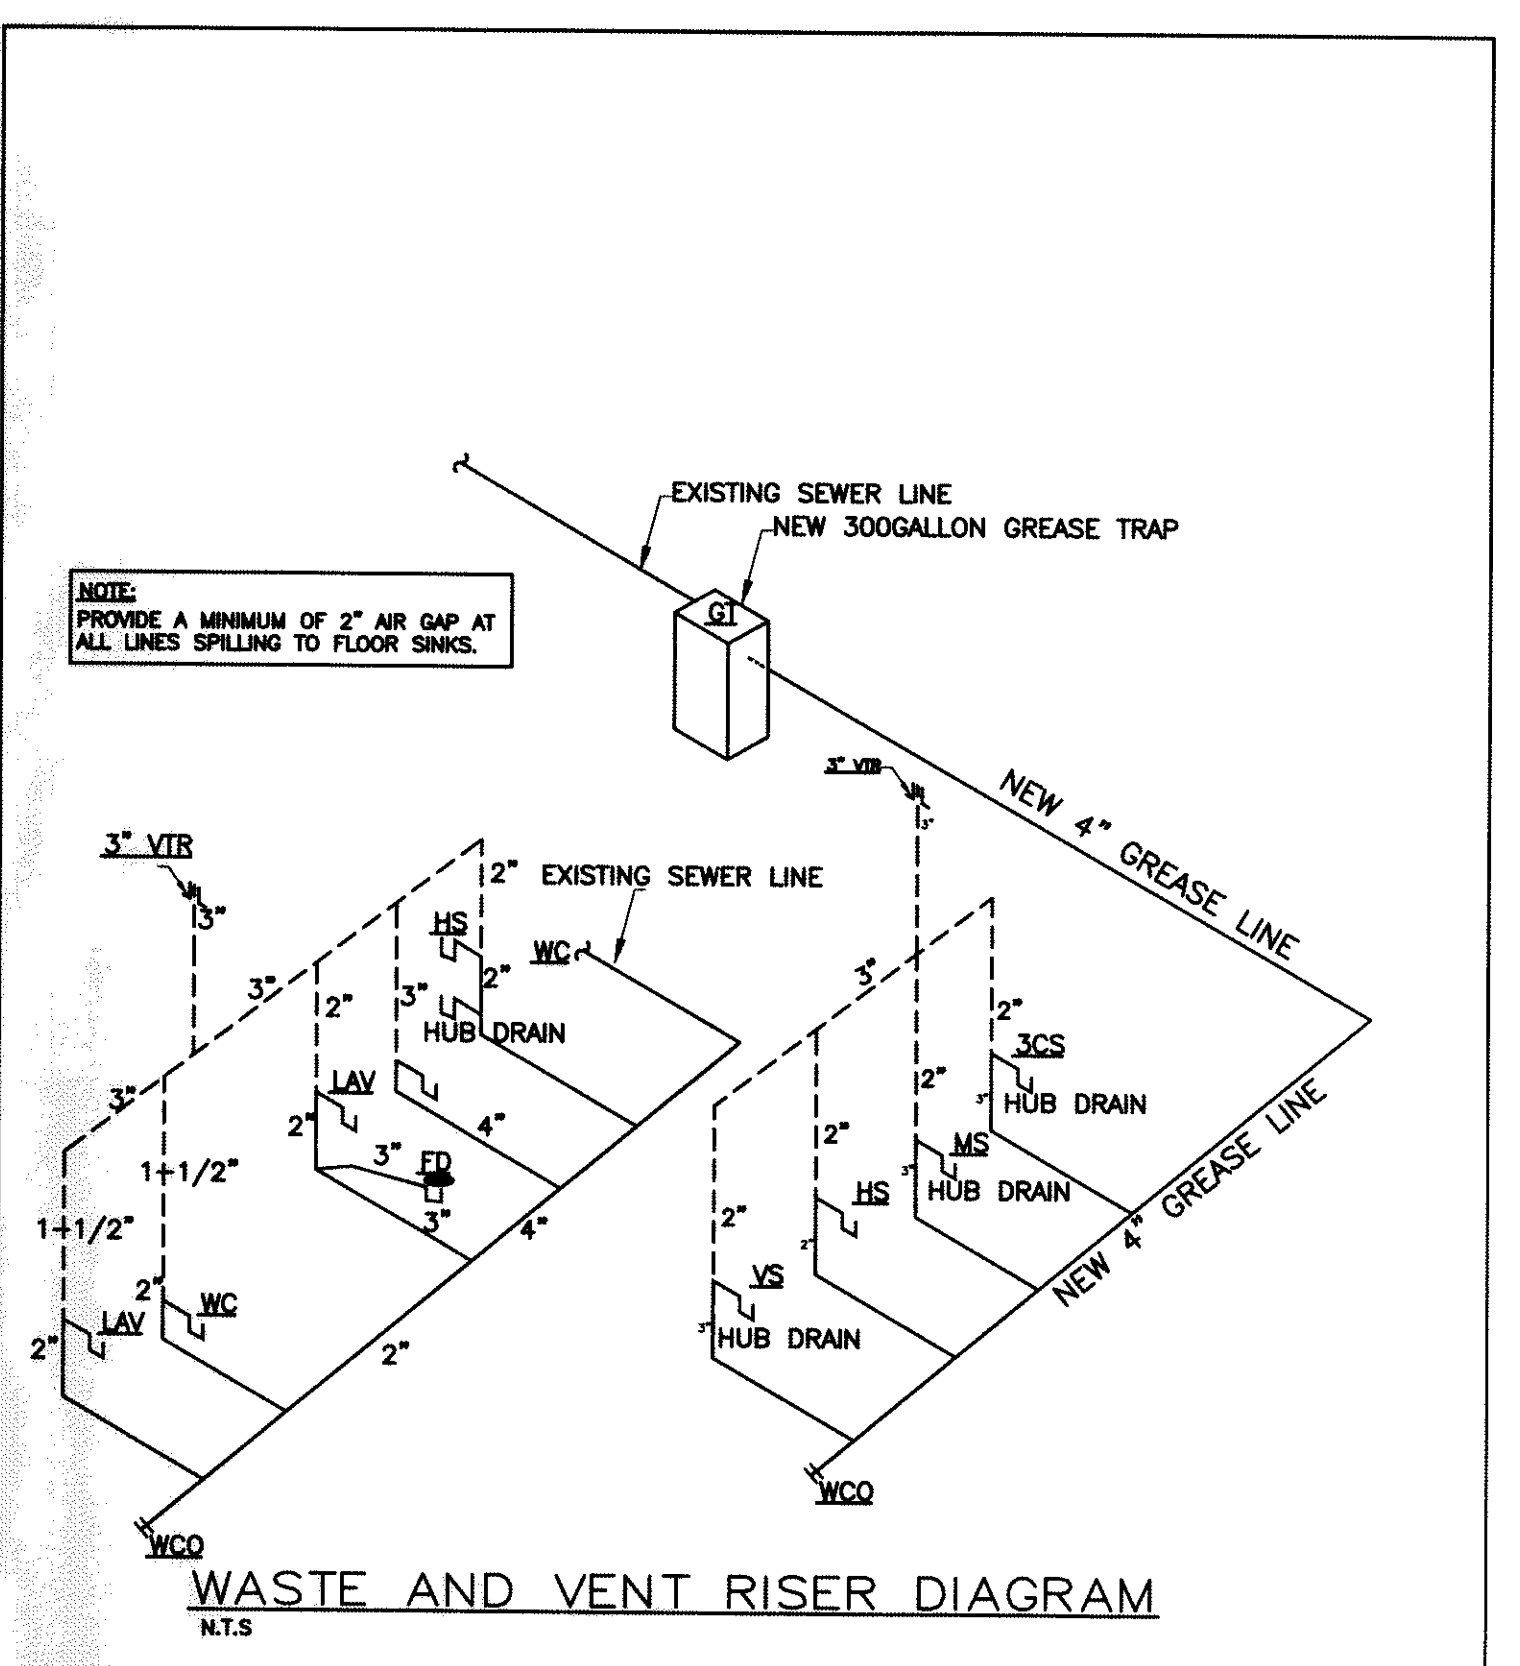
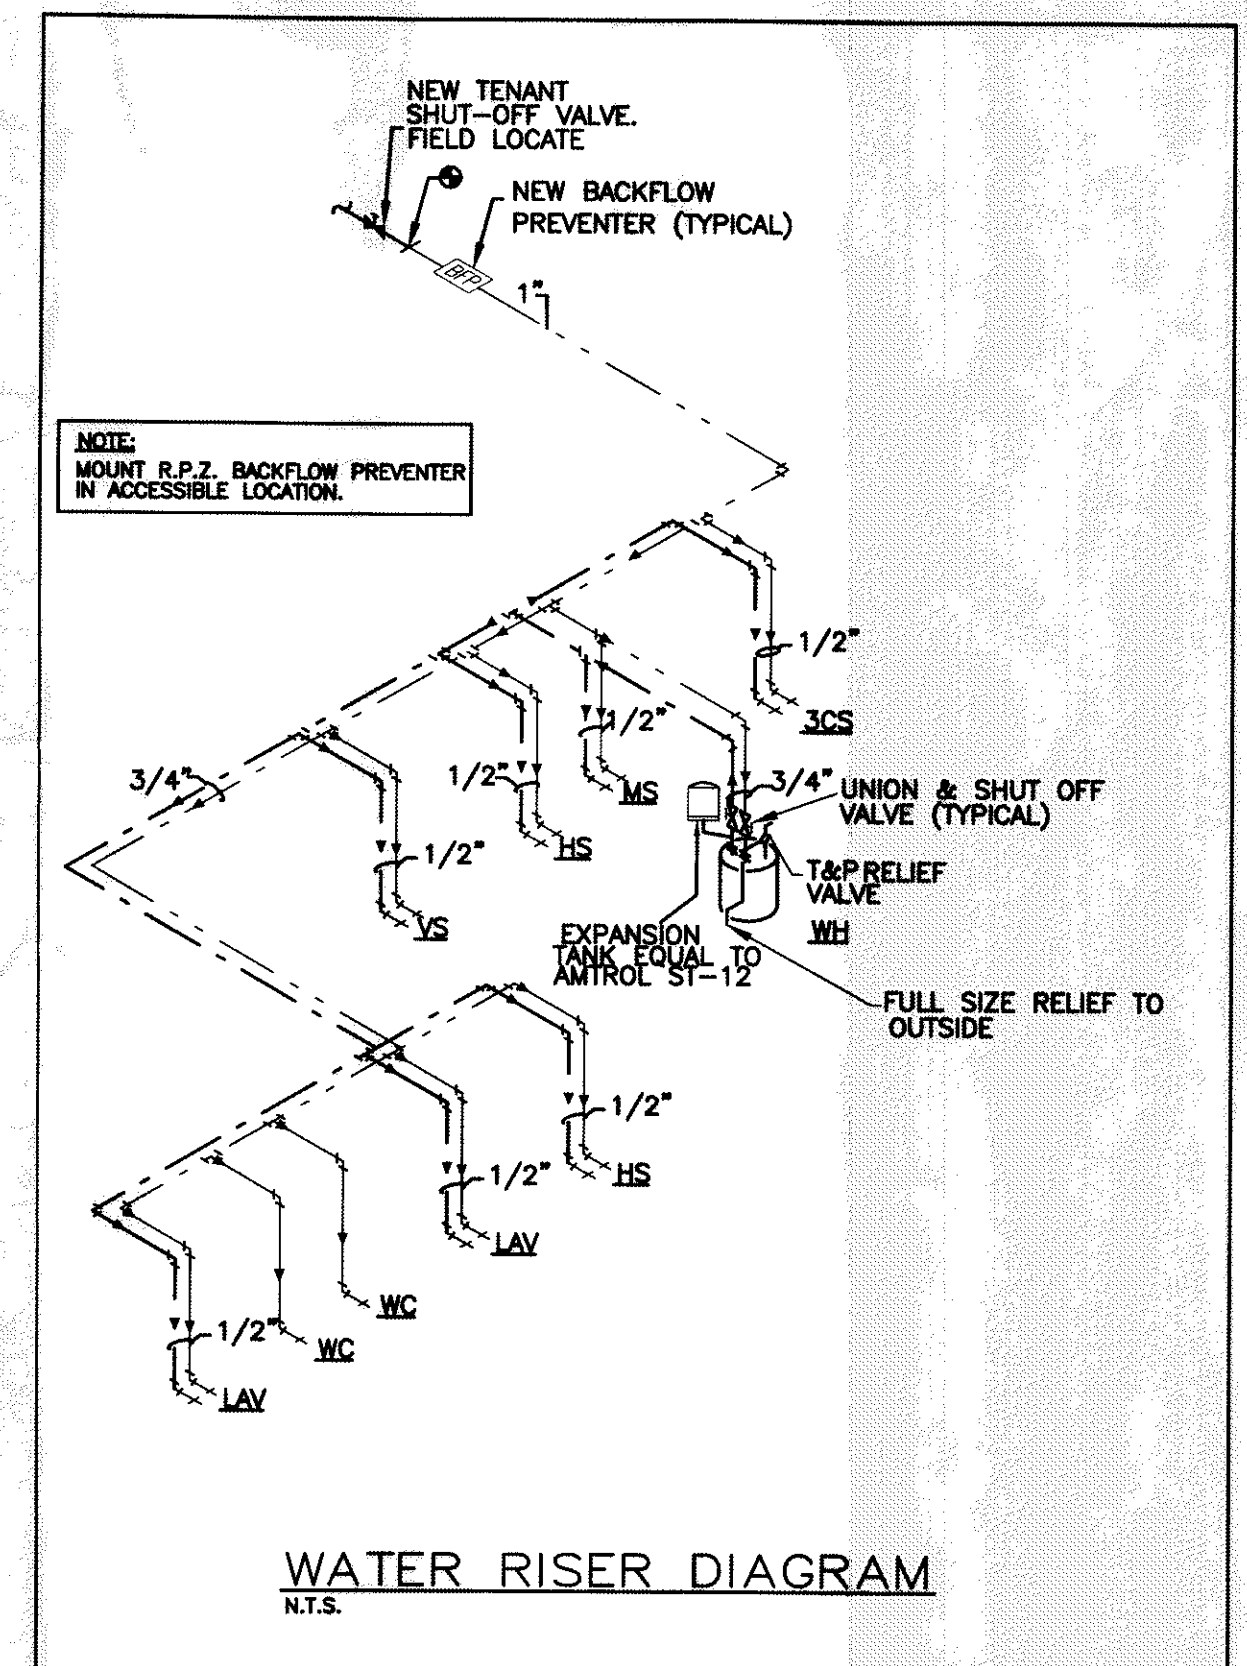
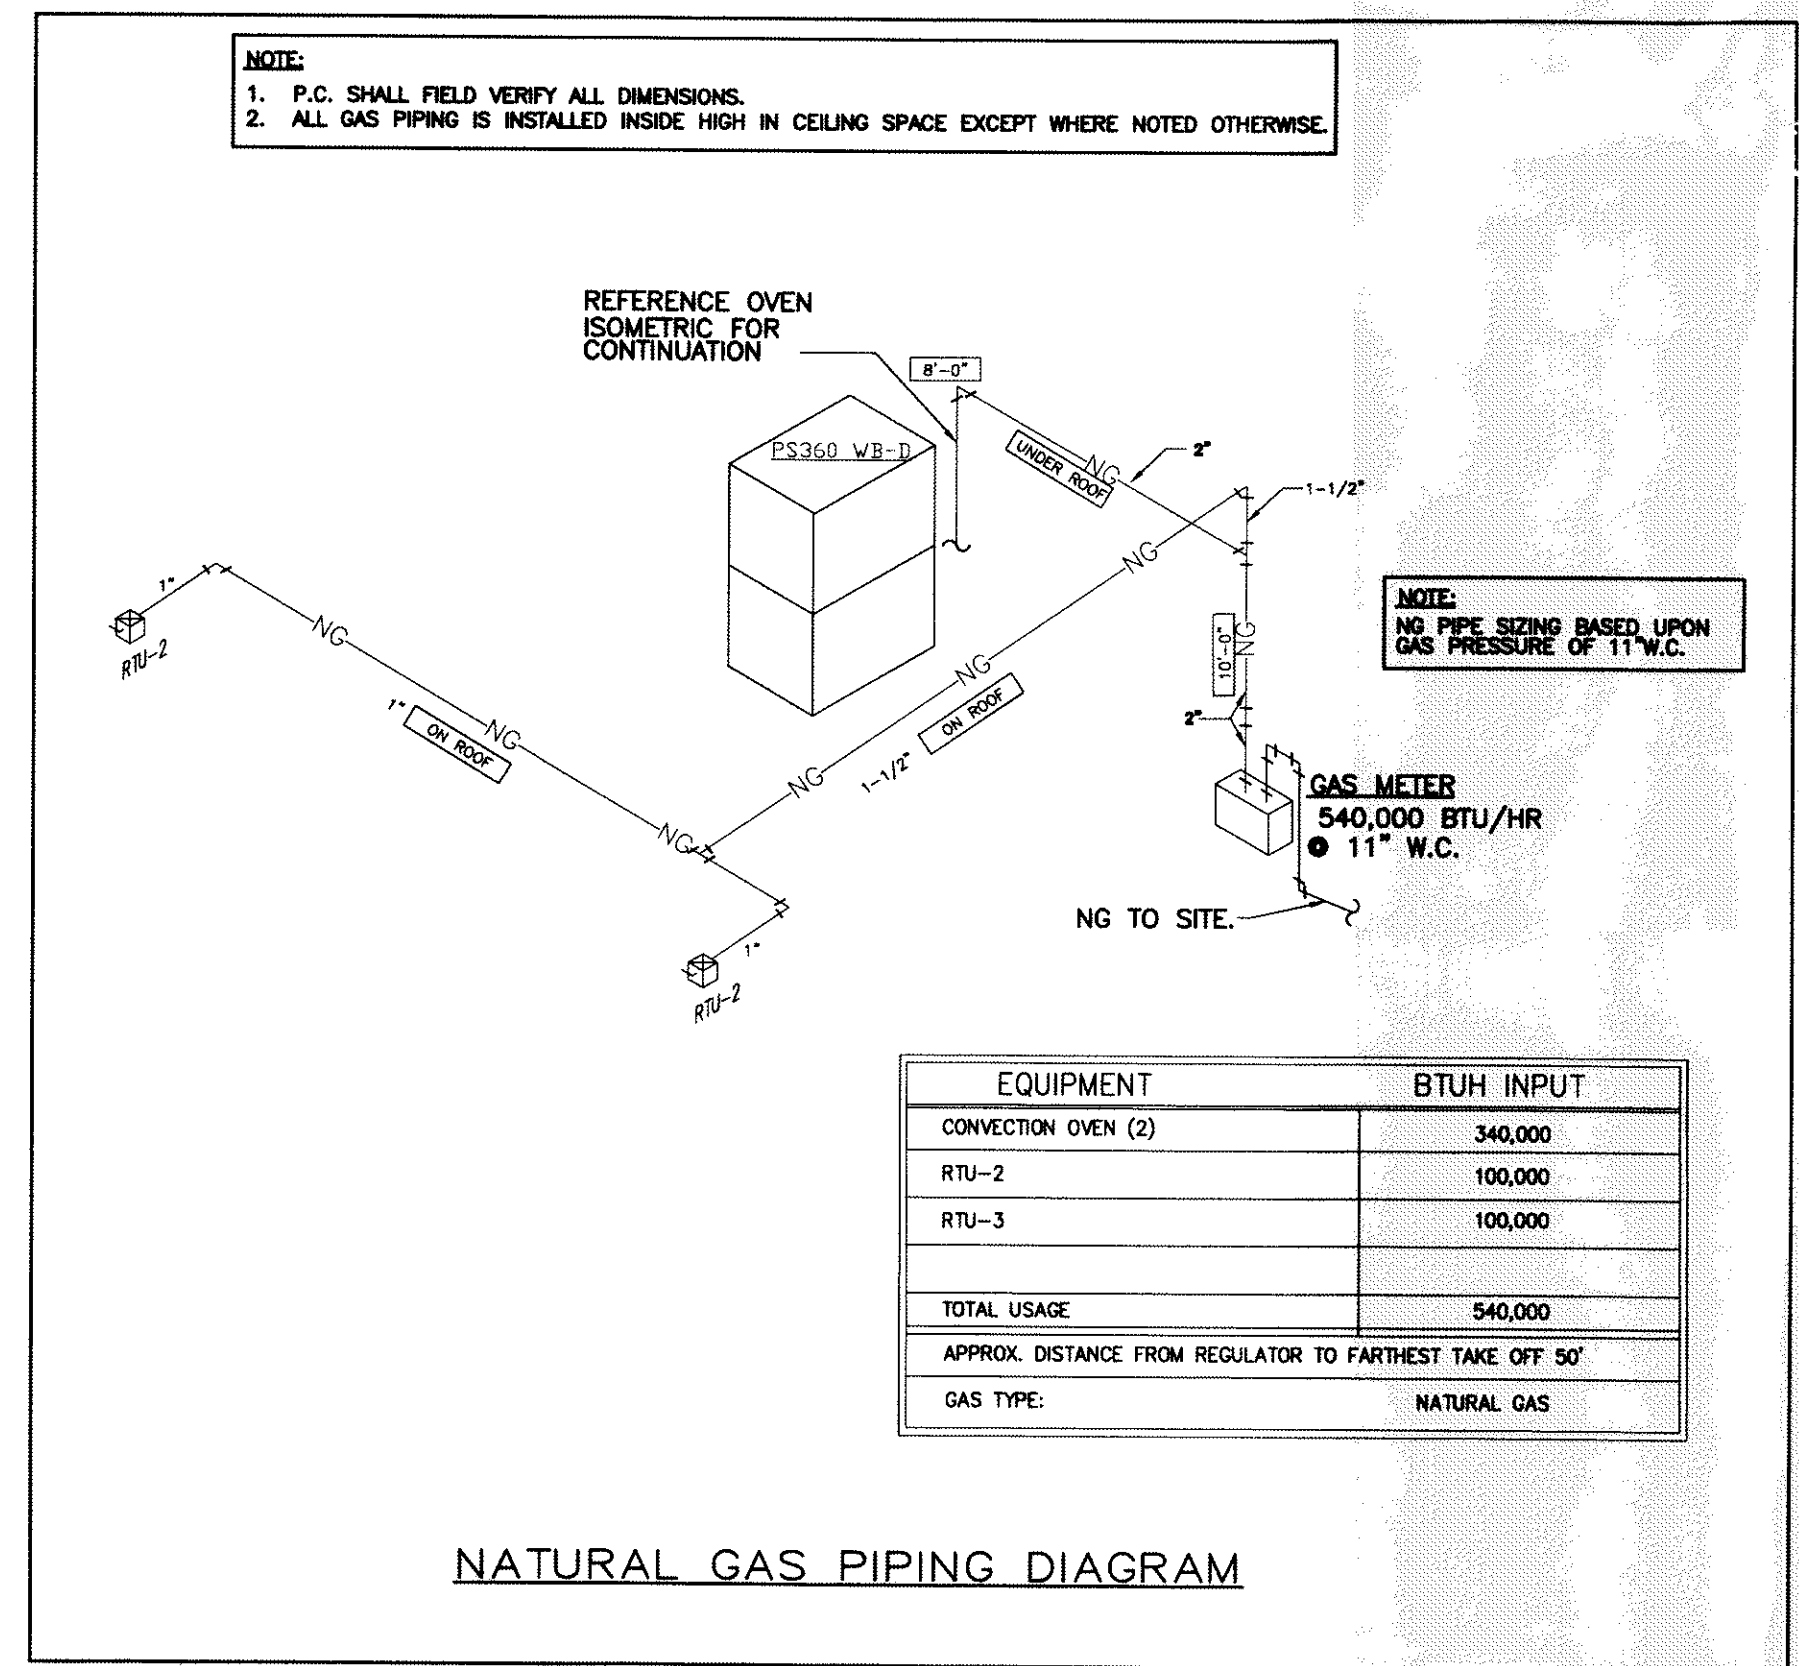
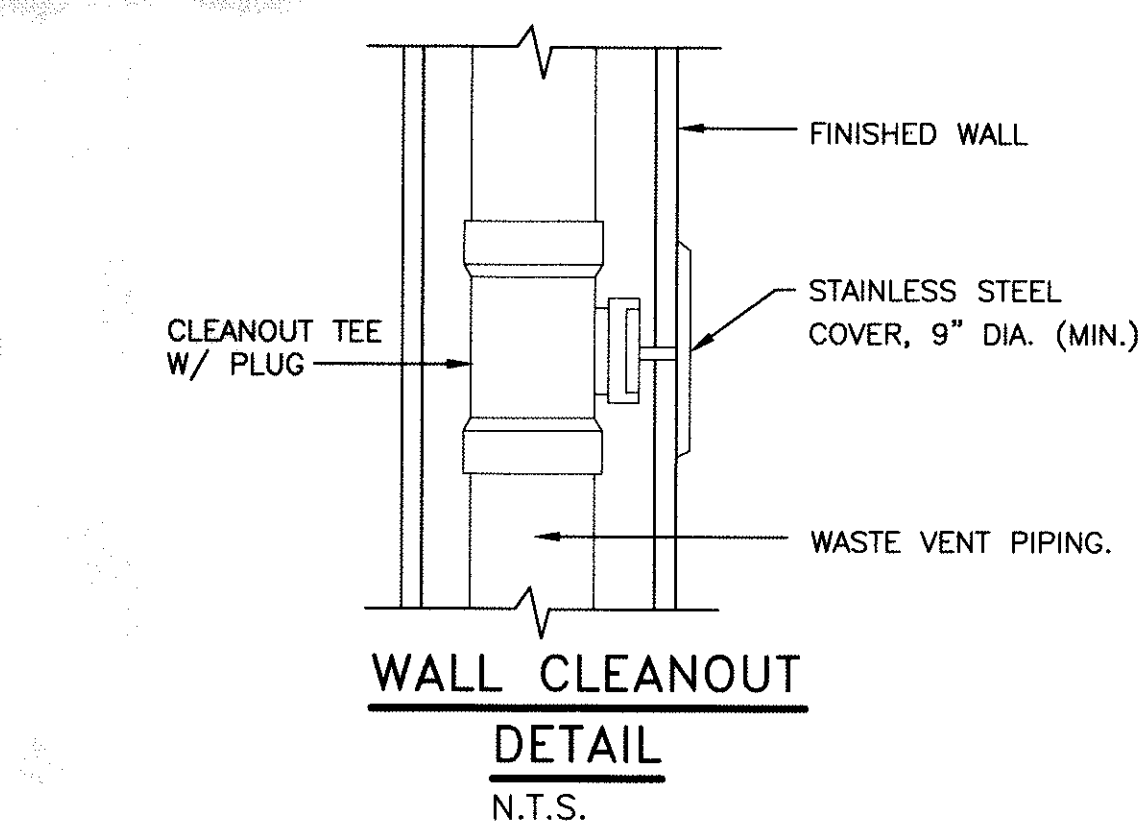
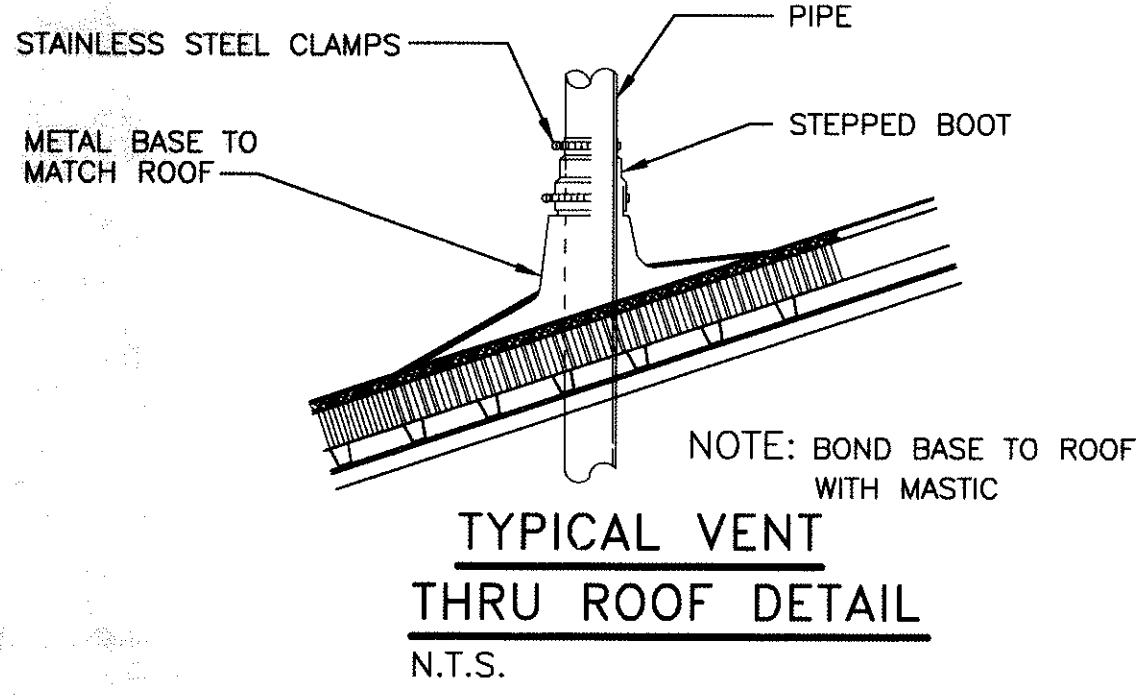
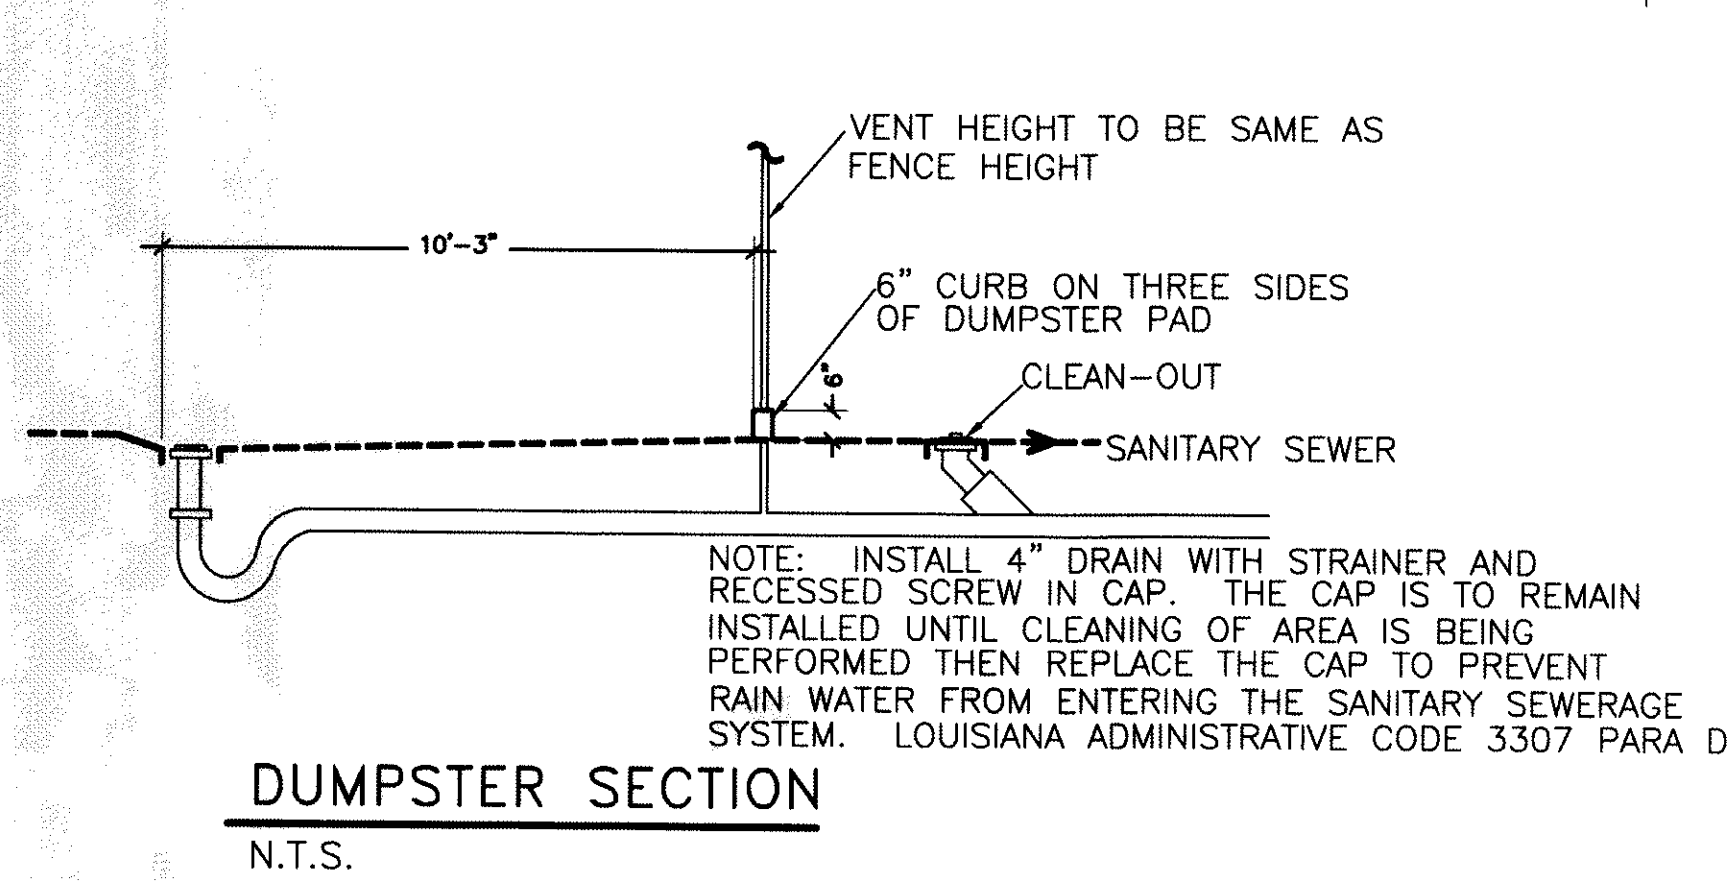
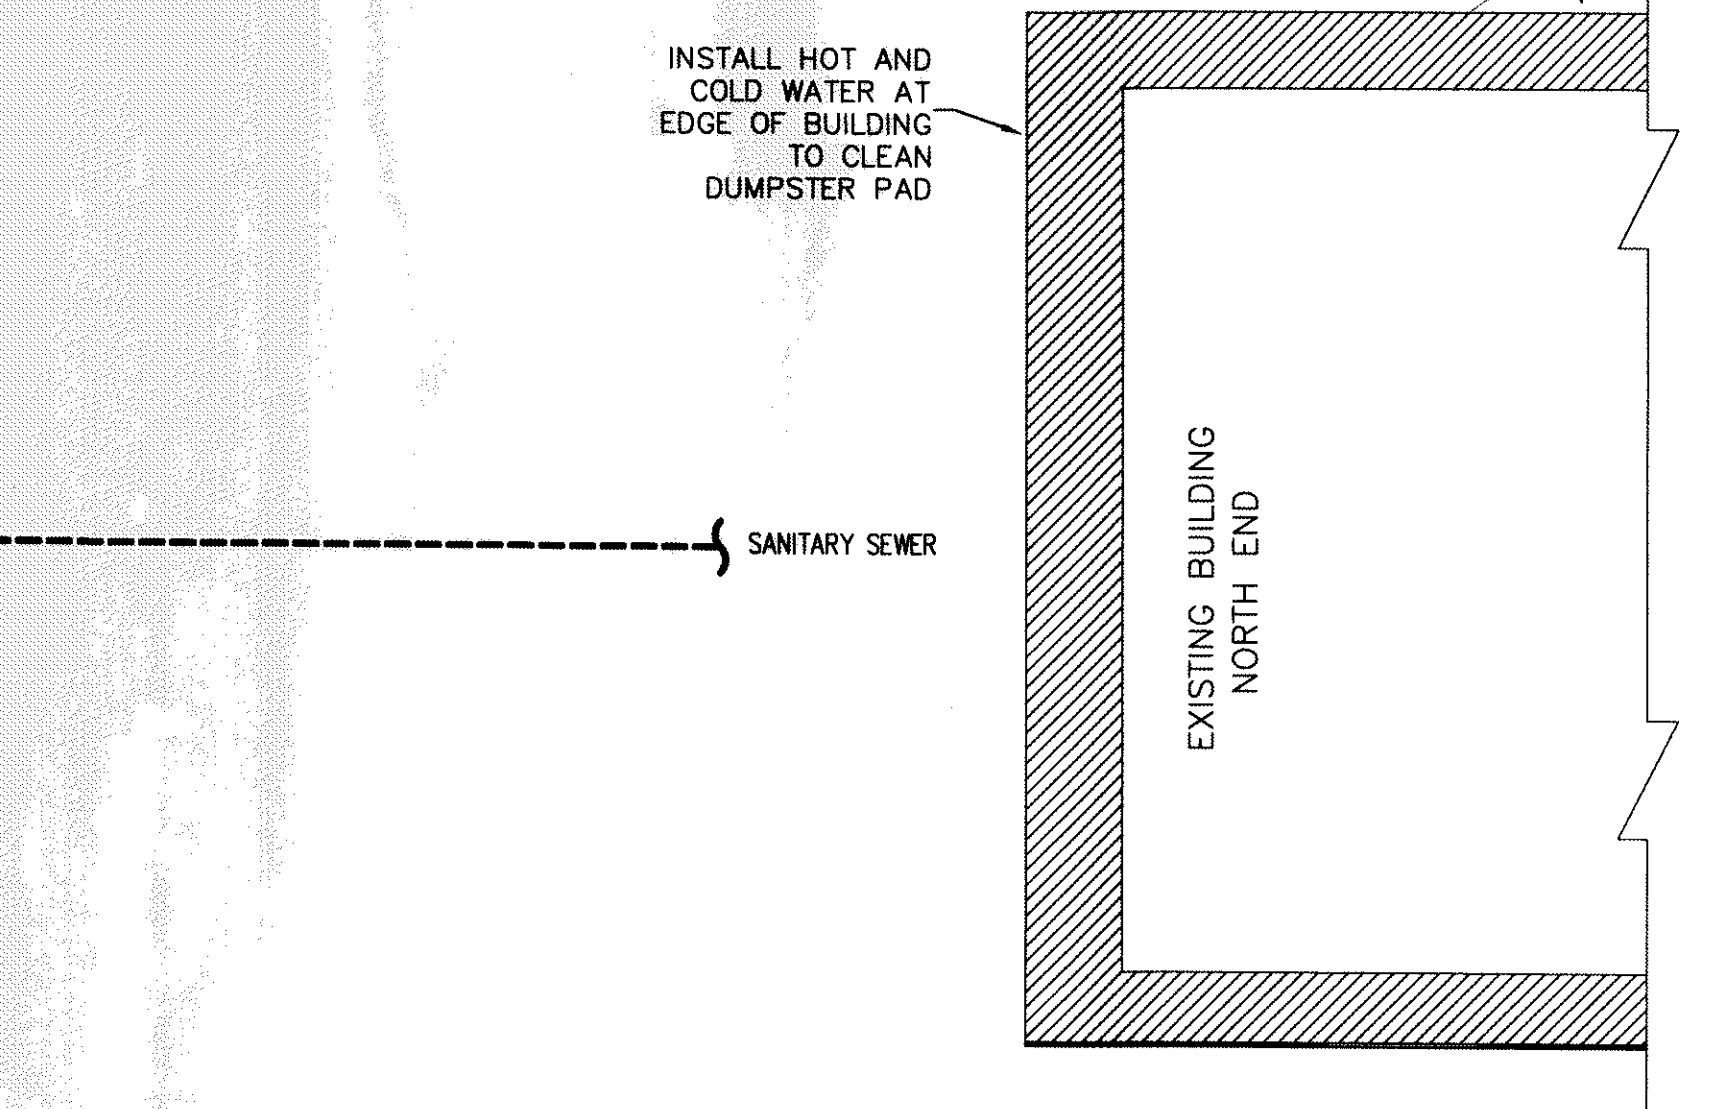
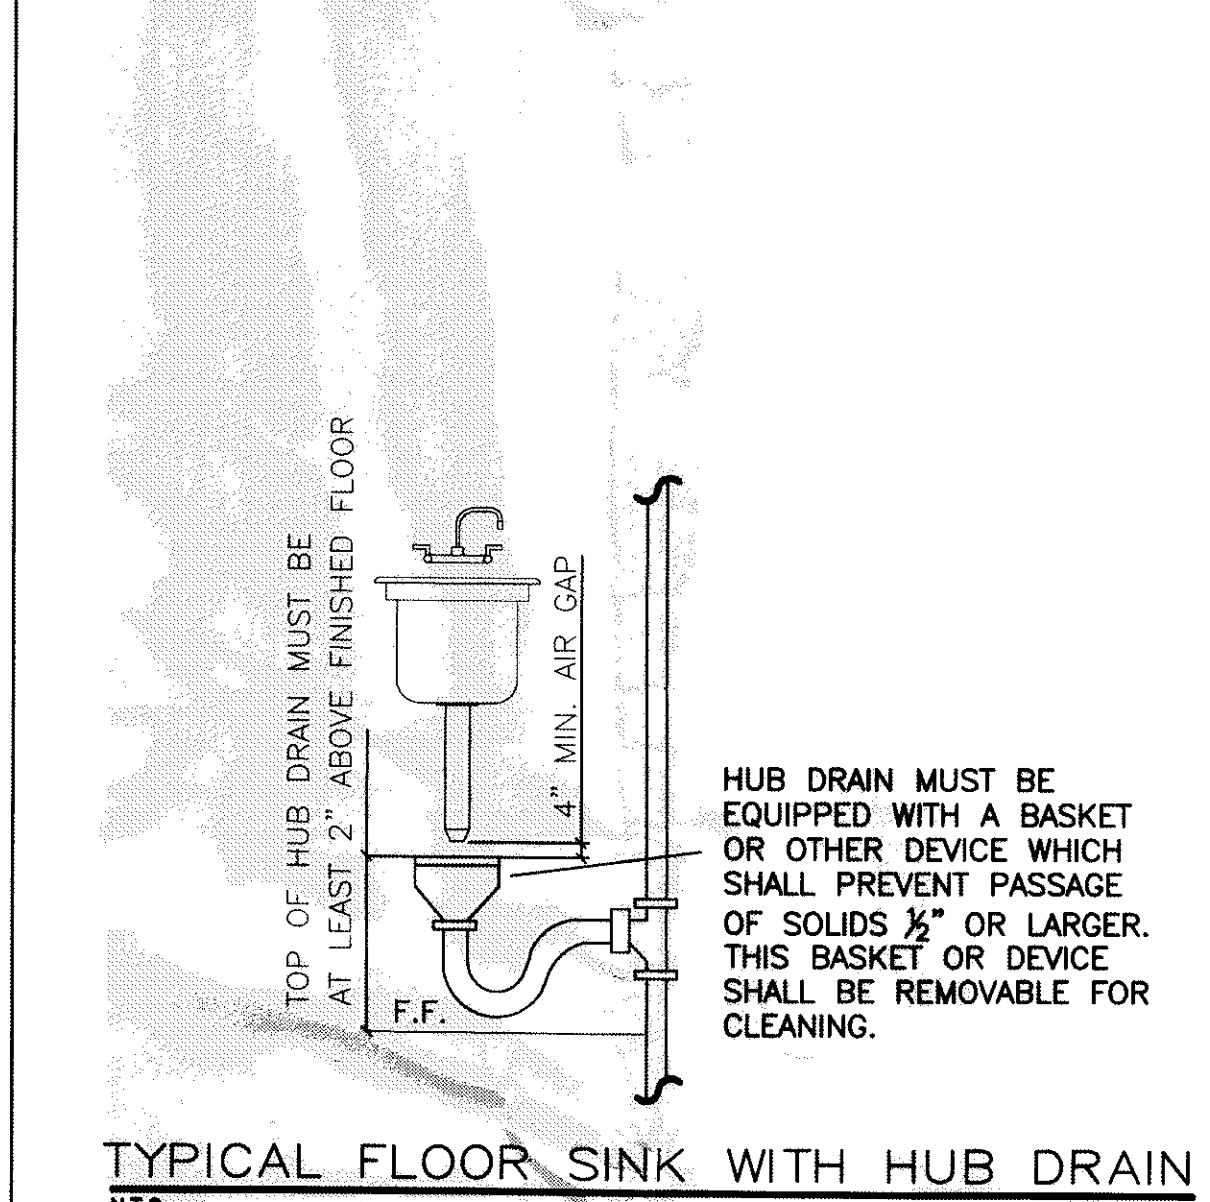
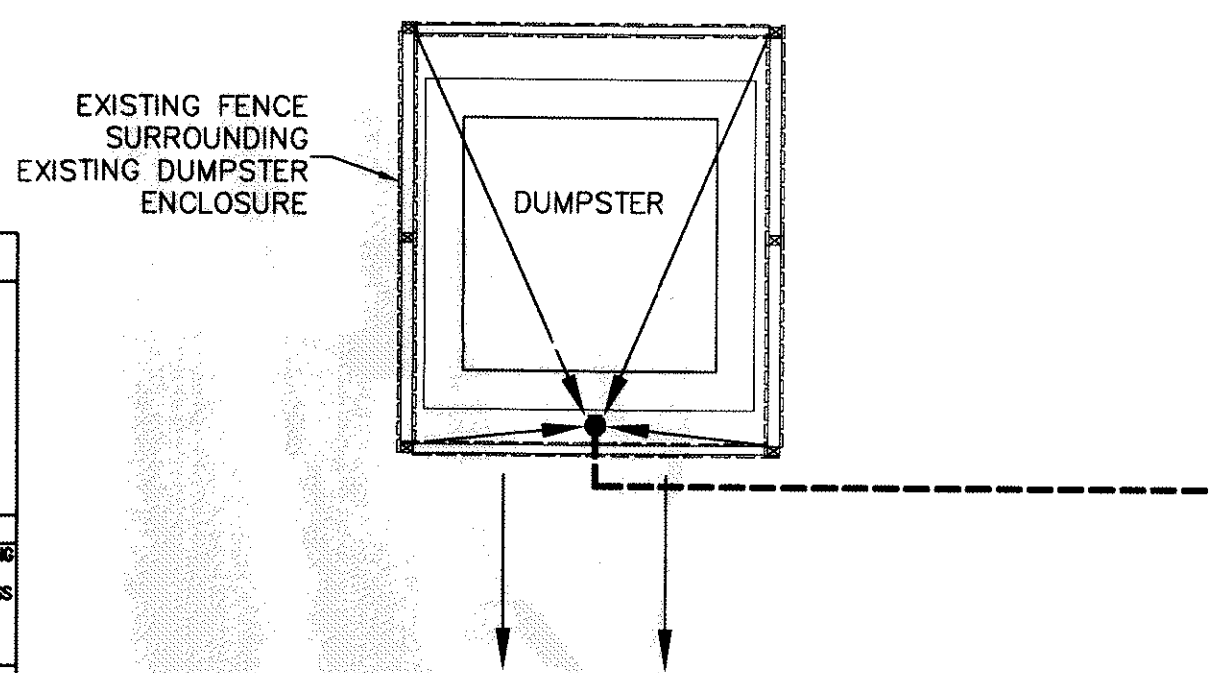
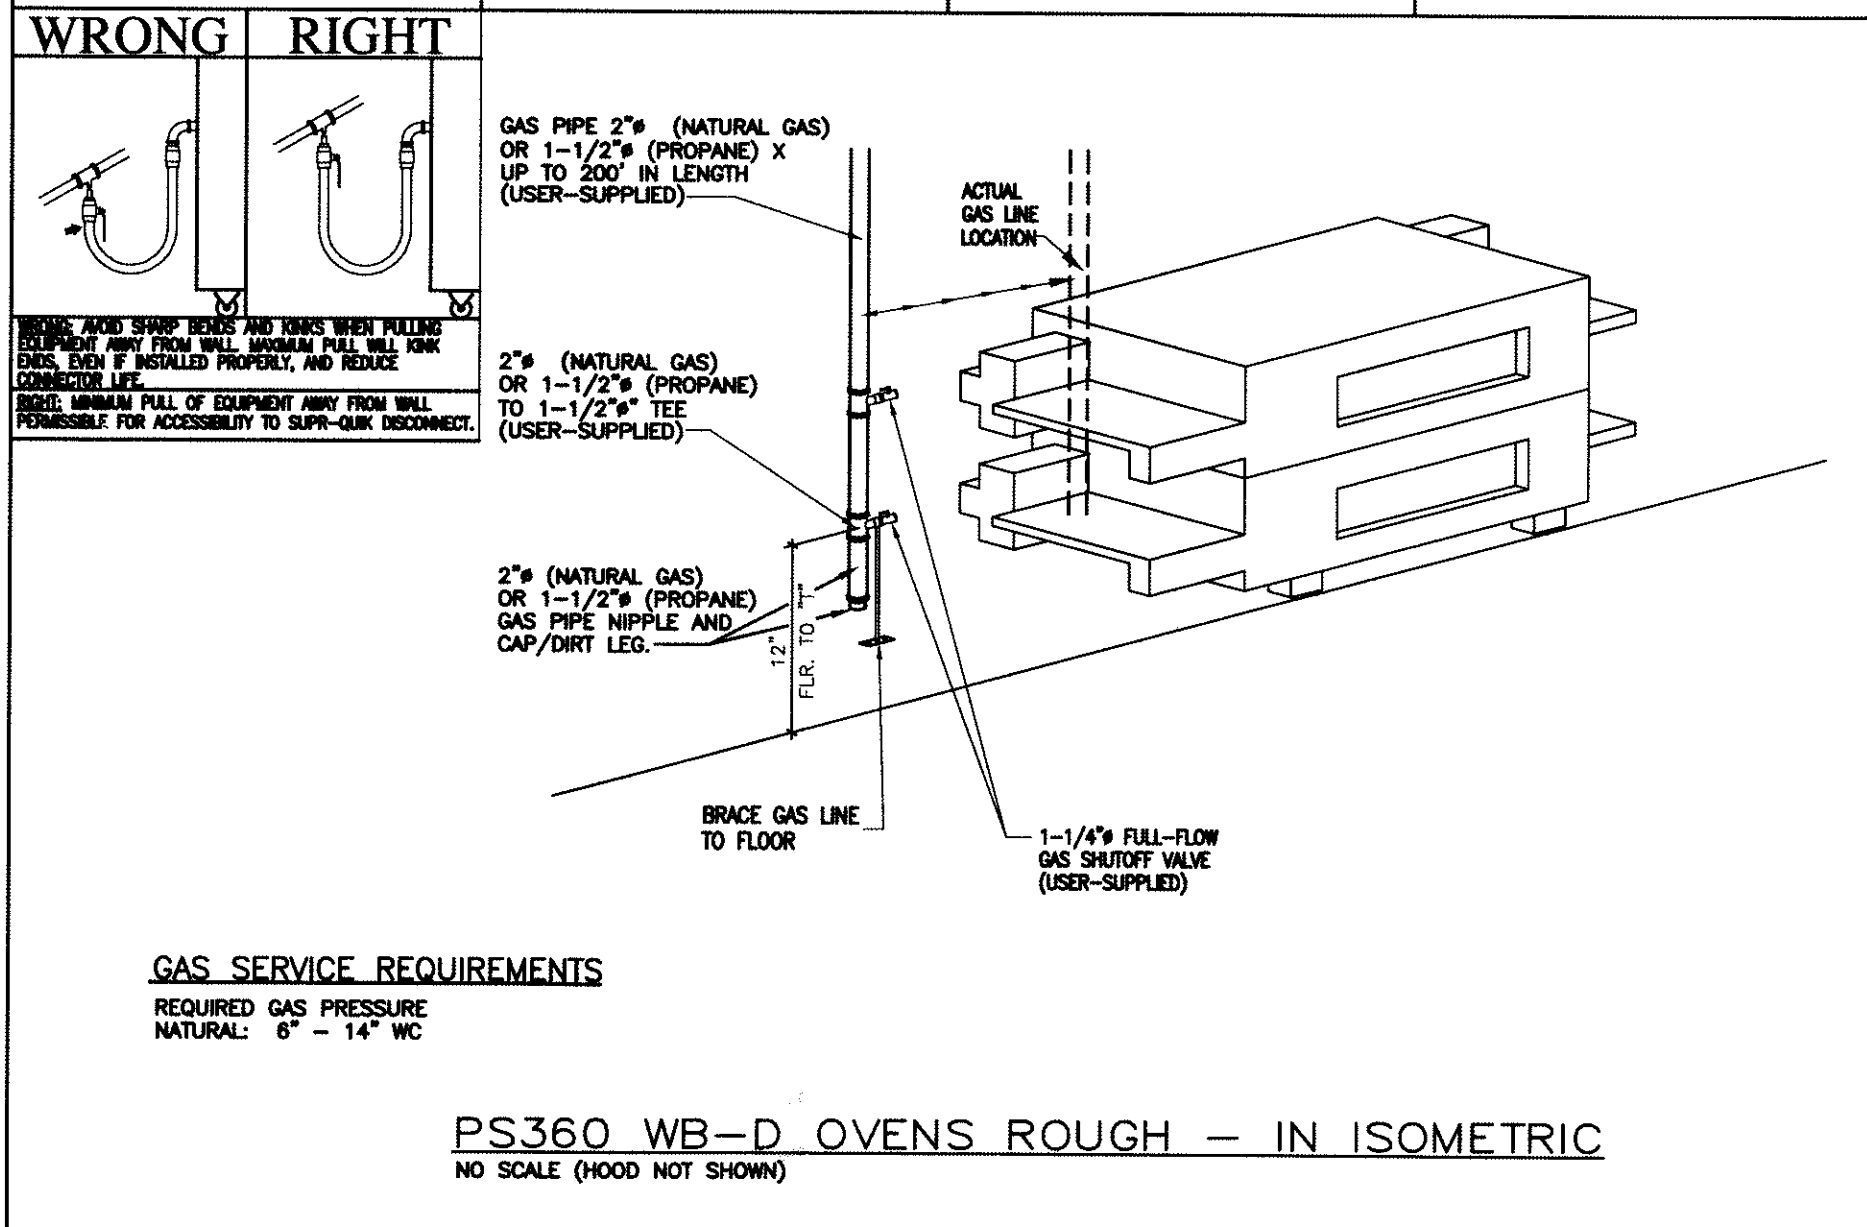


PLUMBING ABBREVIATION LEGEND

- — AT
 - ABV — ABOVE
 - A.F.F. — ABOVE FINISH FLOOR
 - WC — WATER CLOSET
 - CLG — CEILING
 - CLN — CLEANOUT
 - CONN — CONNECT/CONNECTION
 - CONT — CONTINUATION
 - 3CS — THREE COMPARTMENT SINK
 - 4CS — FOUR COMPARTMENT SINK
 - CW — COLD WATER
 - D — DISPOSAL
 - DF — DRINKING FOUNTAIN
 - DRWG — DRAWING
 - DW — DISHWASHER
 - EA — EACH
 - EXT — EXTEND
 - FAC — FURNACE/AIR COND.
 - FCD — FLOOR CLEANOUT
 - FD — FLOOR DRAIN
 - FFE — FINISH FLOOR ELEVATION
 - FIXT — FIXTURE
 - FL — FLOOR
 - FPWH — FREEZE PROOF WALL HYDRANT
 - FS — FLOOR SINK
 - GC — GENERAL CONTRACTOR
 - GT — GREASE TRAP
 - HB — HOSE BIBB
 - HW — HOT WATER
 - L — LAVATORY
 - LOC — LOCATION
 - MC — MECHANICAL CONTRACTOR
 - MS — MOP SINK
 - MTD — MOUNTED
 - NG — NATURAL GAS
 - PC — PLUMBING CONTRACTOR
 - PME — PLUMBING/MECHANICAL/ELECTRICAL
 - REF — REFER/REFERENCE
 - RTU — ROOF TOP HVAC UNIT
 - SS — SANITARY SEWER
 - T&P — TEMPERATURE AND PRESSURE
 - TP — TRAP PRIMER
 - TYP — TYPICAL
 - UR — URINAL
 - V — VENT
 - VS — VEGETABLE SINK
 - VTR — VENT THROUGH ROOF
 - W — WASTE
 - W/ — WITH
 - WB — WASHER BOX
 - WCO — WALL CLEANOUT
 - WH — WATER HEATER
 - WM — WATER METER
 - — CONNECT NEW TO EXISTING
- NOTE: ALL ABBREVIATIONS MAY NOT APPLY

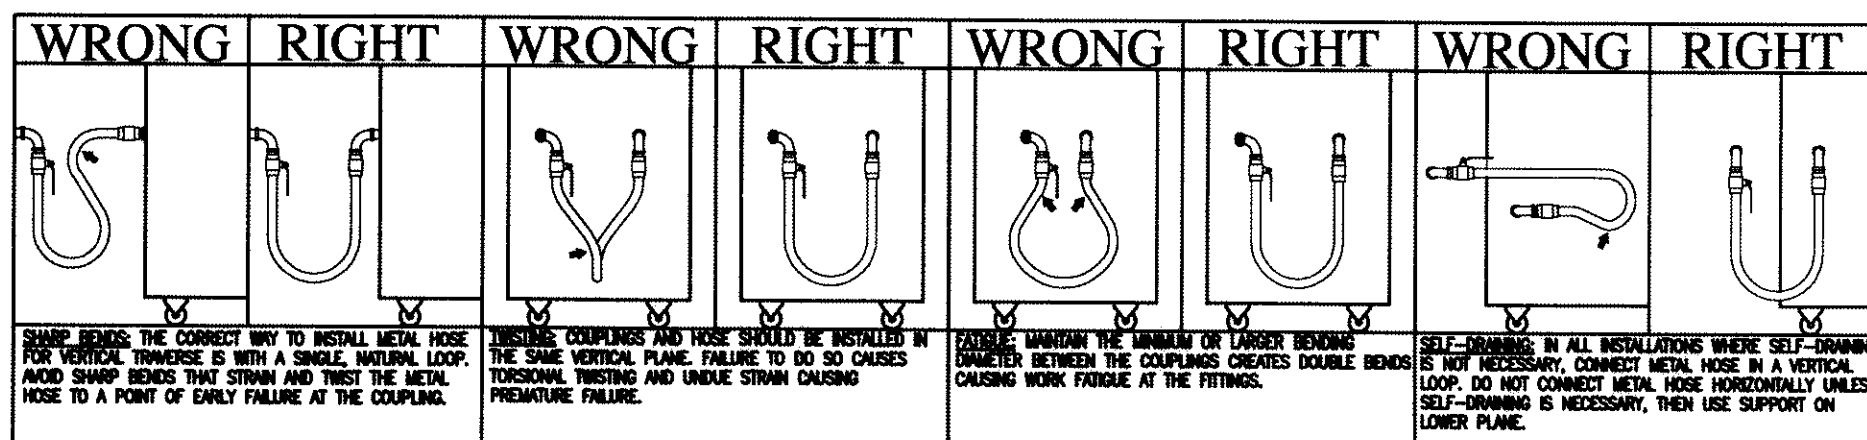

APPROVED

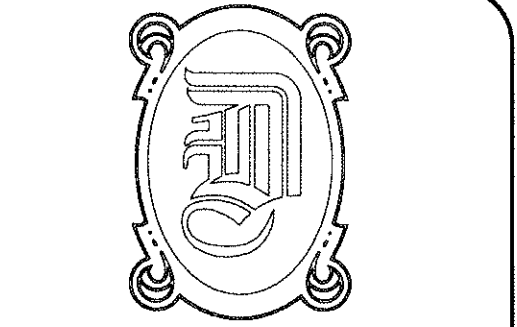

DAMMON ENGINEERING, INC.
EMMETT DAMMON

ARCHITECT
ROBERT WILTSE

1095 FLORIDA AVENUE
SLIDELL, LA. 70458
985-649-5832

WEBSITE:
WWW.DAMMONENGINEERING.COM


EMAIL:
DAMMONENG@BELLSOUTH.NET

ARCHITECTURE
ENGINEERING
STUDIES
PLANNING
INVESTIGATION
EXPERT WITNESS

MARCO'S PIZZA TENANT BUILDOUT

532 GAUSE BLVD
SLIDELL, LA
70458

PLUMBING DETAILS

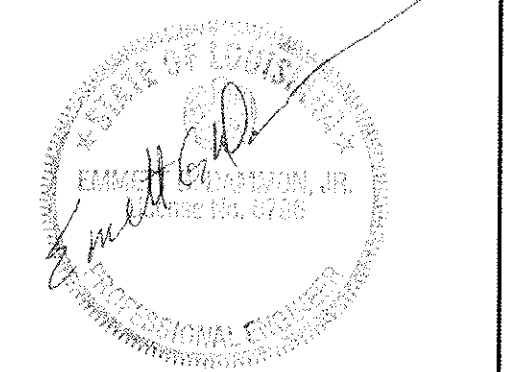

SCALE: AS NOTED

JOB#: 2083

DATE: 11-10-10

SHEET 11

P-2

OF 11