



SECTION
OFFICE DESK TOP
SCALE: 1 1/2" = 1'-0"

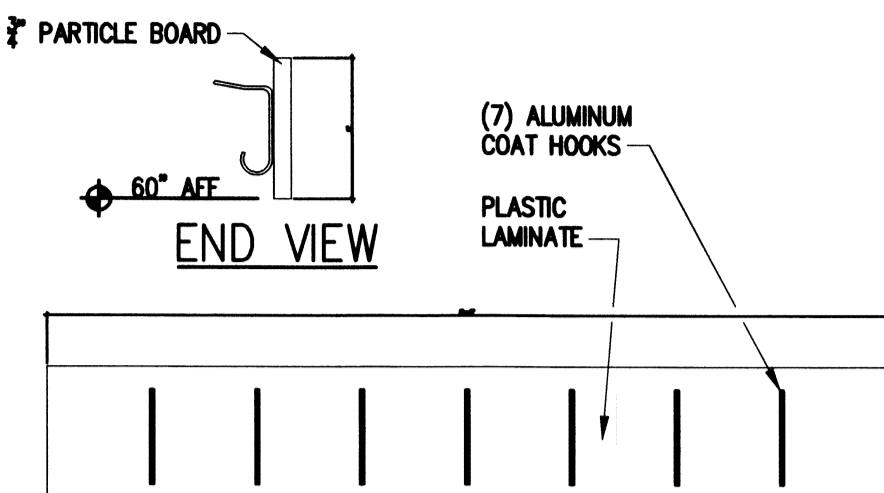

ELEVATION
COORDINATE LOCATION WITH OWNER
SCALE: N.T.S.

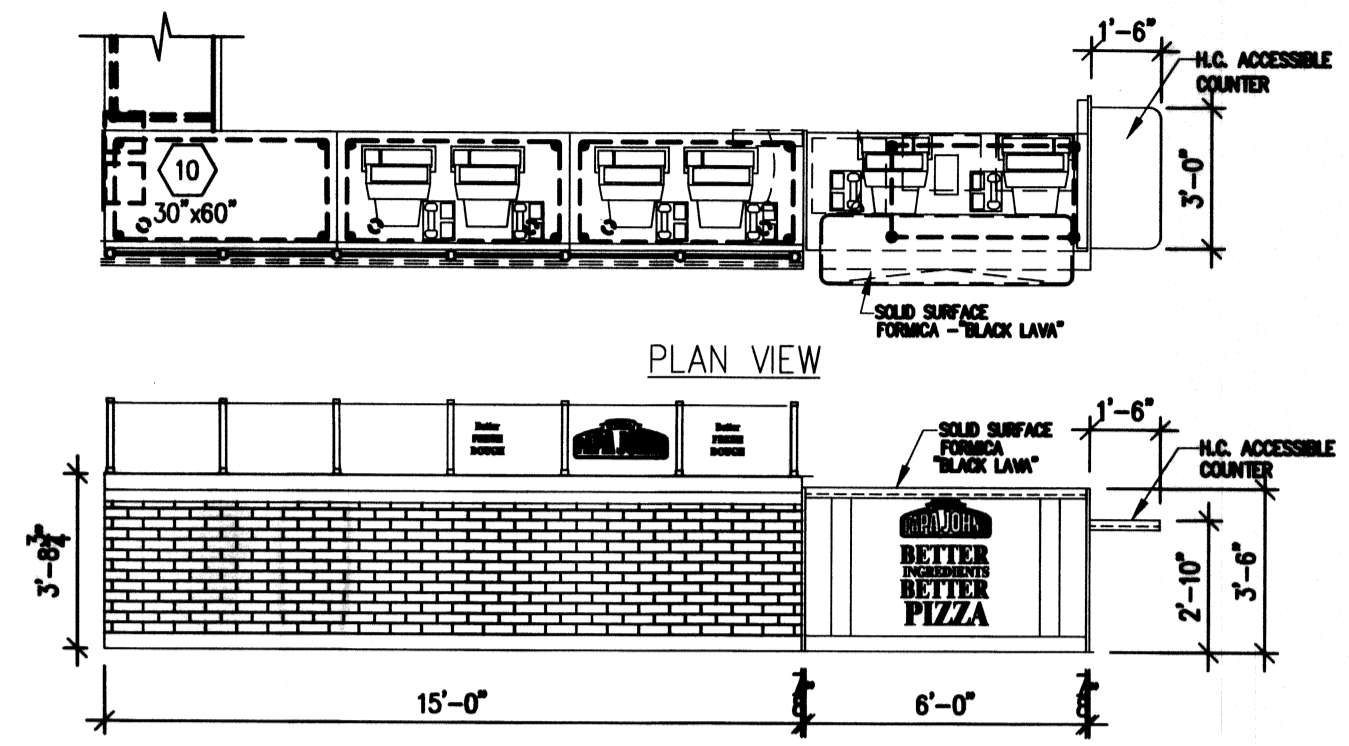

PLAN VIEW
FRONT ELEVATION
FRONT COUNTER ELEVATION
SCALE: N.T.S.

NOTE:
1. A TYPE I HOOD WITH AUTOMATIC EXTINGUISHING SYSTEM IS REQUIRED.
2. CONTRACTOR TO INSTALL DUCT IN ACCORDANCE WITH NFPA 96 AND LOCAL CODE.

HOOD SYSTEM NOTES:
CONTRACTOR TO EMPLOY A LICENSED SPRINKLER SYSTEM COMPANY TO INSTALL WET CHEMICAL SYSTEM IN TYPE I HOOD TO MEET LOCAL CODES.

FOODSERVICE EQUIPMENT SCHEDULE


ITEM	DESCRIPTION	MANUFACTURE	MODEL NO.	SUPPLIED BY	INSTALLED BY	BYE OUT	FABRICATED	MILLWORK	N.I.K.E.C.	REMARKS
1	DOUBLE PIZZA OVEN	MIDDLEBY MARSHALL	PS770/S WCV	O	O			X		CONTACT STEVE BOROSAK 847.429.7790
2	EXHAUST HOOD	CAPTIVE AIRE	ND-2-PSF-F	KEC	GC					INSTALL BY GC
3	PIZZA PREP TABLE	TRUE	TPP-119	KEC	KEC	X				SEE WRITTEN SPECS FOR OPTIONS
4	STAINLESS STEEL CUT TABLE	KITCHEN EQUIPMENT CO.	CUSTOM STAINLESS	KEC	GC	X				SEE DRAWINGS FOR COMPLETE DETAILS
4A	60" HEAT LAMP	APW	FD-60H-1	KEC	KEC	X				REMOTE TOGGLE
4B	42" HEAT LAMP	APW	FD-42H-1	KEC	KEC	X				REMOTE TOGGLE
5	SPARE NUMBER									
6	72" FRONT COUNTER KOISK	KITCHEN EQUIPMENT CO.	CUSTOM MILLWORK	KEC	KEC			X		SEE SPEC MANUAL FOR CMPLT DETAILS
7	S.S. SAUCE TABLE	KITCHEN EQUIPMENT CO.	CUSTOM STAINLESS	KEC	KEC	X				w/ CUT OUT, UNDER SHELF
8	S.S. TABLE	KITCHEN EQUIPMENT CO.	CUSTOM STAINLESS	KEC	KEC	X				w/ OPEN BASE
9	S.S. TABLE	KITCHEN EQUIPMENT CO.	CUSTOM STAINLESS	KEC	KEC	X				w/ MARINE FRONT EDGE & OPEN BASE
10	S.S. PREP TABLE	KITCHEN EQUIPMENT CO.	CUSTOM STAINLESS	KEC	KEC	X				w/ UNDER SHELF, SEE DRAWING FOR TABLE SIZE
10A	FRONT COUNTER P.O.S./SAFE TABLE	KITCHEN EQUIPMENT CO.	CUSTOM STAINLESS	KEC	KEC	X				w/ PARTIAL U.S. & OPEN BASE FOR SAFE
11	CLIP BOARD/DELI TICKET HOLDER	KITCHEN EQUIPMENT CO.	CUSTOM MILLWORK	KEC	KEC			X		WILSONART # 4745-60
12	WALK-IN COOLER	LOUISVILLE COOLER		KEC	GC	X				W/STRIP CURTAIN, WHITE EXT, FLOORLESS
13	EVAPORATOR COIL	HERMETIC	VARIES BY COOLER SIZE	KEC	GC	X				INSTALL BY GC
14	TRASH RECEPTACLE w/ LID	CONTINENTAL	4444 / 4445 / 3255	KEC	GC	X				w/ DOLLY, IN SMALL WARES PKG
15	ALUMINUM DUNNAGE RACK - 24"x48"	NEW AGE	2009	KEC	KEC	X				
16	THREE COMPARTMENT SINK	UNIVERSAL STAINLESS	2N18-2D18	KEC	PC	X				w/ T&S 8-0230-1N FAUCETS, 063X NOZZLE 12"
17	GREASE TRAP	JONESPEC	GT-2700-20	PC	PC	X				40 LBS., PROVIDED/INSTALL BY PC
18	MOP SINK	FIAT MSB	2424	PC	PC	X				FIBERGLASS w/ FISHER B253 FAUCET BY KEC
19	ALUMINUM DUNNAGE RACK - 18"x48"	NEW AGE	94115	KEC	KEC	X				ANGLED PLATFORM
20	SHELVING UNIT - 18"x48"	METRO	1848NK3, 86PK3	KEC	KEC	X				EPOXY
21	DRY STORAGE SHELVING UNIT - 18"x60"	METRO	1860BR, 86P	KEC	KEC	X				ZINC
22	MOBILE CAN OPENING TABLE	NEW AGE	1227	KEC	KEC	X				24"x30" w/ 1/2 TOP CUTTING BOARD
23	S/S CORNER GUARDS	KITCHEN EQUIPMENT CO.	CUSTOM STAINLESS	KEC	GC	X				2"x2"x60"
24	DESK TOP	KITCHEN EQUIPMENT CO.	CUSTOM MILLWORK	KEC	KEC			X		WILSONART # 4745-60
25	SINGLE COMPARTMENT SINK	UNIVERSAL STAINLESS	1N1618-LD18 (RD18)	KEC	PC	X				
26	RAPID COOK OVEN	MERRY CHEF USA	4025	KEC	KEC	X				
27	SODA BOTTLE COOLER	TRUE	SDM-37	FRAN	V			X		PROVIDED BY COKE COLA
28	WIRE WALL SHELVING SYSTEM	METRO		KEC	KEC	X				EPOXY
29	COAT RACK w/ HOOKS	KITCHEN EQUIPMENT CO.	CUSTOM MILLWORK	KEC	KEC			X		WILSONART # 4745-60
30	DOUGH SHEETER	DOYON INC.	DLF1BDP	KEC	KEC	X				
31	TELEPHONE SYSTEM			V	V			X		BY VENDOR
31A	TELEPHONES			V	V			X		BY VENDOR
32	2-DRAWER FILE CABINET	VARIES	VARIES	FRAN	FRAN			X		BY FRANCHISEE
33	DRIVERS DROP BOX 20 SLOT	KITCHEN EQUIPMENT CO.	CUSTOM MILLORK	KEC	KEC	X				WILSONART # 4745-60
34	LOCKING CASH DRAWERS			PJI	KEC	X				UNDER FRONT COUNTER
35	2.5 GAL. WET CHEMICAL FIRE EXTINGUISHER	LARSON	CLASS K	GC	GC			X		w/ WALL BRACKET
36	FLOOR MOUNTED TIME DELAY SAFE	BLUE DOT		GC	GC	X				
37	W/M HAND SINK w/ T&S FAUCET B-1115	UNIVERSAL	EHS-1	KEC	PC	X				SEE DRAWINGS FOR COMPLETE DETAILS
38	BUBBLE FORK HOLDER	KITCHEN EQUIPMENT CO.	BFH	KEC	KEC	X				w/ T&S FAUCET B-1115, SOAP/TOWEL DISP. B.O.
39	MENU BOARD	POSTERLOID	CUSTOM	KEC	GC	X				SEE SPECIFICATIONS FOR CMPLT DETAILS
39A	MENU BOARD LIGHTING	POSTERLOID	CUSTOM	KEC	KEC	X				
40	LARGE PAN HOLDER	KITCHEN EQUIPMENT CO.	CUSTOM STAINLESS	KEC	KEC	X				CUT TABLE MOUNT
41	PAN RACK	NEW AGE INDUSTRIAL	6331	KEC	KEC	X				
42	COOLER LIGHTS	THERMALRITE		KEC	KEC	X				INSTALL BY GC/EC
43	HOLDING CABINET, HALF SIZE	WINSTON INDUSTRIES	HA4511	KEC	KEC	X				
44	REFRIGERATOR, ROLL-IN	TRUE FOOD SERVICES	TA1RR-25	KEC	KEC	X				
45	CLOCK	KITCHEN EQUIPMENT CO.	CUSTOM	KEC	KEC	X				
46	WAREWASHER	HOBART	AM15-1	PC	PC					
47	2" GAS LINE			V	V			X		BY P.C.
48	DISPLAY CASE, HEATED	HATCO	GR25DH-60	KEC	KEC	X				
49	COMMISSARY COMM HOLDER	KITCHEN EQUIPMENT CO.	CUSTOM STAINLESS	KEC	KEC	X				IN SMALL WARES PACKAGE
50	FIRST AID KIT	VARIES	VARIES	FRAN	FRAN			X		BY FRANCHISEE
51	W/M COMPUTER WORK STATION	PEERLESS INDUSTRIES	PC 25/PC-25G	KEC	KEC	X				GC TO VERIFY WALL BACKING REQ
52	WAITING BENCH	WALBASH	1035	KEC	KEC	X				BLACK FINISH
53	CHEESE RACK	NEW AGE	2472TB	KEC	KEC	X				SEVEN (7) TIER, 84" POST
54	UNDERCOUNTER REFRIG.	BEVERAGE AIR	UCR27	KEC	KEC	X				VERIFY LEG AND/OR CASTER SET
55	OFFICE CABINETS	KITCHEN EQUIPMENT CO.	CUSTOM MILLWORK	KEC	KEC			X		WILSONART # 4745-60
56	SNEEZE GUARD	KITCHEN EQUIPMENT CO.	CUSTOM STAINLESS	KEC	KEC	X				SEE SPECIFICATIONS FOR CMPLT DETAILS
56A	OVERHEAD FOOD WARMER	APW WYOTT	FD-36L	KEC	KEC	X				
57	P.O.S. TERMINALS	PJI		V	V			X		
58	WINDOW SIGNS	ZEON CORP	CUSTOM SIGN	KEC	KEC	X				
59	CHEMICAL STORAGE SHELVING - 18"x36"	METRO	1836Z, P84	KEC	KEC	X				5 TIER WALL MOUNT
60	FIRE SUPPRESSION SYSTEM	ANSUL	R-102	KEC	KEC	X				
61	P.O.S. PRINTER	BY VENDOR		V	V			X		
62	OFFICE STORAGE SHELF	METRO		KEC	KEC	X				FOR OFFICE FAX MACHINE / PRINTER
63	MAKE LINE MAGNETIC BILLBOARD - 18"x60"	KITCHEN EQUIPMENT CO.	CUSTOM STAINLESS	KEC	KEC	X				IN SMALL WARES PACKAGE
64	SAUCE W/M PAN HOLDER	KITCHEN EQUIPMENT CO.	CUSTOM STAINLESS	KEC	KEC	X				IN SMALL WARES PACKAGE
65	S/S WALL PANEL	KITCHEN EQUIPMENT CO.	CUSTOM STAINLESS	KEC	KEC	X				VERIFY SIZE, IN SMALL WARES PACKAGE
66	CUP DISPENSER	DELFIELD	CD-539	KEC	KEC	X				
67	ICE/BEVERAGE DISPENSER	MANTOWOC ICE	M-250	V	V			X		
68	SCREEN RACK HOLDER	KITCHEN EQUIPMENT CO.	CUSTOM STAINLESS	KEC	KEC	X				IN SMALL WARES PACKAGE
69	BOOK END - CUT TABLE	KITCHEN EQUIPMENT CO.	CUSTOM MILLWORK	KEC	KEC	X				IN SMALL WARES PACKAGE
70	DOUGH BIN'S & DOLLIES	NOLSEMAN		O	O			X		
71	HOLD & SERVE DRAWER	CVAP	HBB5D2	KEC	KEC	X				
72	FULL SIZE HOLDING CABINET	CVAP	HA4519	KEC	KEC	X				
73	MOP BUCKET	CONTINENTAL	206-31	KEC	KEC	X				IN SMALL WARES PACKAGE
74	CLOSET ORGANIZER	RUBBERMAID	1993	KEC	KEC	X				IN SMALL WARES PACKAGE
75	FOOD CUTTER/SHREDDER	NEMCO	N55200AN-4	KEC	KEC	X				IN SMALL WARES PACKAGE
76	CAN OPENER MANUAL	EDLUND	U-125	KEC	KEC	X				IN SMALL WARES PACKAGE
77	TOMATO SLICER	NEMCO	N55600-2	KEC	KEC	X				IN SMALL WARES PACKAGE
78	DROP-IN, COLD PAN	APW WYOTT	CM-2	KEC	KEC	X				
79	DROP-IN, HOT WELL	APW WYOTT	HW-2D	KEC	KEC	X				
80	DROP-IN, HEATED SHELF	HATCO	GR5BF-36-S	KEC	KEC	X				

EQUIPMENT VENDOR WILL FURNISH & INSTALL THE FOLLOWING PLASTIC LAMINATE ITEMS.


- 11- 1"x6"x40" LONG CLIP BOARD STRIP WITH YELLOW METAL CRAFT ON FACE AND ALL EDGES. INSTALL 56 1/2" ABOVE FINISH FLOOR ON OFFICE WALL.
- 24- OFFICE DESK TOP TO BE YELLOW METAL CRAFT WITH SELF-EDGE AND 3" BACK AND DID SPLASH TOP TO BE COMPLETE WITH WALL SUPPORT BRACKETS. 42" A.F.F.
- 29- 3/4"x6"x40" COAT HOOK STRIP WITH YELLOW METAL CRAFT ON FACE AND ALL EDGES. ATTACH 7 ALUMINUM COAT HOOKS SPACED EVENLY AND MOUNT 60" A.F.F.
- 33- DRIVERS DROP BOX HOLDER WITH YELLOW METAL CRAFT ON ALL FACES EXCEPT BOTTOM AND BACK.
- 34- 16"x18"x1/2" CASH DRAWER, FURNISH ALL HARDWARE AND INSTALL UNDER FRONT STEEL WORK TABLE.

NOTE:
CONTRACTOR TO INSTALL PLYWOOD BACKING BEHIND THE FOLLOWING ITEMS #11, #24, #29, #33, #34 AND CABINET IN MGR. OFFICE. IF CONTRACTOR DOES NOT INSTALL BACKING, THE CONTRACTOR BECOMES RESPONSIBLE FOR THOSE ITEMS SHOULD THEY FAIL.

- NOTES:
- PIZZA OVEN TO BE MODEL PS-770 GAS FIRED CONVEYOR TYPE AS MANUFACTURED BY MIDDLEBY MARSHALL. OVENS ARE TO BE COMPLETE WITH EXHAUST CANOPY DUCTED TO ROOF MOUNTED EXHAUST FAN. DUCT TO BE INSULATED 24 GA. GALV. STEEL. PLUMBING CONTRACTOR TO FURNISH 2" GAS SUPPLY LINE TO OVENS WITH 3/4" GAS VALVES. E.V. TO FURNISH AND GENERAL CONTRACTOR TO INSTALL OVEN EXHAUST HOOD ABOVE OVENS.
 - MAKELINE TO BE MODEL PT-119 - COMPLETE WITH BUN PANS, INSTRUMENTAL/TICKET TAKER HOLDER AND CASTERS AS MANUFACTURED BY VICTORY.
 - PIZZA CUTTING AND BOILING TABLE TO BE PER PLAN. STAINLESS STEEL COMPLETE WITH DBL. OVER SHELVES, TWO HEATED SHELVES, PAN HOLDER AND CASTERS.
 - GREASE INTERCEPTOR SEE SHEET P-1.
 - FLOOR SINK TO BE RELOCATED. INSTALL COMP STRAINER DRAIN.
 - PLUMBING CONTRACTOR TO MAKE ALL CONDENSATE DRAIN LINE CONNECTIONS FOR WALK-IN COOLER AND DROP-IN "COLD PACK" REFRIGERATION UNIT. MECHANICAL CONTRACTOR TO INSTALL COMPRESSOR AND EVAPORATOR THEN DO FINAL CONNECTIONS.
 - ELECTRICAL CONTRACTOR TO MAKE ALL REQUIRED ELECTRICAL CONNECTIONS FOR WALK-IN COOLER LIGHTING AND REFRIGERATION UNIT. ALSO HEAT UNITS ON CUT TABLE.
- RESPONSIBILITIES:
E.V. - DENOTES EQUIPMENT VENDOR
GC - DENOTES GENERAL CONTRACTOR
EC - DENOTES ELECTRICAL CONTRACTOR
PC - DENOTES PLUMBING CONTRACTOR
FRAN - DENOTES FRANCHISEE
VENDOR - DENOTES LOCAL SUPPLIER

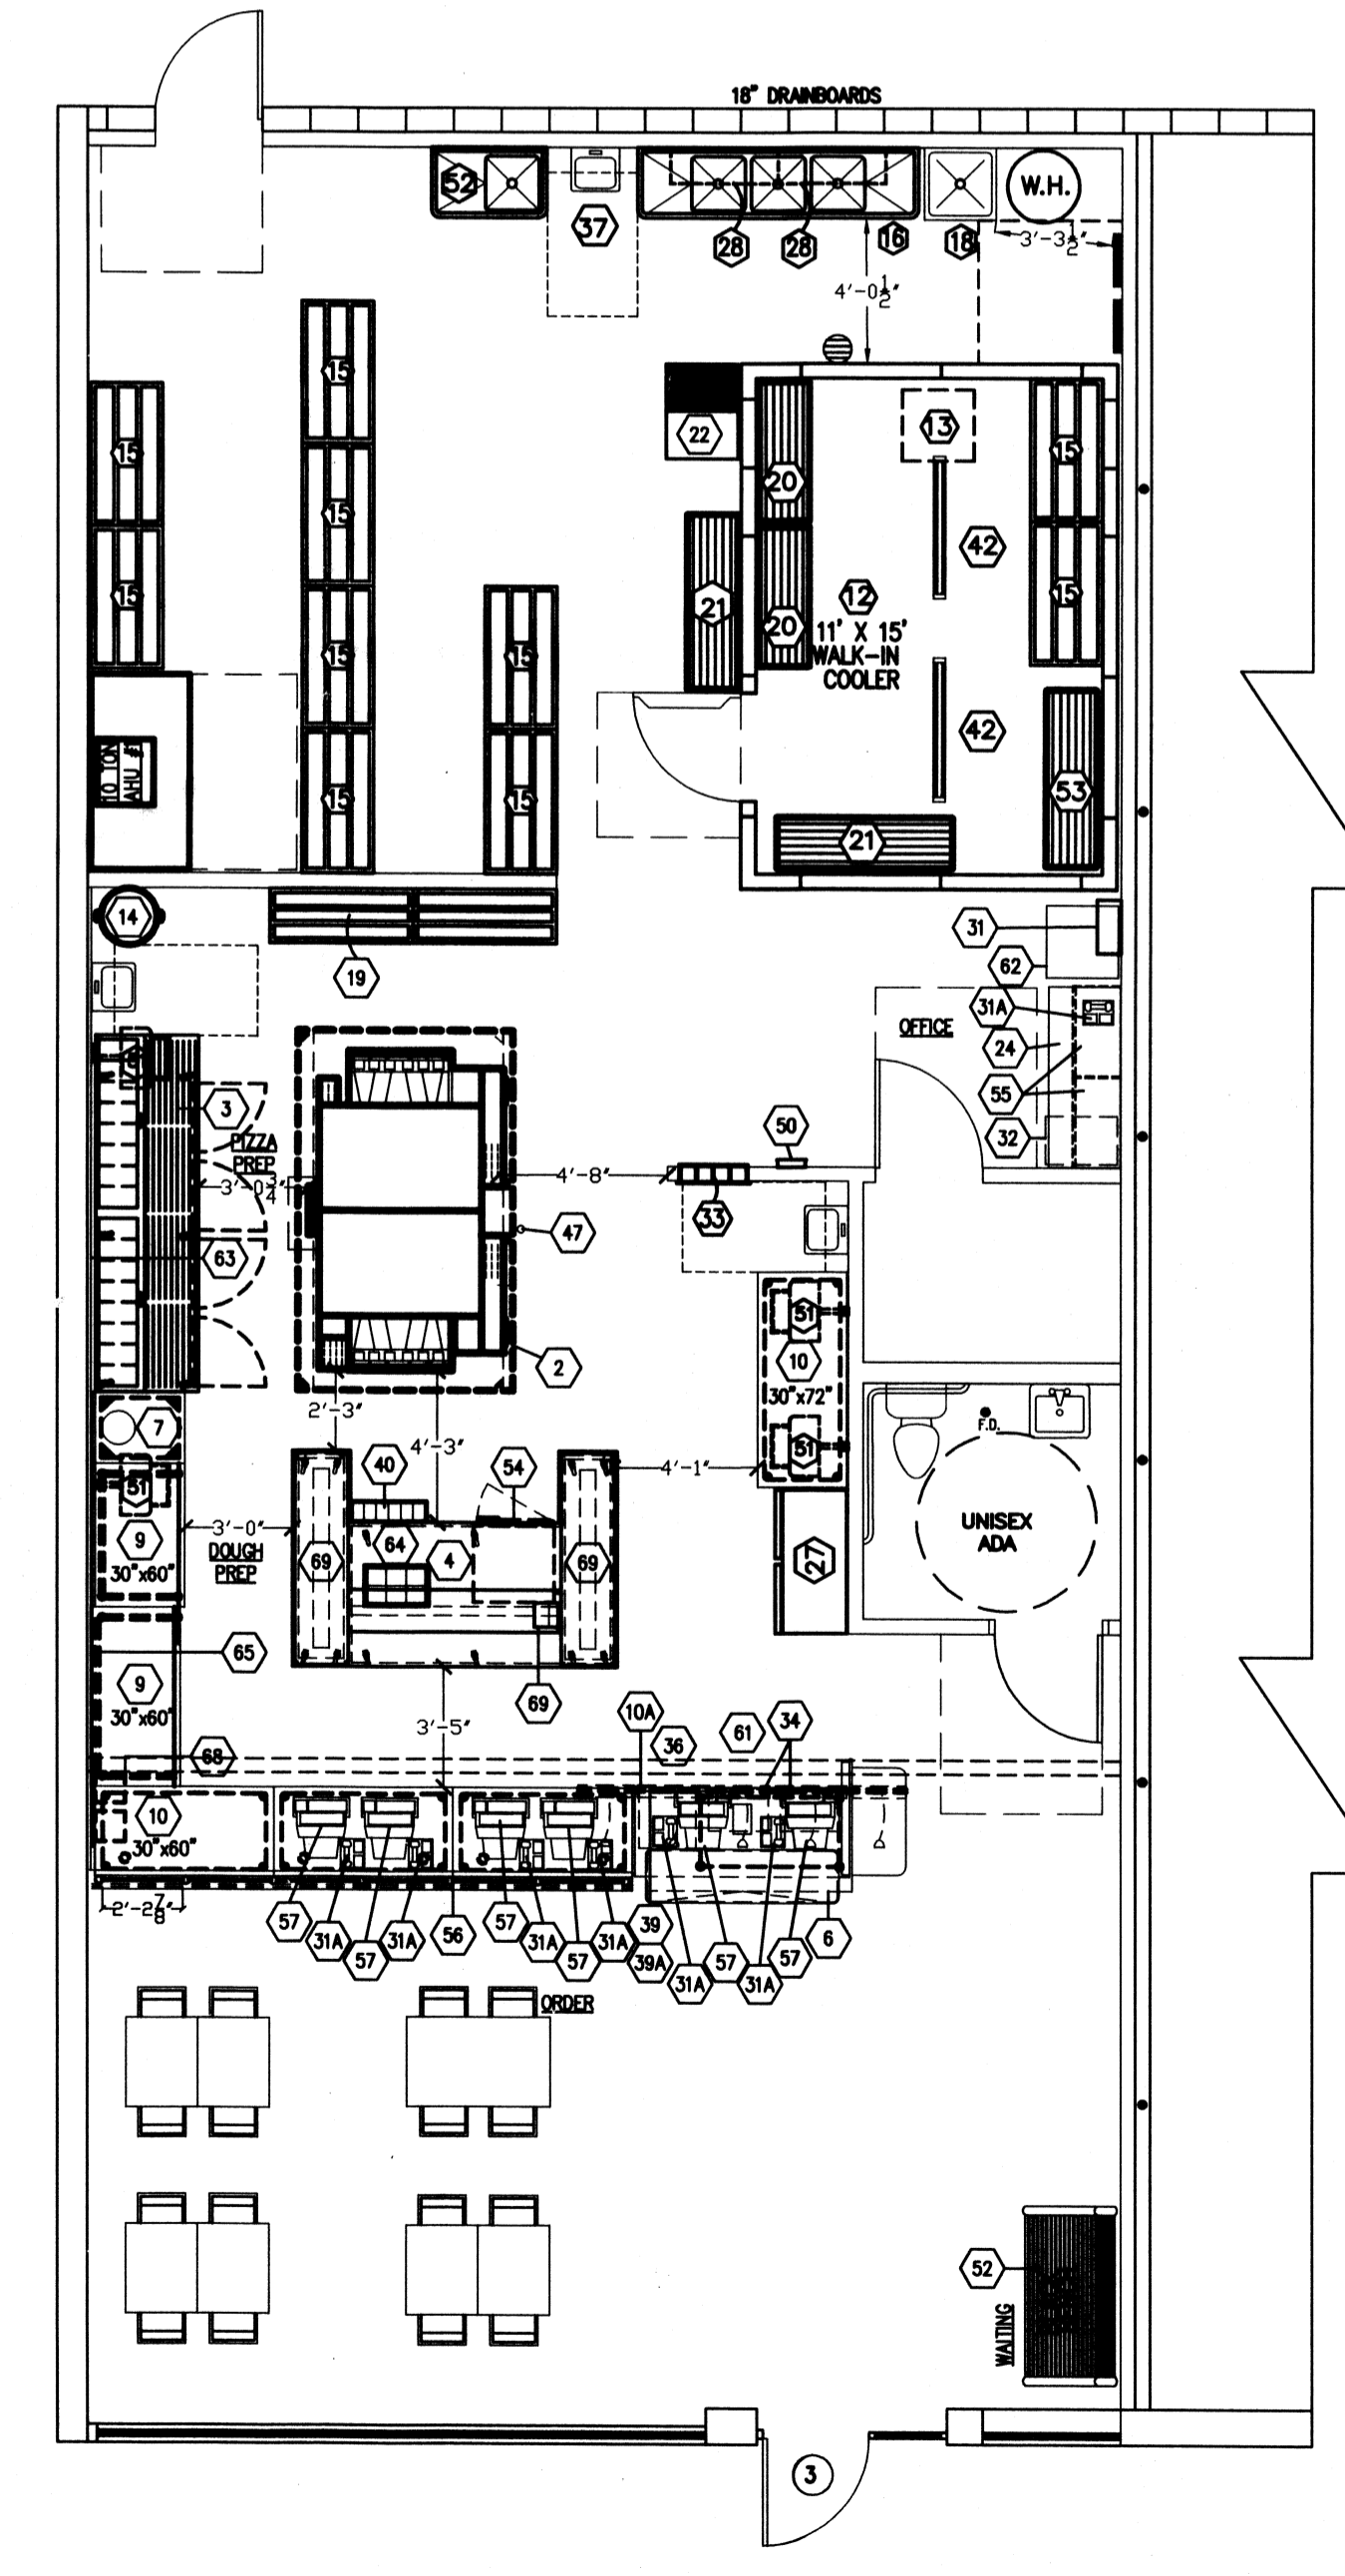

EQUIPMENT PLAN
SCALE: 3/16" = 1'-0"

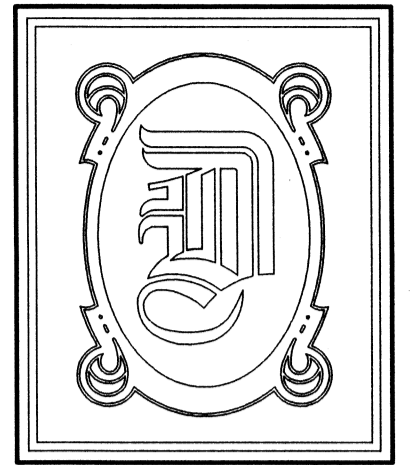

DAMMON ENGINEERING, INC.

CHIEF ENGINEER
EMMETT DAMMON, P.E.

CHIEF ARCHITECT
ROBERT WILTSE

554 OLD SPANISH TRAIL
SLIDELL, LA. 70458
OFFICE: 985-649-5832
FAX: 985-641-5950

WEBSITE:
WWW.DAMMONENGINEERING.COM
EMAIL:
DAMMONENG@BELLSOUTH.NET

ARCHITECTURE
ENGINEERING
STUDIES
PLANNING
INVESTIGATION
EXPERT WITNESS

PAPA JOHN'S
PIZZA
TENANT
BUILDOUT

3013 PONTCHARTRAIN DR.
SLIDELL
LOUISIANA

APPROVED 70458
8/18/11

EQUIPMENT
PLAN

REV:

SCALE: AS NOTED
JOB#: 2119
DATE: 8/12/2011
SHEET 3

A-2

DF 10