




\$18,000
 70 KW
 89x34x48
 1764 # lbs.
 962 cu ft gas fr

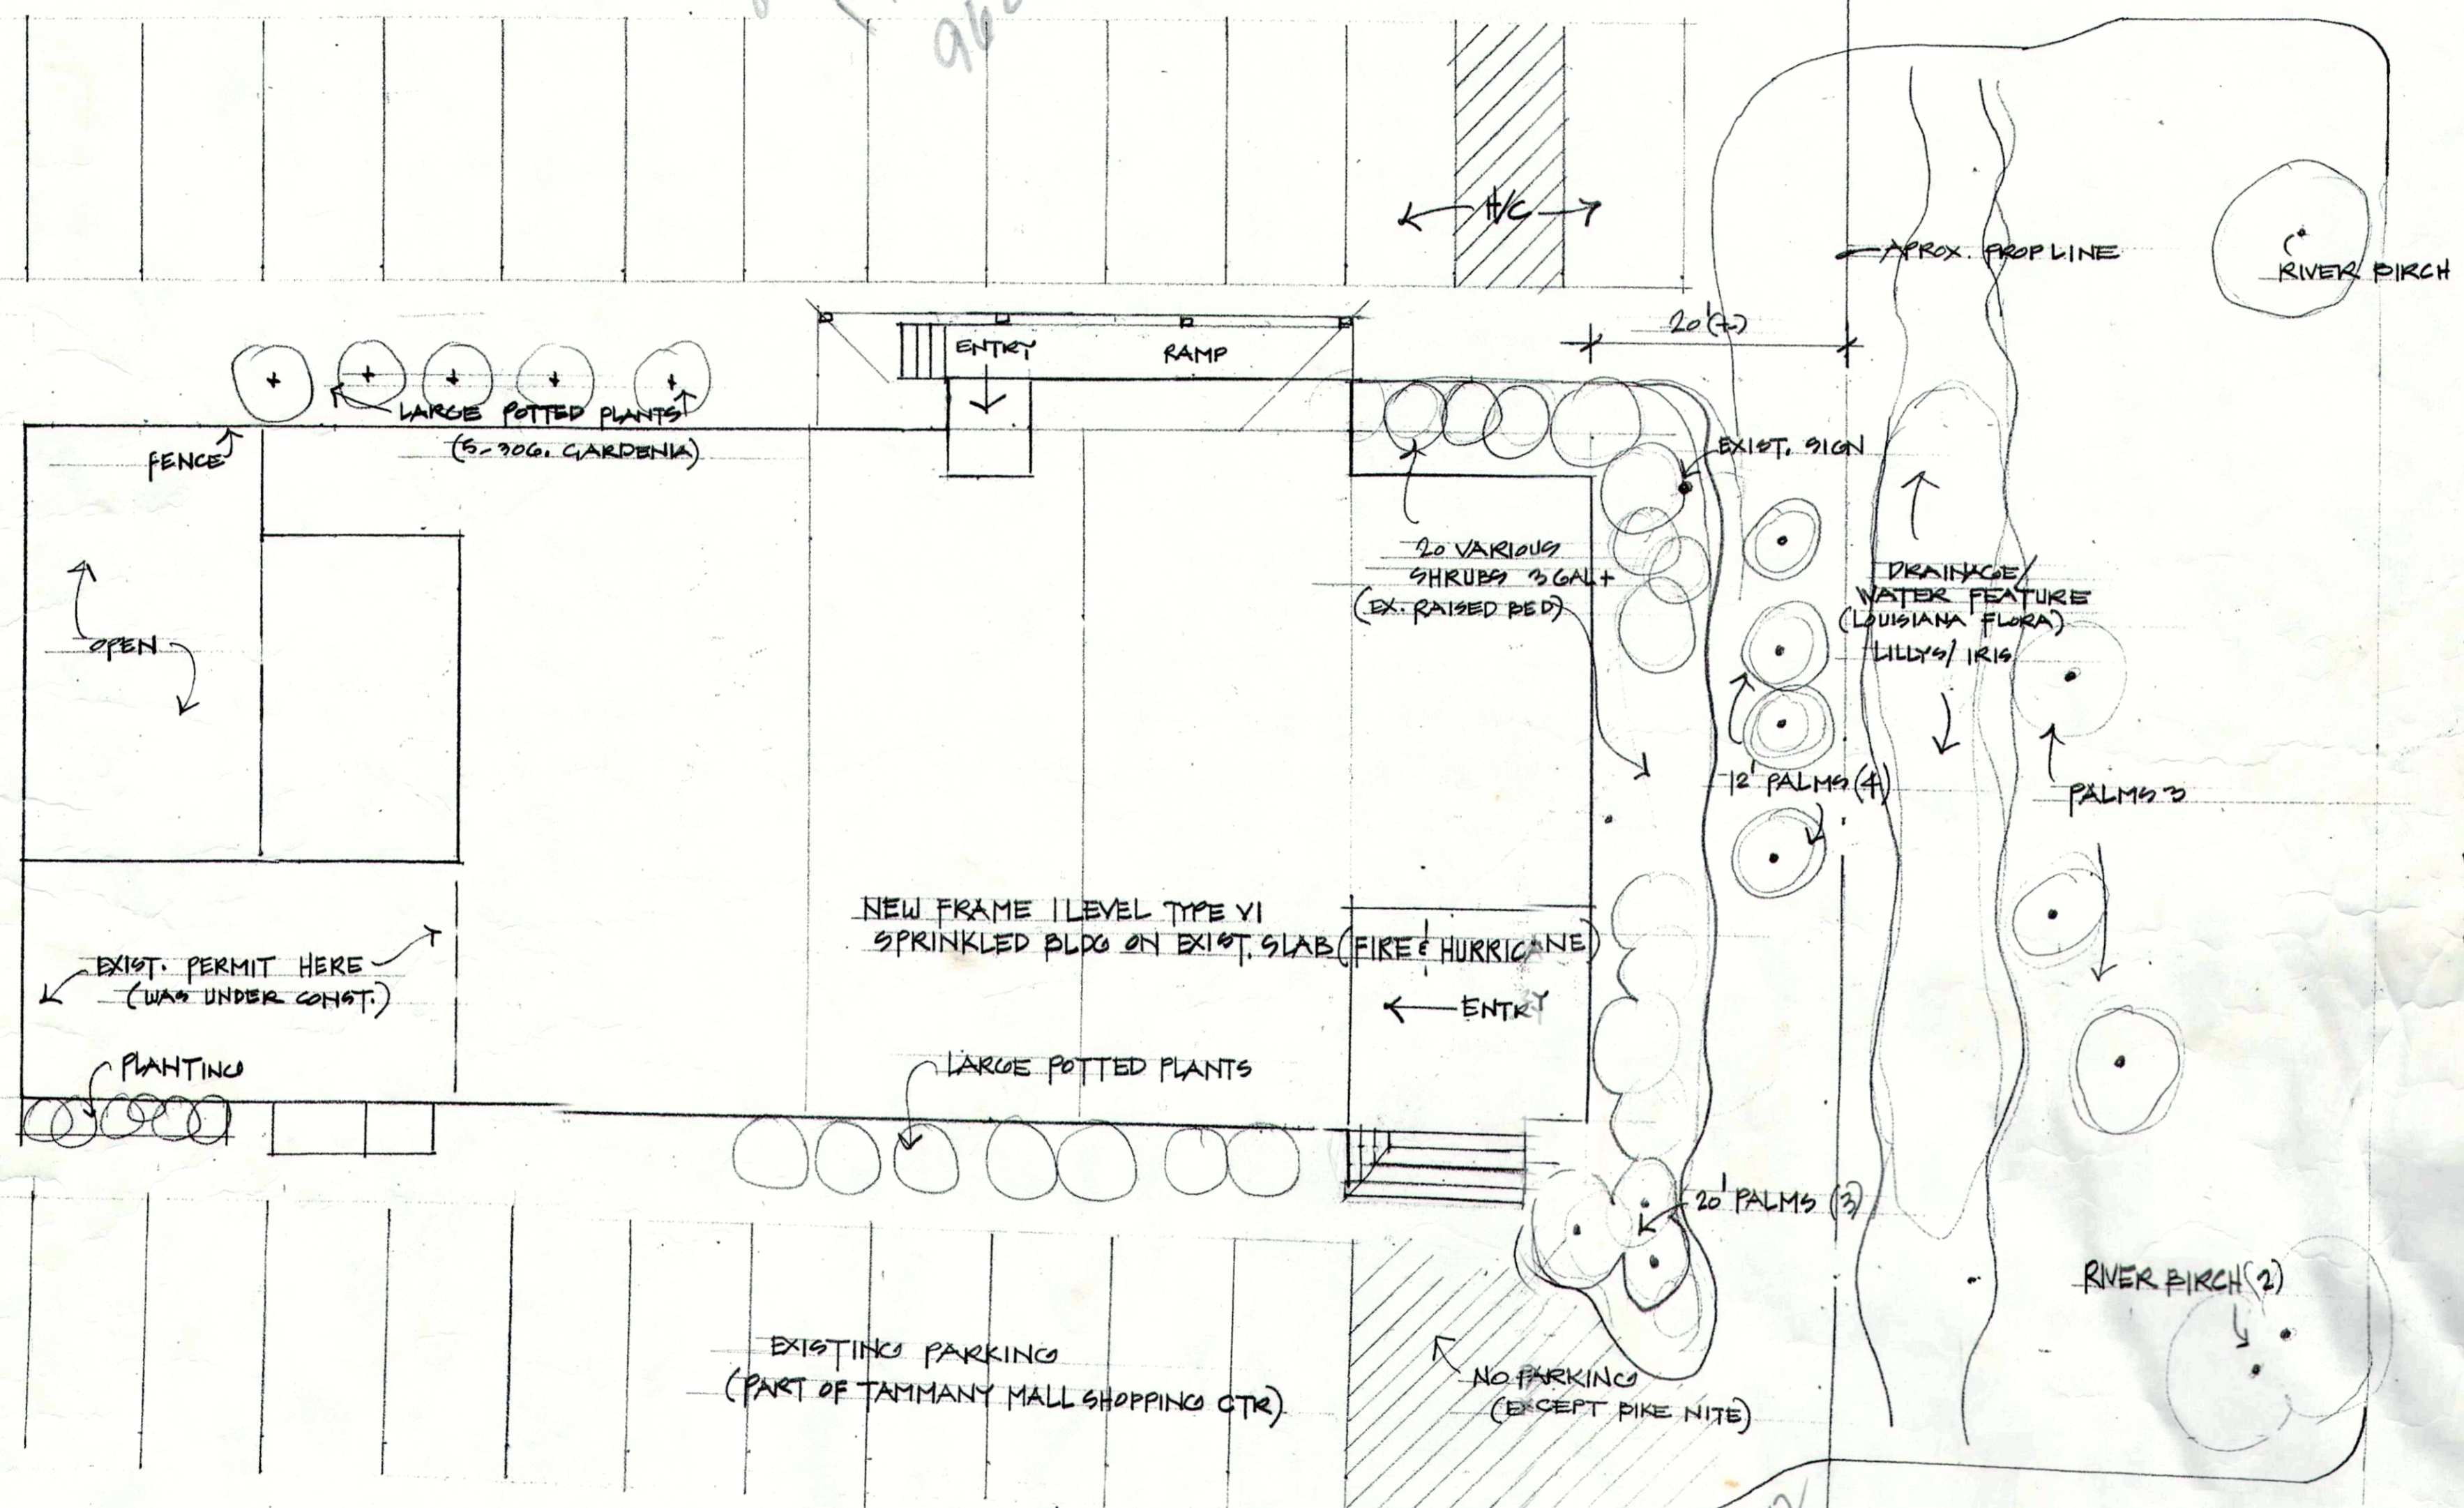





SITE PLAN 11/10/01

225-202-0912


SOUTHSIDE CAFE		3154 PONTCHARTRAIN DR. SLIDE L	
SCALE: NOV 05	DATE: NOV 05	APPROVED BY:	DRAWN BY:
ROBERT SOLLBERGER ARCHITECT		150 CHAMALE DR. SLIDELL, LA 70460	
SITE		DRAWING NUMBER	

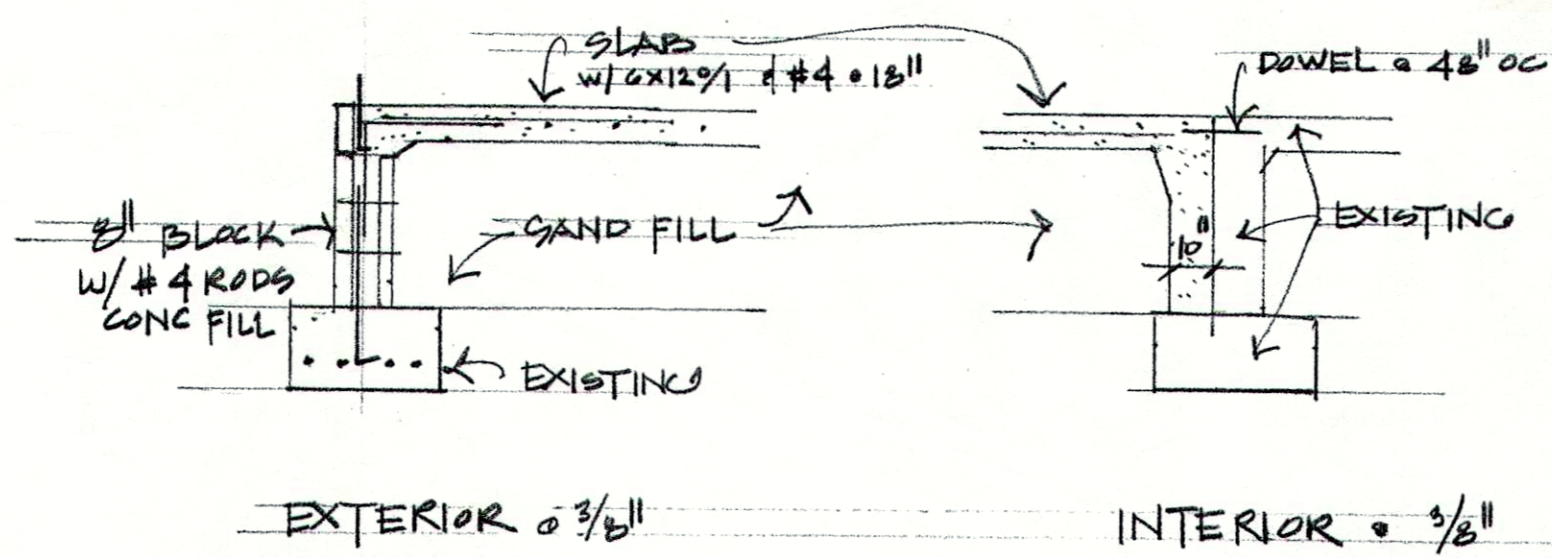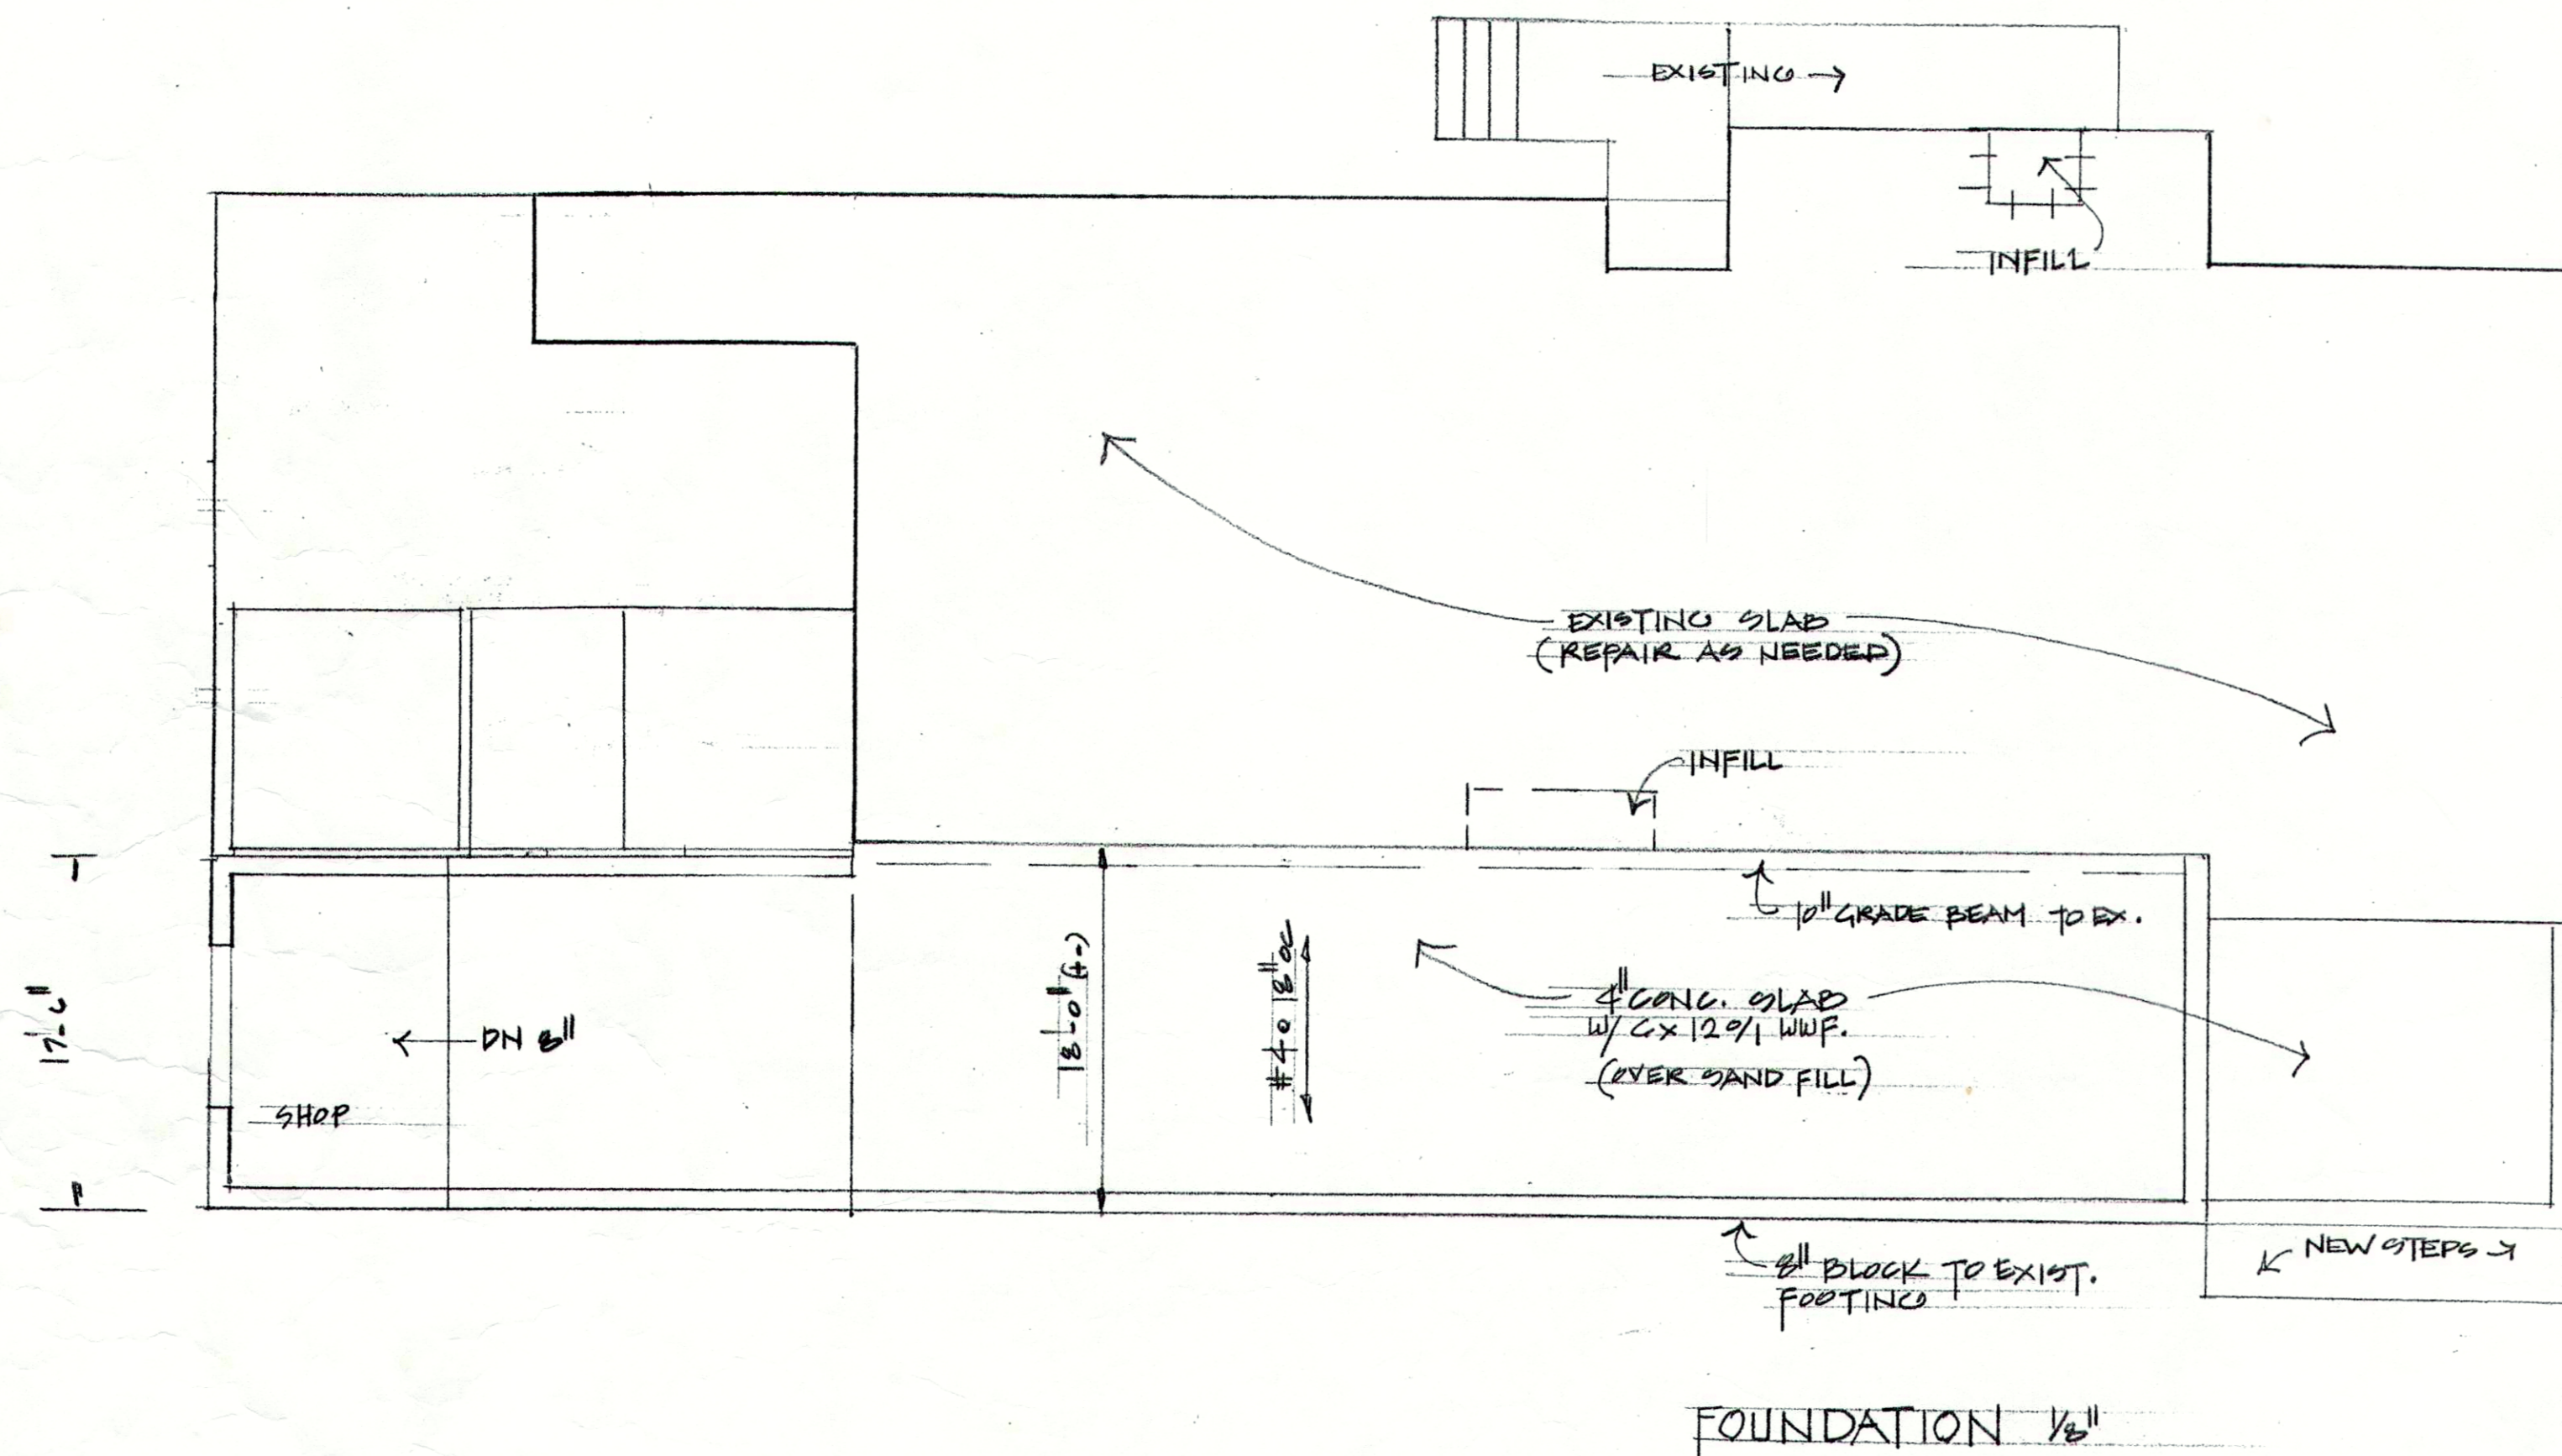

SOUTHSIDE CAFE		
3154 PONTCHARTRAIN DR SLIDELL		
SCALE:	APPROVED BY:	DRAWN BY:
DATE:		REVISED:
SOLLBERGER ARCHITECT		
		DRAWING NUMBER:

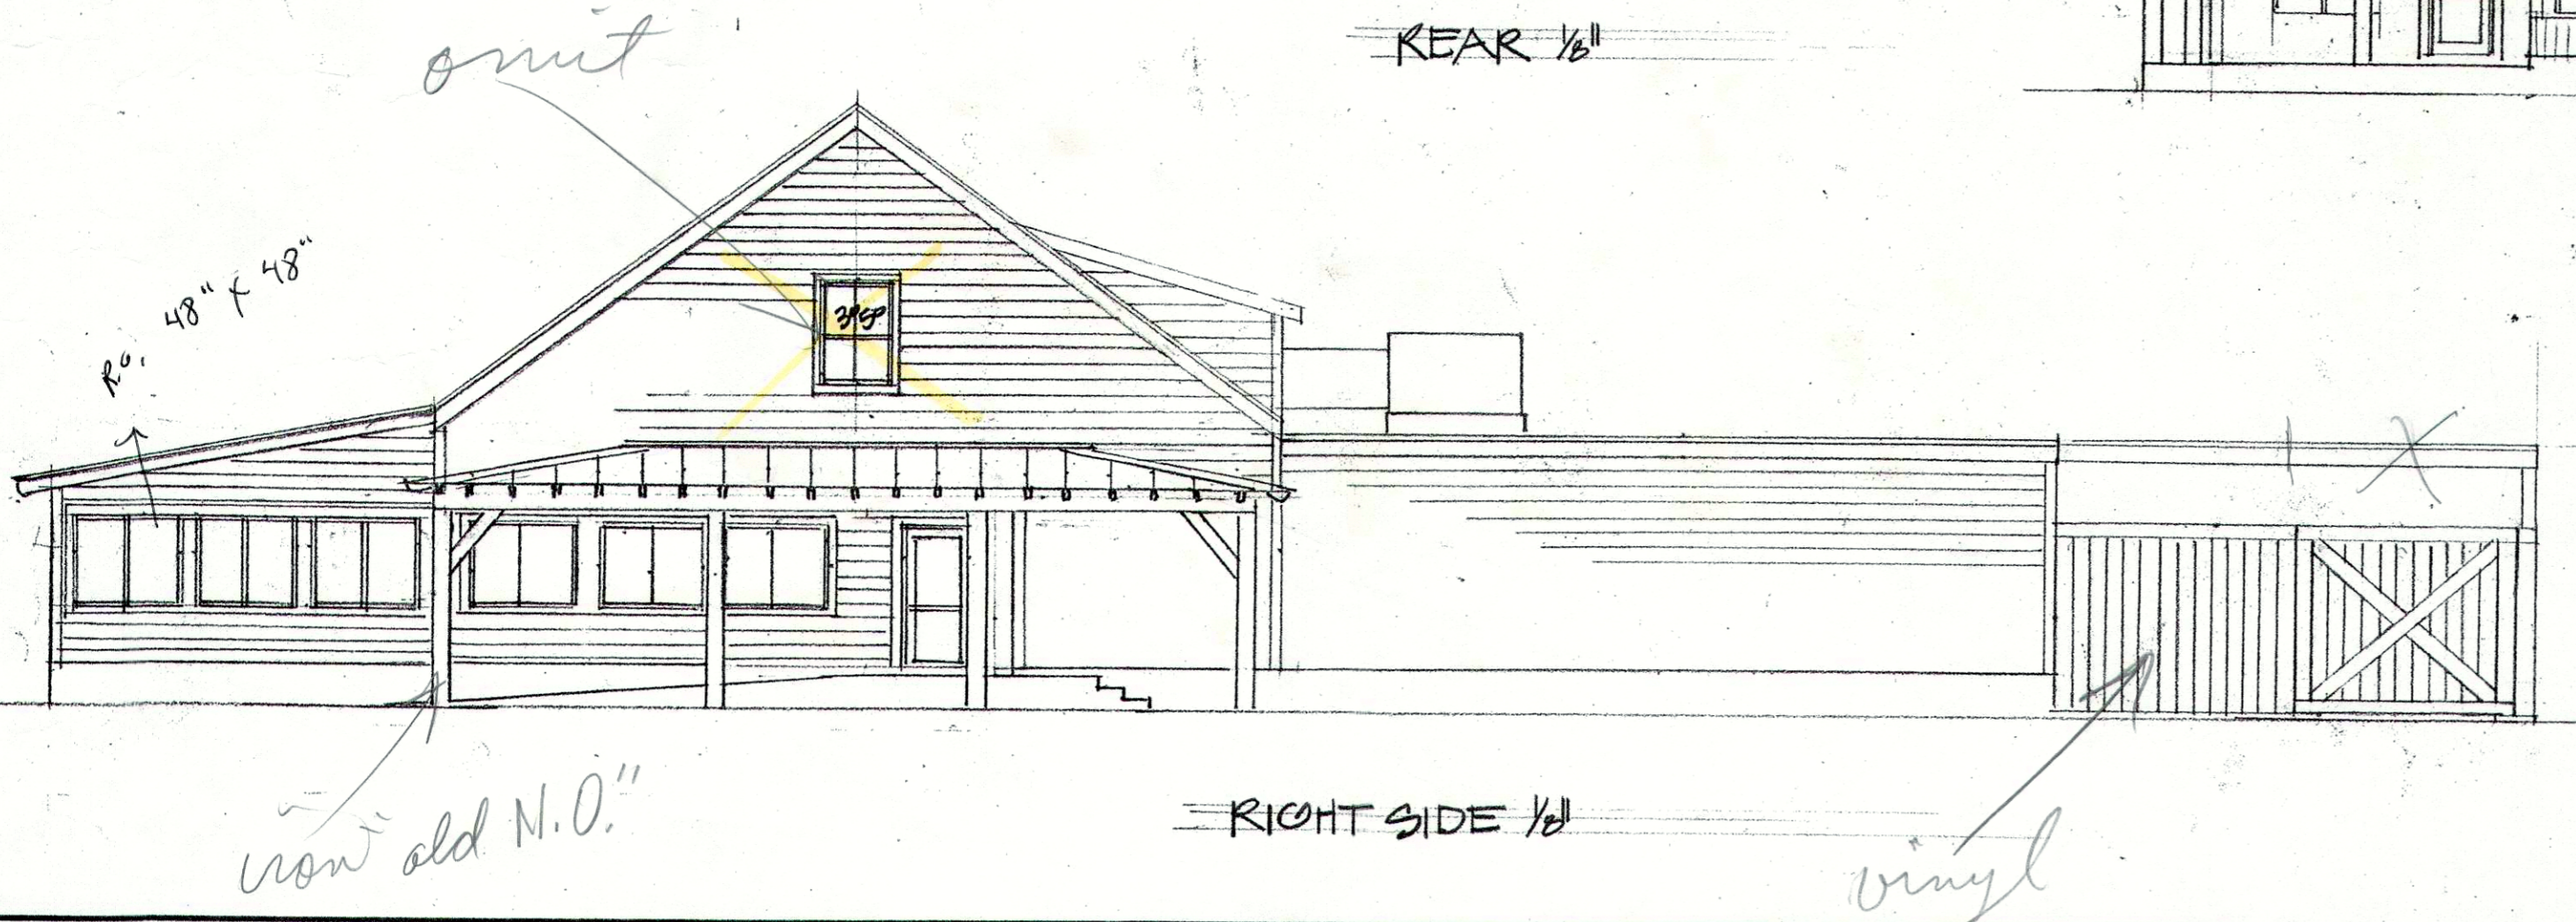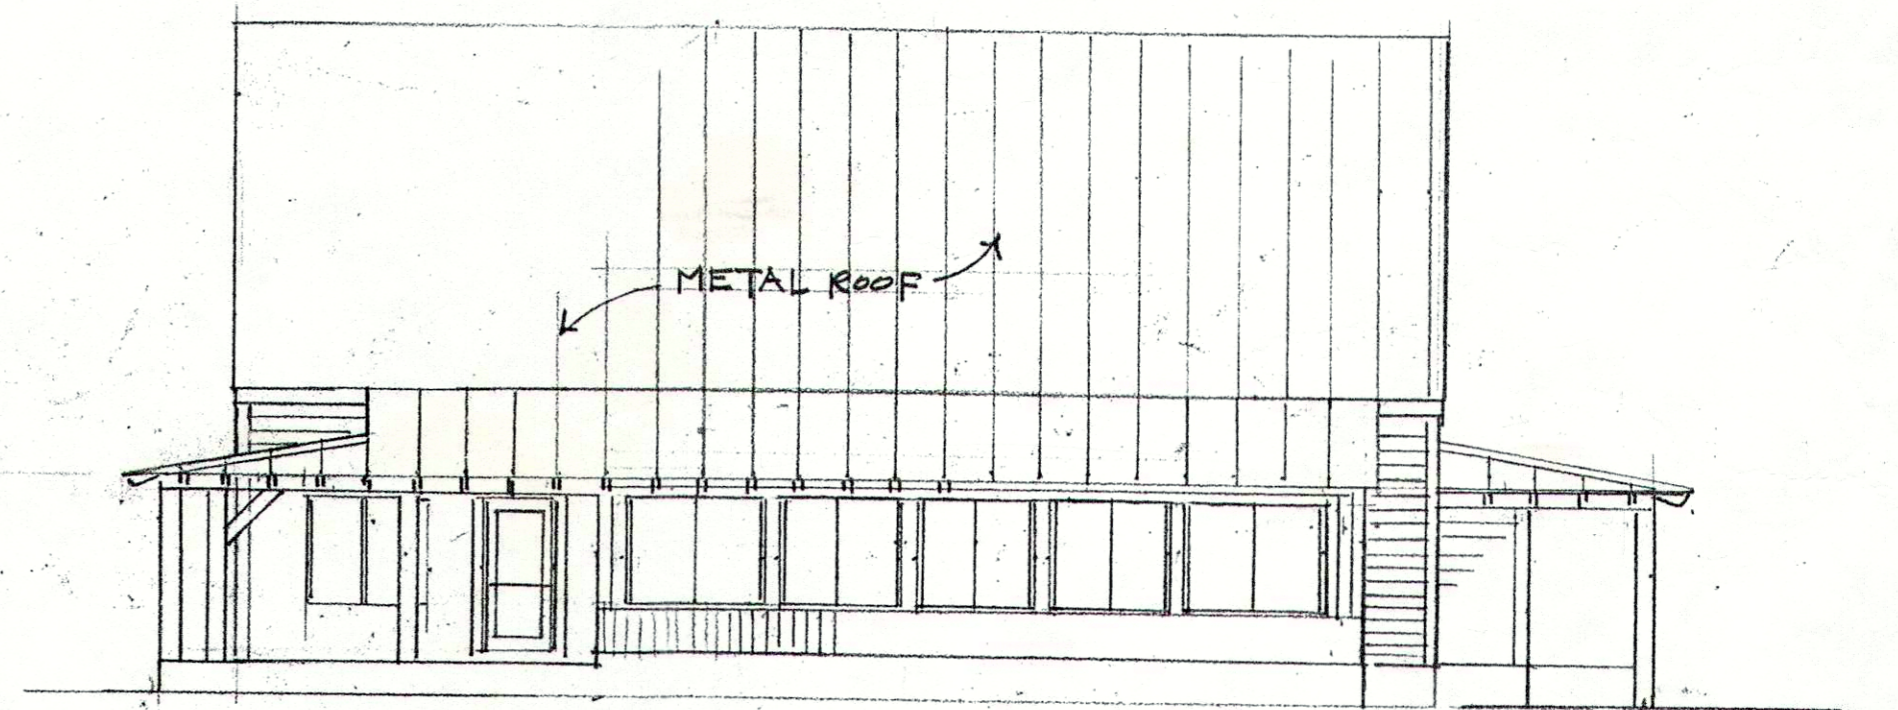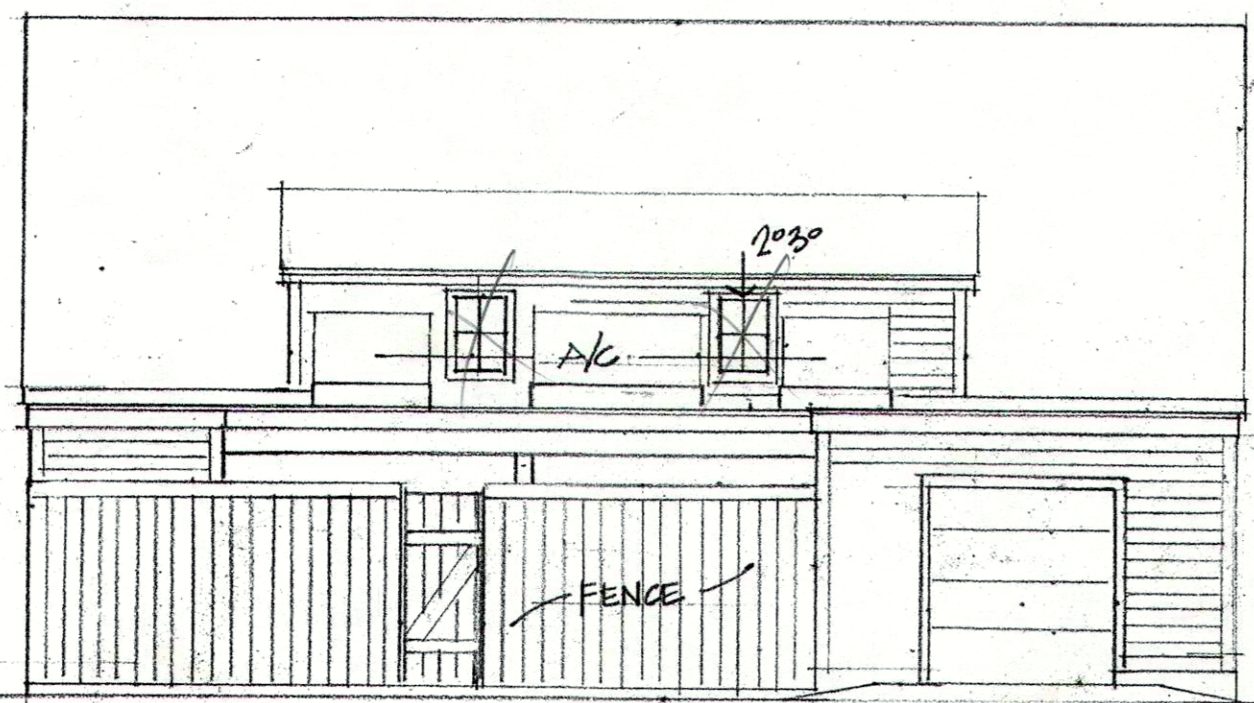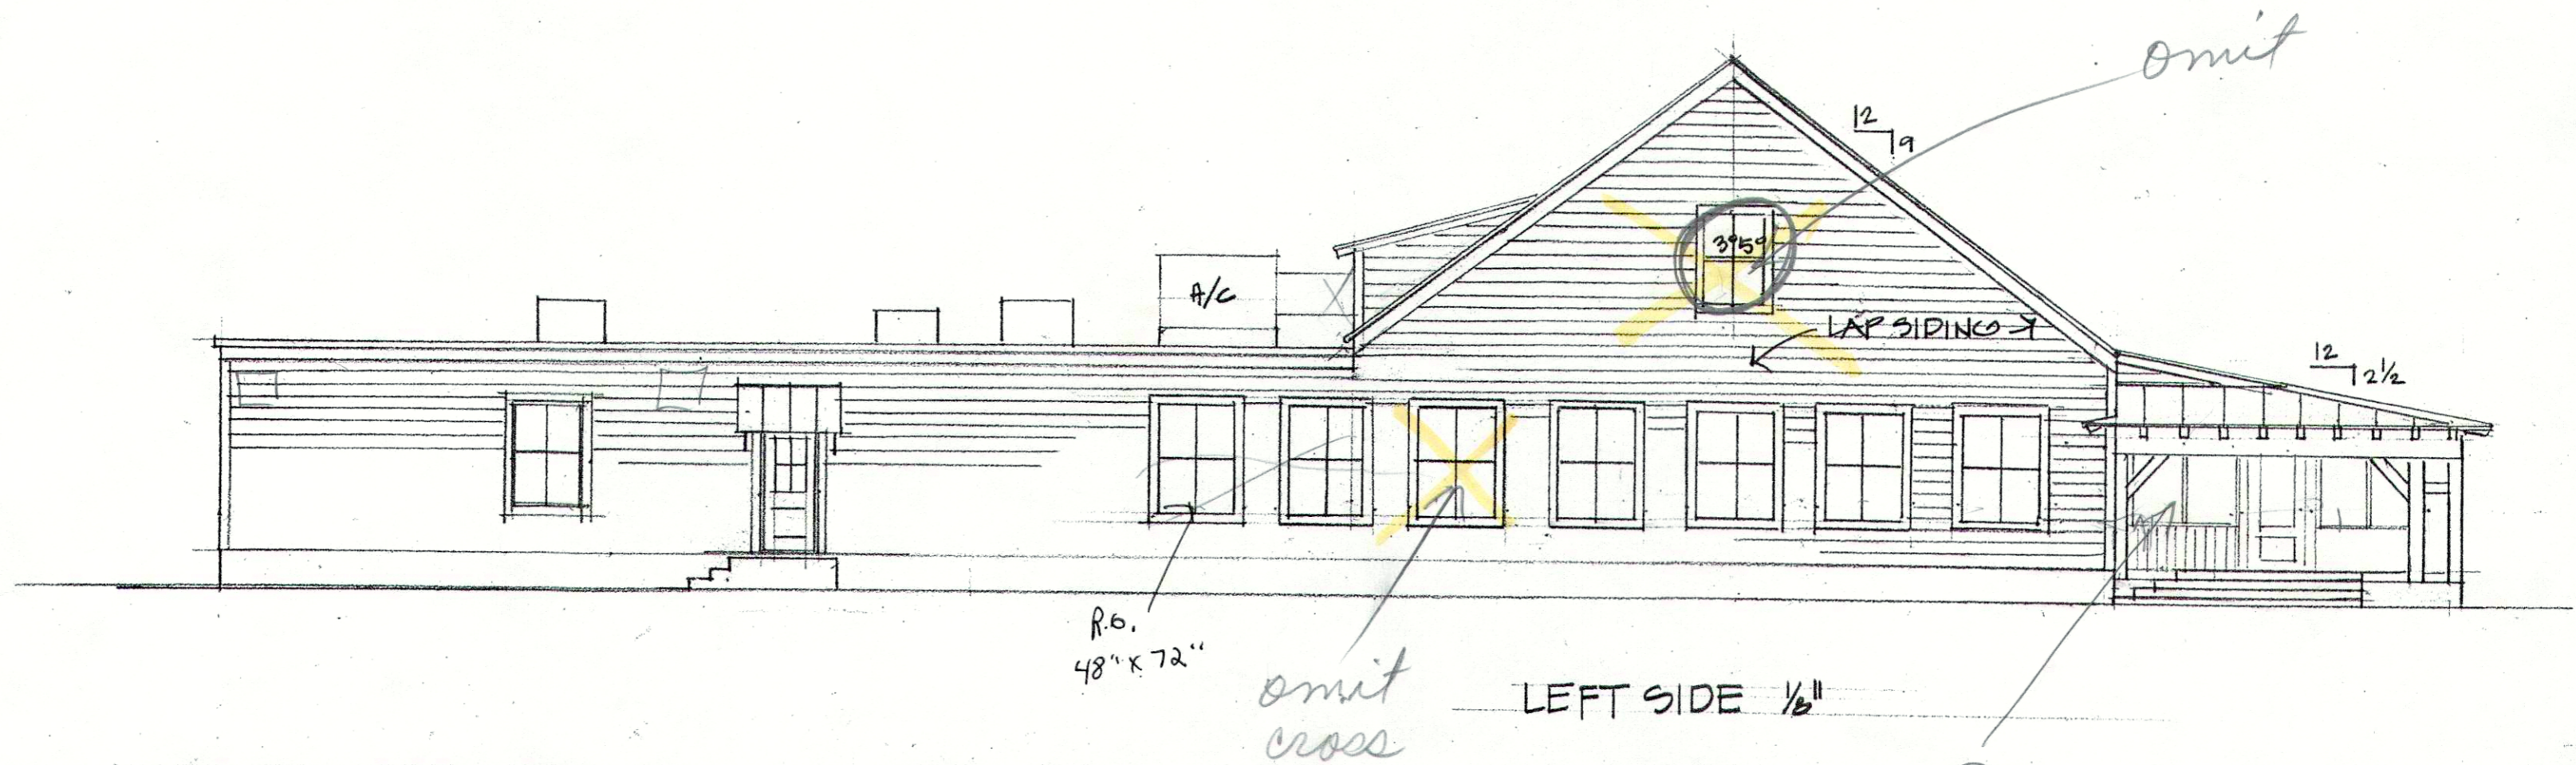


SOUTHSIDE CAFE		
SCALE:	APPROVED BY:	DRAWN BY:
DATE:		REVISED:
		DRAWING NUMBER

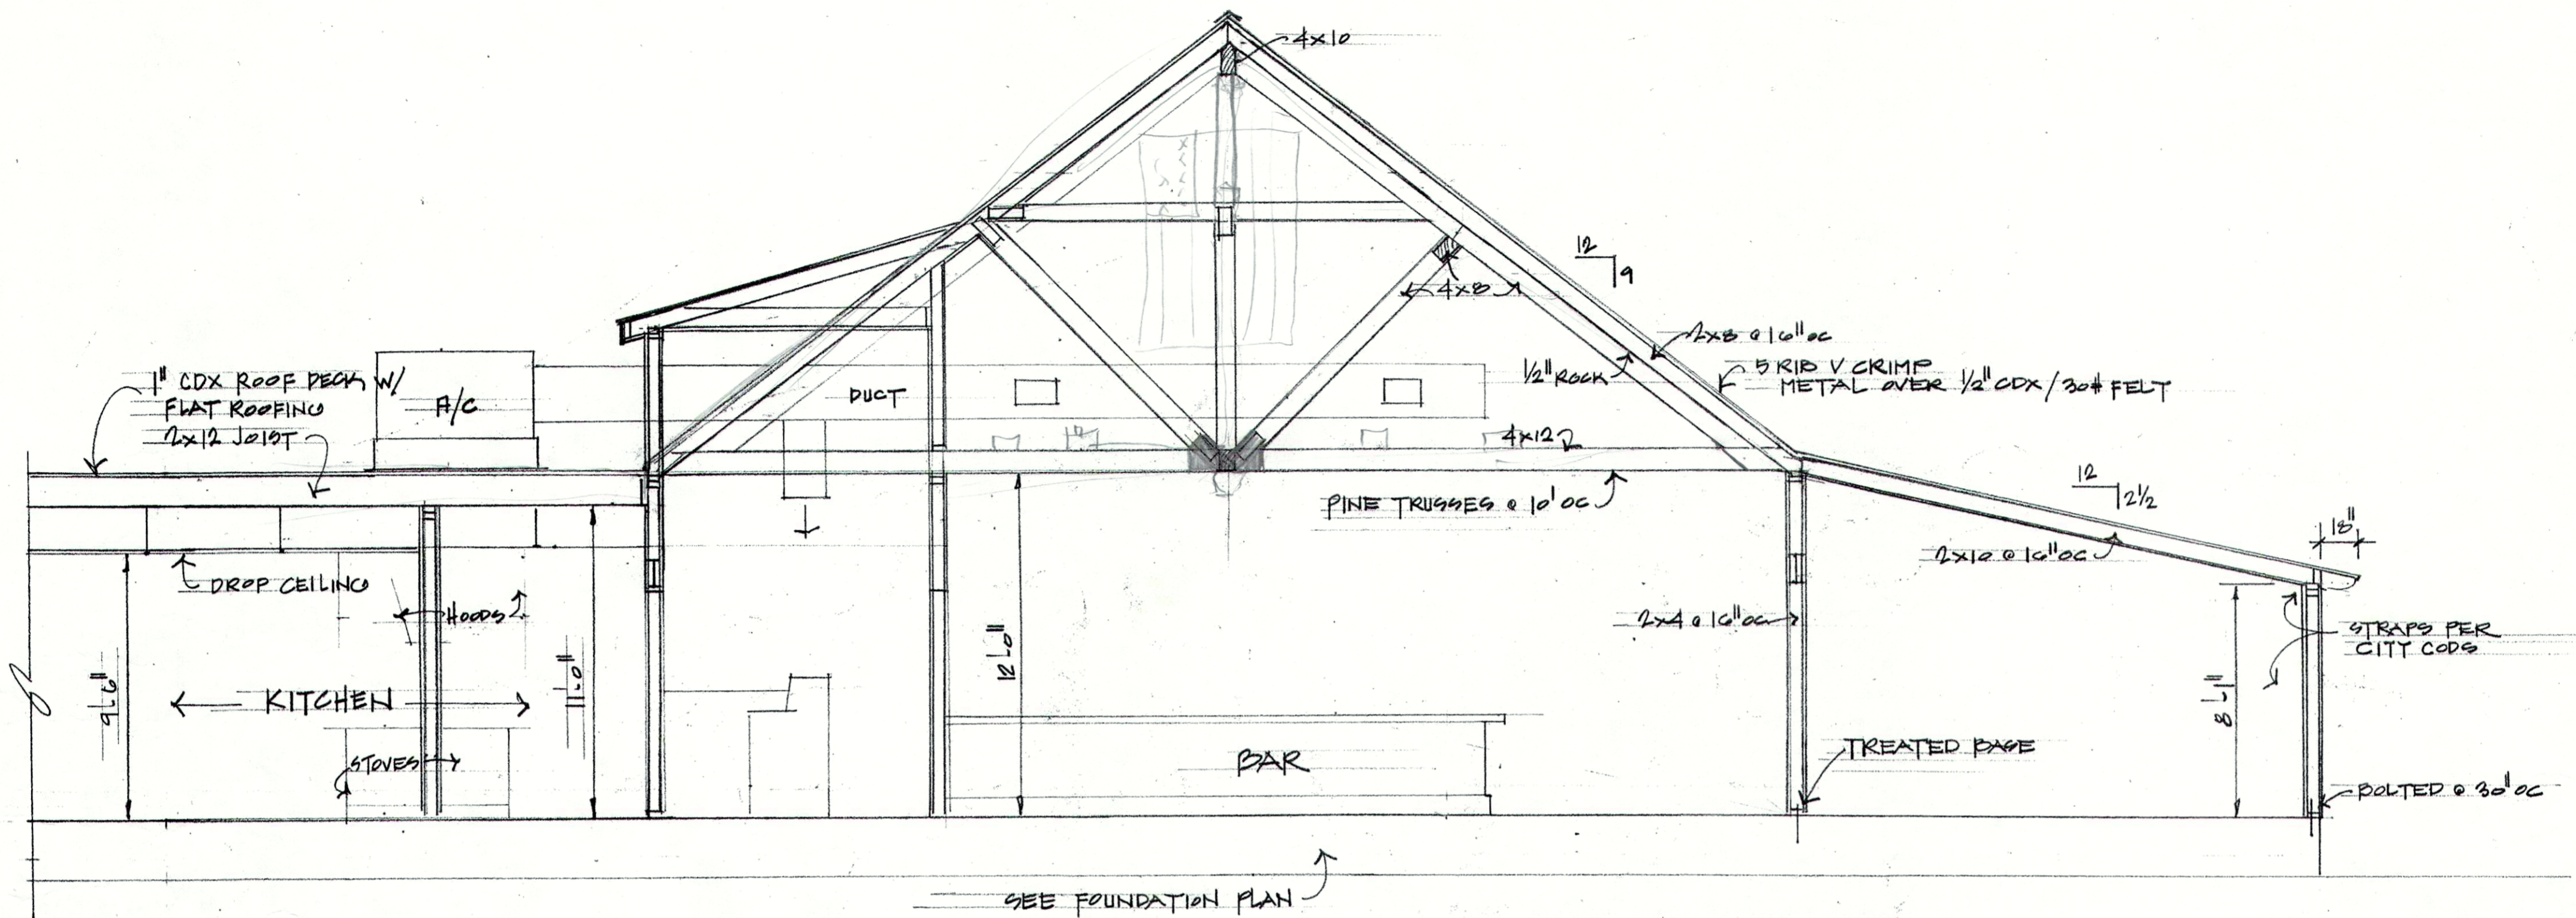

SEE FOUNDATION PLAN

SECTION 1/4" = 1'-0"




SOUTHSIDE CAFE		
SCALE:	APPROVED BY:	DRAWN BY:
DATE:		REVISED:
		DRAWING NUMBER

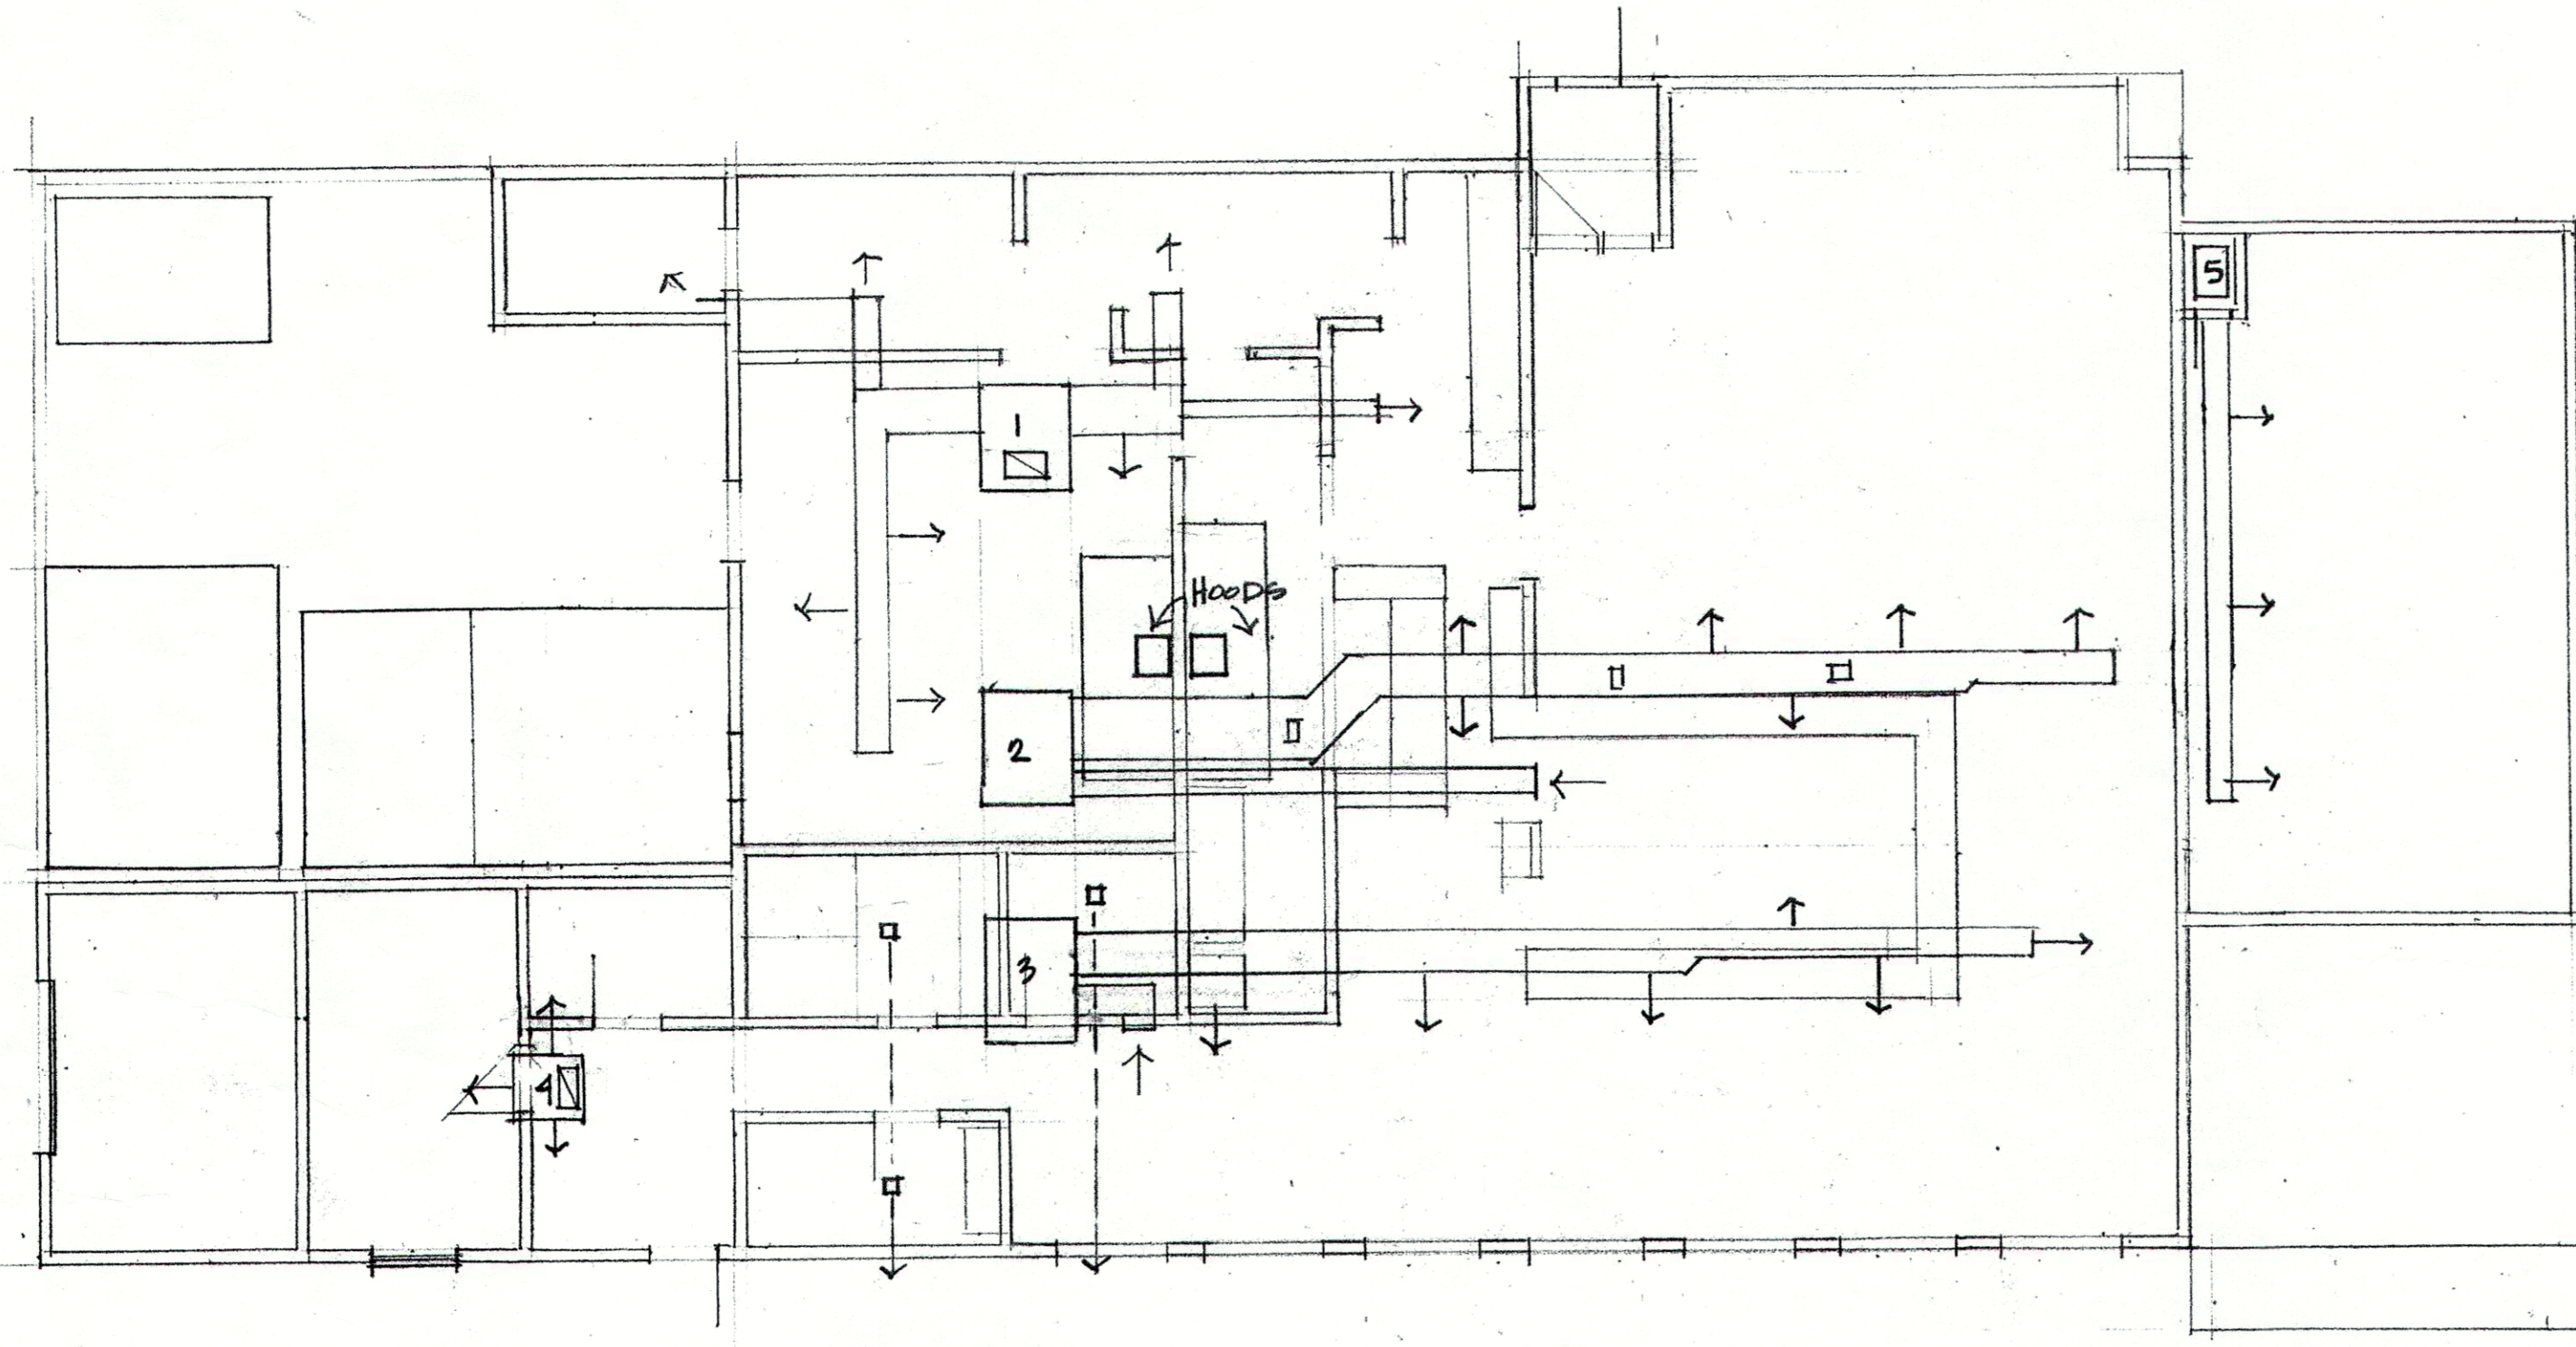

HVAC PLAN 1/8" = 1'-0"

UNIT 1	10 TON	DOWNDRAFT	GAS HT.
UNIT 2	5 "	SIDE DRAFT	"
UNIT 3	10 "	"	"
UNIT 4	2 "	DOWNDRAFT	"
UNIT 5	5 "	SPLIT UNIT	HEAT PUMP ELEC

SOUTHSIDE CAFE		
SCALE:	APPROVED BY:	DRAWN BY:
DATE:		REVISED:
		DRAWING NUMBER



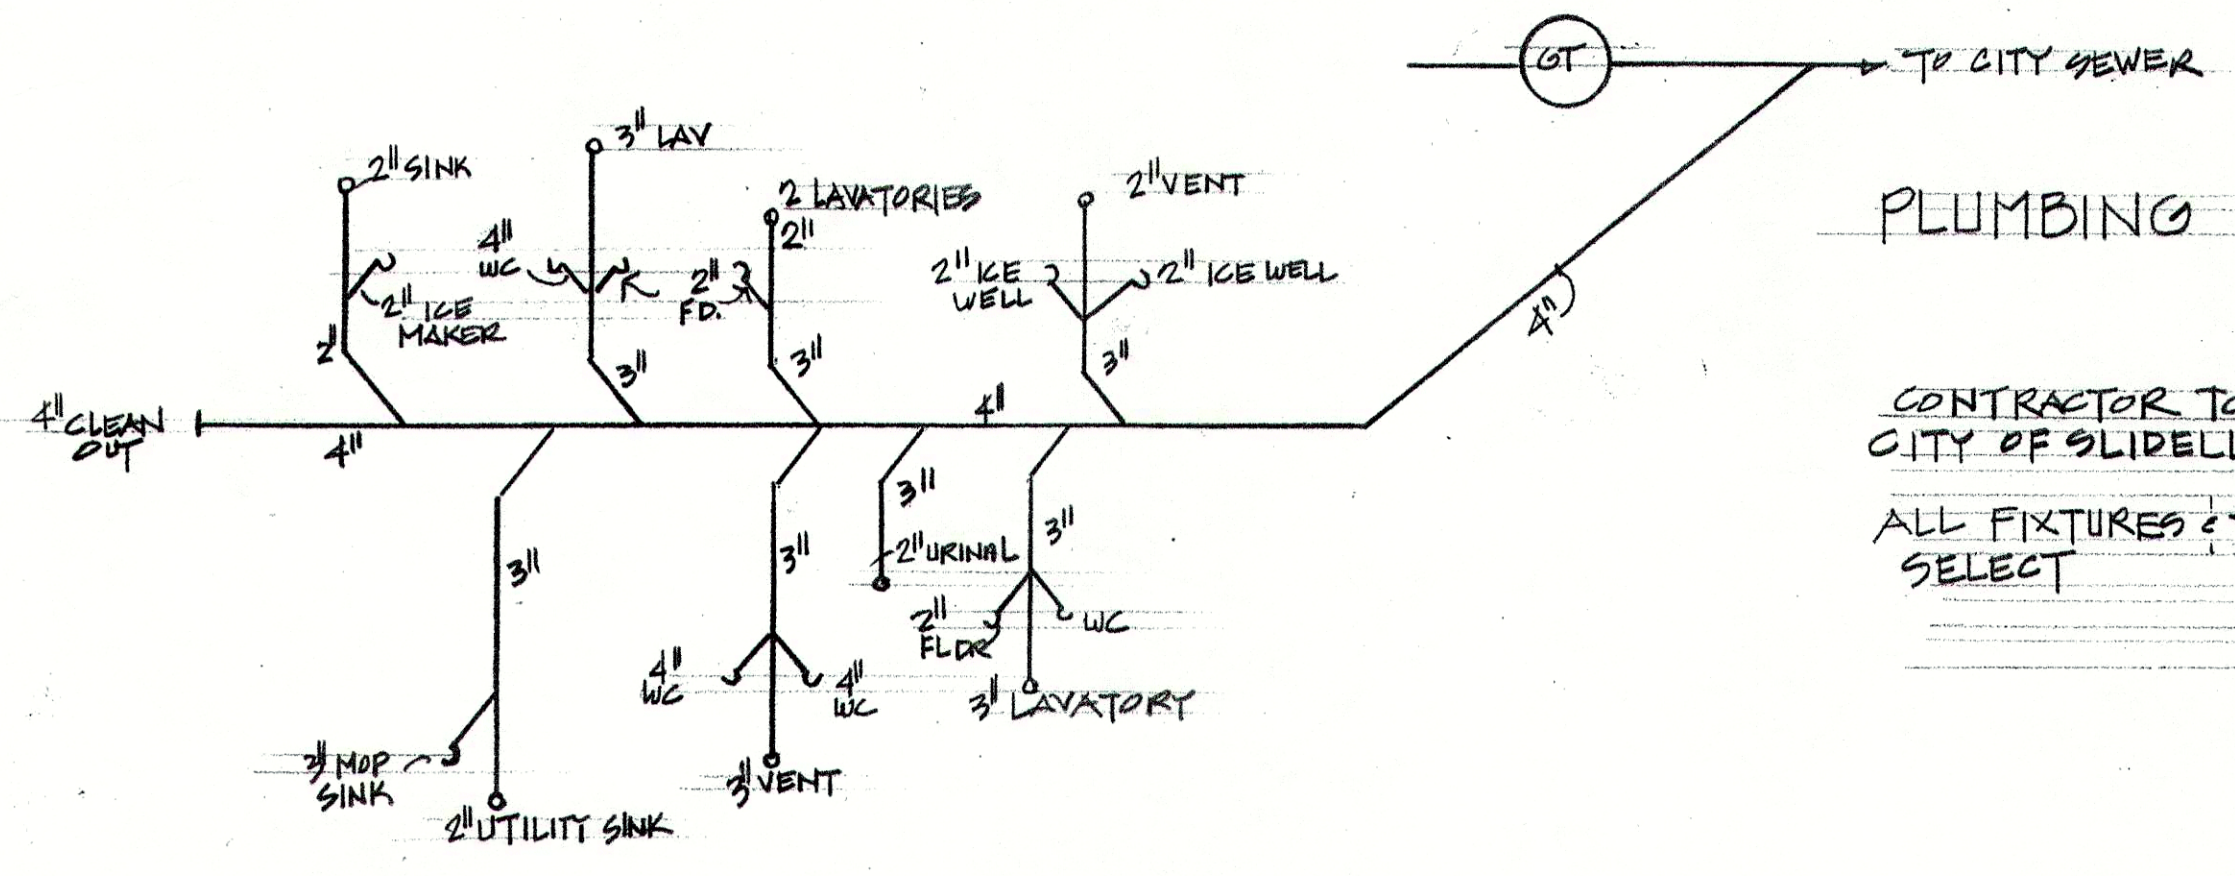
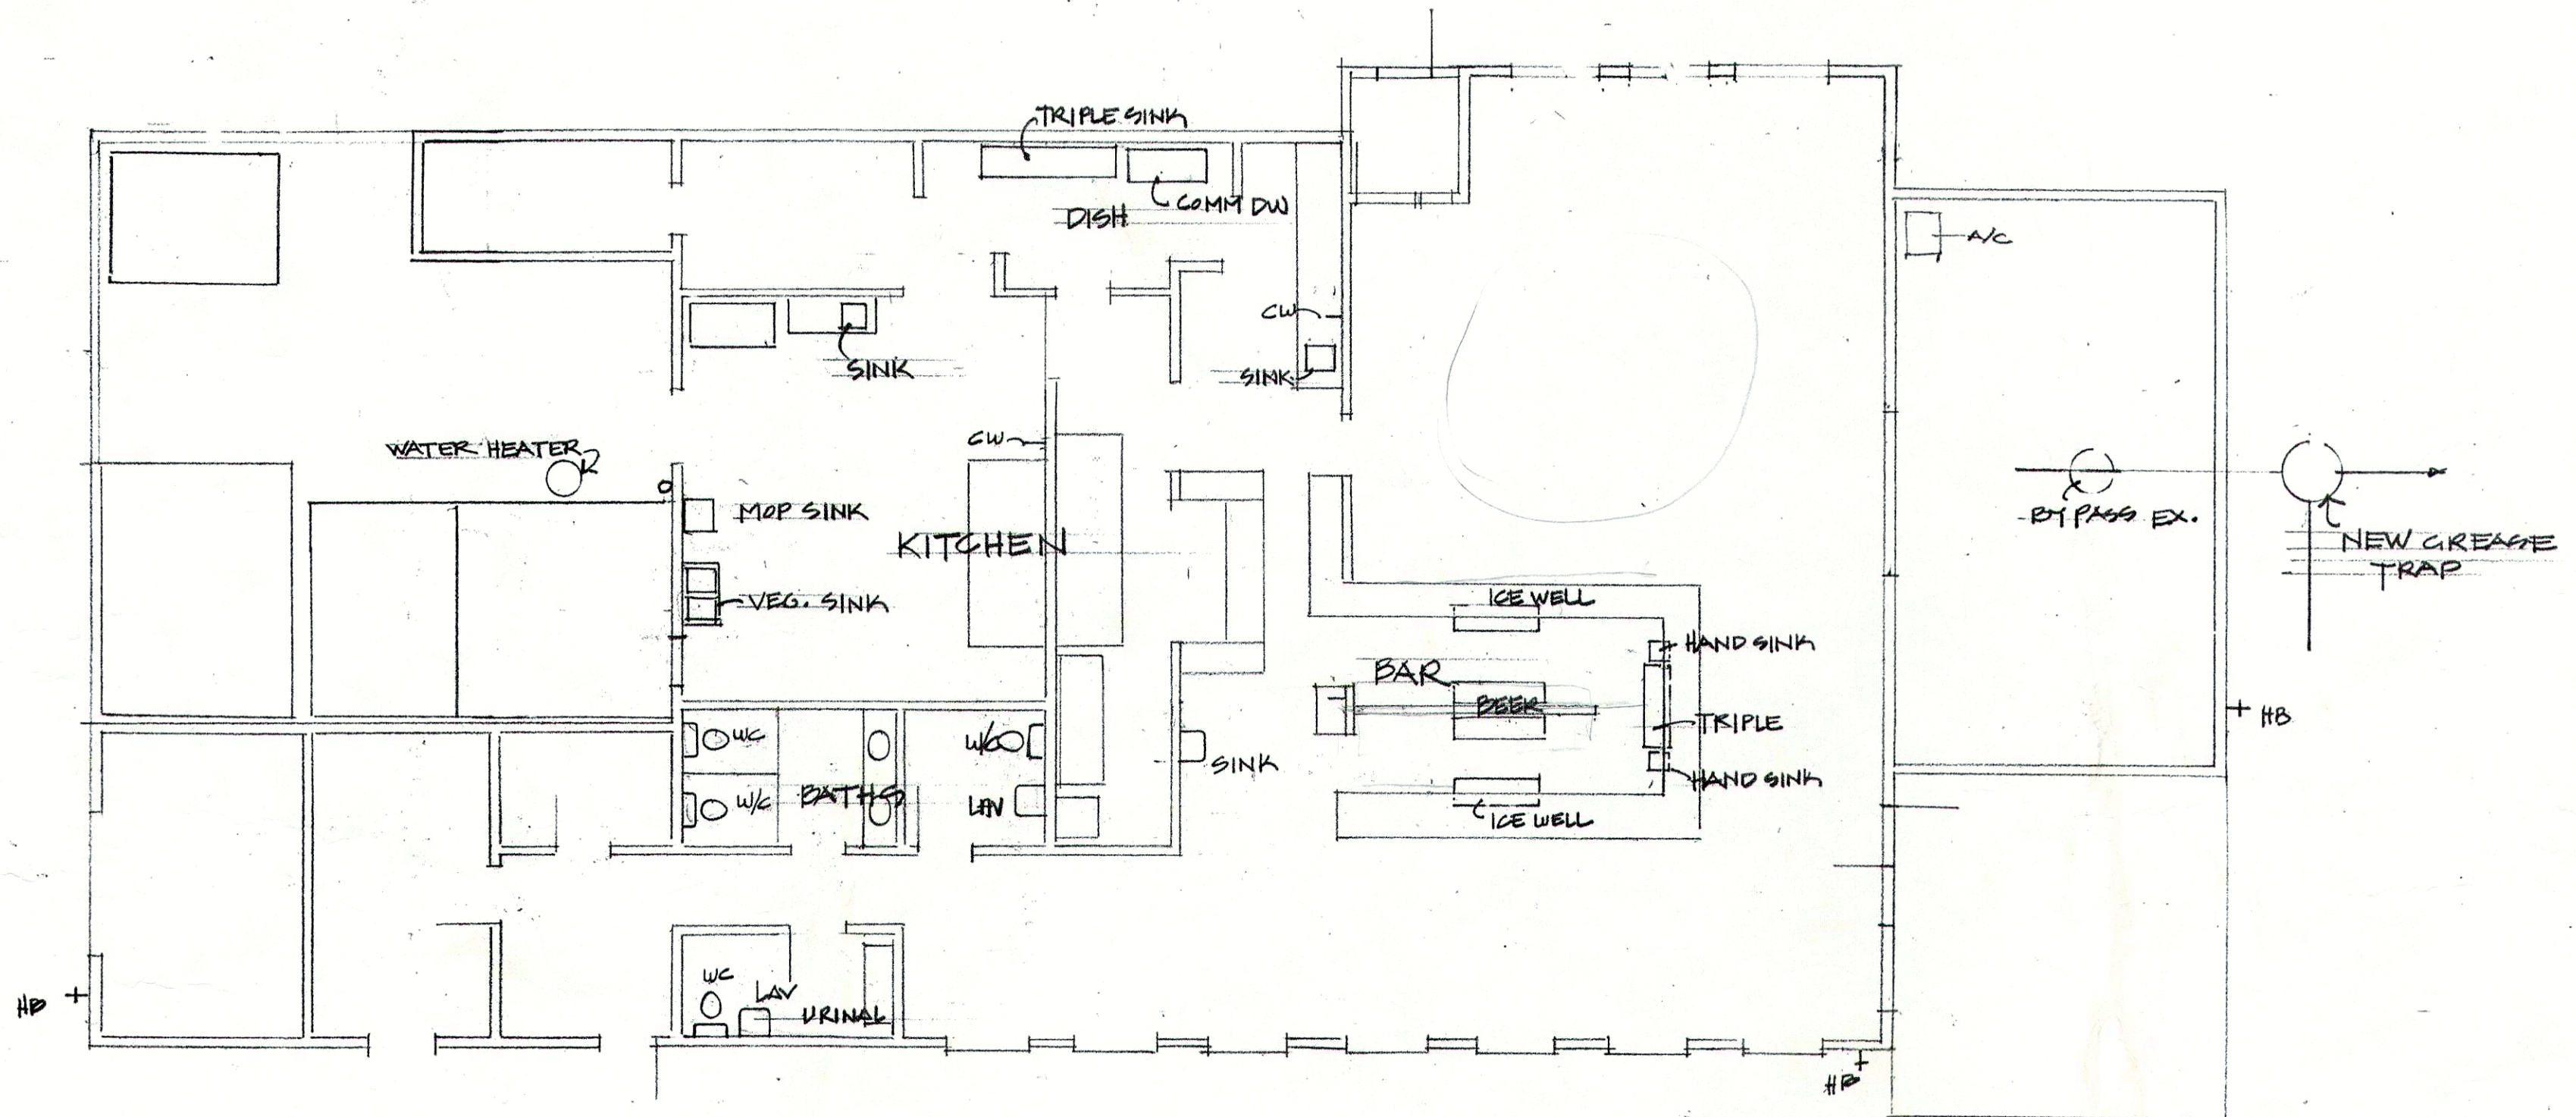
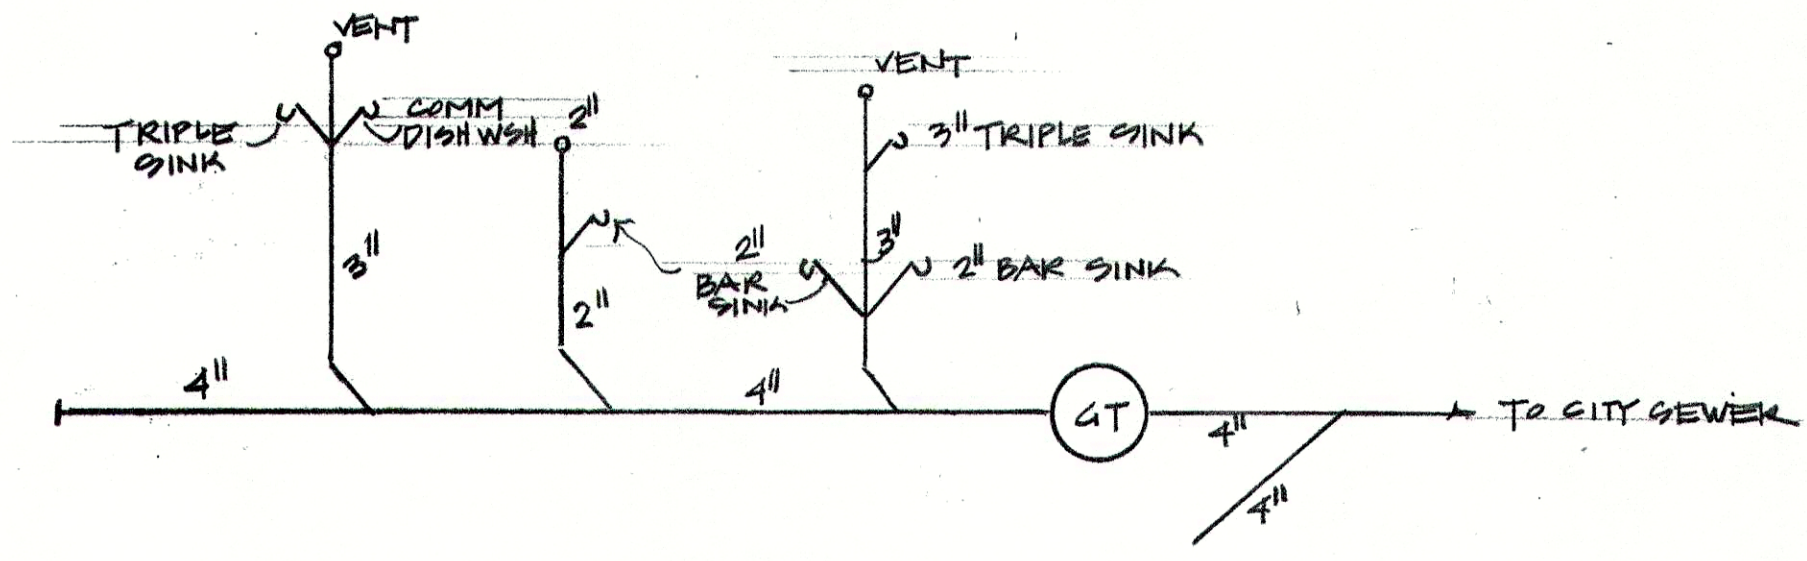


PLUMBING

CONTRACTOR TO FOLLOW ALL CITY OF SLIDELL PLUMBING CODES

ALL FIXTURES & TRIM PER OWNER SELECT

SOUTHSIDE CAFE		
SCALE:	APPROVED BY:	DRAWN BY:
DATE:		REVISED:
		DRAWING NUMBER

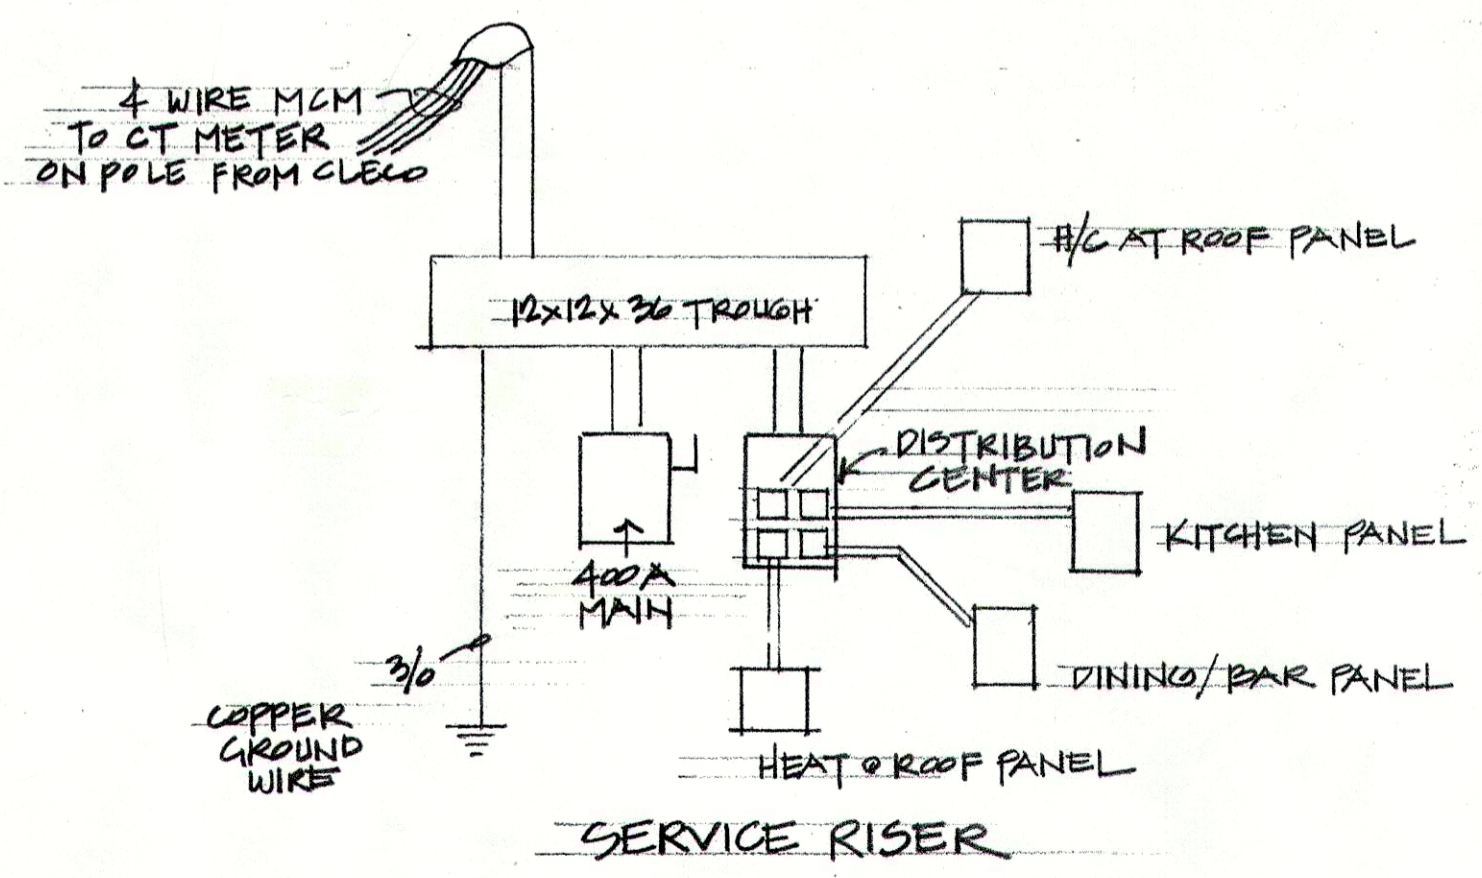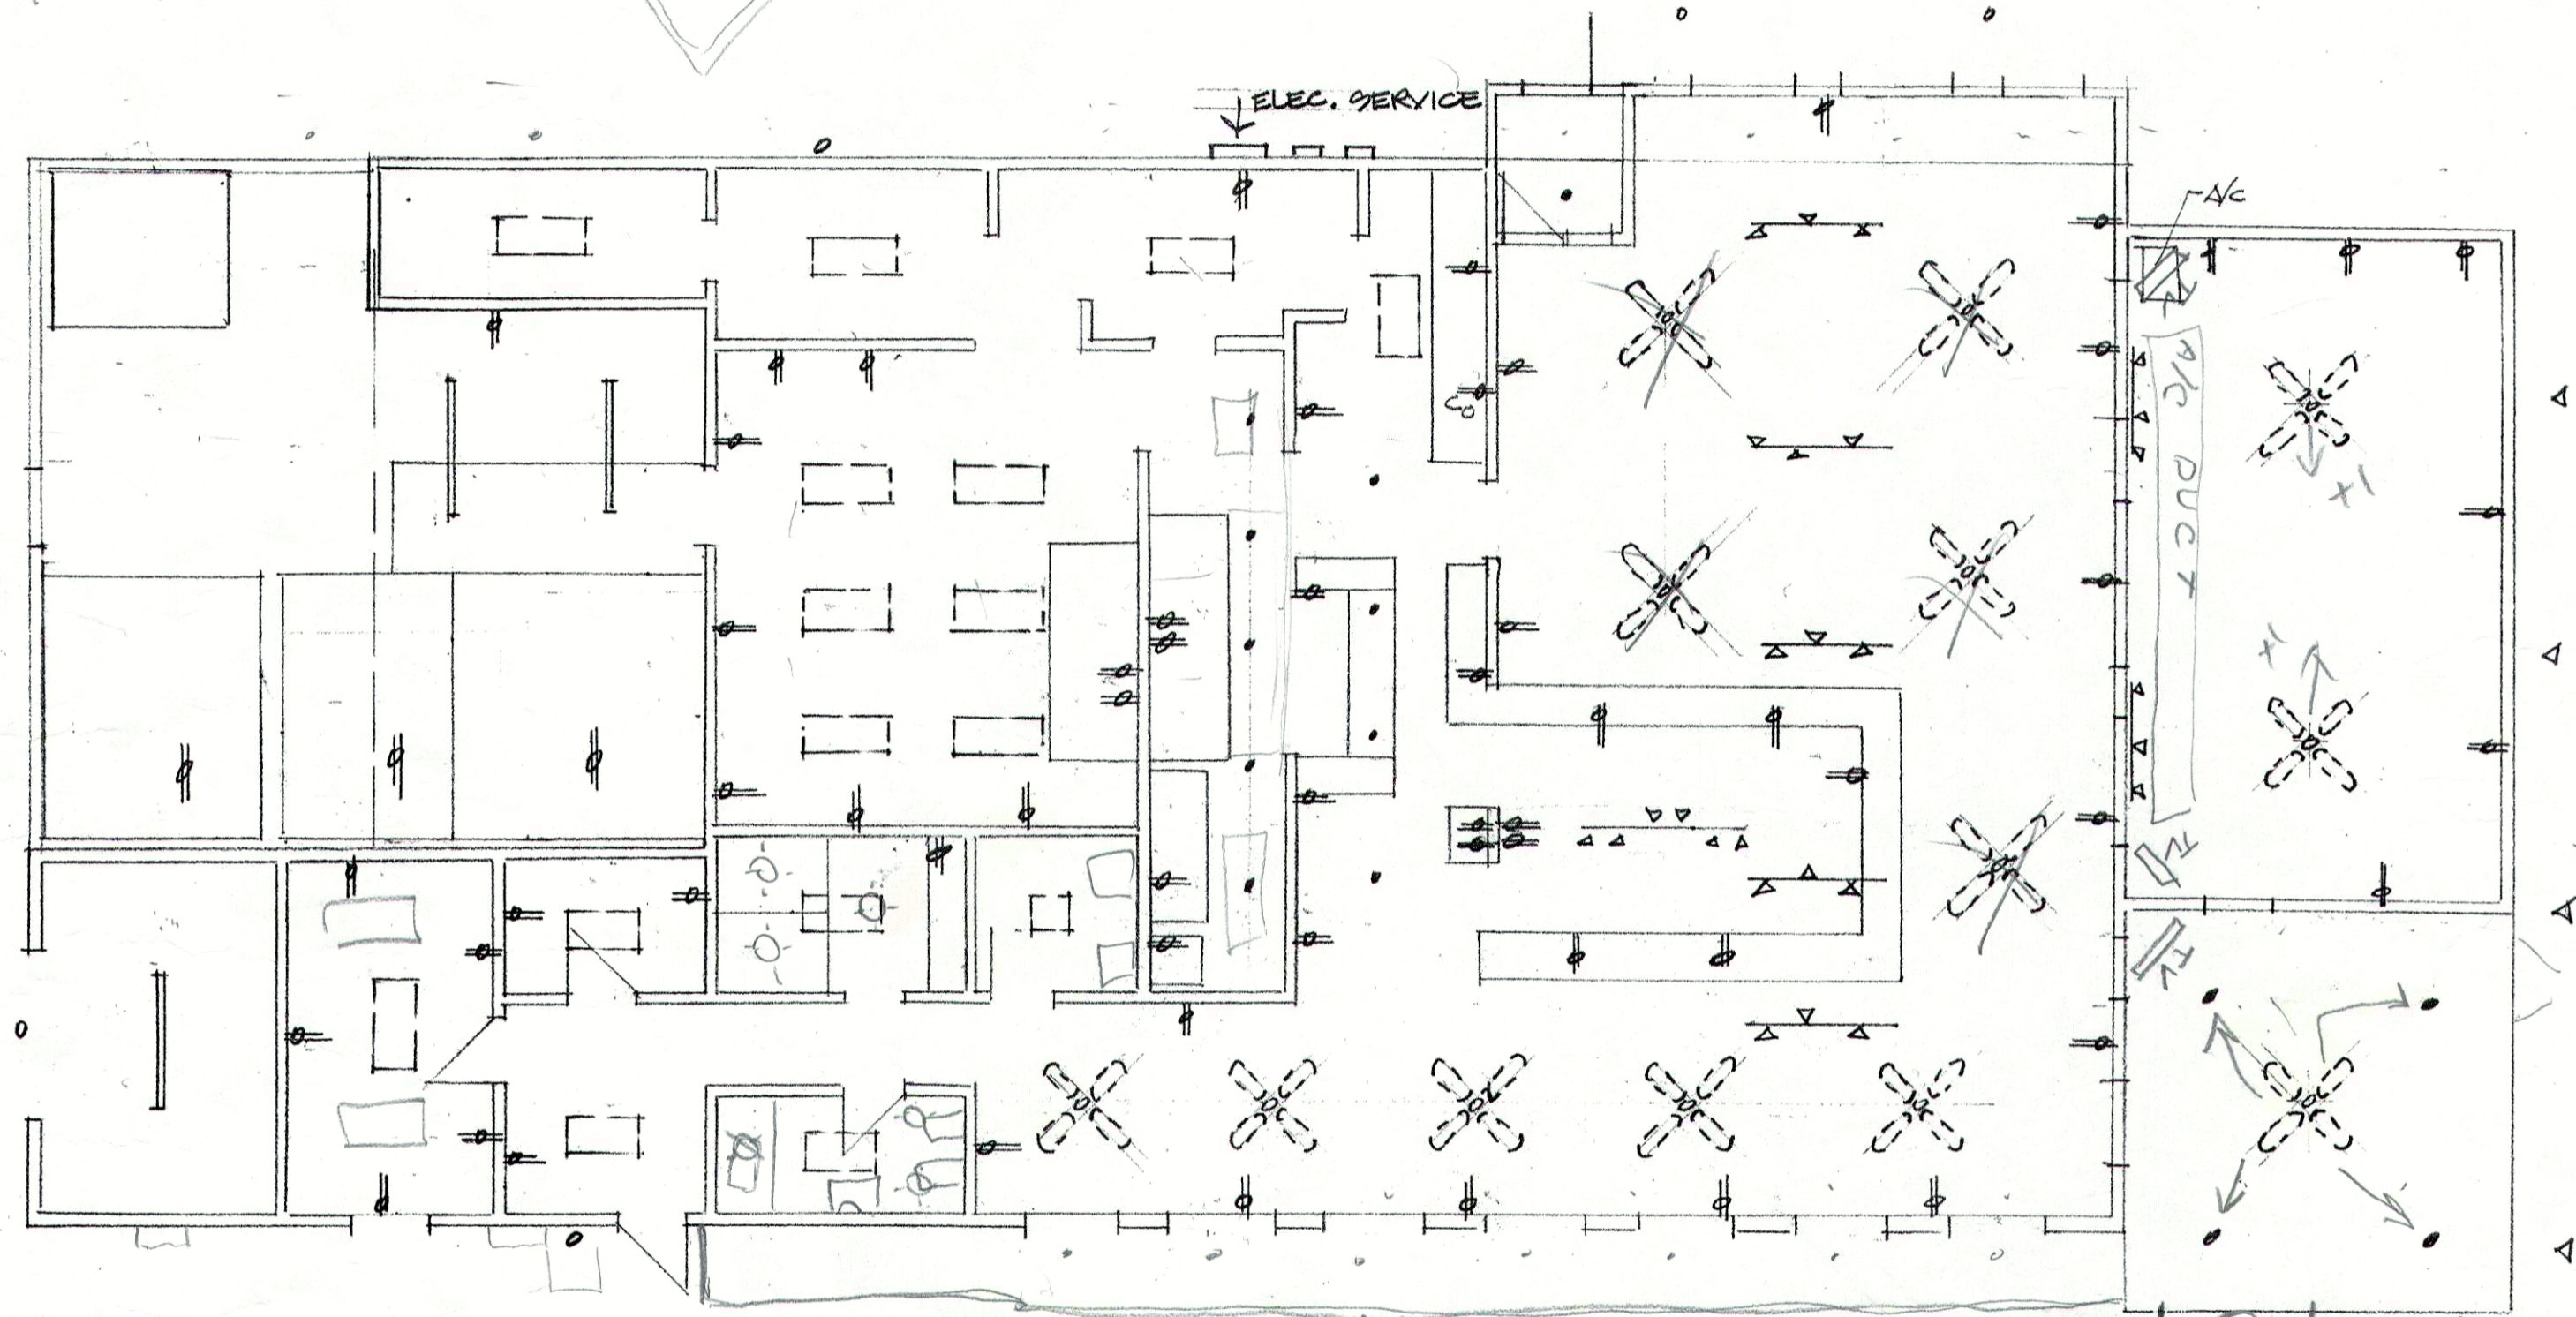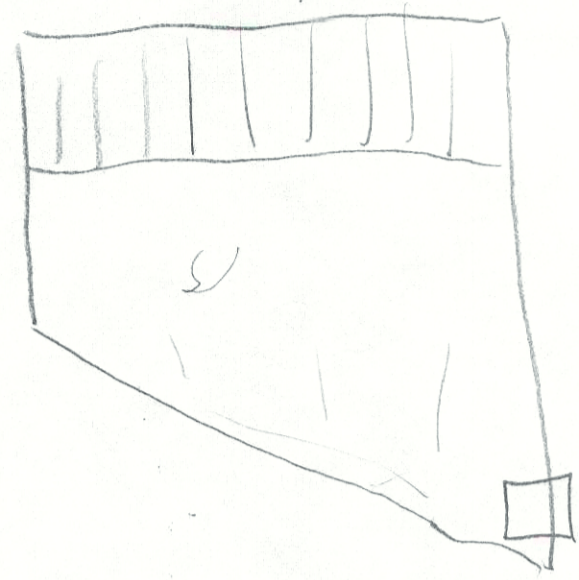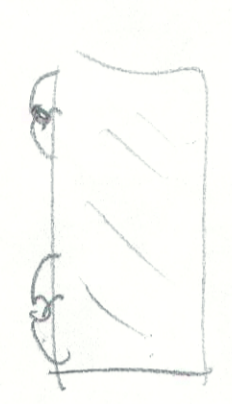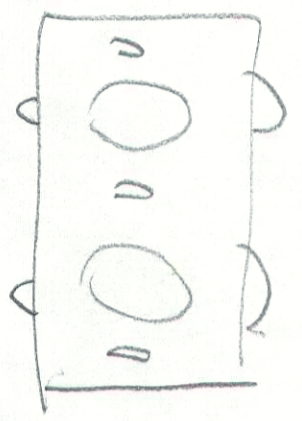

ELECTRICAL 1/8" = 1'-0"

ALL SWITCHING TO BE FIELD DETERMINED BY OWNER & ELECTRICIAN

SOUTHSIDE CAFE		
SCALE:	APPROVED BY:	DRAWN BY:
DATE:		REVISED:
		DRAWING NUMBER