

DAMMON ENGINEERING, INC.

CHIEF ENGINEER
EMMETT
DAMMON, P.E.

CHIEF ARCHITECT
ROBERT
WILTSE

1095 FLORIDA AVENUE
SLIDELL, LA. 70458
OFFICE: 985-649-5832
FAX: 985-641-5950

WEBSITE:
WWW.DAMMONENGINEERING.COM


EMAIL:
DAMMONENG@BELLSOUTH.NET

- ARCHITECTURE
- ENGINEERING
- STUDIES
- PLANNING
- INVESTIGATION
- EXPERT WITNESS

NEW CREMATORY AND EMBALMING FACILITY

HONAKER FUNERAL HOME
TERRY TRANCHINA
1751 W. GAUSE BLVD
SLIDELL, LA

REFLECTED CEILING PLAN

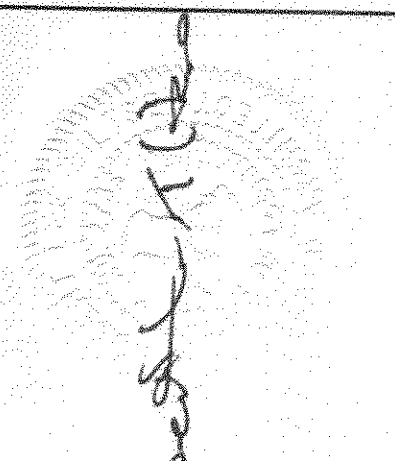

SEE ATTACHED
REVISED SHEET

REV:

SCALE: AS NOTED


JOB#: 1999

DATE: 6-9-09

SHEET 10

A-4

OF 19

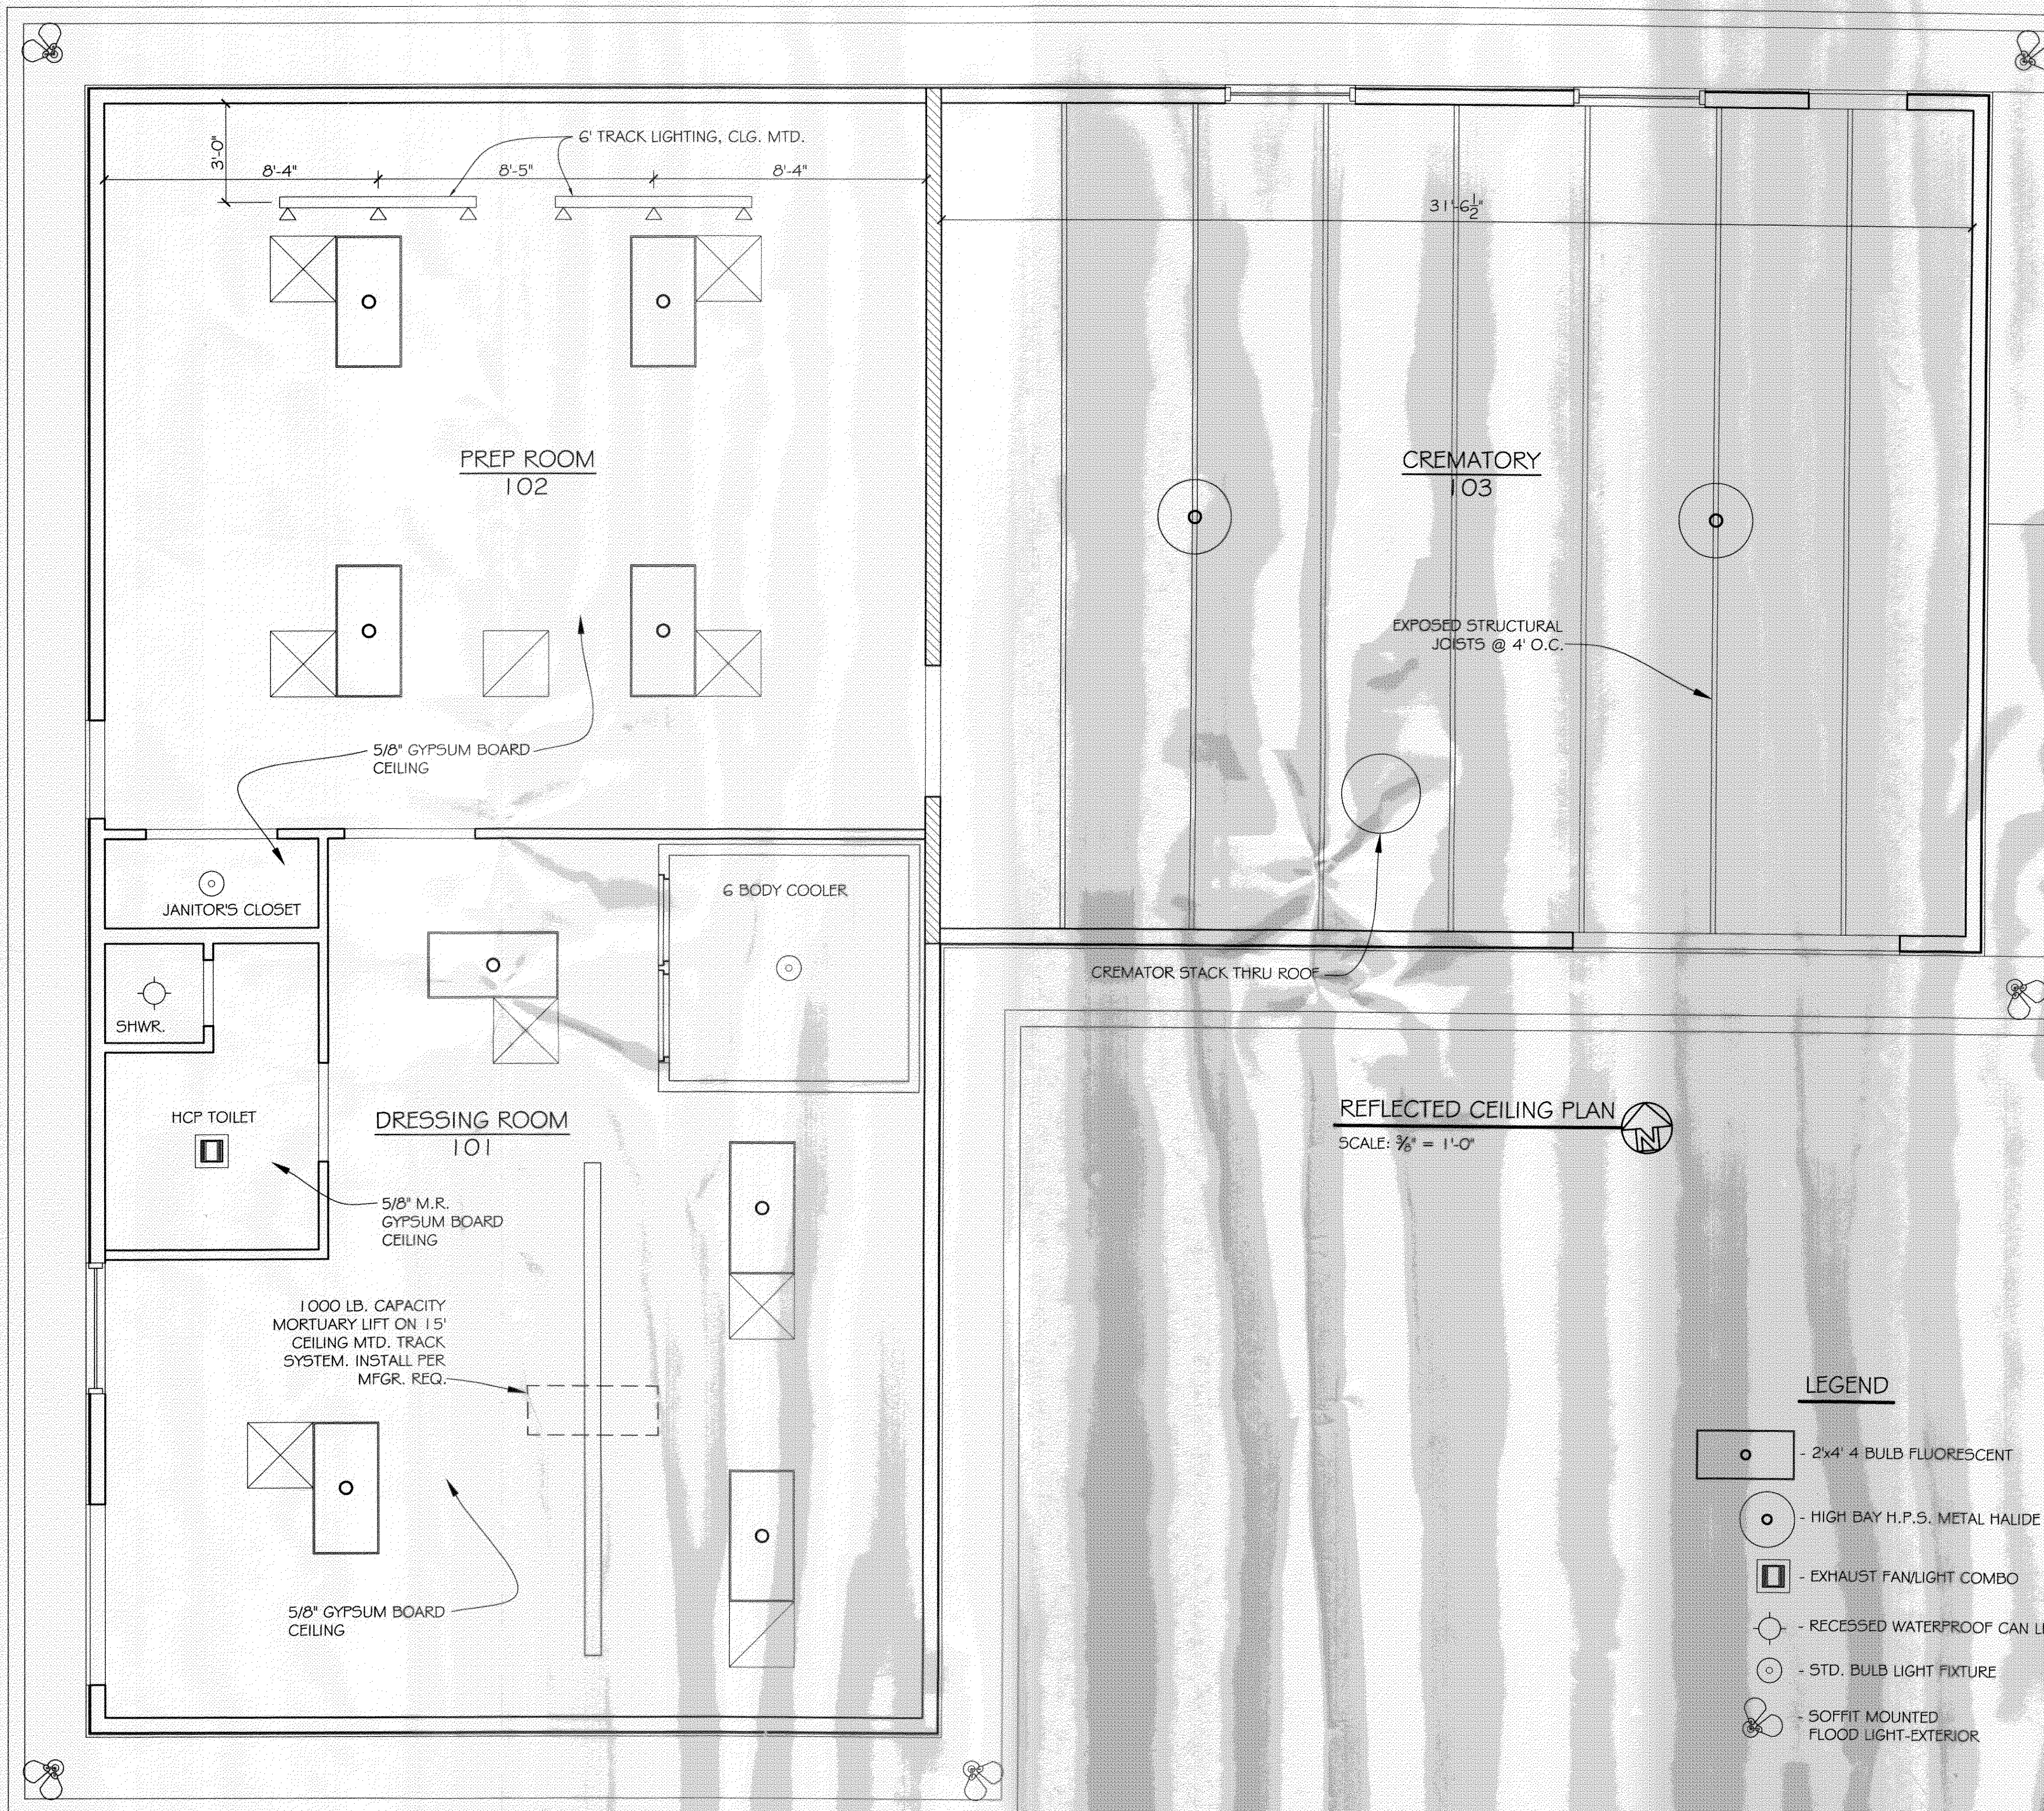

REFLECTED CEILING PLAN
SCALE: 3/8" = 1'-0"

LEGEND

- 2x4' 4 BULB FLUORESCENT
- HIGH BAY H.P.S. METAL HALIDE
- EXHAUST FAN/LIGHT COMBO
- RECESSED WATERPROOF CAN LIGHT
- STD. BULB LIGHT FIXTURE
- SOFFIT MOUNTED FLOOD LIGHT-EXTERIOR