

**DAMMON**  
ENGINEERING, INC.

CHIEF ENGINEER  
EMMETT  
DAMMON, P.E.  
CHIEF ARCHITECT  
ROBERT  
WILTSE

1095 FLORIDA AVENUE  
SLIDELL, LA. 70459  
OFFICE: 985-649-5832  
FAX: 985-641-5950

WEBSITE:  
WWW.DAMMONENGINEERING.COM  
EMAIL:  
DAMMONENG@DELTAOUTH.NET


ARCHITECTURE  
ENGINEERING  
STUDIES  
PLANNING  
INVESTIGATION  
EXPERT WITNESS

PAUL MITCHELL  
SCHOOL  
3321 HESSMER AVE  
METAIRIE, LA  
70002

SECOND FLOOR  
POWER PLAN

OF

E-2

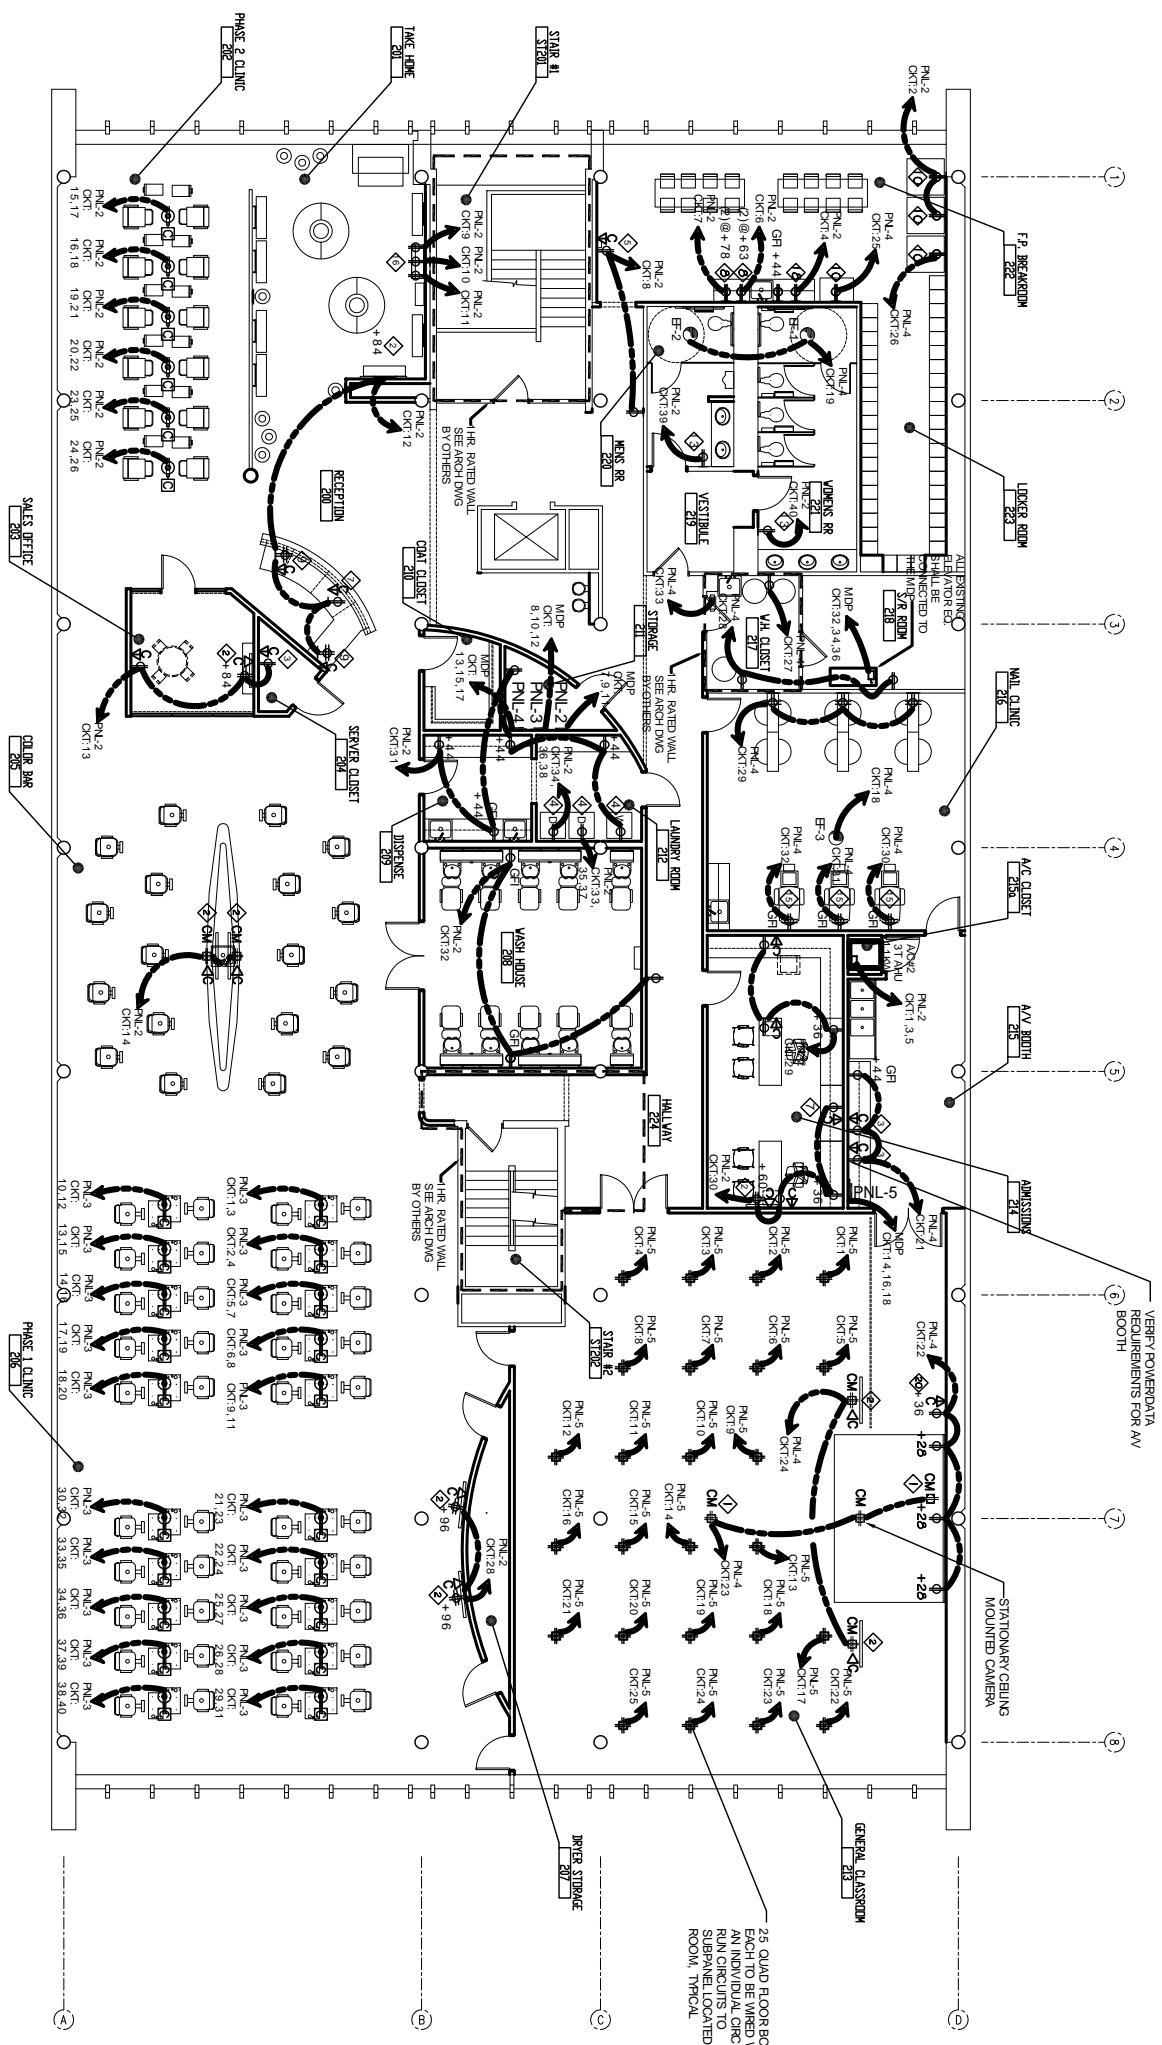

SECOND FLOOR POWER PLAN  
SCALE: 1/8" = 1'

FOR GENERAL ELECTRIC NOTES SEE SHEET E-9  
FOR ELECTRIC PANEL SCHEDULES SEE SHEET E-8

- SPECIALTY NOTES**
- 1 CEILING RECEPTACLE PROVIDED WITH AV PROJECTOR CEILING MOUNT PANEL.
  - 2 PROVIDE CABLE AND QUAD RECEPTACLE FOR FLATSCREEN TELEVISION, COORDINATE MOUNTING HEIGHT WITH A.V. CONSULTANT
  - 3 AV RACK FOR EQUIPMENT LOCATED IN CLOSET, COORDINATE EXACT POWER REQUIREMENT AND LOCATION WITH AV CONSULTANT.
  - 4 OWNER PROVIDED WASHER AND DRYER, VERIFY EXACT POWER, GAS, AND PLUMBING REQUIREMENTS WITH MANUFACTURER OF SELECTED UNITS.
  - 5 VERIFY POWER AND DATA REQUIREMENTS FOR TIME CLOCK, COORDINATE LOCATION WITH OWNER.
  - 7 PROVIDE POWER AND NETWORK CONNECTION FOR OWNER PROVIDED COPIER/PRINTER; VERIFY EQUIPMENT WITH OWNER.
  - 8 PROVIDE 2 DUPLEX OUTLETS, EACH WITH A DEDICATED CIRCUIT FOR 2 MICROWAVES, COORDINATE HEIGHTS WITH WALL SHELVES FOR MICROWAVES. (2) AT 63" AFF AND (2) AT 78" AFF VERIFY WITH WADSWORTH DESIGN.
  - 9 PROVIDE POWER AND NETWORK CONNECTION FLOOR BOXES FOR OWNER PROVIDED COMPUTERS AND POINT OF SALE EQUIPMENT; VERIFY EQUIPMENT WITH OWNER, VERIFY EXACT LOCATION WITH WADSWORTH DESIGN.

- 10 PROVIDE POWER FOR OWNER PROVIDED REFRIGERATORS AND VENDING MACHINES; VERIFY EQUIPMENT WITH OWNER.
- 12 GAS HOT WATER HEATERS AND RECIRCULATING PUMP. REFER TO MEP DRAWINGS AND CUT SHEETS FOR REQUIREMENTS
- 13 ELECTRIC HAND DRYER, REFER TO SHEET A401 AND A402 FOR DETAILS.
- 15 PEDICURE STATIONS, PROVIDE GFI WALL OUTLET WITH DEDICATED CIRCUIT FOR EACH UNIT. REFER TO CUT SHEETS FOR DETAILS.
- 16 WALL MOUNTED TOOL BAR BY WADSWORTH DESIGN, 3 OUTLETS WITH DEDICATED CIRCUITS REQ
- 18 PROVIDE POWER FOR OWNER PROVIDED DISHWASHER AS REQUIRED.
- 20 PROVIDE POWER AND DATA FOR LAPTOP OVER RIDE, VERIFY EXACT REQUIREMENTS AND LOCATION WITH AV CONSULTANT. (LOCATE DIRECTLY UNDER LCD SCREEN)

