


REFLECTED CEILING PLAN  
SCALE: 1/4"=1'-0"

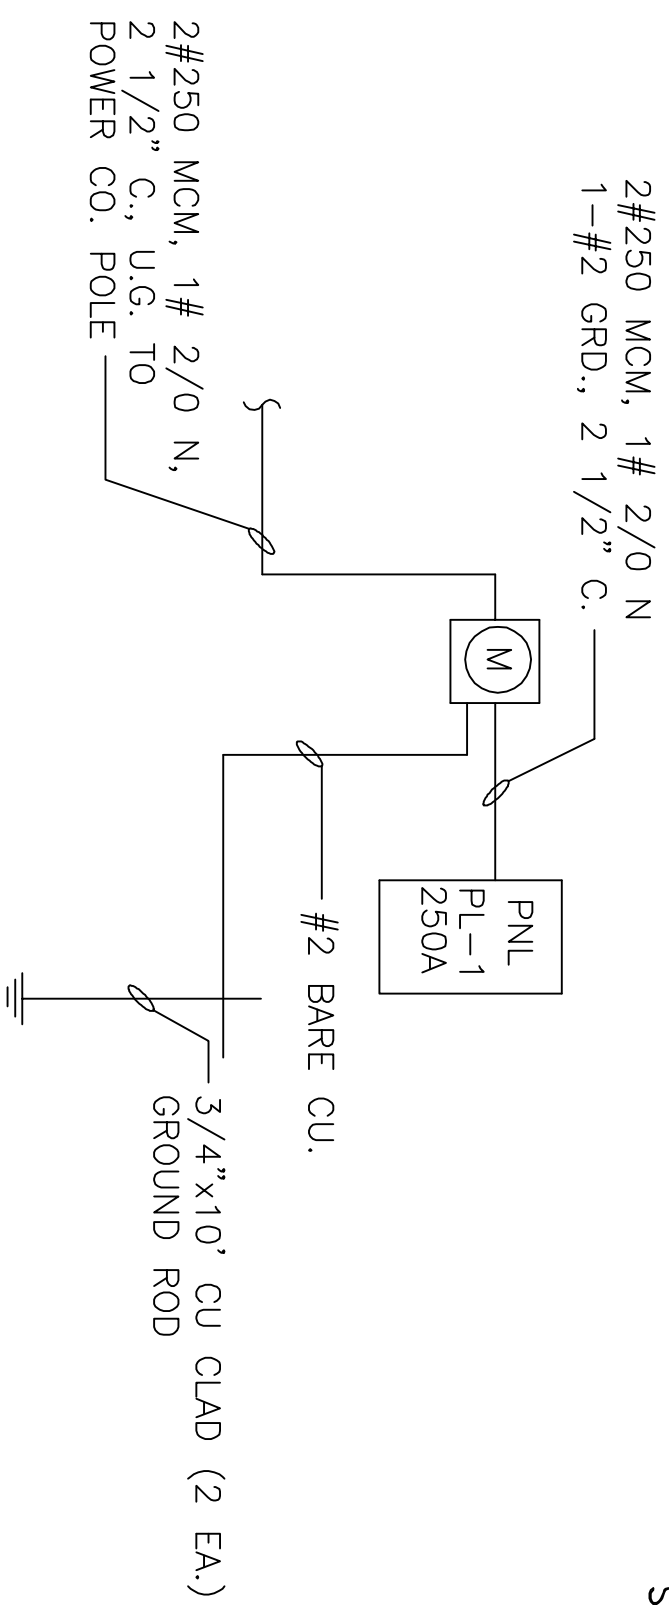

ELECTRICAL RISER DIAGRAM  
N.T.S.

- LEGEND**
- 2x4 FLUORESCENT FIXTURE
  - 4T/F40/C.W.
  - VENT/LIGHT
  - EXIT LIGHT
  - SMOKE DETECTOR
  - SUPPLY AIR
  - RETURN AIR

NO.	LOAD DESCRIPTION	BREAKER AMP	POLE	LOAD (VA)	LOAD (VA)	POLE	BREAKER AMP	LOAD DESCRIPTION	NO.
1	OFFICE AREA & TOILET LIGHTS	20	1	-	-	1	20	OFFICE AREA OUTLETS	2
3	HIGH BAY LIGHTS	20	1	-	-	1	20	WEATHERBORO OUTLETS	4
5	EXIT LIGHTS	20	1	-	-	1	20	EMERGENCY LIGHTS	6
7	WAREHOUSE OUTLETS	20	1	-	-	1	20	WAREHOUSE OUTLETS	8
9	EXTERIOR LIGHTS	20	1	-	-	1	20	MEZZANINE LIGHTS	10
11	SPARE	20	1	-	-	1	40	HOT WATER HEATER	12
13	SPARE	20	1	-	-	1	20	SPARE	14
15	A/C UNIT	40	2	-	-	1	20	SPARE	16
17	ELECTRIC HEATER JUNCTION BOX	20	1	-	-	1	20	ELECTRIC HEATER JUNCTION BOX	18
19	ELECTRIC HEATER JUNCTION BOX	20	1	-	-	1	20	ELECTRIC HEATER JUNCTION BOX	20
21	MICROWAVE OUTLET	20	1	-	-	1	20	EXHAUST FAN JUNCTION BOX	22
23	REFRIGERATION OUTLET	20	1	-	-	1	20	MEZZANINE OUTLETS	24
25	SPARE	20	1	-	-	1	20	SPARE	26
27	SPARE	20	1	-	-	1	20	SMOKE DETECTORS	28
29	SPARE	20	1	-	-	1	20	SPARE	30
31	SPARE	20	1	-	-	1	20	SPARE	32
33	SPARE	20	1	-	-	1	20	SPARE	34
35	SPARE	20	1	-	-	1	20	SPARE	36
37	SPARE	20	1	-	-	1	20	SPARE	38
39	SPARE	20	1	-	-	1	20	SPARE	40
41	SPARE	20	1	-	-	1	20	SPARE	42
				TOTAL CONNECTED LOAD (VA)	Am			GROUND BUS TO GROUND WIRE (G)	

PANEL: PL-1  
LOCATION: WAREHOUSE  
FEDER SOURCE: CLECO

VOLTAGE: 120/240V, 1A, 3W  
20 AMP, 100' MIN. MAIN BUS  
WALL MOUNTED W/ EQUIPMENT GROUND BAR  
SIEMENS TYPE EO OR EQUAL

REFLECTED CEILING PLAN.

RICHARDSON PROPERTY  
ADAM STREET  
SLIDELL, LOUISIANA

NEW STORAGE FACILITY

**DAMMON ENGINEERING, INC.**  
ARCHITECTS - ENGINEERS

1095 FLORIDA AVENUE 985-649-5832 SLIDELL, LA. 70458  
DAMMONENGINEERING.COM

SCALE: AS NOTED

FILE:

JOB NO. 1586

DATE: 5-14-04

SHEET

E-2

OF