


TRANSVERSE SECT. THRU

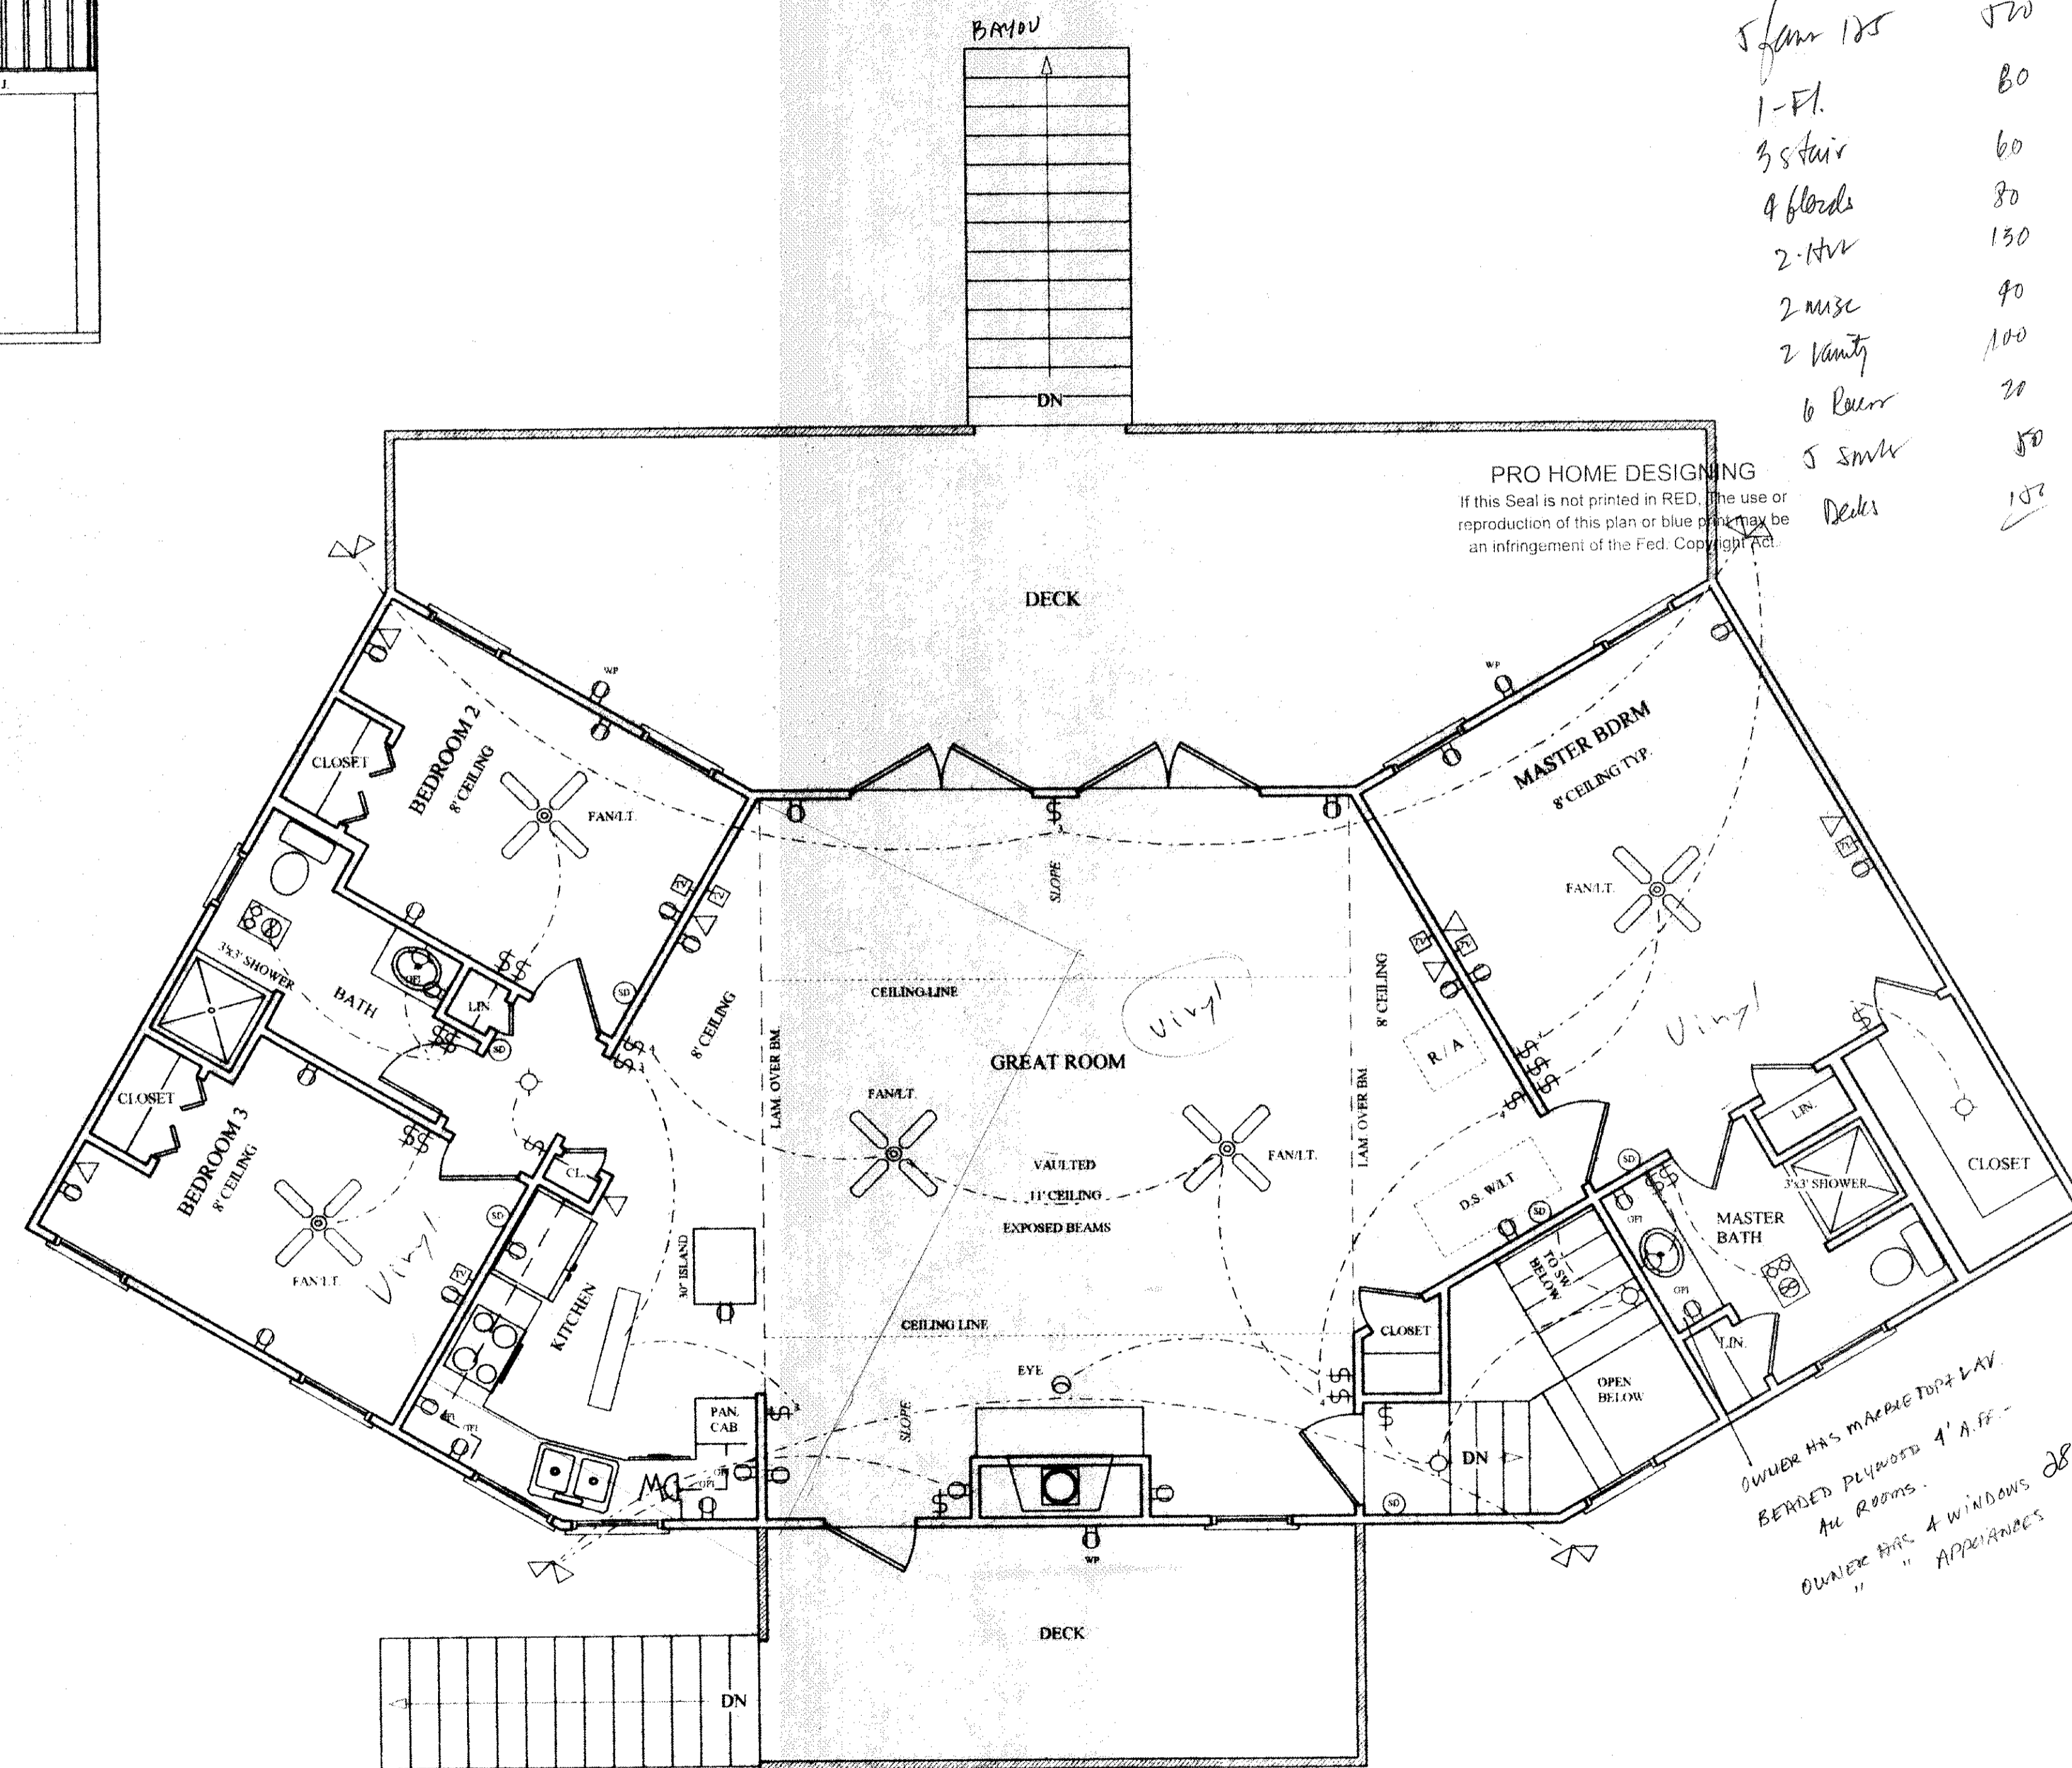

ELECTRICAL PLAN

Down	8 - Ft.	320
5 from 185		520
1 - Ft.		80
3 s stair		60
4 floors		80
2 - HVR		130
2 misc		40
2 Vanity		100
6 Beer		20
5 smkr		50
Decks		150

SYMBOLS KEY	
	110V DUPLEX OUTLET
	110V OUTDOOR OUTLET
	110V GFI DUPLEX OUTLET
	220V OUTLET
	SINGLE POLE SWITCH
	TELEPHONE JACK
	TV JACK
	DOOR BELL
	SMOKE DETECTOR
	REC LIGHT/HEAT/FAN
	REC LIGHT/FAN
	FLUORESCENT LIGHT
	STANDARD LIGHT
	RECESSED LIGHT
	FLOOD LIGHT
	WATER / HOSE BIB
	THERMOSTAT
	FLOOR OUTLET W/ COVER
	SWIVEL EYE
	REC FAN

A RESIDENCE FOR
MR. AND MRS. JAKE LEVY
 SLIDELL, LA

PRO HOME DESIGNS
 803 MEMORIAL BLVD STE. D PICAYUNE, MS
 (601) 799-2018

AUG. 2000
 SCALE:
 1/4"=1'-0"
 FILE
 1821
 SHEET
 4 OF 5

Every effort has been made in preparing these drawings and specifications to avoid mistakes. Any discrepancy, error and/or omission, if found, is to be brought immediately to the attention of Pro Home Designs, before any construction work or purchases made. Pro Home Designs will not be liable for human error after construction has started.
 All codes, ordinances and requirements - federal, state and local - take precedence over any part of these drawings and specifications which may conflict with these agencies, rules and/or regulations.