



SCOPE OF WORK

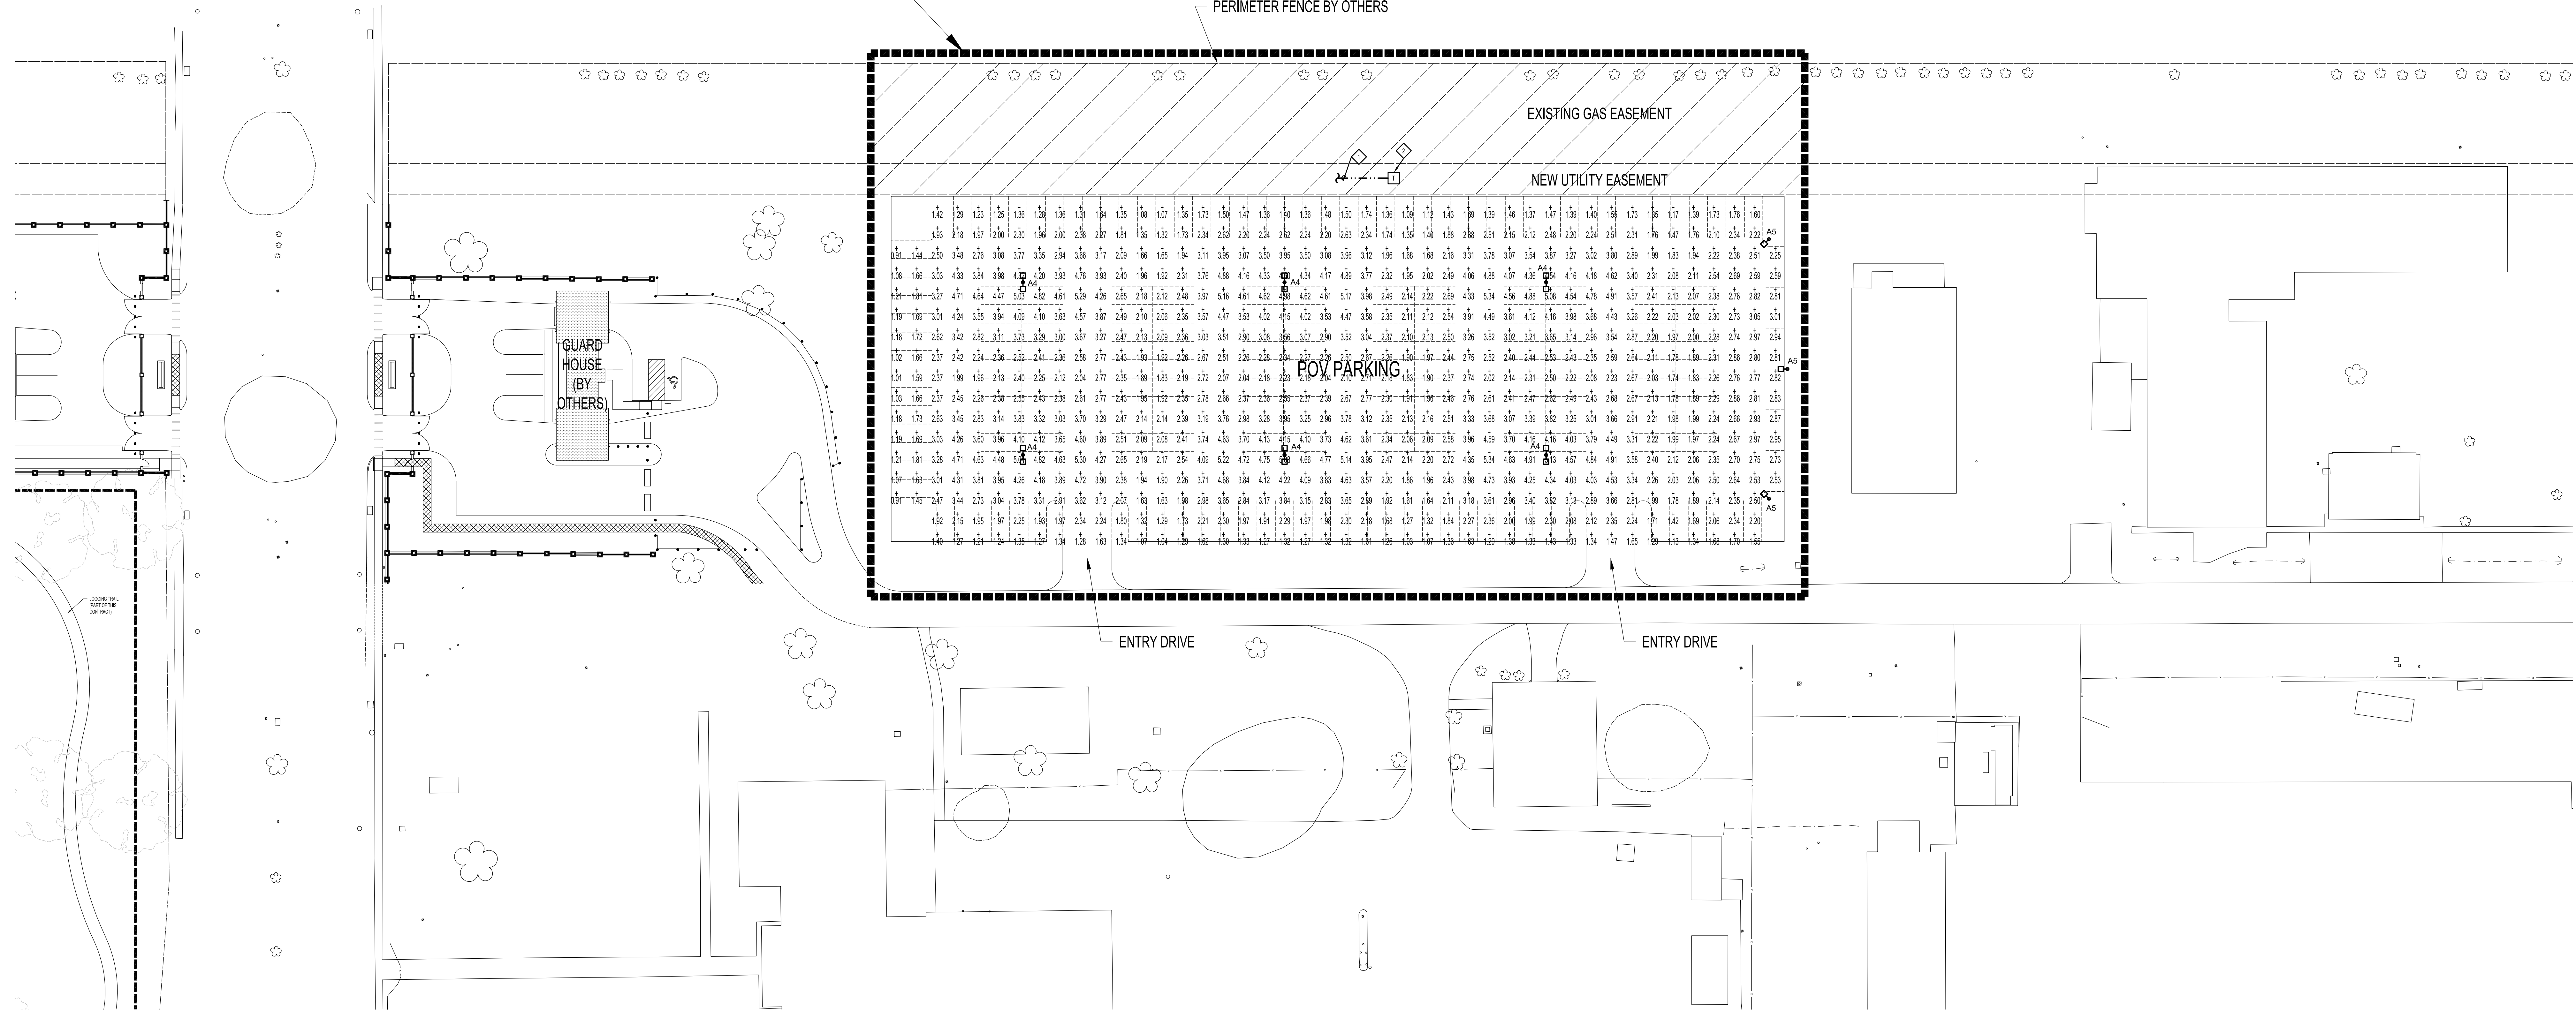

1 ELECTRICAL SITE PLAN - LIGHTING AREA D POV PARKING
1"=30'

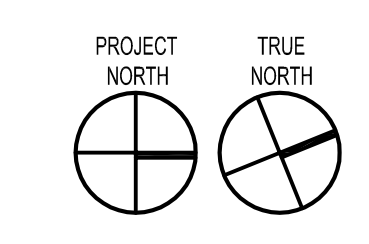

- SPECIFIC NOTES:**
- IF REQUIRED, DIRECTIONAL BORE (1) 6" NDPE CONDUITS WITH 20KV MEDIUM VOLTAGE CABLE OF 8' BELOW GRADE FROM NEAREST MEDIUM VOLTAGE SWITCHGEAR TO OIL-FILLED TRANSFORMER. ROUTE AN ADDITIONAL 5' HOPE CONDUIT WITH FULL CORE TO MEDIUM VOLTAGE SWITCHGEAR FOR FUTURE. REFERENCE INFRASTRUCTURE DRAWINGS FOR NEAREST MEDIUM VOLTAGE SECTIONALIZING CABINET LOCATION.
 - PROVIDE SINGLE-PHASE TRANSFORMER AND DISTRIBUTION EQUIPMENT IF NECESSARY TO PROVIDE POWER TO PARKING LOT FIXTURES.
- USED POLE ASSEMBLIES**
- A2 = (4) EH19-Q-250 MH @ 33'
A4 = (2) EH19-Q-350 PSMH 180" APART @ 33'
A5 = (1) EH19-FM-350 PSMH
A11 = (1) EH19-3-350 PSMH
- NOTE: ALL ASSEMBLIES USE TYPE S1 FIXTURES. SEE FIXTURE SCHEDULE.

© 2006 **IMC** 1474
CONSULTING ENGINEERS
INC.
3120 20th STREET
METAIRIE, LOUISIANA, 70002

These drawings are conceptual in nature and are not suitable for construction. It is the intent of these documents to identify delineate the baseline minimum scale, scope and quality of the project. It is the responsibility of the design-builder that his proposal provides for a complete and functional facility responding to relative Army National Guard criteria, recognized industry standards and applicable building codes regardless of the content of these conceptual drawings. Further, it will be the responsibility of the successful design-builder and his architect of record to prepare complete construction documents responding to the fullest intent of the conceptual drawings and specifications.

BROADMOOR
DESIGN GROUP
BROADMOOR DESIGN GROUP | DEAN R. DUPONTIER, ARCHITECT
A PROFESSIONAL ARCHITECTURAL CORPORATION
METAIRIE, LOUISIANA, 70002
3700 W. CHARLOTTE ROAD
(504) 885-5411
FAX (504) 885-6005

Blitcknevel
ARCHITECTS
787 ST. CHARLES AVENUE
NEW ORLEANS, LOUISIANA, 70130
(504) 942-4834
FAX (504) 942-5128

LOUISIANA ARMY NATIONAL GUARD
141st FIELD ARTILLERY BATTALION
READINESS CENTER
JACKSON BARRACKS NEW ORLEANS, LOUISIANA



2/22/06	PROG. REVIEW #1
3/10/06	PROG. REVIEW #2
3/27/06	PROG. REVIEW #3
4/10/06	PROG. REVIEW #4
5/3/06	PRELIM. DESIGN

MARK	DATE	DESCRIPTION

DRAWING ISSUED: 05/03/2006

NSB PROJECT NO.: 220027

PRELIMINARY DESIGN

DRAWING TITLE:
ELECTRICAL SITE
LIGHTING AREA
D POV PARKING

DRAWING NUMBER:

E102
SHEET 77 OF 106