





1 LIGHTING PLAN - FIRST FLOOR CENTRAL PLANT

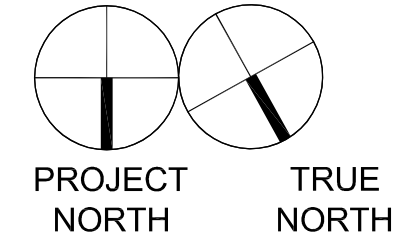

SPECIFIC NOTES:
 ◇ (STANCHION MTD. ON 1" CONDUIT. USE HOPE H42300 OR EQUAL) HOT DIPPED, GALVANIZED, CAST IRON CONDUIT BASE WITH GFI RECEPTACLE.

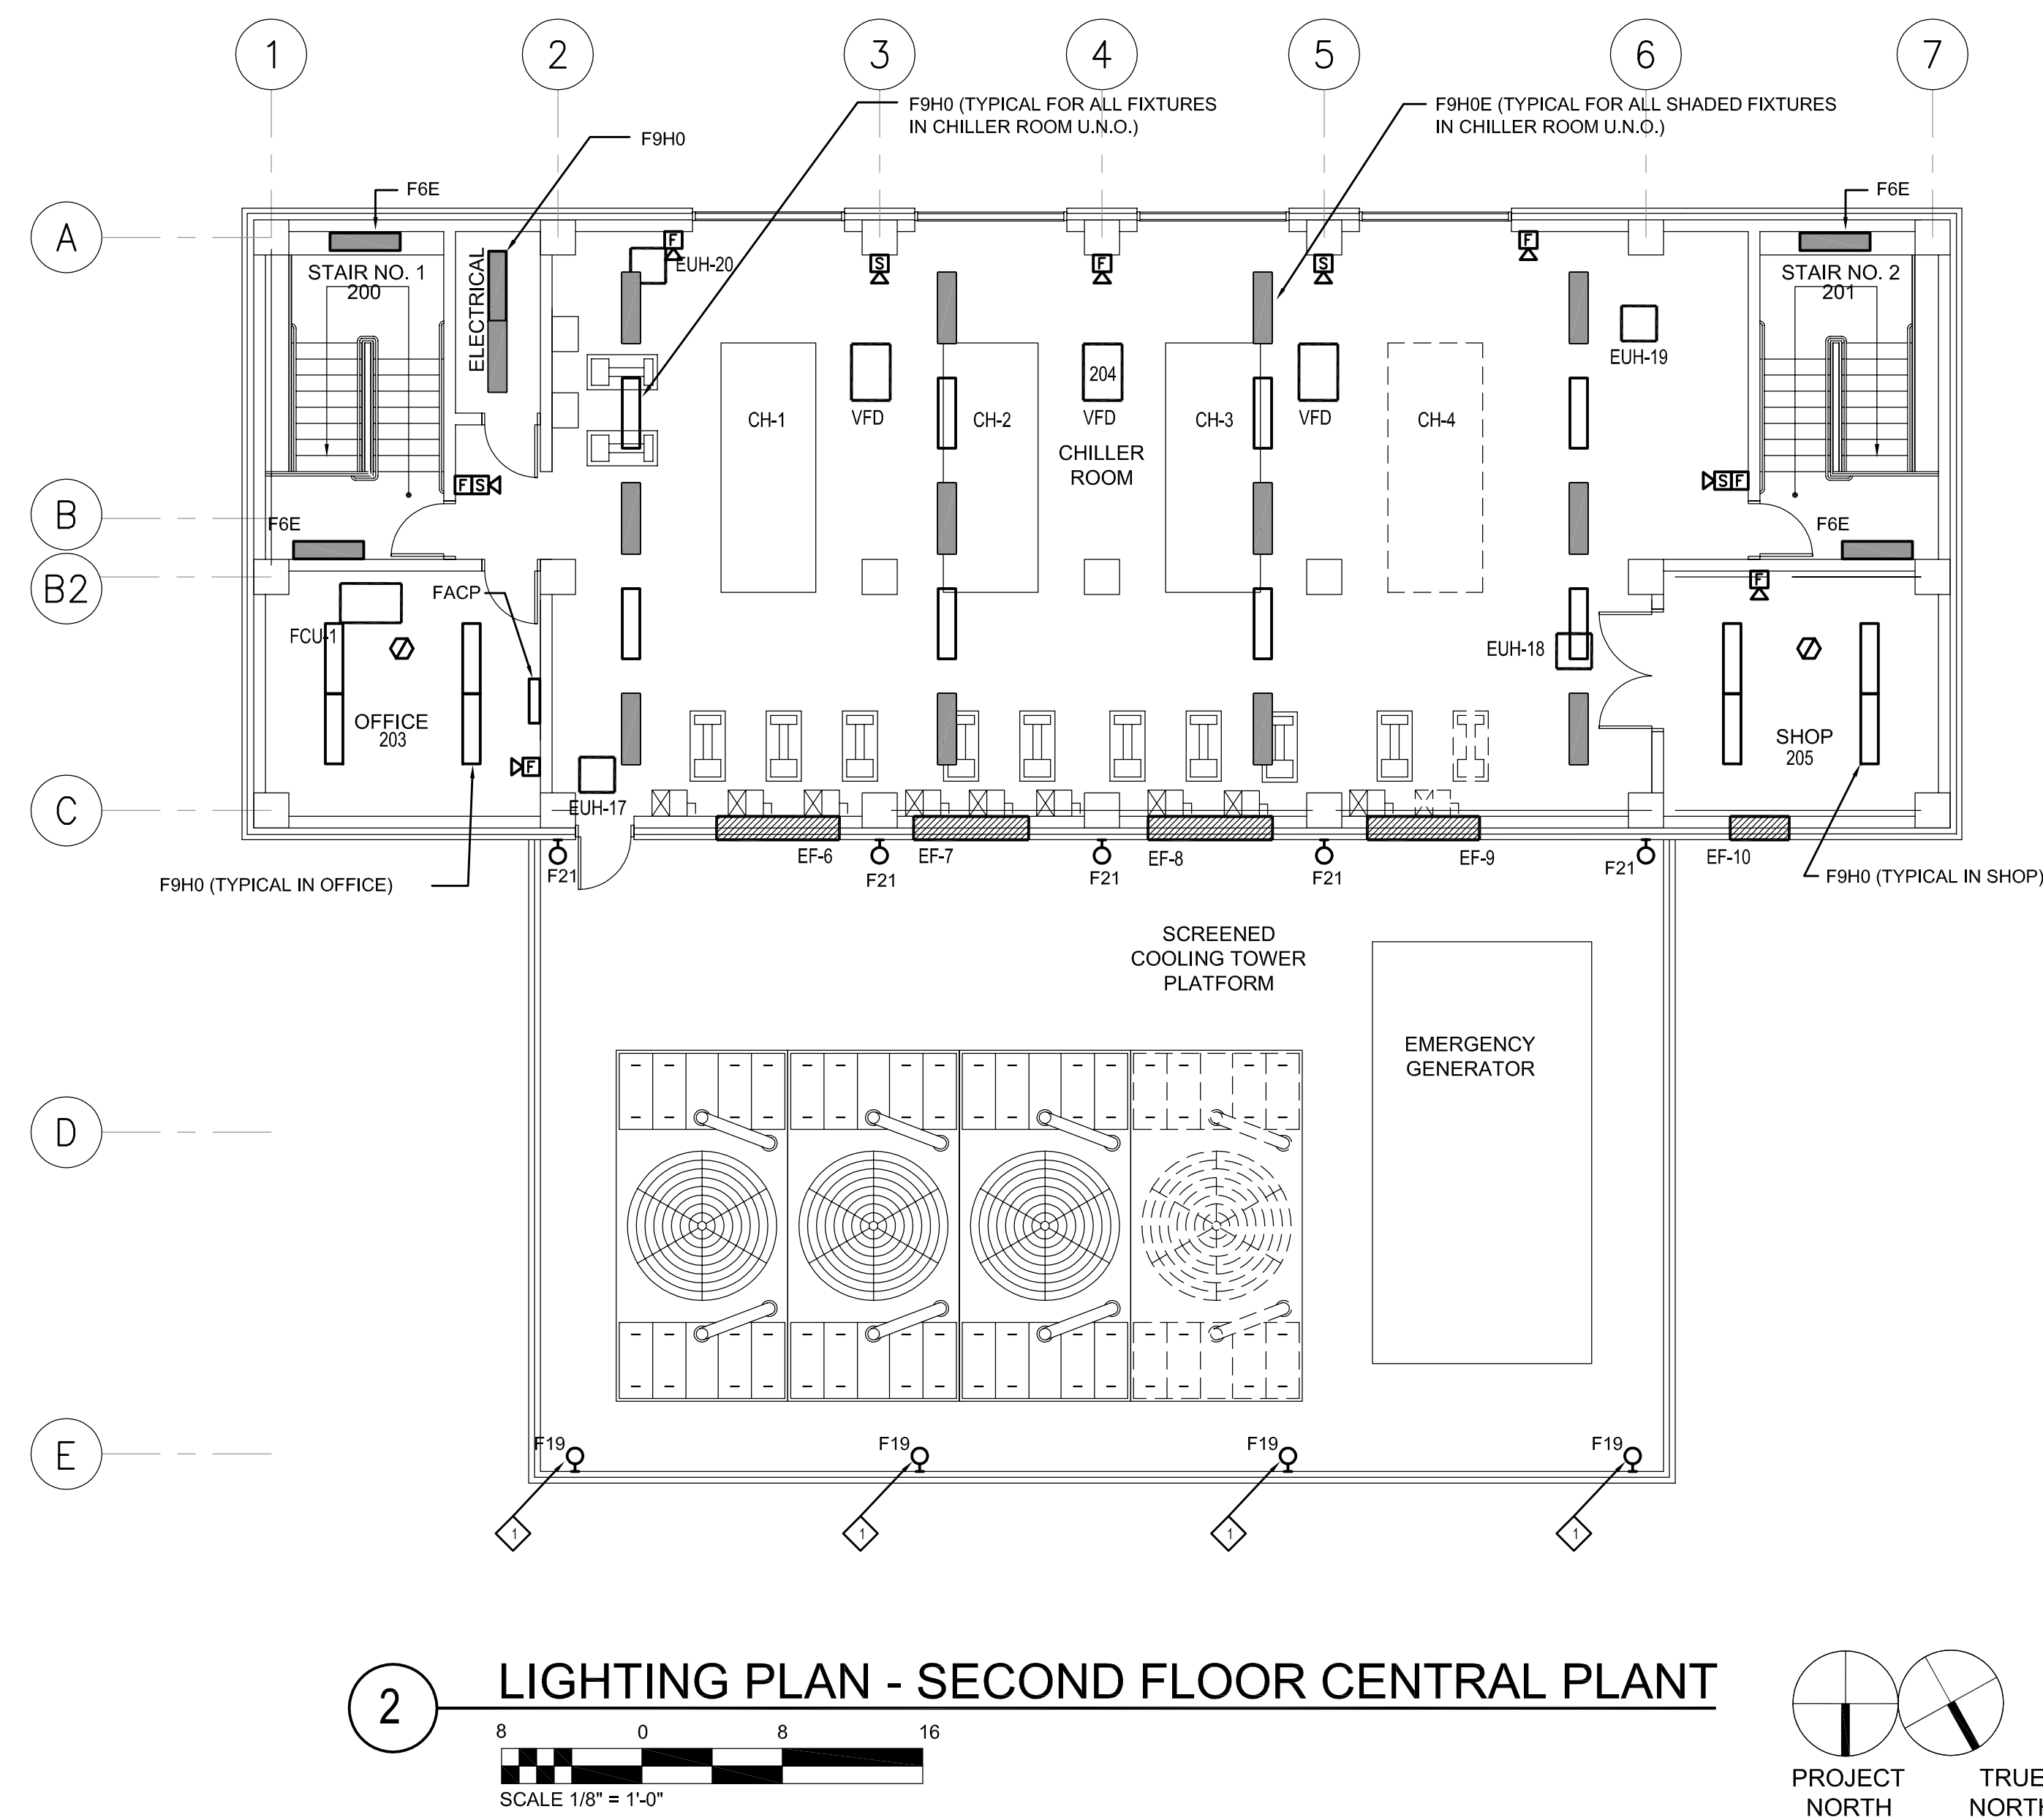

2 LIGHTING PLAN - SECOND FLOOR CENTRAL PLANT

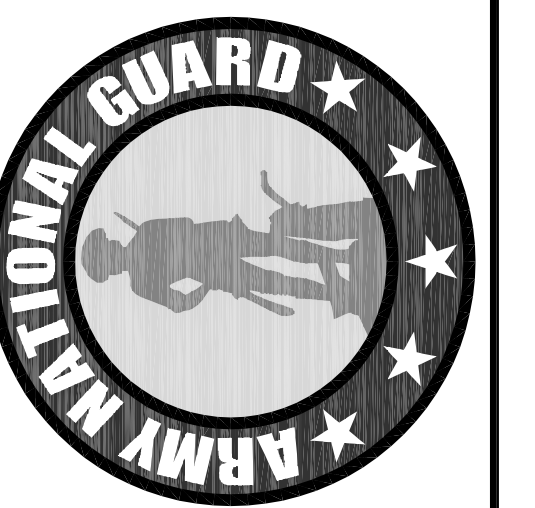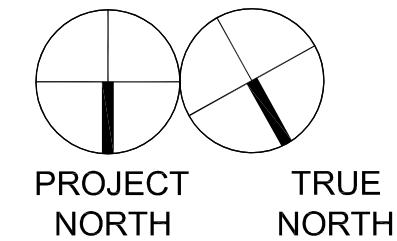

△	2/22/06	PROG. REVIEW #1
△	3/1/06	PROG. REVIEW #2
△	3/27/06	PROG. REVIEW #3
△	4/10/06	PROG. REVIEW #4
△	5/3/06	PRELIM. DESIGN

MARK	DATE	DESCRIPTION
DRAWING ISSUED: 05/03/2006		

NOB PROJECT NO.: 220027

PRELIMINARY DESIGN

DRAWING TITLE:
 LIGHTING PLAN
 FIRST & SECOND FL.
 CENTRAL PLANT

DRAWING NUMBER:

E151

SHEET 96 OF 106