




1 FIRST FLOOR ENLARGED ELECTRICAL PLAN  
SCALE: 1/2"=1'-0"

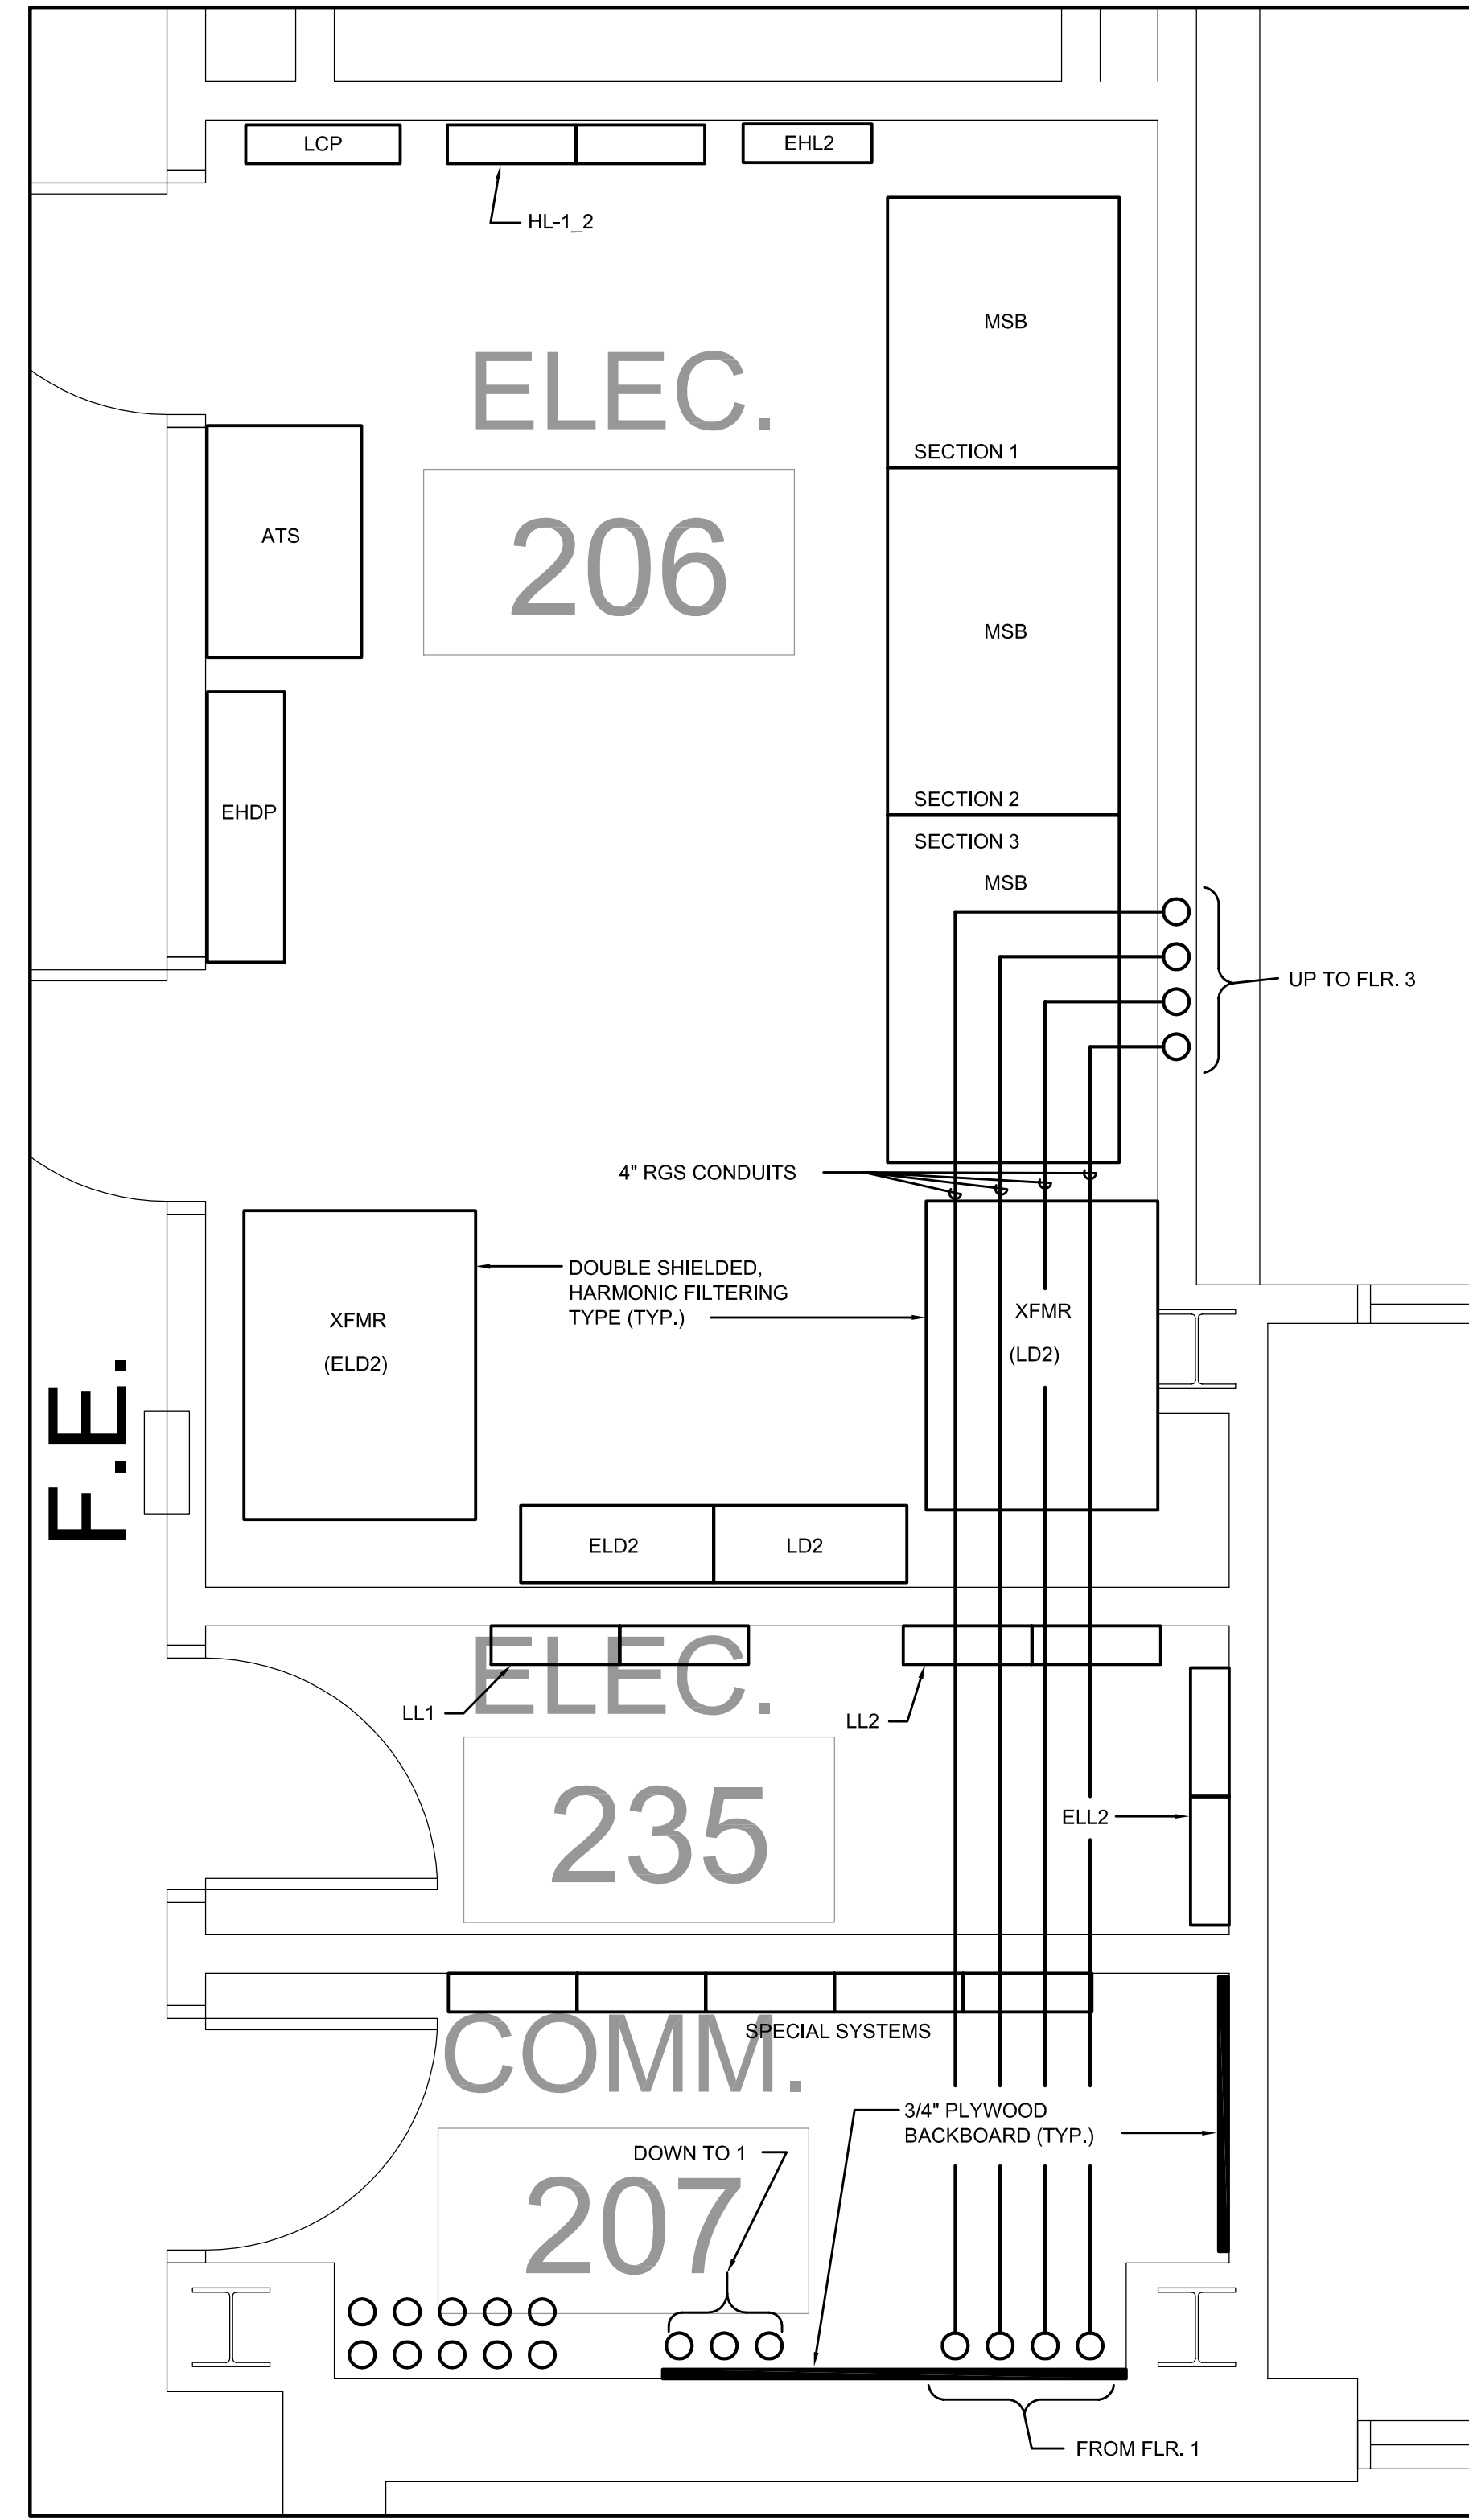


2 SECOND FLOOR ENLARGED ELECTRICAL PLAN  
SCALE: 1/2"=1'-0"

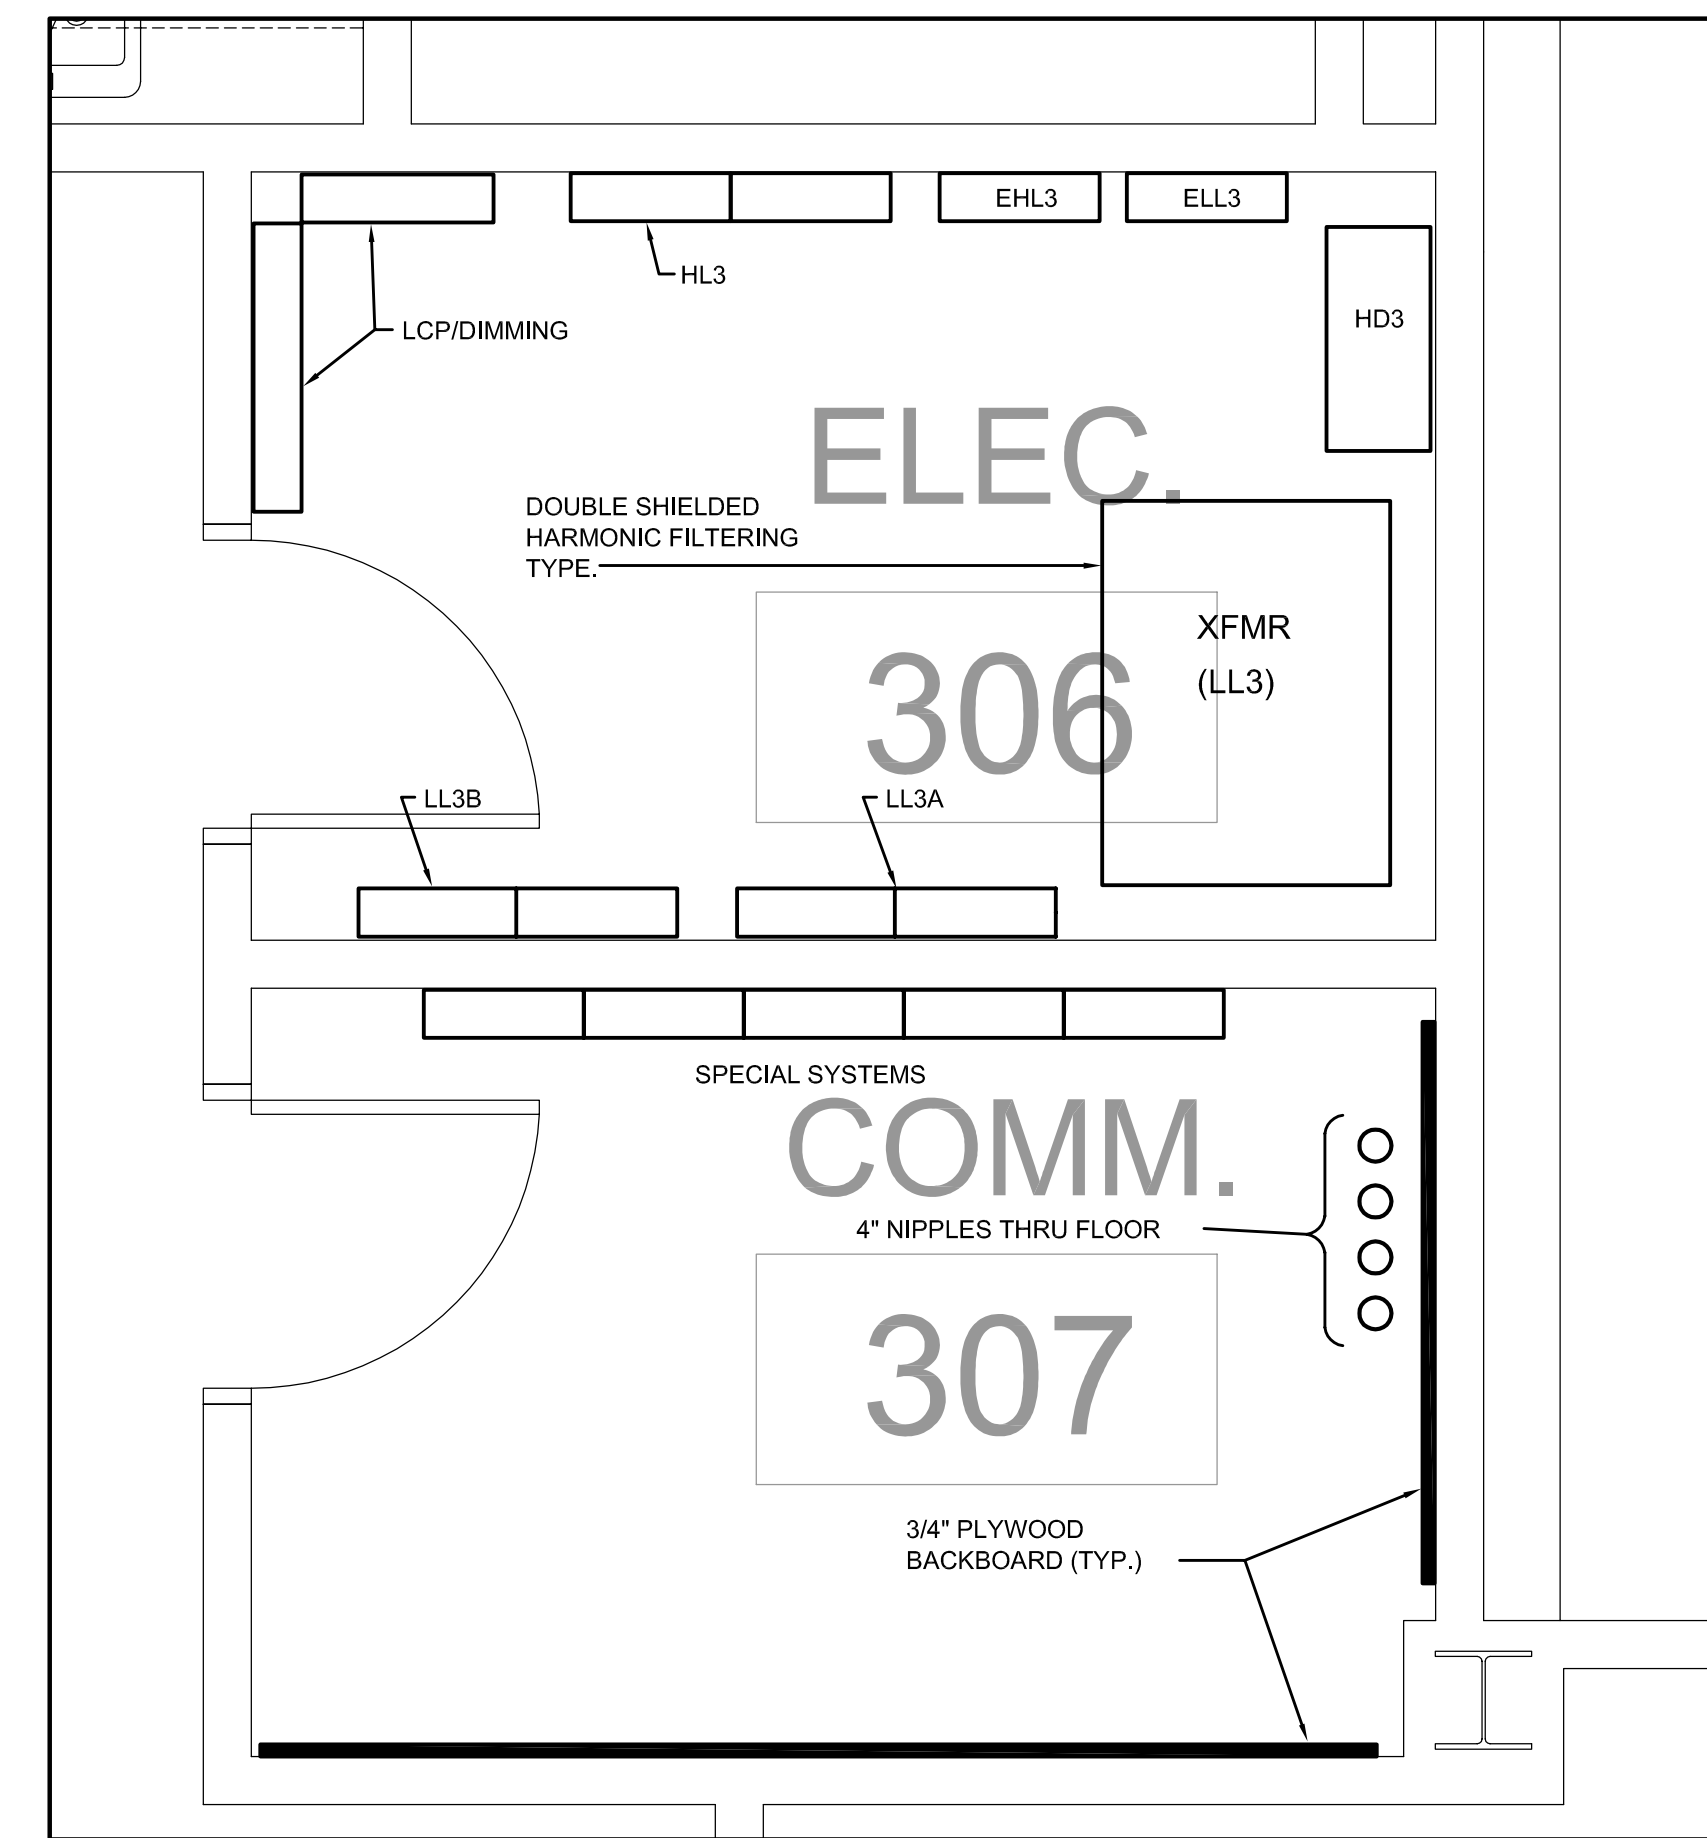


3 THIRD FLOOR ENLARGED ELECTRICAL PLAN  
SCALE: 1/2"=1'-0"

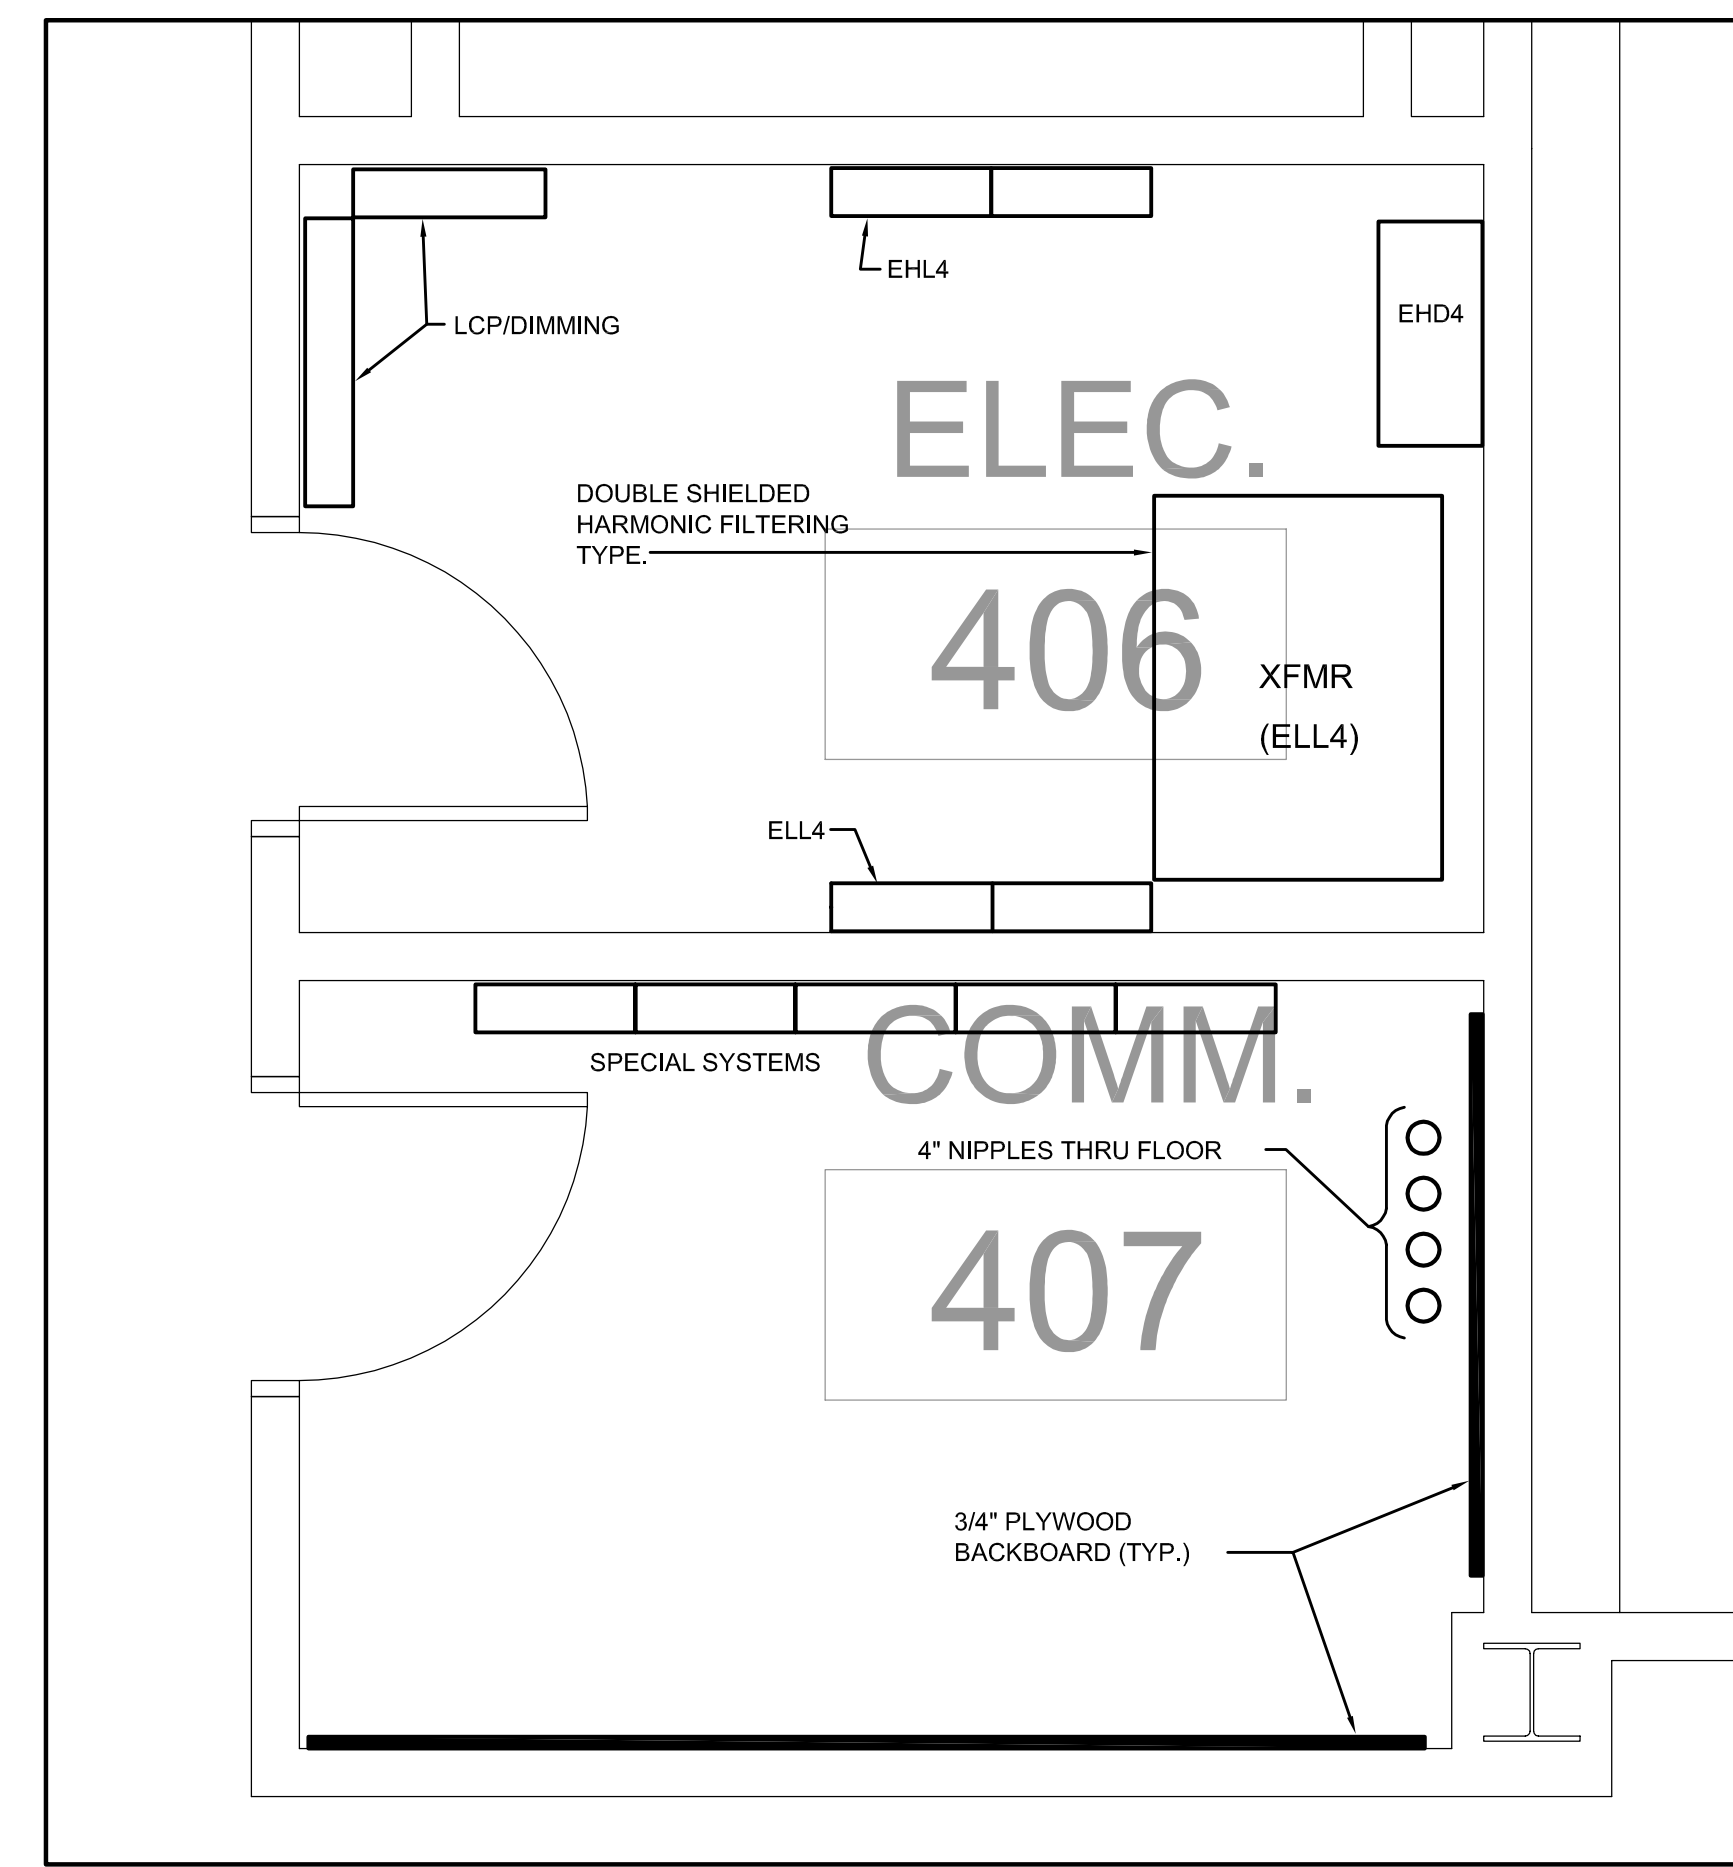

4 FOURTH FLOOR ENLARGED ELECTRICAL PLAN  
SCALE: 1/2"=1'-0"

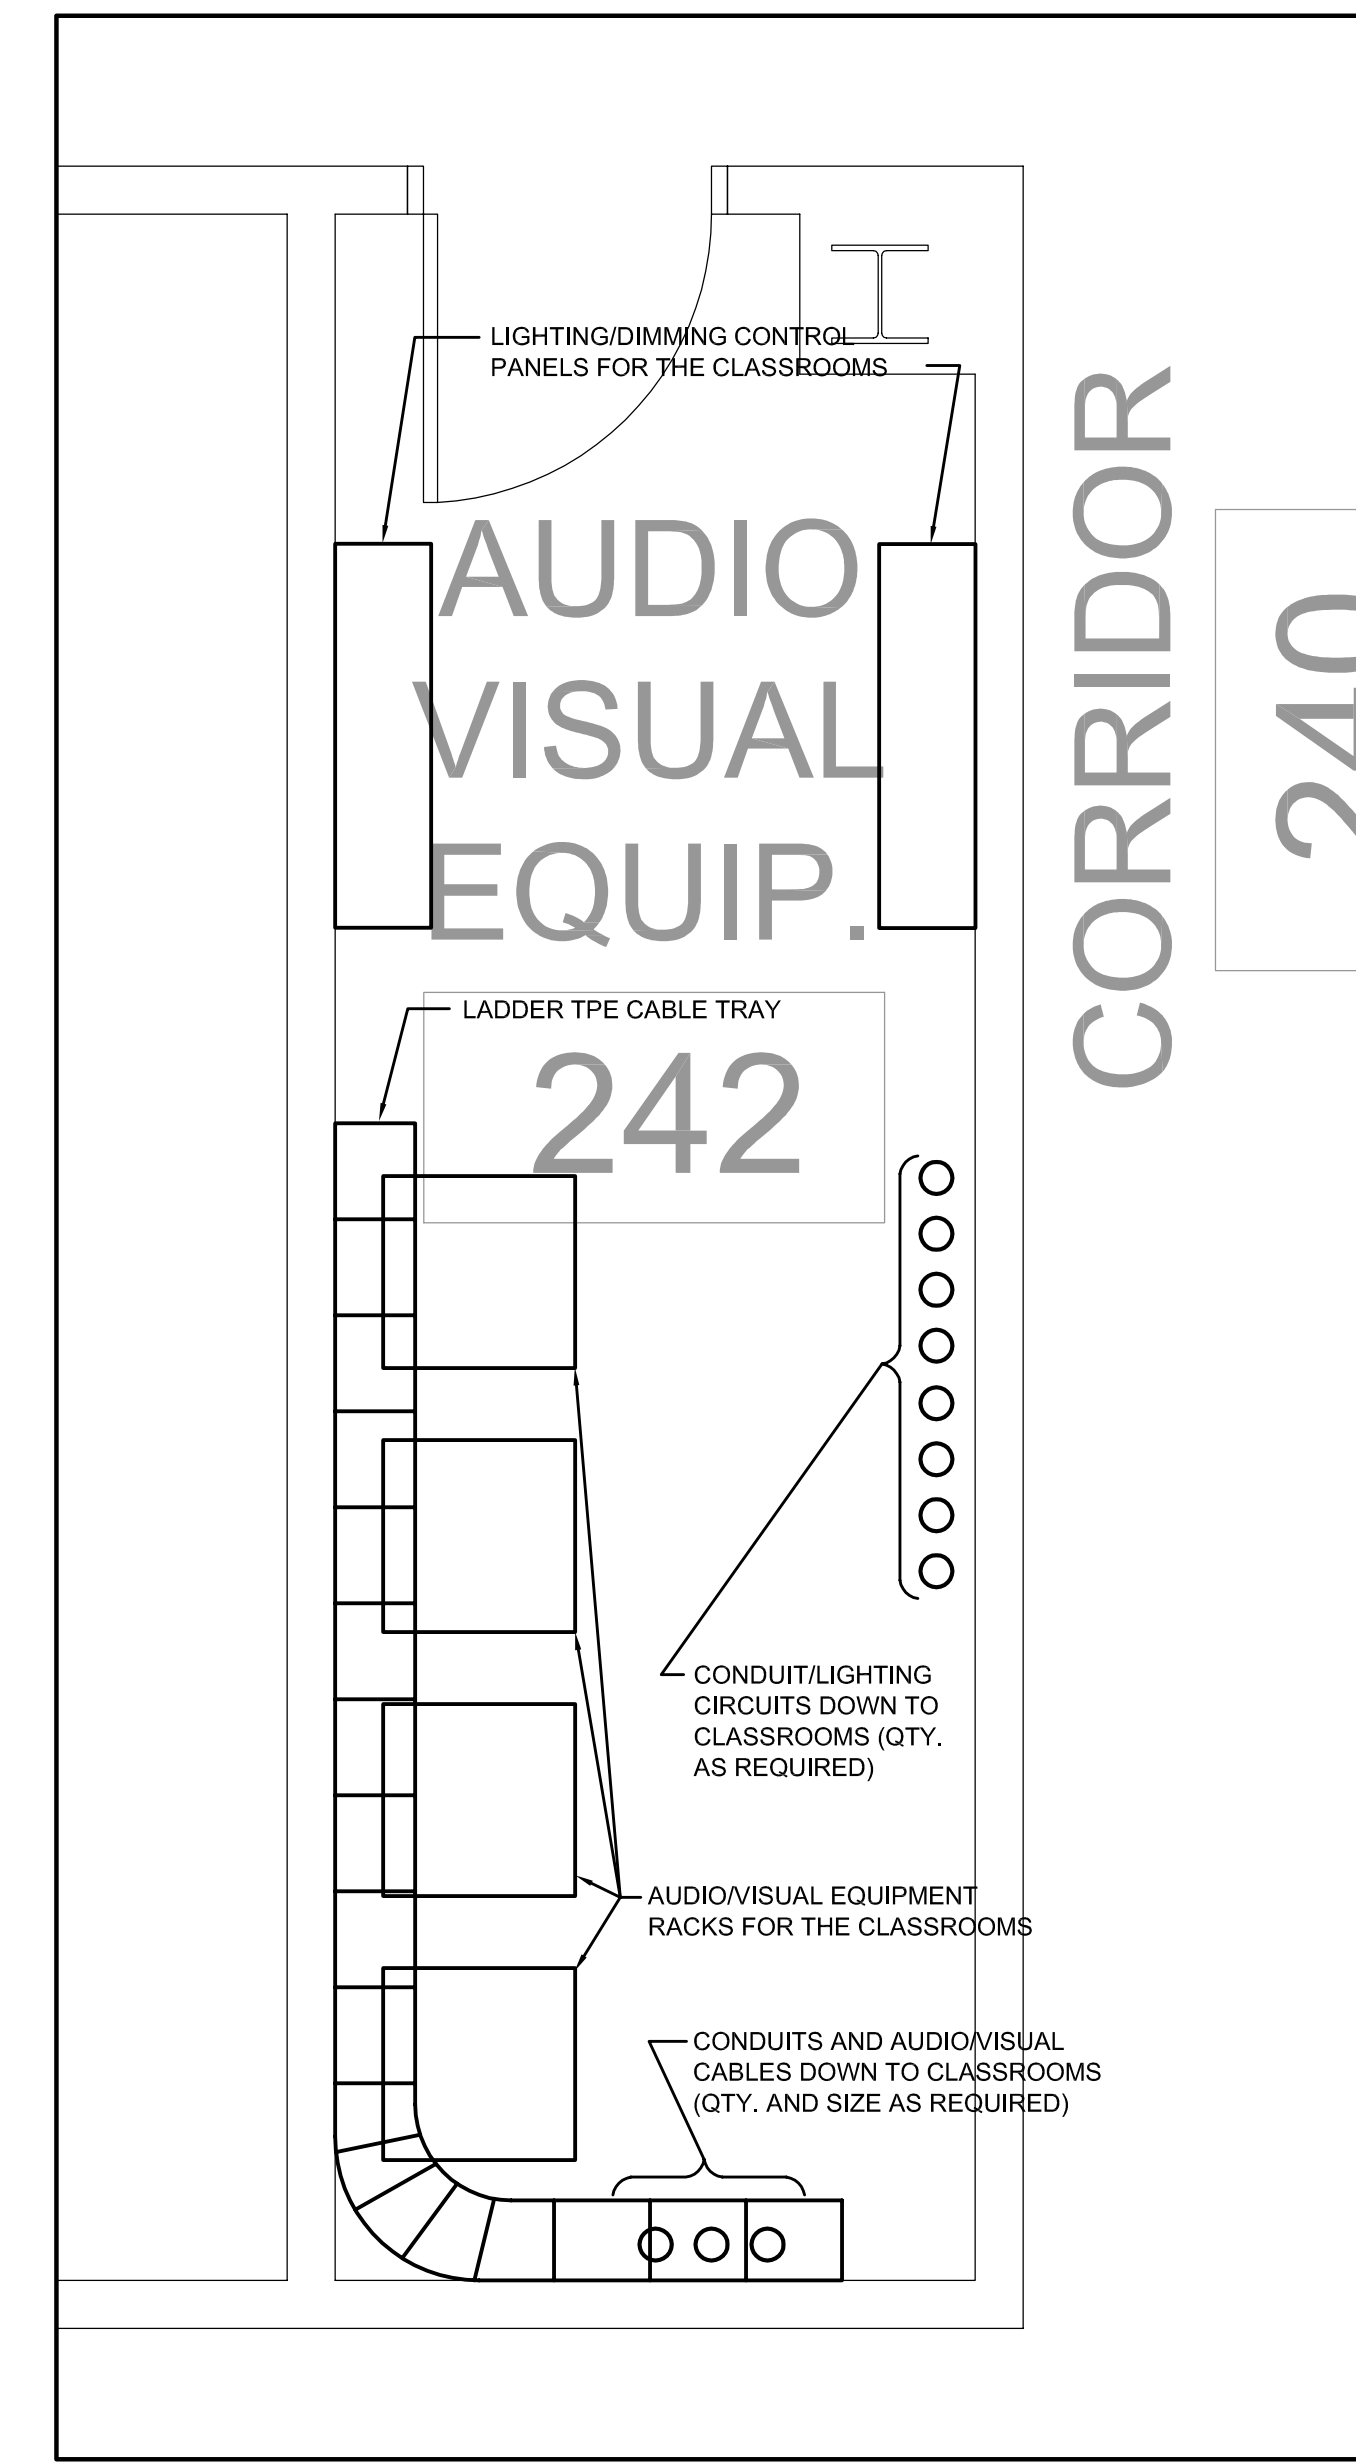

5 SECOND FLOOR ENLARGED ELECTRICAL PLAN  
SCALE: 1/2"=1'-0" AUDIO/VISUAL EQUIPMENT 241

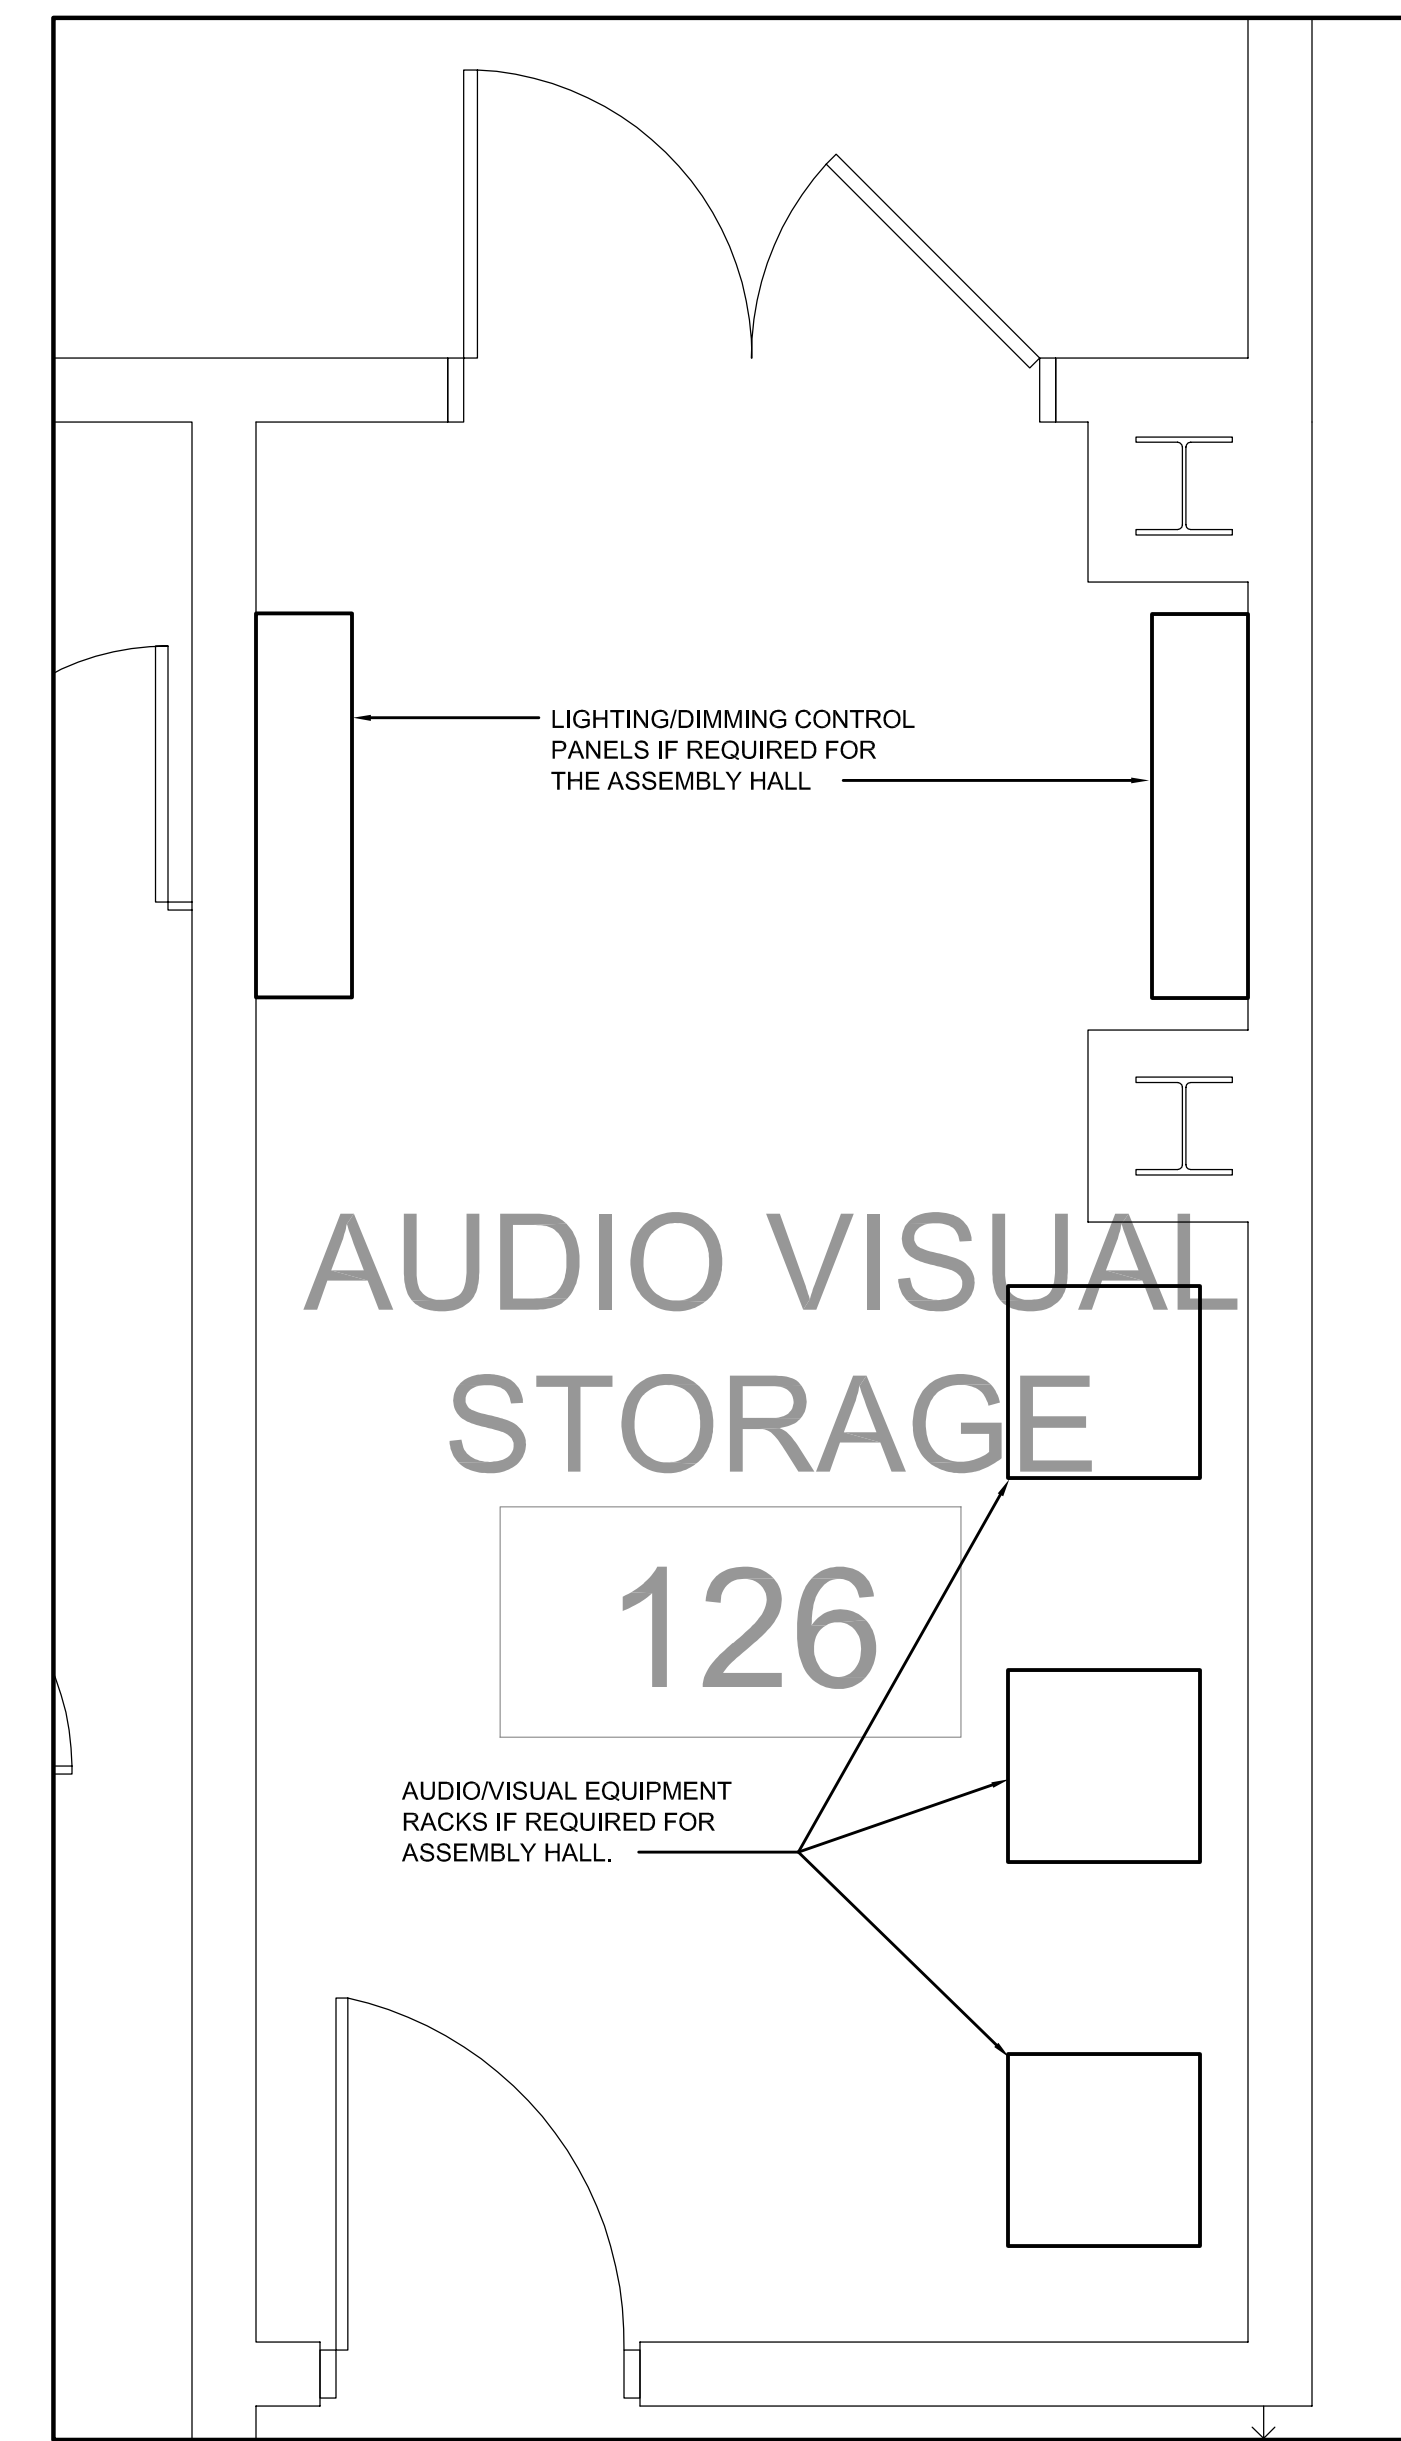

6 FOURTH FLOOR ENLARGED ELECTRICAL PLAN  
SCALE: 1/2"=1'-0" AUDIO/VISUAL EQUIPMENT 126

IMC 1474  
CONSULTING ENGINEERS  
INC.  
3120 209 STREET  
METAIRIE, LOUISIANA 70002

These drawings are conceptual in nature and are not suitable for construction. It is the intent of these documents to clearly delineate the baseline minimum scale, scope and quality of the project. It is the responsibility of the design-builder that his proposal provides for a complete and functional facility responding to relative Army National Guard criteria, recognized industry standards and applicable building codes regardless of the content of these conceptual drawings. Further, it will be the responsibility of the successful design-builder and his architect of record to prepare complete construction documents responding to the fullest intent of the conceptual drawings and specifications.

**BROADMOOR**  
DESIGN GROUP  
ARCHITECTS  
7740 NORTH ANNULOU ROAD  
METAIRIE, LOUISIANA 70002  
(504) 885-5401

**BltchKnevel**  
ARCHITECTS  
757 ST. CHARLES AVENUE  
NEW ORLEANS, LOUISIANA 70130  
(504) 524-4834

LOUISIANA ARMY NATIONAL GUARD  
141st FIELD ARTILLERY BATTALION  
READINESS CENTER  
JACKSON BARRACKS NEW ORLEANS, LOUISIANA



2/22/06	PROG. REVIEW #1
3/1/06	PROG. REVIEW #2
3/27/06	PROG. REVIEW #3
4/10/06	PROG. REVIEW #4
5/3/06	PRELIM. DESIGN

MARK DATE DESCRIPTION  
DRAWING ISSUED: 05/03/2006

NOB PROJECT NO.: 220027

PRELIMINARY DESIGN

DRAWING TITLE:  
ENLARGED ELECTRICAL PLAN

DRAWING NUMBER:

E401

SHEET 99 OF 106