



1 FIRE ALARM SYSTEM RISER
SCALE: 1/80 SCALE

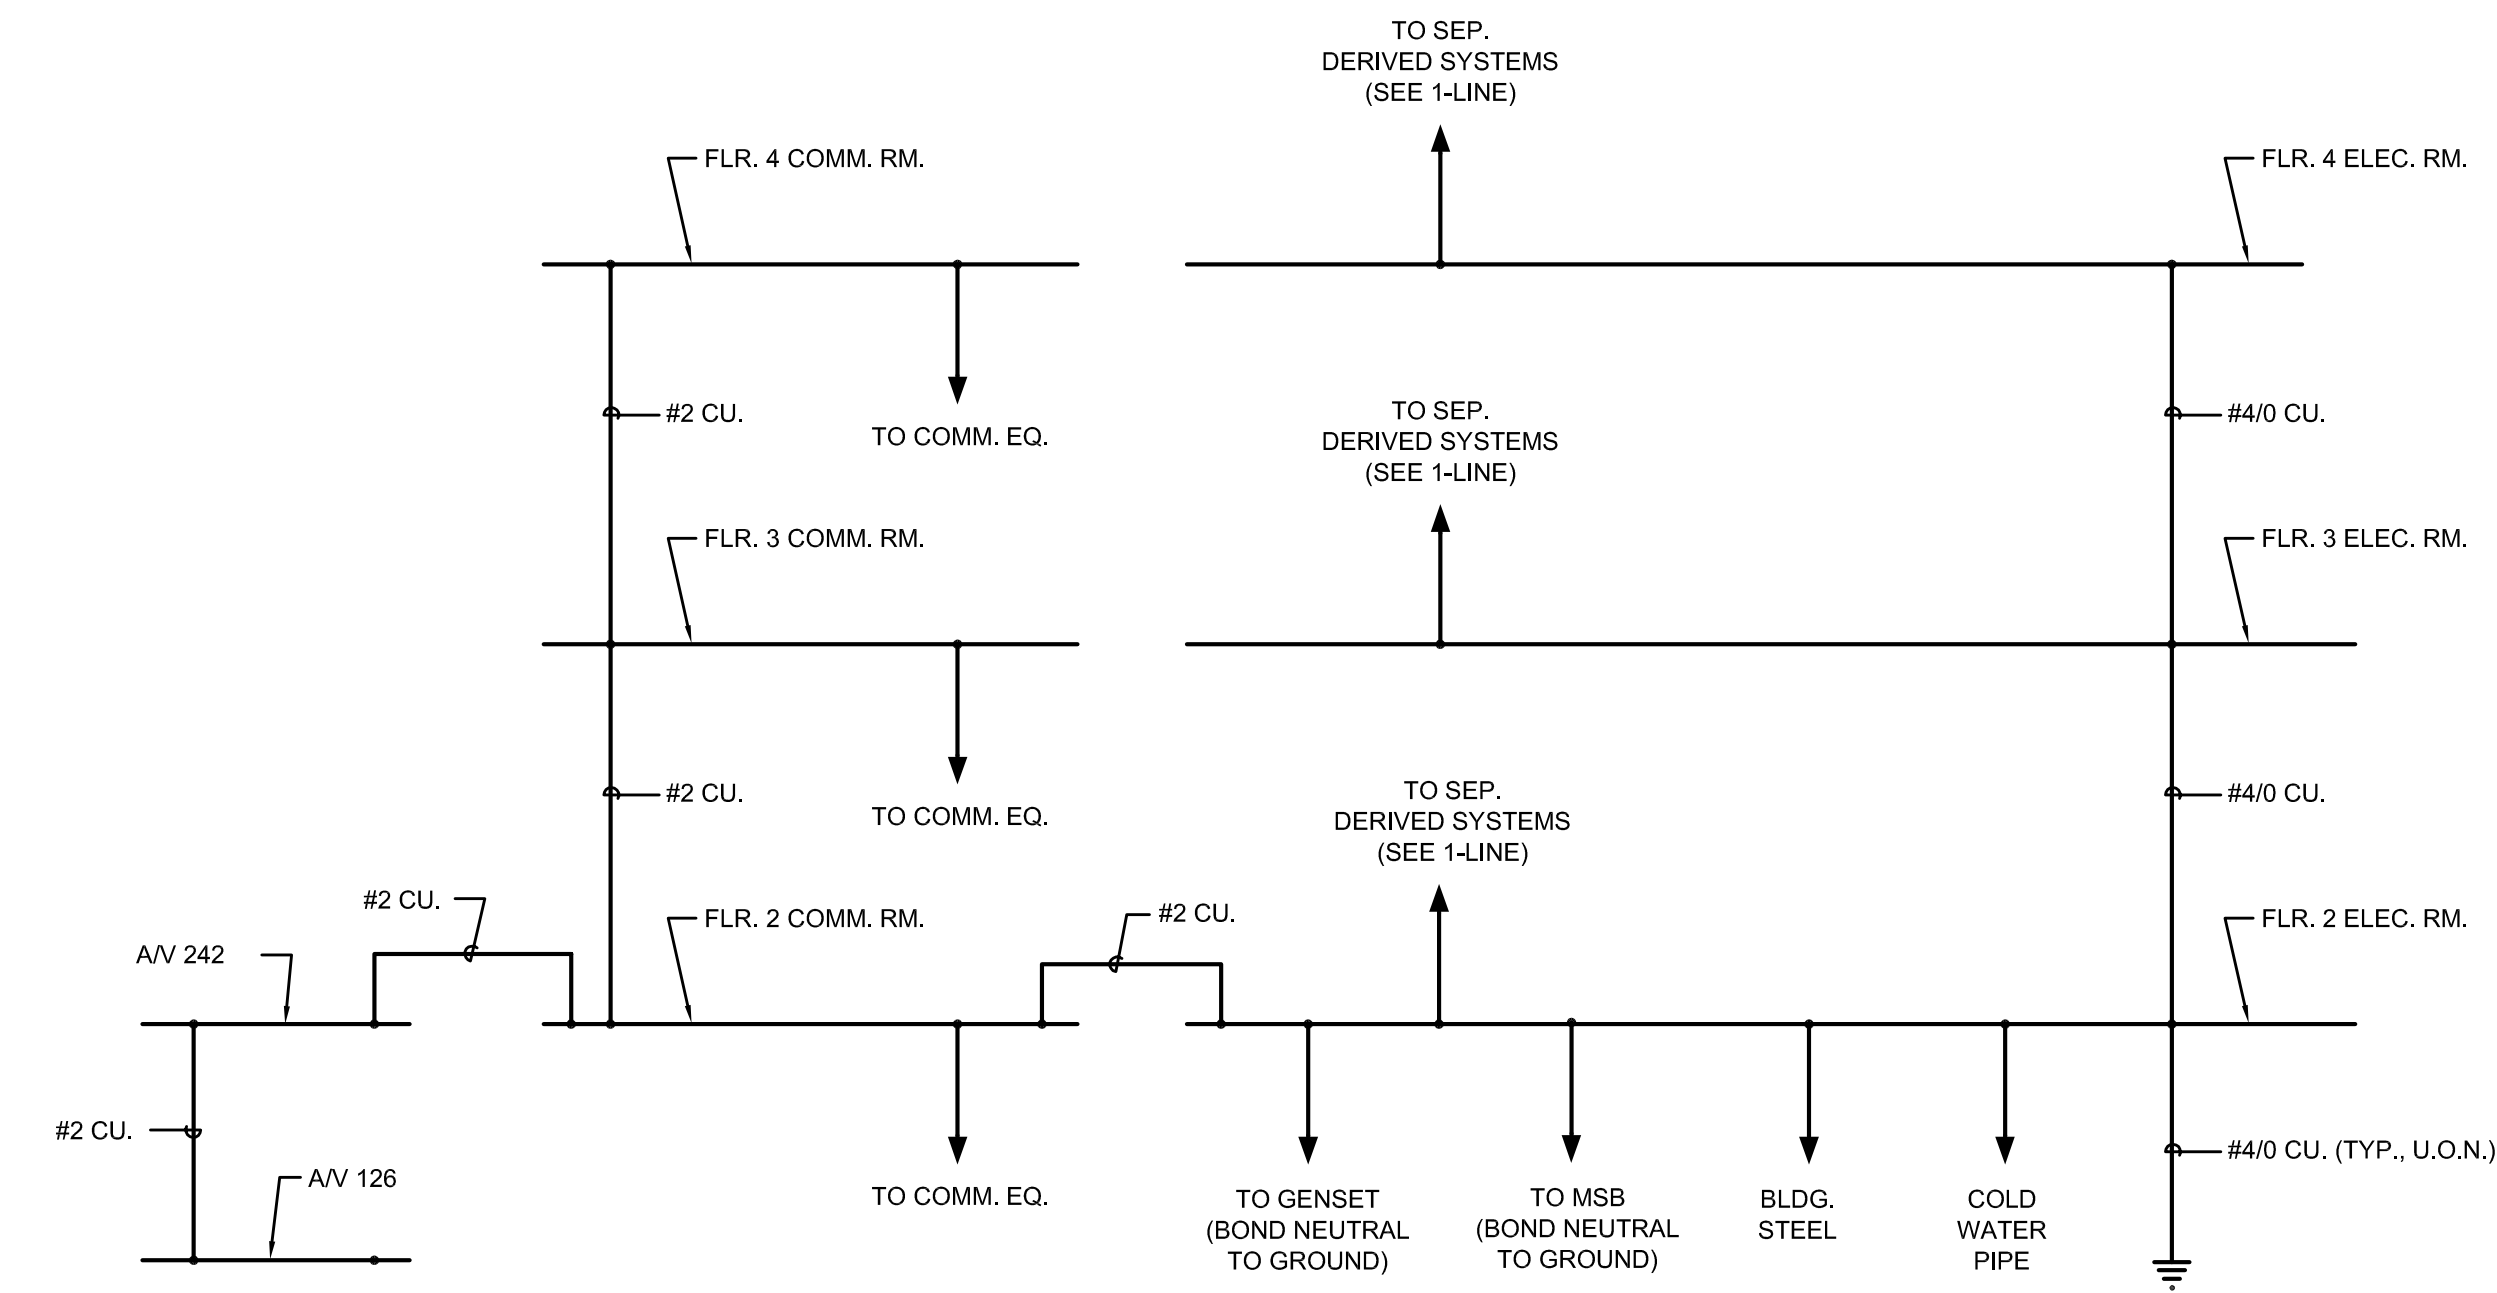

2 GROUNDING SYSTEM RISER
SCALE: NTS

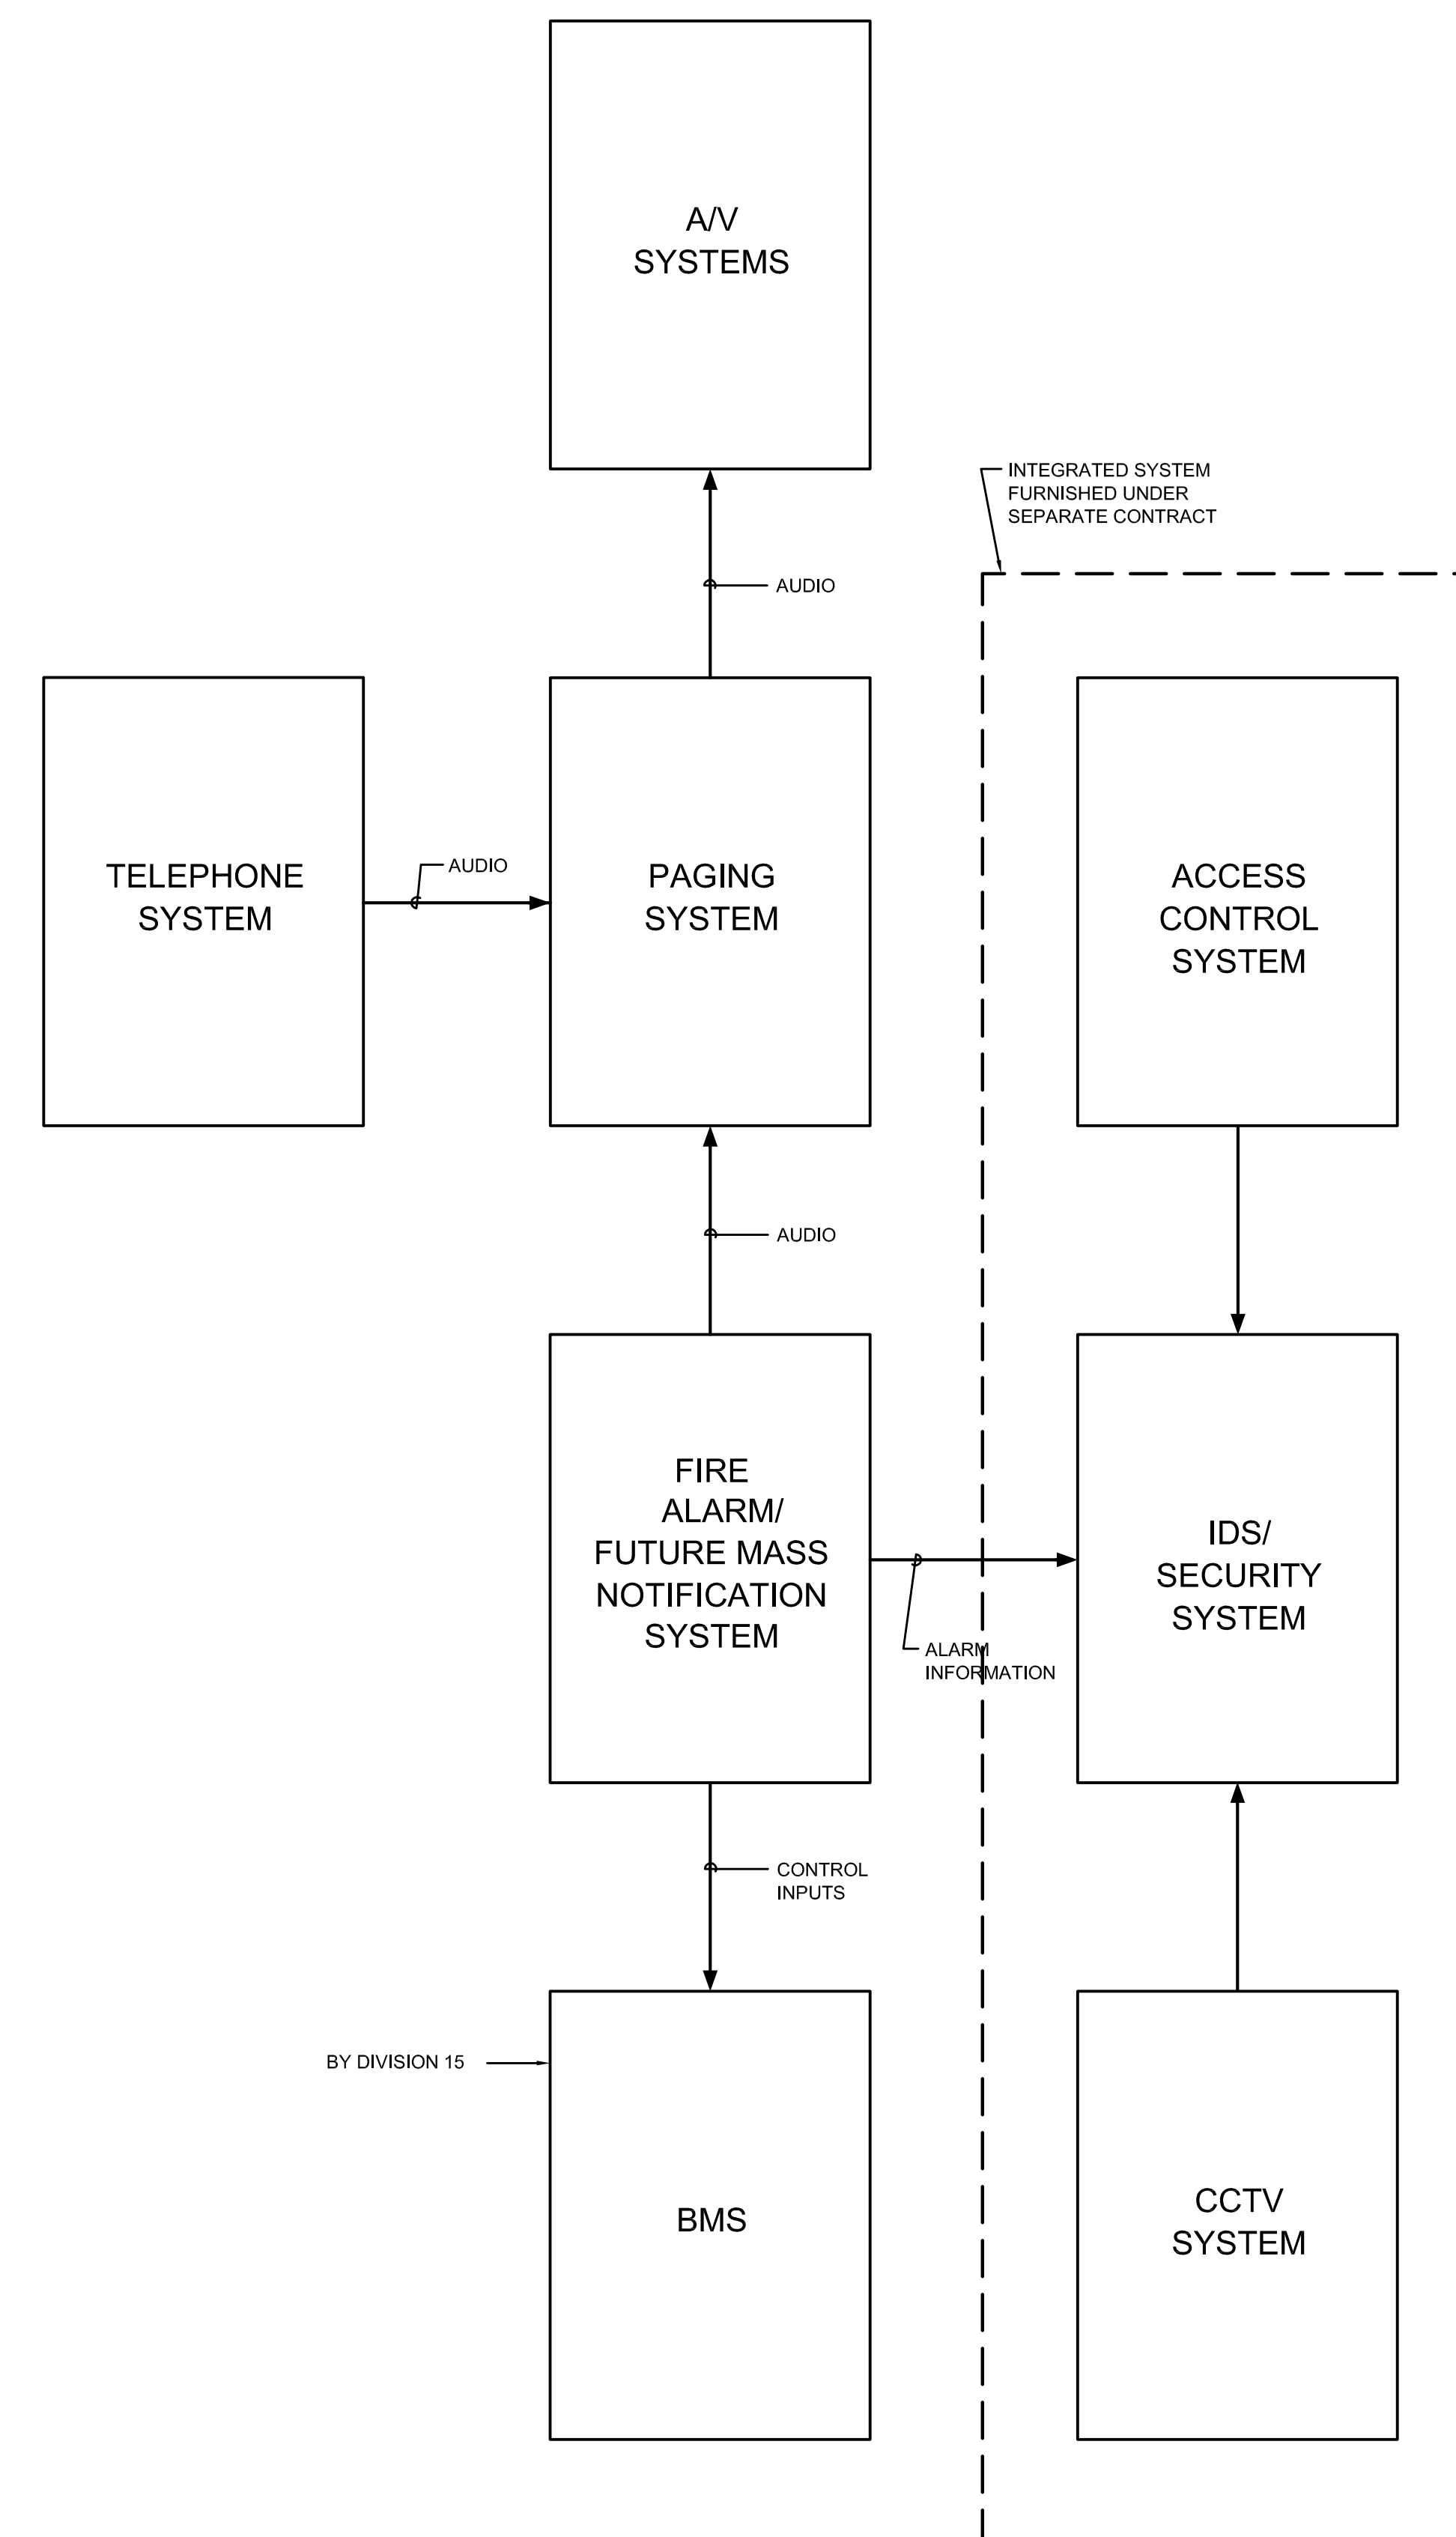

3 BLOCK DIAGRAM - SPECIAL SYSTEM INTERCONNECTIONS
SCALE: NTS

© 2006 IMC 1474
CONSULTING ENGINEERS
INC.
3120 20th STREET
METAIRIE, LOUISIANA 70002

These drawings are conceptual in nature and are not suitable for construction. It is the intent of these documents to clearly delineate the baseline minimum scale, scope and quality of the project. It is the responsibility of the design-builder that his proposal provides for a complete and functional facility responding to relative Army National Guard criteria, recognized industry standards and applicable building codes regardless of the content of these conceptual drawings. Further, it will be the responsibility of the successful design-builder and his architect of record to prepare complete construction documents responding to the fullest intent of the conceptual drawings and specifications.

BROADMOOR
DESIGN GROUP
ARCHITECTS
A PROFESSIONAL ARCHITECTURAL CORPORATION
METAIRIE, LOUISIANA 70002
2740 NORTH ARCADOU ROAD
(504) 885-4001

BltchKnevel
ARCHITECTS
NEW ORLEANS, LOUISIANA 70130
757 ST. CHARLES AVENUE
(504) 524-4834

LOUISIANA ARMY NATIONAL GUARD
141st FIELD ARTILLERY BATTALION
READINESS CENTER
JACKSON BARRACKS NEW ORLEANS, LOUISIANA



2/22/06	PROG. REVIEW #1
3/1/06	PROG. REVIEW #2
3/27/06	PROG. REVIEW #3
4/10/06	PROG. REVIEW #4
5/3/06	PRELIM. DESIGN

MARK DATE DESCRIPTION
DRAWING ISSUED: 05/03/2006

NOB PROJECT NO.: 220027

PRELIMINARY DESIGN

DRAWING TITLE:
ELECTRICAL
RISER DIAGRAMS

DRAWING NUMBER:

E611

SHEET 103 OF 106