


REFLECTED CEILING PLAN LEGEND	
○	UPRIGHT SPRINKLER
●	PENDANT HEAD
▽	SIDEWALL SPRINKLER
□	FLOURESCENT LIGHT FIXTURE RE: LIGHTING PLANS
□	FLOURESCENT LIGHT FIXTURE RE: LIGHTING PLANS
□	WALL MTD. FLOURESCENT LIGHT FIXTURE RE: LIGHTING PLANS
□	FLOURESCENT LIGHT FIXTURE RE: LIGHTING PLANS
□	STRIP LIGHTING RE: LIGHTING PLANS
◇	CEILING MTD. HID OR INCANDESCENT FIXTURE RE: LIGHTING PLANS
◇	WALL MTD. HID OR INCANDESCENT FIXTURE RE: LIGHTING PLANS
⊠	HVAC REGISTER RE: HVAC PLANS
⊠	HVAC RETURN AIR RE: HVAC PLANS

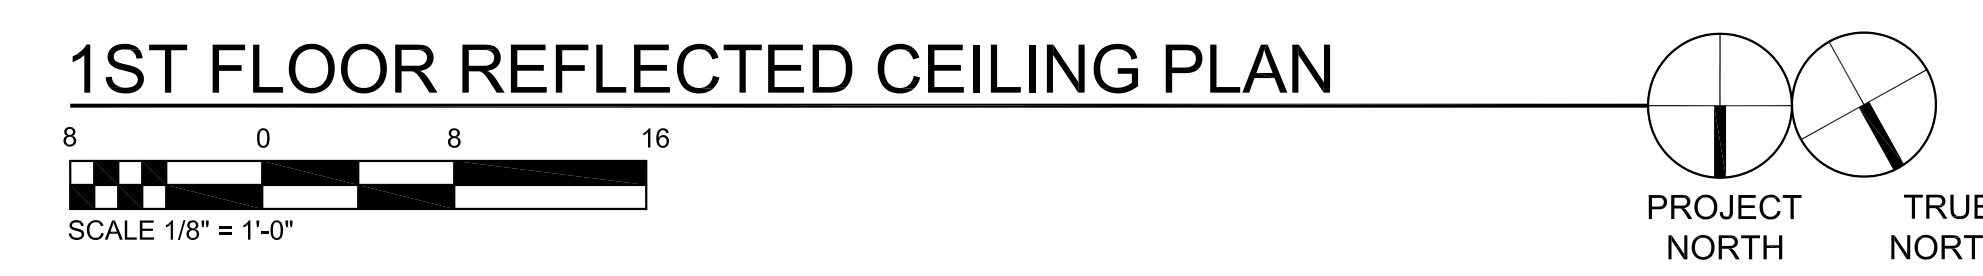

MARK	DATE	DESCRIPTION
△	2/22/06	PROG. REVIEW #1
△	3/10/06	PROG. REVIEW #2
△	3/27/06	PROG. REVIEW #3
△	4/10/06	PROG. REVIEW #4
△	5/3/06	PRELIM. DESIGN

DRAWING ISSUED: 05/03/2006

NOB PROJECT NO.: 220027

**PRELIMINARY DESIGN**

DRAWING TITLE:  
**FIRST FLOOR REFLECTED CEILING PLAN**

DRAWING NUMBER:

These drawings are conceptual in nature and are not suitable for construction. It is the intent of these documents to clearly delineate the baseline minimum scale, scope and quality of the project. It is the responsibility of the design-builder that his proposal provides for a complete and functional facility responding to relative Army National Guard criteria, recognized industry standards and applicable building codes regardless of the content of these conceptual drawings. Further, it will be the responsibility of the successful design-builder and his architect of record to prepare complete construction documents responding to the fullest intent of the conceptual drawings and specifications.