


**GENERAL NOTES THIS SHEET:**

- ALL HW, CW, AND VENT PIPING SHALL BE RUN ABOVE CEILING UNLESS NOTED OTHERWISE. ROUTE ALL PIPING TIGHT TO STRUCTURE. OFFSET UNDER BEAMS AS REQUIRED. SEE SPECIFICATIONS FOR PIPING INSULATION REQUIREMENTS.
- ALL WASTE PIPING SHALL BE RUN BELOW SLAB UNLESS NOTED OTHERWISE.
- COORDINATE EXACT ROUTING OF ALL PIPING SO AS NOT TO CONFLICT WITH OTHER TRADES INCLUDING DUCTWORK AND ELECTRICAL.

**SPECIFIC NOTES THIS SHEET:**

- TRAP PRIMER IN WALL WITH ACCESS PANEL. SEE P-601 FOR DETAILS.

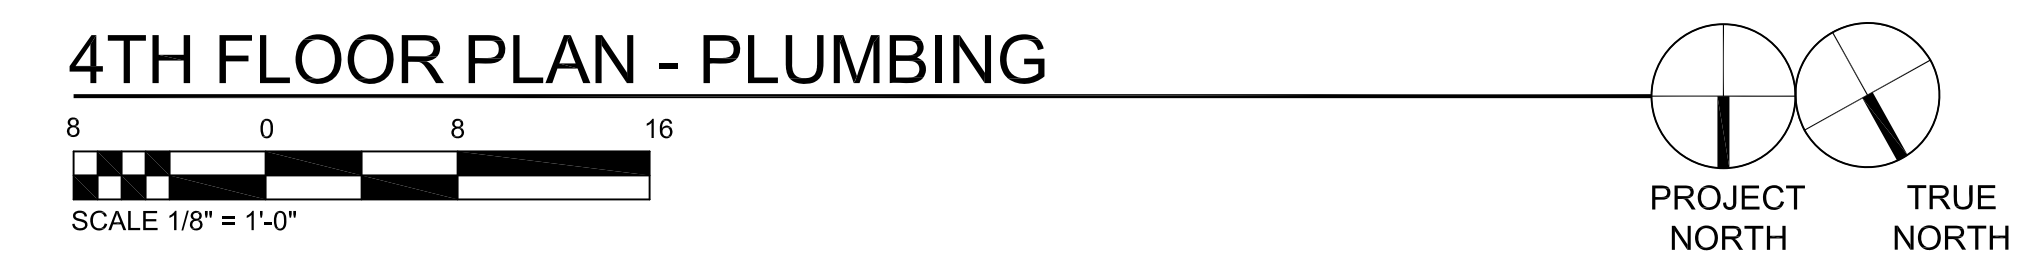

2/22/06	PROG. REVIEW #1
3/10/06	PROG. REVIEW #2
3/27/06	PROG. REVIEW #3
4/10/06	PROG. REVIEW #4
5/3/06	PRELIM. DESIGN

MARK	DATE	DESCRIPTION
DRAWING ISSUED: 05/03/2006		

NGB PROJECT NO.: 220027

PRELIMINARY DESIGN

DRAWING TITLE:  
4TH FLOOR PLAN - PLUMBING

DRAWING NUMBER:

**LUCIEN T. VIVIEN JR. & ASSOC., INC.**  
CONSULTING ENGINEERS  
121 HICKORY AVENUE HARAHAN, LA 70123 (504) 228-5409

These drawings are conceptual in nature and are not suitable for construction. It is the intent of these documents to clearly delineate the baseline minimum scale, scope and quality of the project. It is the responsibility of the design-builder that his proposal provides for a complete and functional facility responding to relative Army National Guard criteria, recognized industry standards and applicable building codes regardless of the content of these conceptual drawings. Further, it will be the responsibility of the successful design-builder and his architect of record to prepare complete construction documents responding to the fullest intent of the conceptual drawings and specifications.